

1. BUILDING WILL BE DESIGNED (STRUCTURES) AS PER RELEVANT IS CODES FOR EARTH QUAKE RESISTANCE.
2. BUILDING IS HAS AUTOMATIC SPRINKLER SYSTEM ON ALL FLOORS.

S.NO.	DESCRIPTION	LEND
1.	1000 SOIL & VENT PIPE	0
2.	1000 WASTE & VENT PIPE	0
3.	750 ANTI SYPHONAGE VENT PIPE	0
4.	1000 RAIN WATER PIPE	0
5.	1500 RAIN WATER PIPE	0
6.	140X25X200 FLOORING WATER SUPPLY	0
7.	140X25X200 DRAINAGE WATER SUPPLY	0
8.	140X25X200 HOT WATER SUPPLY	0

S.NO.	DESCRIPTION	LEND
9.	110 OD UPVC SOIL PIPE	0
10.	40 OD UPVC WASTE PIPE	0
11.	80 OD UPVC WASTE PIPE	0
12.	110 OD UPVC WASTE PIPE	0
13.	FIRE ROSE CABINET	PHC
14.	FLOOR TRAP	PHC

Project: PROPOSED GROUP HOUSING SCHEME MEASURING 7.50 ACRES FALLING IN THE RESIDENTIAL PLOTTED COLONY MEASURING 393.538 ACRES (LICENSE NO. 113 OF 2010 DATED 01.06.2008, LICENSE NO. 71 OF 2010 DATED 15.09.2010 & LICENSE NO.62 OF 2011 DATED 05.07.2011) IN SECTOR-81,82,-A.83 & 85, GURGAON MANESAR URBAN COMPLEX BEING DEVELOPED BY VATIKA LTD. AND OTHERS
Associate Architects

RSMS ARCHITECTS PVT. LTD.
59, Nora Niwas Bhawani Kunj
(Behind D2), Vasant Kunj,
New Delhi-110070.
Tel.: 011-26898616, 26898617
www.rsms-arch.com

Checked and found correct. (initials) Service only is to be returned to:
forwarding letter No. 529442
By _____

Superintending Engineer (R&B)
NDA, Delhi-110010

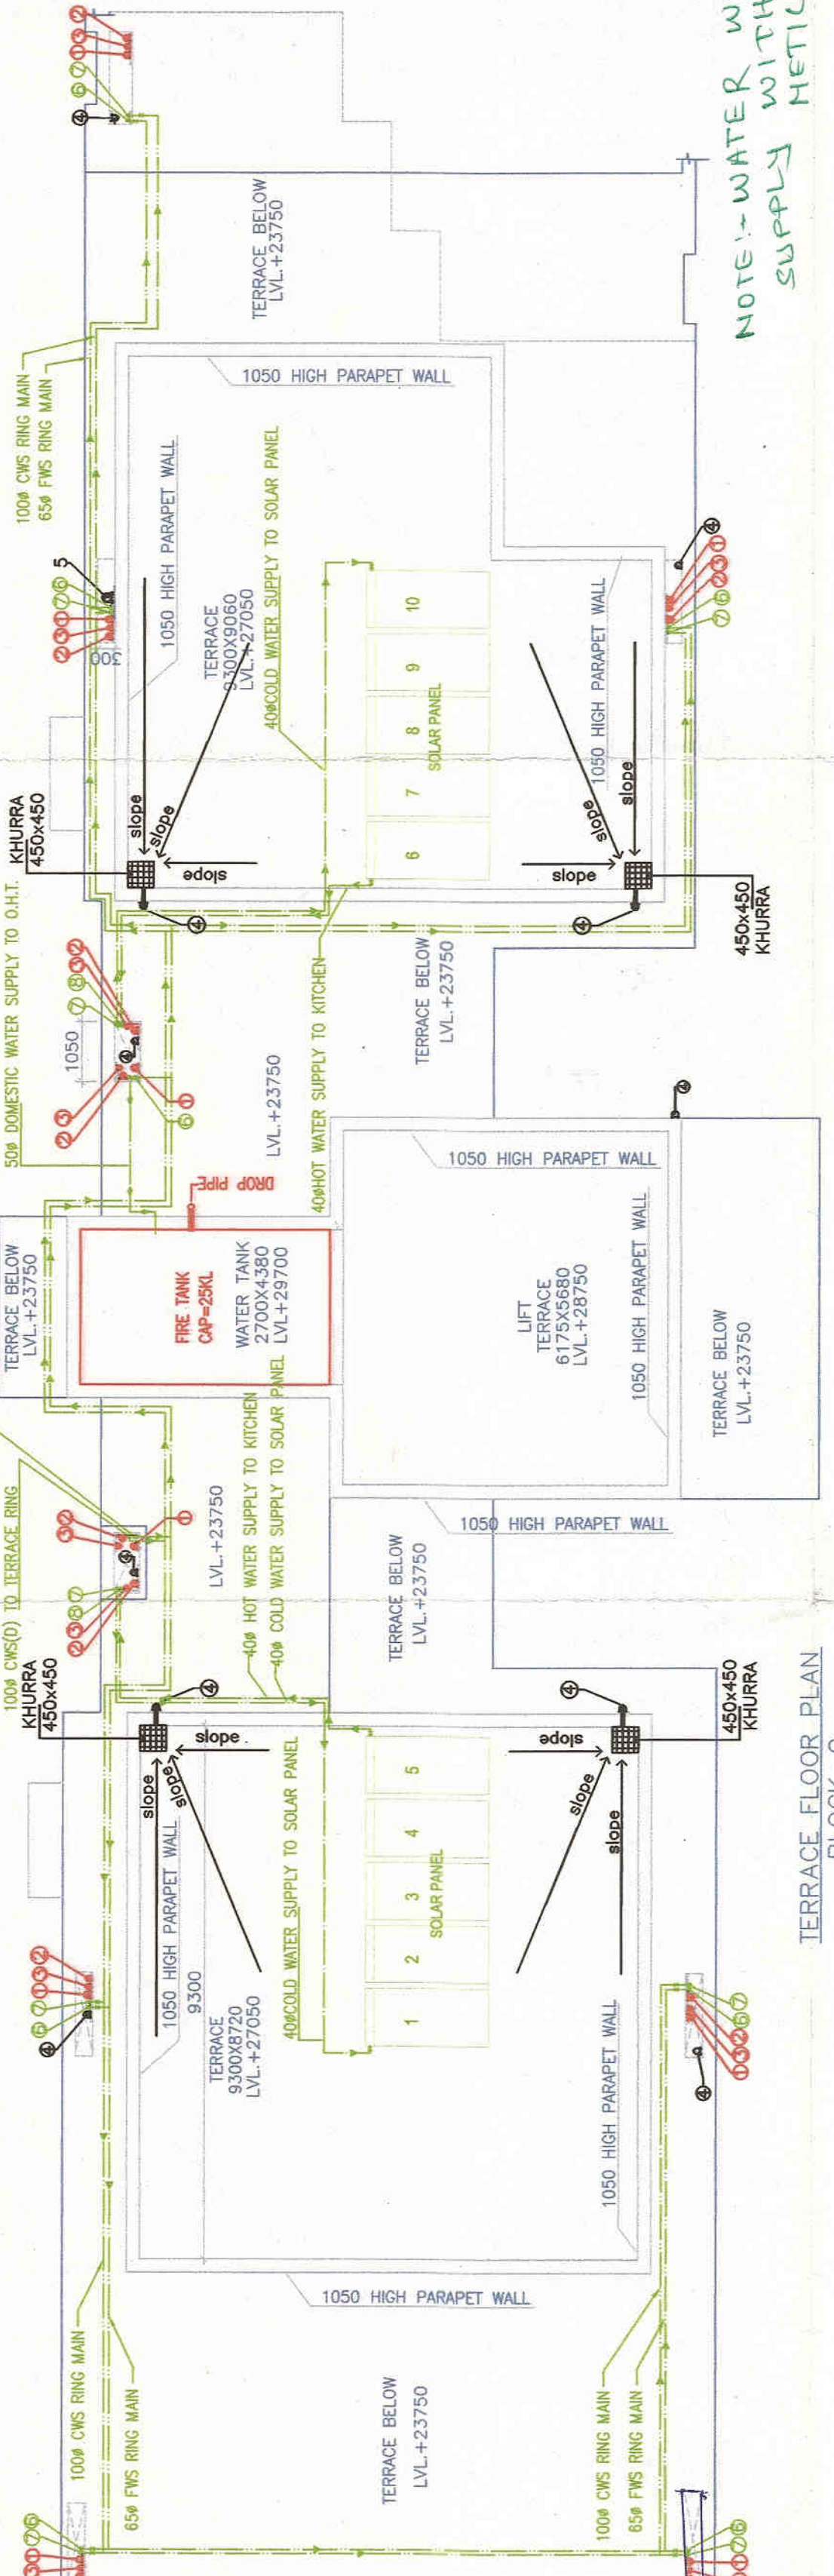
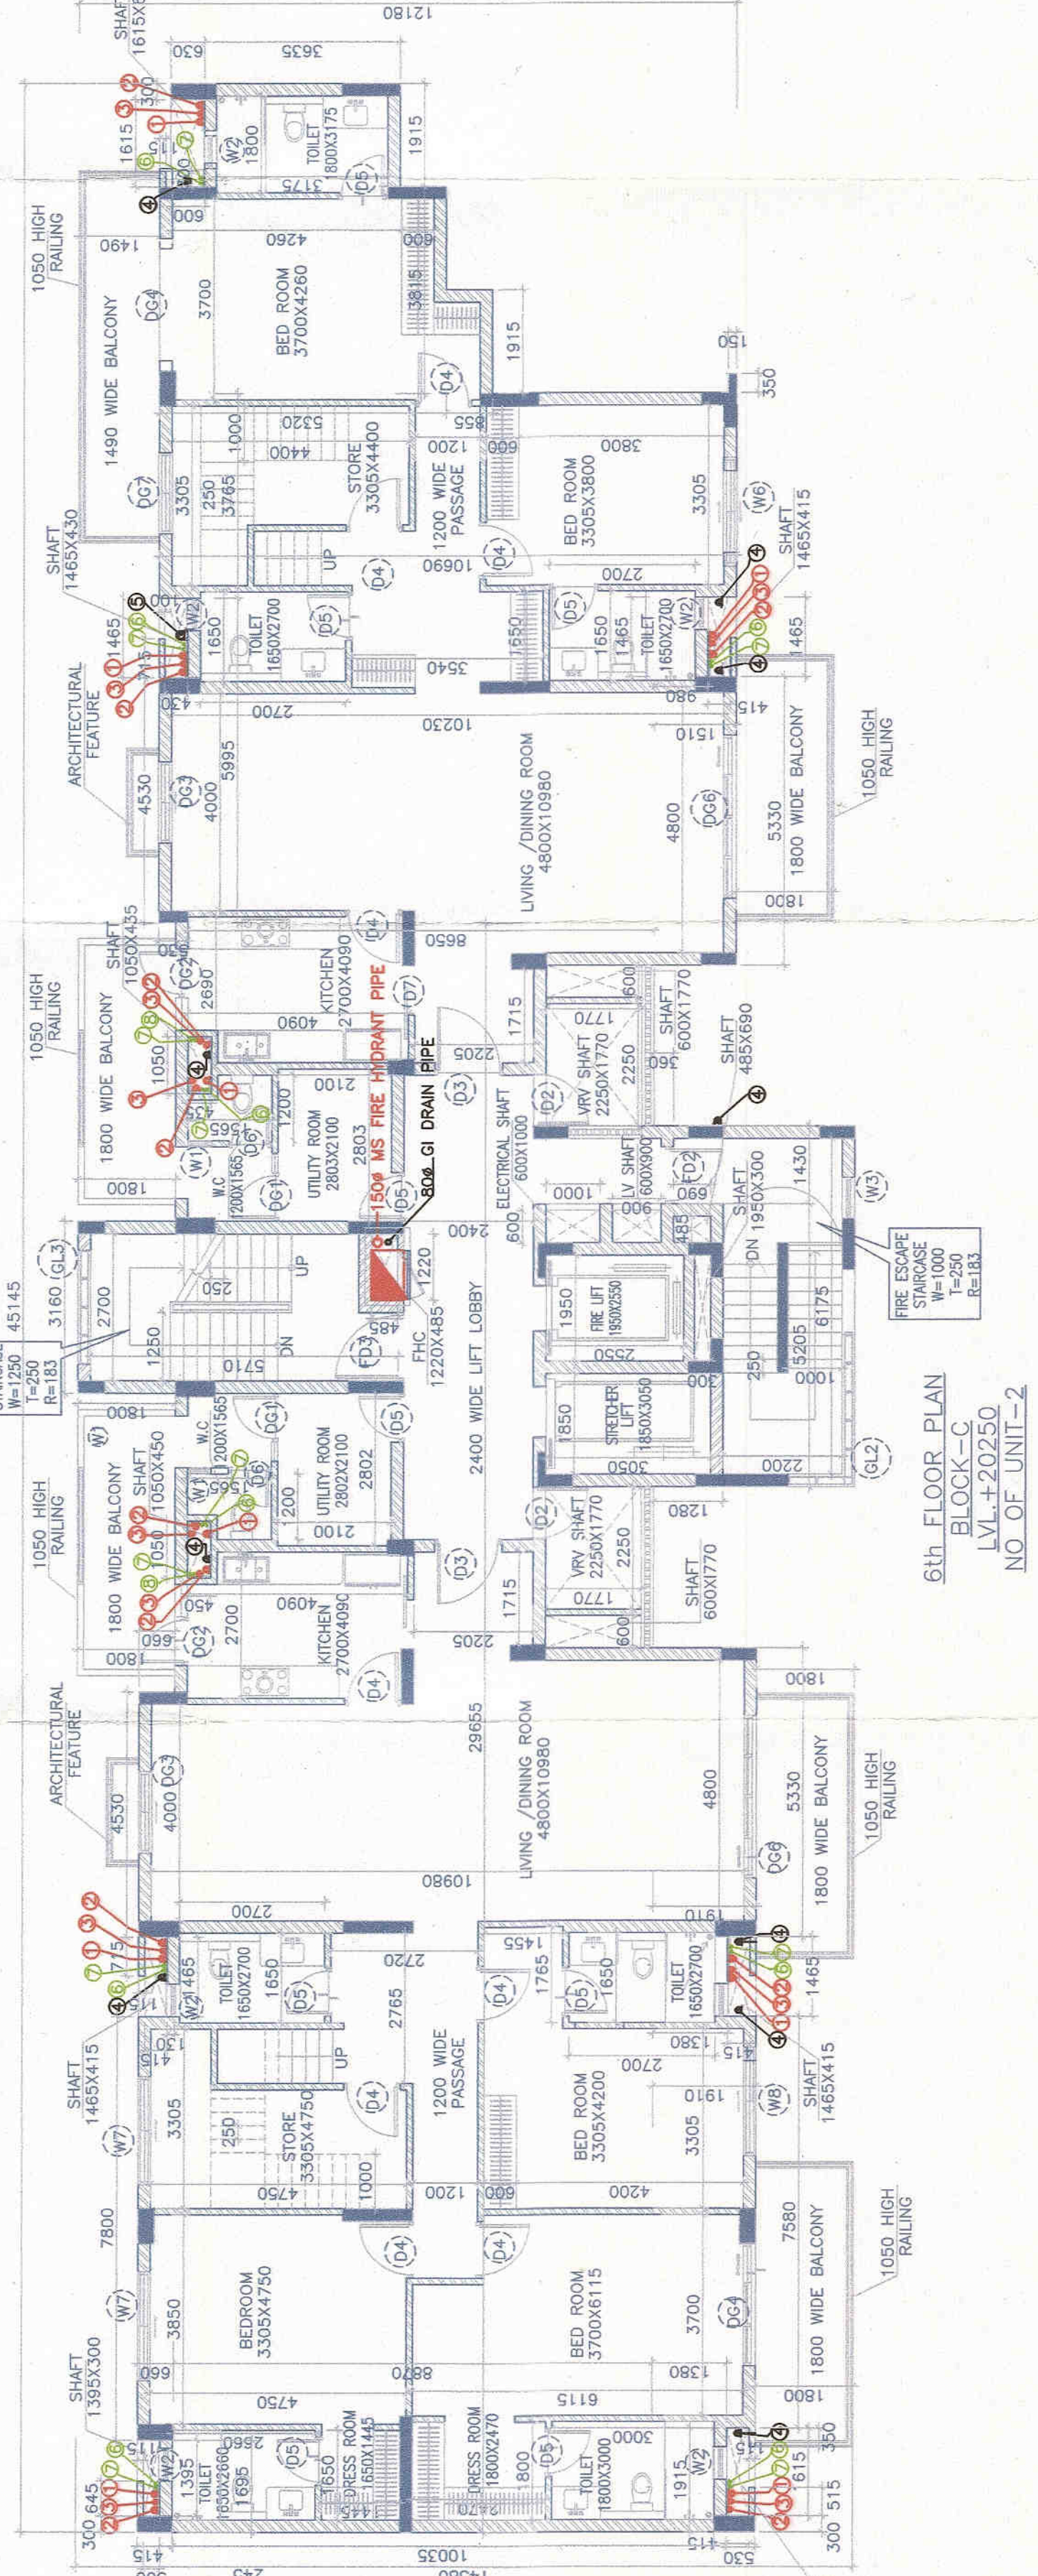
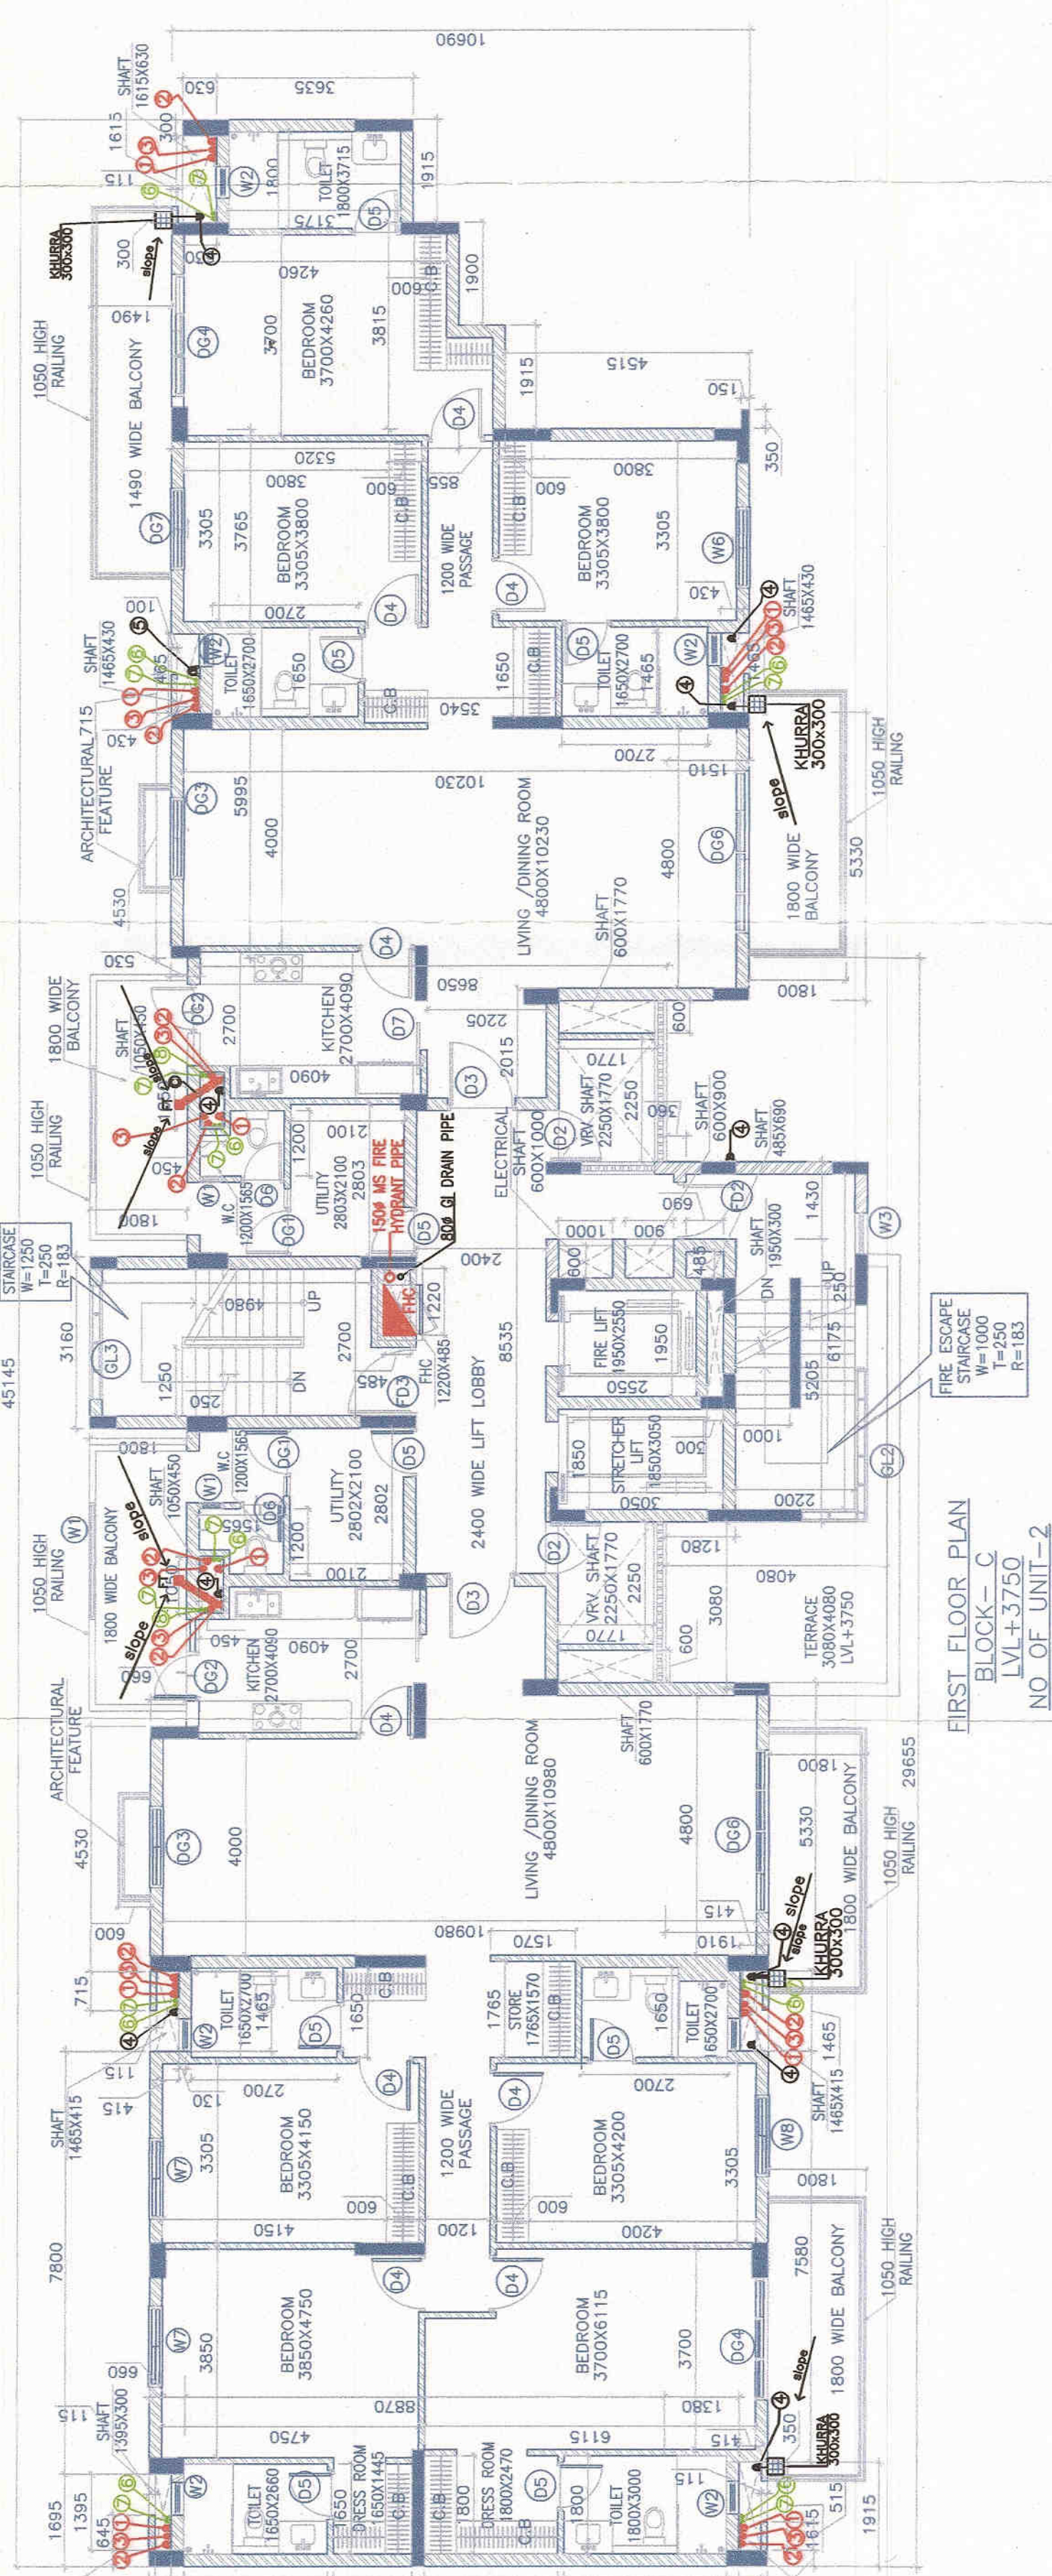

 C.T.P. (H.)
 Chairman
 B.P.C.


 D.T.P. (H.)
 Member Secretary
 B.P.C.

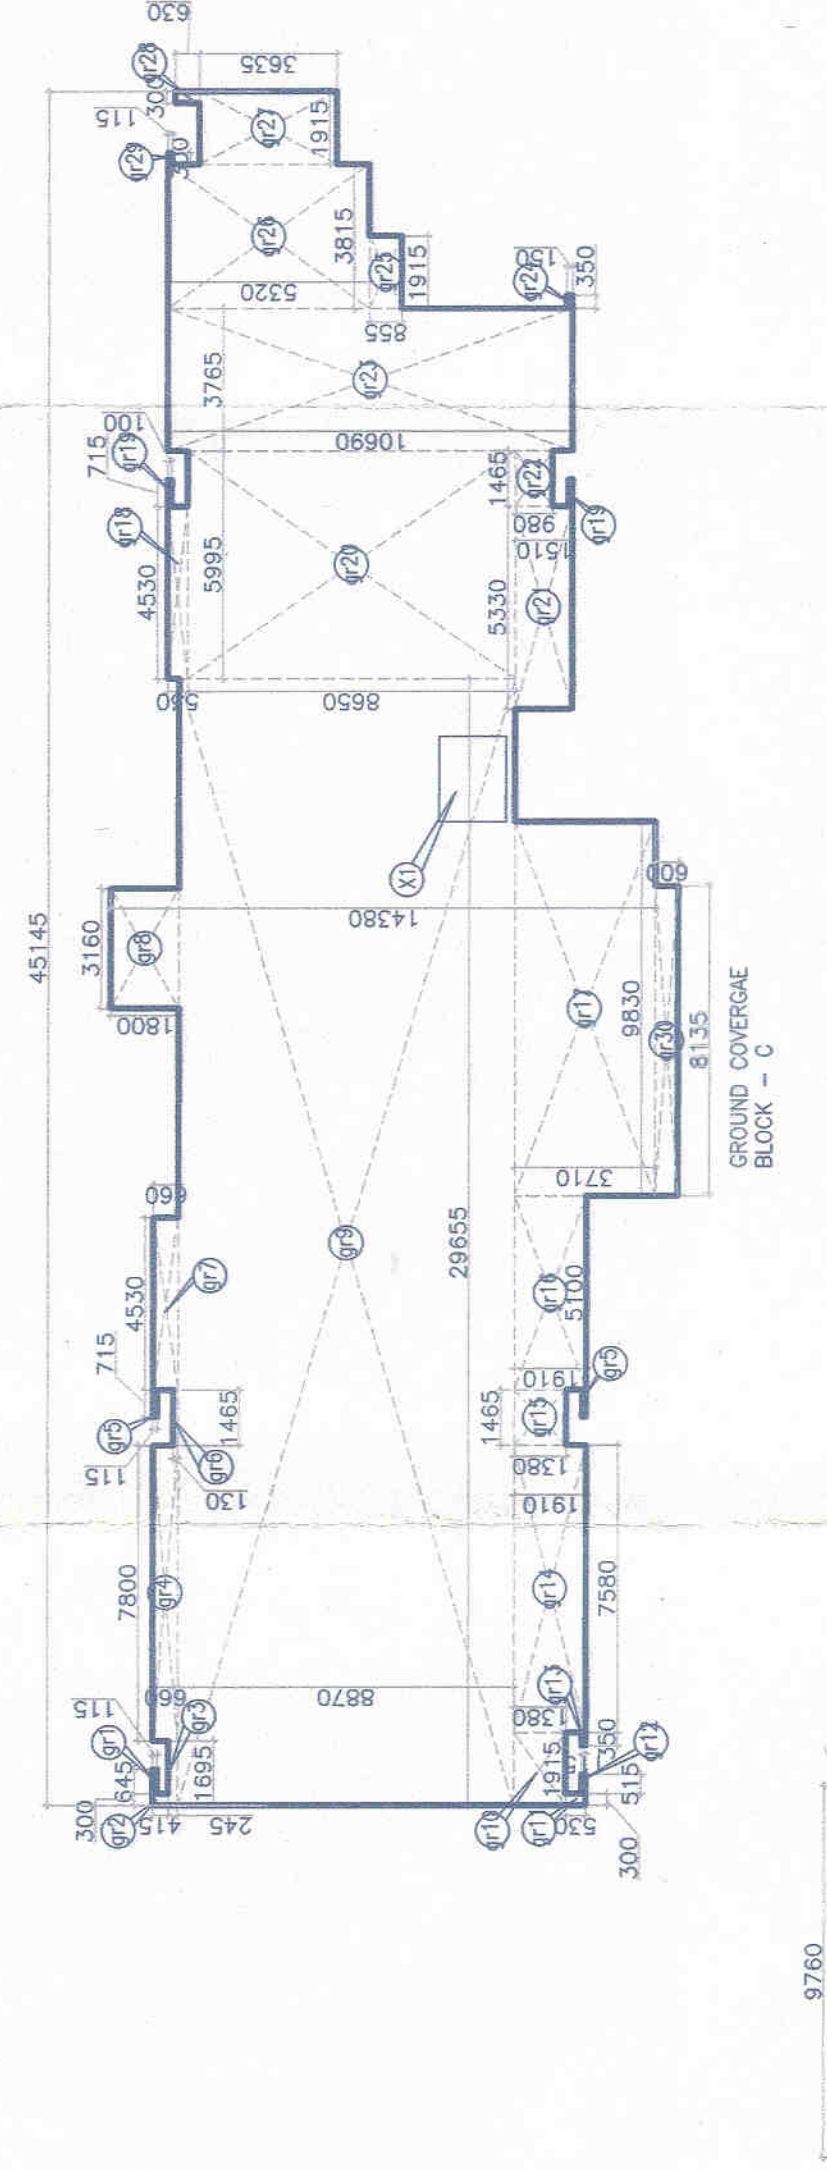
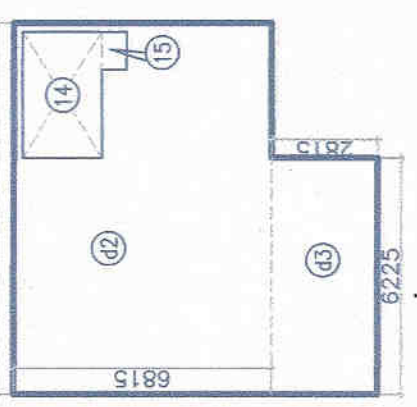
Checked and found OK for Public Release
(Internal) Services only subject to continuing review
forwarding letter No. SEHQ/11873, D. 211/13
Superintending Engineer, MO
Public, Ranchhula
A-13

ARCHITECT'S SEAL	OWNER'S SEAL
------------------	--------------

MARCH-2013.	Scale : 1:100	Drawing Title:- GROUND TO 7TH FLOOR & TERRACE PLAN & AREA CALCULATION OF ALL FLOOR PLAN (BLOCK-C)	Drawing No C-0
			WATER SIGNATURE

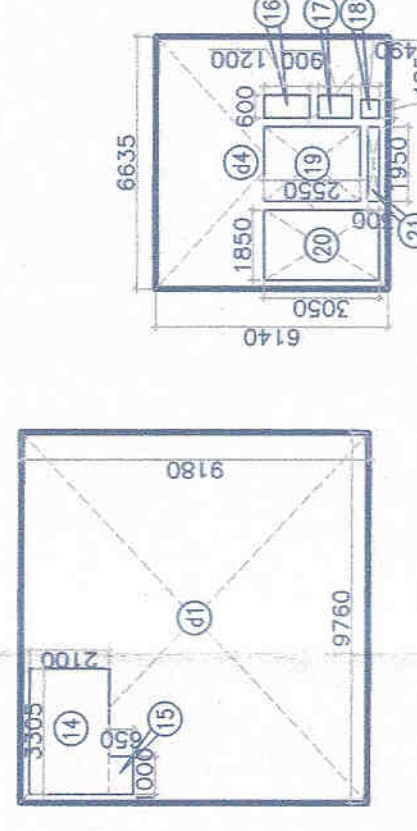
[illegible]

DEDUCTION - X									
X1	=	2.250	X	1.770	X	1	=	3.983	500m.
				TOTAL				3.983	500m.

[illegible]

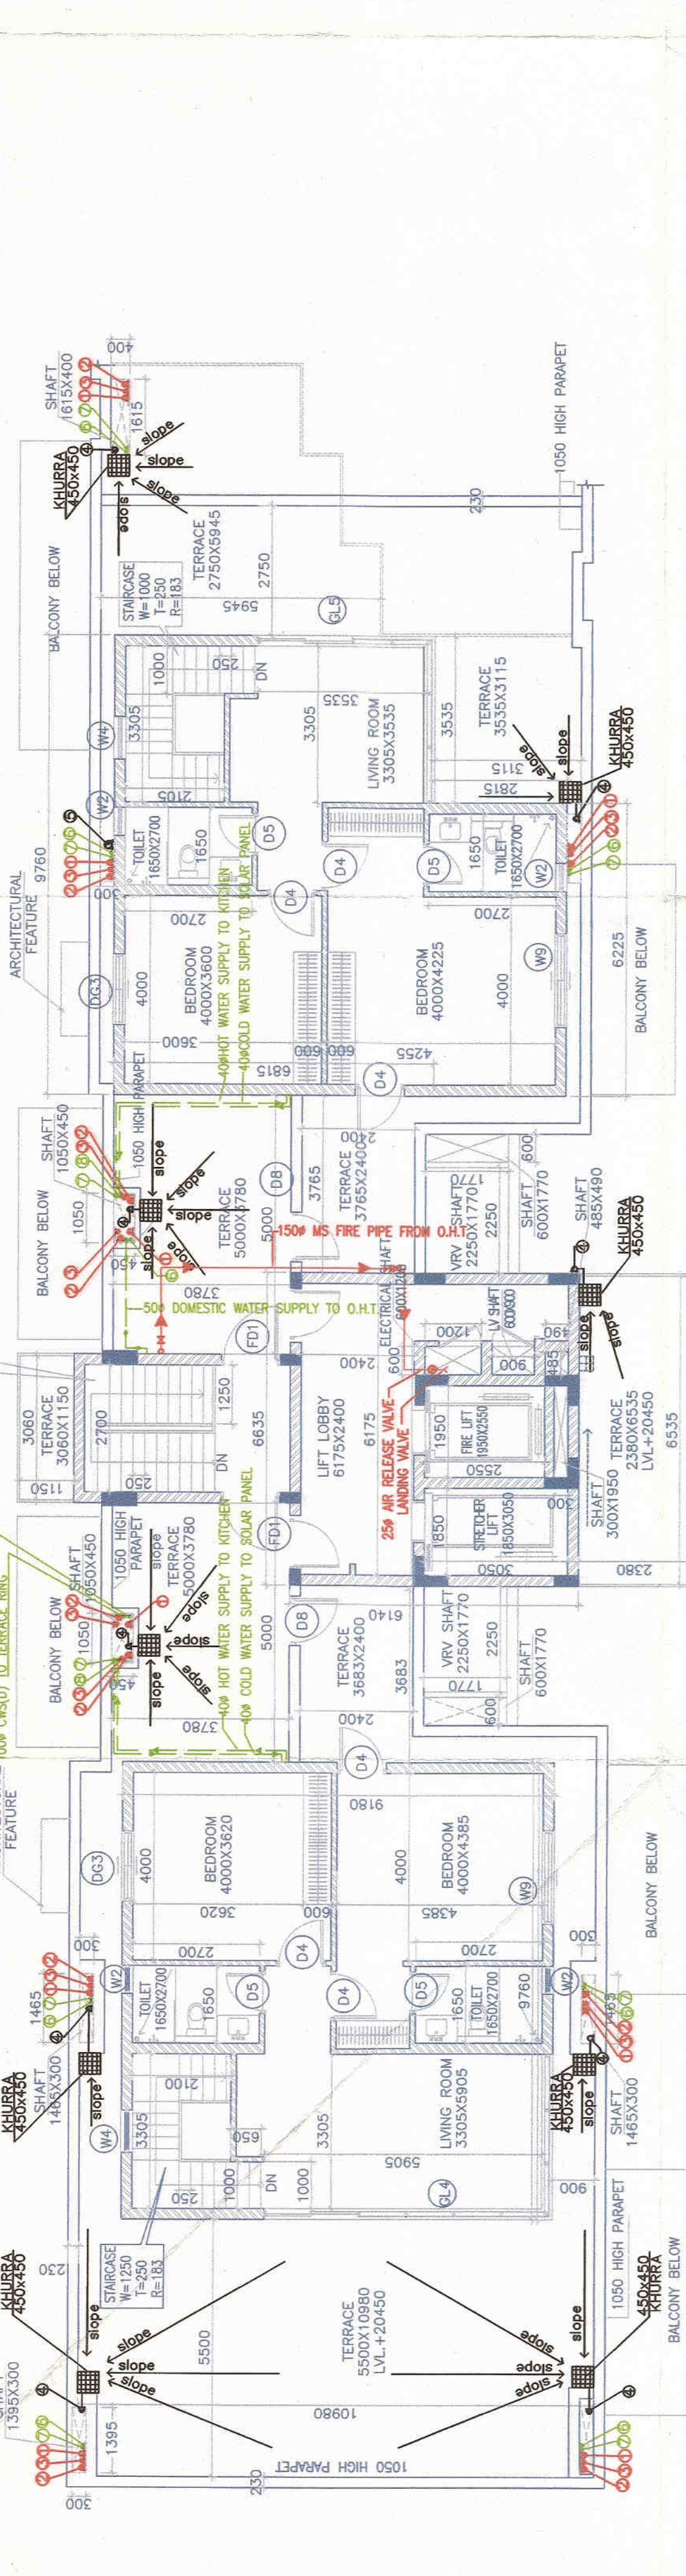
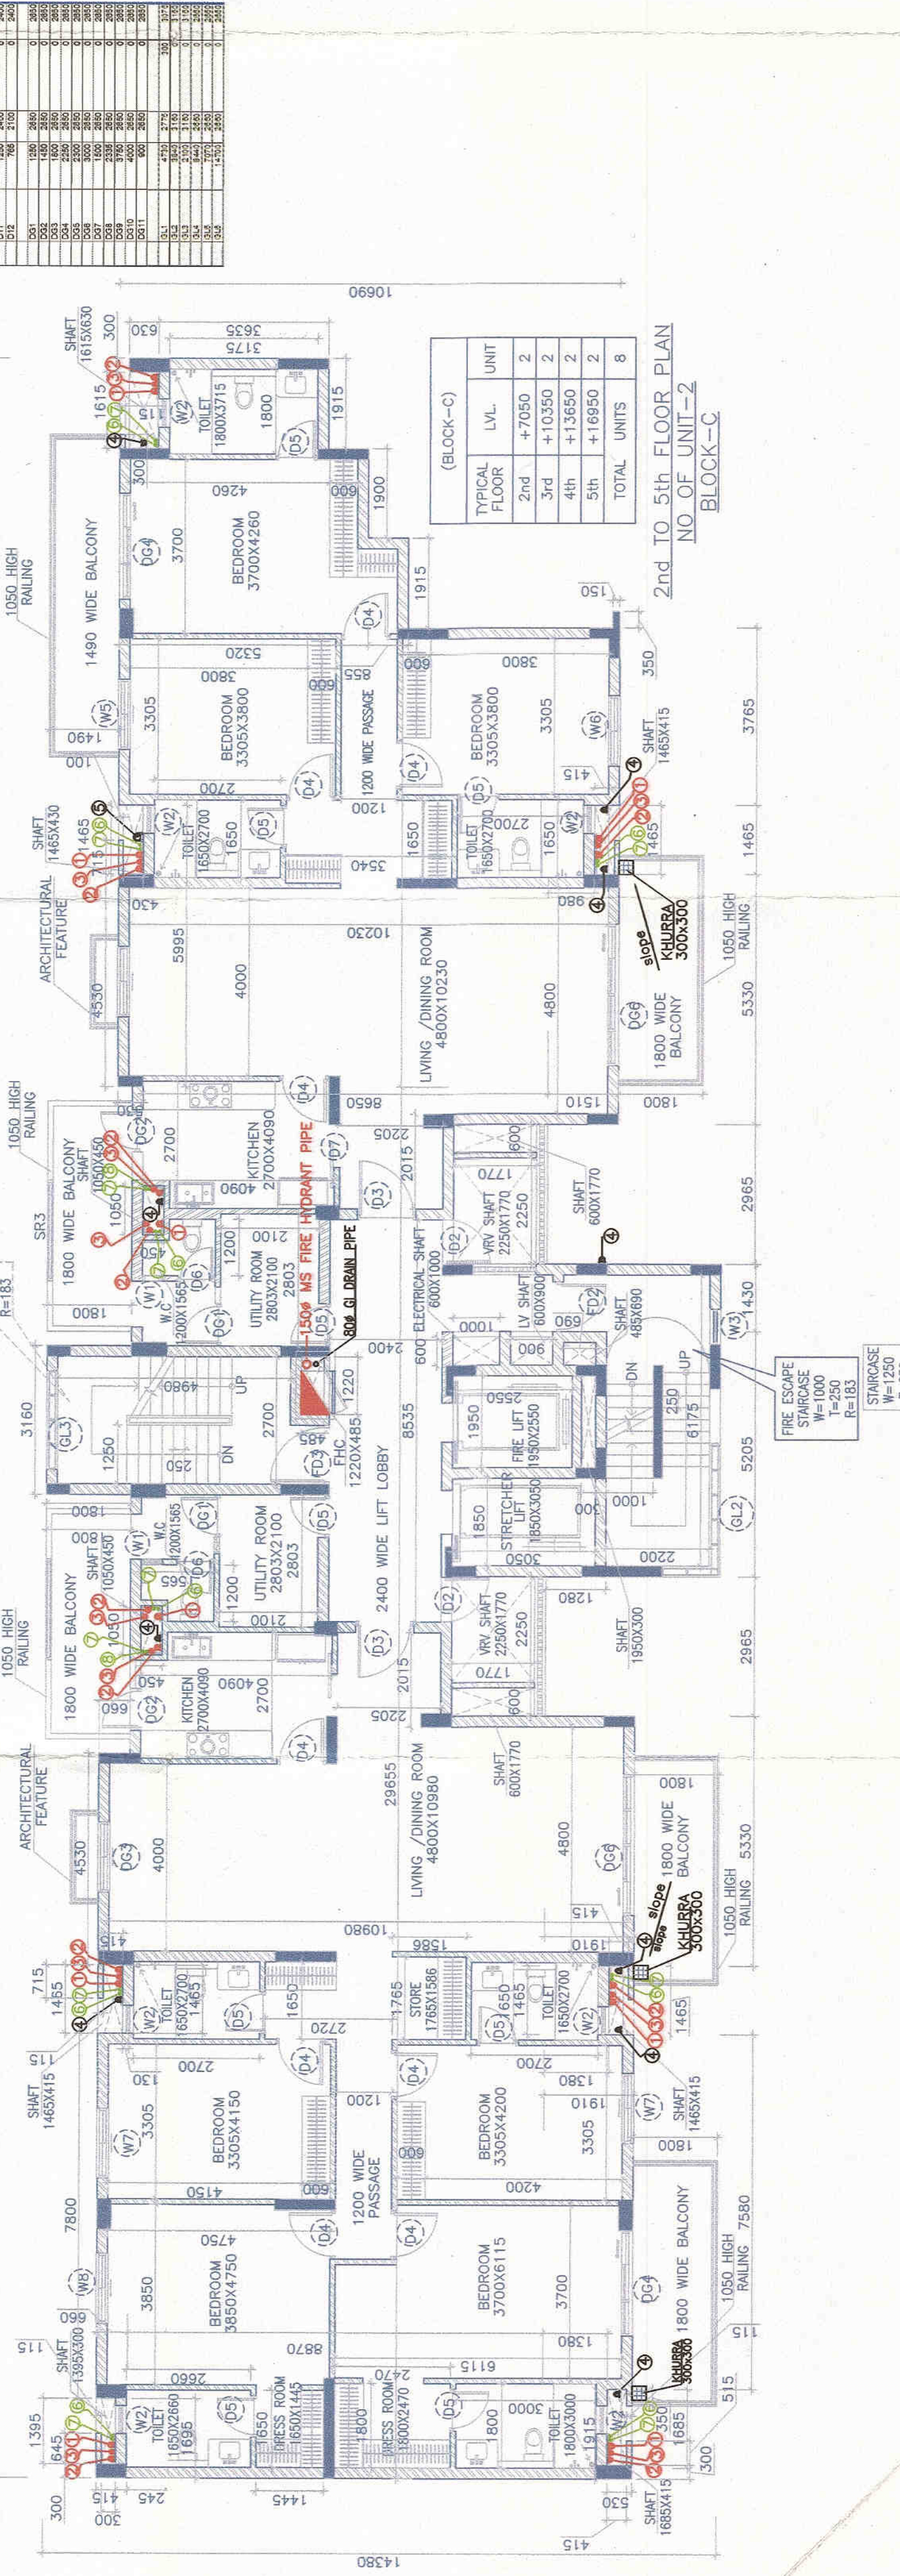
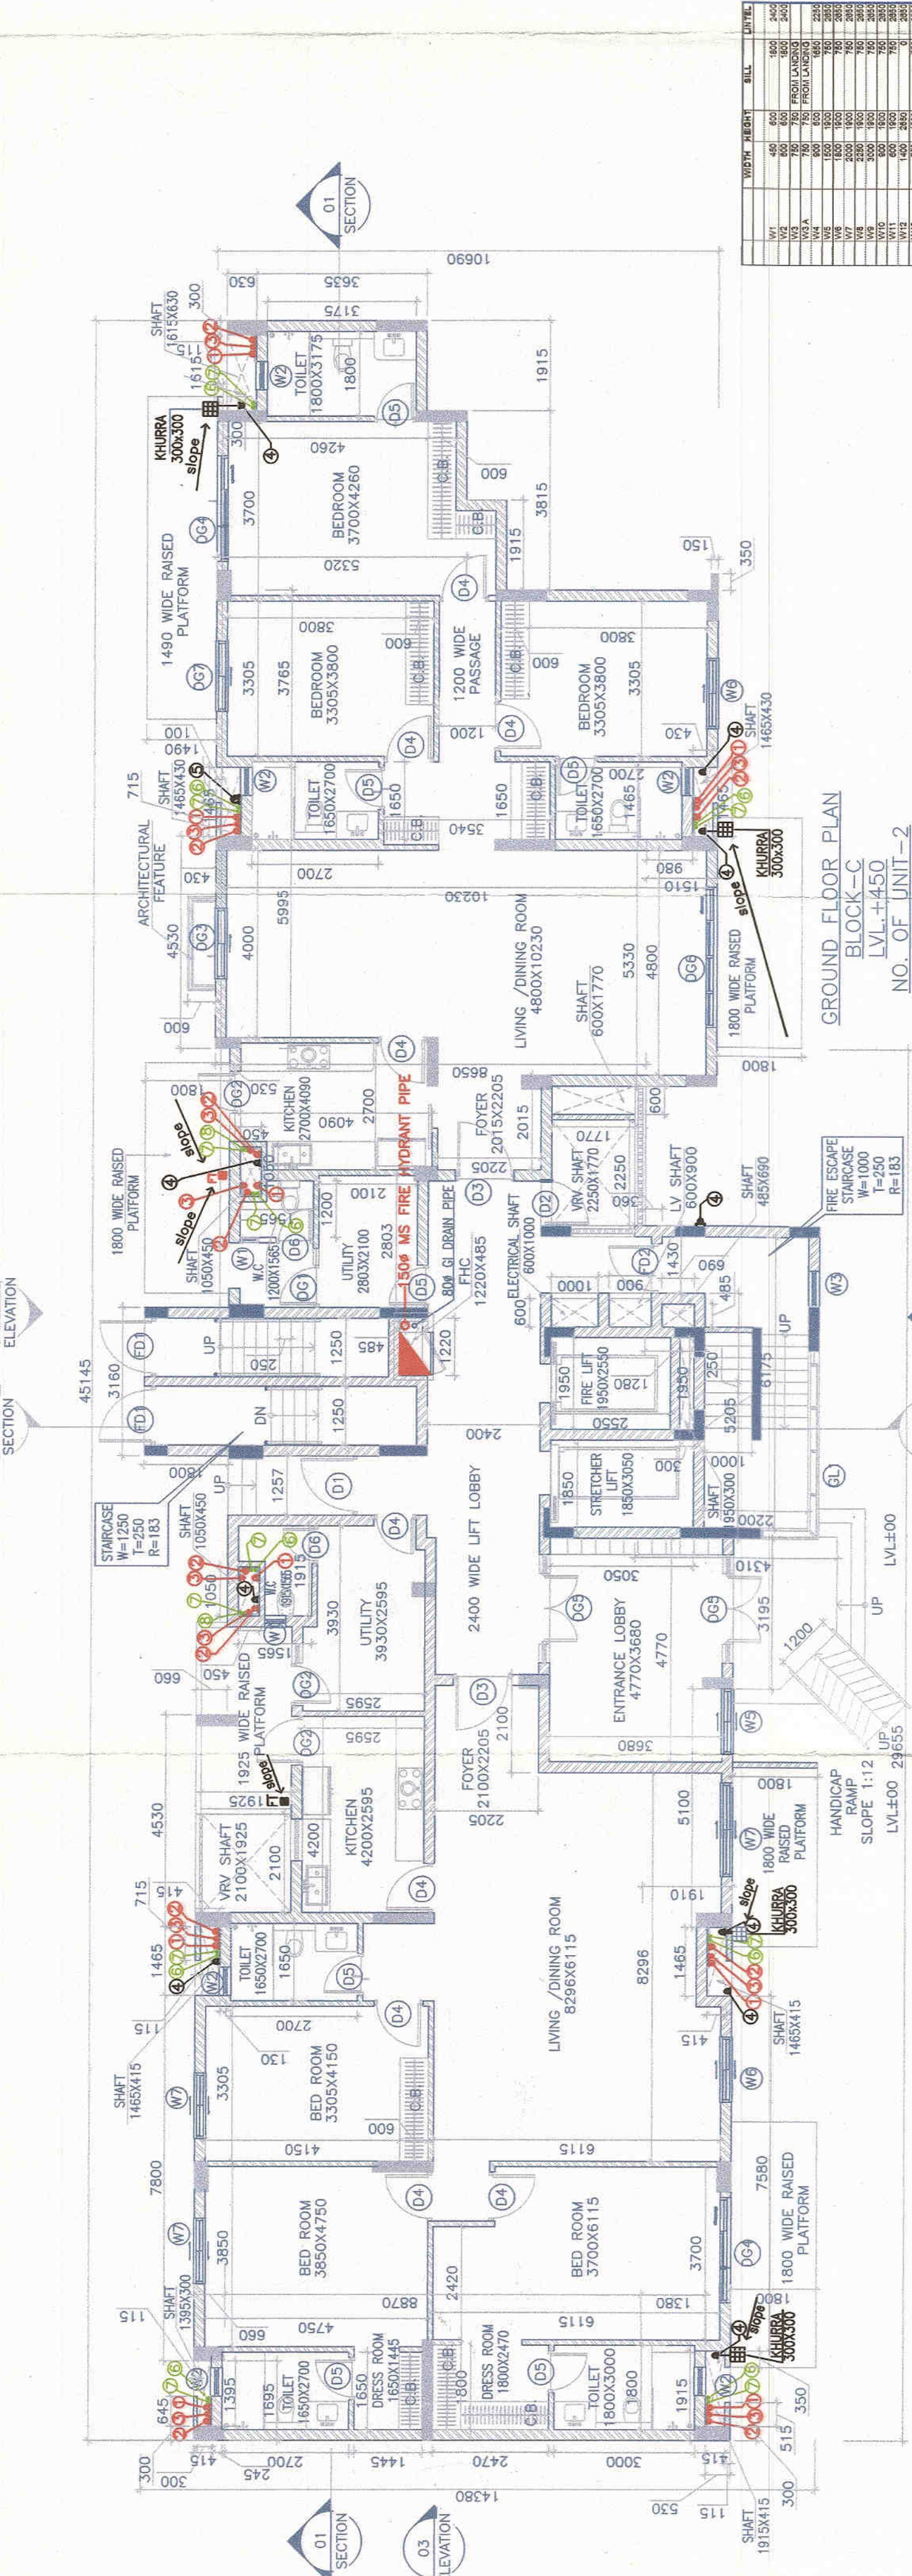
	ADDITION - D. (7TH FLOOR)				
d1 =	9.760	X	9.180	=	89.597 SQM.
d2 =	9.760	X	6.815	=	66.514 SQM.
d3 =	6.225	X	2.815	=	17.523 SQM.
d4 =	5.535	X	6.140	=	40.739 SQM.
			TOTAL		= 214.373 SQM.

165. AREA OF 7th FLOOR
 = 214.373
 165. BLUCK - C
 = 186.484 SQM.

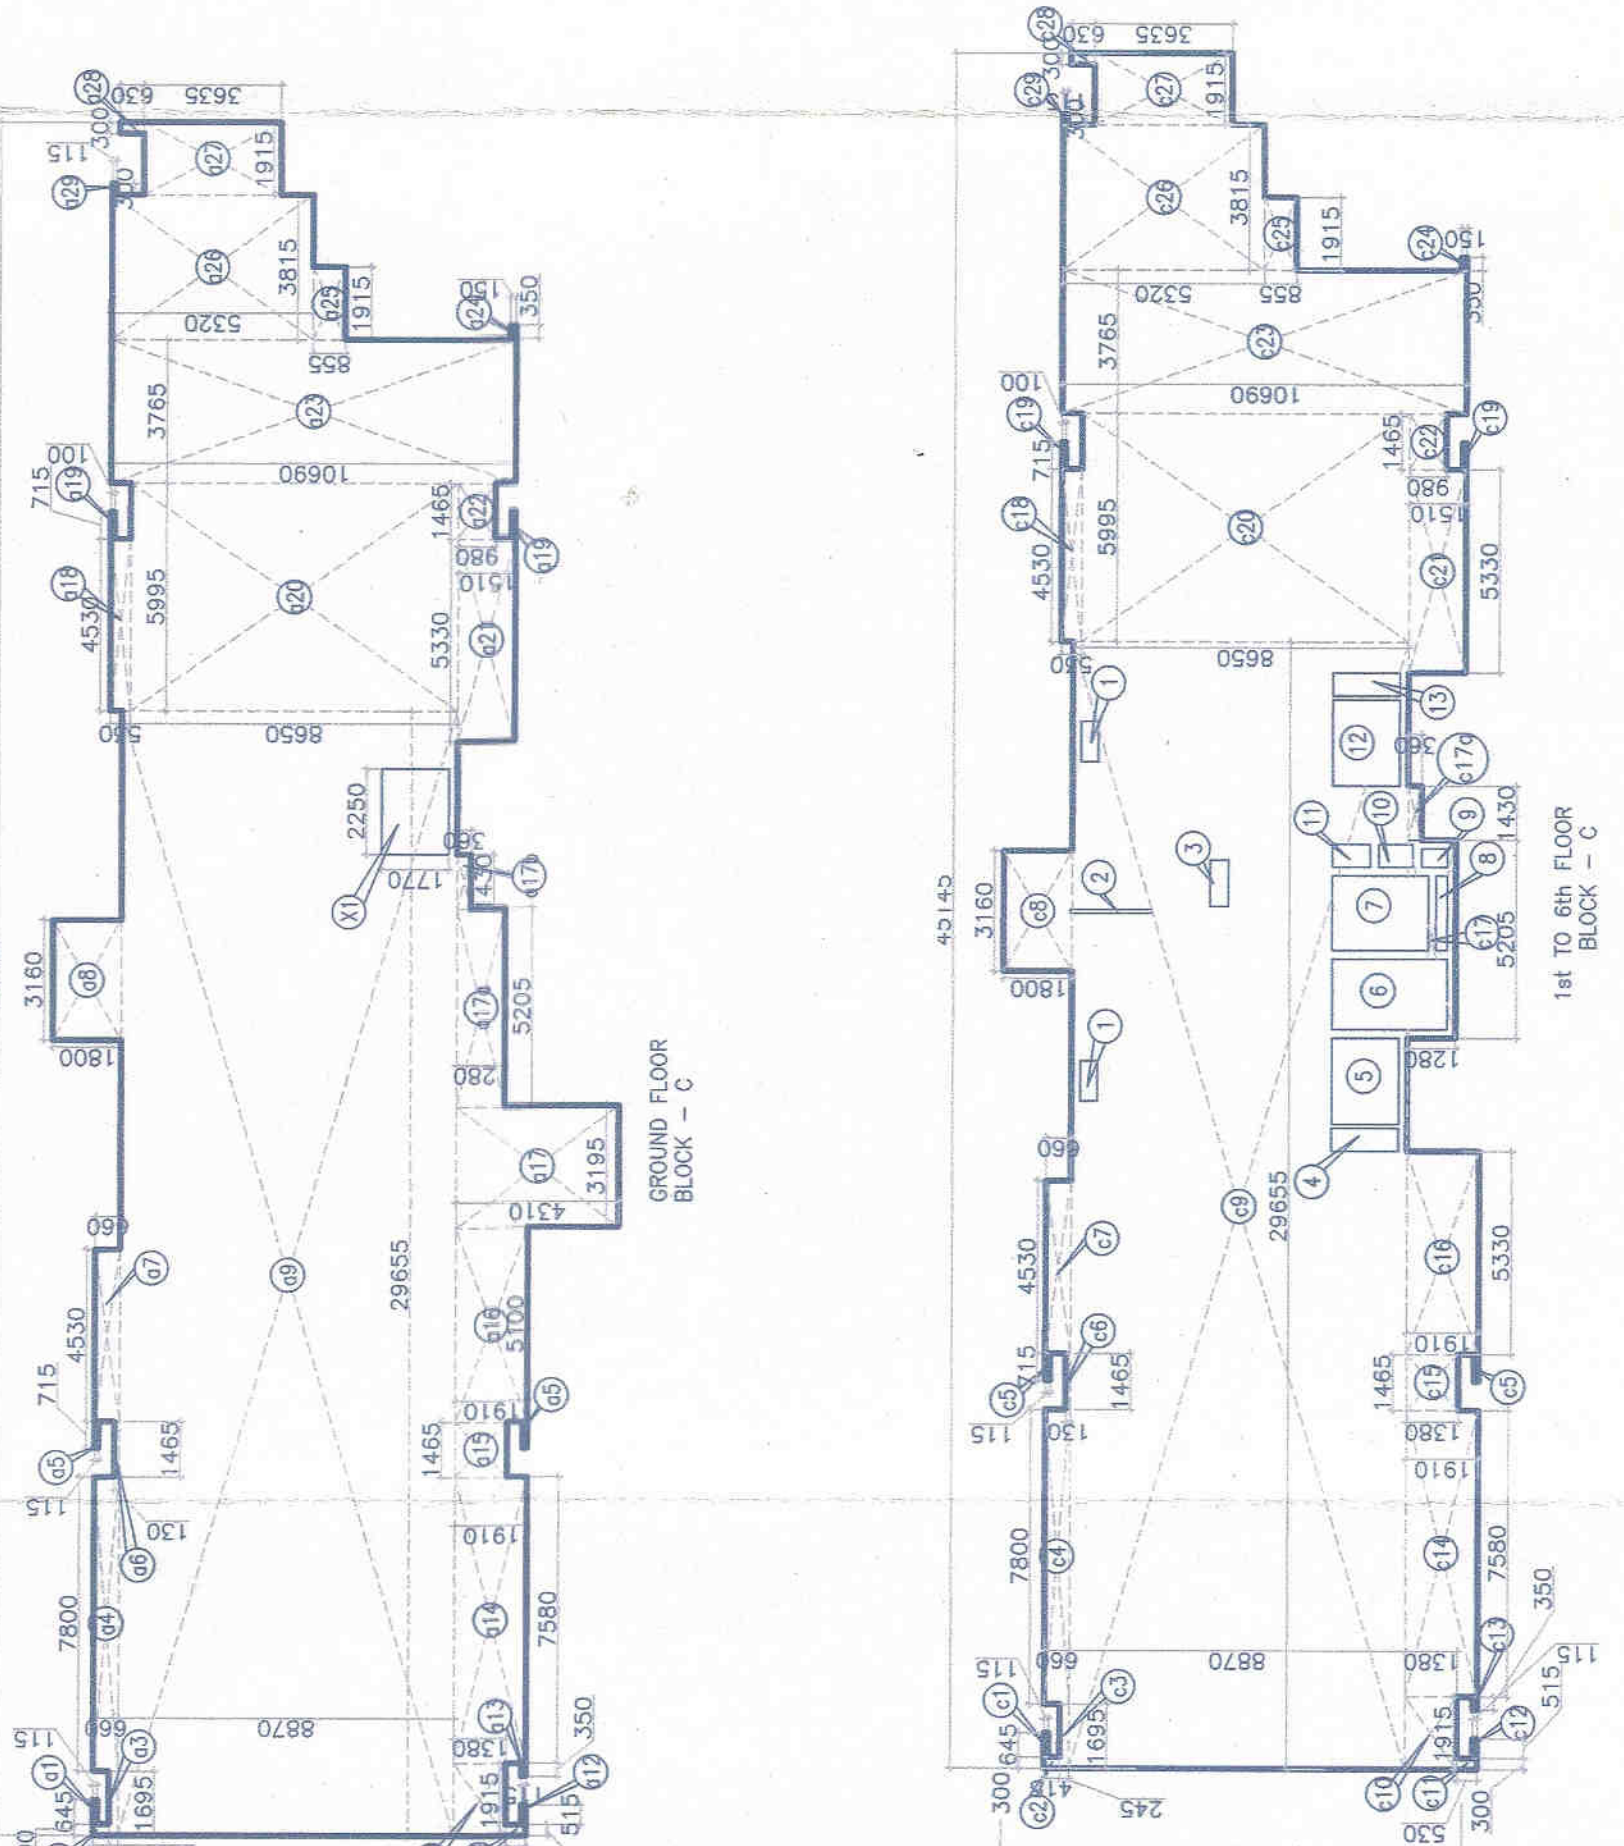


		DEDUCTION -1					
		1	2	3	4	5	6
1		1,000	X	0,450	X	2	0,945
2		0,100	X	2,150	X	1	0,215
3		1,200	X	0,485	X	1	0,502
4		0,600	X	1,770	X	1	1,062
5		2,250	X	1,770	X	1	3,943
6		1,850	X	3,050	X	1	4,903
7		1,950	X	2,550	X	1	4,972
8		1,950	X	0,200	X	1	0,585
9		0,485	X	0,690	X	1	0,335
10		0,900	X	0,600	X	1	0,540
11		0,900	X	1,605	X	1	0,600
12		2,250	X	1,770	X	1	3,983
13		0,600	X	1,770	X	1	3,052

ADDITION — C (7th-8th-9th-10th)									
	61	62	63	64	65	66	67	68	69
1	1645	1	0115	1	1	0074	5883		
2	3200	0415	1	1	0125	5883			
3	1695	0245	1	1	0415	5883			
4	7600	0660	1	1	0148	5883			
5	3715	0115	1	2	0160	5883			
6	1405	0130	1	1	0180	5883			
7	4300	0860	1	1	2890	5883			
8	3100	1600	1	1	5668	5883			
9	2825	8870	1	1	2033-040	5883			
10	1915	1380	1	1	2643	5883			
11	3300	0330	1	1	0159	5883			
12	5375	0115	1	1	0059	5883			
13	3200	0330	1	1	0059	5883			
14	7890	0115	1	1	1478	5883			
15	1465	1380	1	1	0078	5883			
16	3300	1915	1	1	3035	5883			
17	2300	1380	1	1	4618	5883			
18	4300	0360	1	1	0515	5883			
19	7915	0100	1	2	2401	5883			
20	9995	0600	1	1	2187	5883			
21	5300	1510	1	1	0048	5883			
22	1405	0990	1	1	4356	5883			
23	3795	10400	1	1	40248	5883			
24	3300	0100	1	1	1053	5883			
25	1915	0865	1	1	1637	5883			
26	3815	5300	1	1	20296	5883			
27	1915	1380	1	1	0189	5883			
28	3200	0360	1	1	0325	5883			
29	3200	0115	1	1	4186	5883			
30	3200	TOTAL							



7TH FLOOR PLAN
BLOCK C

[illegible]

SCALE-1:200

= ADDITION (A) -- DEDUCTION -- (X)