




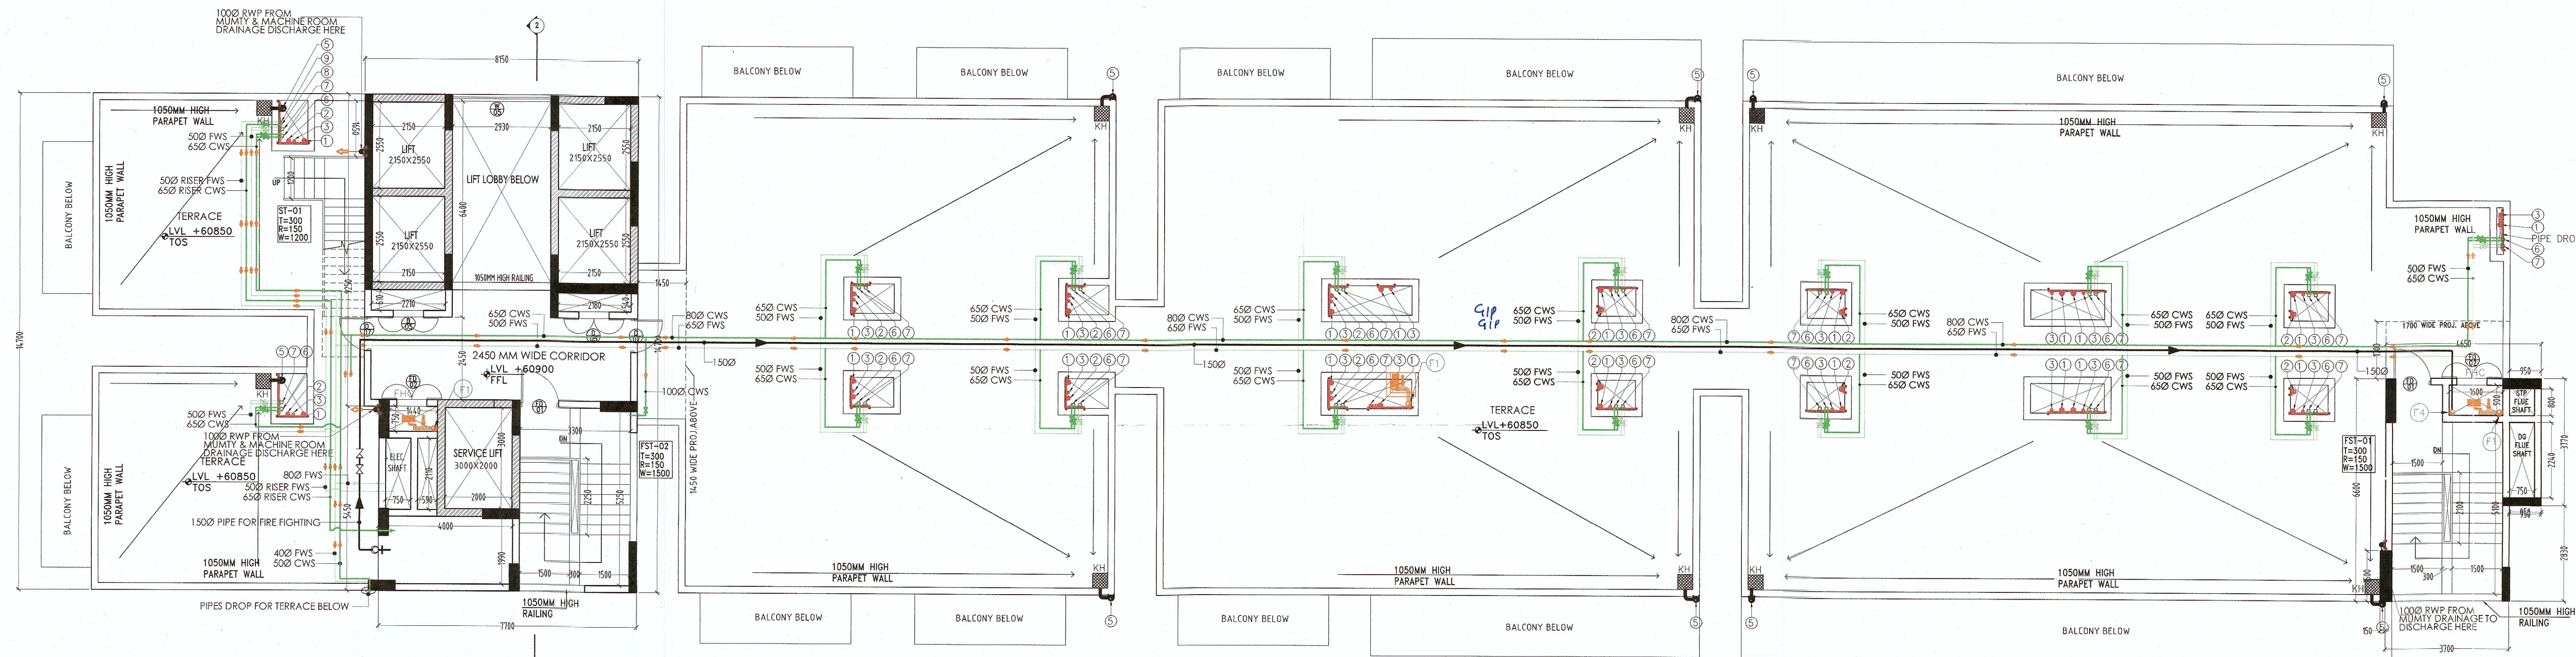


MUMTY FLOOR PLAN

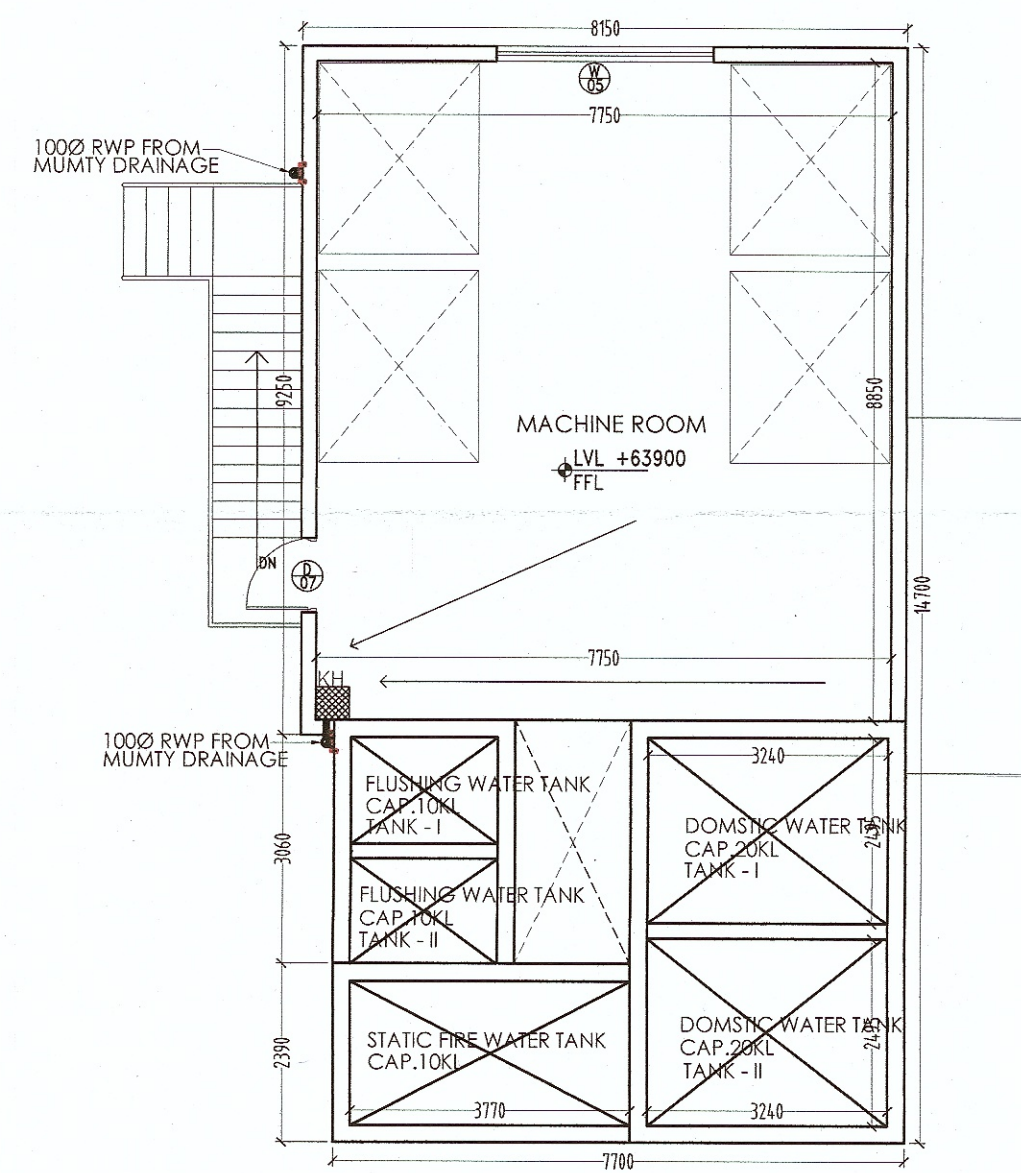

MACHINE ROOM PLAN

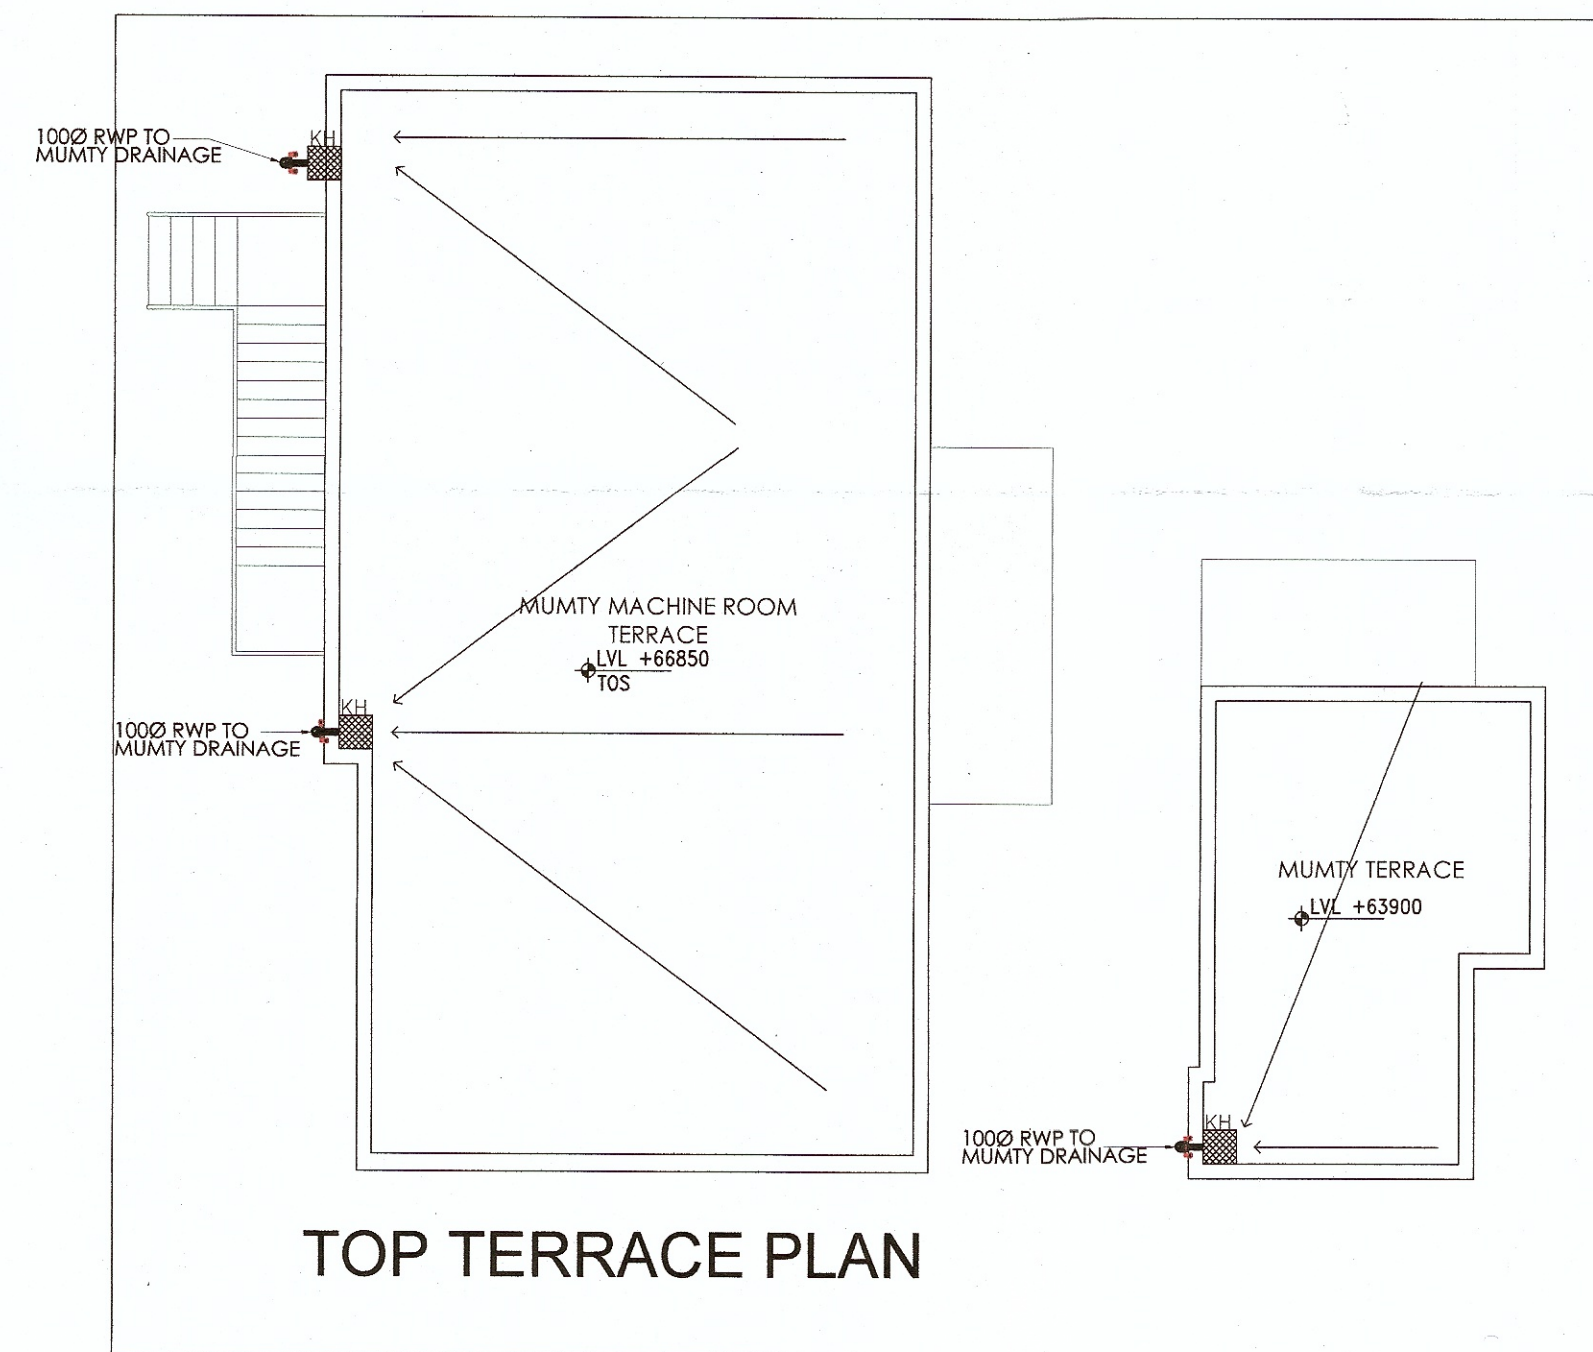

TOP TERRACE PLAN

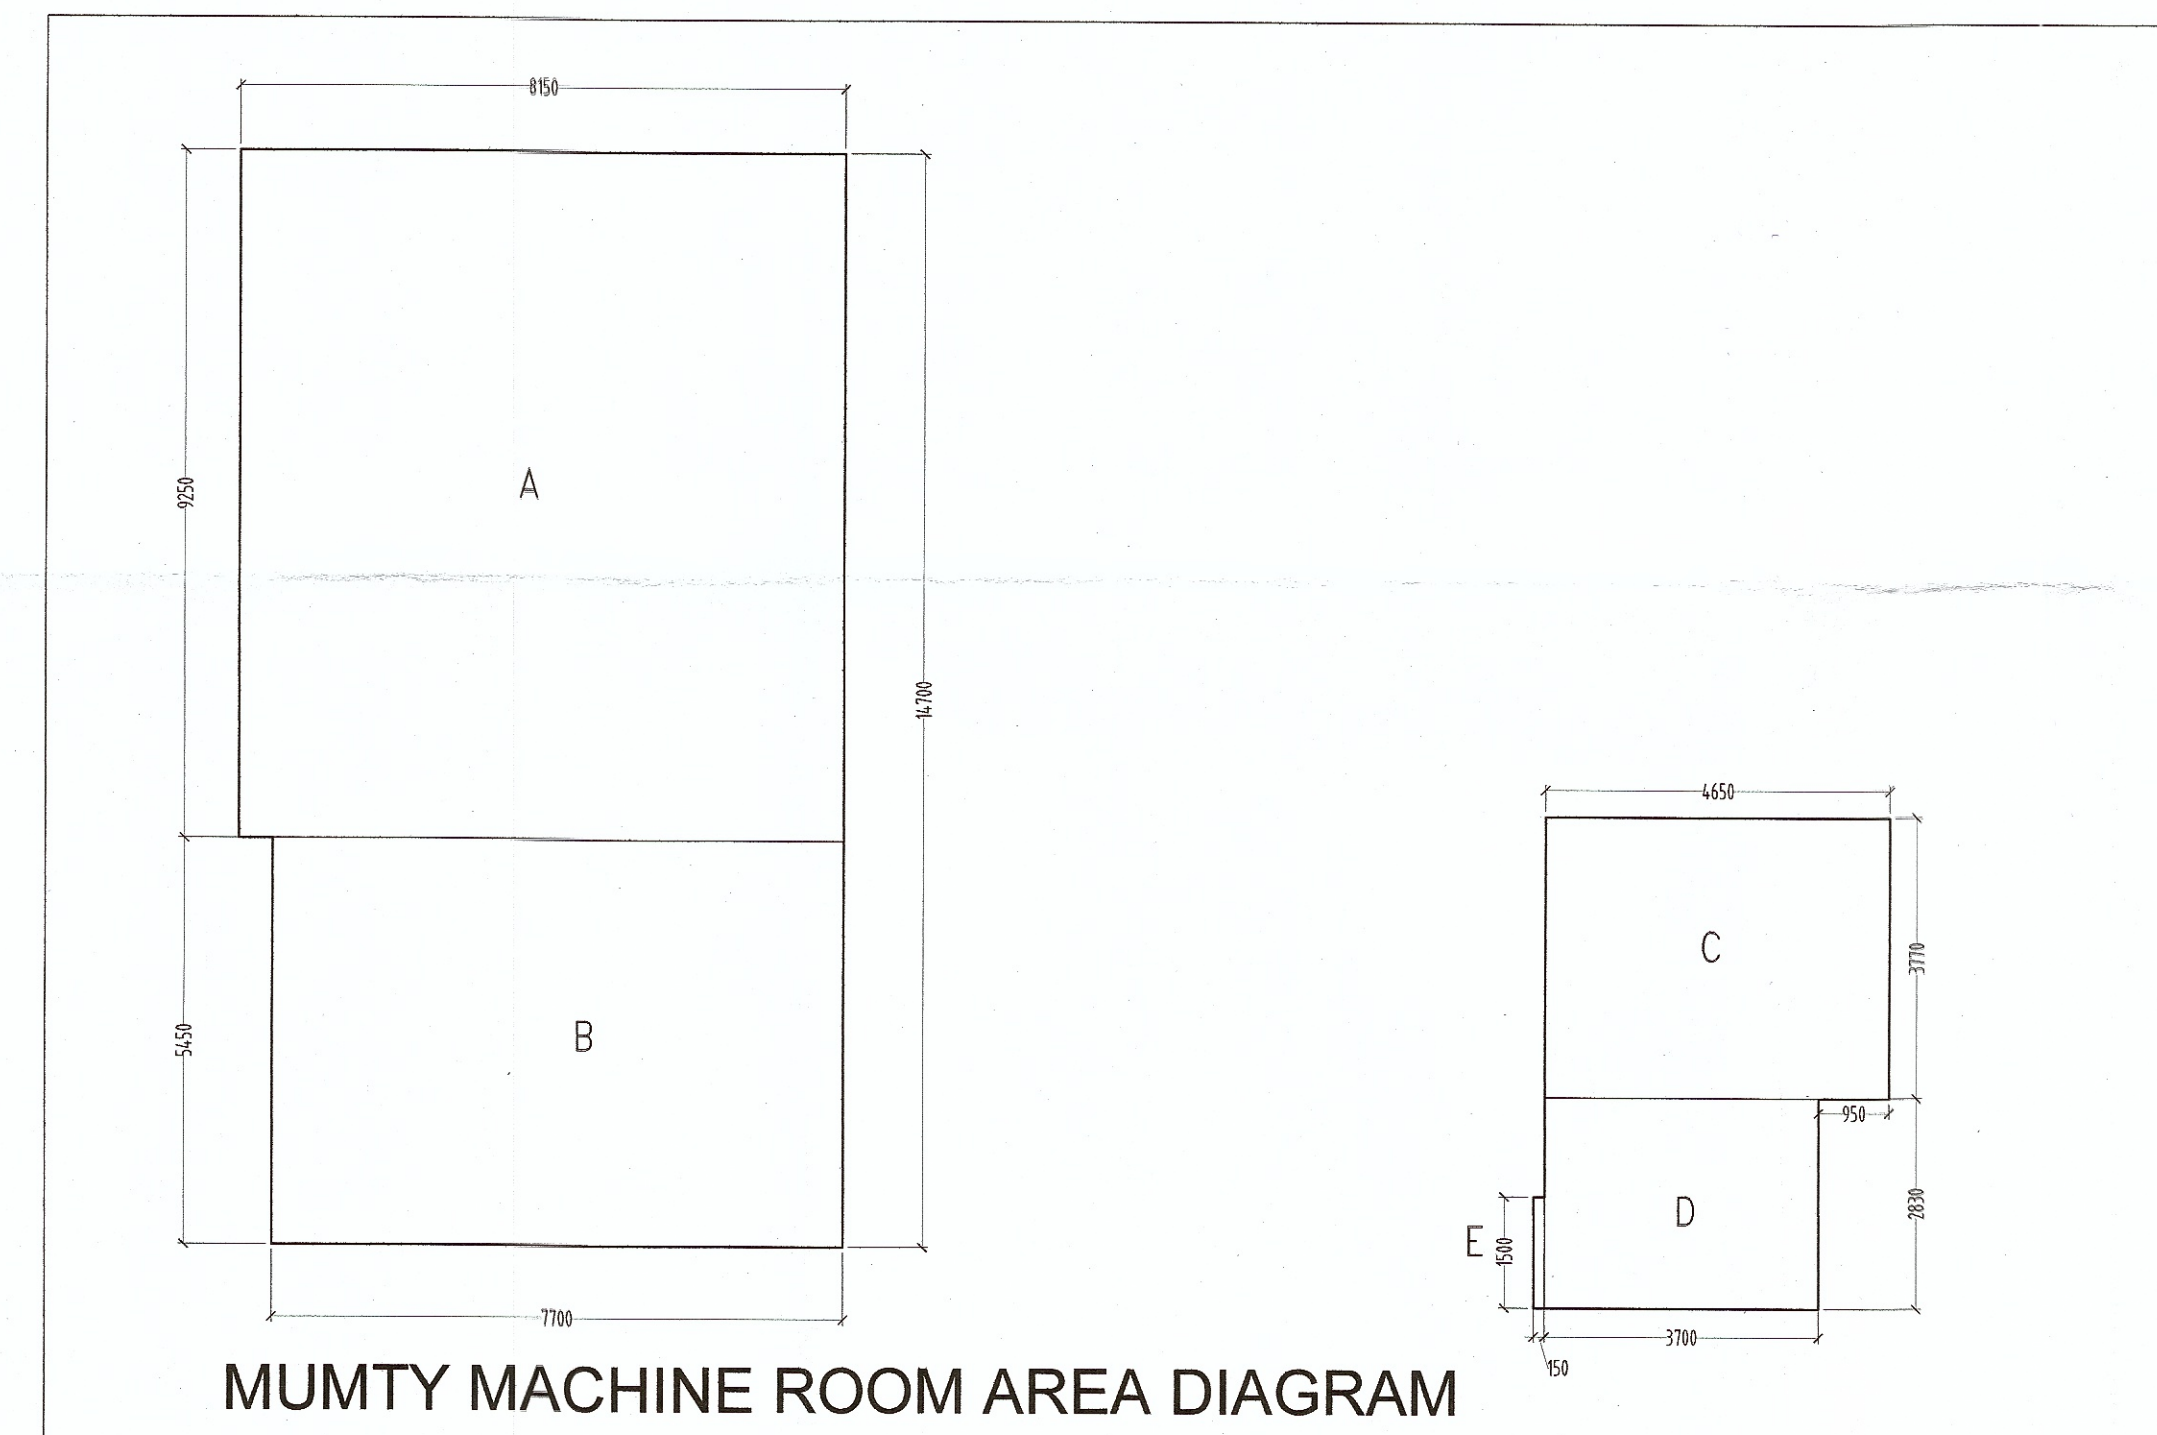

MUMTY MACHINE ROOM AREA DIAGRAM

TOP FLOOR MUMTY MACHINE ROOM AREA (NON F.A.R.)					
S.N.O.	NO.	PREFIX	LENGTH	BREATH	AREA
A	1	1	8.150	9.250	75.388
B	1	1	7.700	5.450	41.965
C	1	1	4.650	3.770	17.531
D	1	1	3.700	2.830	10.471
E	1	1	0.150	1.500	0.225
TOTAL ADDITION					145.354
SUBTRACTIONS					
S.N.O.	NO.	PREFIX	LENGTH	BREATH	AREA
1	1	0	0.000	0.000	0.000
TOTAL SUBTRACTION					0.000
TOTAL TOP FLOOR MUMTY MACHINE ROOM AREA					145.354

TOTAL F.A.R.		
TOTAL F.A.R. ON GROUND FLOOR		1325.645
TOTAL F.A.R. ON FIRST FLOOR		1163.846
TOTAL F.A.R. ON SECOND FLOOR		1238.661
TOTAL F.A.R. ON THIRD FLOOR		1238.661
TOTAL F.A.R. ON FOURTH FLOOR		1238.661
TOTAL F.A.R. ON FIFTH FLOOR		1238.661
TOTAL F.A.R. ON SIXTH FLOOR		1238.661
TOTAL F.A.R. ON SEVENTH FLOOR		1238.526
TOTAL F.A.R. ON EIGHTH FLOOR		1238.526
TOTAL F.A.R. ON NINTH FLOOR		1238.526
TOTAL F.A.R. ON TENTH FLOOR		1238.526
TOTAL F.A.R. ON ELEVENTH FLOOR		1238.526
TOTAL F.A.R. ON TWELFTH FLOOR		1238.526
TOTAL F.A.R. ON THIRTEENTH FLOOR		934.418
TOTAL F.A.R. ON FOURTEENTH FLOOR		934.418
TOTAL F.A.R. ON FIFTEENTH FLOOR		934.418
TOTAL F.A.R. ON SIXTEENTH FLOOR		934.418
TOTAL F.A.R. ON SEVENTEENTH FLOOR		934.418
TOTAL F.A.R. ON EIGHTEENTH FLOOR		934.418
TOTAL F.A.R. ON NINETEENTH FLOOR		934.418
TOTAL F.A.R.		22654.878

BUILT-UP AREA					
S.N.O.	NO.	PREFIX	LENGTH	BREATH	AREA
TOTAL F.A.R.					22654.878
MUMTY ON 13TH FLOOR					25.034
MAUMTY MACHINE ROOM TOP FL.					145.354
TOAL BUILT-UP AREA					22825.266

LEGEND	
DESCRIPTION	SYMBOL
FIRE HOSE CABINET	FHC

PIPE SCHEDULE		
PIPE NO.	DESCRIPTION	DIA (MM)
F1	WET RISER FOR FIRE HYDRANTS SYSTEM	150
F2	WET RISER FOR SPRINKLER SYSTEM	150
F3	DRAIN PIPE	80
F4	DOWN COMER FOR SPRINKLERS	150

SCHEDULE OF PIPES

PIPE NO.	DESCRIPTION	DIA (mm)
1	SOIL, WASTE & VENT PIPE	110
2	WASTE & VENT PIPE	110
3	VENT PIPE	75
4	RAIN WATER PIPE FOR BALCONY	110
5	RAIN WATER PIPE FOR TERRACE	160
6	CWS DROP FROM OHT	*
7	FWS DROP FROM OHT	*
8	COLD WATER RISER TO OHT	*
9	FLUSHING WATER RISER TO OHT	*

*AS PER WATER SUPPLY DISTRIBUTION DIAGRAM.

LEGEND	
DESCRIPTION	LEGEND
SOIL, WASTE AND VENT PIPE	HCIIP
SOIL AND VENT PIPE	HCIIP
WASTE AND VENT PIPE	HCIIP
VENT PIPE	HCIIP
RAIN WATER PIPE FOR BALCONY	HCIIP
RAIN WATER PIPE FOR TERRACE	HCIIP
COLD WATER SUPPLY DROP FROM O.H.T.	HCIIP
FLUSHING WATER SUPPLY DROP FROM O.H.T.	HCIIP
COLD WATER SUPPLY RISER TO O.H.T.	HCIIP
FLUSHING WATER SUPPLY RISER TO O.H.T.	HCIIP
FLOOR TRAP	FT
DRAIN POINT	DP
KHURRA (300X300MM)	KH
SOIL PIPE	SP
WASTE PIPE	WP
COLD WATER SUPPLY	CWS
HOT WATER SUPPLY	HWS
FLUSHING WATER SUPPLY	FWS
ISOLATING VALVE	IV

DOOR WINDOW SCHEDULE					
S.NO	SIZE	SILL LVL	LINTEL	REMARKS	
D01	1050X2200	-	2200		
D02	900X2200	-	2200		
D03	950X2200	-	2200		
D04	900X2200	-	2200		
D05	900X2200	100	2200		
D06	1500X2200	-	2200		
D07	1000X2200	-	2200		
W01	750X700	1500	2200		
W02	600X1150	1050	2200		
W03	1400X1150	1050	2200		
W04	1050X1150	1050	2200		
W05	2830X1150	1050	2200		
W06	3050X1150	1050	2200		
W07	575X1150	1050	2200		
W08	1100X1150	1050	2200		
W09	2100X1150	1050	2200		
W10	1300X1150	1050	2200		
W11	1150X1150	1050	2200		
DG01	2100X2200	-	2200		
DG02	2400X2200	-	2200		
DG03	2500X2200	-	2200		
FD01	1150X2200	-	2200		
FD02	900X2200	-	2200		

- NOTES :-
1. ALL DIMENSIONS ARE IN MM
 2. GATE & B/WALL AS/STD DESIGN
 3. THE RESPONSIBILITY OF THE STRUCTURAL DRG, STRUCTURAL STABILITY OF THE BUILDING BLOCK AGAINST THE EARTHQUAKE SHALL BE SOLELY OF OWNER/ ARCHITECT / ENGINEER.
 4. BUILDING SHALL BE FULLY AIR CONDITIONED, MECHANICALLY VENTILATED & FULLY SPRINKLED WITH 100% POWER BACKUP.

Project:
PROPOSED BUILDING PLAN FOR COMMERCIAL COLONY ADMEASURING 3.5 ACRE (LICENSE NO. 4 OF 2016 DATED 26-04-2016) IN SEC. 106, GURGAON BEING DEVELOPED BY M/S. MAGIC EYE DEVELOPERS PVT.LTD.

OWNERS
M/S.MAGIC EYE DEVELOPERS
PVT.LTD.

DESIGN CONSULTANTS:
ACA
AJOY CHOUDHURY & ASSOCIATES
ARCHITECTURE
URBAN DESIGN
SUITE #103-103, 10TH FLOOR, DLF GALLERIA TOWERS
DLF CITY, PHASE-IV, GURGAON-122002, HARYANA

OWNER'S SEAL & SIGNATURE
For Magic Eye Developers Pvt. Ltd.
AJOY CHOUDHURY
Authorized Signatory

ARCHITECT'S SEAL & SIGNATURE
AJOY CHOUDHURY
CA/75/632

SEP. 2016 SCALE - 1:100
TITLE:- MUMTY MACHINE ROOM FLOOR PLAN & AREA CALCULATION
DRAWING NO:- A-ST-110



SANCTIONED

To be read in conjunction with memo no. 27642 Dtd. 21-12-2016

D.P. (HQ) Member Secretary B.P.C.
S.T. (G) Member B.P.C.
C.T.P. (HQ) Chairman B.P.C.

Check: and found ok for Public Health (Internal) Service only subject to comments in forwarding letter No. SE(HQ)/.....Dt. 22-12-2016

Superintending Engineer (HO) HUDA, Panchkula.

27/10/16

(BALWANT SINGH) SD(HQ)