

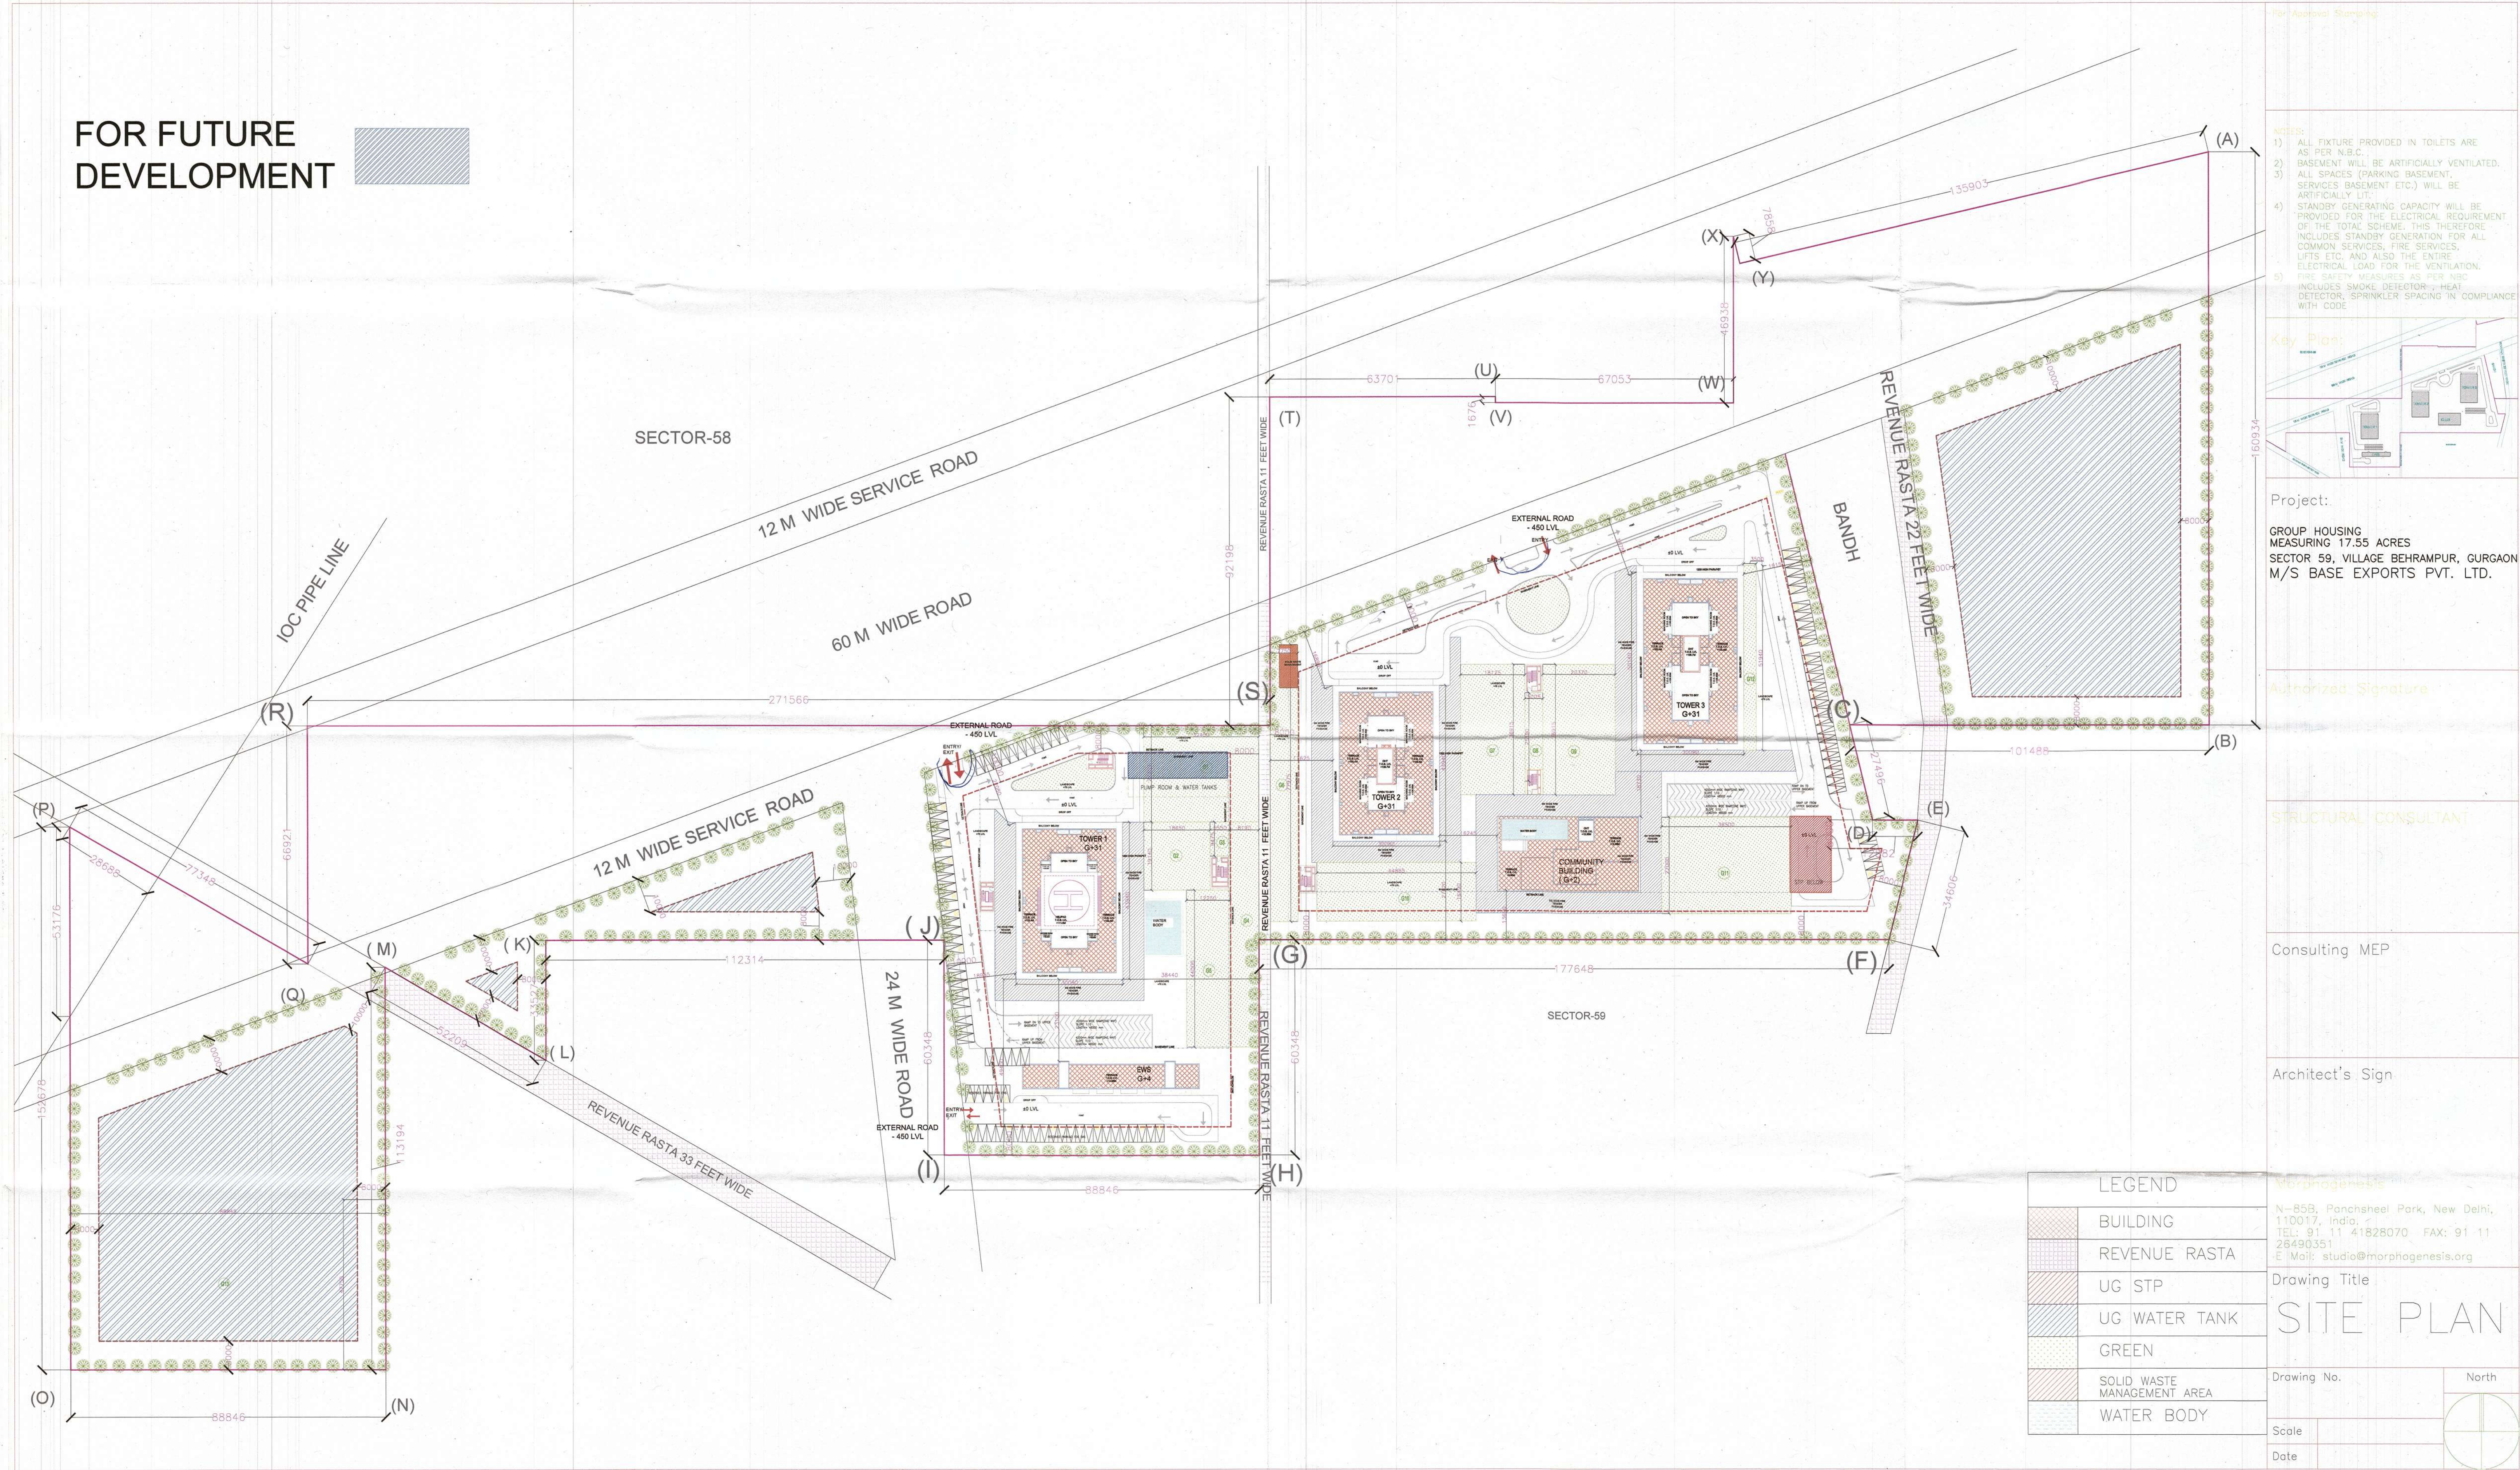


FOR FUTURE DEVELOPMENT

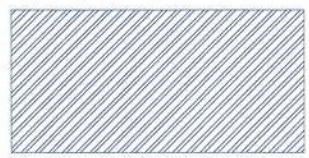

For Approval Stamping

- NOTES:
- 1) ALL FIXTURE PROVIDED IN TOILETS ARE AS PER N.B.C.
 - 2) BASEMENT WILL BE ARTIFICIALLY VENTILATED.
 - 3) ALL SPACES (PARKING BASEMENT, SERVICES BASEMENT ETC.) WILL BE ARTIFICIALLY LIT.
 - 4) STANDBY GENERATING CAPACITY WILL BE PROVIDED FOR THE ELECTRICAL REQUIREMENT OF THE TOTAL SCHEME. THIS THEREFORE INCLUDES STANDBY GENERATION FOR ALL COMMON SERVICES, FIRE SERVICES, LIFTS ETC. AND ALSO THE ENTIRE ELECTRICAL LOAD FOR THE VENTILATION.
 - 5) FIRE SAFETY MEASURES AS PER NBC INCLUDES SMOKE DETECTOR, HEAT DETECTOR, SPRINKLER SPACING IN COMPLIANCE WITH CODE.

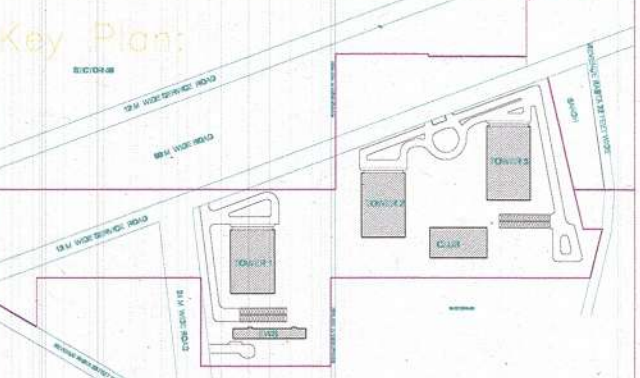

Project:

GROUP HOUSING
MEASURING 17.55 ACRES
SECTOR 59, VILLAGE BEHRAMPUR, GURGAON
M/S BASE EXPORTS PVT. LTD.

Authorized Signature

STRUCTURAL CONSULTANT

Consulting MEP

Architect's Sign

Morphogenesis
N-85B, Panchsheel Park, New Delhi,
110017, India. TEL: 91 11 41828070 FAX: 91 11
26490351
E Mail: studio@morphogenesis.org

Drawing Title

SITE PLAN

Drawing No.

Scale

Date