

PLUMBING LEGEND=

- 1- 110(00) SOL PIPE
- 2- 110(00) SOL PIPE
- 3- 110(00) SOL PIPE
- 4- 110(00) SOL PIPE
- 5- 80(00) ANTI-SIPHONAGE PIPE
- 6- DOMESTIC WATER SUPPLY PIPE
- 7- DOMESTIC WATER SUPPLY PIPE
- 8- DOMESTIC WATER SUPPLY RISER
- 9- FISHING WATER SUPPLY RISER
- 10- 110(00) RAIN WATER PIPE
- 11- 110(00) RAIN WATER PIPE
- 12- 110(00) RAIN WATER PIPE
- 13- DOMESTIC WATER SUPPLY
- 14- DOMESTIC WATER SUPPLY
- 15- DOMESTIC WATER SUPPLY
- 100- DOMESTIC WATER SUPPLY

DOOR WINDOW SCHEDULE

SNO.	TYPE	SIZE	SQ. M.	LEVEL
1	D	2000X2100	4.20	00
2	D	2000X2100	4.20	00
3	D	2000X2100	4.20	00
4	D	2000X2100	4.20	00
5	D	2000X2100	4.20	00
6	D	2000X2100	4.20	00
7	D	2000X2100	4.20	00
8	D	2000X2100	4.20	00
9	D	2000X2100	4.20	00
10	D	2000X2100	4.20	00
11	D	2000X2100	4.20	00
12	D	2000X2100	4.20	00
13	D	2000X2100	4.20	00
14	D	2000X2100	4.20	00
15	D	2000X2100	4.20	00
16	D	2000X2100	4.20	00

PROJECT

REVISED BUILDING PLANS FOR
Group Housing scheme measuring 35,2515 sq.m
(License No. 155 of 2008 dated 14.06.2008) in
(License No. 200 of 2008 dated 08.12.2008) in
the City of Chennai, Tamil Nadu, India
being
executed by Gurupriya Infra Pvt. Ltd.
Landscape Structures Pvt. Ltd. & Arcant Properties Pvt. Ltd.

**GROUND FLOOR PLAN
(TOWER-5)**

OWNERS SIGN _____


ARCHITECTS SIGN _____

DATE _____

SCALE 1:100

DRAWN BY _____

DRG. NO TH755SUB-29

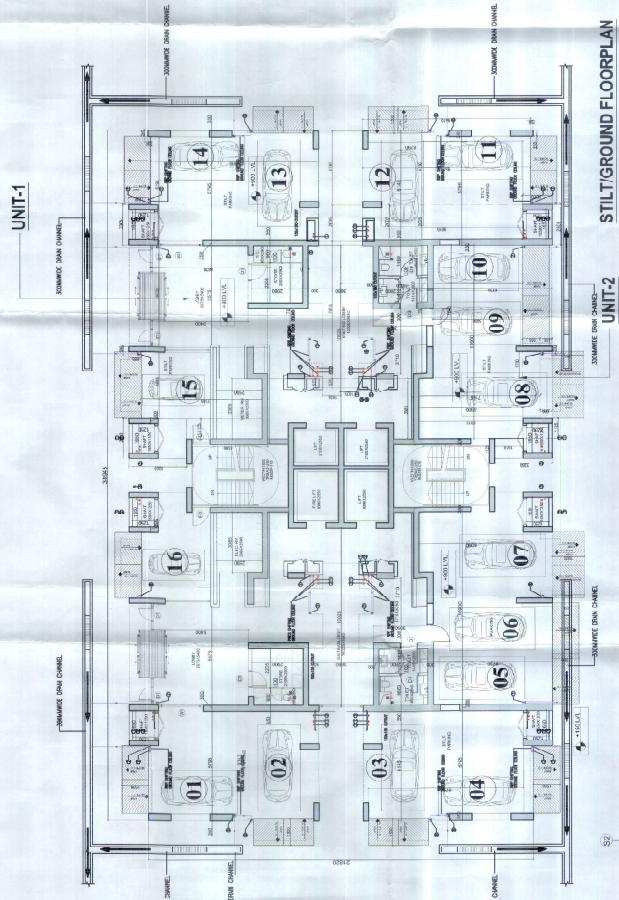

STILT/GROUND FLOORPLAN
NO OF CAR PARKING- 16 CARS

AREA DETAIL SINGLE UNIT-1


SNO.	TYPE	SIZE	SQ. M.
1	D	2000X2100	4.20
2	D	2000X2100	4.20
3	D	2000X2100	4.20
4	D	2000X2100	4.20
5	D	2000X2100	4.20
6	D	2000X2100	4.20
7	D	2000X2100	4.20
8	D	2000X2100	4.20
9	D	2000X2100	4.20
10	D	2000X2100	4.20
11	D	2000X2100	4.20
12	D	2000X2100	4.20
13	D	2000X2100	4.20
14	D	2000X2100	4.20
15	D	2000X2100	4.20
16	D	2000X2100	4.20

TOTAL 172.235

AREA DETAIL SINGLE UNIT-2

SNO.	TYPE	SIZE	SQ. M.
1	D	2000X2100	4.20
2	D	2000X2100	4.20
3	D	2000X2100	4.20
4	D	2000X2100	4.20
5	D	2000X2100	4.20
6	D	2000X2100	4.20
7	D	2000X2100	4.20
8	D	2000X2100	4.20
9	D	2000X2100	4.20
10	D	2000X2100	4.20
11	D	2000X2100	4.20
12	D	2000X2100	4.20
13	D	2000X2100	4.20
14	D	2000X2100	4.20
15	D	2000X2100	4.20
16	D	2000X2100	4.20

TOTAL 172.235

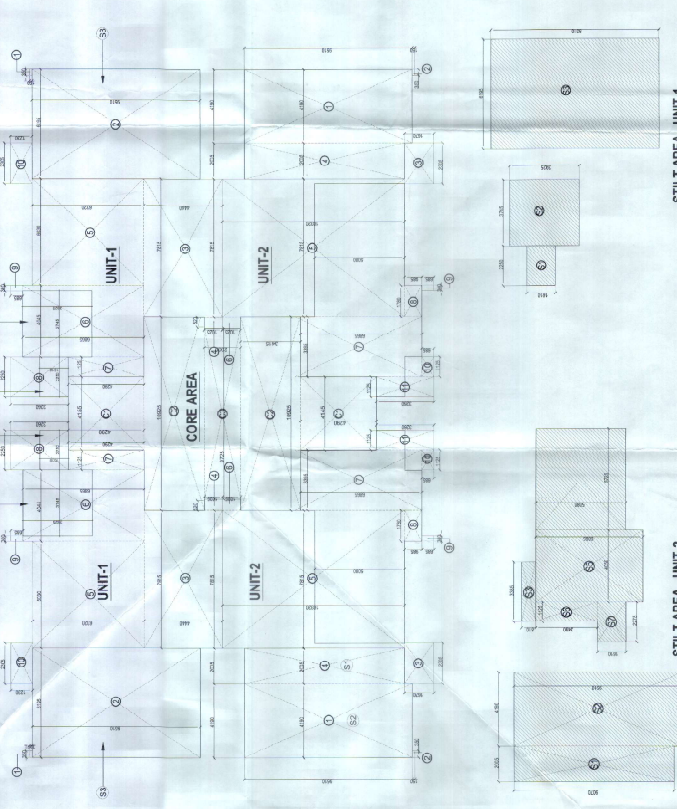

STILT AREA - UNIT-1

STILT AREA - UNIT-2