


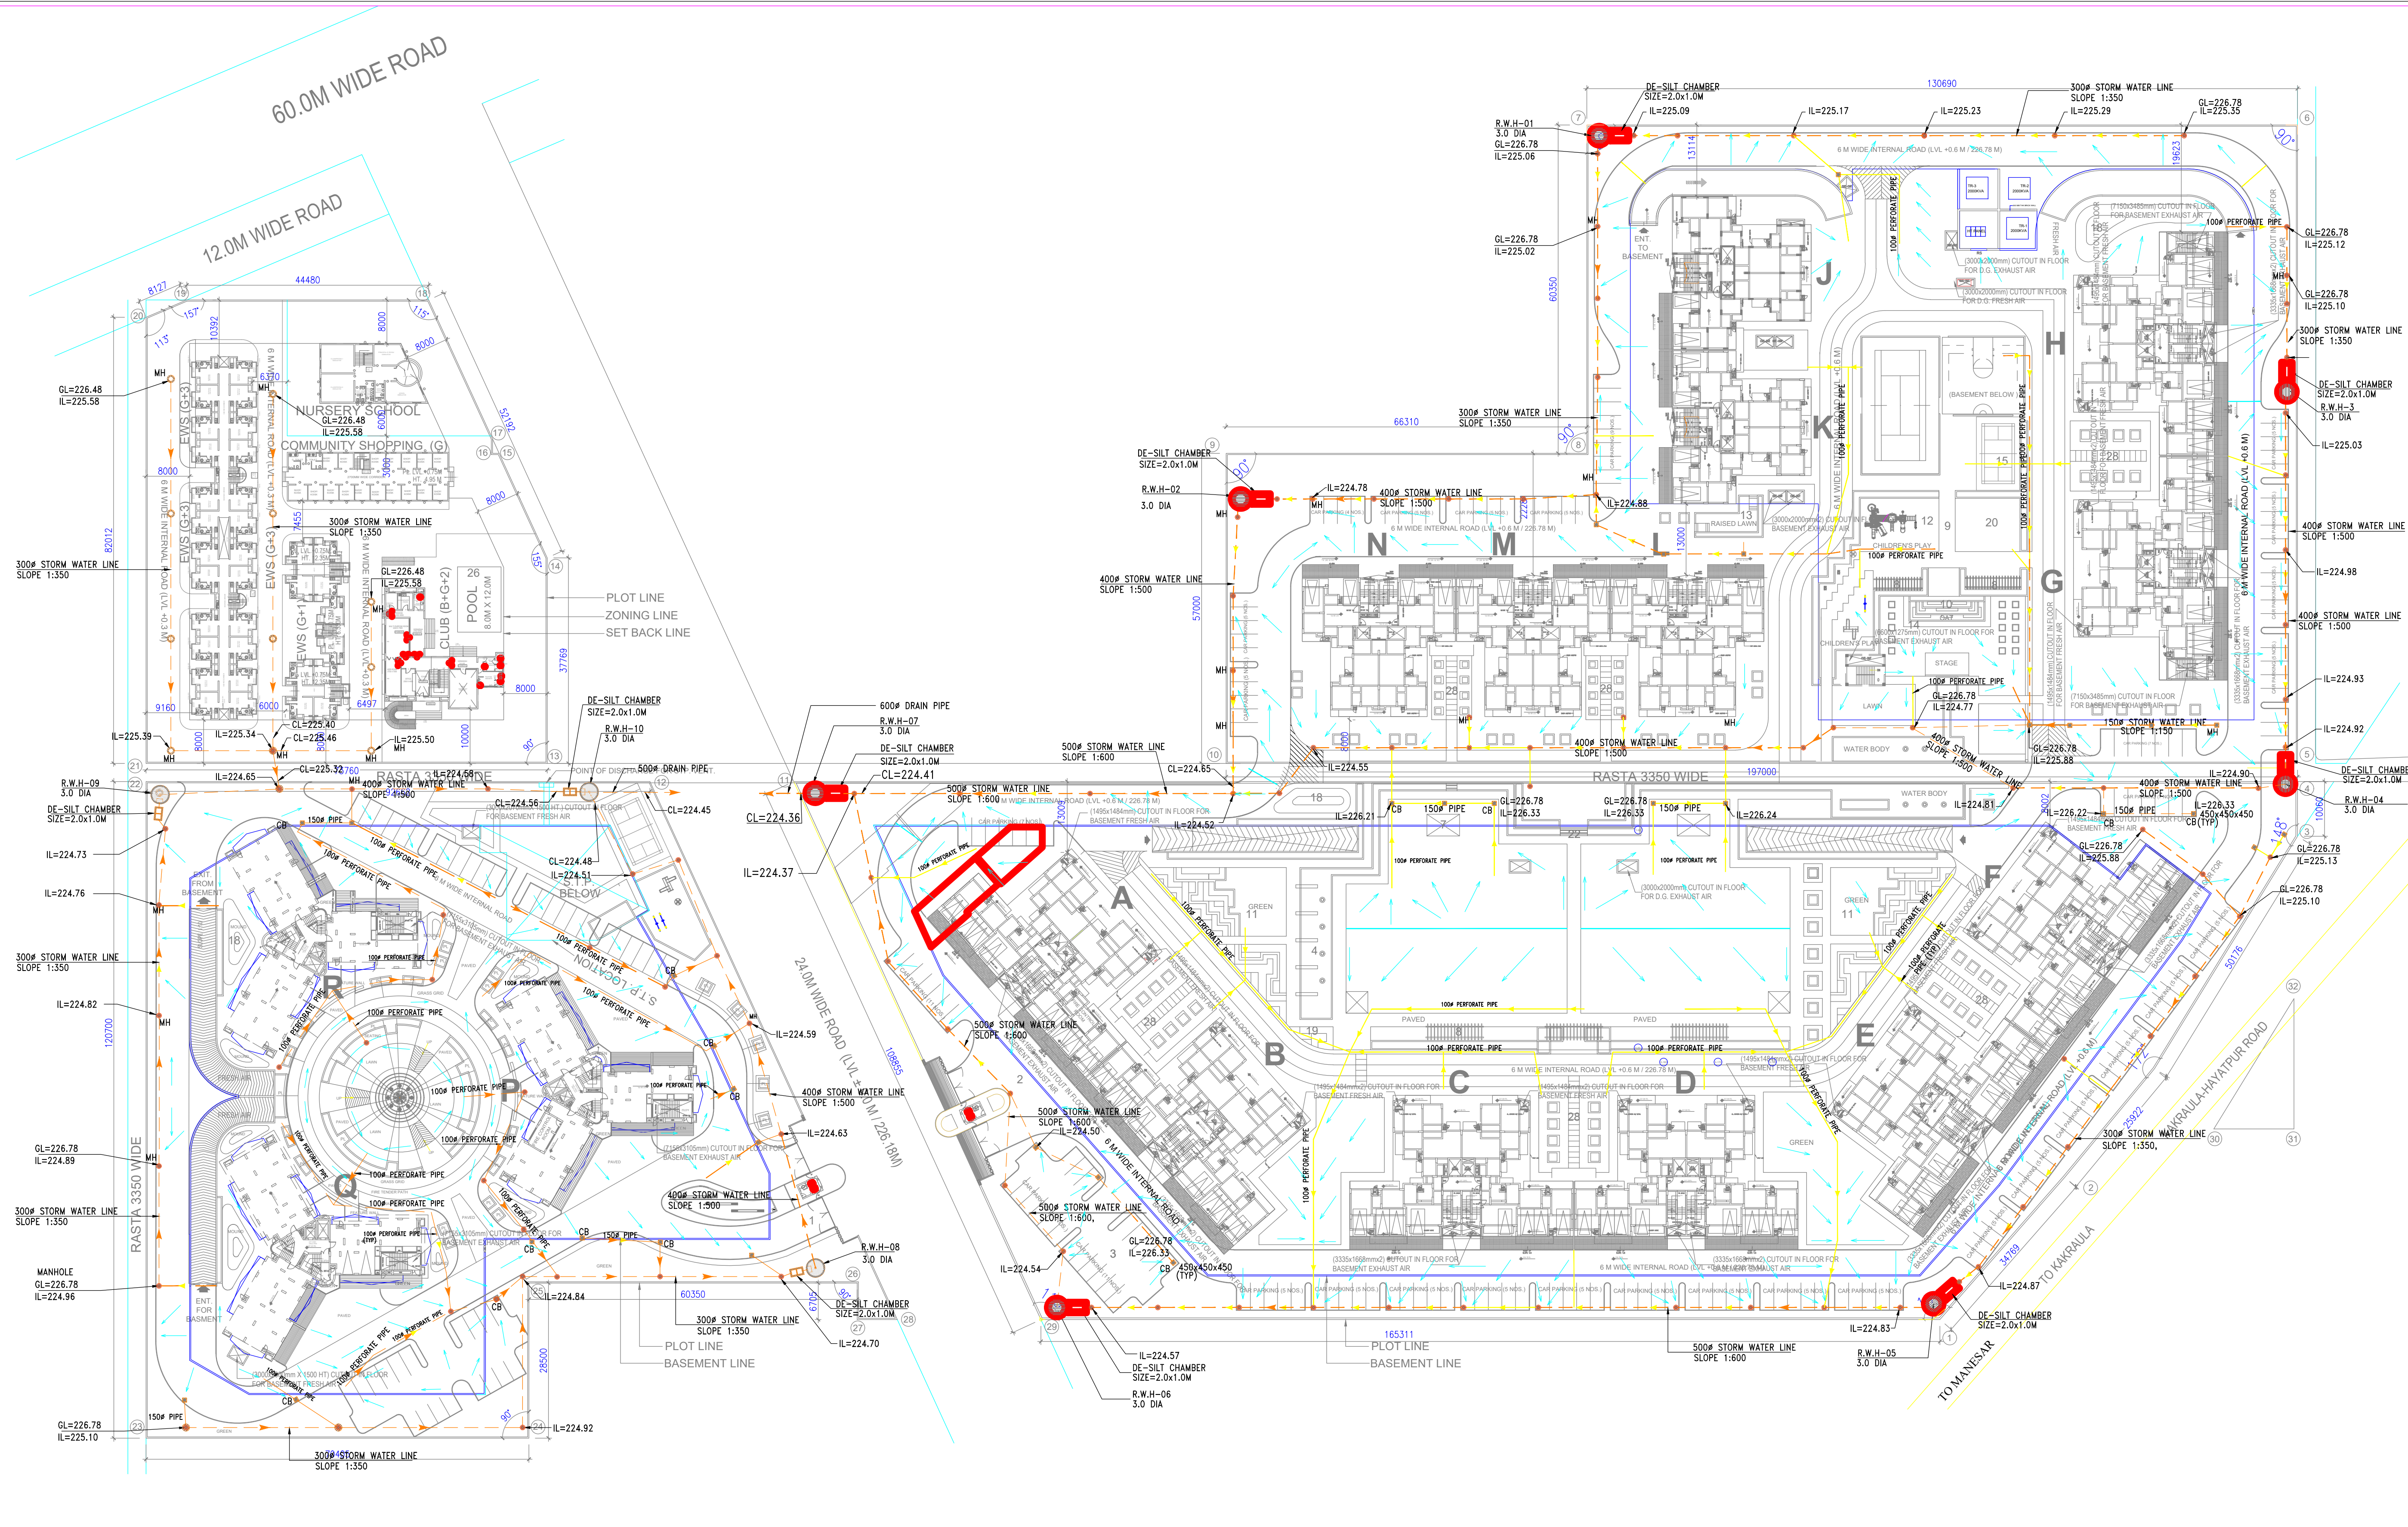


This drawing is a "COPYRIGHT" contents of this drawing or part thereof may not be used or reproduced without the permission of the Architect			
NO. OF PRINTS	DATE	ISSUED TO	REMARKS
EMAIL	22-04-14	CLIENT	TENDER
REVISION	DATE	DESCRIPTION	BY

LEGEND:-	
CB	CATCH BASIN 450x450mm
MH	STORM WATER MANHOLE
—	STORM WATER LINE
○	RAIN WATER HARVESTING WELL SIZE=4.0M.DIA
□	DESILT CHAMBER

- PLUMBING NOTES:
- This drawing represents plumbing details only. For Arch/Structural & Elect details, please refer relevant drawings.
 - Please coordinate this drawing with all other Plumbing/Services drawings.
 - The sizes of the catch basins shall be as follows:
(a) 450mm X 450mm upto 450mm depth.
(b) 600mm X 600mm upto 700mm depth.
(c) 1000mm X 700mm from 750mm to 1250mm depth.
 - All external storm water pipe are RCC pipe

TENDER DRAWING

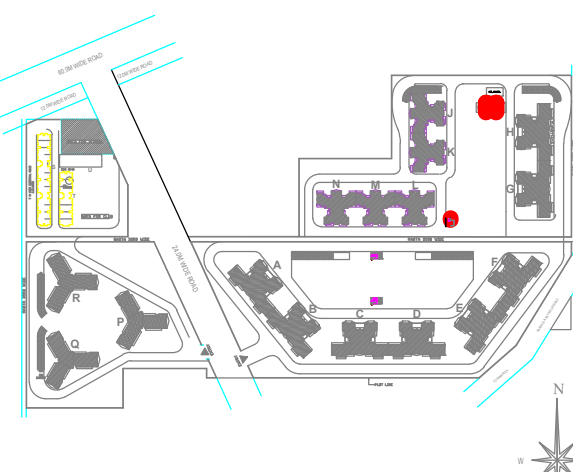

KEY PLAN		
CLIENT		
ANANT RAJ INDUSTRIES LIMITED		
PROJECT		
PROPOSED GROUP HOUSING AT SECTOR -91, GURGAON, HARYANA		
DATE	CHECKED BY	PROJECT INCH.
22-04-14	Y.VIRDI	DINESH KAPOOR
SCALE	DEALT BY	APPROVED BY
1:500	SHYAM	V.C. MISRA
DRAWING TITLE		
SITE PLAN		
STORM WATER DRAIN		
PLUMBING DRAWING		
ARCHITECTS:		
C. P. KUKREJA ASSOCIATES		
ASHIRWAD BUILDING D-1, GREEN PARK NEW DELHI - 110016, PHONE: - 26863953 FAX:- 26865770, EMAIL: cpka@cpkukreja.com		
DRAWING NO.	REVISION	
10008 / ANANTRAJ HSG / P-SP01	RO	
CAD FILE NO. P-SP01		