





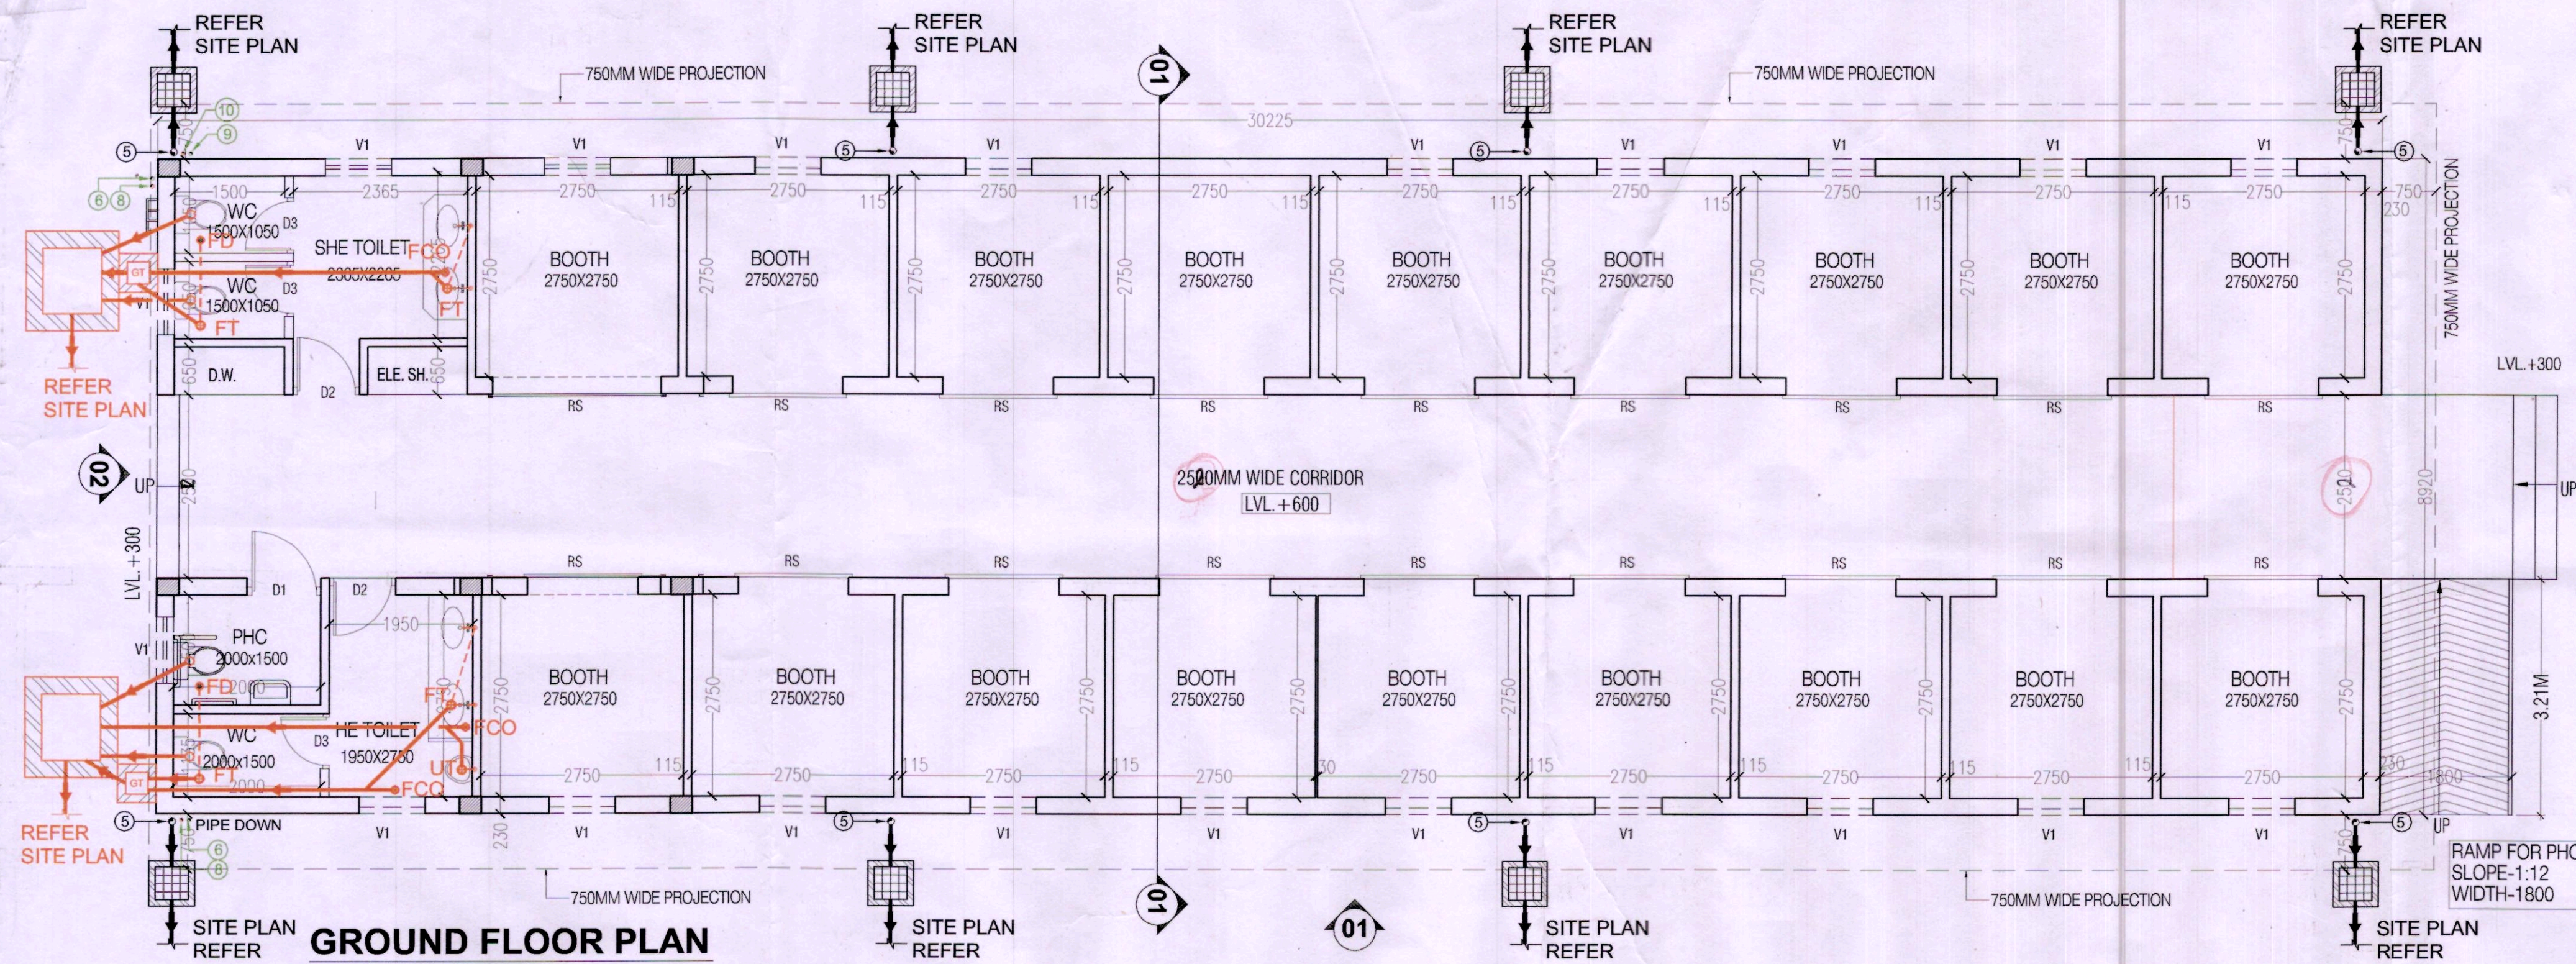


G. FLOOR/G. COVERAGE CALULATION
 A 30.225 X 8.92 269.607 SQMT.

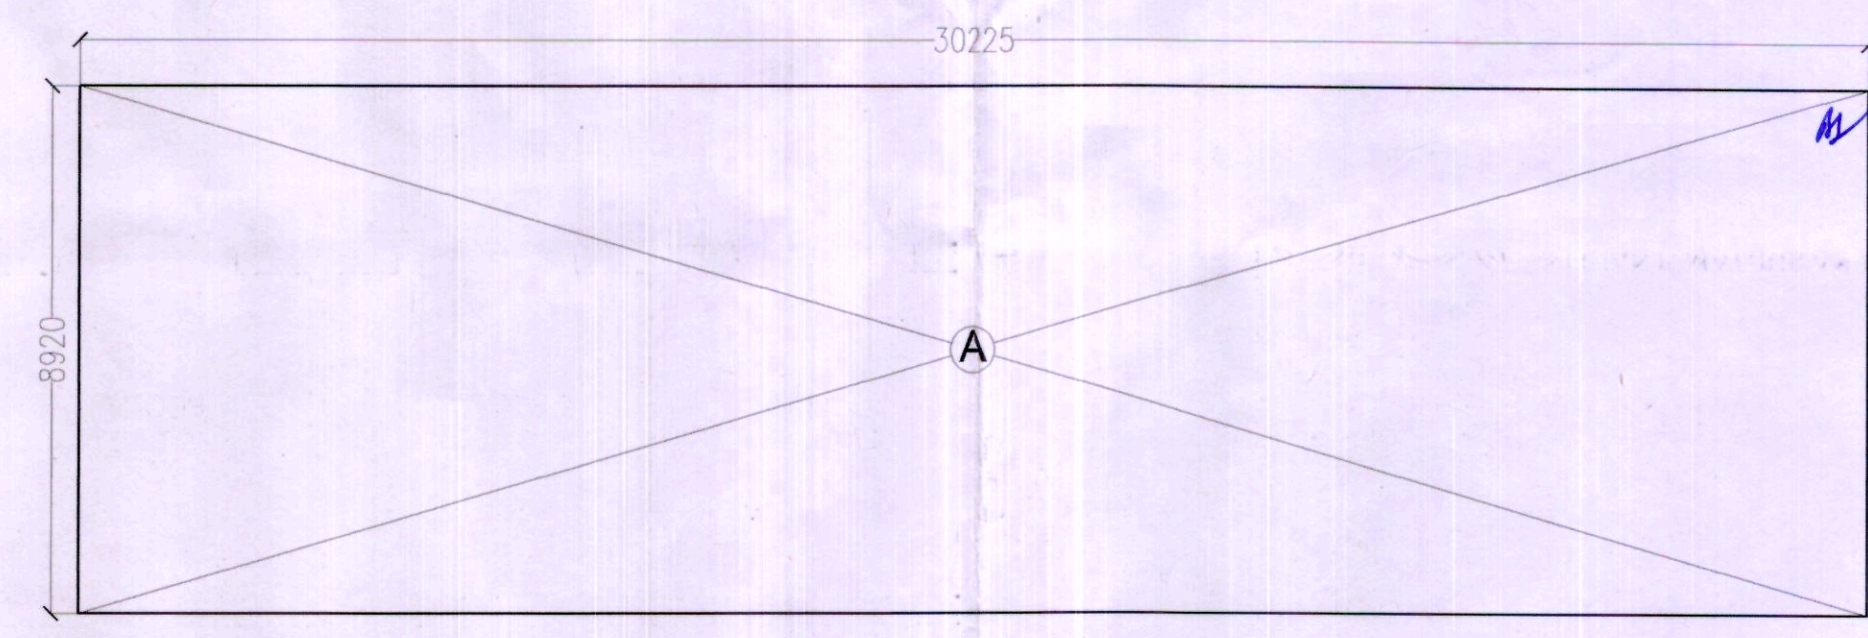

LEGEND

⑤	110 OD uPVC (SWR) RAIN WATER PIPE
⑥	DOMESTIC WATER SUPPLY DN TAKE
⑧	FLUSHING WATER SUPPLY DN TAKE
⑨	DOMESTIC WATER SUPPLY RISER
⑩	FLUSHING WATER SUPPLY RISER
FT	FLOOR TRAP
FD	FLOOR DRAIN
FCO	FLOOR CLEAN OUT
COP	CLEAN OUT PLUG
KH	KHURRA 450x450
MH	MANHOLE

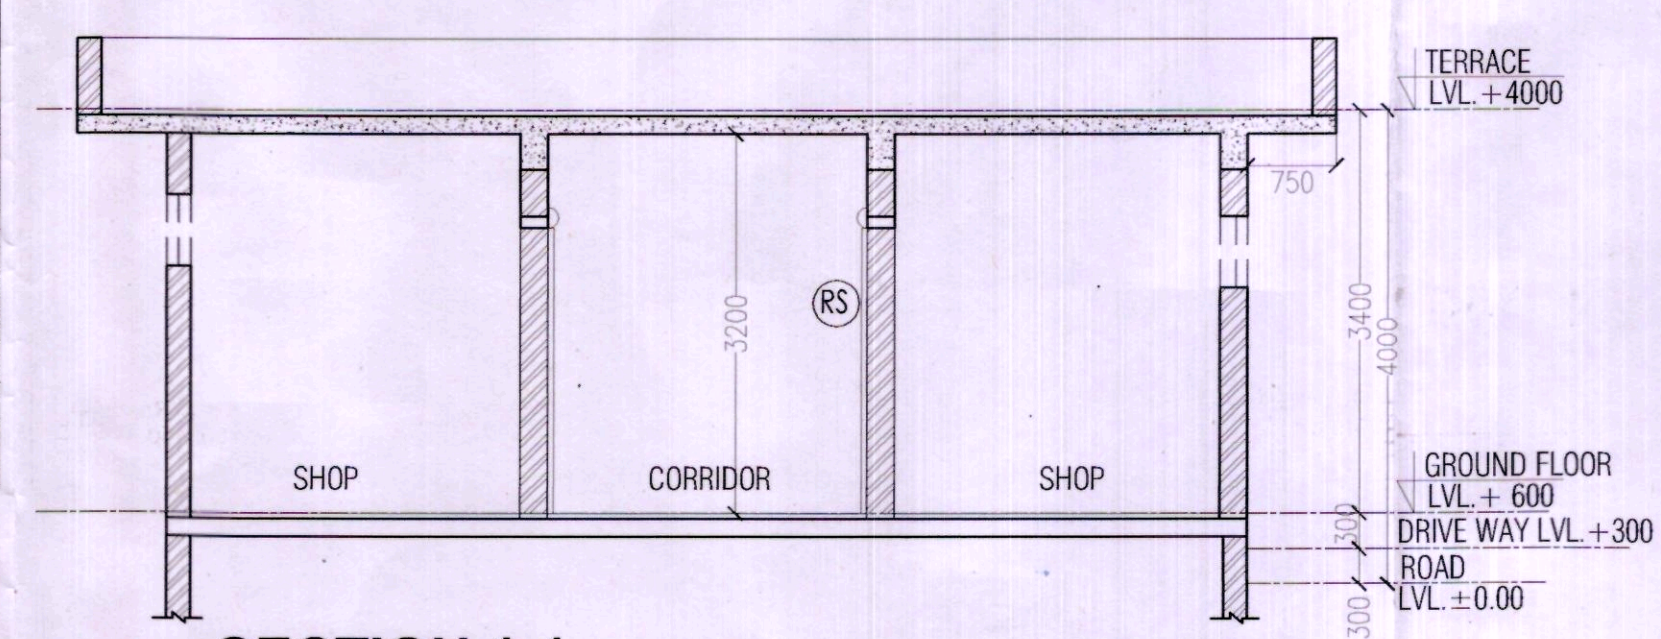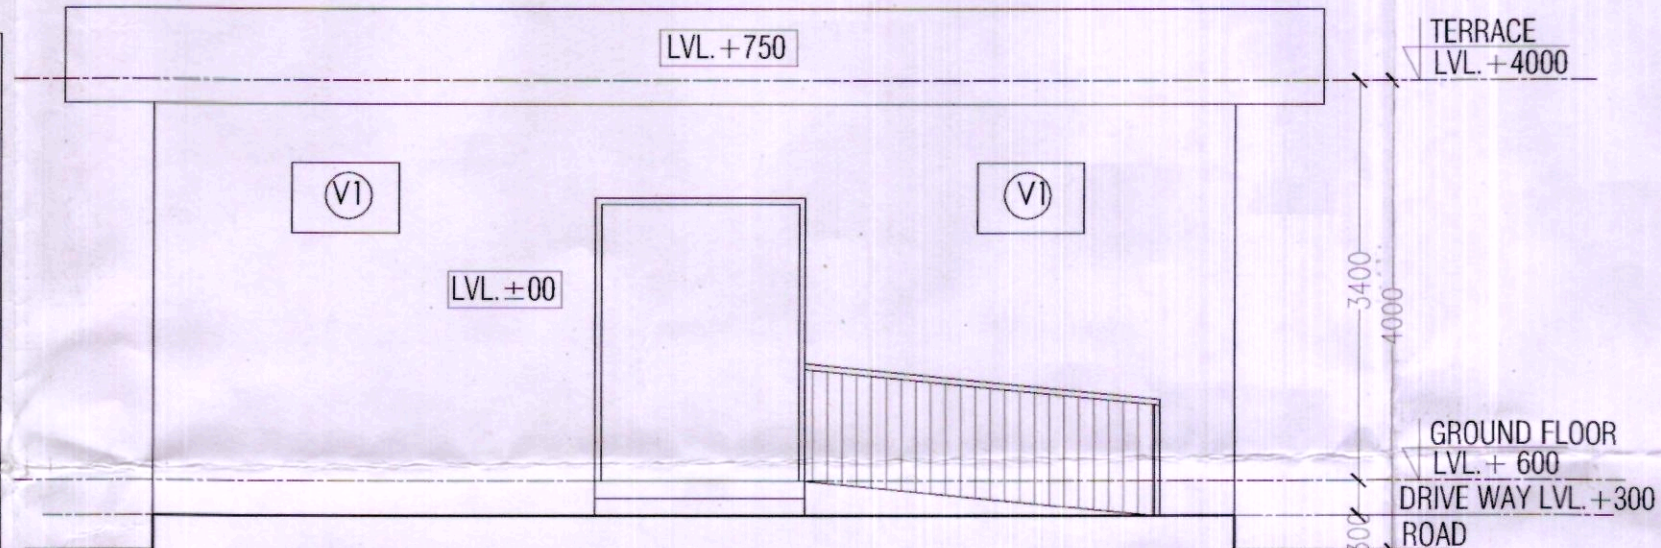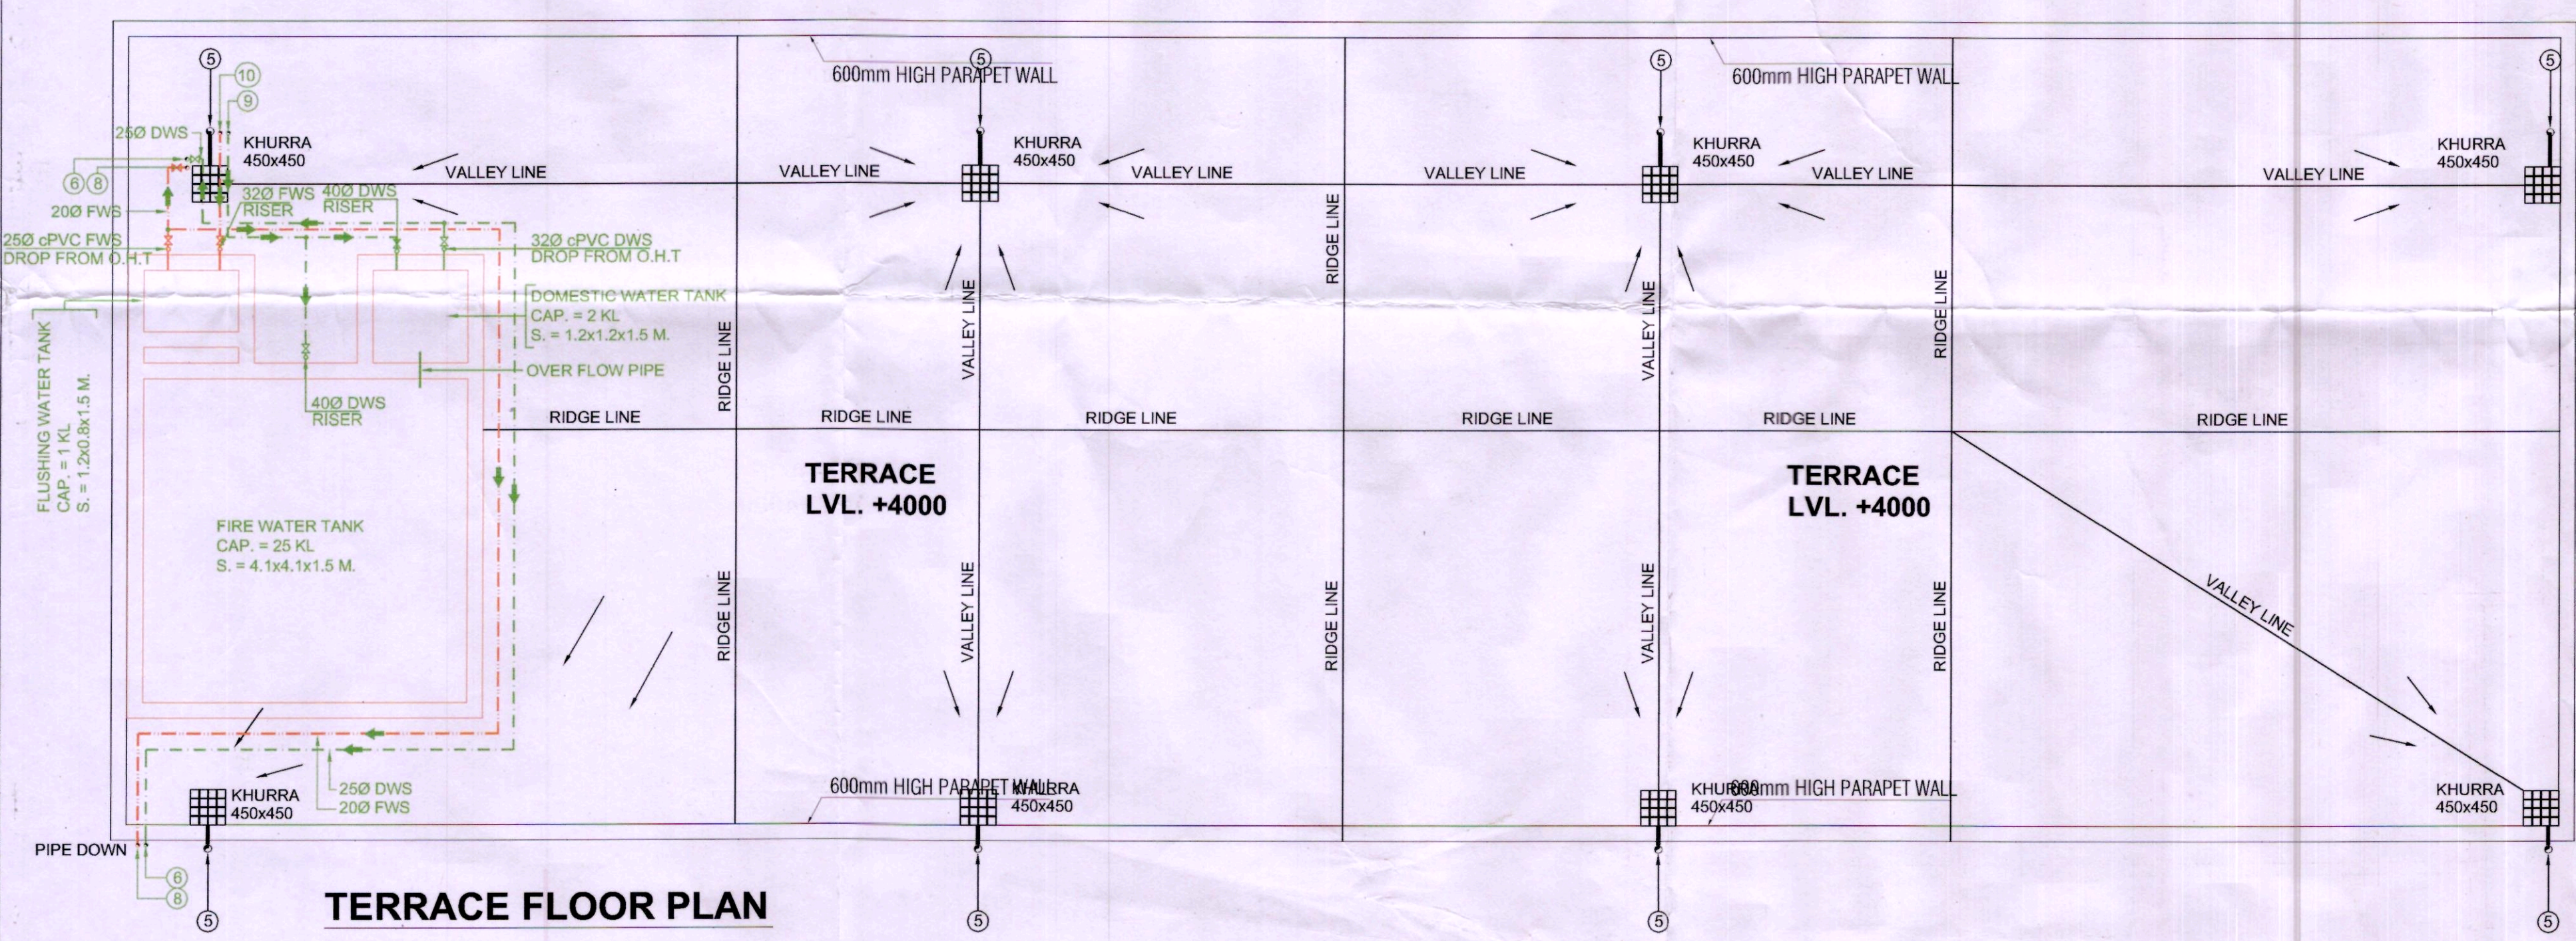

NOTES:-
 1. ALL DIMENSIONS IN MM.

PROJECT:-
 REVISED BUILDING PLAN OF GROUP HOUSING SCHEME LAND MEASURING 15.575 ACRES (LICENCE NO.71 OF 2008 DATED 25.03.2008) IN SECTOR -91, GURGAON MANESAR URBAN COMPLEX BEING DEVELOPED BY M/S JUBILANT SOFTWARES SERVICES PVT.LTD.

ARCHITECT:-
 GIAN P. MATHUR AND ASSOCIATES (P) LTD.
 C-55, East Of Kailash, New Delhi-110065
 T: 011-46599599 / F: 011-46599512
 E: gpma@airtelmail.in / W: www.gpmindia.com

OWNERS SIGNATURE:-
 For Jubilant Software Services Pvt. Ltd.
 W. Mathur
 Authorised Signatory

ARCHITECT SIGNATURE:-
 GIAN P. MATHUR
 ARCHITECT
 B. Arch., M.C.A., I.I.A.
 CA No. 805769

DRAWING TITLE:-
 CONVENIENT SHOPPING
 PLAN, ELEVATION, SECTION & AREA
 CALCULATION

DATE:- JULY-2017
SCALE:- 1:60
SHEET NO. 26

DOOR SCHEDULE:

TYPE	OPENING SIZE	CILL LVL.	UNTEL LVL.	LOCATION
D1	1000X2100	±00	2100	PHC
D2	900X2100	±00	2100	TOILETS
D3	750X2100	±00	2100	WC
RS	1500X2400	±00	2400	SHOPS / KIOSKS

VENTILATOR / SCHEDULE:

TYPE	OPENING SIZE	CILL LVL.	UNTEL LVL.	LOCATION
V1	900X600	2400	3000	SHOP / KIOSK & TOILET

