




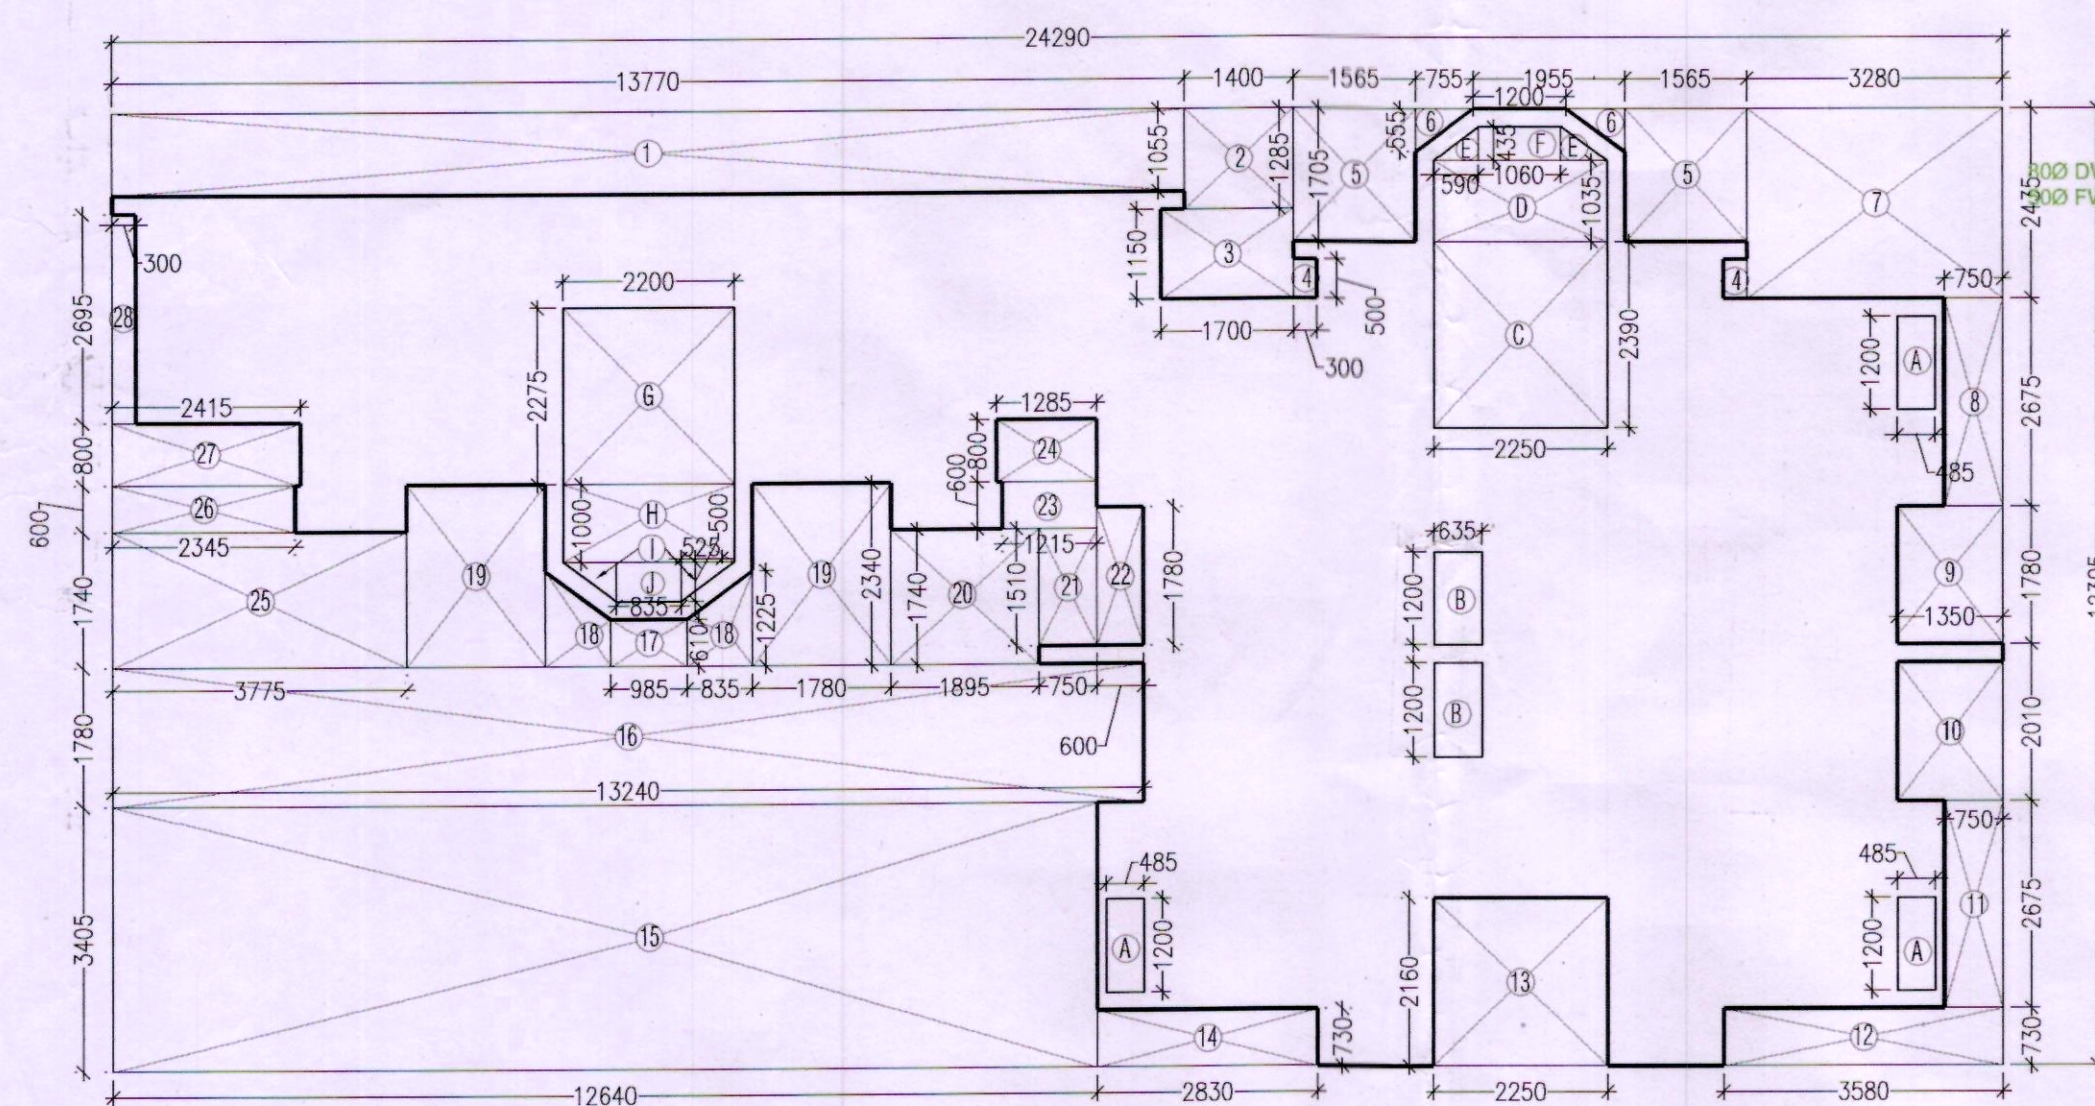


4TH FLOOR AREA DIAGRAM (BLOCK-B)

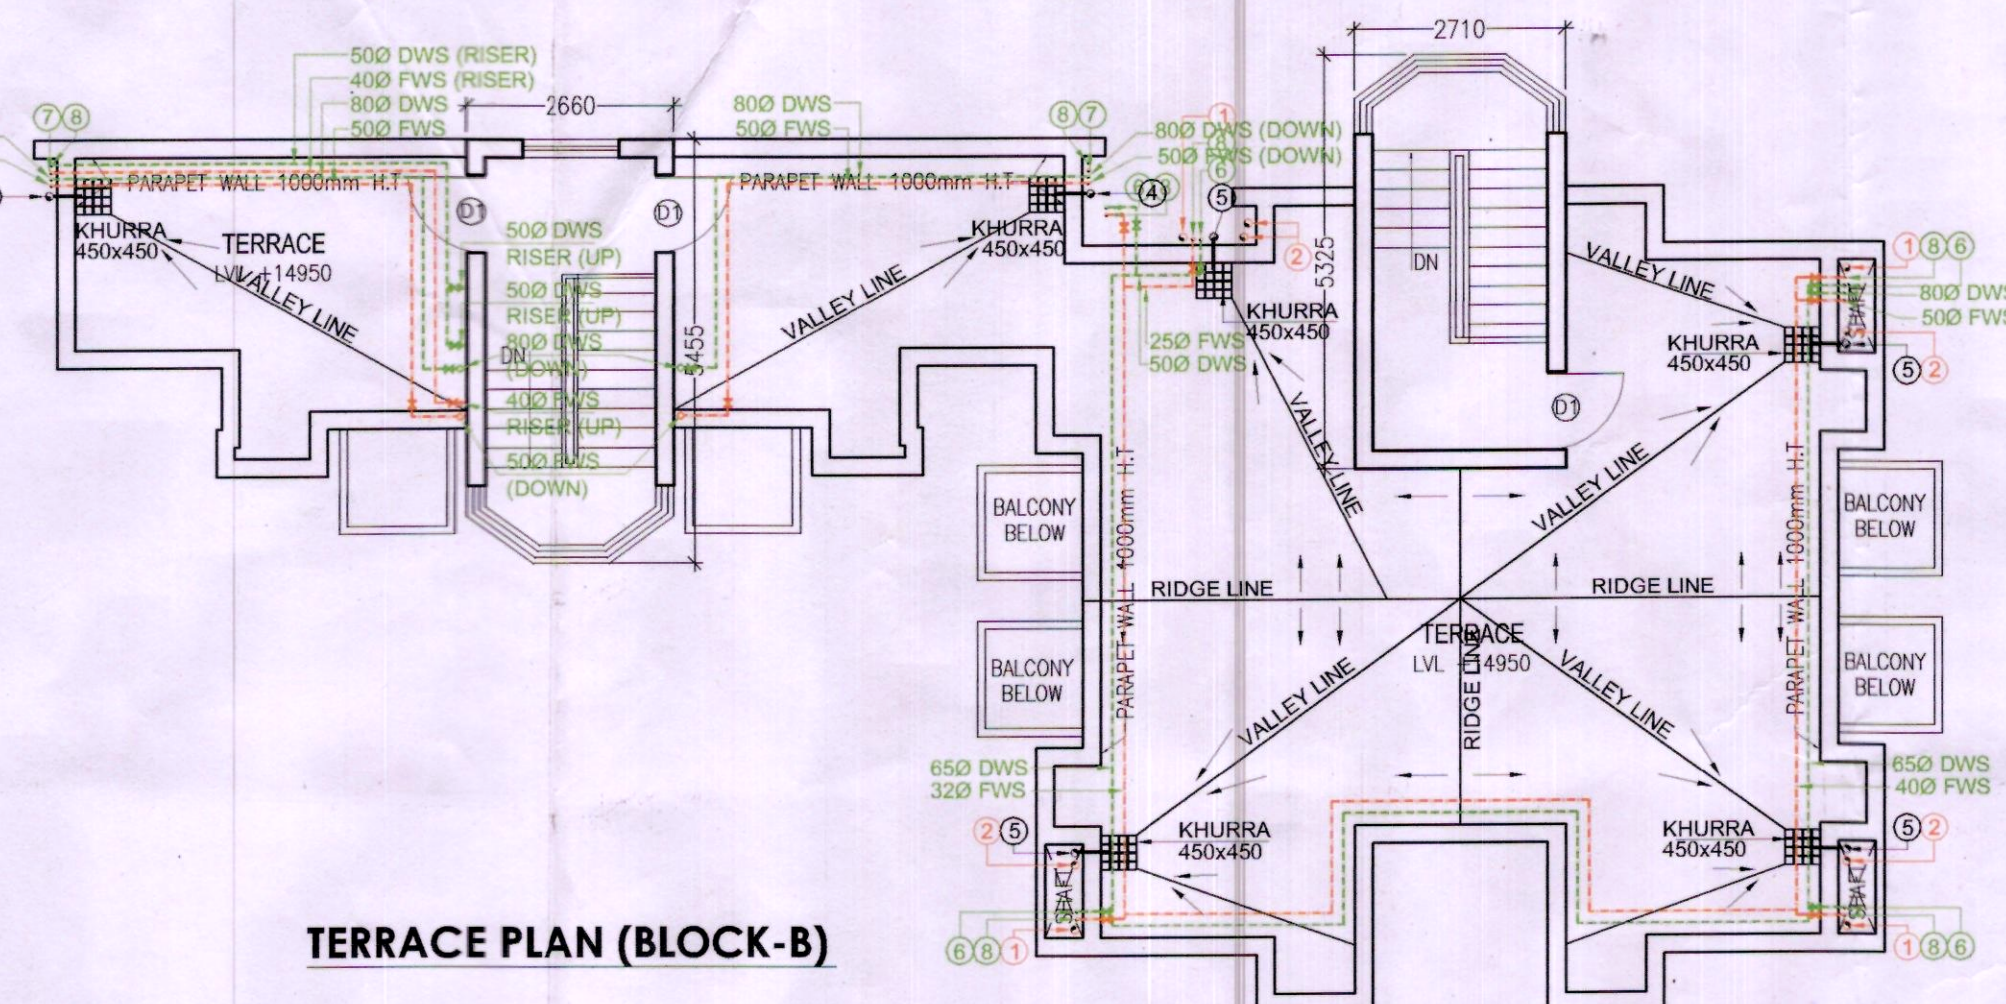


TERRACE PLAN (BLOCK-B)

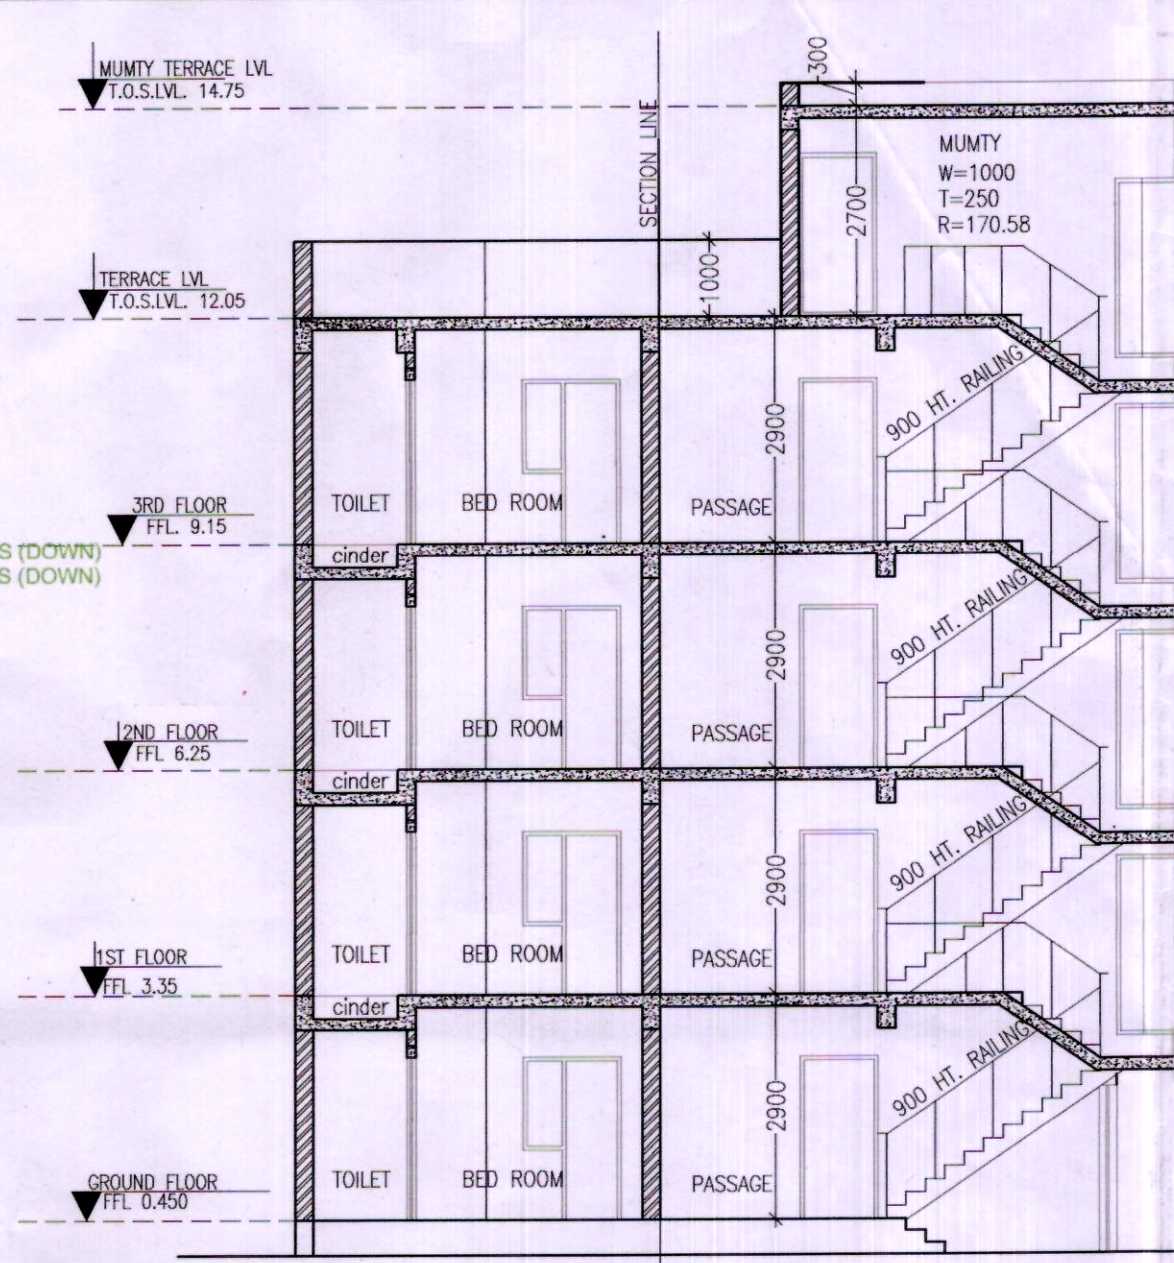

SECTION Y-Y EWS (BLOCK-B)

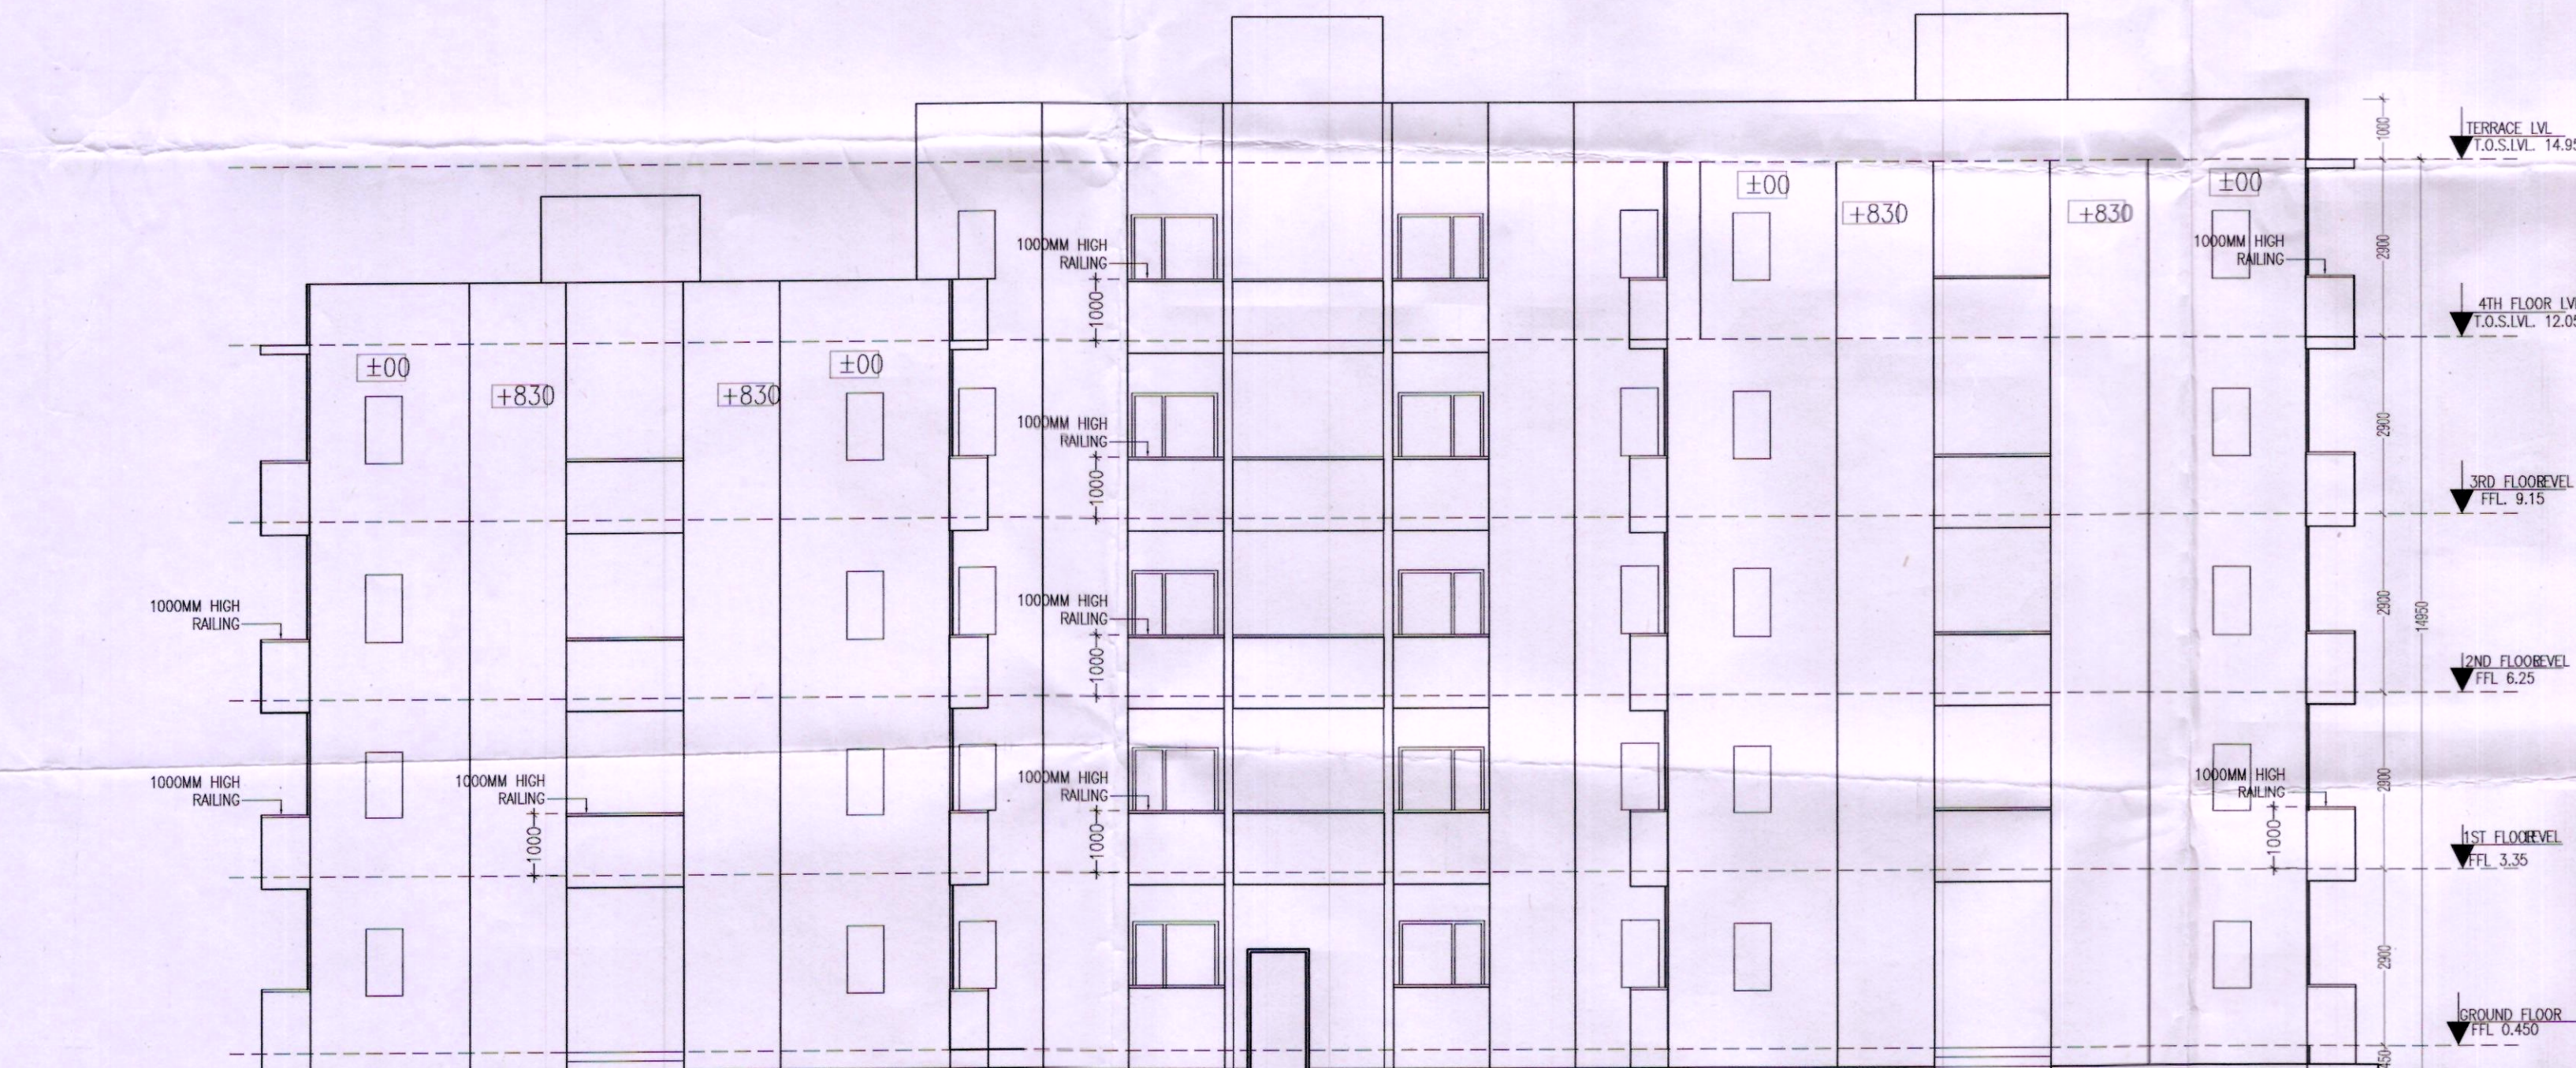

ELEVATION 'A' EWS (BLOCK-B)

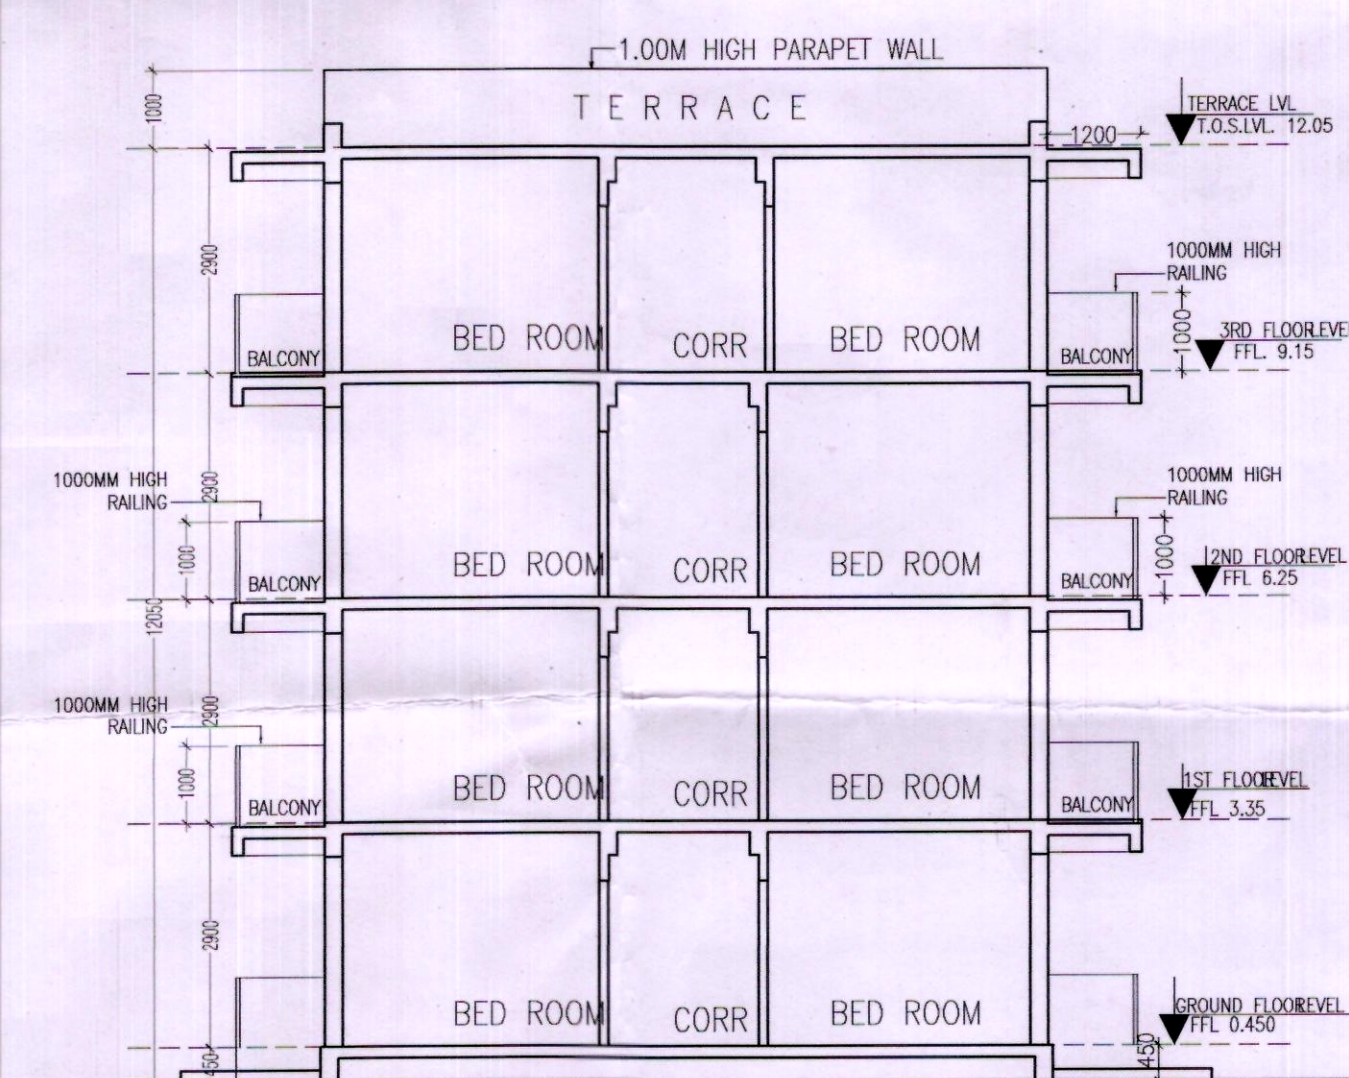

SECTION X-X EWS (BLOCK-B)

Architect (HQ)

(BALWANT SINGH) S.D.

LEGEND

①	110 OD uPVC (SWR) SOIL & VENT PIPE
②	110 OD uPVC (SWR) WASTE & VENT PIPE
③	90 OD uPVC (SWR) RAIN WATER PIPE
④	110 OD uPVC (SWR) RAIN WATER PIPE
⑤	DOMESTIC WATER SUPPLY RISE
⑥	FLUSHING WATER SUPPLY RISE
⑦	DOMESTIC WATER SUPPLY RISE
⑧	FLUSHING WATER SUPPLY RISE
⑨	FLUSHING WATER SUPPLY RISE
FT	FLOOR TRAP
FD	FLOOR DRAIN
FCO	FLOOR CLEAN OUT
COP	CLEAN OUT PLUG
KH	KHURRA 450x450
MH	MANHOLE

NOTES:-

- ALL DIMENSIONS IN MM.
- LIFT SHALL BE WITH 100% POWER BACKUP.

PROJECT:-

REVISED BUILDING PLAN OF GROUP HOUSING SCHEME LAND MEASURING 15.575 ACRES (LICENCE NO.71 OF 2008 DATED 25.03.2008) IN SECTOR - 91, GURGAON MANESAR URBAN COMPLEX BEING DEVELOPED BY M/S JUBILANT SOFTWARES SERVICES PVT. LTD.

ARCHITECT:-

GIAN P. MATHUR AND ASSOCIATES (P) LTD.
C - 55, East Of Kailash, New Delhi-110065
T : 011-46599599 / F 011-46599512
E : gpma@airtelmail.in / W : www.gpmindia.com

OWNERS SIGNATURE:-

ARCHITECT SIGNATURE:-

GIAN P. MATHUR
ARCHITECT
B. Arch., M.C.A. I.I.A.
CA No. 80/5789

DRAWING TITLE:

EWS FLOOR PLANS & AREA CALULA. (BLOCK - B)

DATE:- JULY-2017

SCALE:- 1:100

SHEET NO. 22