



11TH FLOOR AREA CALCULATION					
PART	NO.	TOTAL AREA (SQMT.)			
1	2.930	X	6.970	X	3
2	2.895	X	6.370	X	3
3	1.630	X	5.225	X	3
4	1.860	X	5.335	X	3
5	8.350	X	1.270	X	3
6	9.305	X	8.030	X	3
7	(11.440+10.580)/2	X	1.490	X	1
8	(12.120+12.100)/2	X	0.125	X	1
9	0.655	X	1.440	X	0.5
10	1.58903345	X	0.667	X	1
11	12.120+1.770/2	X	8.940	X	1
12	1.770 X 0.475	X	0.667	X	1
13	1.860 X 0.520	X	0.667	X	1
TOTAL AREA					483.144
DEDUCTION					
E	0.115	X	0.300	X	3
F	0.955	X	0.450	X	3
G	1.465	X	0.400	X	0.667
H	4.455+3.775/2	X	1.270	X	1
I	3.260+2.420/2	X	1.450	X	1
J	2.670+2.475	X	1.000	X	0.5
K	(2.780+2.675)/2	X	0.380	X	1
L	0.525	X	0.980	X	1
M	0.525	X	1.470	X	1
N	4.040+2.610/2	X	2.840	X	1
O	2.335	X	4.040	X	0.50
P	4.815+4.085/2	X	1.365	X	1
Q	1.465	X	0.420	X	0.667
R	1.830	X	1.055	X	0.5
S	1.950	X	2.150	X	1
T	1.720	X	0.995	X	0.5
U	2.200	X	3.410	X	1
V	1.270	X	0.385	X	0.667
V1	1.200	X	0.485	X	0.50
V2	0.700	X	0.405	X	1
TOTAL AREA					48.612
NET FLOOR AREA (A1-B1)					434.532

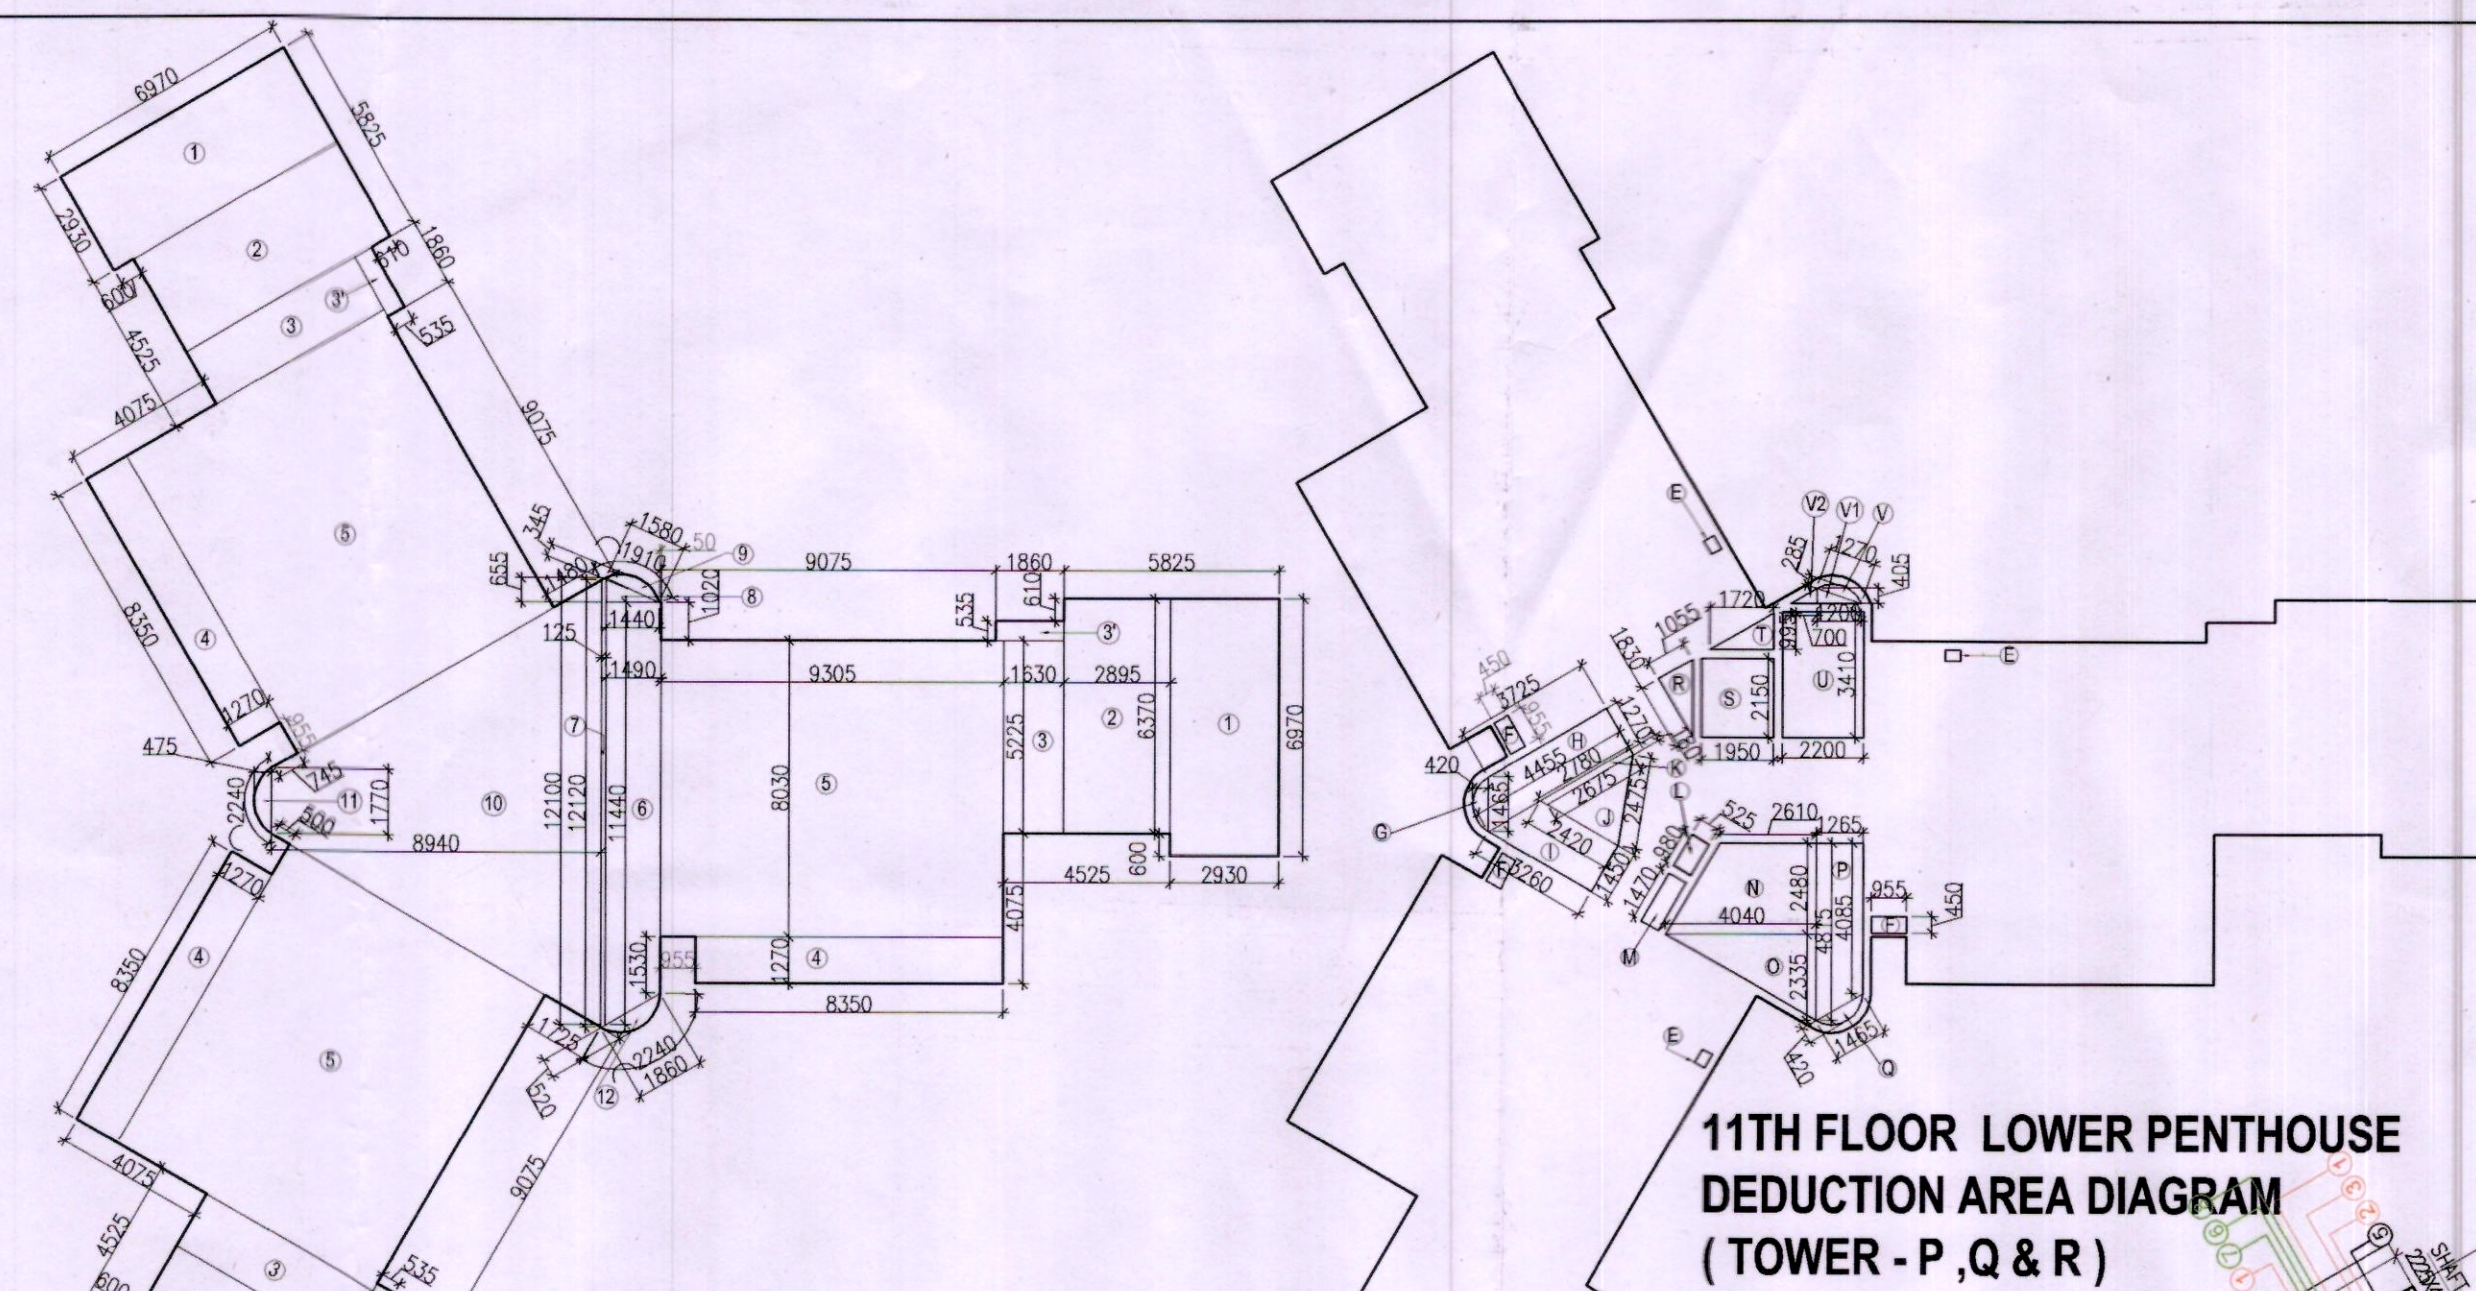

11TH FLOOR LOWER PENTHOUSE
AREA DIAGRAM
(TOWER - P, Q & R)

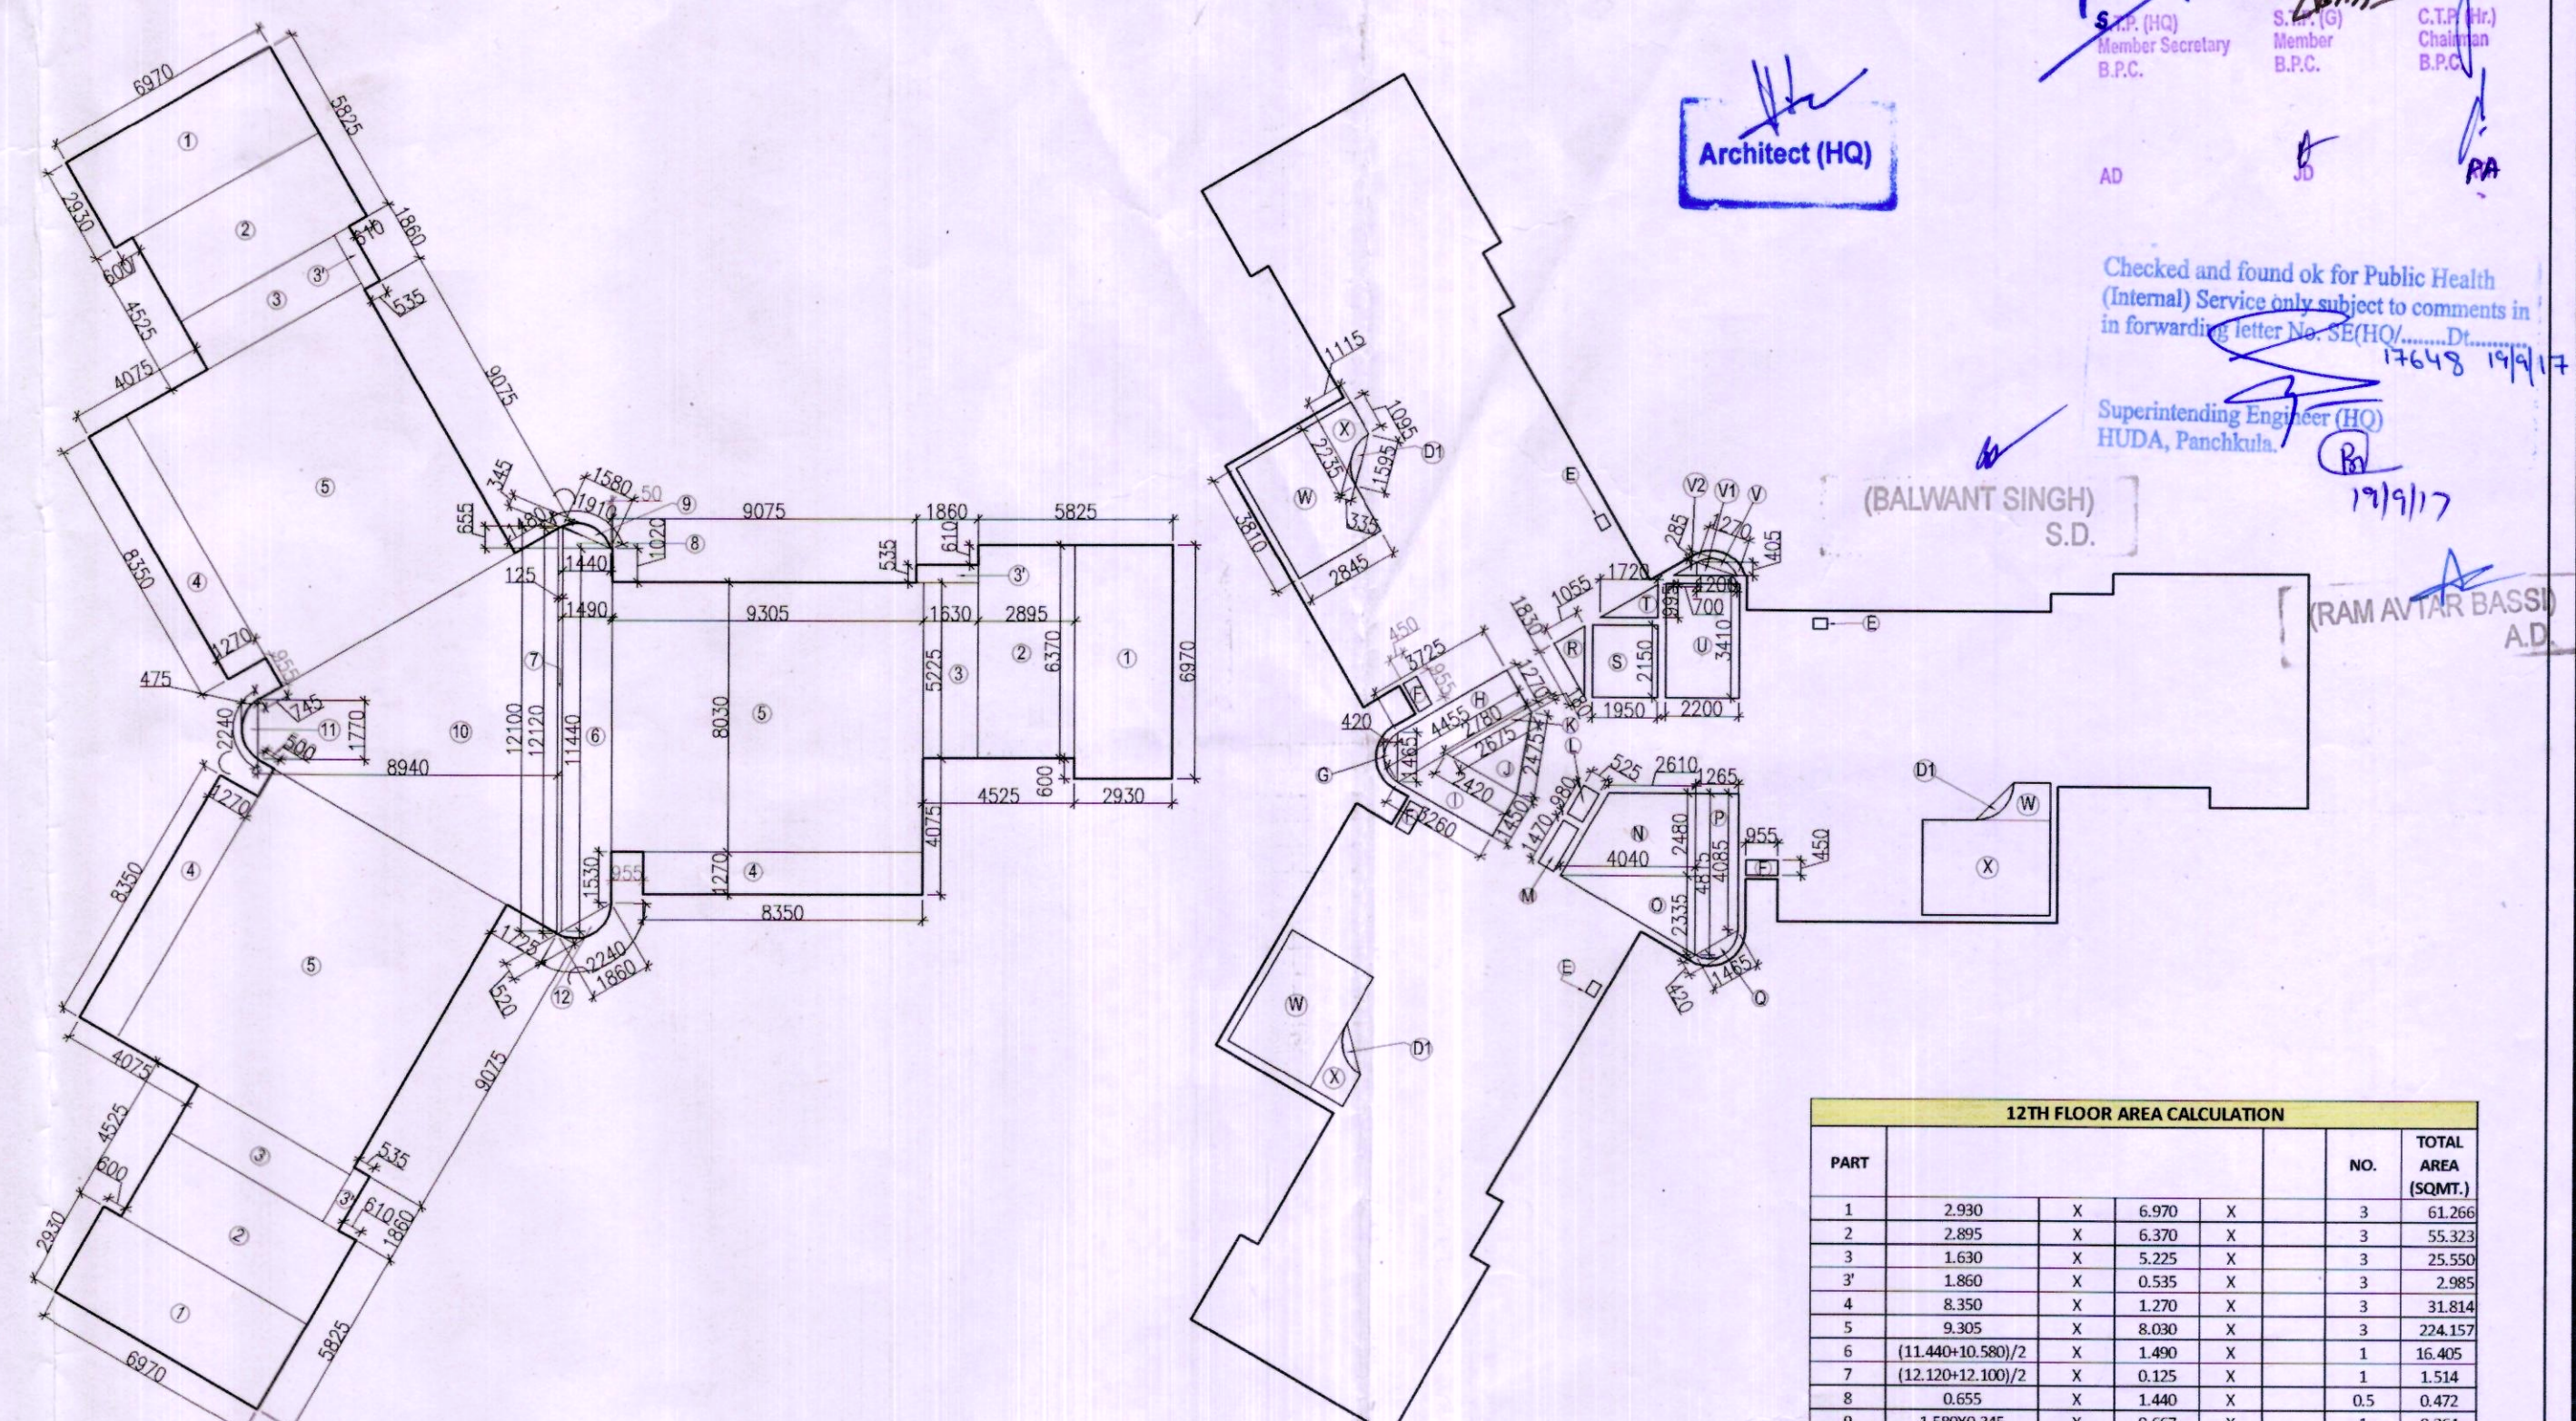

12TH FLOOR UPPER PENTHOUSE
AREA DIAGRAM
(TOWER - P, Q & R)

12TH FLOOR UPPER PENTHOUSE
DEDUCTION AREA DIAGRAM
(TOWER - P, Q & R)

12TH FLOOR AREA CALCULATION					
PART	NO.	TOTAL AREA (SQMT.)			
1	2.930	X	6.970	X	3
2	2.895	X	6.370	X	3
3	1.630	X	5.225	X	3
4	1.860	X	5.335	X	3
5	8.350	X	1.270	X	3
6	9.305	X	8.030	X	3
7	(11.440+10.580)/2	X	1.490	X	1
8	(12.120+12.100)/2	X	0.125	X	1
9	0.655	X	1.440	X	0.5
10	1.58903345	X	0.667	X	1
11	12.120+1.770/2	X	8.940	X	1
12	1.770 X 0.475	X	0.667	X	1
13	1.860 X 0.520	X	0.667	X	1
TOTAL AREA					483.144
DEDUCTION					
E	0.115	X	0.300	X	3
F	0.955	X	0.450	X	3
G	1.465	X	0.400	X	0.667
H	4.455+3.775/2	X	1.270	X	1
I	3.260+2.420/2	X	1.450	X	1
J	2.670+2.475	X	1.000	X	0.5
K	(2.780+2.675)/2	X	0.380	X	1
L	0.525	X	0.980	X	1
M	0.525	X	1.470	X	1
N	4.040+2.610/2	X	2.840	X	1
O	2.335	X	4.040	X	0.50
P	4.815+4.085/2	X	1.365	X	1
Q	1.465	X	0.420	X	0.667
R	1.830	X	1.055	X	0.5
S	1.950	X	2.150	X	1
T	1.720	X	0.995	X	0.5
U	2.200	X	3.410	X	1
V	1.270	X	0.385	X	0.667
V1	1.200	X	0.485	X	0.50
V2	0.700	X	0.405	X	1
W	2.245	X	3.810	X	1
X	2.255+1.055/2	X	1.115	X	1
TOTAL AREA					63.300
DEDUCTION (B2)					0.350
TOTAL DEDUCTION					0.350
TOTAL AREA A1					60.953
NET FLOOR AREA (A1-B3)					422.193

NOTES:-

1. ALL DIMENSIONS IN MM.
2. LIFT SHALL BE WITH 100% POWER BACKUP.

PROJECT:-

REVISED BUILDING PLAN OF
GROUP HOUSING SCHEME LAND
MEASURING 15.575 ACRES
(LICENCE NO.71 OF 2008 DATED
25.03.2008) IN SECTOR - 91,
GURGAON MANESAR URBAN
COMPLEX BEING DEVELOPED BY
M/S JUBILANT SOFTWARES
SERVICES PVT. LTD.

ARCHITECT:-

GIAN P. MATHUR AND ASSOCIATES (P) LTD.
C - 55, East Of Kailash, New Delhi-110065
T : 011-46599599 / F 011-46599512
E : gpmathur@airtelmail.in / W : www.gpmindia.com

OWNERS SIGNATURE:-

ARCHITECT SIGNATURE:-

For Jubilant Software Services Pvt. Ltd.
Authorized Signatory

GIAN P. MATHUR
ARCHITECT
B. Arch., M.C.A., I.I.T.A.
CA No. 80/5769

DRAWING TITLE:-


LOWER & UPPER PENTHOUSE FLOOR
PLANS & AREA CALCULATION
(TOWERS - P, Q & R)

DATE:- JULY-2017

SCALE:- 1:100


SHEET NO.

17

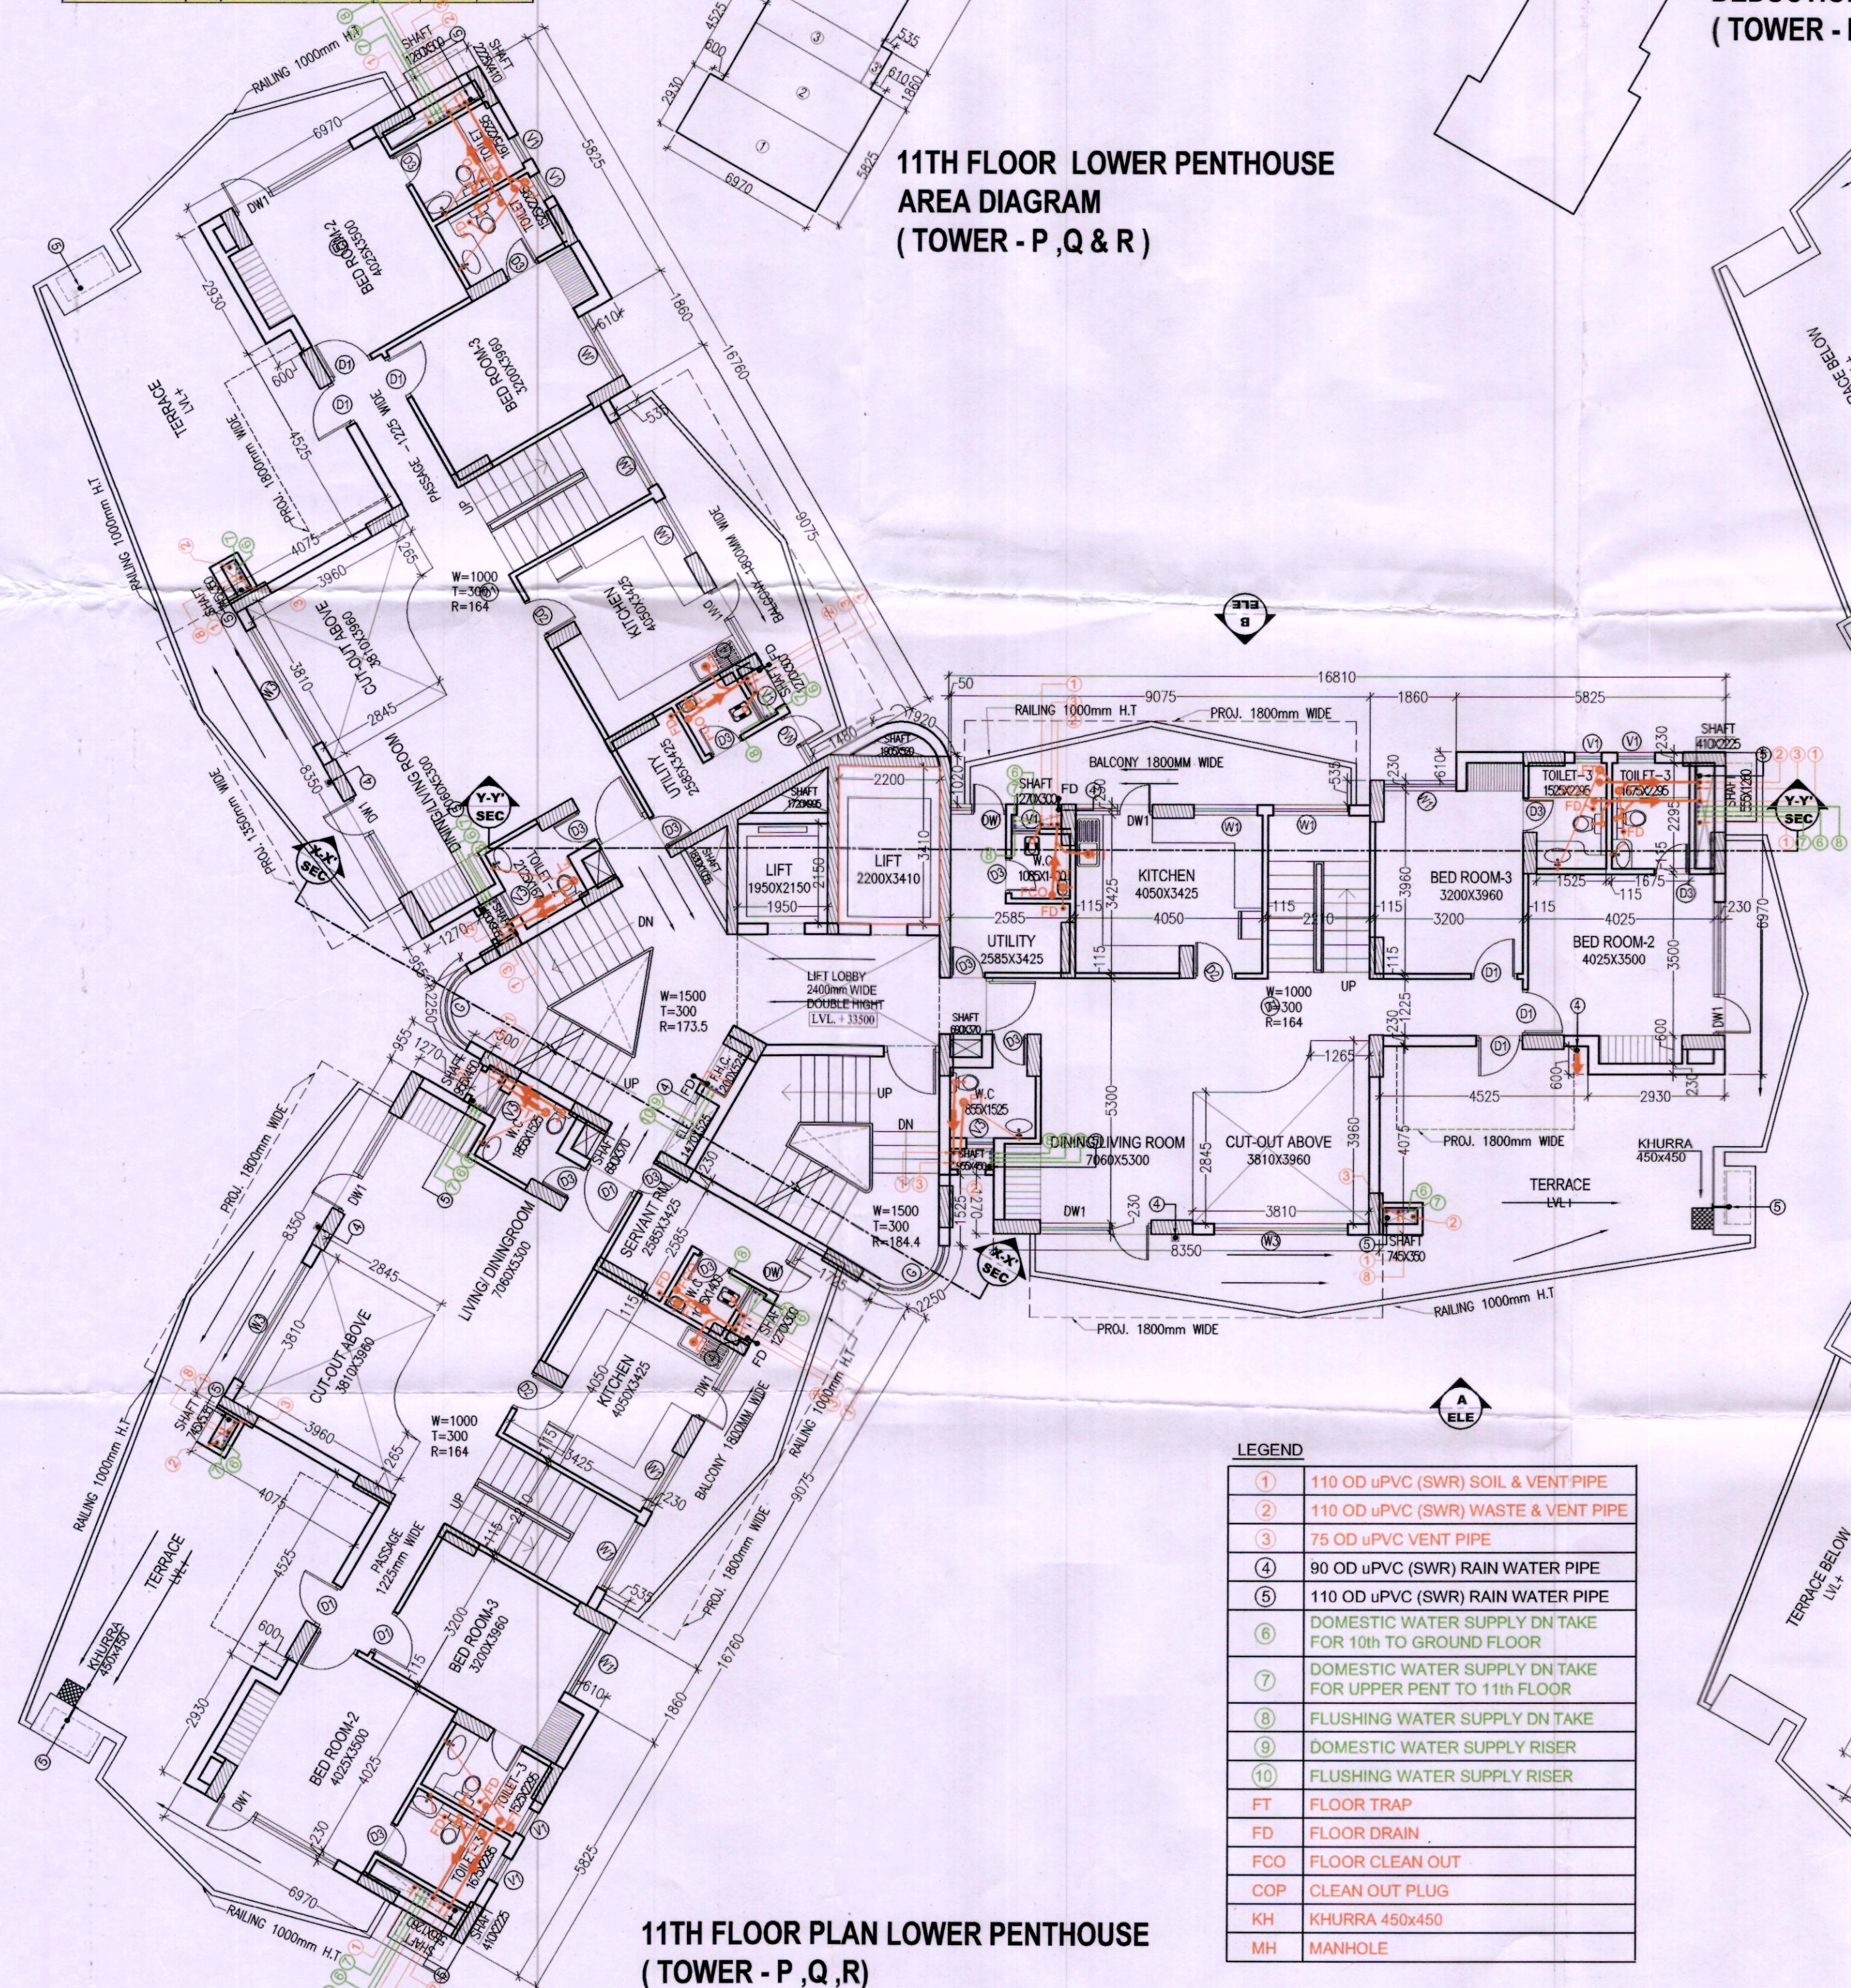

11TH FLOOR PLAN LOWER PENTHOUSE
(TOWER - P, Q, R)

LEGEND	
①	110 OD uPVC (SWR) SOIL & VENT PIPE
②	110 OD uPVC (SWR) WASTE & VENT PIPE
③	75 OD uPVC VENT PIPE
④	90 OD uPVC (SWR) RAIN WATER PIPE
⑤	110 OD uPVC (SWR) RAIN WATER PIPE
⑥	DOMESTIC WATER SUPPLY DN TAKE FOR 10th TO GROUND FLOOR
⑦	DOMESTIC WATER SUPPLY DN TAKE FOR UPPER PENT TO 11th FLOOR
⑧	FLUSHING WATER SUPPLY DN TAKE
⑨	DOMESTIC WATER SUPPLY RISER
⑩	FLUSHING WATER SUPPLY RISER
FT	FLOOR TRAP
FD	FLOOR DRAIN
FCO	FLOOR CLEAN OUT
COP	CLEAN OUT PLUG
KH	KHURRA 450x450
MH	MANHOLE

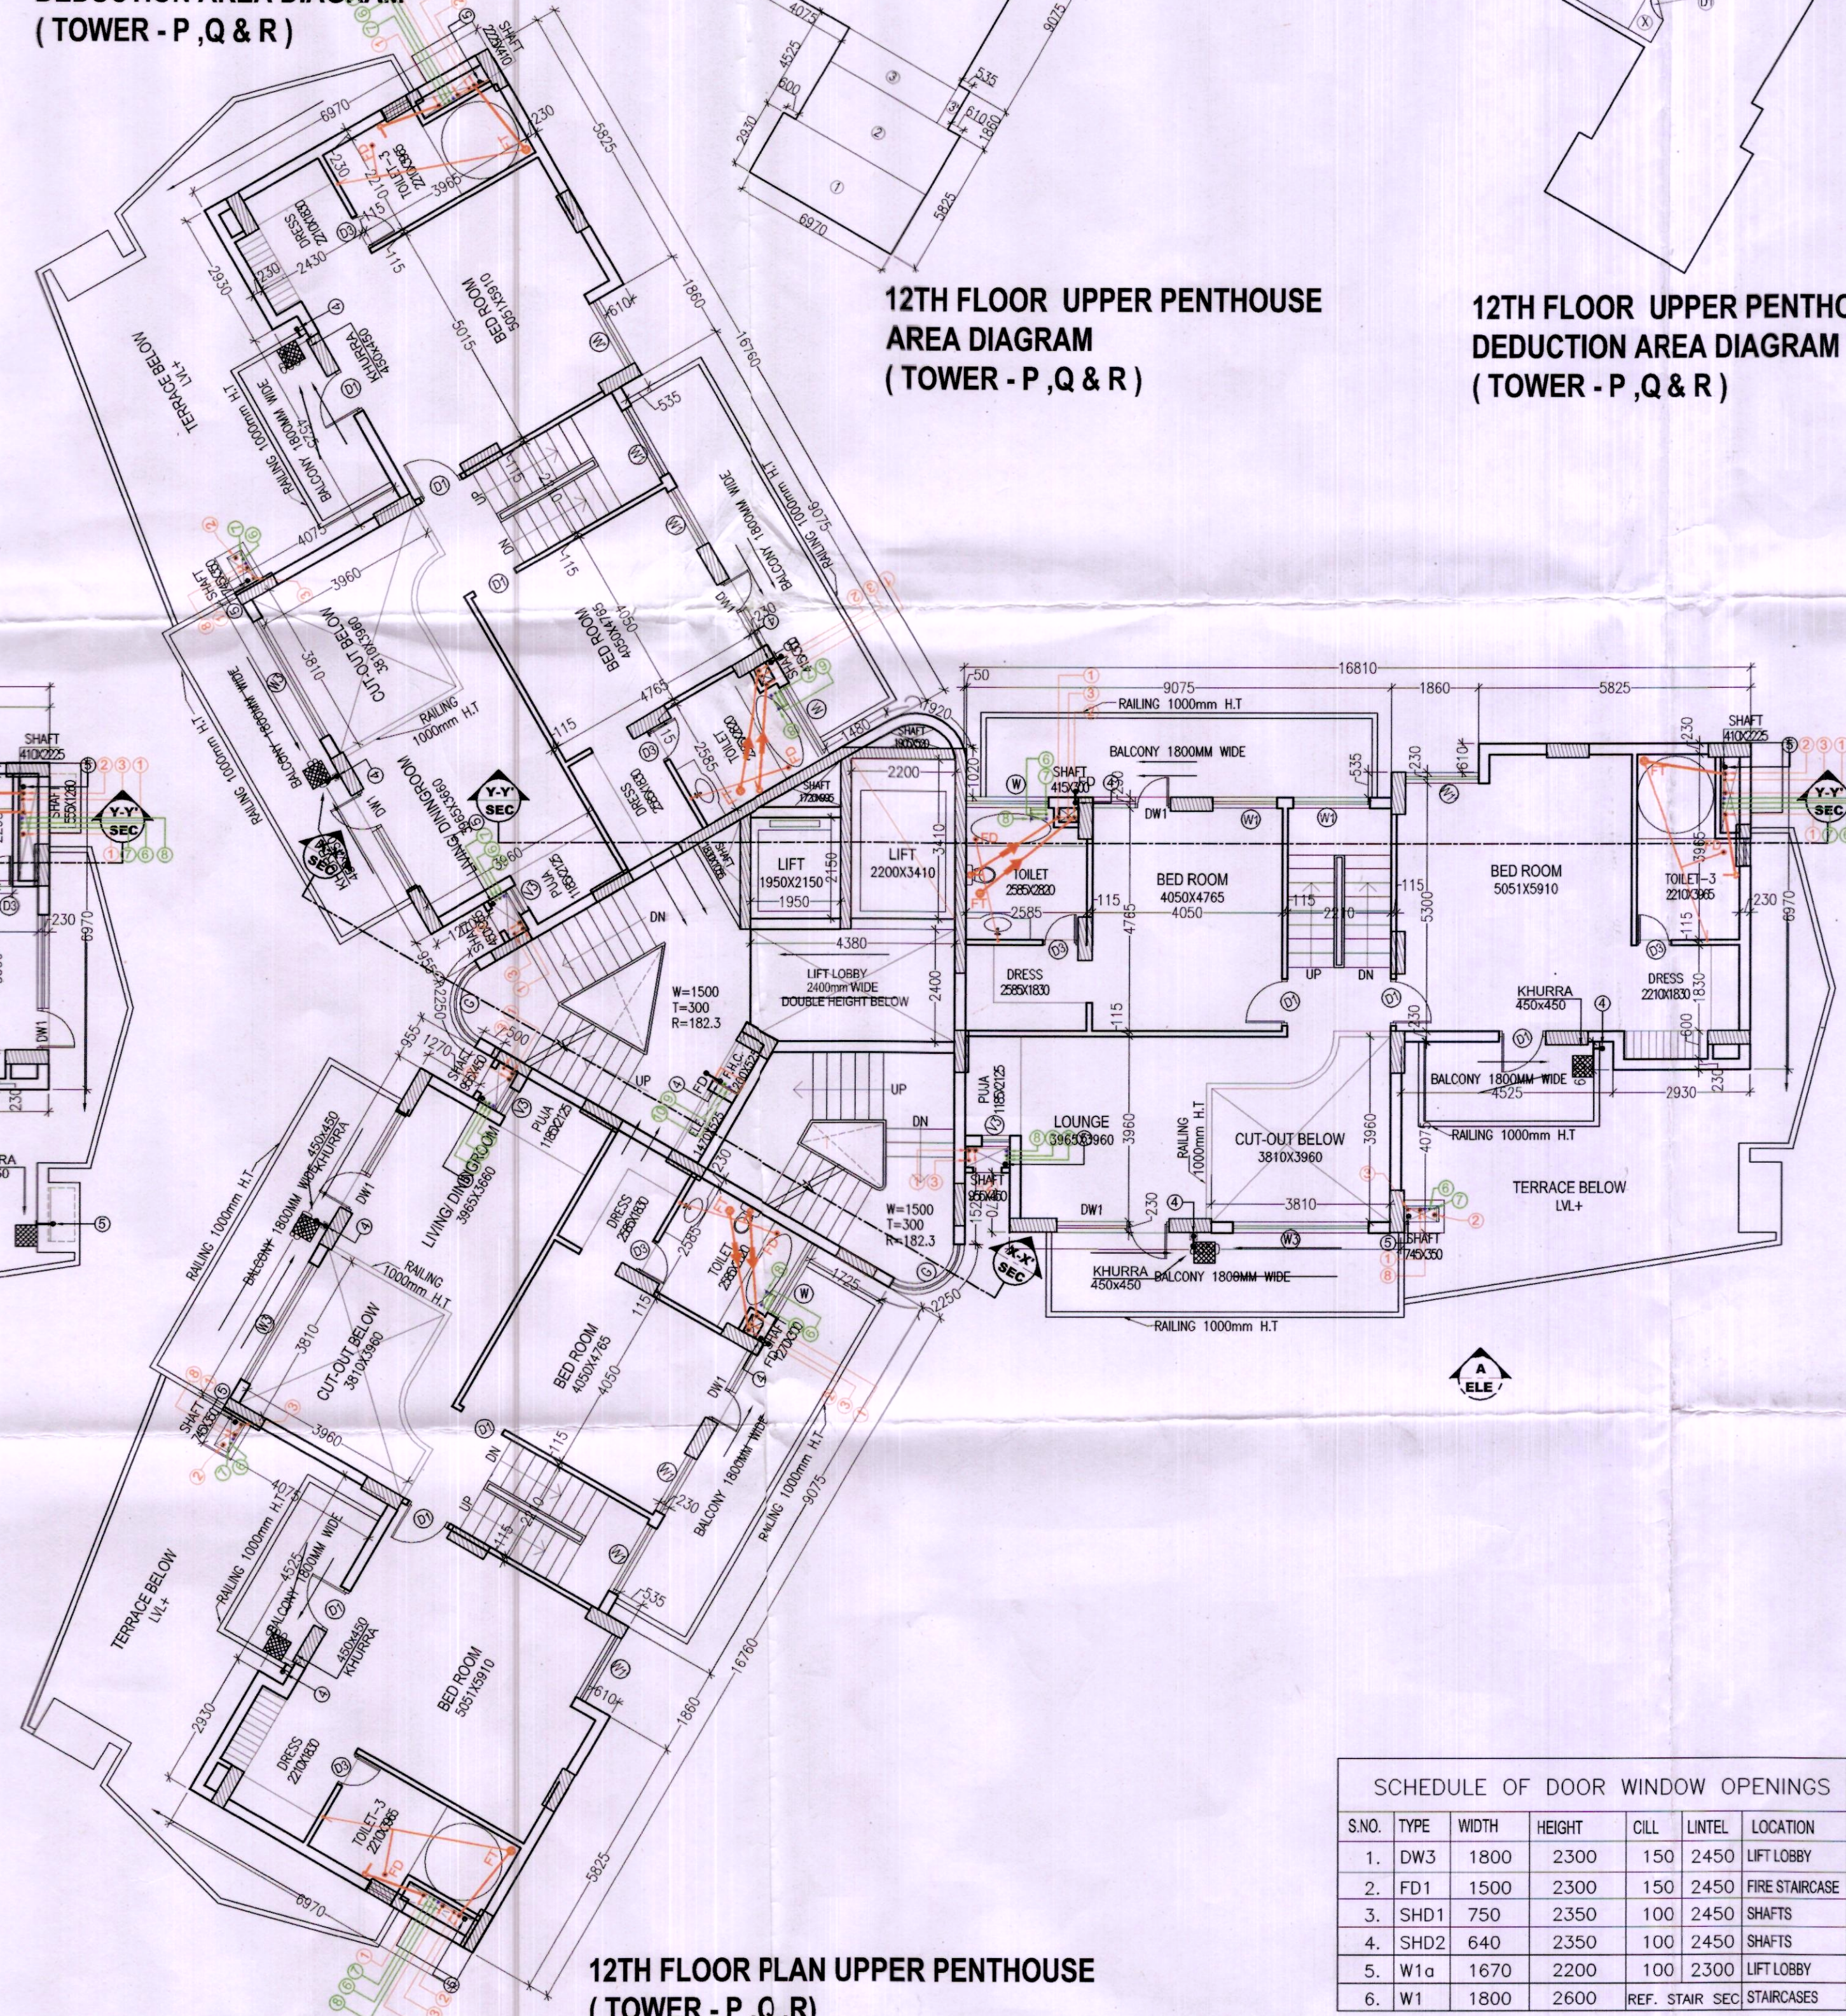

12TH FLOOR PLAN UPPER PENTHOUSE
(TOWER - P, Q, R)

SCHEDULE OF DOOR WINDOW OPENINGS

S.NO.	TYPE	WIDTH	HEIGHT	CILL	LINTEL	LOCATION
1.	DW3	1800	2300	150	2450	LIFT LOBBY
2.	FD1	1500	2300	150	2450	FIRE STAIRCASE
3.	SHD1	750	2350	100	2450	SHAFTS
4.	SHD2	640	2350	100	2450	SHAFTS
5.	W1a	1670	2200	100	2300	LIFT LOBBY
6.	W1	1800	2600	REF. STAIR SEC		STAIRCASES