



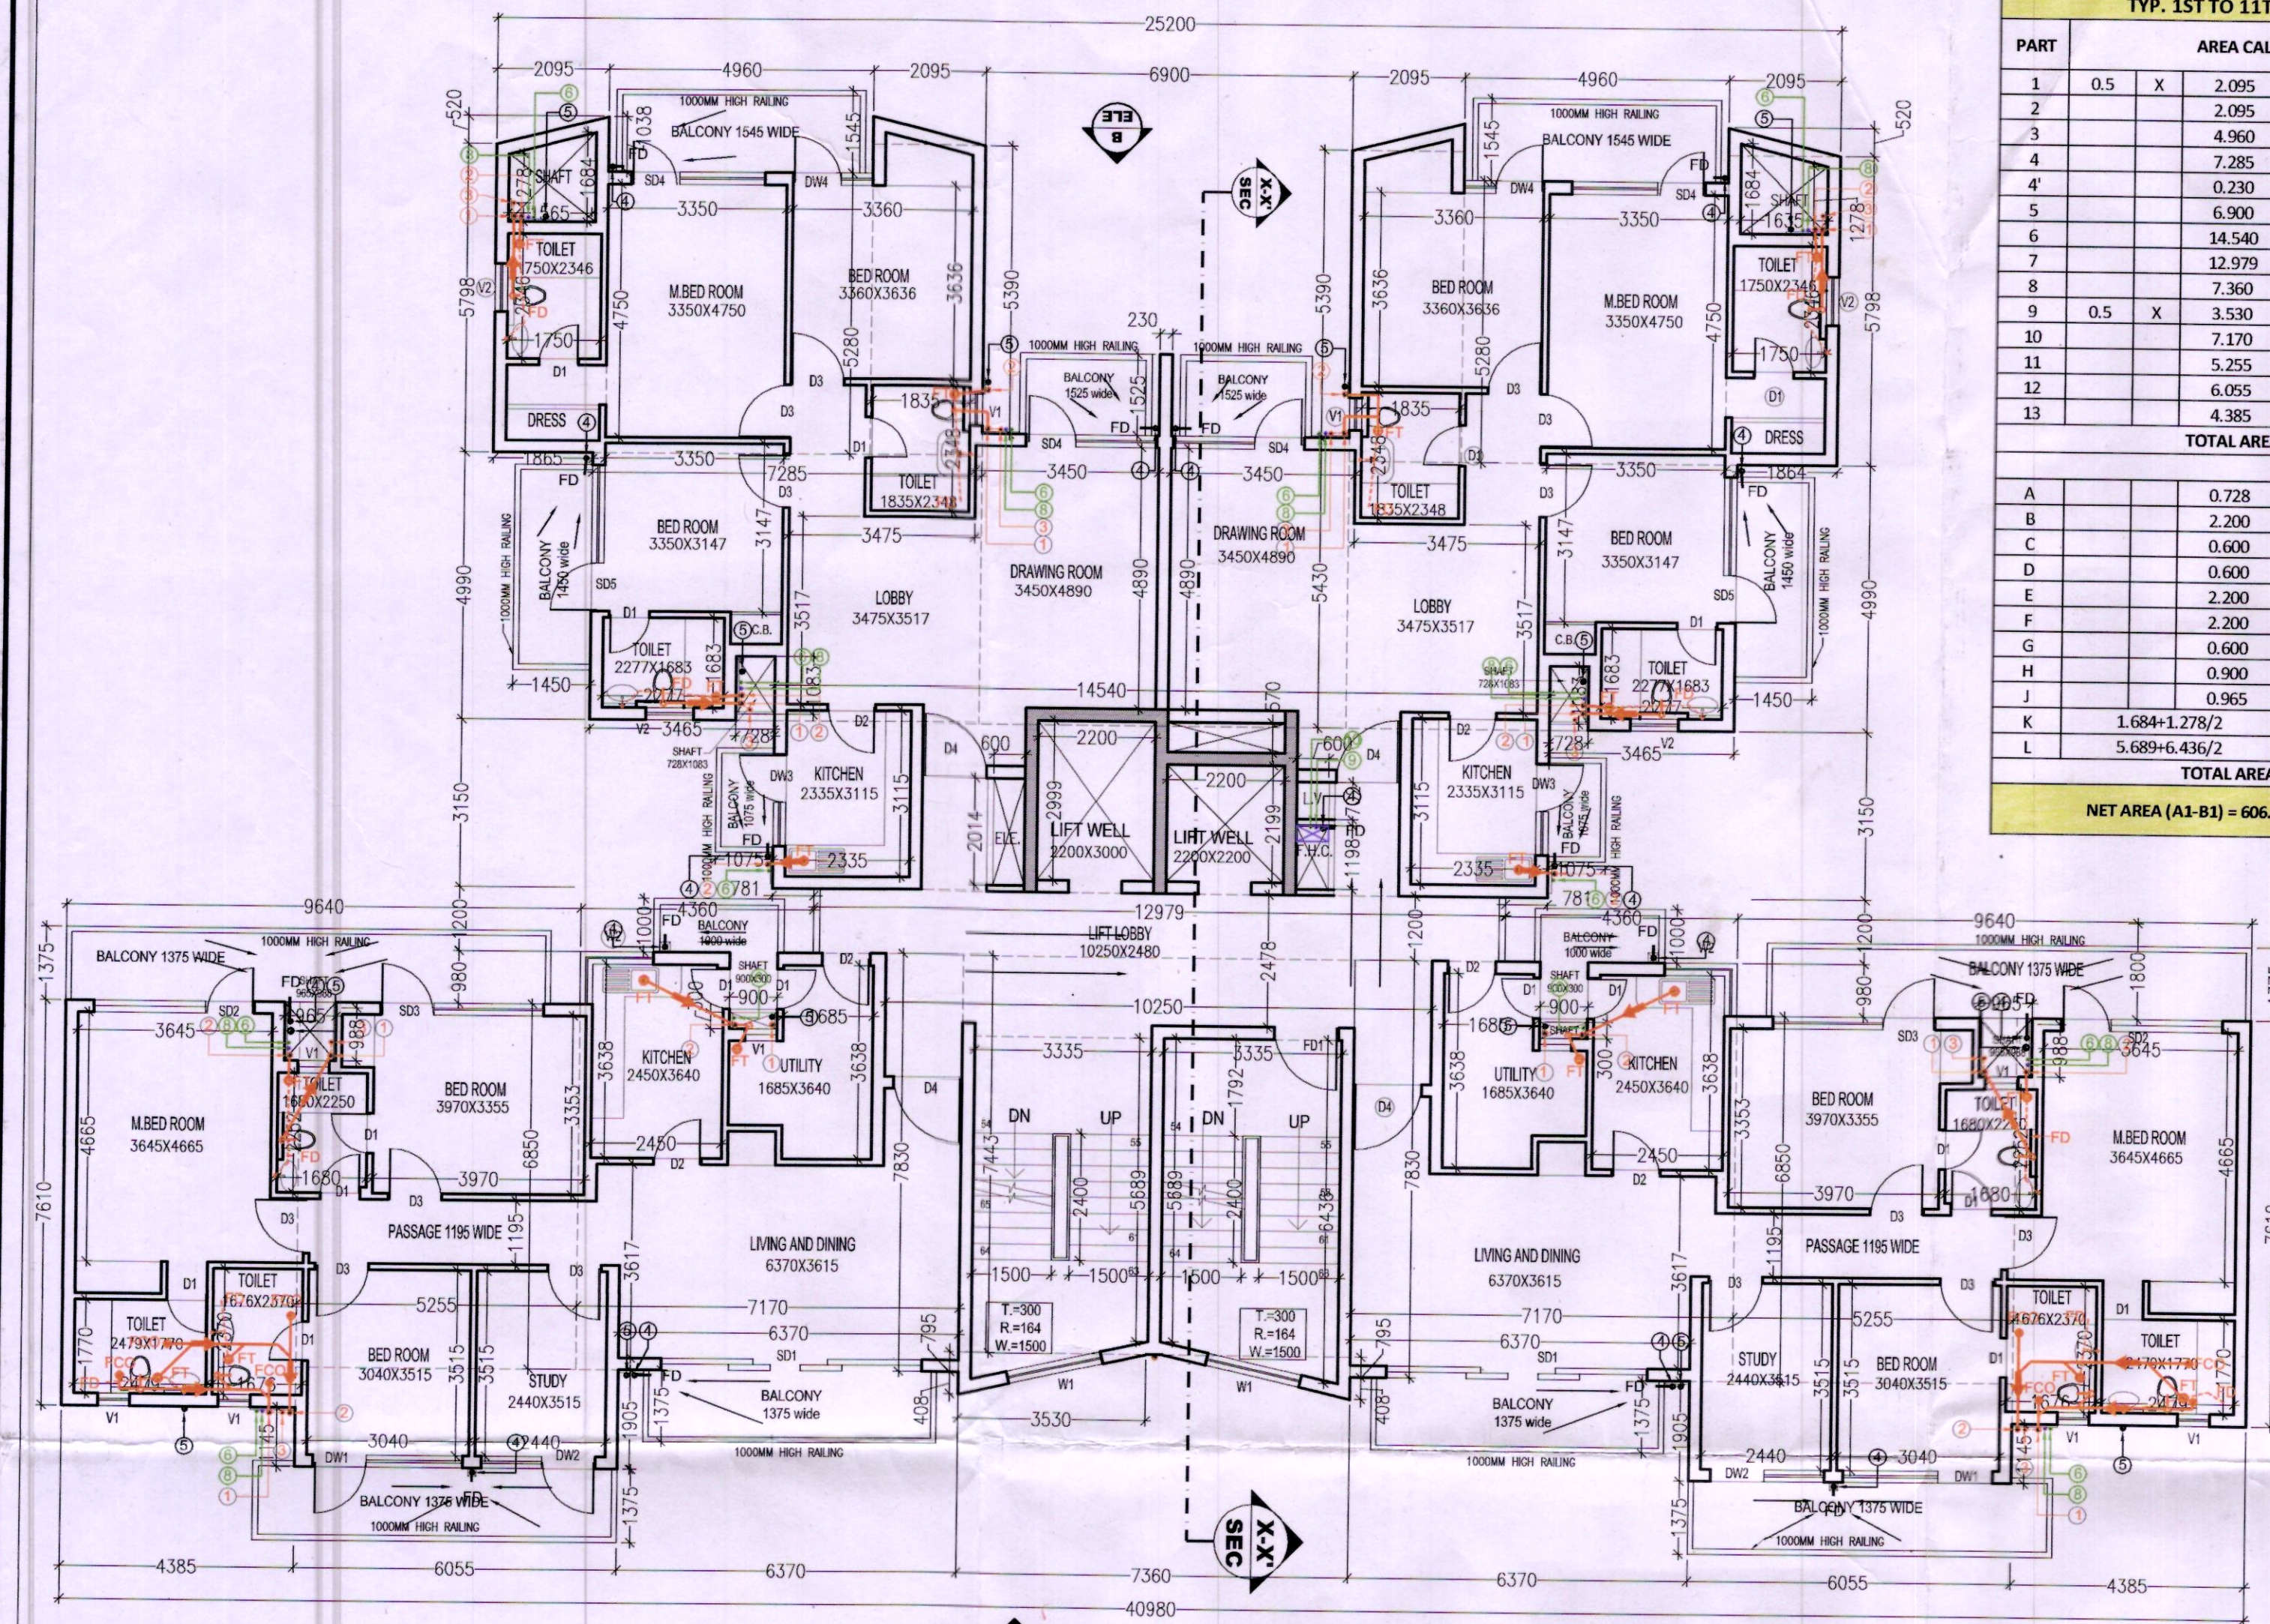


TYP. 1ST, 2ND, 4TH, 6TH, 8TH & 10TH FLOOR PLAN (TOWER A, B, C, D, E & F)

TYP. 1ST TO 11TH FLOOR AREA CALCULATION						
PART	AREA CALCULATION				NO.	TOTAL AREA (SQM'T)
1	0.5	X	2.095	X	0.520	X 4 = 2.179
2			2.095	X	5.798	X 4 = 48.587
3			4.960	X	5.280	X 2 = 52.378
4			7.285	X	4.950	X 2 = 72.717
4'			0.230	X	1.525	X 1 = 0.351
5			6.900	X	5.430	X 1 = 37.467
6			14.540	X	3.150	X 1 = 45.800
7			12.979	X	1.200	X 1 = 15.575
8			7.360	X	7.443	X 1 = 54.780
9	0.5	X	3.530	X	0.795	X 2 = 2.806
10			7.170	X	7.830	X 2 = 112.282
11			5.255	X	6.850	X 2 = 71.990
12			6.055	X	1.905	X 2 = 23.066
13			4.385	X	7.610	X 2 = 66.740
TOTAL AREA						= 606.713
DEDUCTION						
A			0.728	X	1.083	X 2 = 1.577
B			2.200	X	0.570	X 1 = 1.254
C			0.600	X	0.702	X 1 = 0.421
D			0.600	X	1.198	X 1 = 0.719
E			2.200	X	2.200	X 1 = 4.840
F			2.200	X	3.000	X 1 = 6.600
G			0.600	X	2.014	X 2 = 1.208
H			0.900	X	0.300	X 2 = 0.540
J			0.965	X	0.988	X 2 = 1.907
K	1.684+1.278/2	X	1.635	X	2	= 4.842
L	5.689+6.436/2	X	3.335	X	2	= 40.437
TOTAL AREA						= 64.345
NET AREA (A1-B1) = 606.363 - 64.345						= 542.018

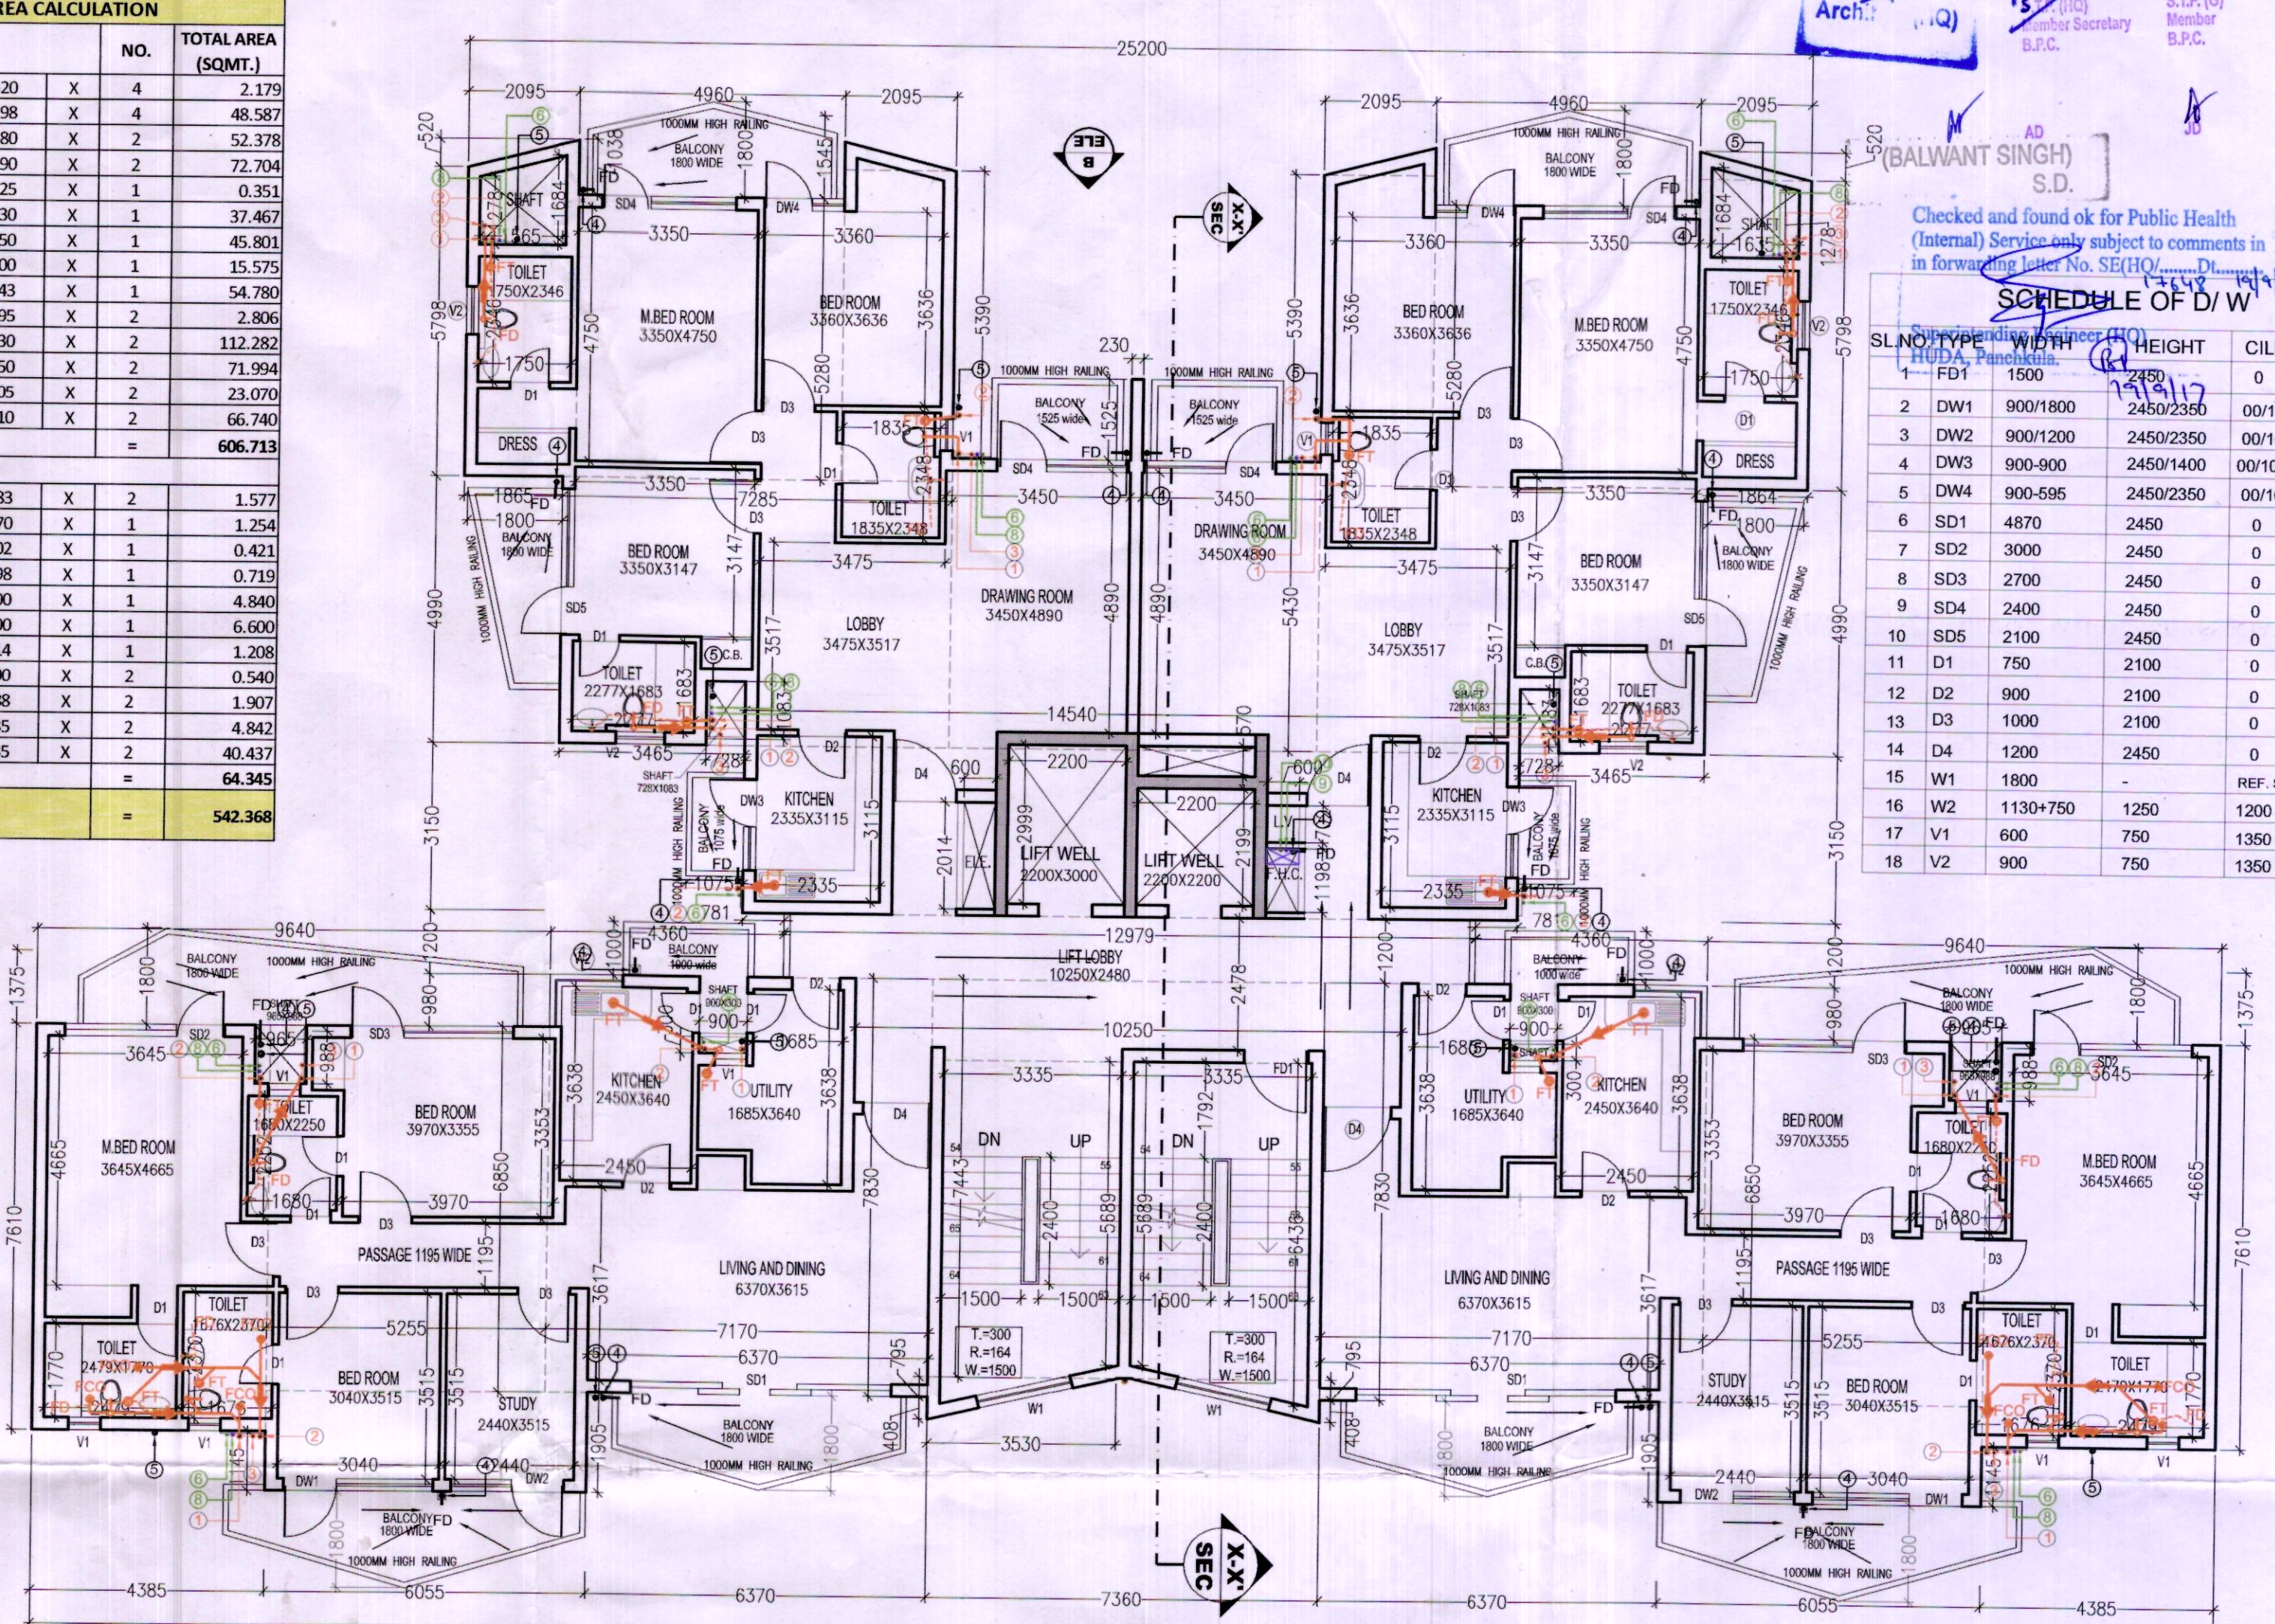


TYP. 3RD, 5TH, 7TH, 9TH & 11TH FLOOR PLAN (TOWER A, B, C, D, E & F)

LEGEND	
1	110 OD uPVC (SWR) SOIL & VENT PIPE
2	110 OD uPVC (SWR) WASTE & VENT PIPE
3	75 OD uPVC VENT PIPE
4	90 OD uPVC (SWR) RAIN WATER PIPE
5	110 OD uPVC (SWR) RAIN WATER PIPE
6	DOMESTIC WATER SUPPLY DN TAKE FOR 10th TO GROUND FLOOR
7	DOMESTIC WATER SUPPLY DN TAKE FOR UPPER PENT TO 11th FLOOR
8	FLUSHING WATER SUPPLY DN TAKE
9	DOMESTIC WATER SUPPLY RISER
10	FLUSHING WATER SUPPLY RISER
11	FLOOR TRAP
12	FLOOR DRAIN
13	FLOOR CLEAN OUT
14	CLEAN OUT PLUG
15	KH KHURRA 450x450
16	MANHOLE

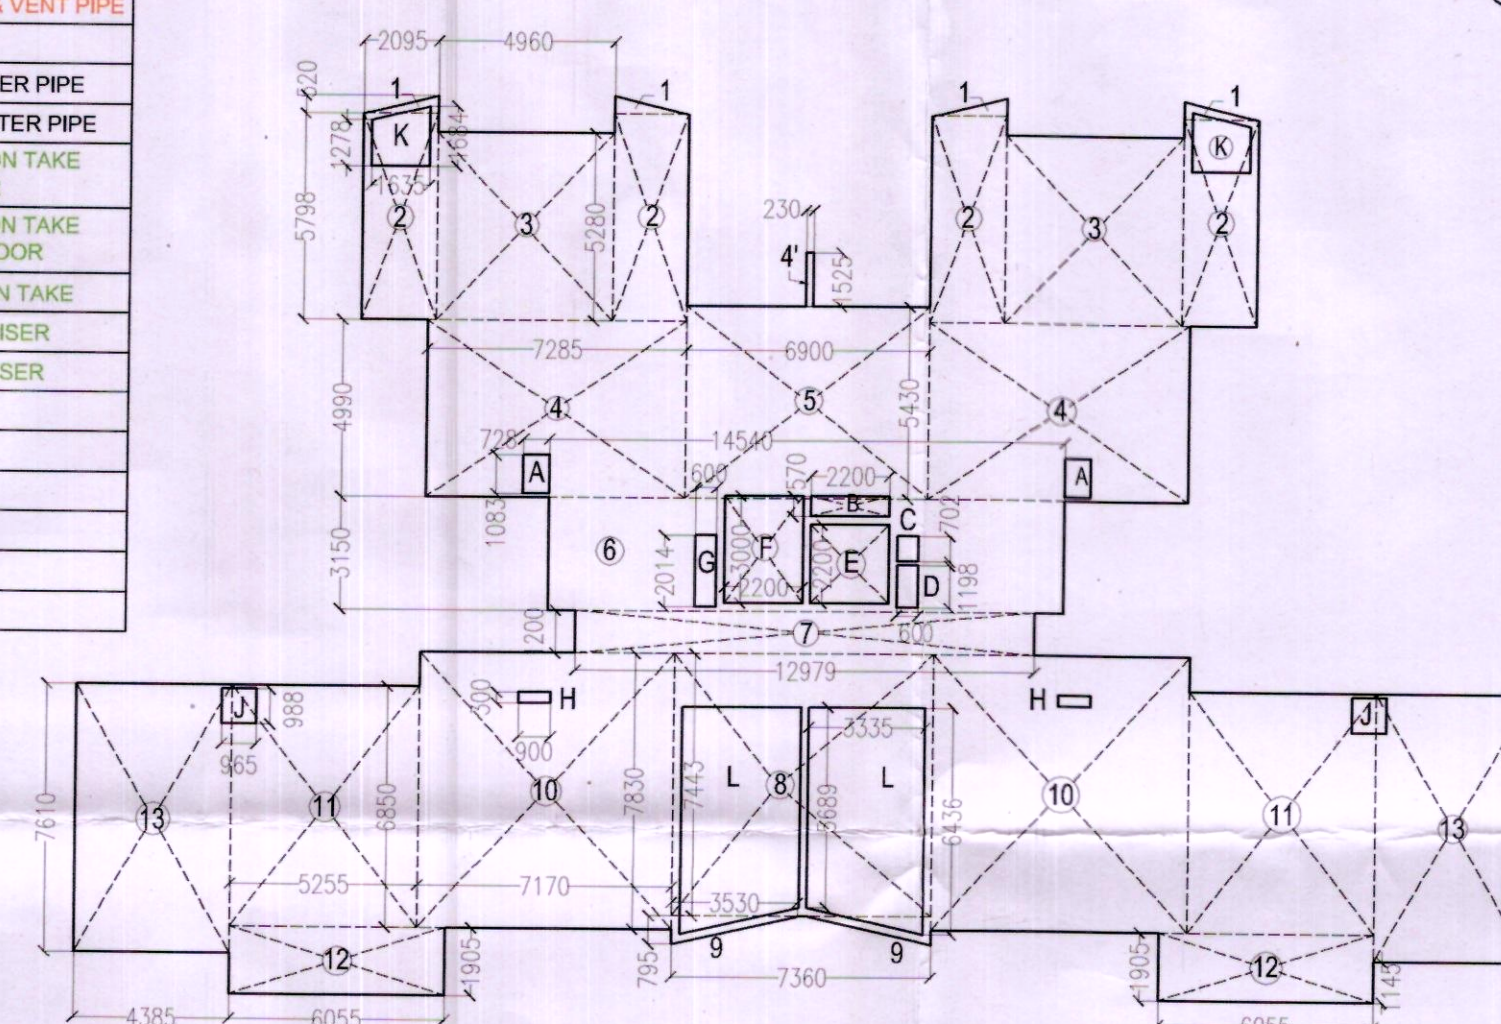

TYP. 1ST TO 11TH FLOOR AREA DIAGRAM (TOWER A, B, C, D, E & F)

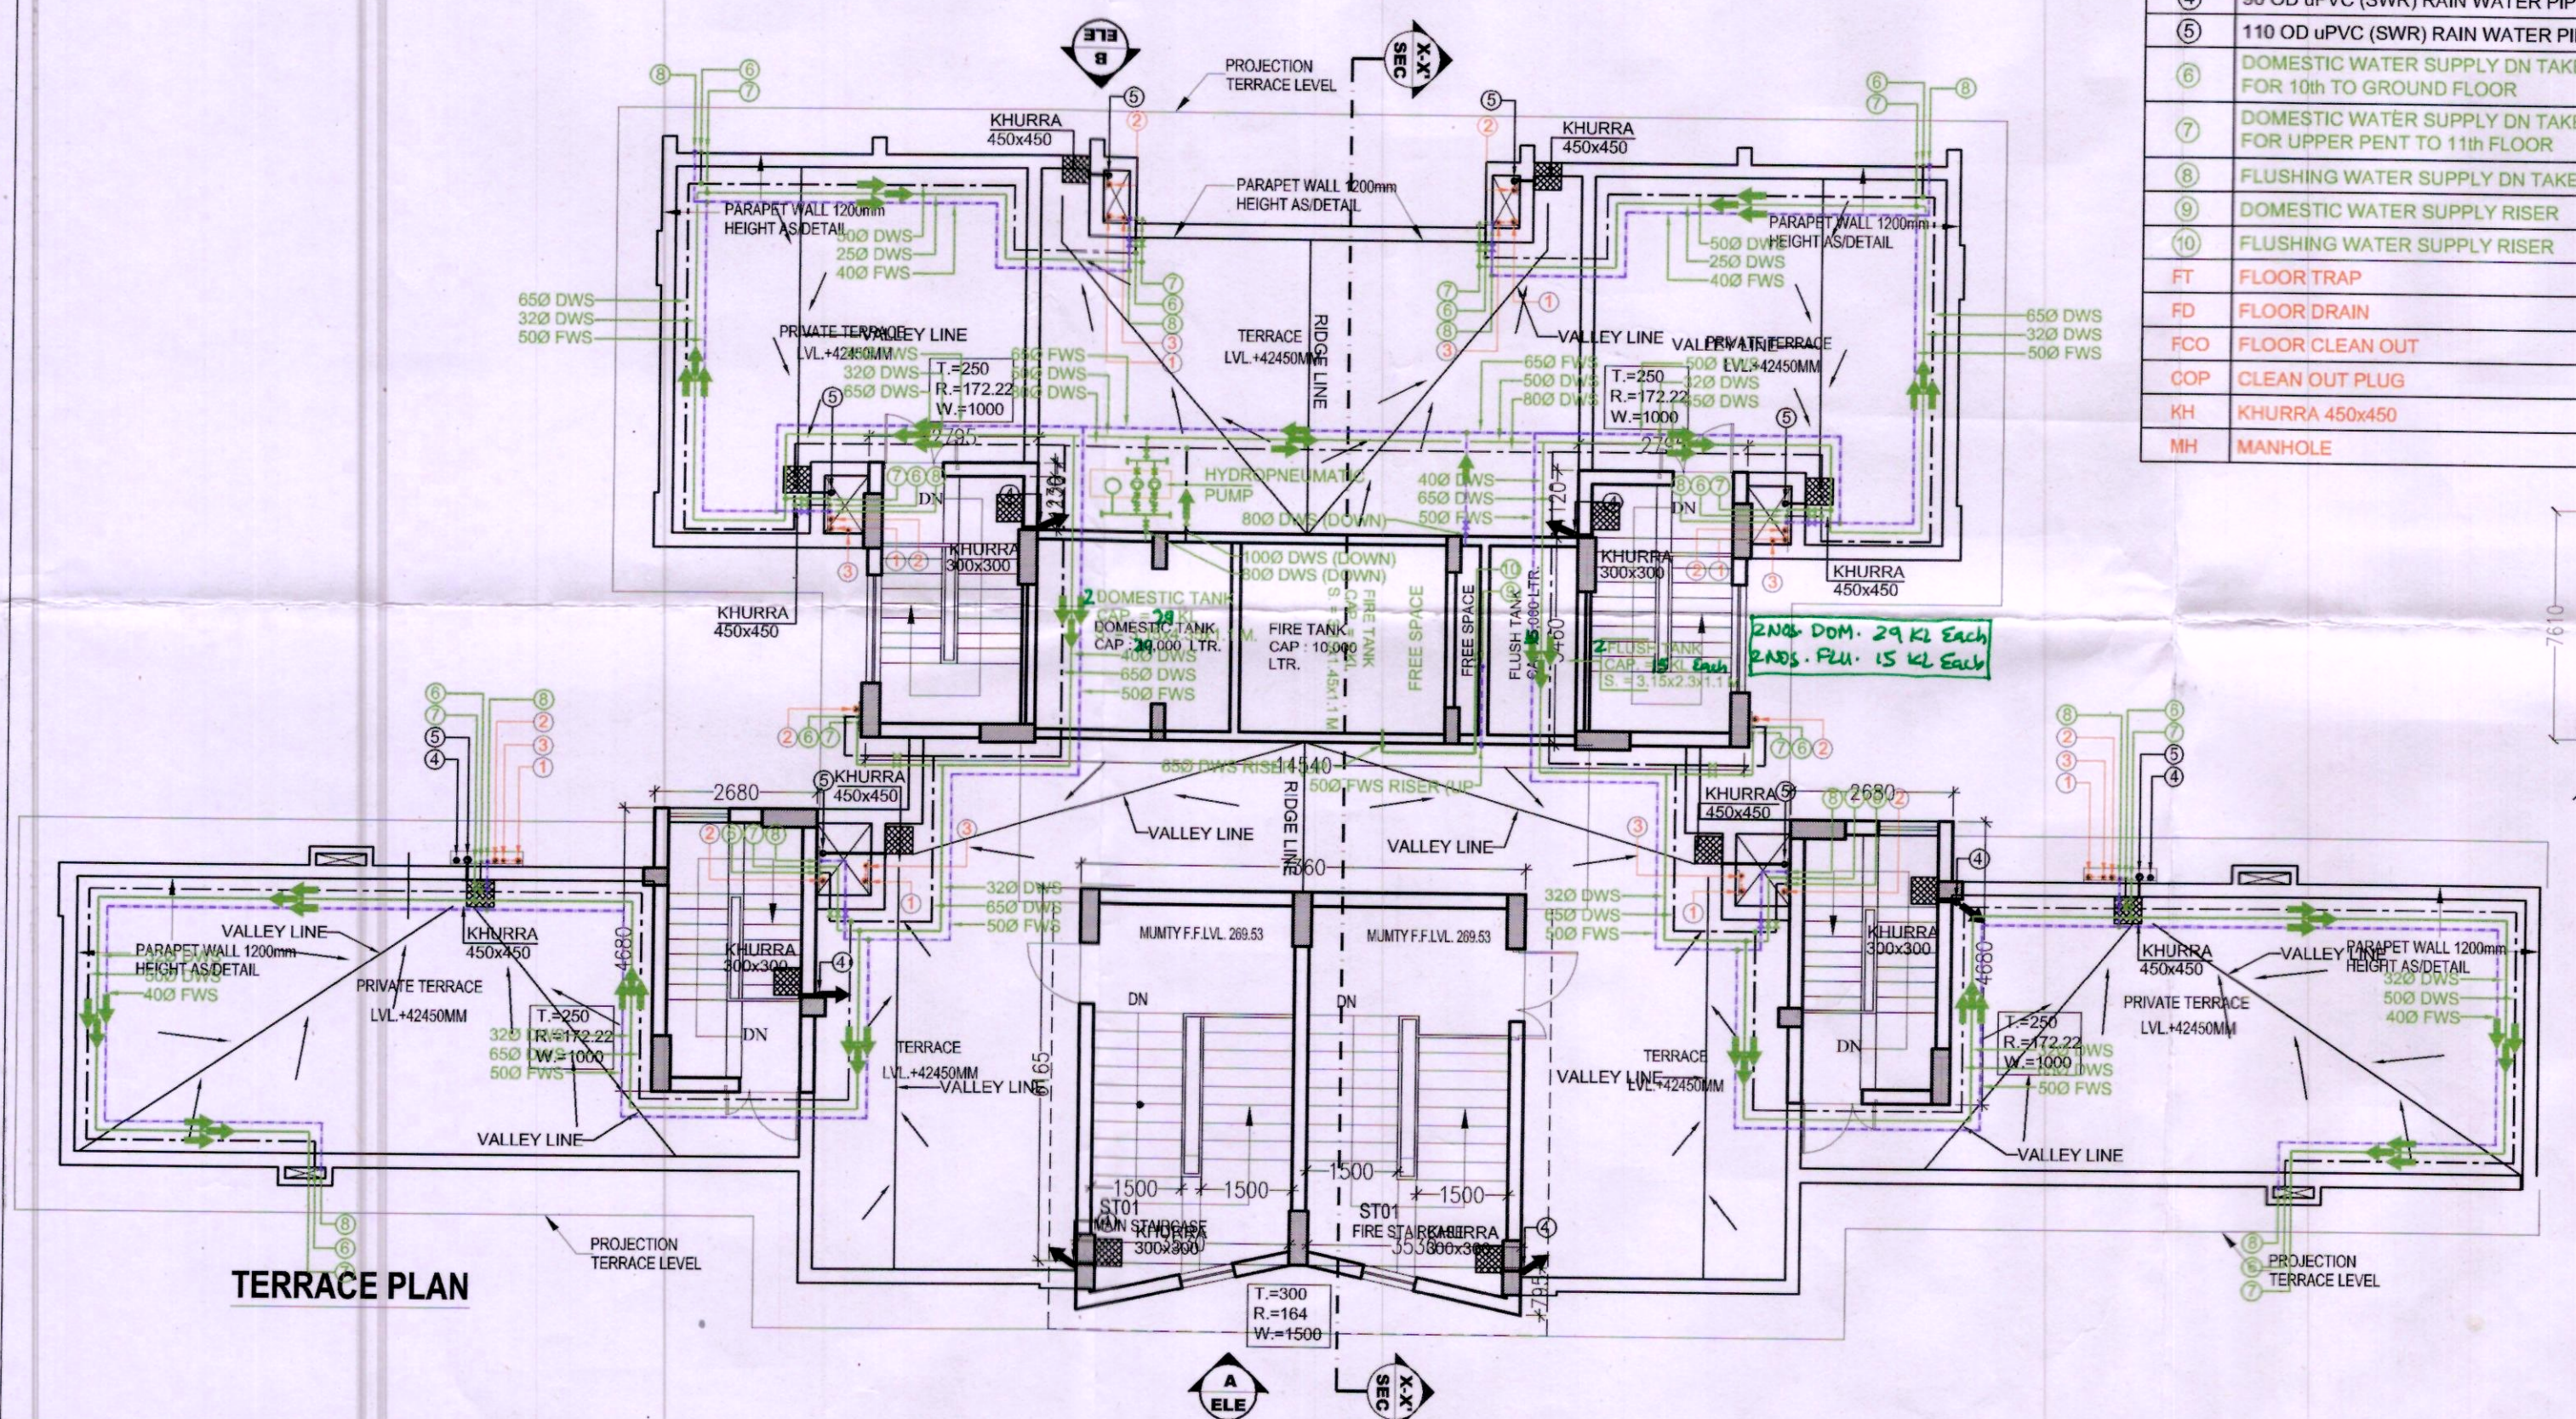

TERRACE PLAN

MUMTY MACHINE ROOM AREA DIAGRAM

MUMTY AREA NON F.A.R.					
S.N.O.	NO.	PREFIX	LENGTH	BREATH	AREA
1	2	1	2.795	1.120	6.261
2	1	1	14.540	3.460	50.308
3	2	1	2.680	4.680	25.085
4	1	1	7.360	6.165	45.374
5	2	0.5	3.530	0.795	2.806
TOTAL MUMTY MACHINE ROOM AREA (NON F.A.R.)					129.835

TOP TERRACE PLAN

- NOTES:-
- ALL DIMENSIONS IN MM.
 - LIFT SHALL BE WITH 100% POWER BACKUP.

PROJECT:-
REVISED BUILDING PLAN OF GROUP HOUSING SCHEME LAND MEASURING 15.575 ACRES (LICENCE NO. 71 OF 2008 DATED 25.03.2008) IN SECTOR - 91, GURGAON MANESAR URBAN COMPLEX BEING DEVELOPED BY M/S JUBILANT SOFTWARES SERVICES PVT.LTD.

ARCHITECT:-
GIAN P. MATHUR AND ASSOCIATES (P) LTD.
C-55, East Of Kailash, New Delhi-110065
T: 011-46599599 / F: 011-46599512
E: gpma@airtelmail.in / W: www.gpmindia.com

OWNERS SIGNATURE:-
ARCHITECT SIGNATURE:-

For JUBILANT Software Services Pvt. Ltd.
Authorised Signatory
GIAN P. MATHUR
ARCHITECT
B. Arch., M.C.A. I.I.T.
CA No. 8015769

DRAWING TITLE:
TOWER A TO F
TYP. FLOOR PLAN

DATE:- JULY-2017
SCALE:- 1:100

SHEET NO.
04