


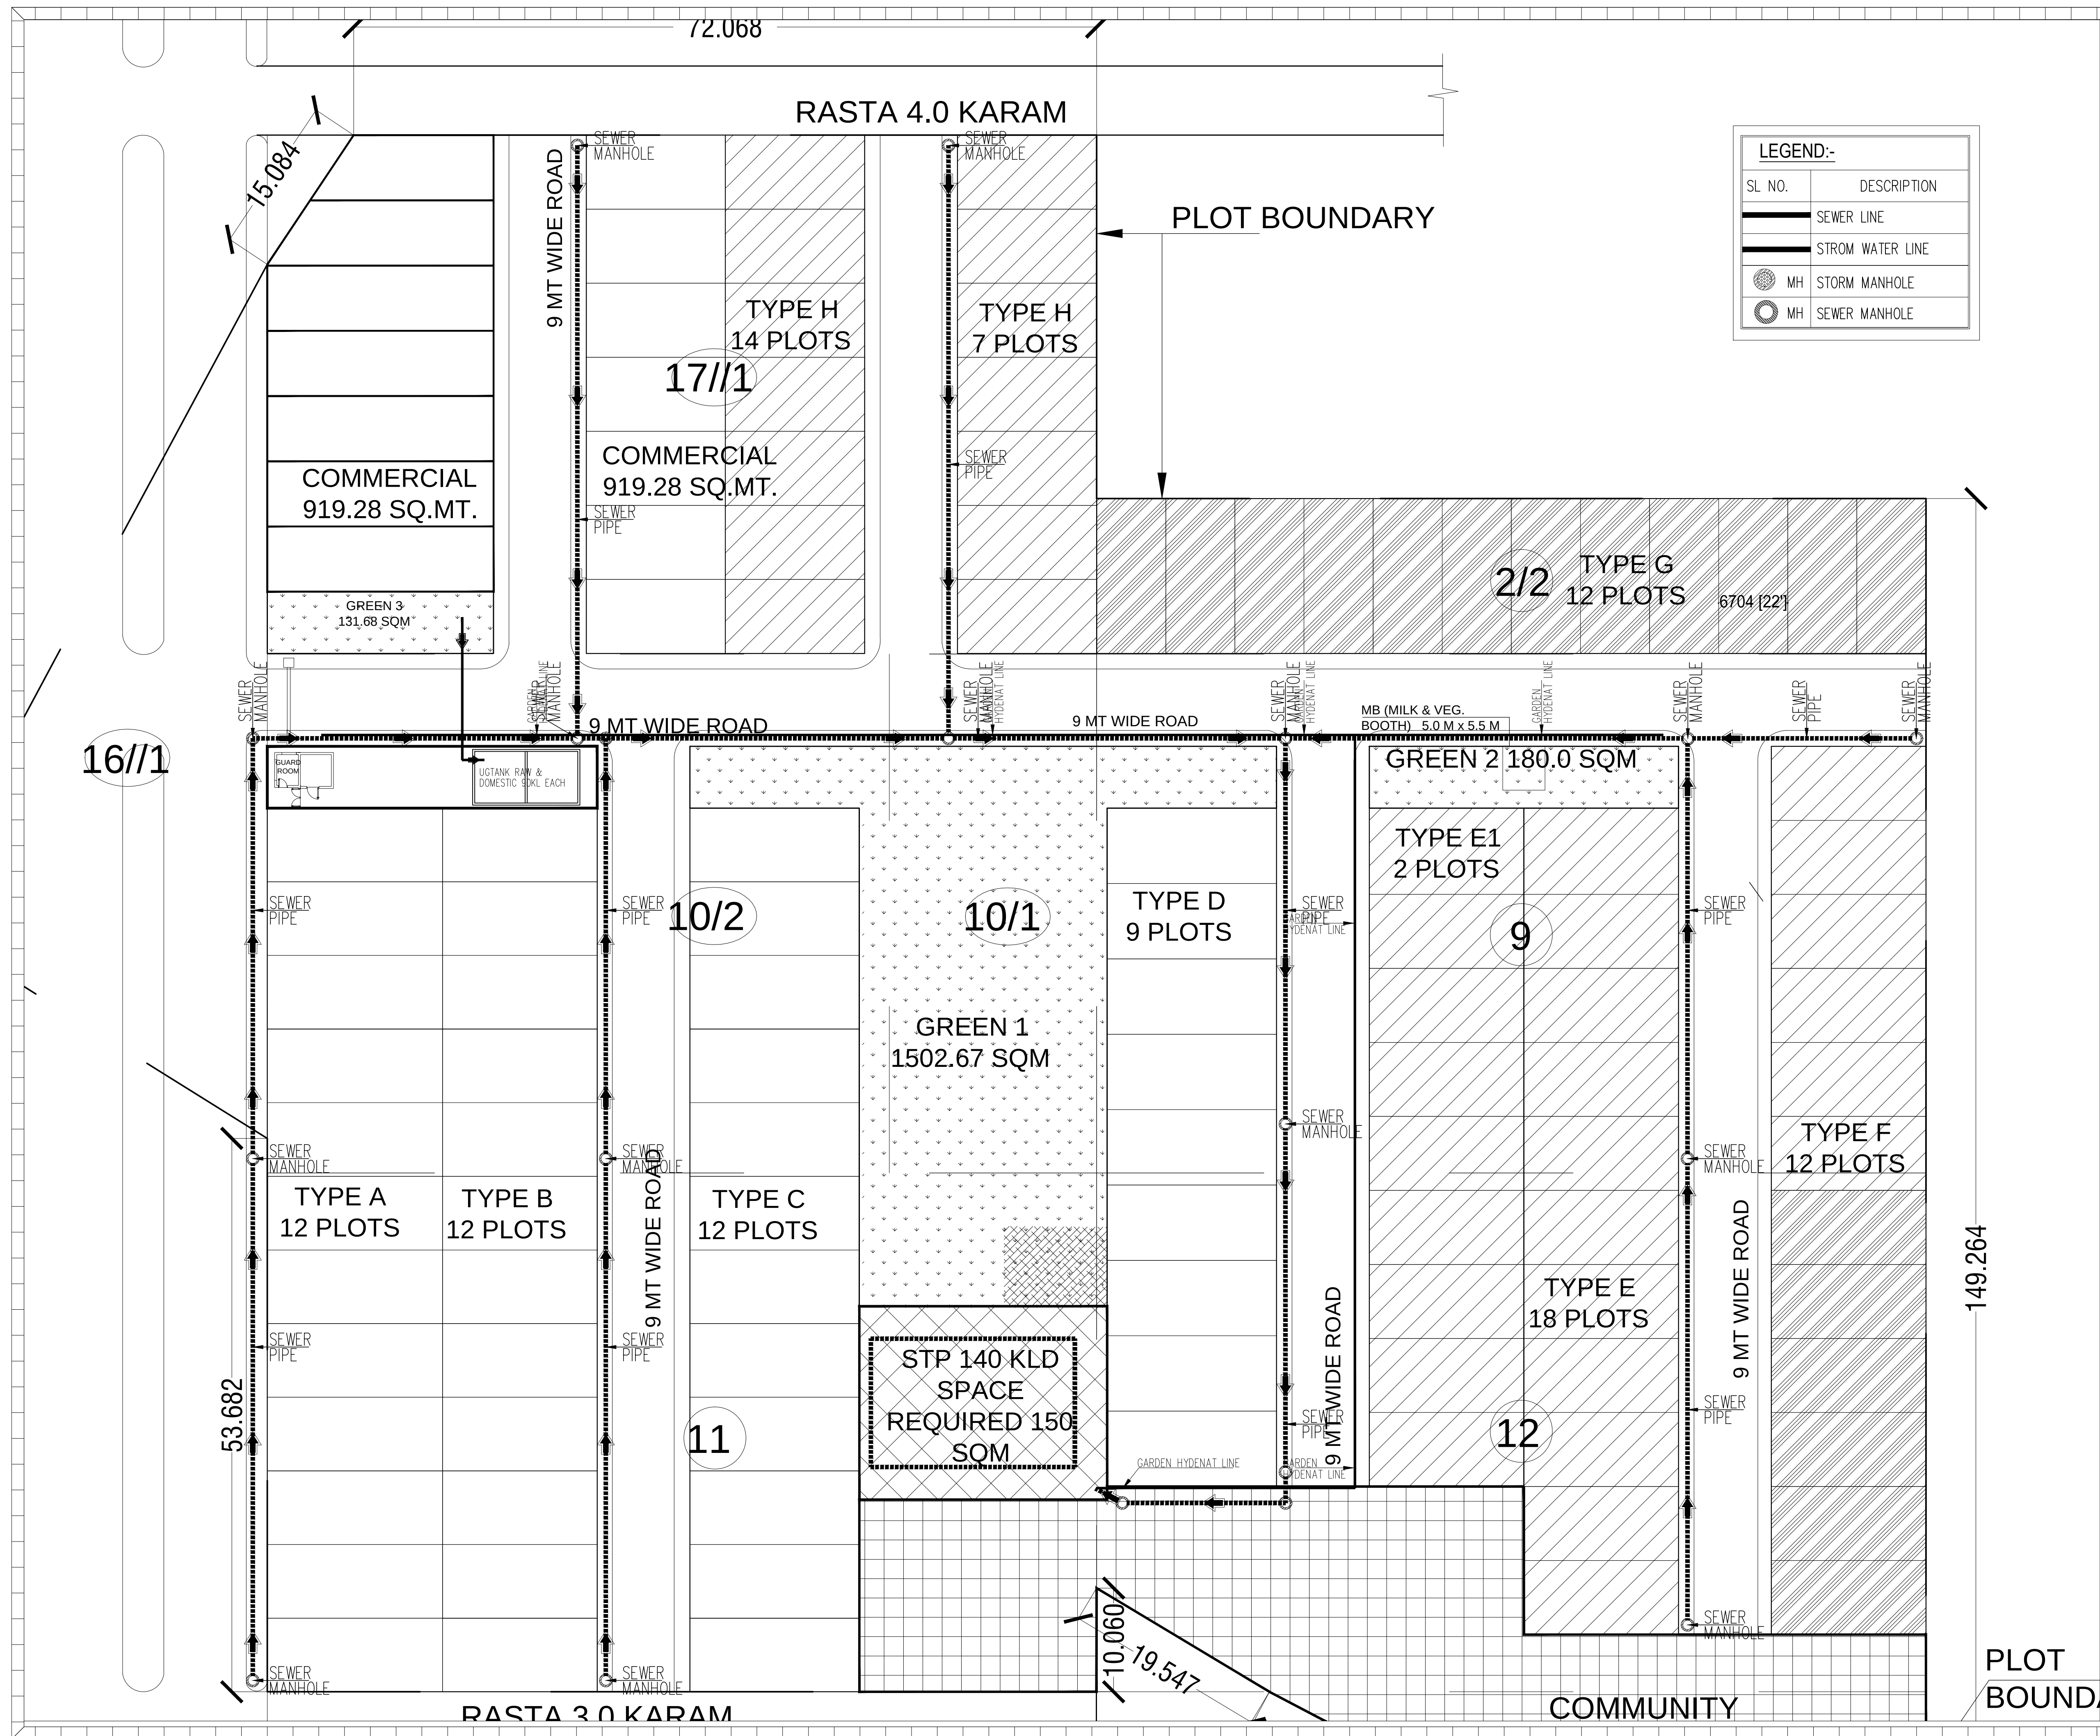

PROJECT NAME AND ADDRESS:
**AFFORDABLE PLOTTED
RESIDENTIAL COLONY (DDJAY)
AT VILLAGE ATTA & RAMPUR
SECTOR 12 SOHNA, MEWAT**

CLIENT NAME AND ADDRESS:
M/s.- TEDRE REALCON INDIA PVT. LTD.

PLUMBING & FIRE CONSULTANTS:
BEHERA ASSOCIATES PVT.LTD
F-623A, LADO SARAI, BEHIND CNG STATION
NEW DELHI - 110030
Ph: 011-40583898, 09811911853
Email: behera.associates@gmail.com

ELECTRICAL CONSULTANT
ECMS INDIA PVT. LTD.
G-241, First Floor, Sector-63, Noida
PIN 201301
E-mail: ecms.tech01@gmail.com
URL: www.ecmsindia.com
Ph.No. 0120-4205667

DRAWING TITLE
**EXTERNAL SITE PLAN
SEWER LAYOUT**

PURPOSE OF DRAWING

☐ PRELIMINARY LAYOUT	☐ ADVANCE COPY
☐ FOR APPROVAL	☐ GOOD FOR CONSTRUCTION
☒ SUBMISSION DRAWING	☐ REFERENCE DRAWING

DRG. CODE NO.: ZARA/BA/PL/SITE.-01
DATE: R0(11.08.2020)

SCALE : NTS
Rev. No. North

Architect:-

DESIGN FORUM
INTERNATIONAL
ARCHITECTURE • URBAN DESIGN • TOWN PLANNING

Address : K-47, KAILASH COLONY , NEW DELHI -48
: 011-46556600 , Fax - 46556601