


AMSTORIA

TOTAL LICENCED AREA = 126.674 ACS.
APPLIED AREA = 6.375 ACS.
TOTAL AREA OF THE SCHEME = 133.049 ACS.

LEGEND FOR EXTERNAL LIGHTING	
	250W Sodium Vapour 9M POLE FOR 24M ROAD
	150W Sodium Vapour 6M POLE FOR 12,15&18 M ROAD
	STREET LIGHT FEEDER PILLER

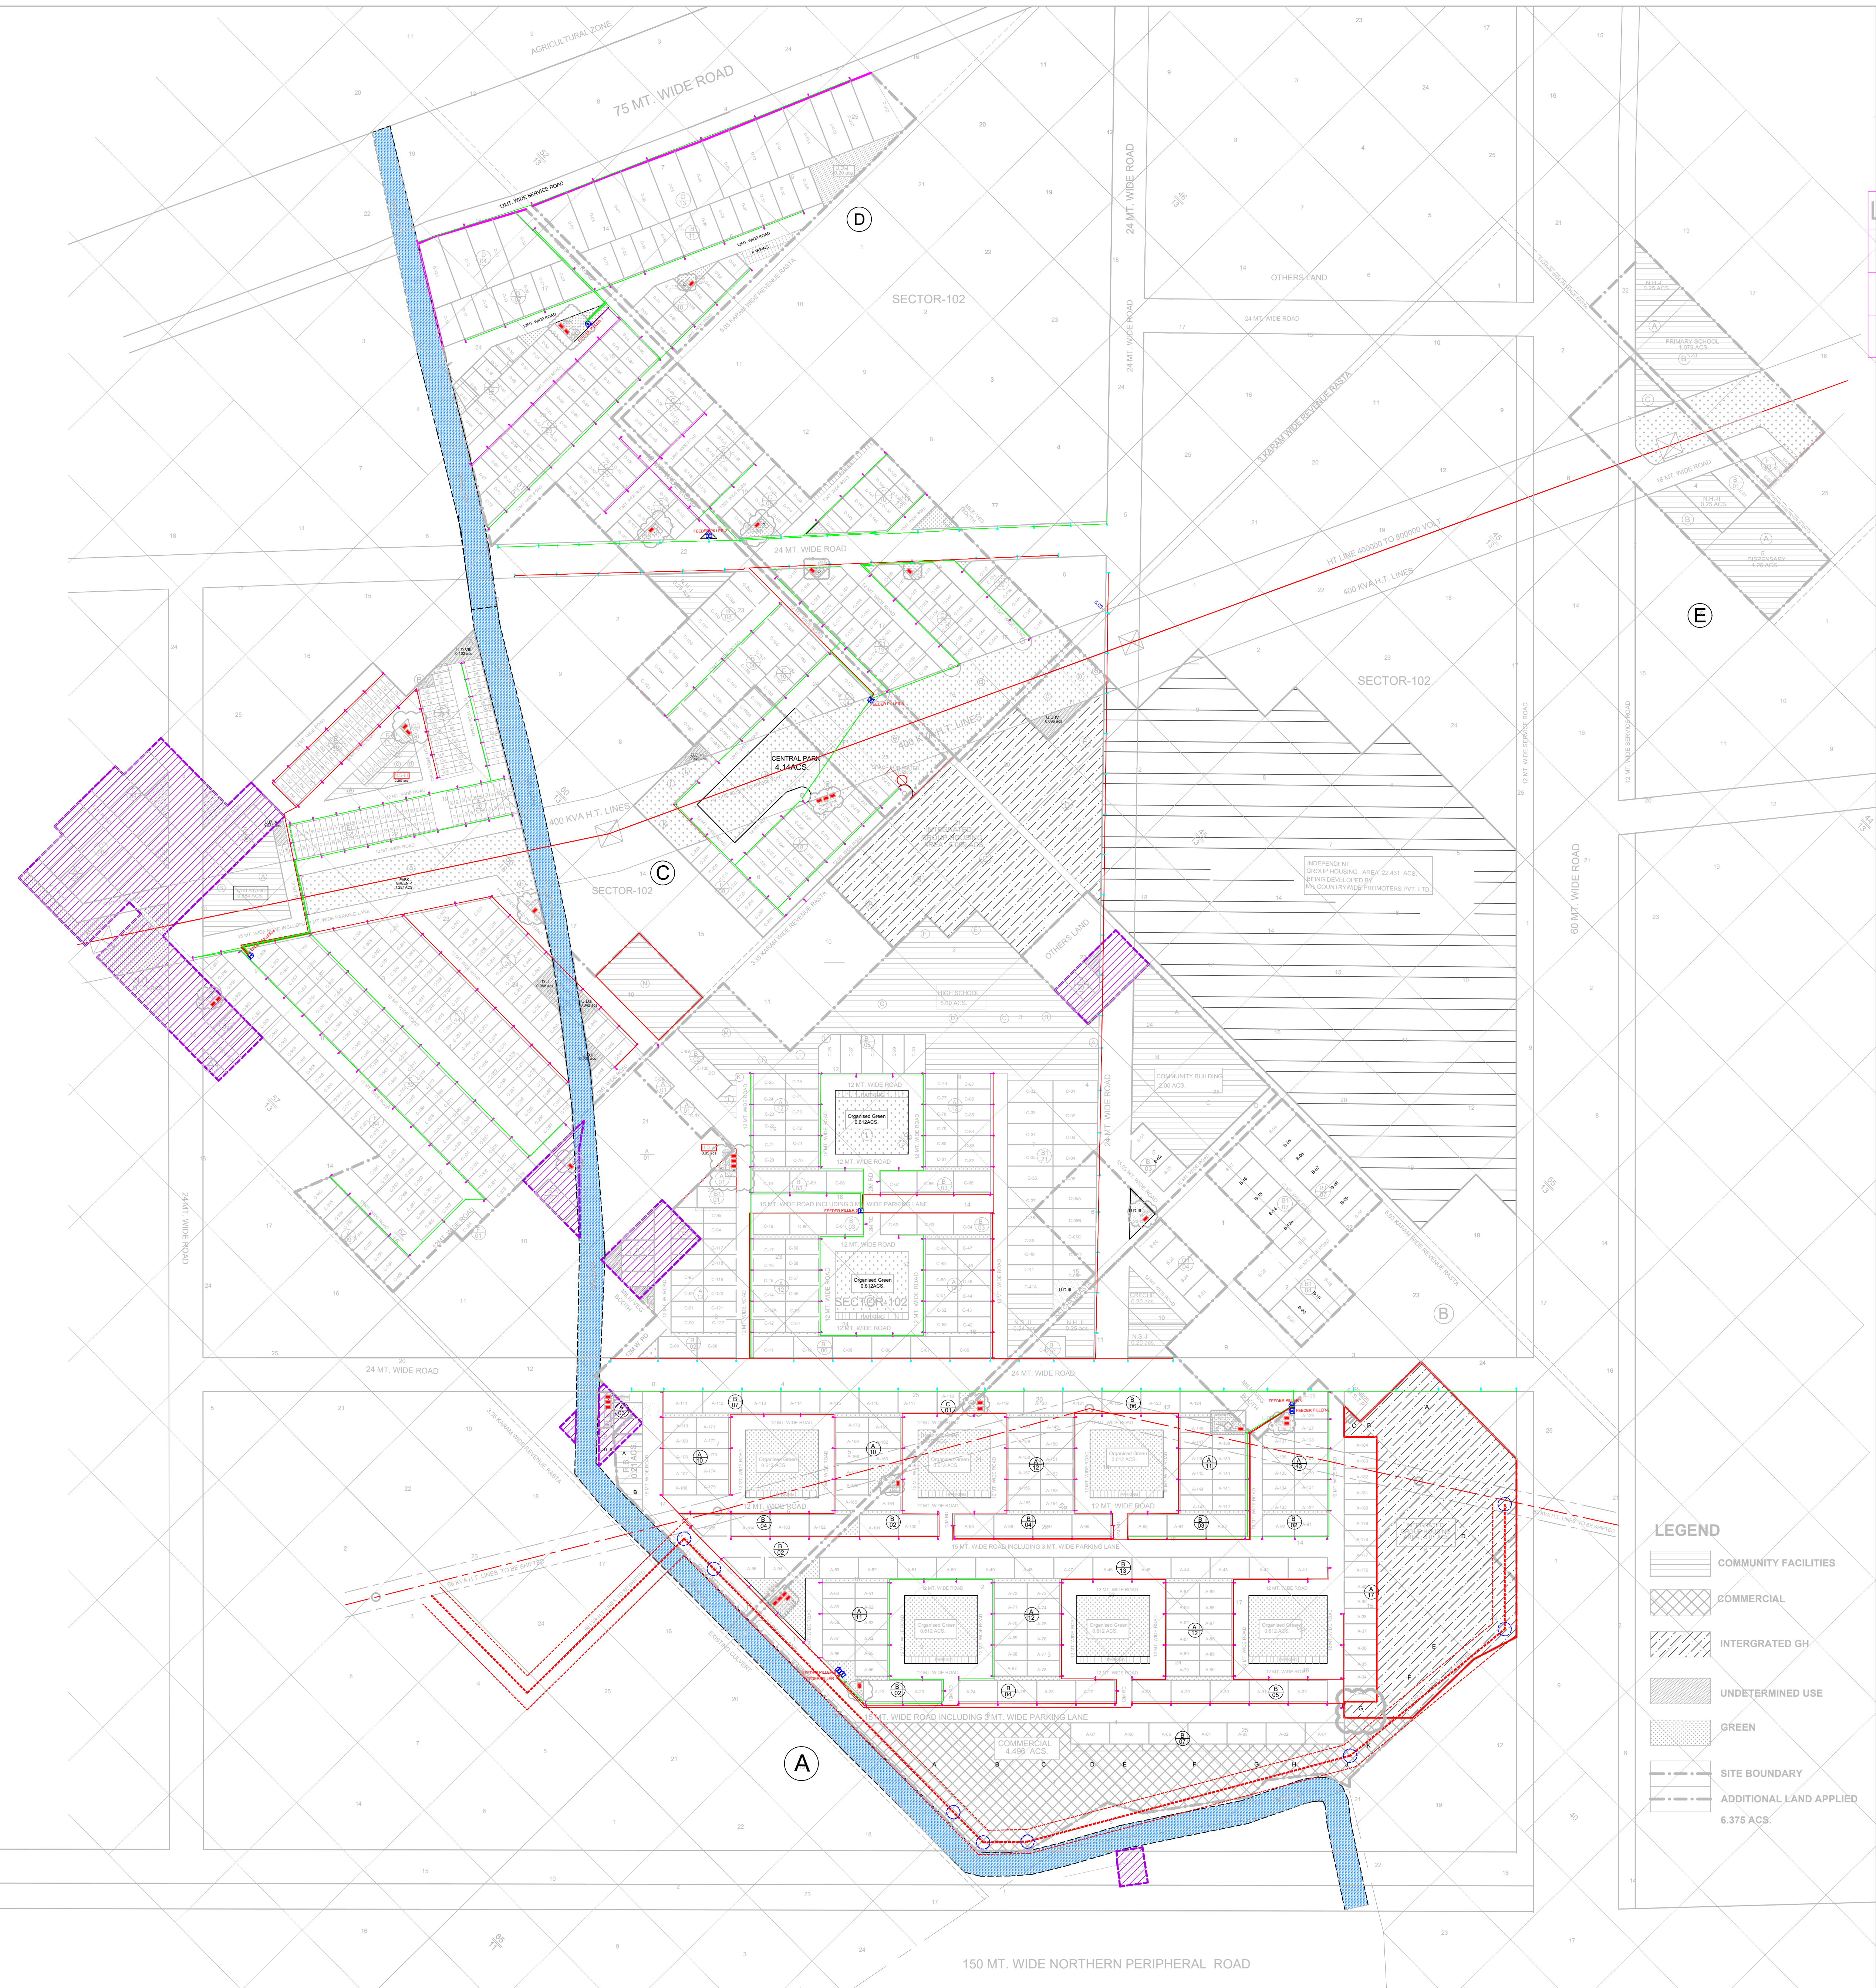

LEGEND	
	COMMUNITY FACILITIES
	COMMERCIAL
	INTERGATED GH
	UNDETERMINED USE
	GREEN
	SITE BOUNDARY
	ADDITIONAL LAND APPLIED 6.375 ACS.

CLIENT :
COUNTRYWIDE PROMOTERS PVT. LTD.
M-11 CONNAUGHT CIRCUS
NEW DELHI

Authorized Signatory	Architect / Town Planner	
----------------------	--------------------------	--

STREET LIGHTING LAYOUT PLAN
SECTOR -102&102A IN GURGAON
HARYANA.

SCALE 1:1000 | DATE:- JUNE 2014 | DRAWN BY- sandeep | DRG. NO.- R9/LOP/GGN