




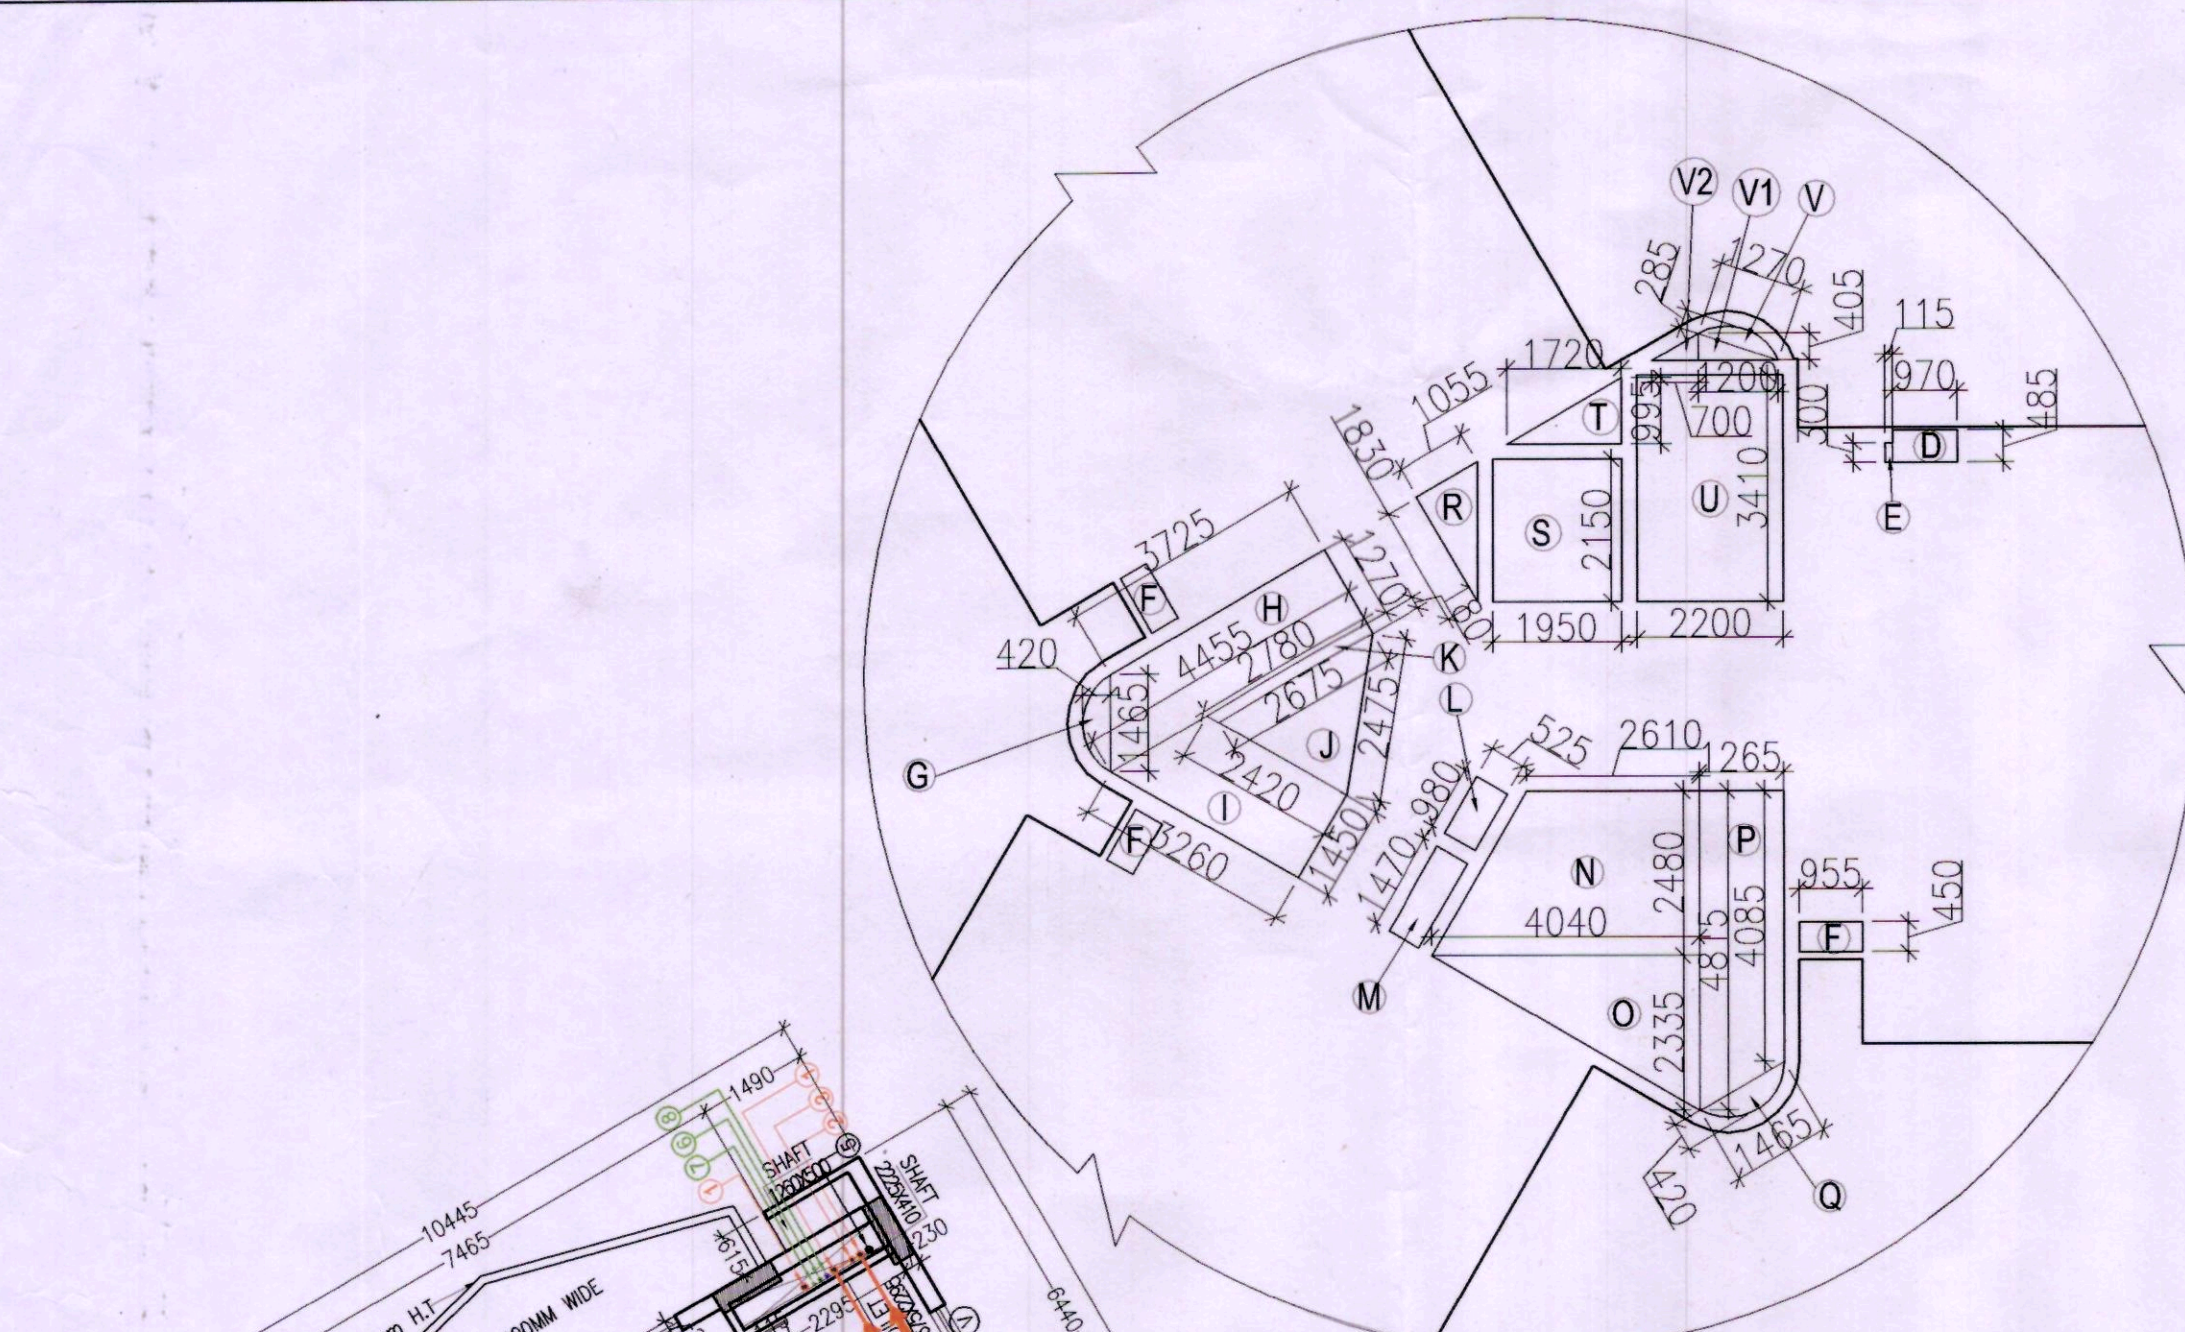

TYP. FLOOR DEDUCTION AREA
DIAGRAM 1ST TO 10TH FLOOR
AREA DIAGRAM
(TOWER - P, Q & R)

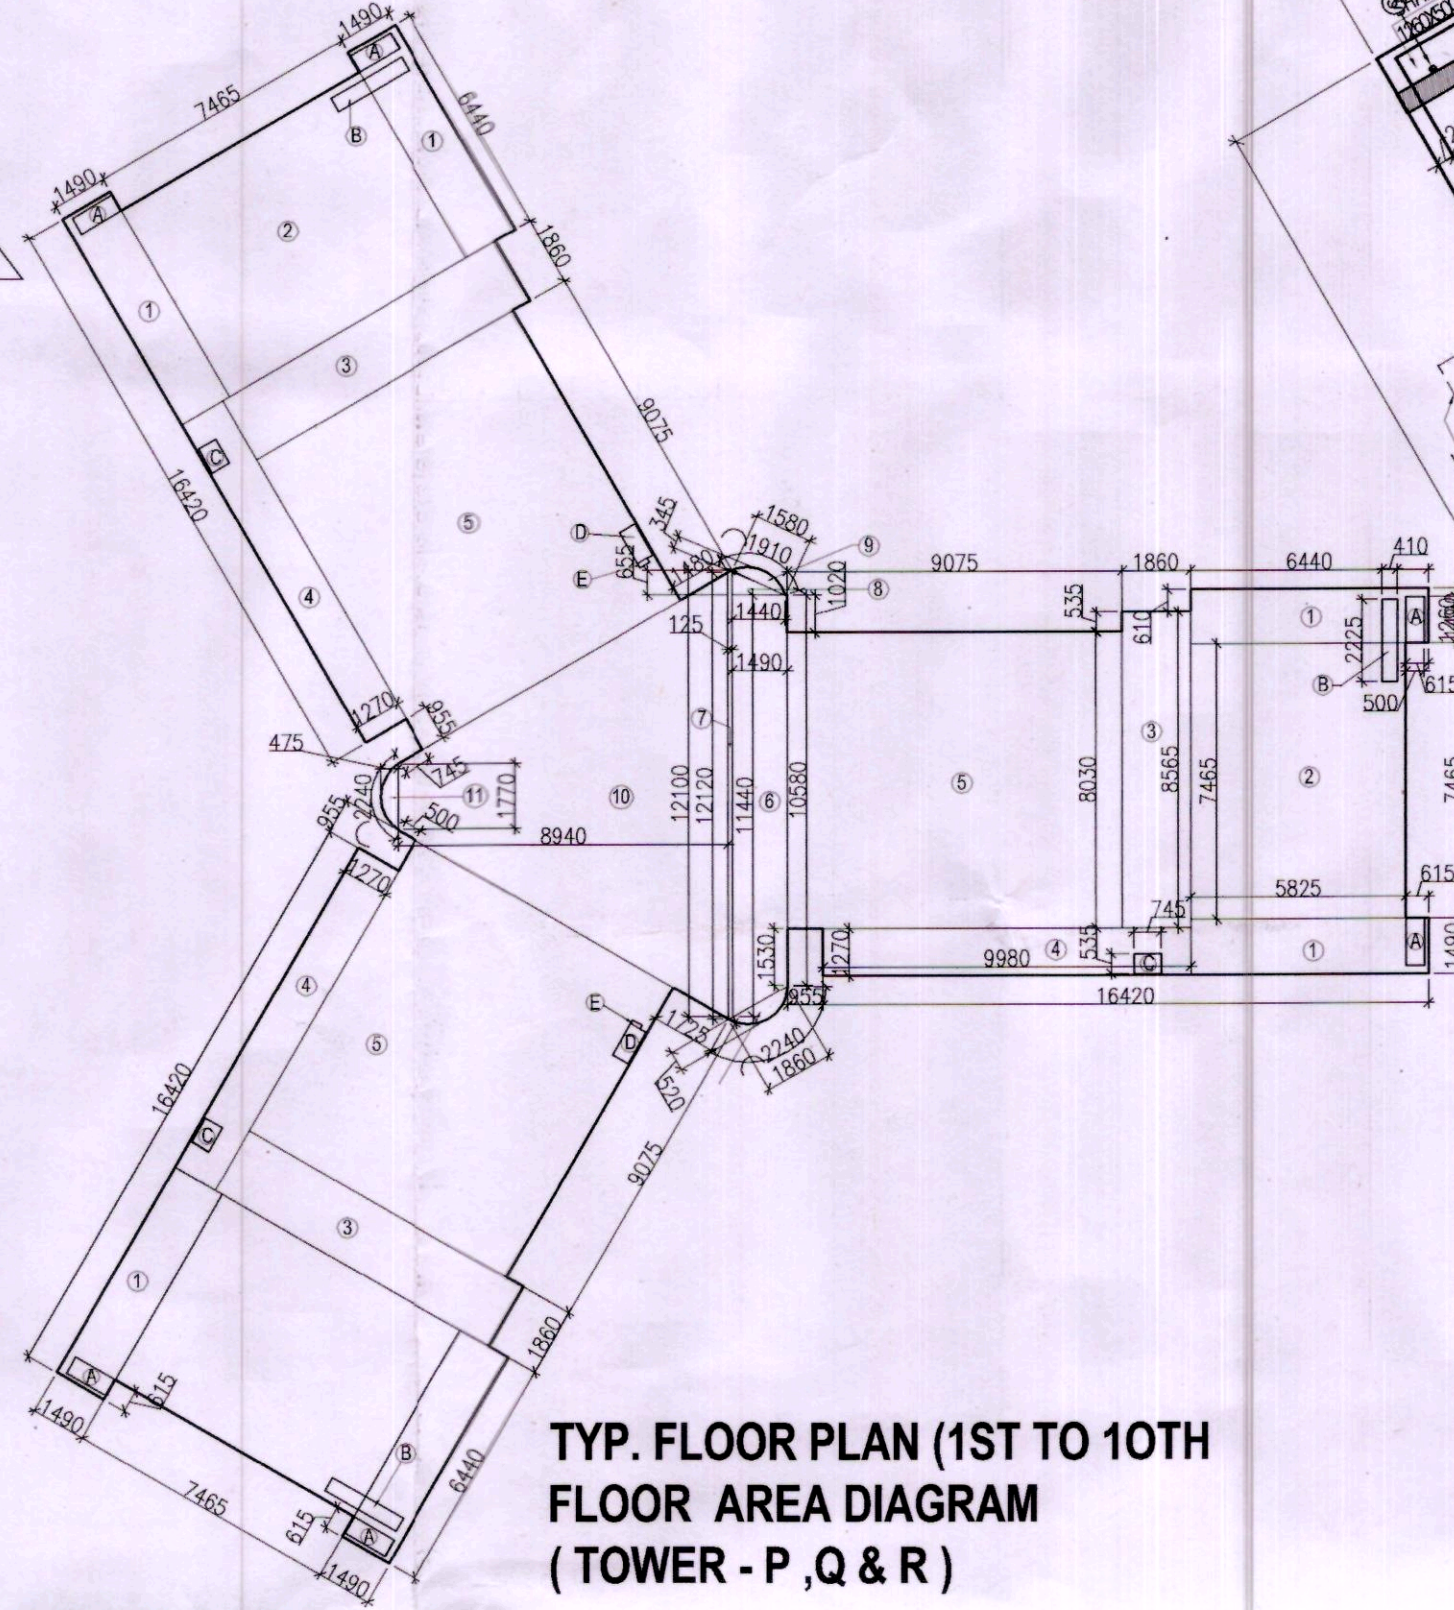

TYP. FLOOR PLAN (1ST TO 10TH
FLOOR AREA DIAGRAM
(TOWER - P, Q & R)

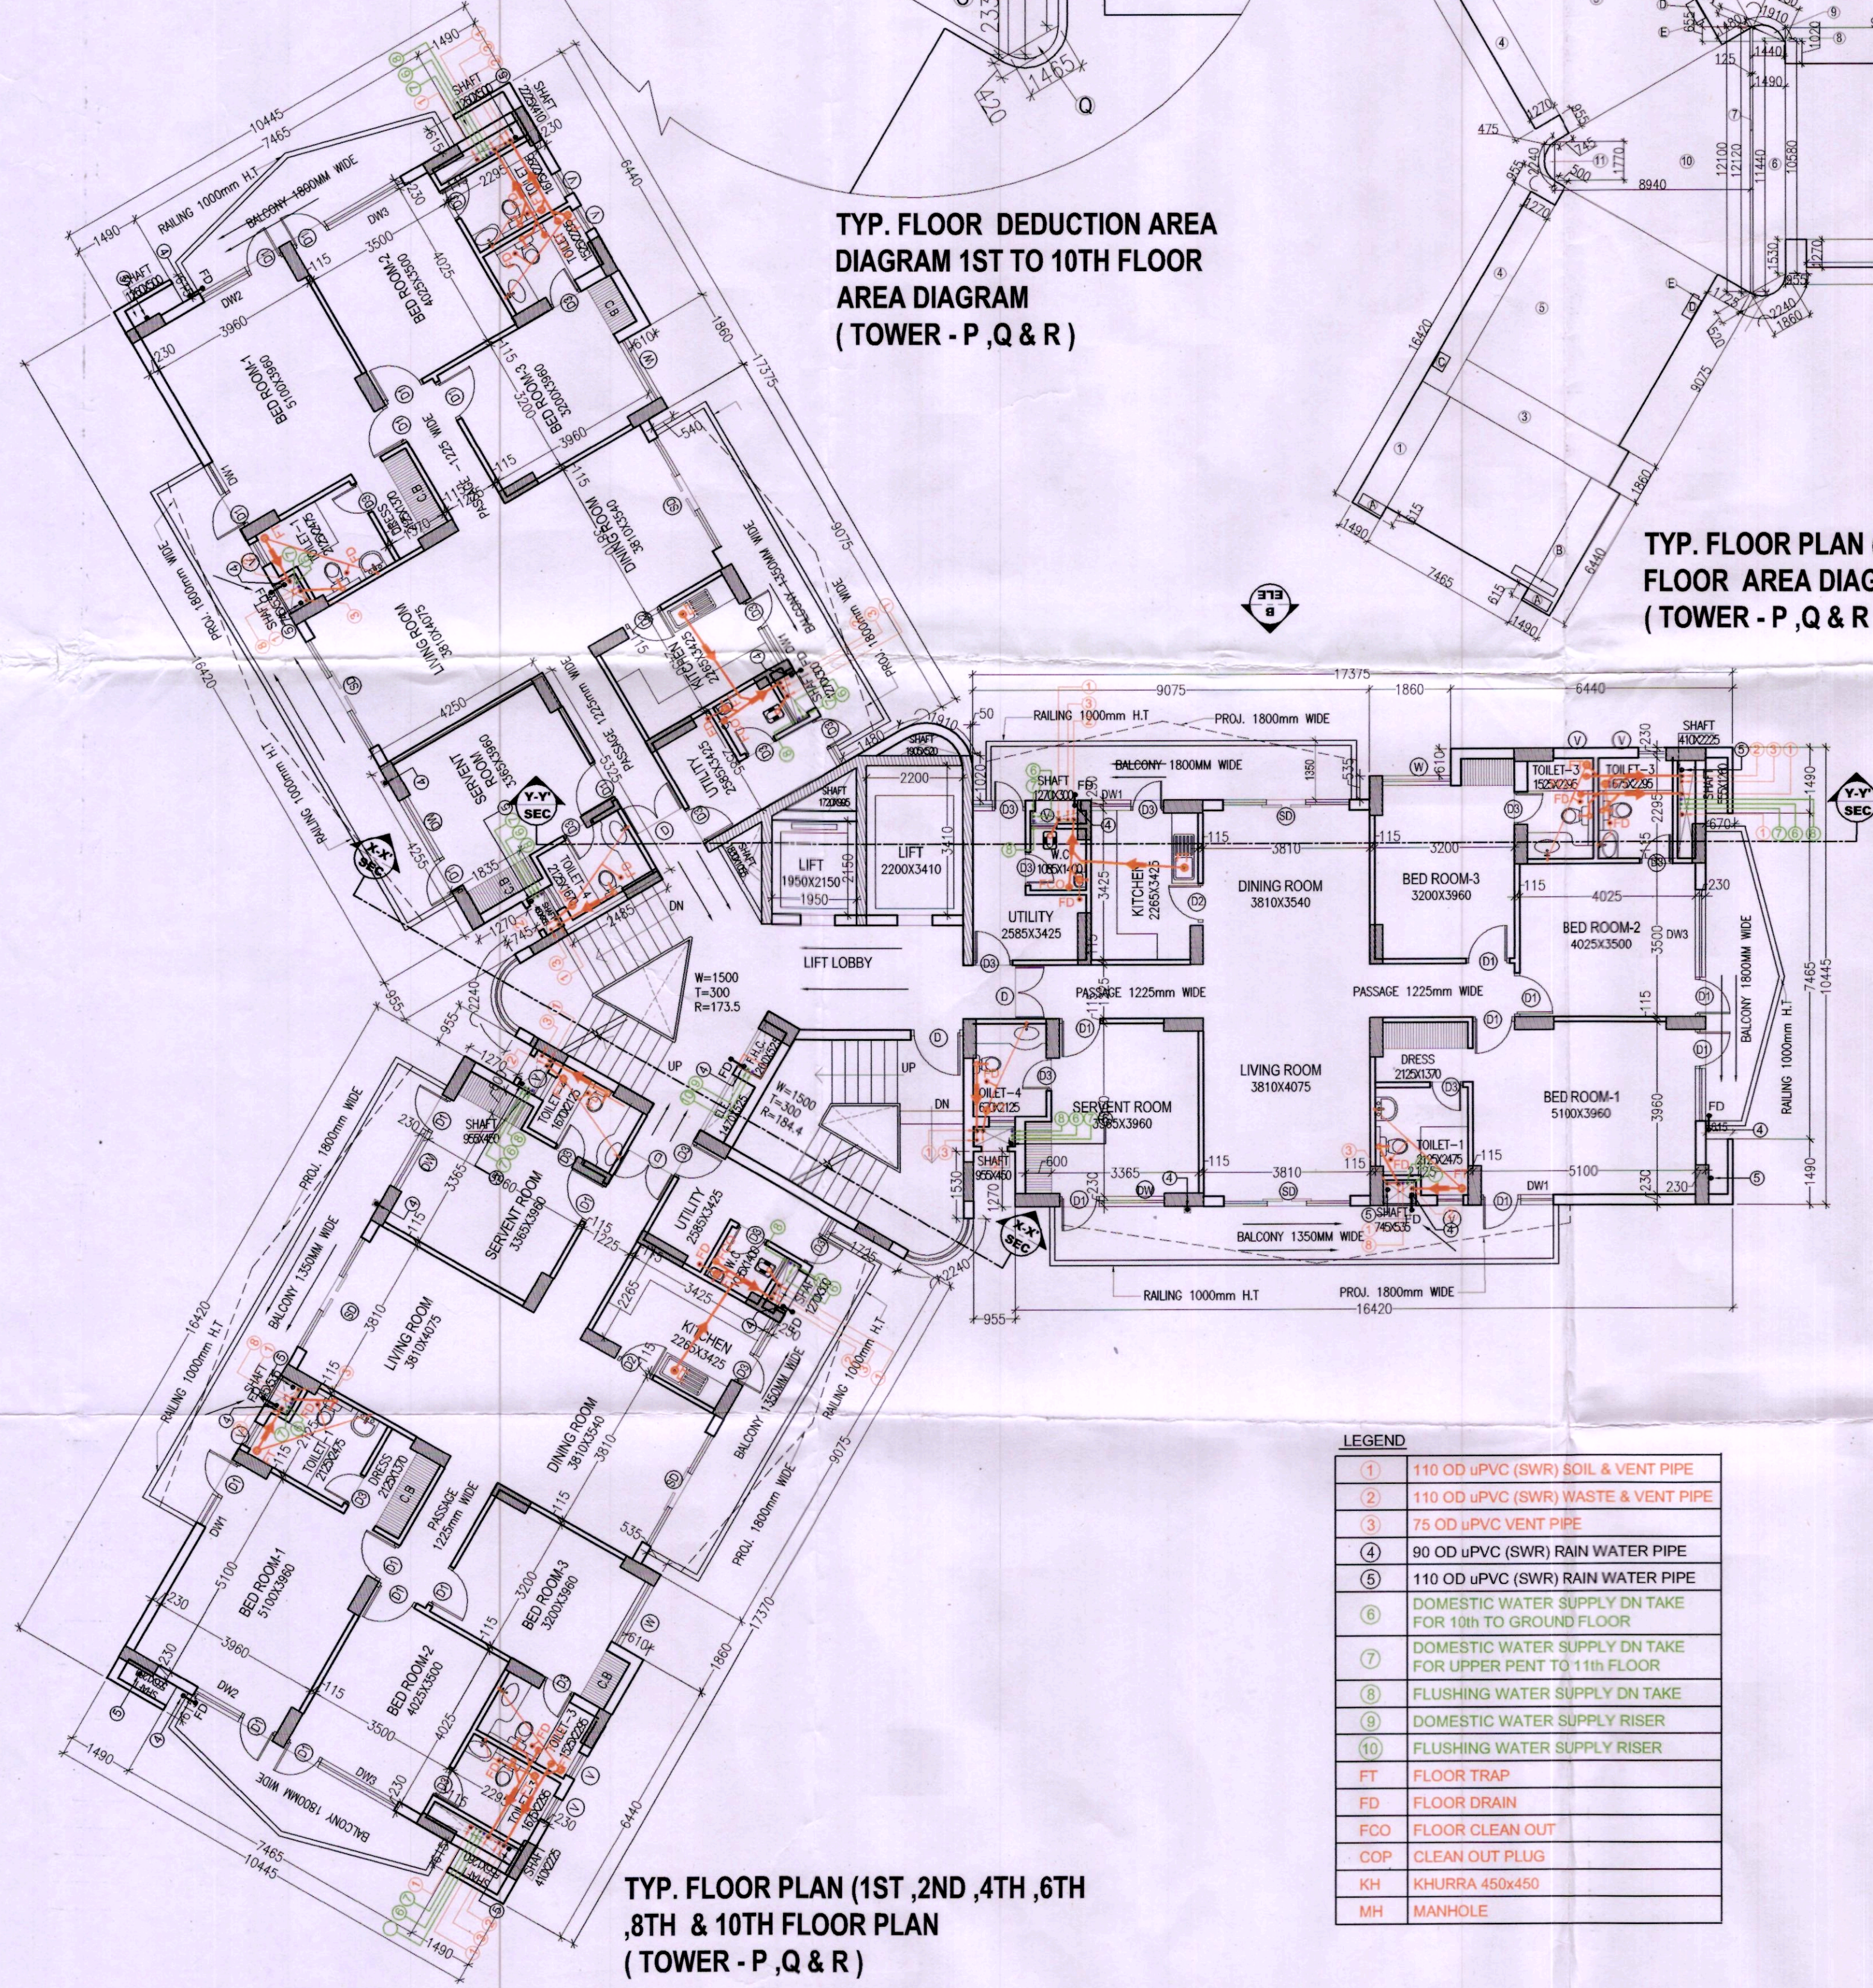


TYP. FLOOR PLAN (1ST, 2ND, 4TH, 6TH
, 8TH & 10TH FLOOR PLAN
(TOWER - P, Q & R)

LEGEND

①	110 OD uPVC (SWR) SOIL & VENT PIPE
②	110 OD uPVC (SWR) WASTE & VENT PIPE
③	75 OD uPVC VENT PIPE
④	90 OD uPVC (SWR) RAIN WATER PIPE
⑤	110 OD uPVC (SWR) RAIN WATER PIPE
⑥	DOMESTIC WATER SUPPLY DN TAKE FOR 10th TO GROUND FLOOR
⑦	DOMESTIC WATER SUPPLY DN TAKE FOR UPPER PENT TO 11th FLOOR
⑧	FLUSHING WATER SUPPLY DN TAKE
⑨	DOMESTIC WATER SUPPLY RISER
⑩	FLUSHING WATER SUPPLY RISER
FT	FLOOR TRAP
FD	FLOOR DRAIN
FCO	FLOOR CLEAN OUT
COP	CLEAN OUT PLUG
KH	KHURRA 450x450
MH	MANHOLE

TYP FLOOR PLAN (3TH, 5TH, 7TH & 9TH FLOOR PLAN
(TOWER - P, Q, R)

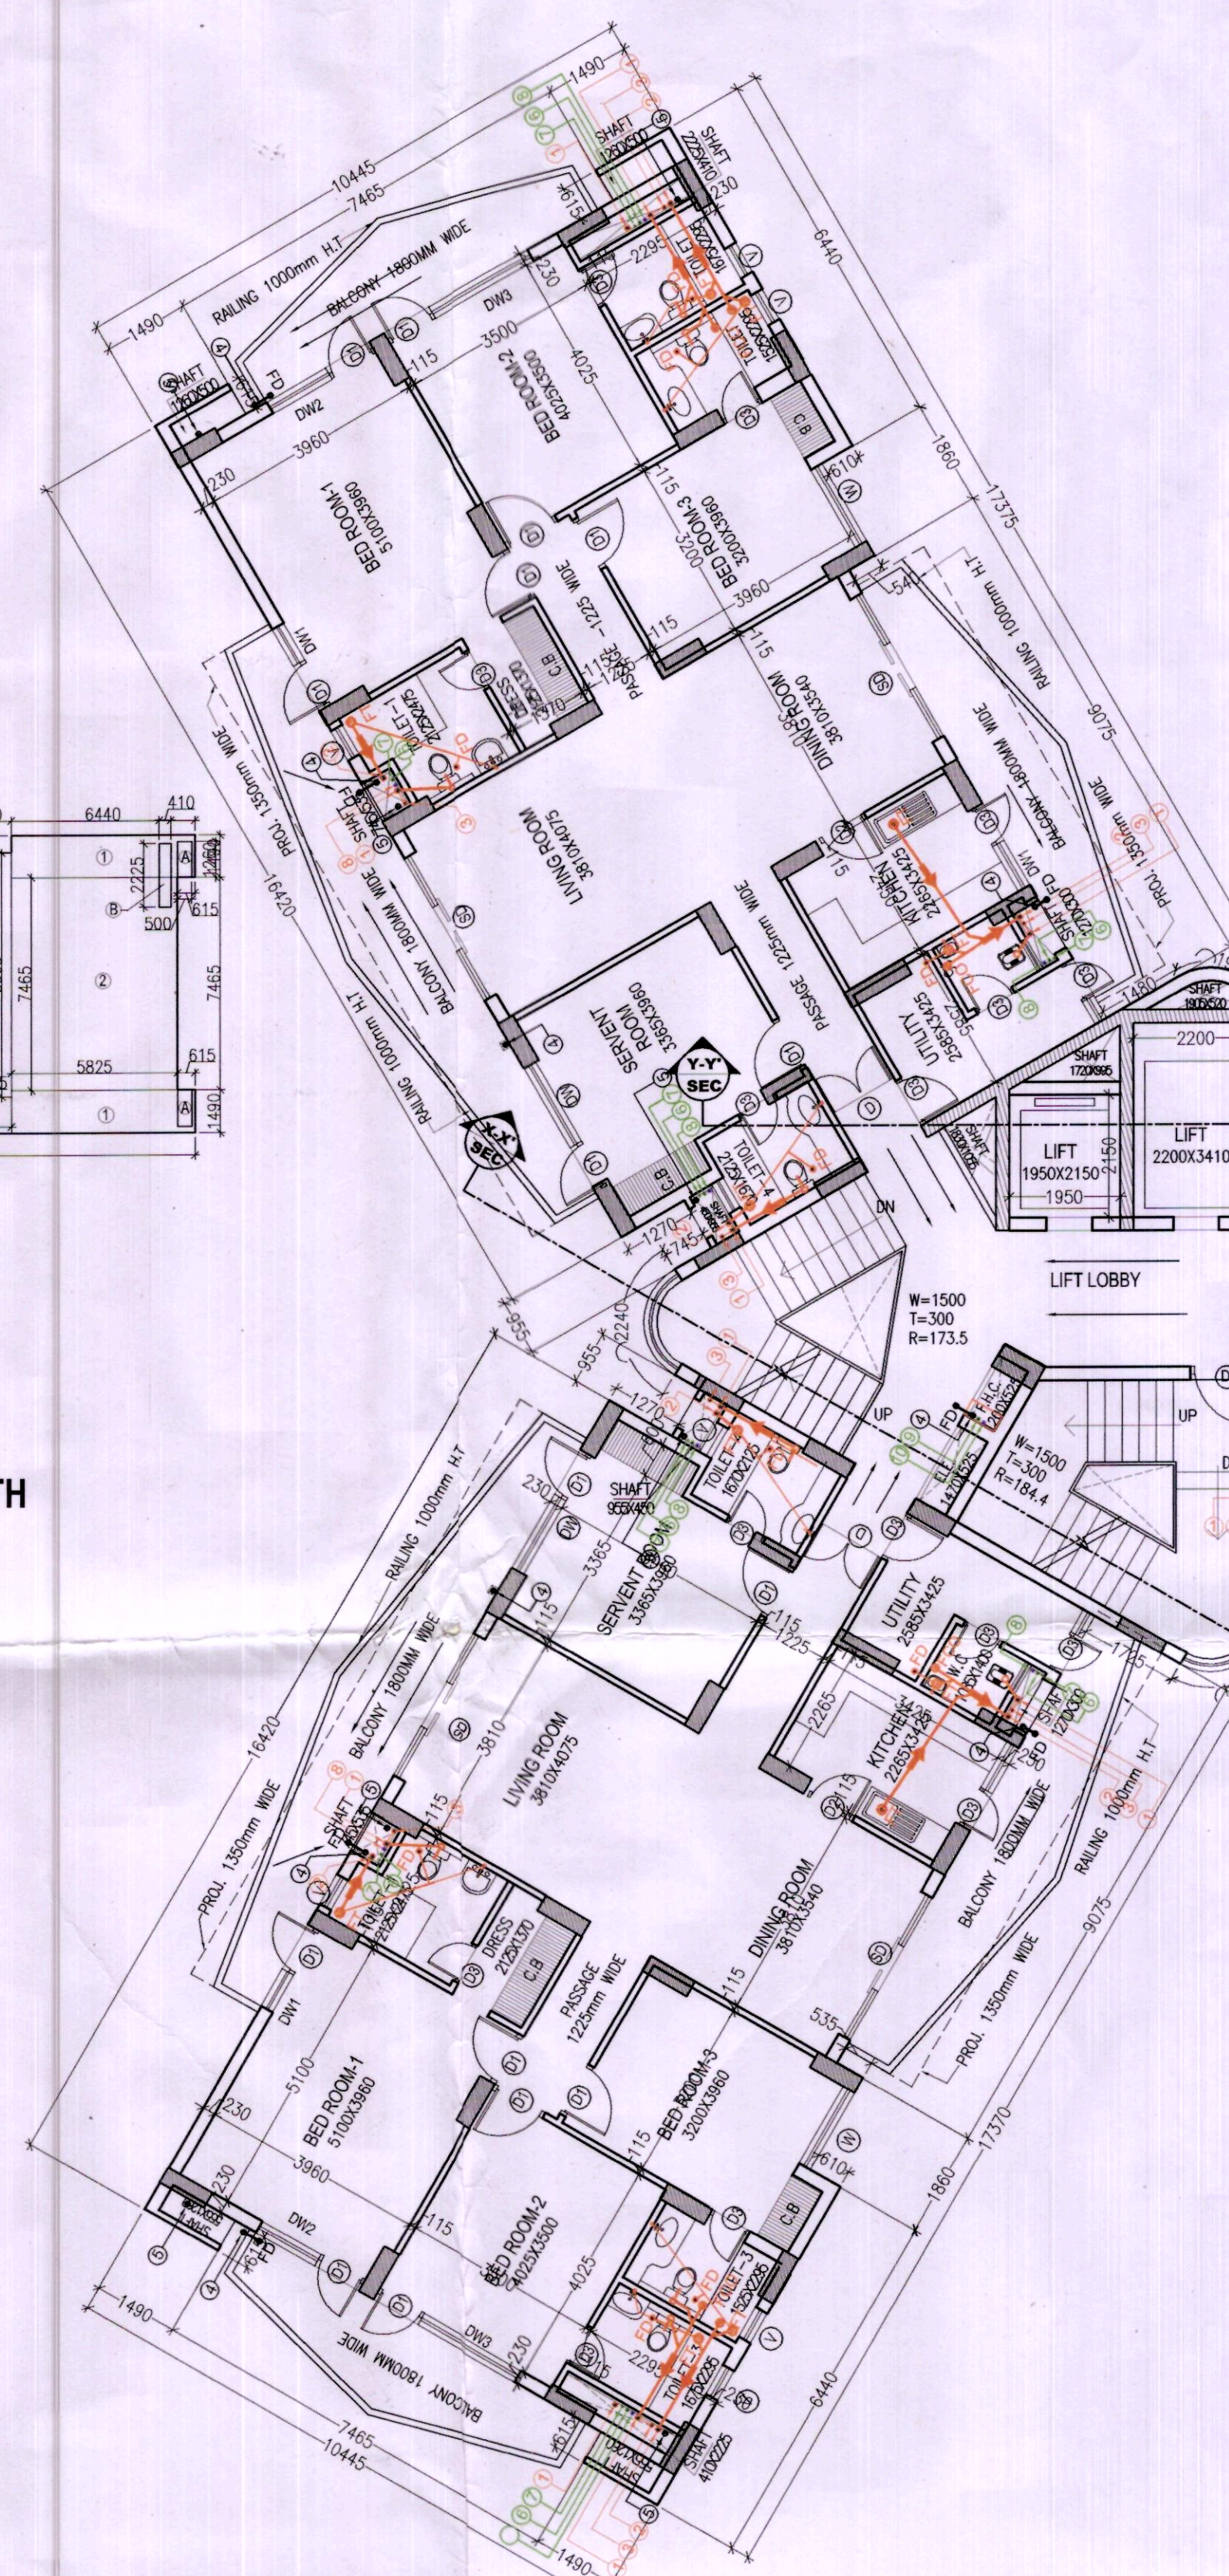

TYP. 1ST TO 10TH FLOOR AREA CALCULATION

PART	AREA CALCULATION	NO.	TOTAL AREA (SQMT.)
1	6.440 X 1.490 X 6	6	57.574
2	5.455 X 7.465 X 3	3	120.461
3	1.800 X 5.555 X 3	3	47.793
4	9.980 X 1.270 X 3	3	38.024
5	9.975 X 4.050 X 3	3	75.817
6	(11.440+10.590)/2 X 1.490 X 1	1	16.405
7	(12.120+12.590)/2 X 0.125 X 1	1	1.514
8	0.655 X 1.440 X 0.5	0.5	0.472
9	1.0500 X 3.35 X 1	1	3.514
10	12.120+1.702 X 8.940 X 1	1	62.088
11	1.70 X 8.475 X 1	1	0.561
12	1.800 X 0.520 X 1	1	0.65
TOTAL AREA			574.506
DEDUCTION			
A	0.500 X 1.200 X 6	6	3.782
B	0.430 X 2.225 X 3	3	2.737
C	0.745 X 0.535 X 3	3	1.196
D	0.970 X 0.485 X 3	3	1.411
E	0.115 X 0.930 X 3	3	0.104
F	0.955 X 0.450 X 3	3	1.289
G	1.465 X 1.420 X 1	1	0.432
H	4.454+3.725/2 X 1.270 X 1	1	5.194
I	3.200+2.420/2 X 1.450 X 1	1	4.118
J	3.470+2.475 X 1.000 X 1	1	2.975
K	(2.780+2.675)/2 X 0.180 X 1	1	0.491
L	0.525 X 0.980 X 1	1	0.515
M	0.525 X 1.470 X 1	1	0.771
N	4.000+2.510/2 X 2.480 X 1	1	6.245
O	0.50 X 2.335 X 1	1	4.717
P	1.205 X 4.815+4.082/2 X 1.205 X 1	1	4.629
Q	0.667 X 1.405 X 1	1	0.430
R	0.5 X 1.800 X 1	1	0.900
S	1.950 X 2.150 X 1	1	4.193
T	0.5 X 1.720 X 1	1	0.865
U	2.200 X 3.480 X 1	1	7.560
V	0.667 X 1.230 X 1	1	0.341
V1	0.50 X 1.300 X 1	1	0.243
V2	1 X 0.700 X 1	1	0.142
TOTAL AREA			574.506 - 57.736 = 516.770

Architect (HQ)
Checked and found ok for Public Health (Internal) Services only subject to comments in forwarding letter No. SE(HQ) dated 17/09/17
Superintending Engineer (HQ) HUDA, Panchajitra
(BALWANT SINGH) S.D.
17/9/17
(RAMA/TAR BASI)

- NOTES:-
- ALL DIMENSIONS IN MM.
 - LIFT SHALL BE WITH 100% POWER BACKUP.

PROJECT:-
REVISED BUILDING PLAN OF
GROUP HOUSING SCHEME LAND
MEASURING 15.575 ACRES
(LICENCE NO.71 OF 2008 DATED
25.03.2008) IN SECTOR - 91,
GURGAON MANESAR URBAN
COMPLEX BEING DEVELOPED BY
M/S JUBILANT SOFTWARES
SERVICES PVT. LTD.

ARCHITECT:-
GIAN P. MATHUR AND ASSOCIATES (P) LTD.
C - 55, East Of Kailash, New Delhi-110065
T: 011-46599599 / F: 011-46599512
E: gpma@airtelmail.in / W: www.gpmindia.com

OWNERS SIGNATURE:-
ARCHITECT SIGNATURE:-
GIAN P. MATHUR
ARCHITECT
B. Arch. M.C.A. I.I.A.
CANO. 8015769

DRAWING TITLE:-
TYP FLOOR PLANS & AREA CALCUL.
(TOWERS - P, Q & R)

DATE:- JULY-2017
SCALE:- 1:100
SHEET NO. 16

SCHEDULE OF DOOR WINDOW OPENINGS

S.NO.	TYPE	WIDTH	HEIGHT	CILL	LINTEL	LOCATION
1.	DW3	1800	2300	150	2450	LIFT LOBBY
2.	FD1	1500	2300	150	2450	FIRE STAIRCASE
3.	SHD1	750	2350	100	2450	SHAFTS
4.	SHD2	640	2350	100	2450	SHAFTS
5.	W1a	1670	2200	100	2300	LIFT LOBBY
6.	W1	1800	2600	REF.	STAIR SEC	STAIRCASES