




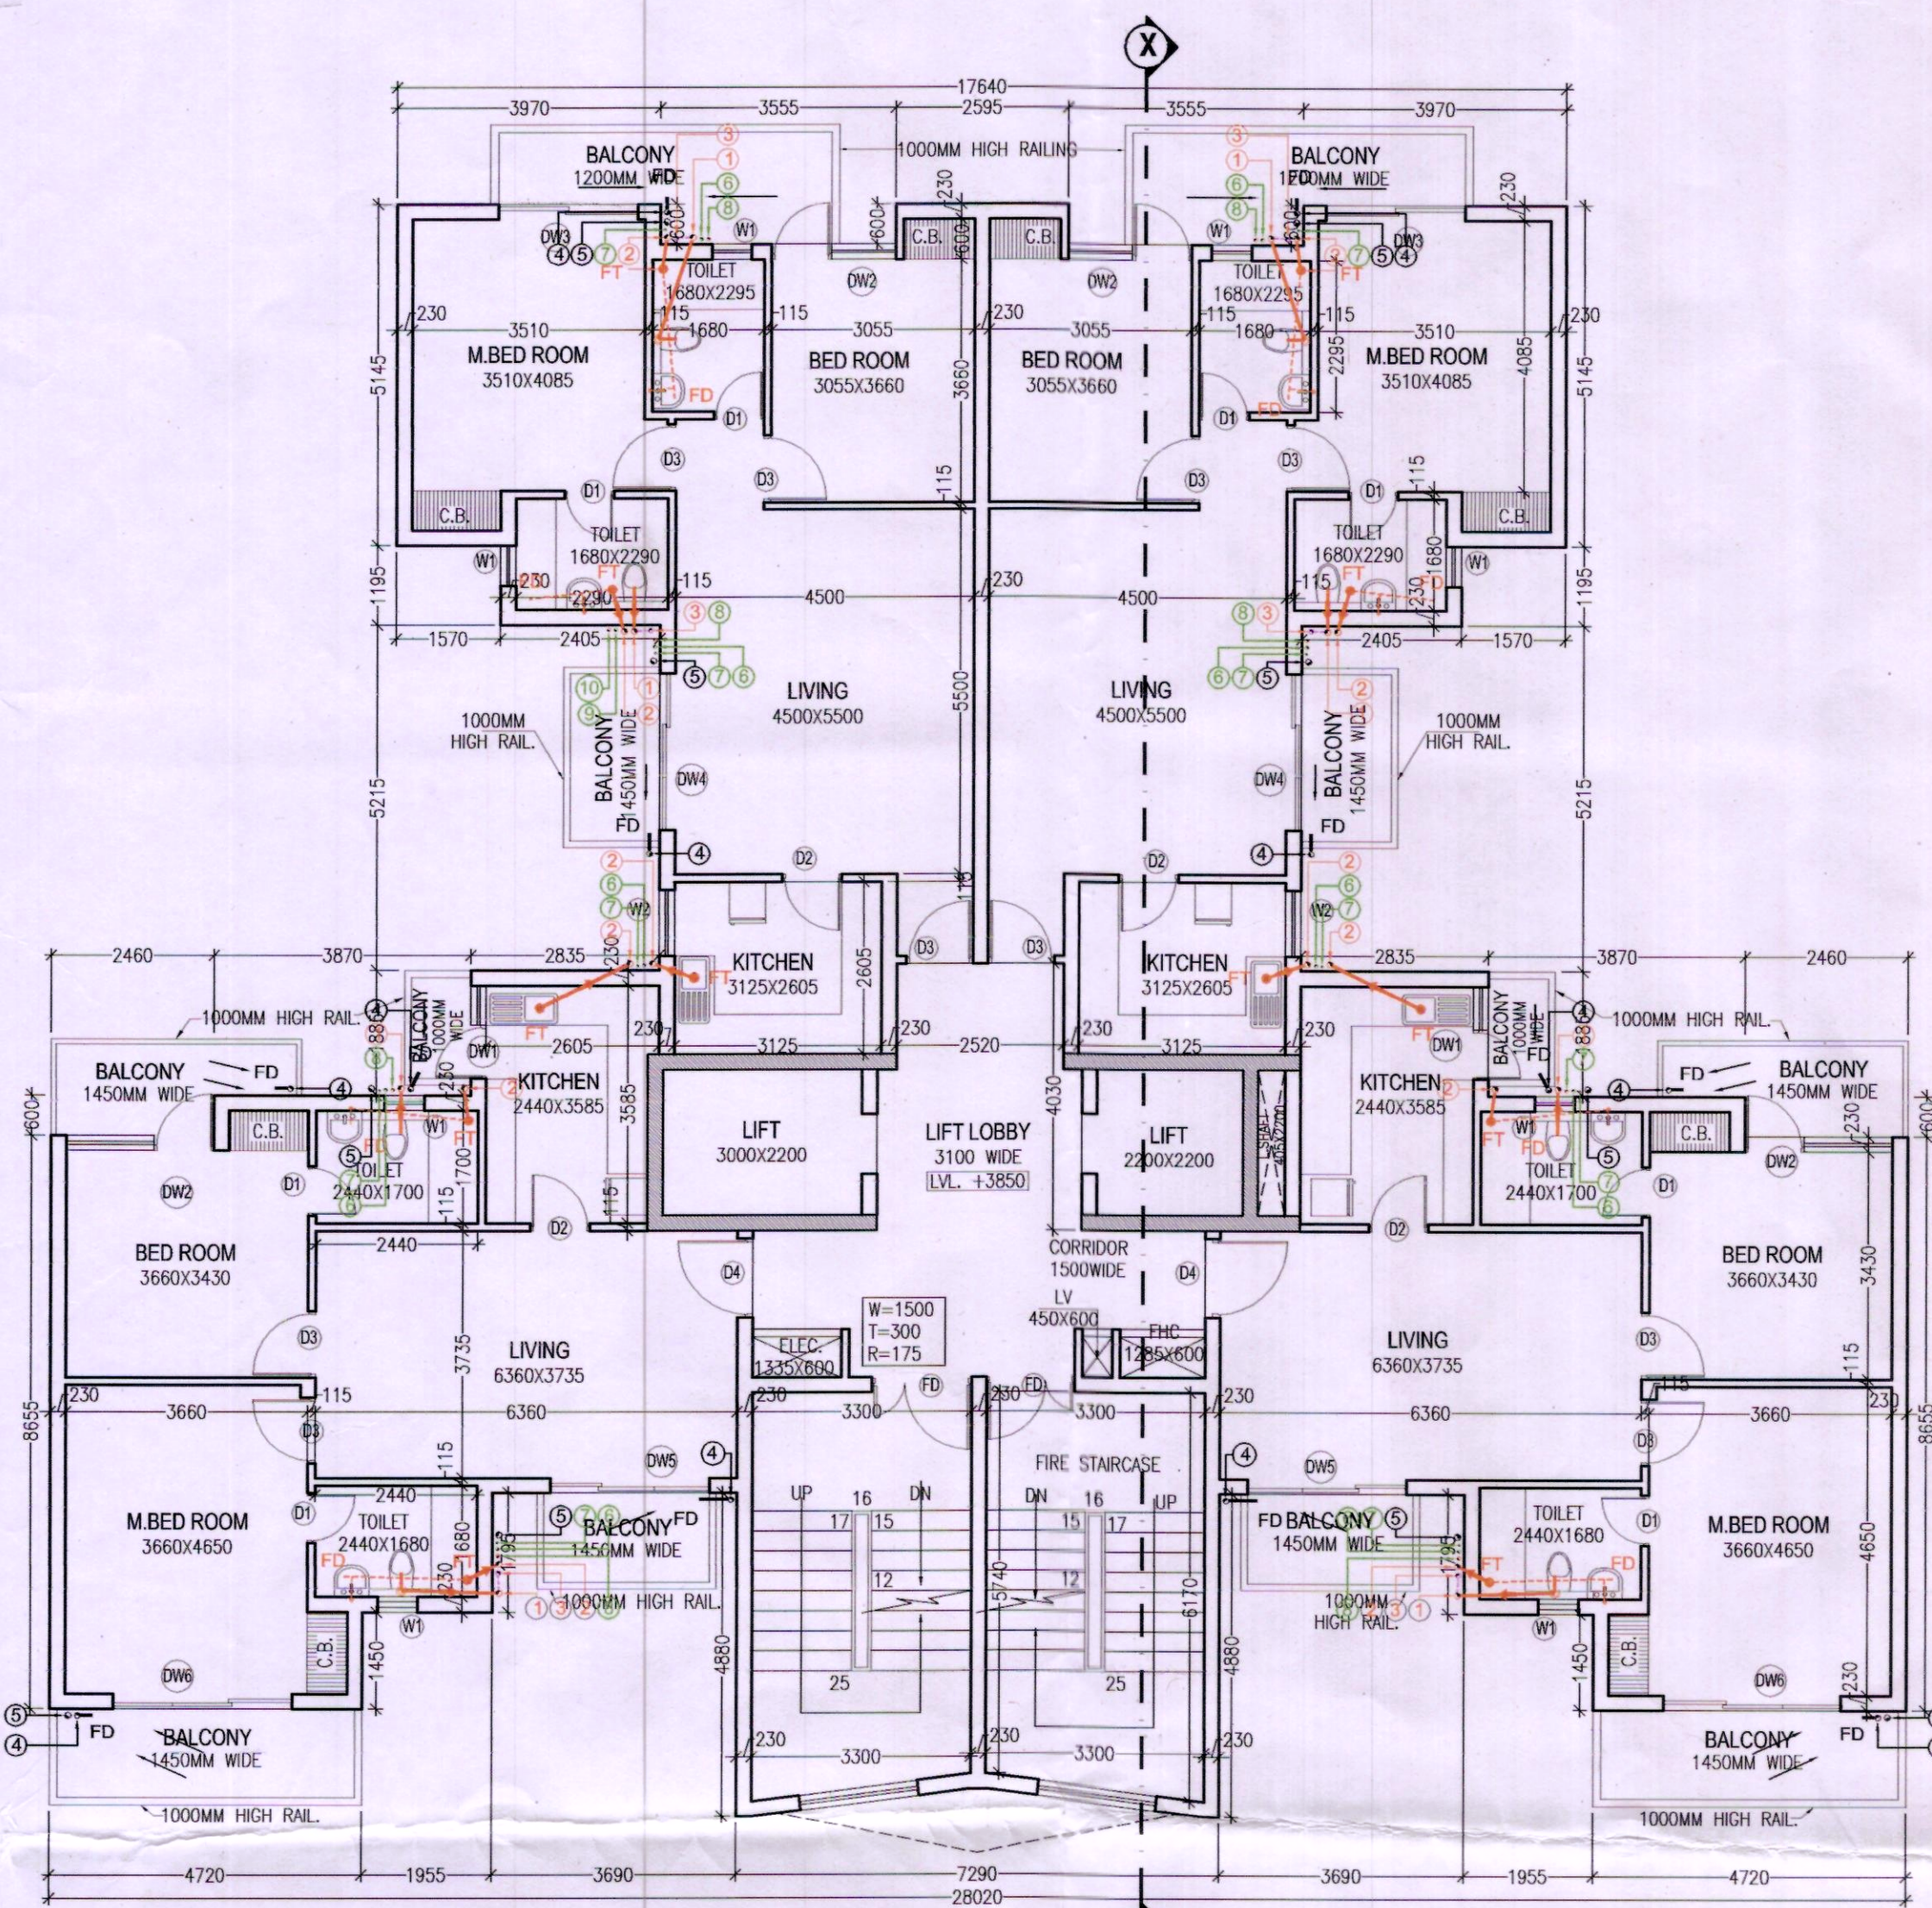

TYPICAL FLOOR PLAN (1,2,4,6,8,10 & 12TH FLOOR) (TOWER - J, K, L, M & N)

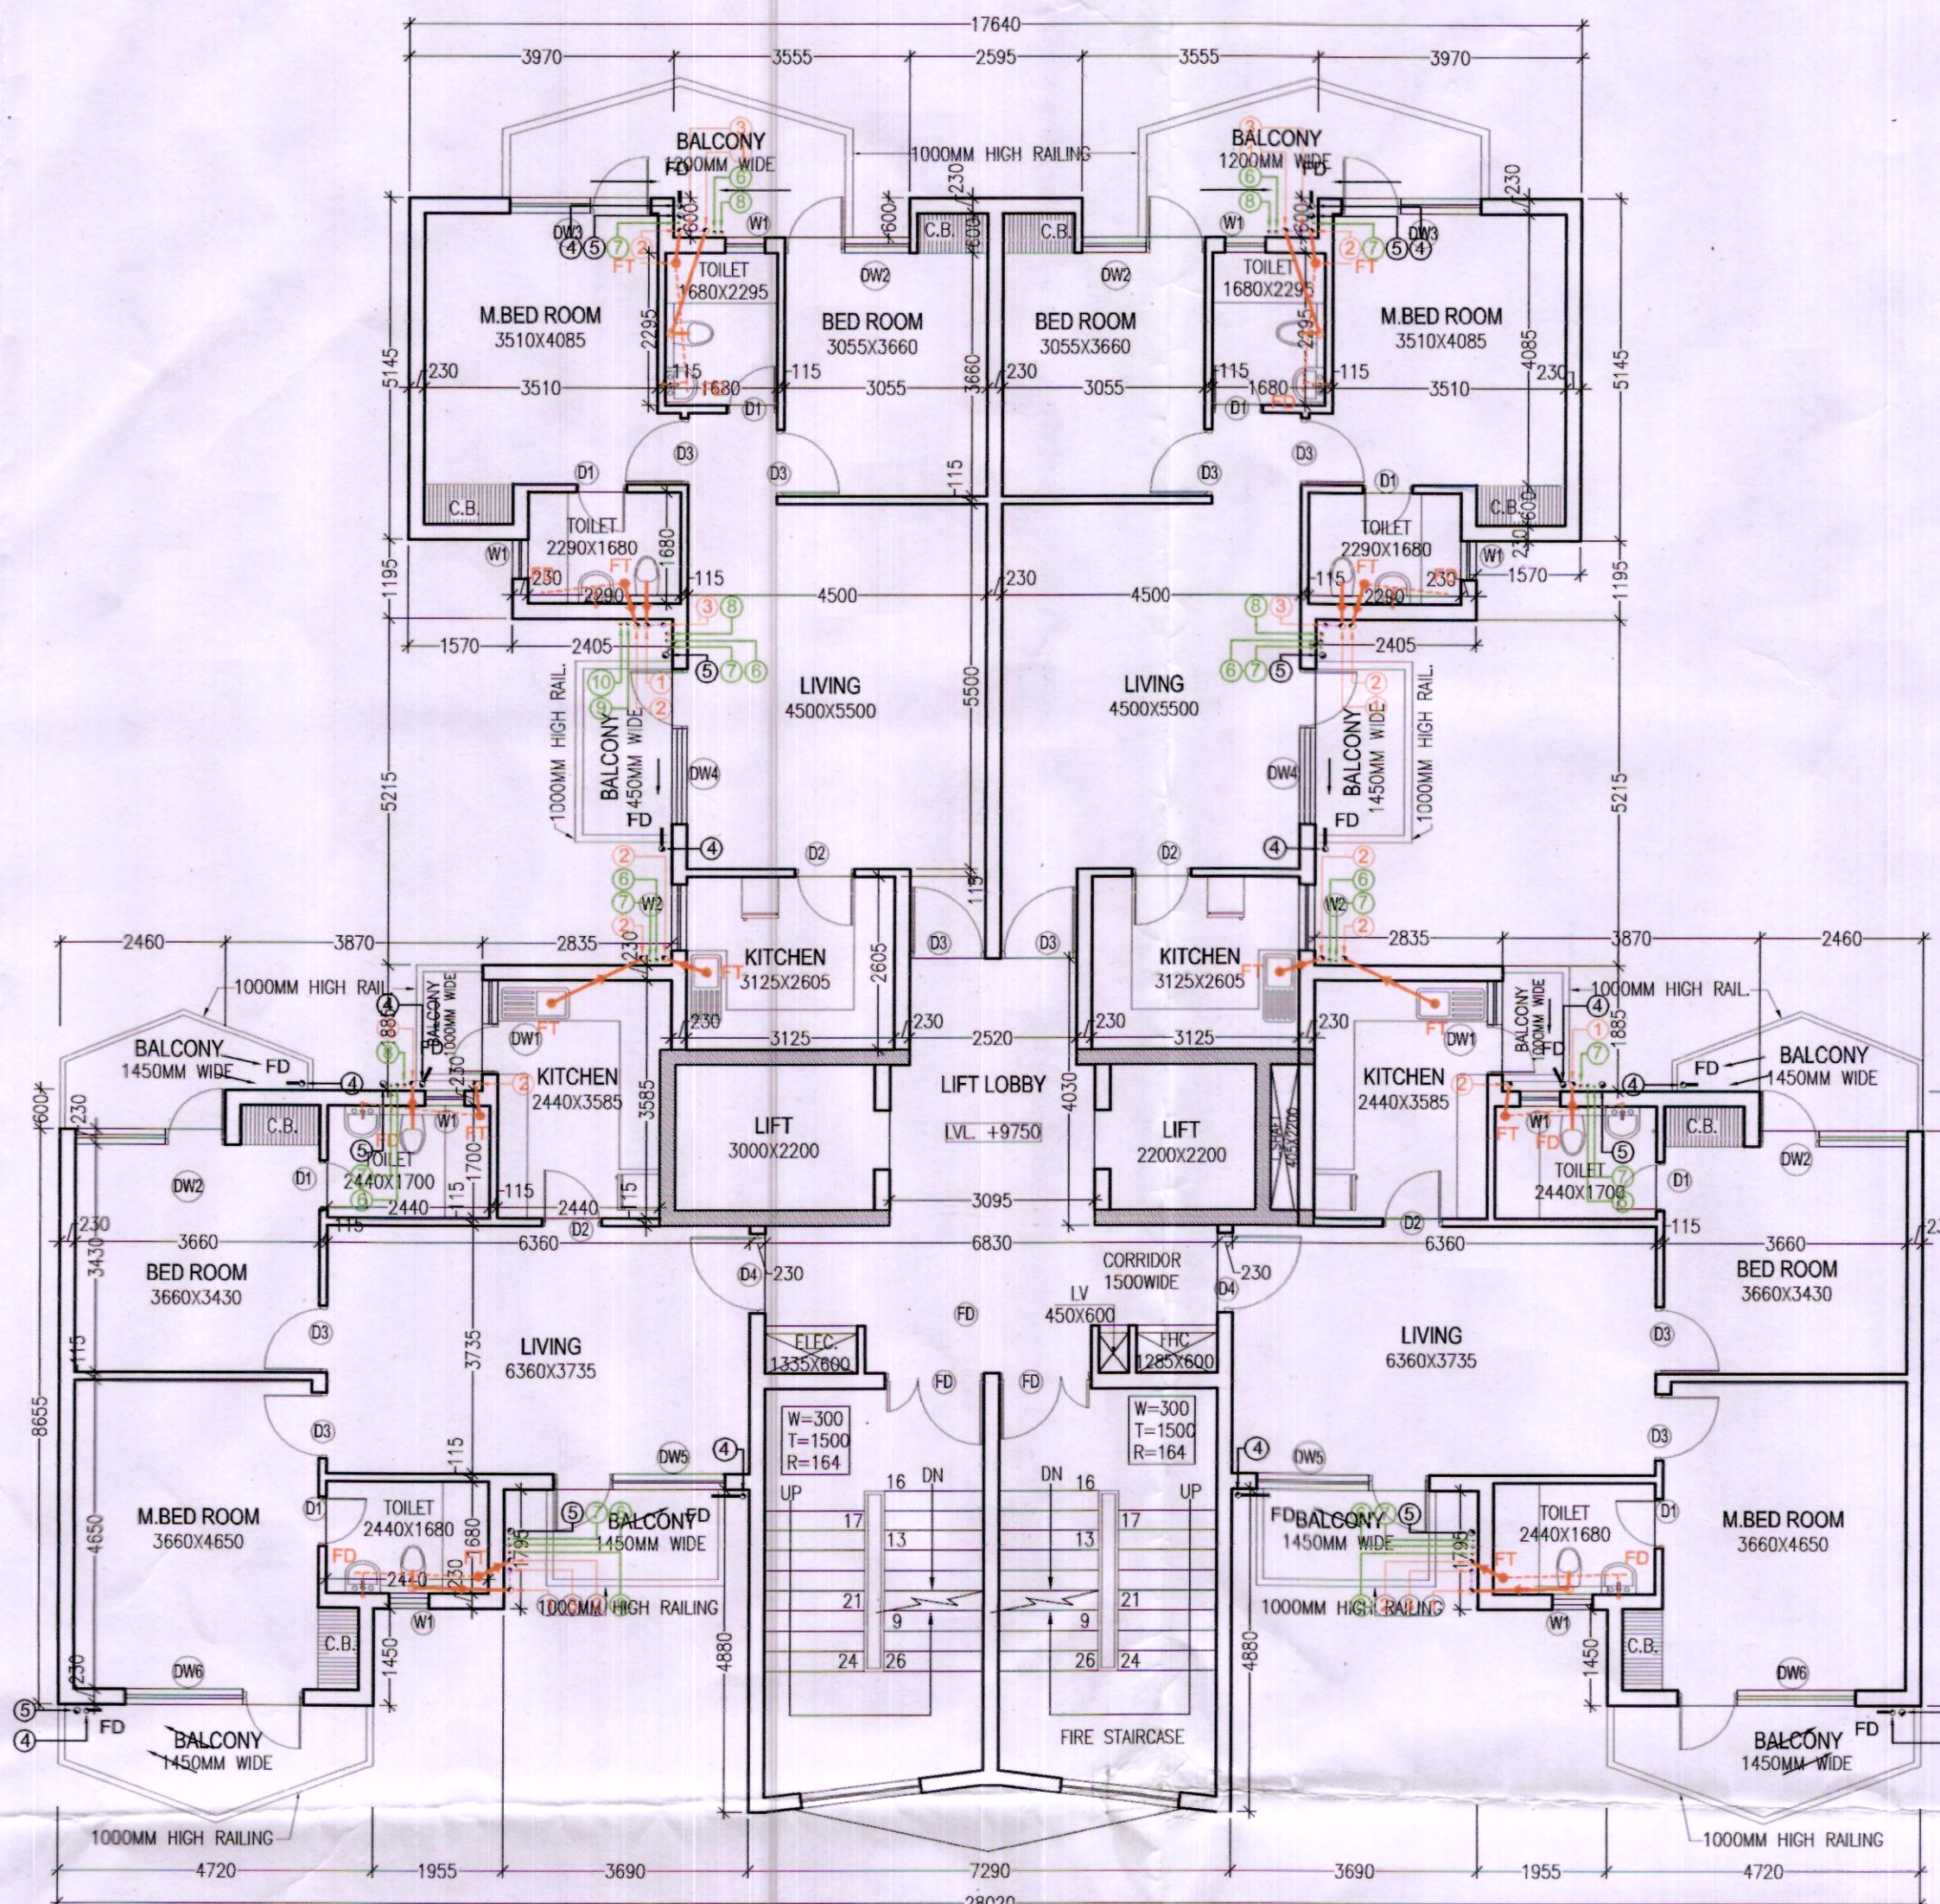

TYPICAL FLOOR PLAN (3,5,7,9,11, & 13TH FLOOR) (TOWER J, K, L, M & N)

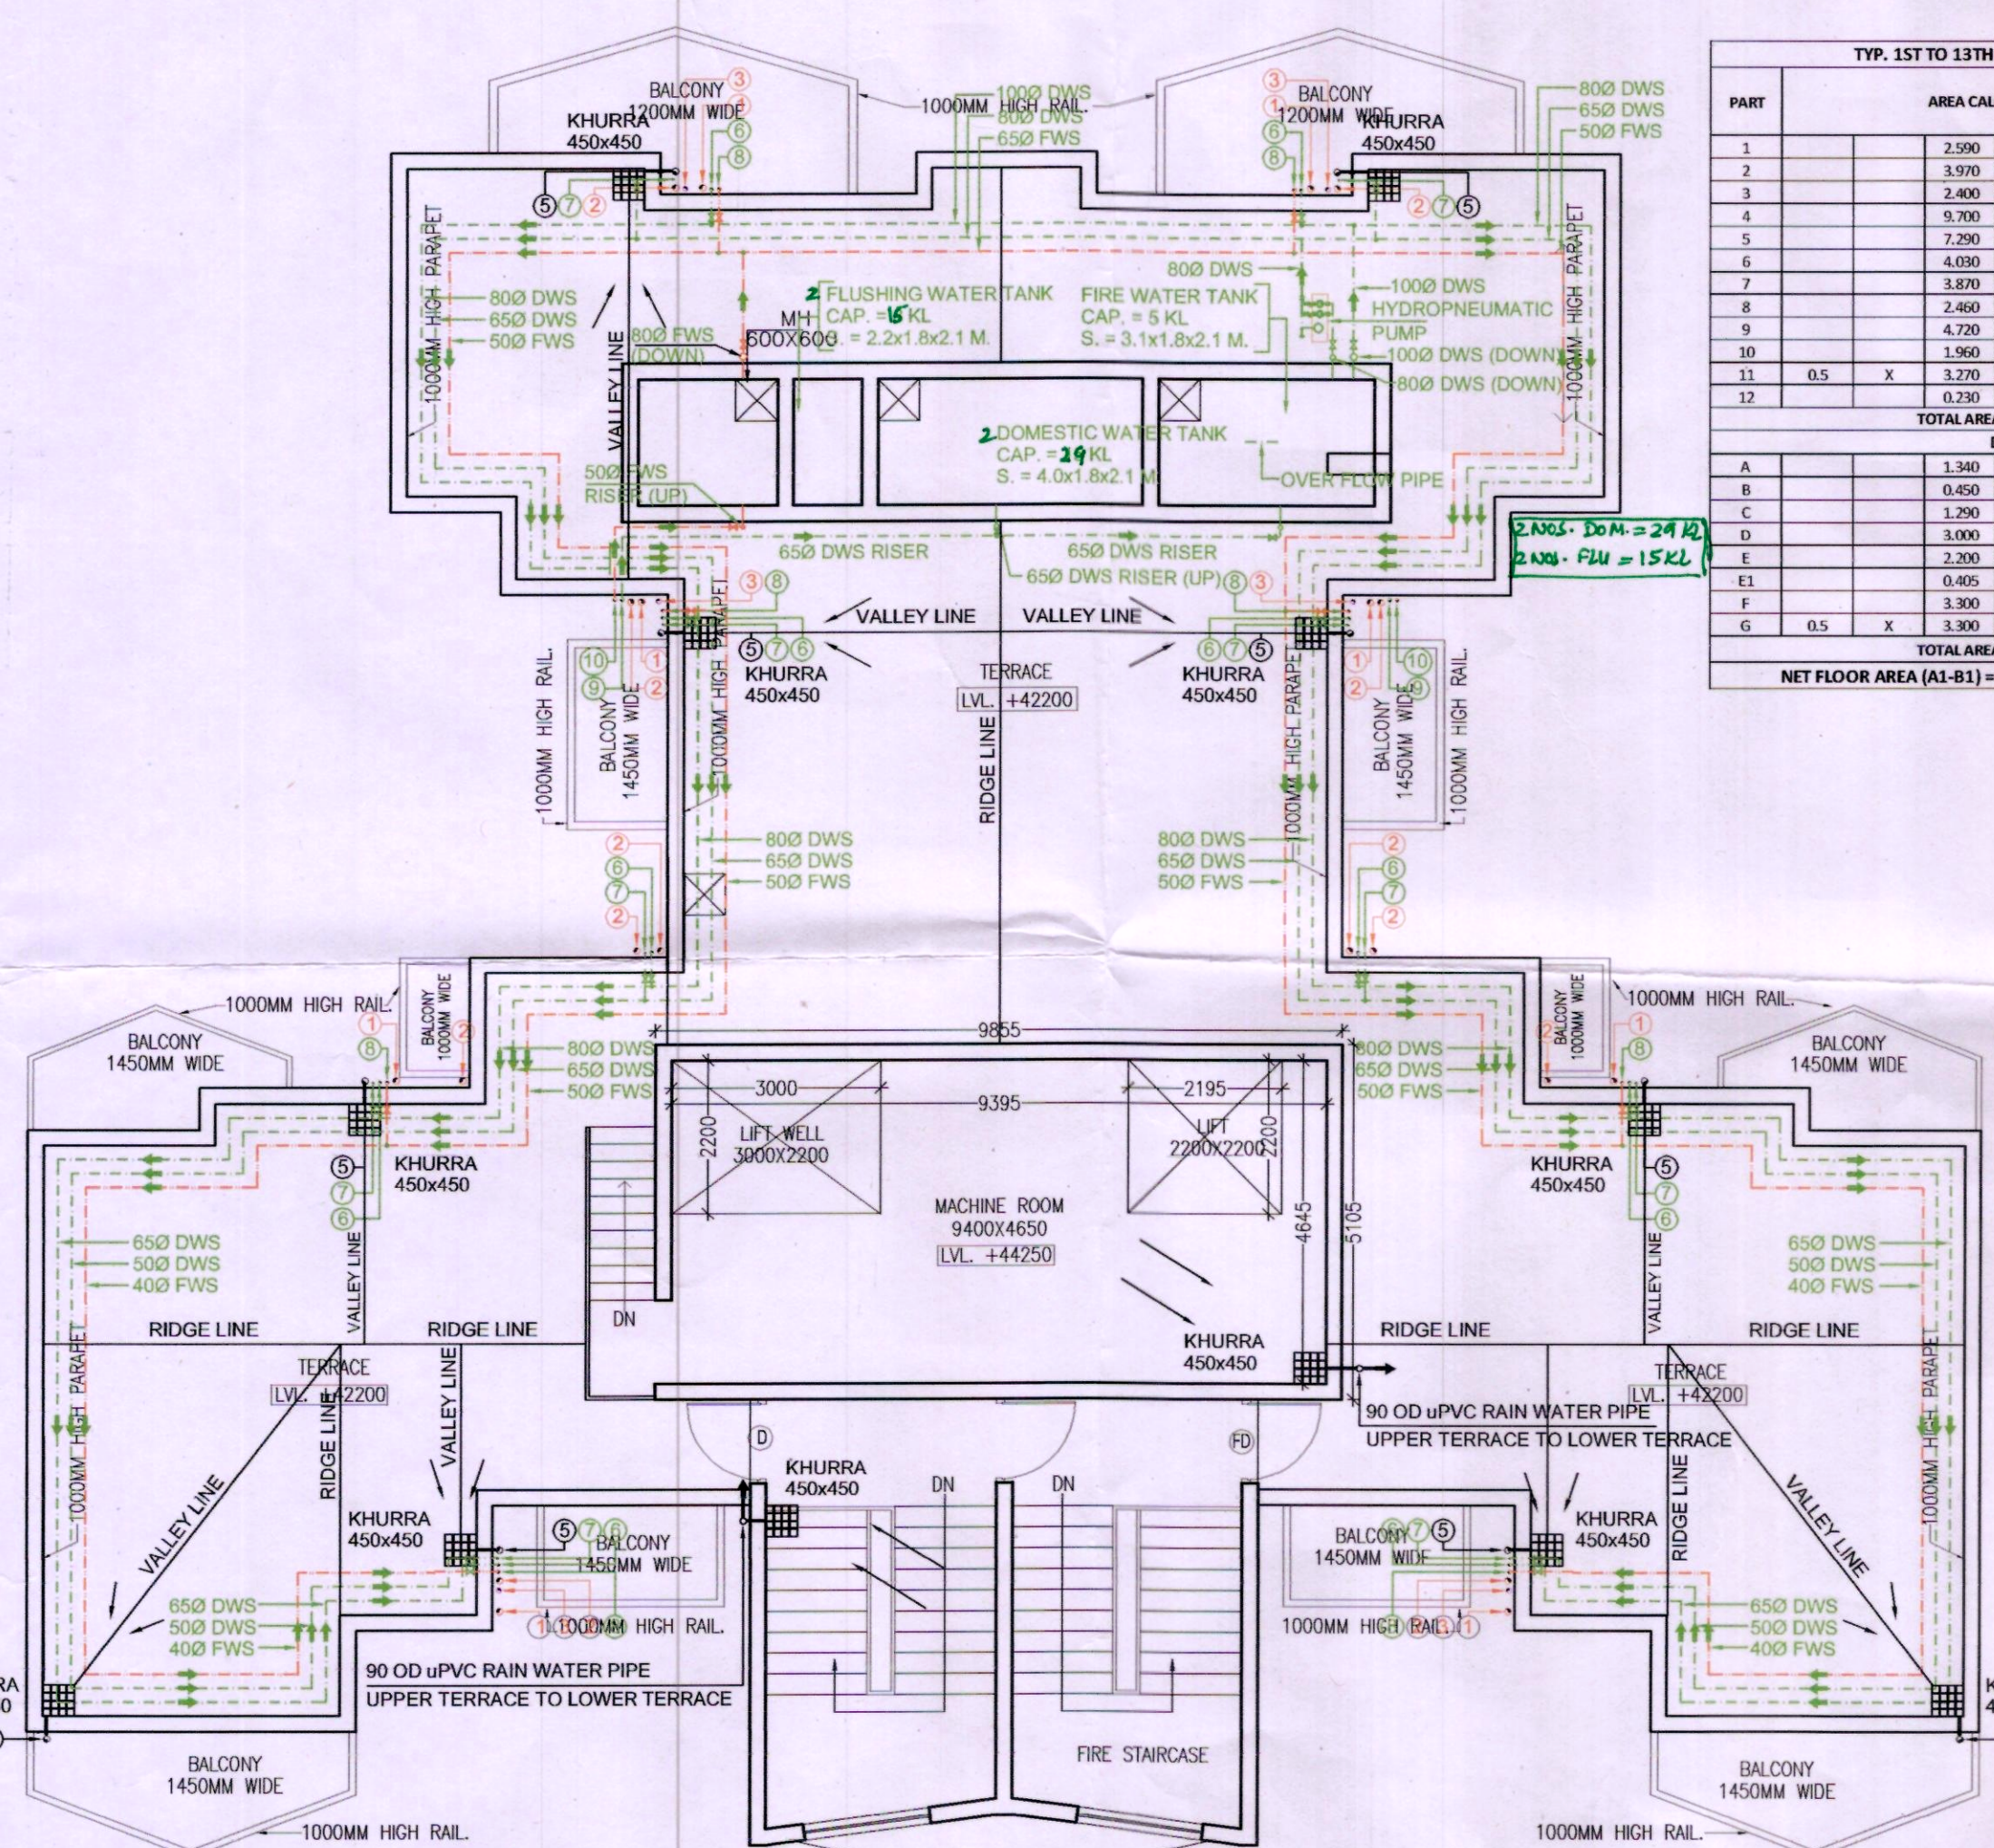

TERRACE PLAN (TOWER J, K, L, M & N)


PART	AREA CALCULATION	NO.	TOTAL AREA (SQM)
1	2590 X 0.000 X 1	1	2590
2	3970 X 5.150 X 2	2	40890
3	2460 X 1.300 X 2	2	6396
4	9790 X 30.950 X 1	1	301312
5	7290 X 12.850 X 1	1	93633
6	4090 X 7.900 X 2	2	64818
7	3670 X 6.000 X 2	2	44040
8	2460 X 5.410 X 2	2	26617
9	4720 X 3.240 X 2	2	30588
10	1960 X 1.800 X 2	2	7056
11	3270 X 0.430 X 2	2	1405
12	0.230 X 0.430 X 2	2	0.198
TOTAL AREA			420.603
DEDUCTION			
A	1.340 X 0.000 X 1	1	0.000
B	0.000 X 0.000 X 1	1	0.000
C	1.290 X 0.000 X 1	1	0.000
D	3.000 X 2.200 X 1	1	6.600
E	2.200 X 2.200 X 1	1	4.840
F	0.400 X 2.200 X 1	1	0.880
G	3.900 X 5.740 X 2	2	44.880
H	3.300 X 0.430 X 2	2	2.838
TOTAL AREA			52.785
NET FLOOR AREA (A1-B1) = 420.603 - 52.785			367.817

FLOOR	NO. OF FLOOR	UNIT	TOTAL
GROUND FLOOR	1	X 3	= 3
TYP. 1,2,4,6,8,10 & 12	7	X 4	= 28
TYP. 3,5,7,9,11 & 13	6	X 4	= 24
TOTAL UNITS			= 55


NO.	COEFF.	BREADTH	LENGTH	NO. S	AREA (SQ.M)
1	6.400	5.975	2	3.460	43.189
2	1	0.300	5.975	1	1.795
3	1	0.300	5.105	1	1.531
TOTAL ADDITIONS (A1)					46.515

FLOOR	NO. OF FLOOR	UNIT	TOTAL
GROUND FLOOR	1	X 3	= 3
TYP. 1,2,4,6,8,10 & 12	7	X 4	= 28
TYP. 3,5,7,9,11 & 13	6	X 4	= 24
TOTAL UNITS			= 55


FLOOR	NO. OF FLOOR	UNIT	TOTAL
GROUND FLOOR	1	X 3	= 3
TYP. 1,2,4,6,8,10 & 12	7	X 4	= 28
TYP. 3,5,7,9,11 & 13	6	X 4	= 24
TOTAL UNITS			= 55

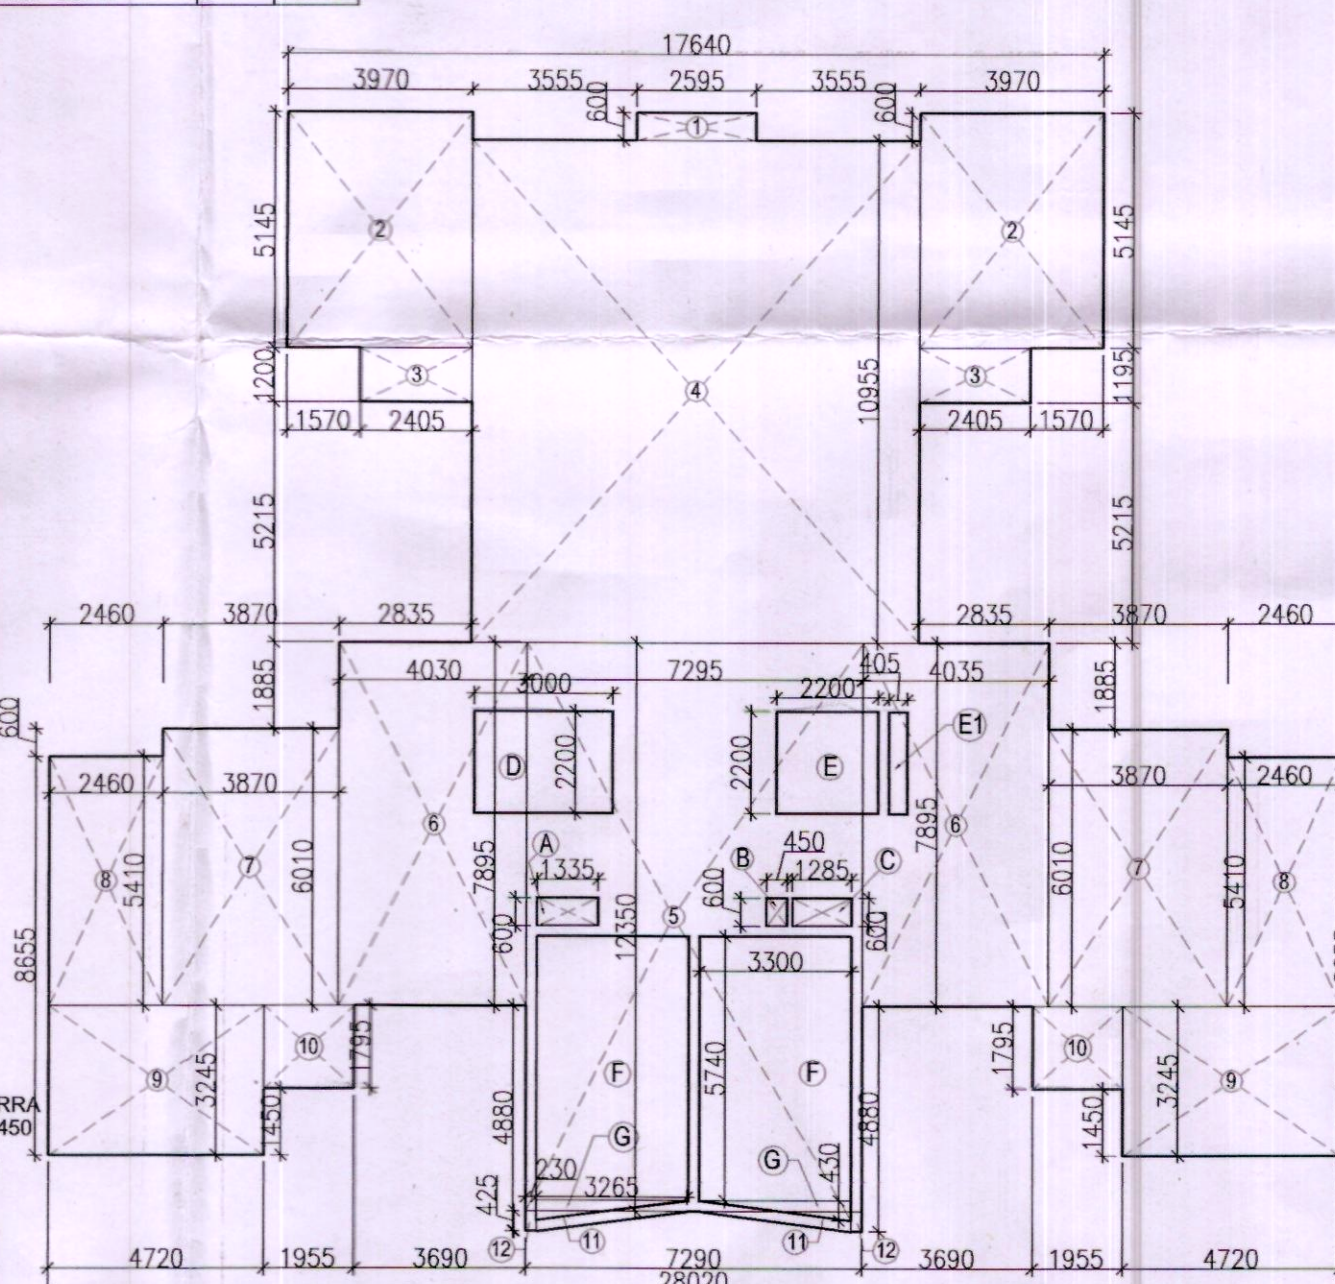

TYP. 1ST TO 13TH FLOOR AREA DIAGRAM

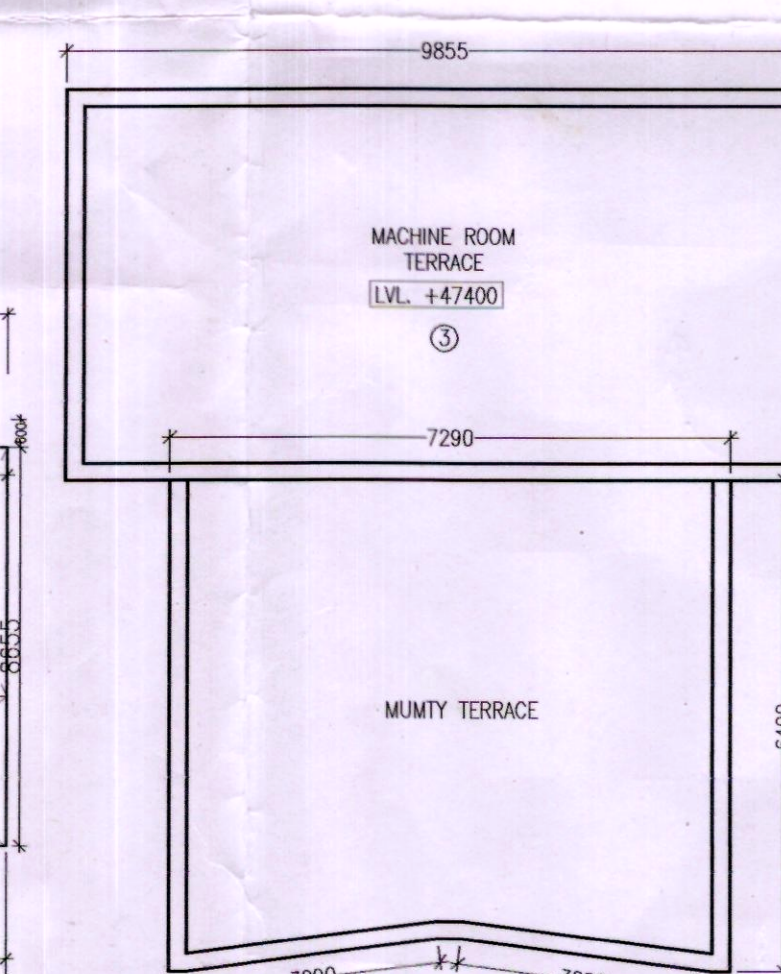

MUMTY & MACHINE ROOM PLAN

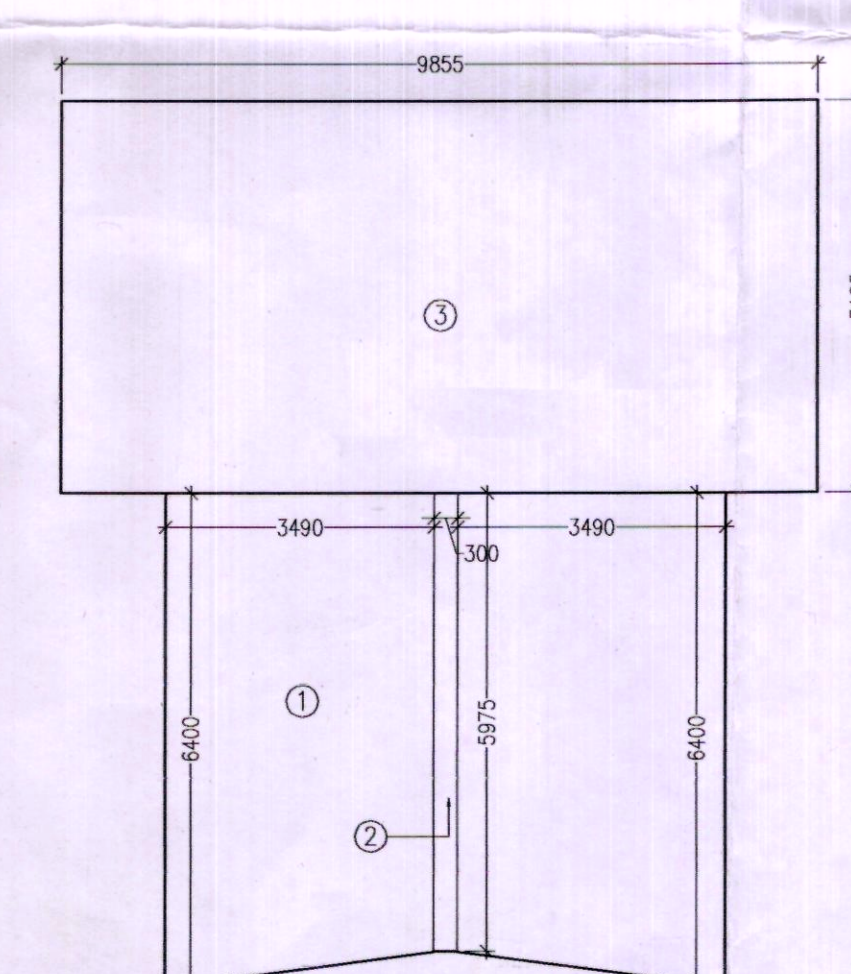

MUMTY AREA DIAGRAM

LEGEND	DESCRIPTION
1	110 OD UPVC (SWR) SOIL & VENT PIPE
2	110 OD UPVC (SWR) WASTE & VENT PIPE
3	110 OD UPVC (SWR) RAIN WATER PIPE
4	110 OD UPVC (SWR) DOMESTIC WATER SUPPLY ON TAKE FOR 10th TO GROUND FLOOR
5	110 OD UPVC (SWR) DOMESTIC WATER SUPPLY ON TAKE FOR UPPER FLOOR TO 11th FLOOR
6	FLUSHING WATER SUPPLY ON TAKE
7	DOMESTIC WATER SUPPLY RISER
8	FLUSHING WATER SUPPLY RISER
9	FLOOR TRAP
10	FLOOR DRAIN
11	FLOOR CLEAN OUT
12	CLEAN OUT PLUG
13	KHURRA 450x450
14	MANHOLE

S.NO.	TYPE	SIZE	S.L.	L.L.
1	DW1	1410 X	2450	150
2	DW2	2230 X	2450	150
3	DW3	2100 X	2450	150
4	DW4	2360 X	2450	150
5	DW5	2400 X	2450	150
6	DW6	2700 X	2450	150
7	D1	750 X	2100	0
8	D2	900 X	2400	0
9	D3	1000 X	2450	0
10	FD	1500 X	2450	0
11	W1	600 X	900	1550
12	W2	1000 X	1250	2450

- NOTES:
- ALL DIMENSIONS IN MM.
 - LIFT SHALL BE WITH 100% POWER BACKUP.

PROJECT:

REVISED BUILDING PLAN OF GROUP HOUSING SCHEME LAND MEASURING 15.575 ACRES (LICENCE NO.71 OF 2008 DATED 25.03.2008) IN SECTOR - 91, GURGAON MANESAR URBAN COMPLEX BEING DEVELOPED BY M/S JUBILANT SOFTWARES SERVICES PVT. LTD.

ARCHITECT:-

GIAN P. MATHUR AND ASSOCIATES (P) LTD.
C-55, East Of Kailash, New Delhi-110065
T: 011-46599599 / F: 011-46599512
E: gpm@airtelmail.in / W: www.gpmindia.com

OWNERS SIGNATURE:-

ARCHITECT SIGNATURE:-

GIAN P. MATHUR
B. Arch., M.C.A. I.I.A.
CA No. 8015769

DRAWING TITLE:

TYP. FLOOR PLANS (TOWERS - J, K, L, M, N)

DATE:- JULY-2017

SCALE:- 1:100

SHEET NO. 12