


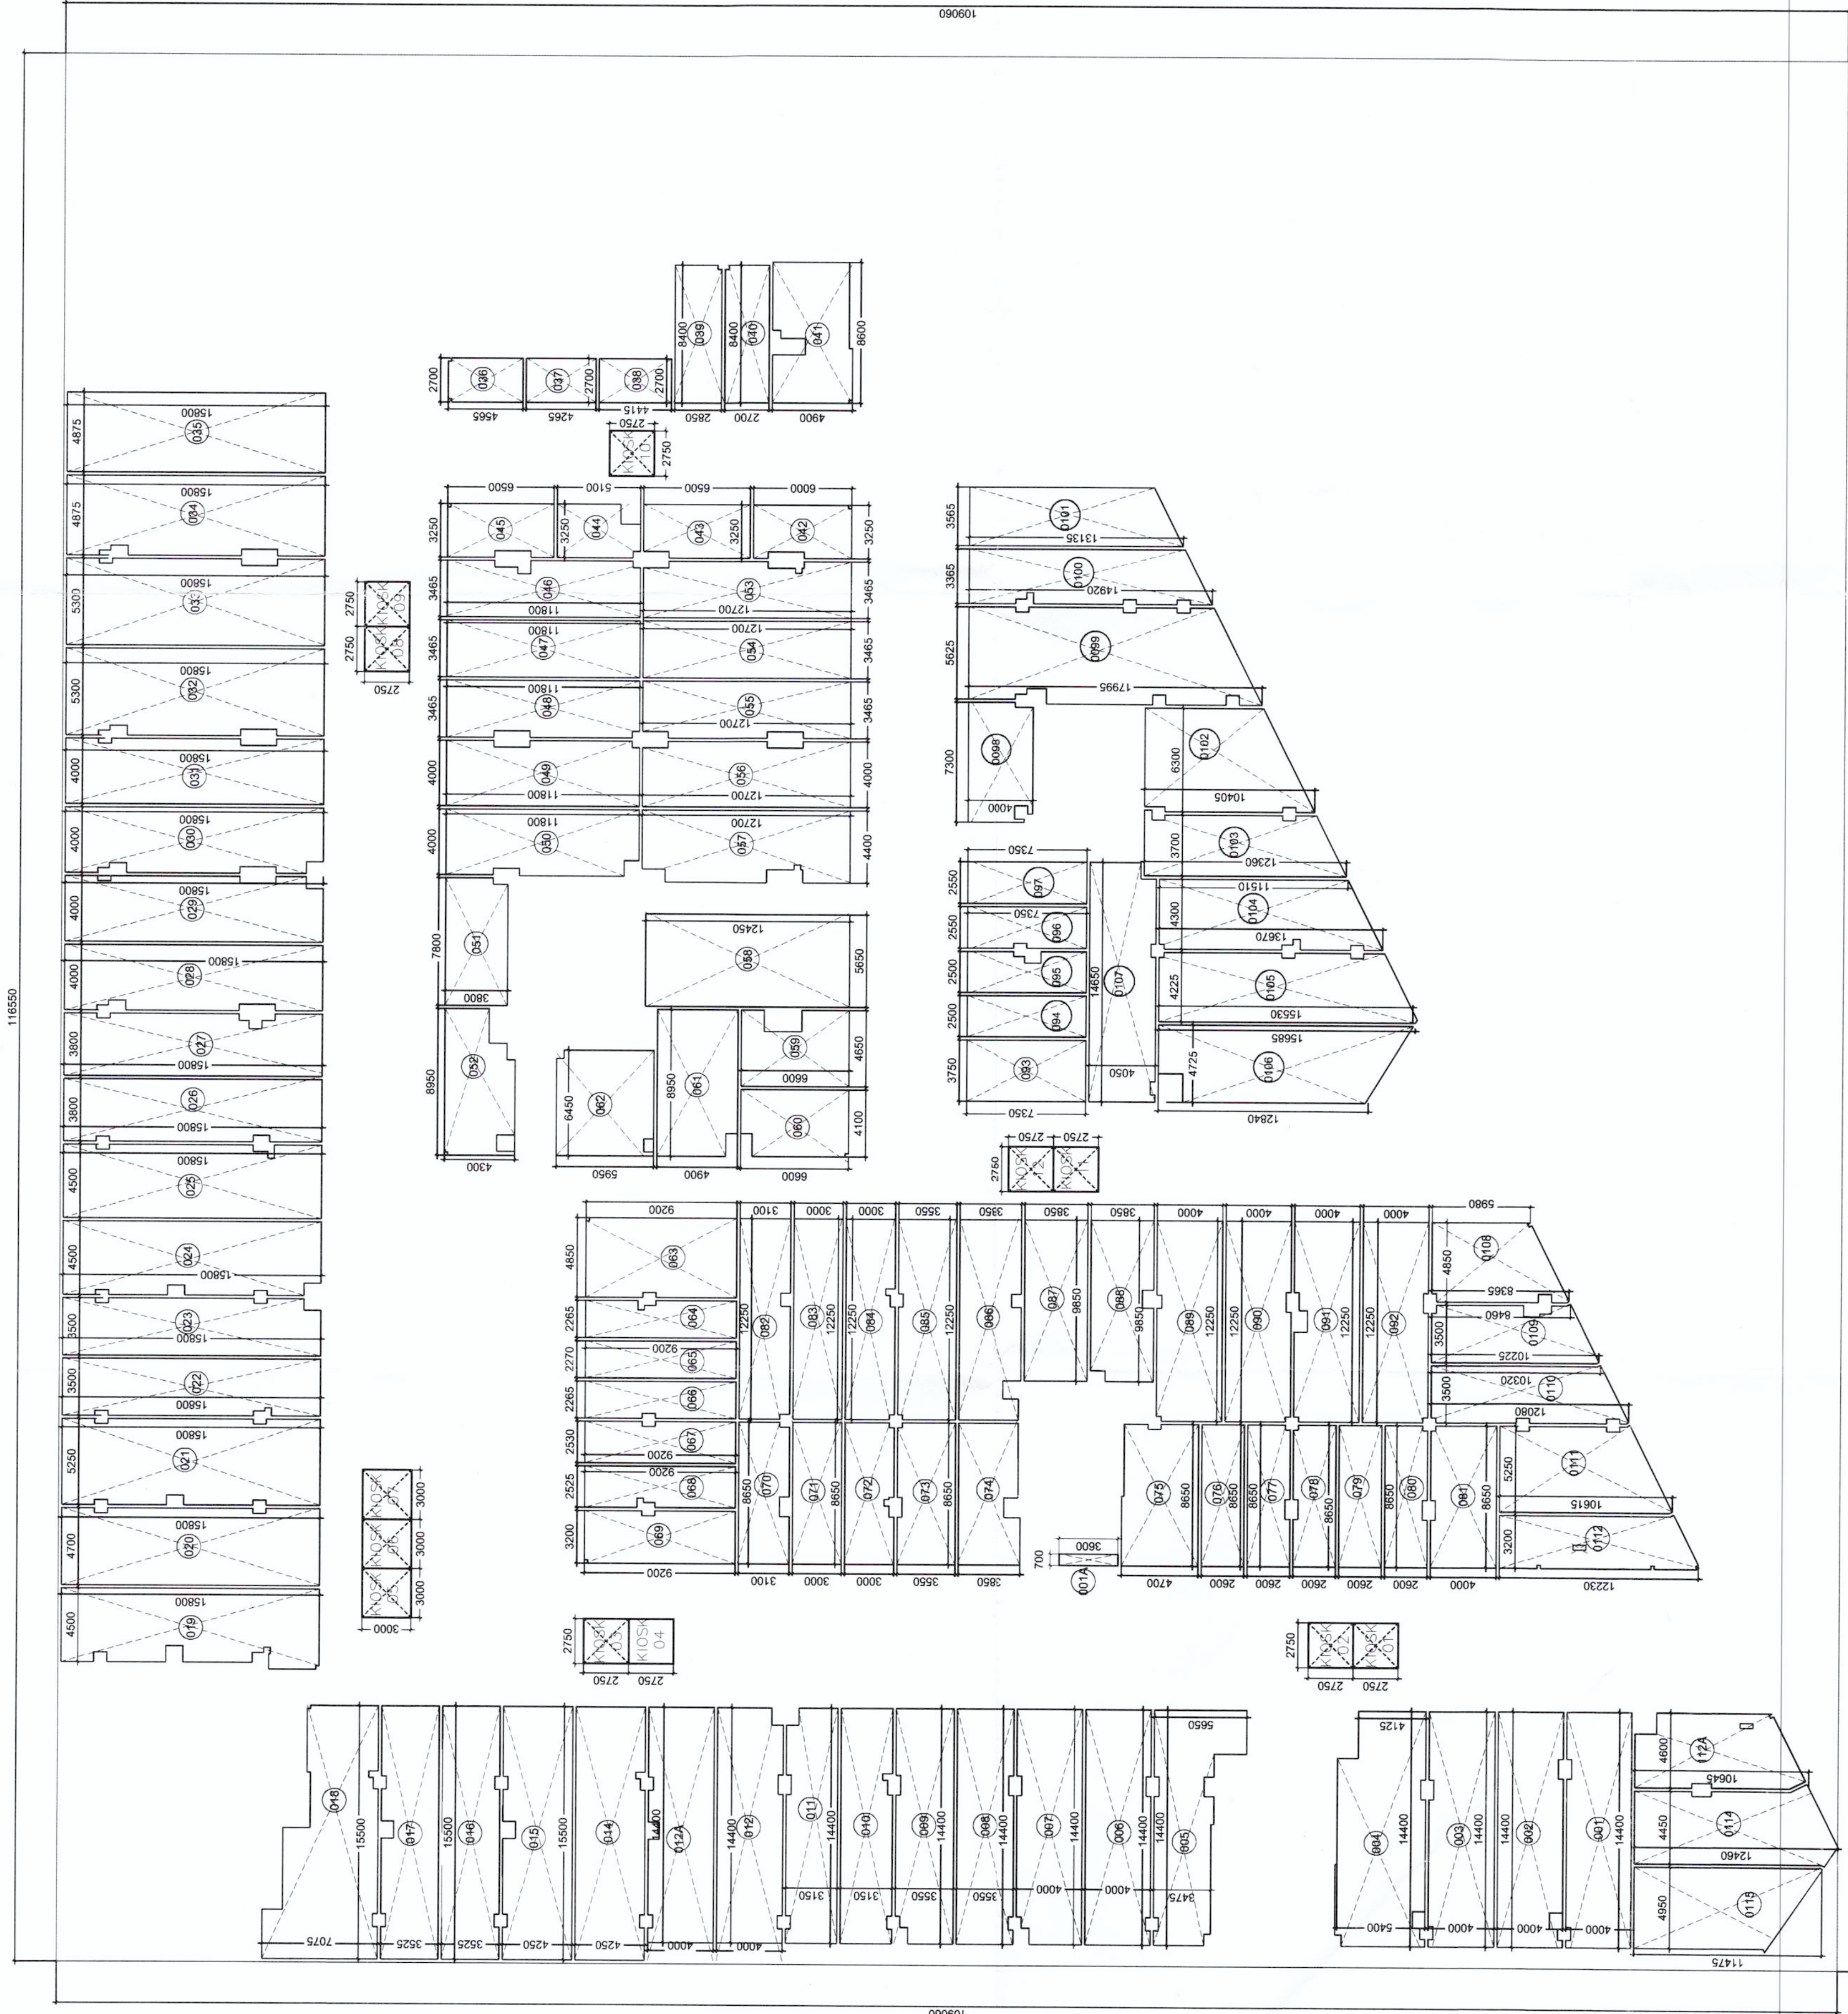

1 CARPET AREA DIAGRAM
SCALE 1:250

[illegible][illegible]

ARCHITECT:
**DESIGN FORUM
INTERNATIONAL**
K-47, KALASH COLONY,
NEW DELHI
TEL: 011-46556920

STRUCTURE CONSULTANT:
VINTECH CONSULTANTS
C-35, PAMPOSH ENCLAVE, GREATER
MUMBAI 400 019, INDIA

MEP CONSULTANT:
SANELAC CONSULTANTS PVT LTD
C-84/2, Okhla Industrial Area, Phase-II
New Delhi-110029
Tel. 36285731, 65607360

NOTES:

1. ALL DIMENSIONS ARE IN MM.
2. GATE AND BOUNDARY WALL SHALL BE AS PER STANDARD DESIGN.
3. SPRINKLERS WILL BE PROVIDED IN ENTIRE BUILDING INCLUDING BASEMENT'S AS PER N.B.C.
4. RAIN WATER HARVESTING SYSTEM WILL BE PROVIDED AS PER APPLICABLE NORMS.
5. 100% POWER BACK UP WILL BE PROVIDED FOR LIFT'S & ESSENTIAL SERVICE AREAS.
6. DISABLED RAMP @ 1:12 SLOPE WITH 900MM HIGH RAILING.
7. ALL BUILDINGS ARE MECHANICALLY VENTILATED AND FULLY AIR CONDITIONED.

PROJECT:

BUILDING PLAN OF COMMERCIAL COLONY
MEASURING 4.418 ACRES (LICENCE NO. 197 OF 2008
DATED 05-12-2008) IN SECTOR 66, GURGAON
MANESAR URBAN COMPLEX, BEING DEVELOPED BY
M/S R. C. SODH & CO.
C/O ADVANCE INDIA PROJECTS LIMITED
THE MASTERPIECE, GOLF COURSE ROAD,
SECTOR 54, GURUGRAM - 122002, HARYANA, INDIA

ARCHITECT'S SIGNATURE:

CLIENT'S SIGNATURE

DRAWING TITLE:
GROUND FLOOR PLAN
(CARPET AREA)

DRAWING NO:

SCALE:	DATE:
AS MENTION	18/01/2020