
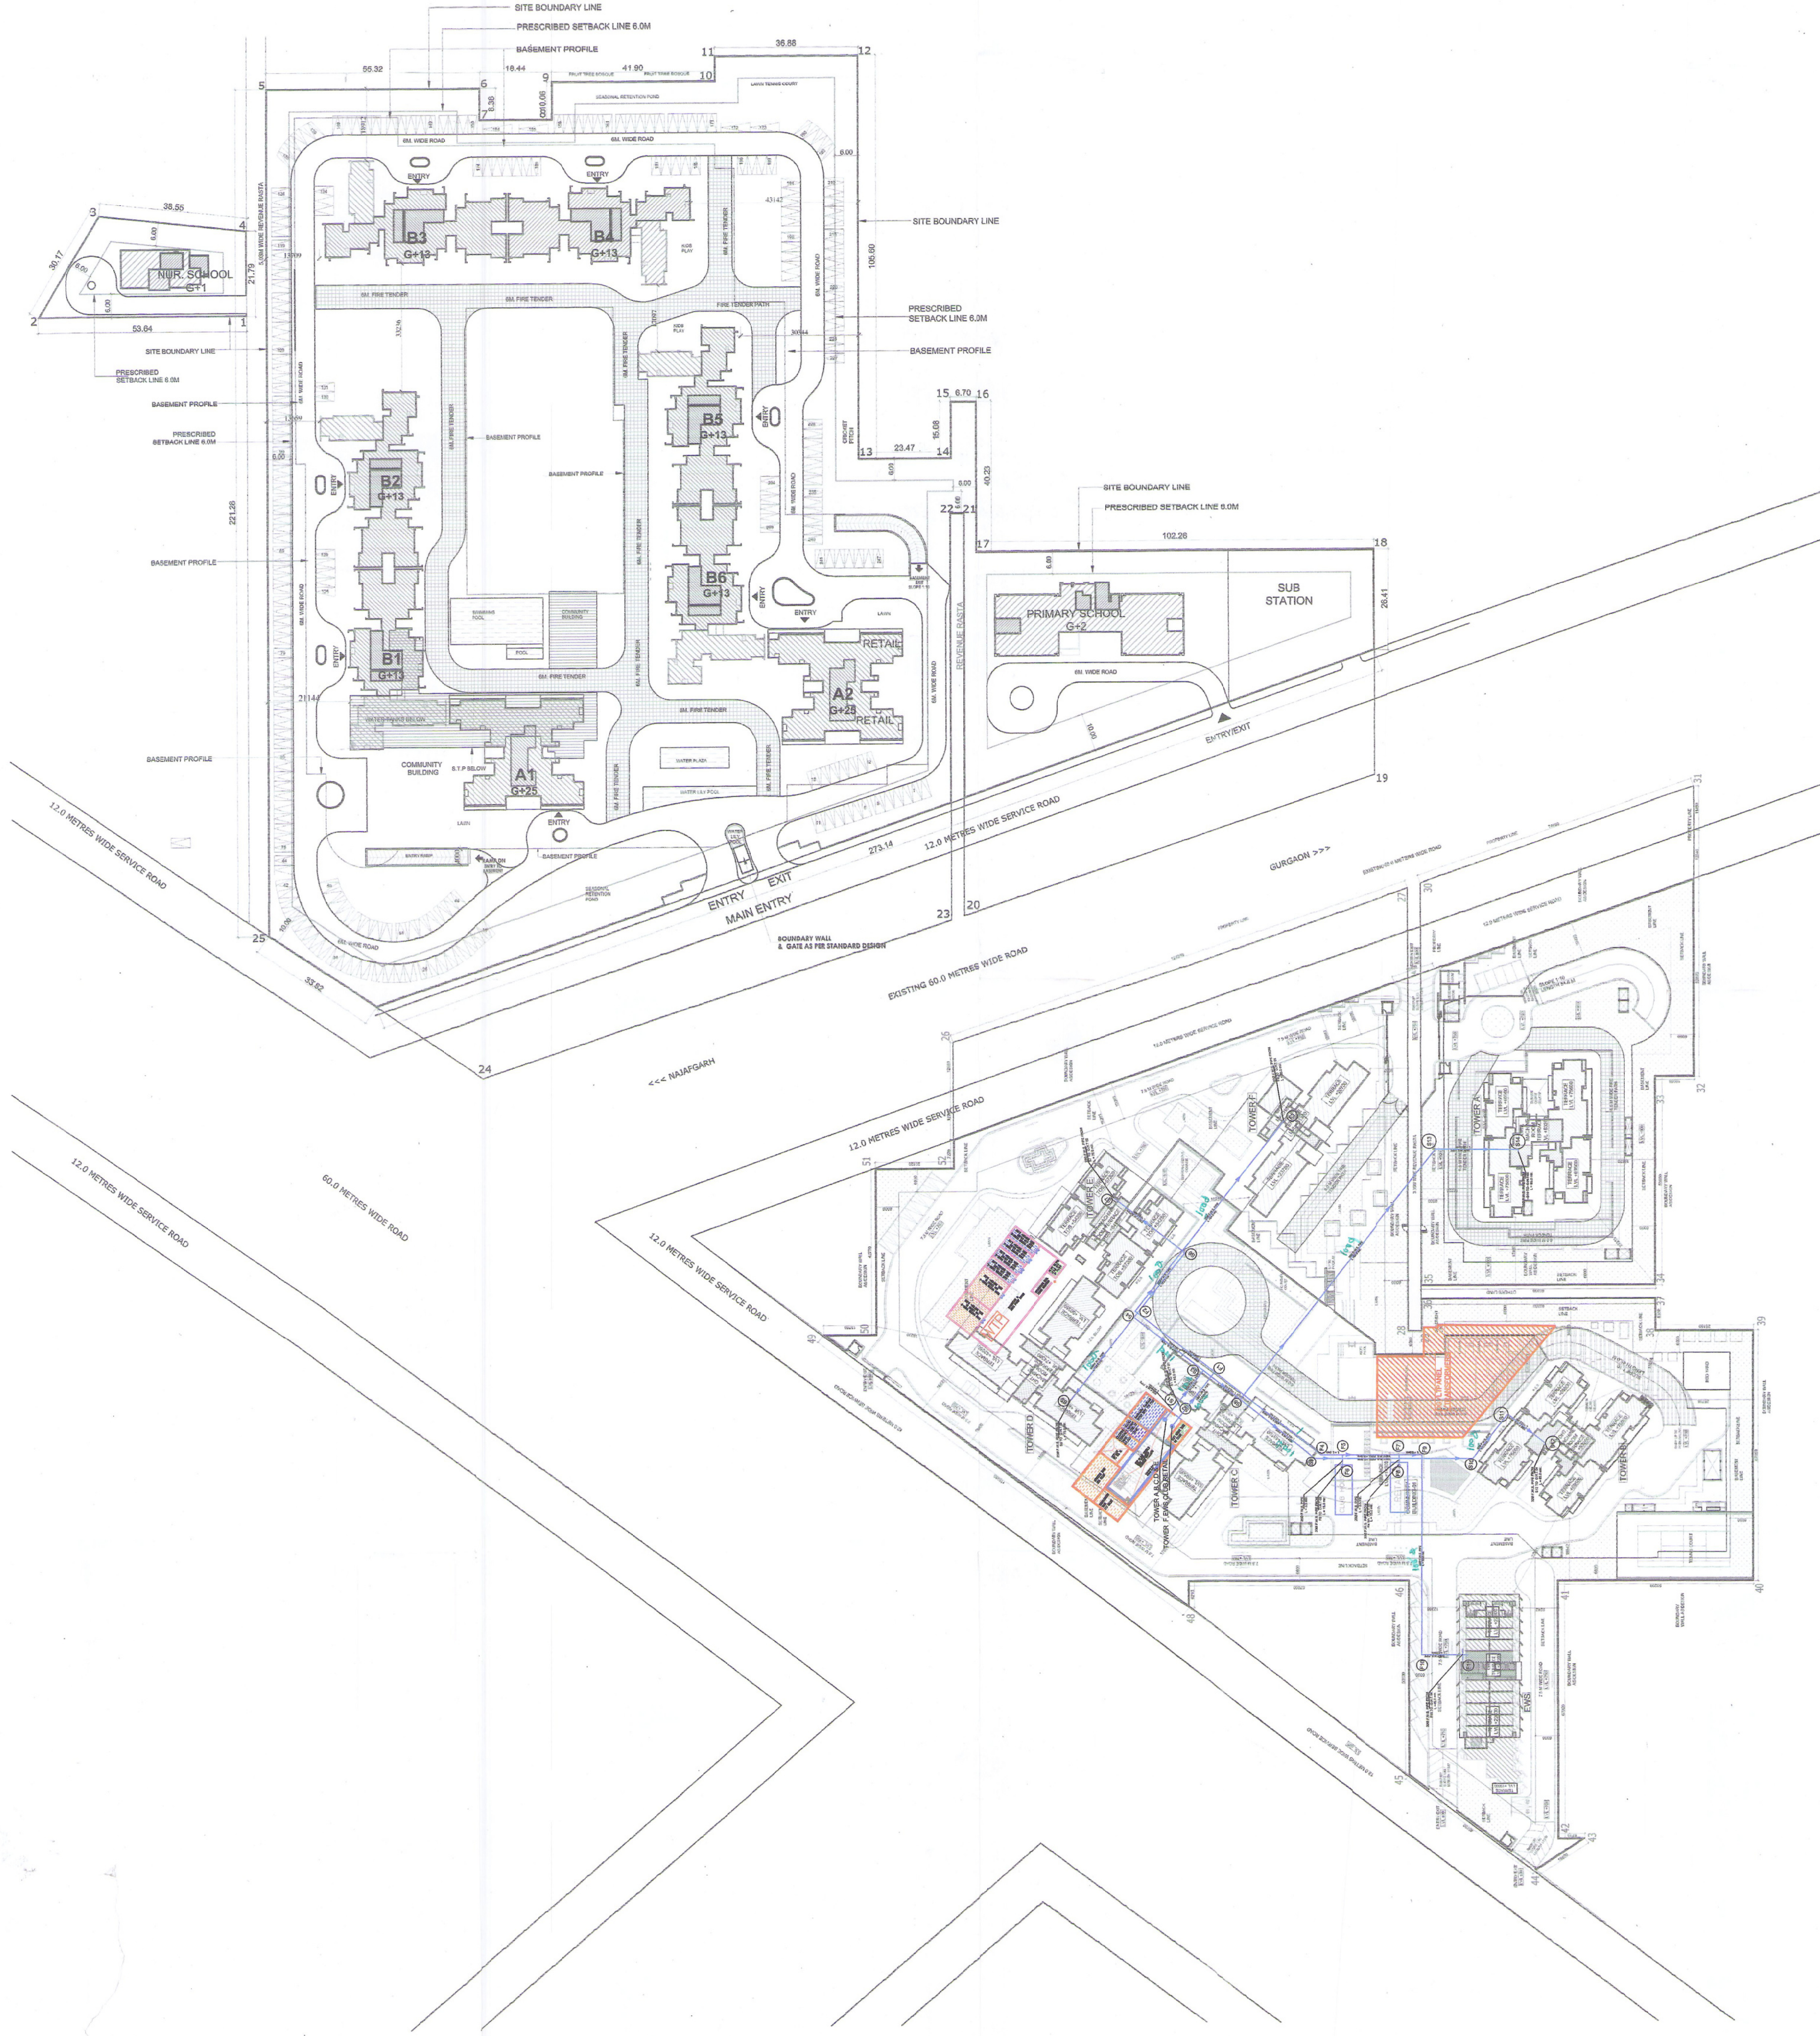


- NOTES
1. ALL DIMENSIONS IN MILLIMETERS UNLESS OTHERWISE SPECIFIED.
 2. ALL BASEMENT AREAS SHALL BE MECHANICALLY LIT.
 3. GATE AND BOUNDARY WALL SHALL BE AS PER STANDARD DESIGN.
 4. THE PROVISION OF SOLAR WATER HEATING SYSTEM TO BE AS PER NORMS SPECIFIED BY HAREDA, AND MADE BEFORE APPLYING FOR OCCUPANCY CERTIFICATE.
 5. RAIN WATER HARVESTING SYSTEM SHALL BE AS PER CENTRAL GOVT. WATER AUTHORITY NORMS.
 6. RAINY SEASON PROVISIONS INCLUDING FIRE SPRINKLERS SHALL BE AS PER NBC GUIDELINES.

PERSONS	DATE	REMARKS
DESIGNER	22.12.2015	
CHECKER		
APPROVER		

PROPOSED BUILT UP.
FOR DETAILED PLAN,
REFER DWG NO.
MP-PH2-001 & MP-PH2-002

KEY PLAN

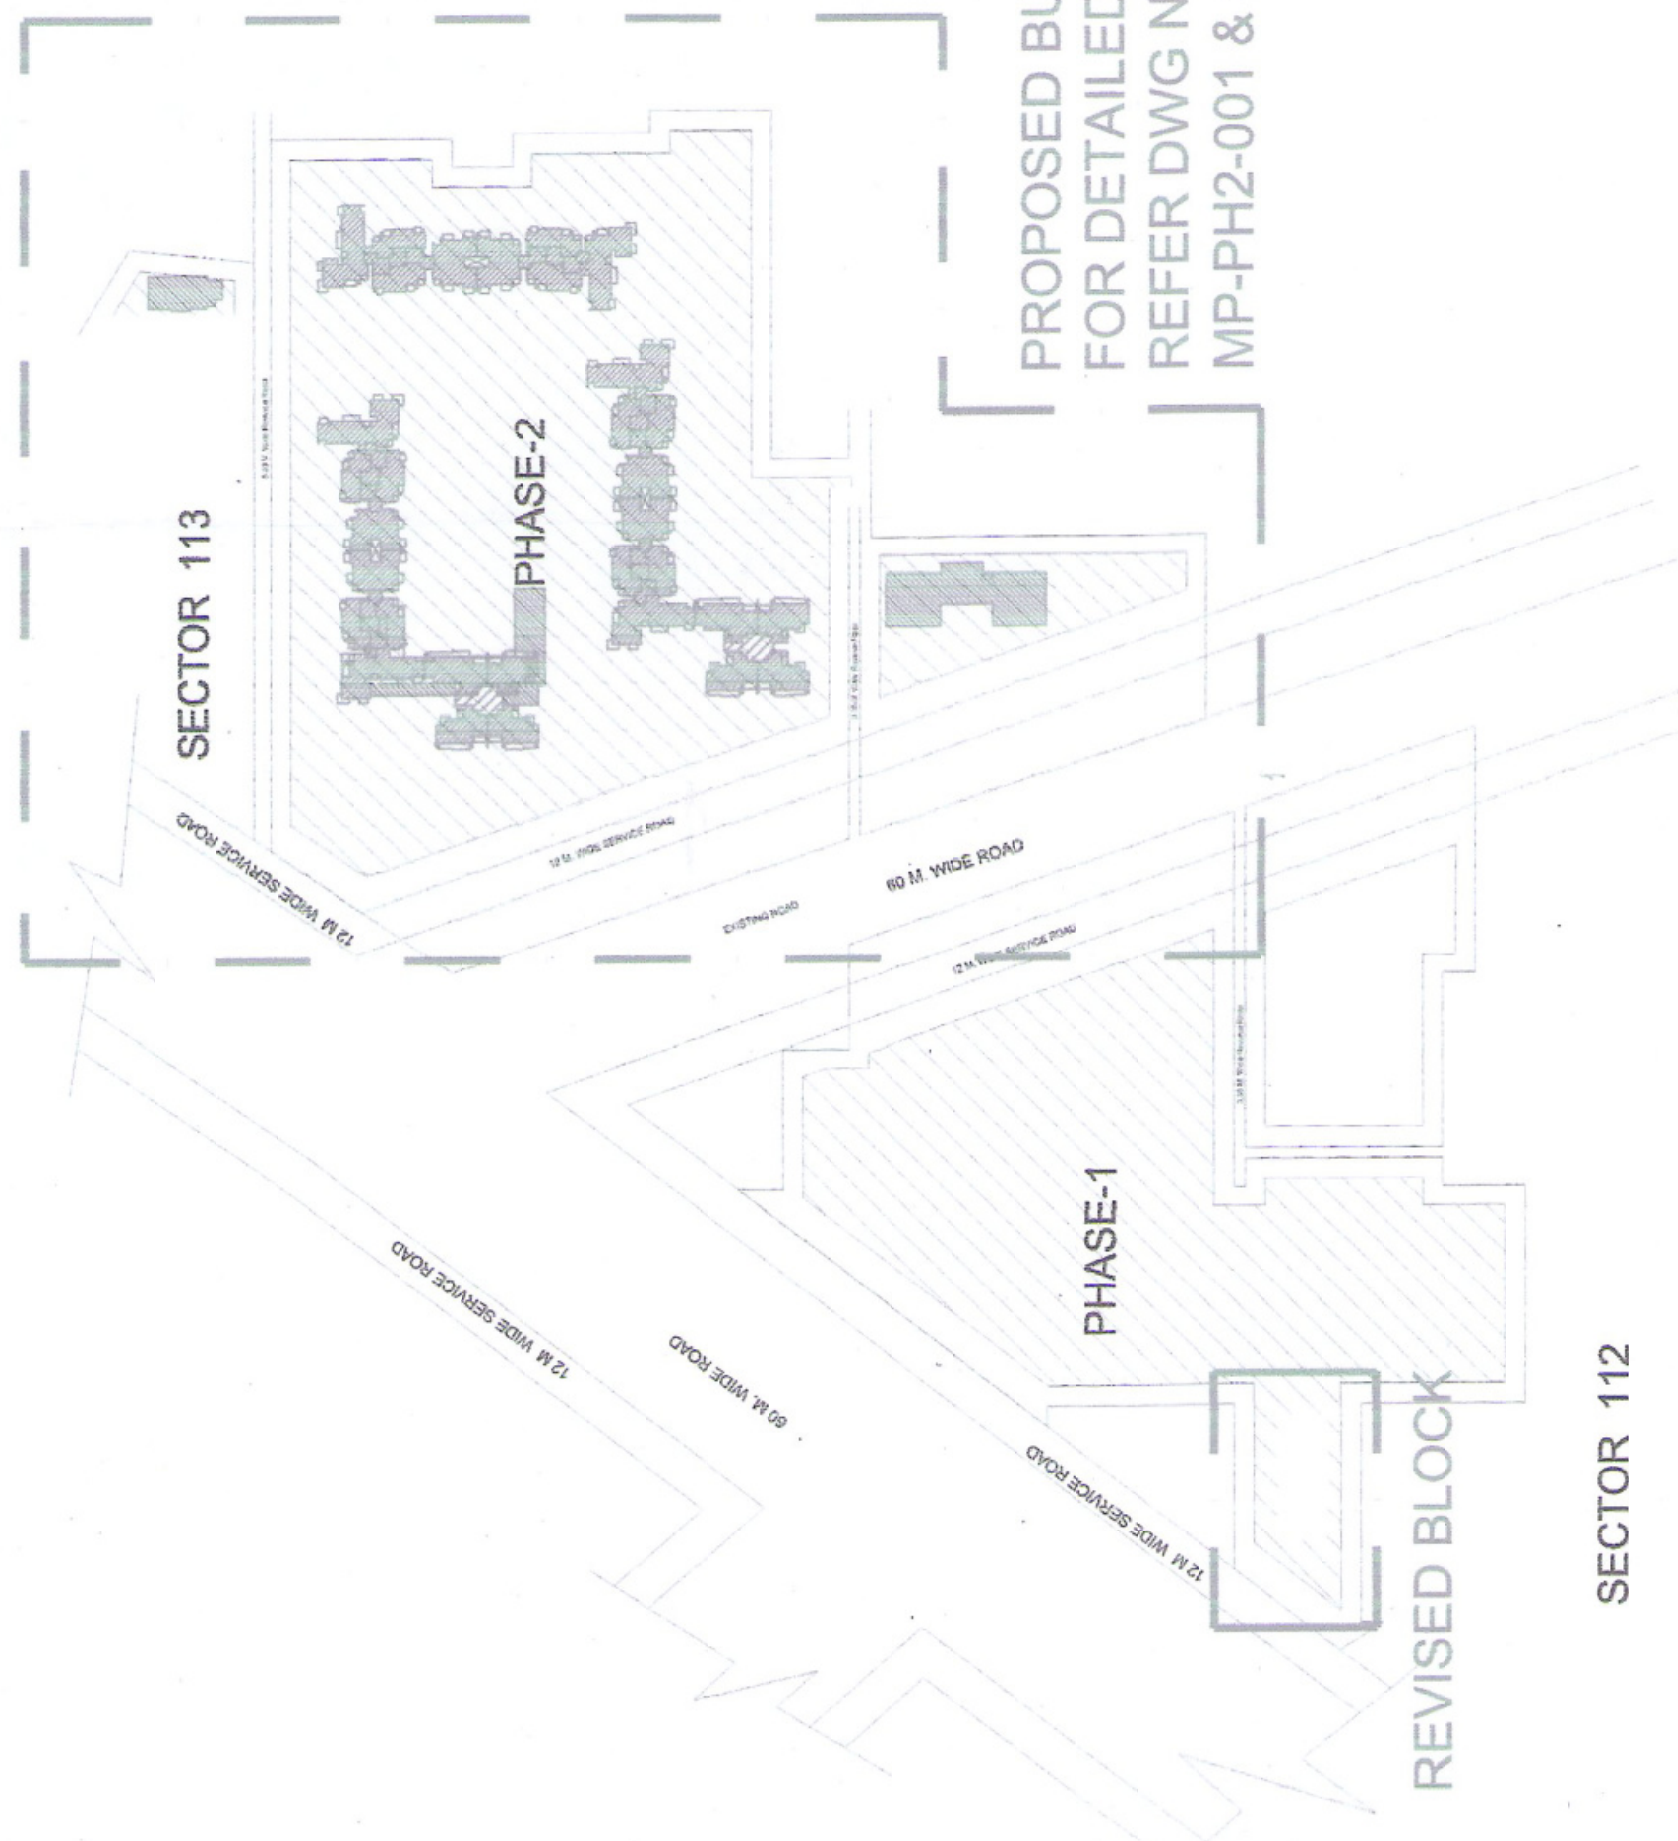

Architect's Signature
Manish K. Bagga, Architect
Council of Architects
Registration No. C-1000000

Owner's Signature
Supriyanshu Bagga
1100, Gurgaon, Haryana

Architect
Aroop Associates Pvt. Ltd.
Plot No. 304, Sec. 32, Gurgaon - 122001
Ph: 91-124-458500 Fax: 91-124-458500
Address: D-10, New Delhi - 110025

Structure
IPC Technical Projects Consultants Pvt. Ltd.
B-74, Sector 27, Gurgaon - 122025 (Ultra Phase II) India
E-mail: ipc@ipc.co.in | Tel: 91-124-458500 | Fax: 91-124-458500

MEP
Gurgaon Consultants
G-46, Sector 29, Gurgaon - 122025
E-mail: gurgaonconsultants@gmail.com

Checked and approved by
In forwarding letter No. 13447
Ph: 91-124-458500 and notes
attached with the drawings

Engineer
Gurgaon



Engineer
Gurgaon

Drawing No.
Drawing title
Scale
1:750

SITE PLAN (OVERALL)
FLUSHING WATER SUPPLY
MP-001
PHE-02