



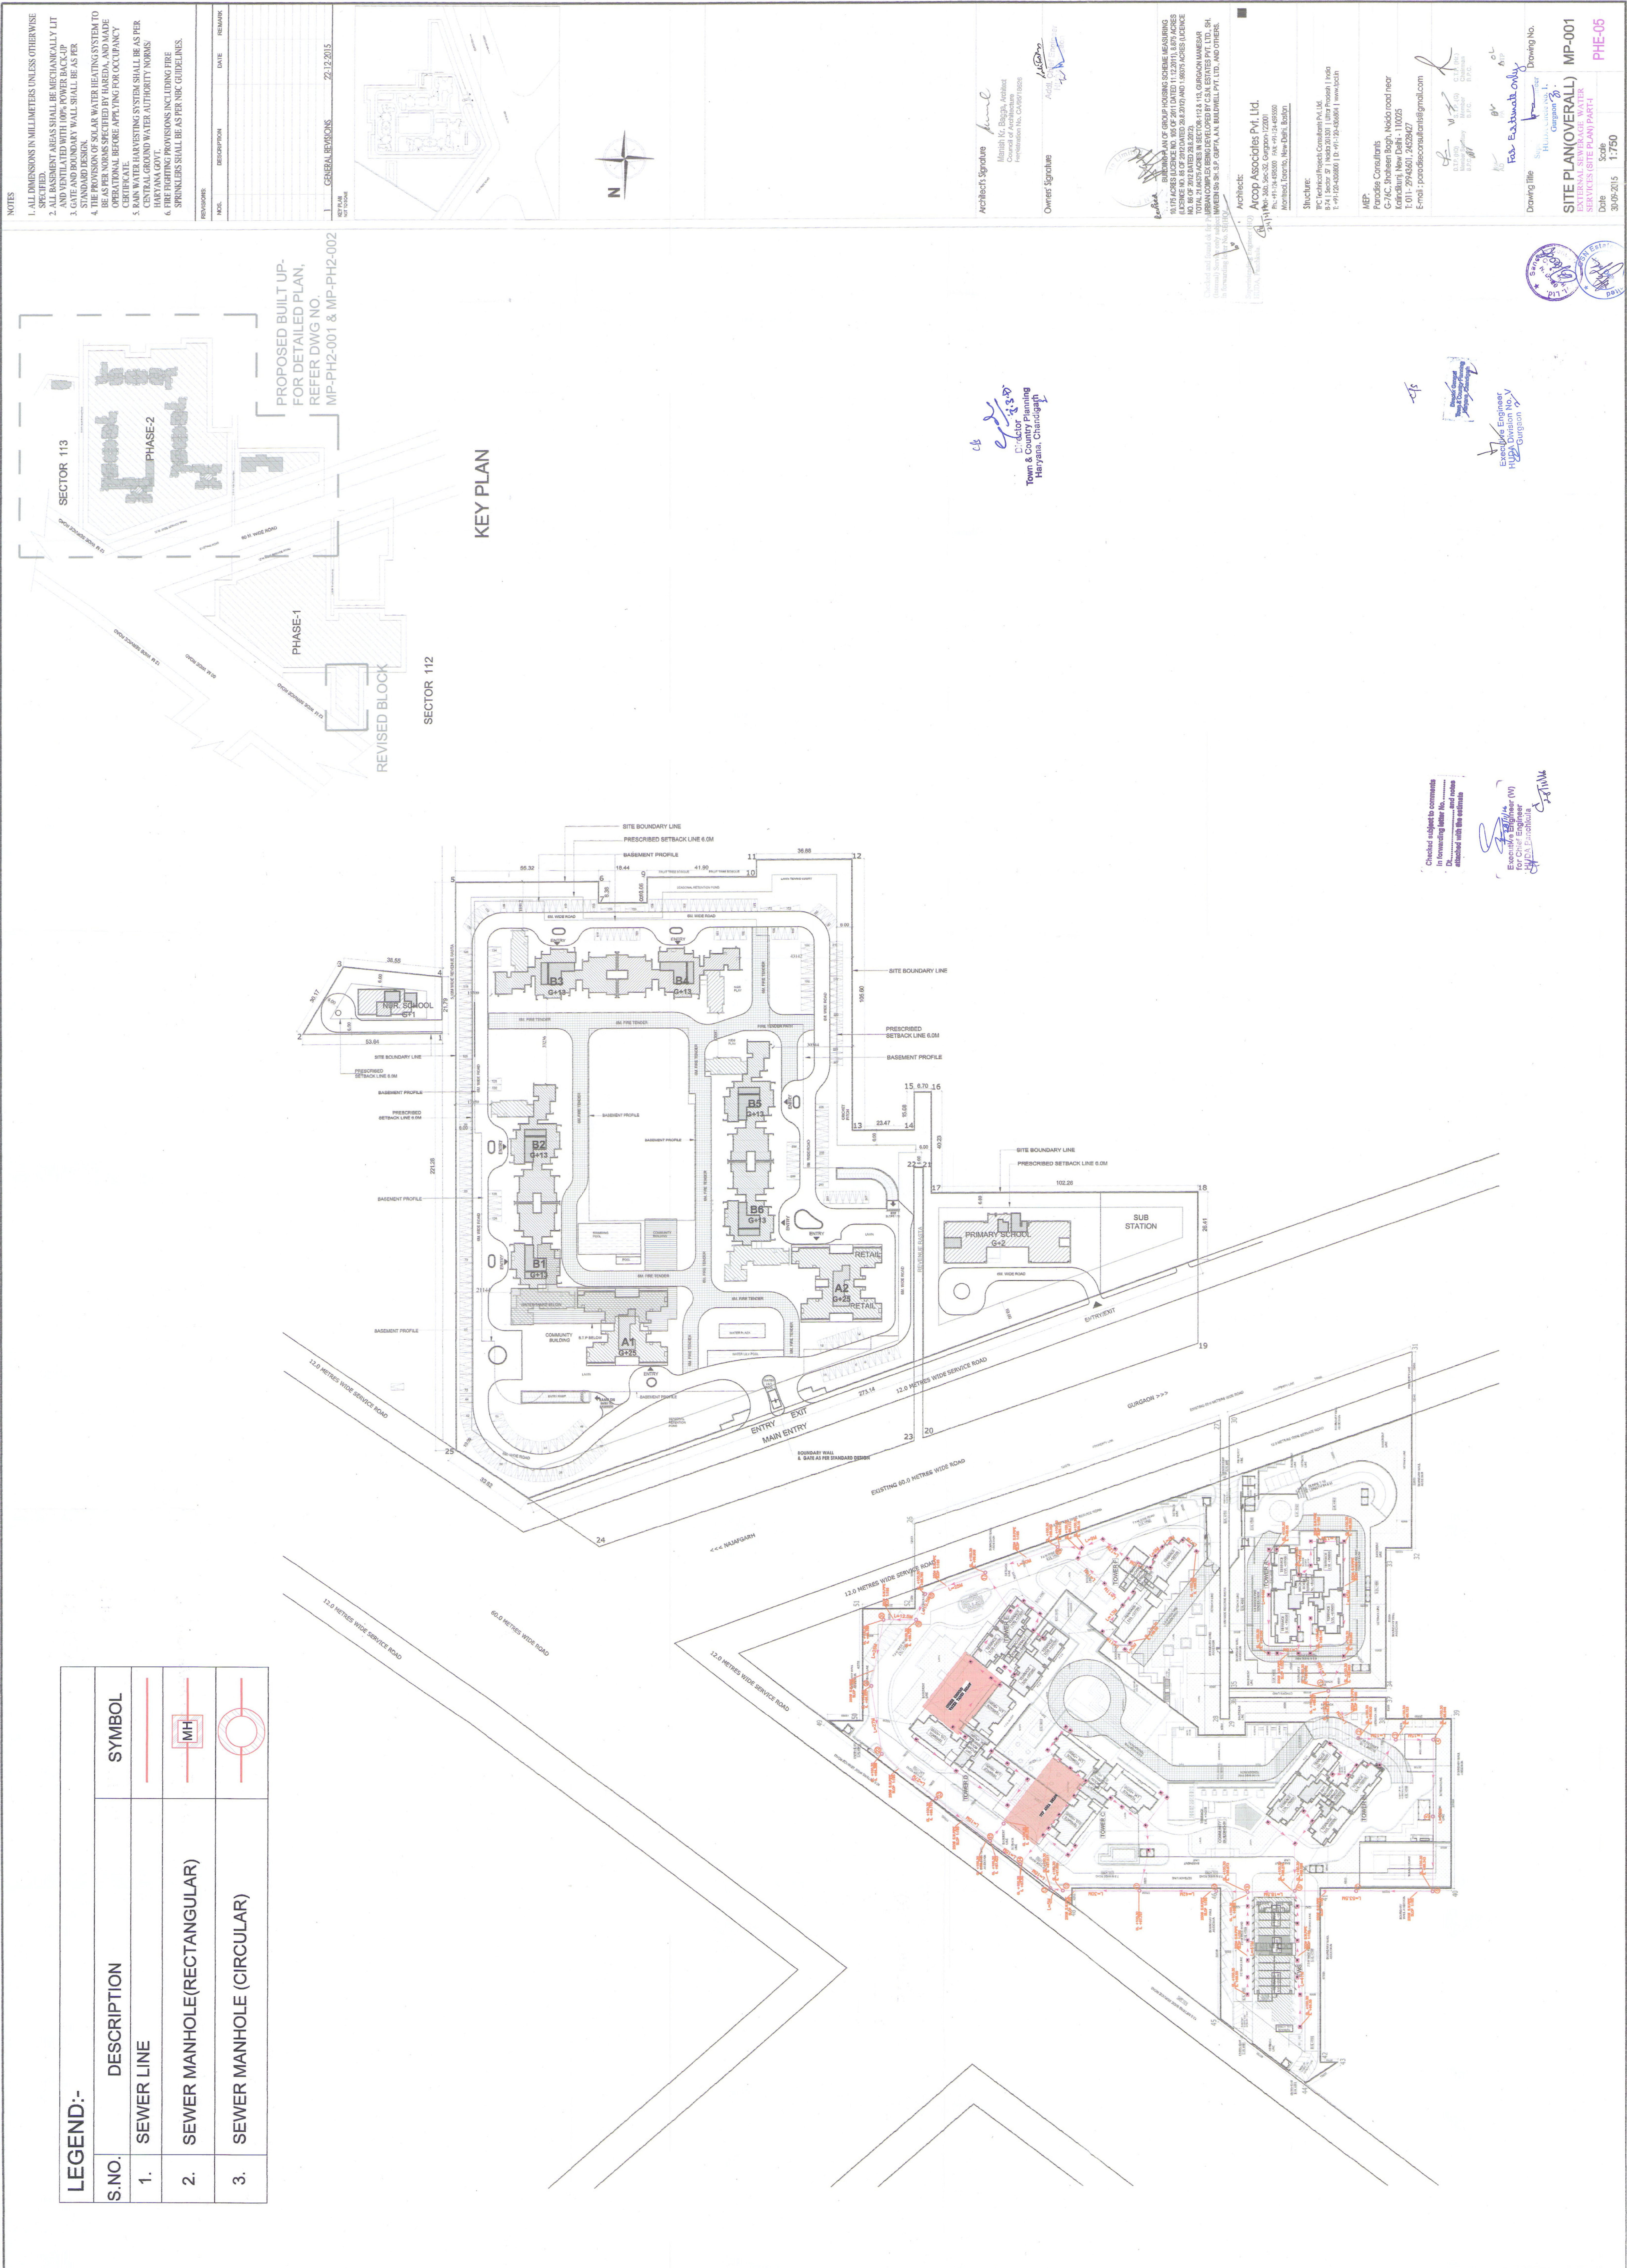

NOTES

1. ALL DIMENSIONS IN MILLIMETERS UNLESS OTHERWISE SPECIFIED.
2. ALL BASEMENT AREAS SHALL BE MECHANICALLY LIT AND VENTILATED WITH 100% POWER BACK-UP.
3. GATE AND BOUNDARY WALL SHALL BE AS PER SPECIFICATION.
4. THE PROVISION OF SOLAR WATER HEATING SYSTEM TO BE AS PER NORMS SPECIFIED BY HAREDA, AND MADE OPERATIONAL BEFORE APPLYING FOR OCCUPANCY CERTIFICATE.
5. RAIN WATER HARVESTING SYSTEM SHALL BE AS PER CENTRAL GOVT. WATER AUTHORITY NORMS/ HARYANA GOVT.
6. FIRE FIGHTING PROVISIONS INCLUDING FIRE SPRINKLERS SHALL BE AS PER NBC GUIDELINES.

REVISIONS	DATE	REMARKS
1	22.12.2015	GENERAL REVISIONS

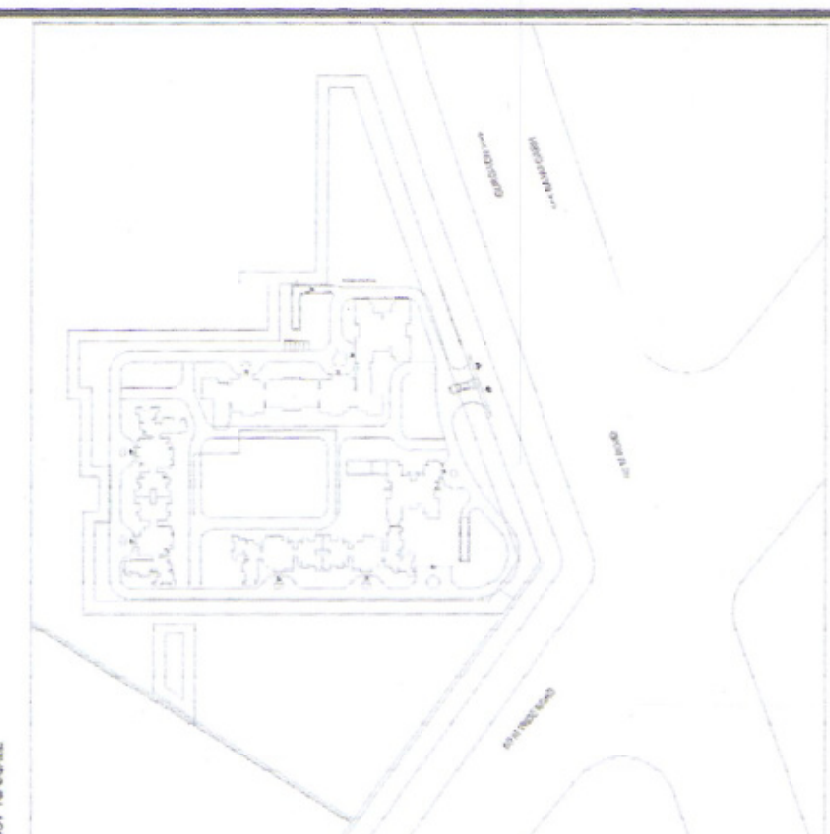

Architect's Signature
Munish K. Bhatia, Architect
Registration No. CA/08718288

Owner's Signature
Amit Choudhary

Architect
Aroop Associates Pvt. Ltd.
G-7/CC, Indraprastha, Noida road near
Sector 18, Noida-201301 | Uttar Pradesh | India
P: +91 120 450066 | F: +91 120 450067 | www.aarop.com

Structure
Paradees Consultants
G-7/CC, Indraprastha, Noida road near
Sector 18, Noida-201301 | Uttar Pradesh | India
P: +91 120 450066 | F: +91 120 450067 | www.paradees.com

MEP
Paradees Consultants
G-7/CC, Indraprastha, Noida road near
Sector 18, Noida-201301 | Uttar Pradesh | India
P: +91 120 450066 | F: +91 120 450067 | www.paradees.com

Checked subject to comments
By: _____
Drawing No. _____
Date: _____
Scale: 1:750

Executive Engineer (W)
Haryana Water Board
Gurgaon

SITE PLAN (OVERALL)
MP-001
PHE-05
Date: 30.09.2015
Scale: 1:750