


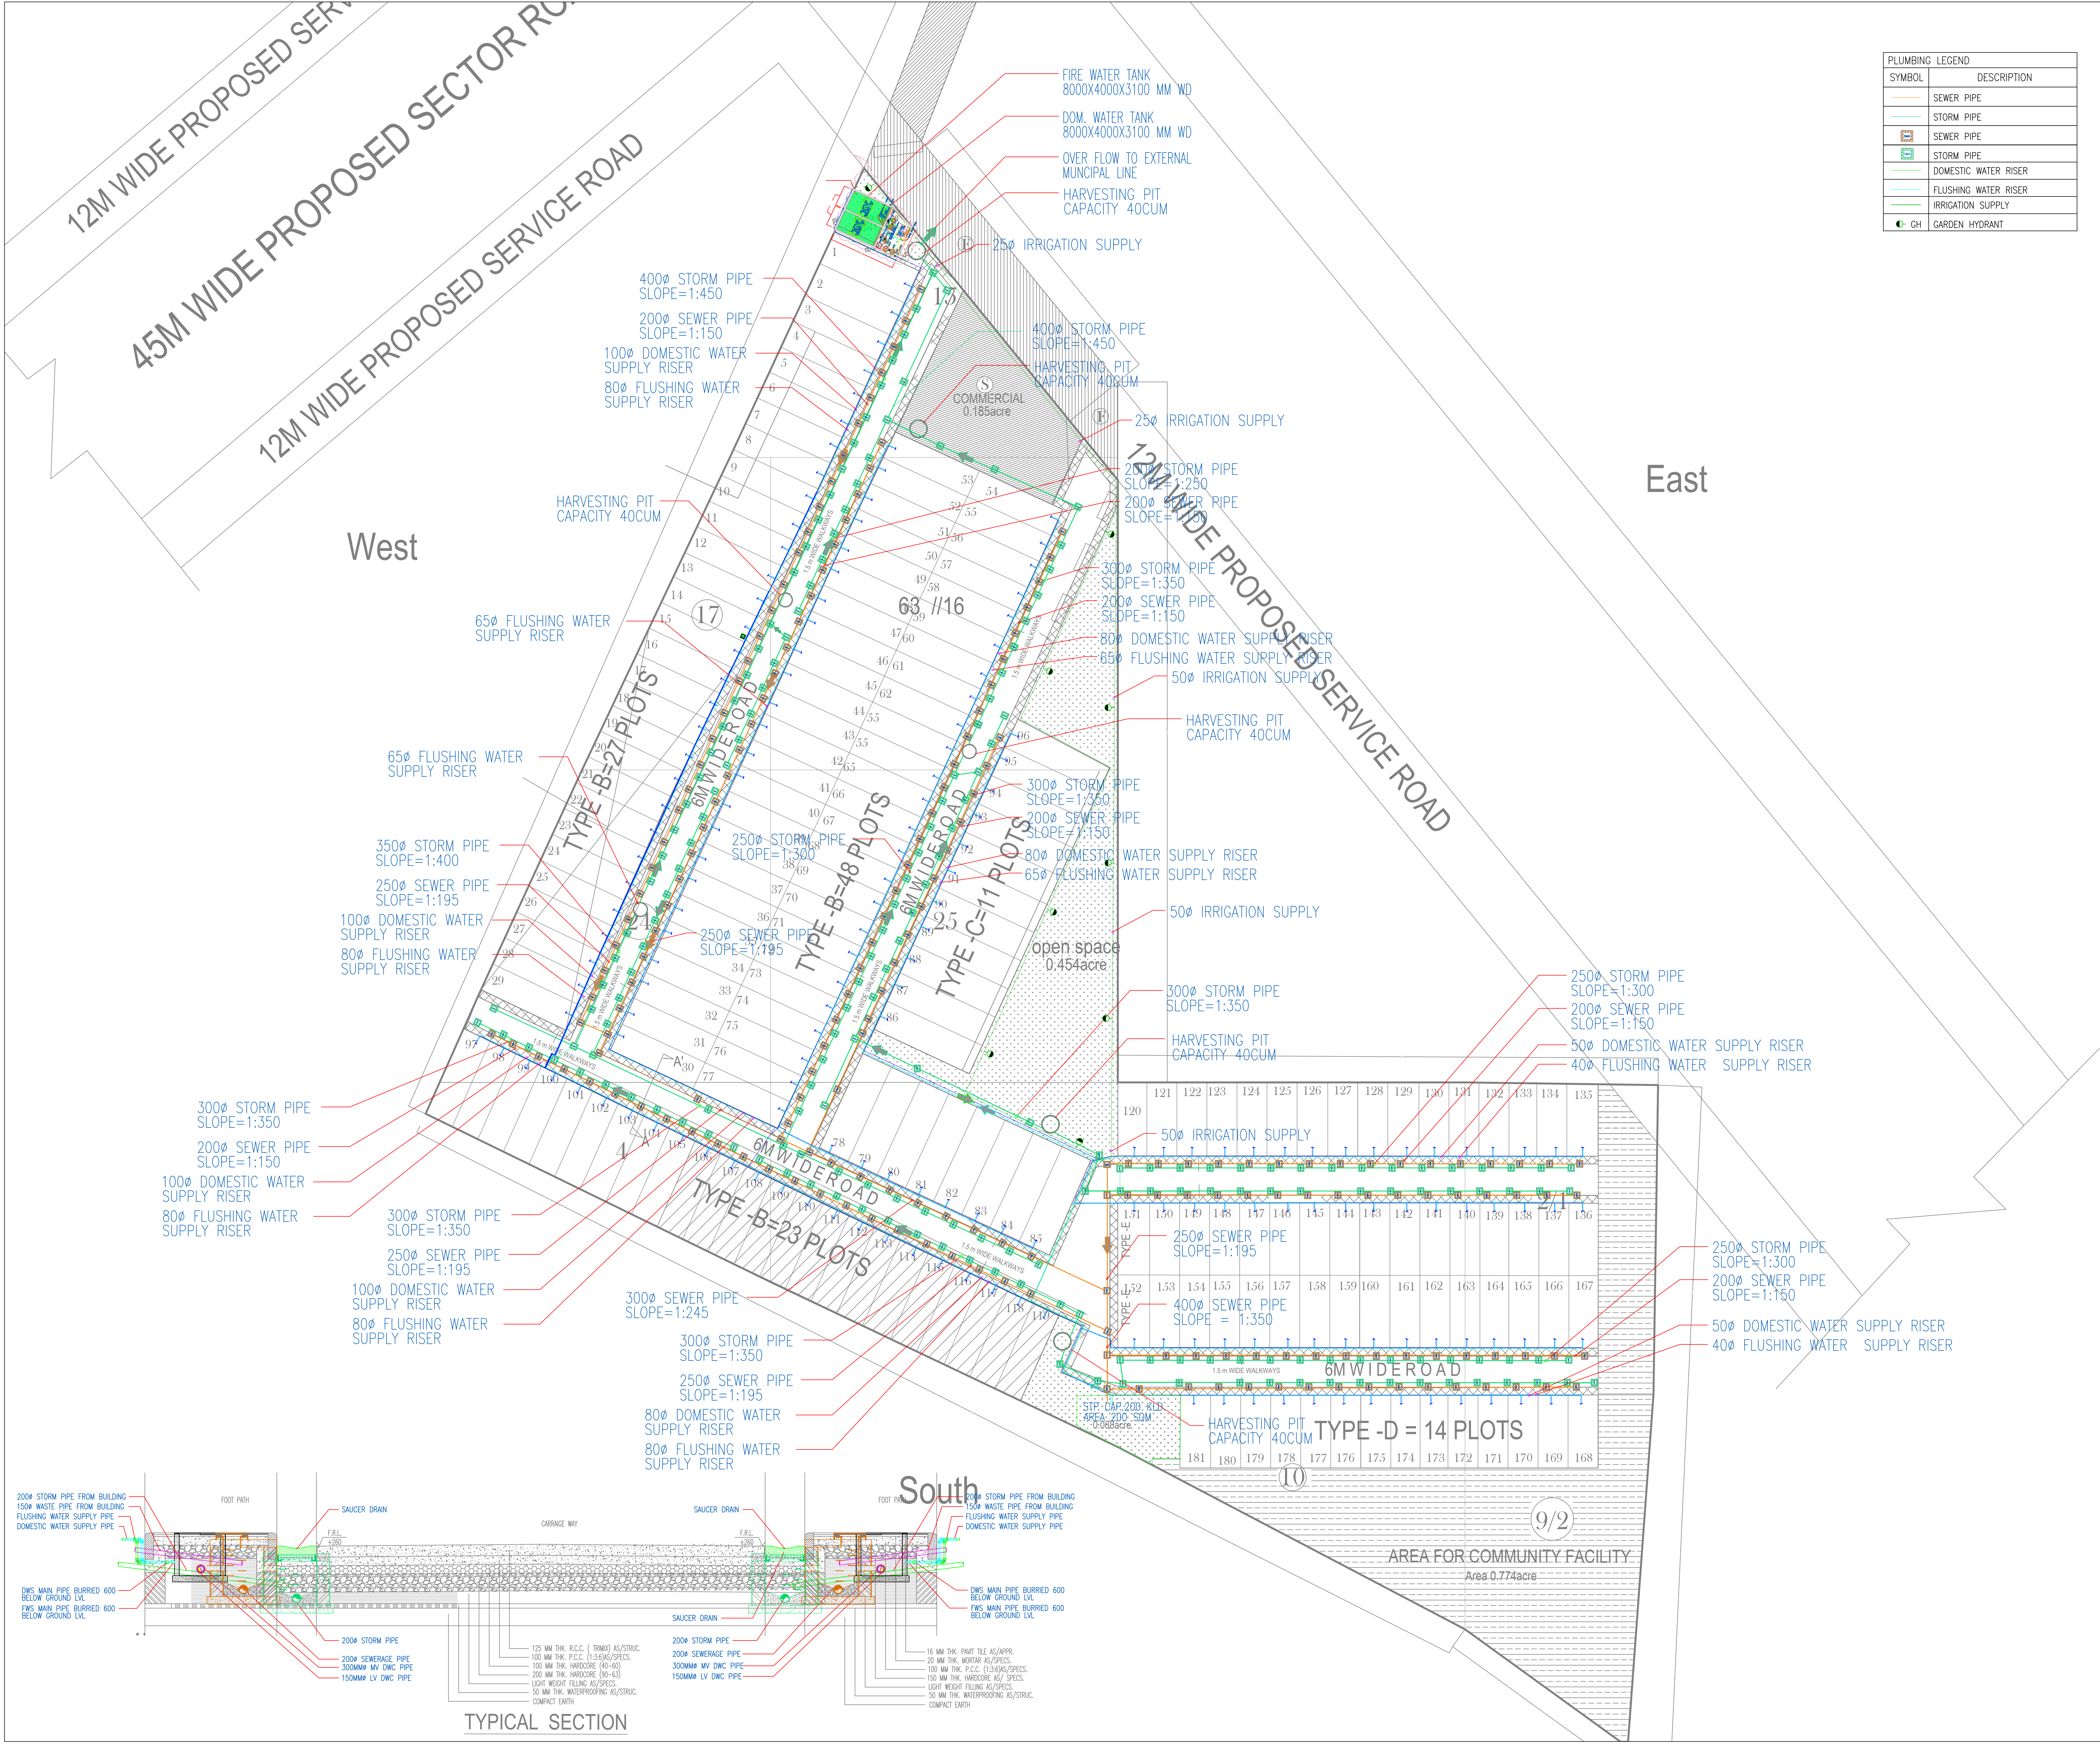

PLUMBING LEGEND	
SYMBOL	DESCRIPTION
	SEWER PIPE
	STORM PIPE
	SEWER PIPE
	STORM PIPE
	DOMESTIC WATER RISER
	FLUSHING WATER RISER
	IRRIGATION SUPPLY
	GH GARDEN HYDRANT

PROJECT TITLE:
RESIDENTIAL PLOTTED COLONY
SECTOR-5, PATAUDI,
DISTRICT GURUGRAM, HARYANA

CLIENT: KSD BUILTECH PVT. LTD

Address: SCO-35, SECTOR-15,PART-II HUDA
MARKET GURGAON HR 122001

SIGN: _____

DATE: _____

ARCHITECTS

I.S.B.E CONSULTING INC.
INTEGRATED STRATEGIC BUSINESS EXECUTION
403,2nd FLOOR,PILLER NO.119,GHITORNI,
M.G. ROAD,NEW DELHI-30
Web-site: www.isbe.com
Email: isbeconsulting@gmail.com
Mob No: +9818023948/011-26502421

SIGN: _____

DATE: _____

DRAWING TITLE:
SITE PLAN - PLUMBING

SCALE:	SCALE:	DRAWN:	DRAWNBY:
DATE:	DATE:	CHECKED:	CHECKED:
PROJECT NO:	PRJTNO	DRAWING NO:	DRAWINGNO.
REVISION NO:	-	REVISION DATE:	-
FILENAME:	FILENAME		

WORKING

DRAWING