


SECTOR-8

SECTOR-6

SECTOR-5

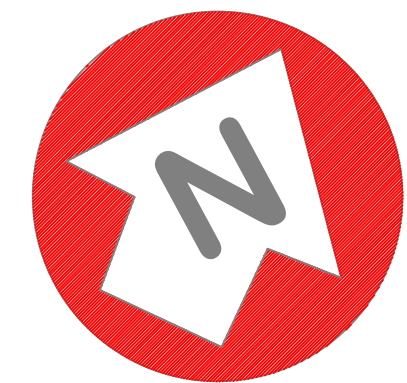

West

East


South

14 PLOT
AREA =1369.09 m2

14 PLOT
AREA =1401.27 m2

AREA DIAGRAM

LEGEND	
SYMBOL	DESCRIPTION
	150MM LV DMC PIPE
	300MM MV DMC PIPE
	EL. MV/LV CHAMBER
	BODY EARTHING
	NEUTRAL EARTHING
	LT CABLE ROUTE FOR ESS TO FELLER DILARS
	STREET LIGHT

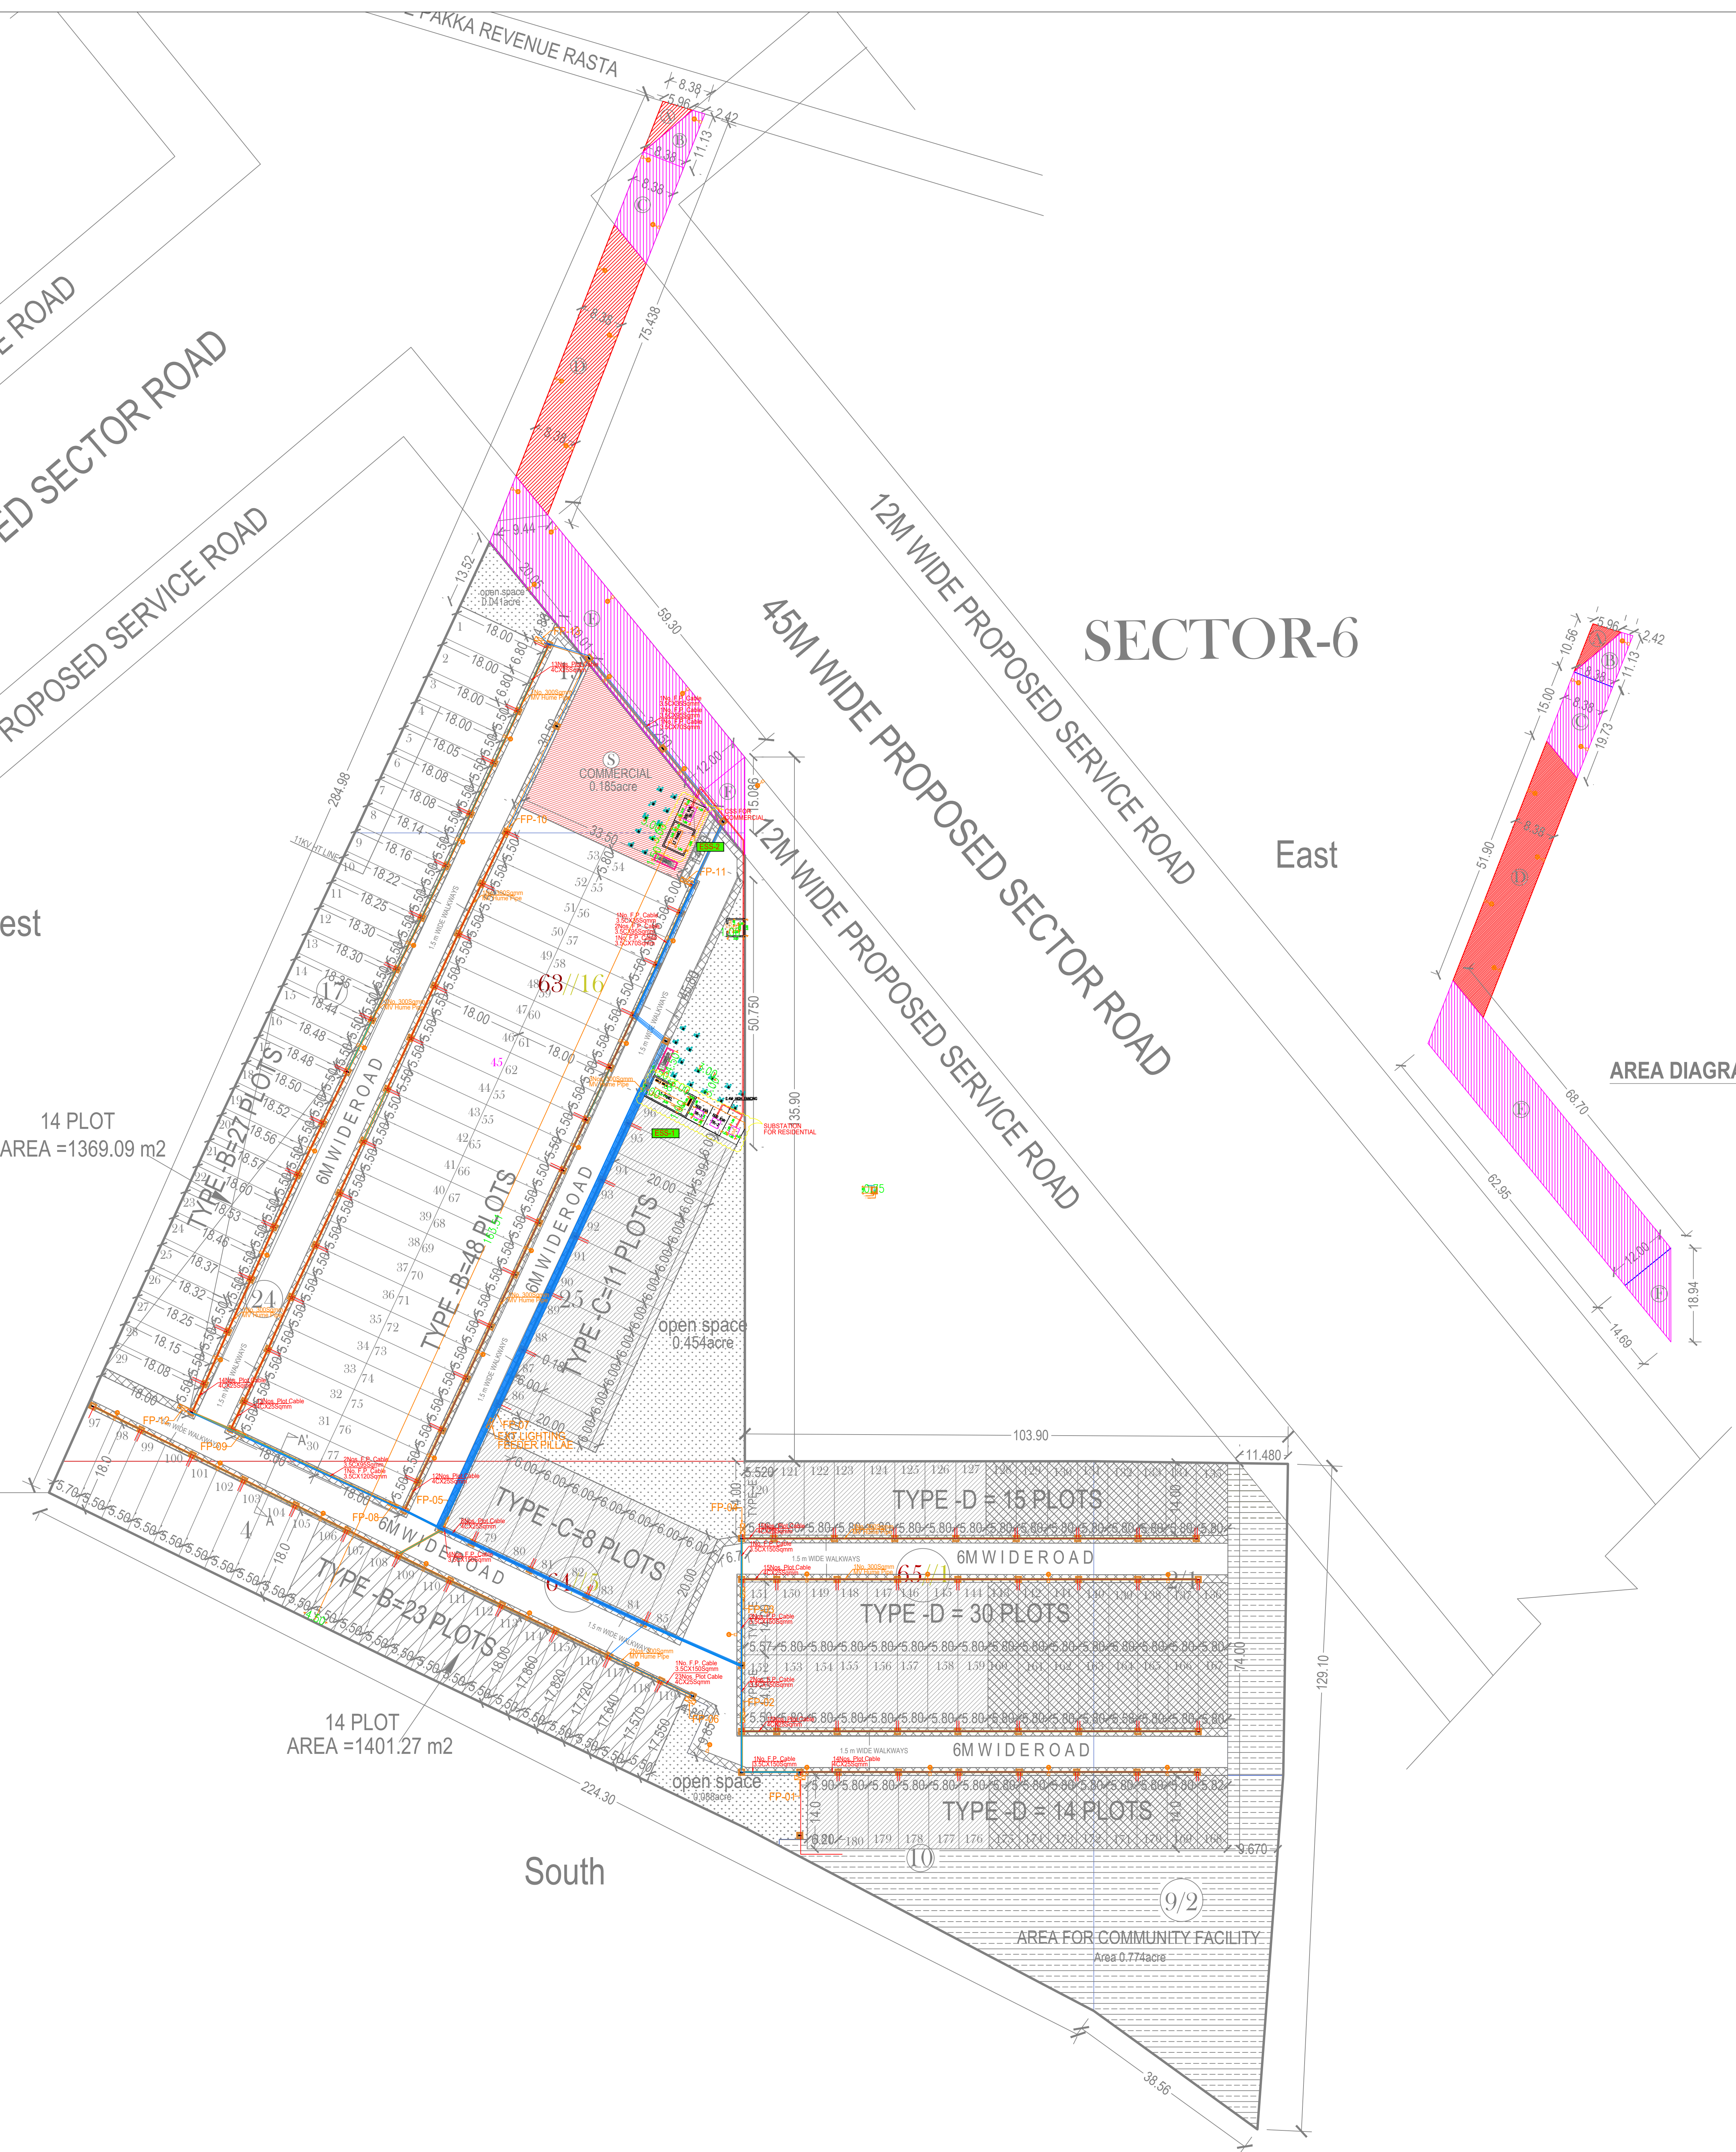

PROJECT TITLE:
RESIDENTIAL PLOTTED COLONY
SECTOR-5, PATAUDI,
DISTRICT GURUGRAM, HARYANA

CLIENT: KSD BUILTECH PVT. LTD
Address: SCO-35, SECTOR-15 PART-II HUDA
MARKET GURGAON HR 122001

SIGN: DATE:

ARCHITECTS
I.S.B.E CONSULTING INC.
INTEGRATED STRATEGIC BUSINESS EXECUTION
403, 2nd FLOOR, PILLAR NO.119, GHITORNI,
M.G. ROAD, NEW DELHI-30
Web-site: www.Isbe.com
Email: isbeconsulting@gmail.com
Mob No: +9818023948/011-26502421

SIGN: DATE:

DRAWING TITLE:
SITE PLAN - ELECTRICAL LAYOUT

SCALE:	SCALE	DRAWN:	DRAWNBY:
DATE:	DATE	CHECKED:	CHECKED
PROJECT NO:	PRJTNO	DRAWING NO:	DRAWINGNO.
REVISION NO:	-	REVISION DATE:	-
FILENAME:	FILENAME		

WORKING DRAWING