

NOTES :-
ALL DIMENSIONS ARE IN MILLIMETERS

PUBLIC HEALTH LEGEND

- 100 MM DIA SW PIPE
- 100 MM DIA SV PIPE
- 75 MM DIA AS PIPE
- 100 MM DIA RW PIPE
- DW RISER
- FW RISER
- DW SUPPLY
- FW SUPPLY

PROJECT :-

Proposed
Group Housing
at Sector-99-A,
Gurgaon

JOB TITLE :-

PROPOSED BUILDING PLAN OF
GROUP HOUSING. MEASURING
10.5875 ACRES (LICENCE NO.
10 OF 2013 DATED
13/3/2013) IN SECTOR-99-A,
GURGAON, HANESAR URBAN
COMPONENT BEING DEVELOPED
BY MONEX INFRASTRUCTURE
PVT. LTD.
LC 2753


CLIENT :-

MONEX
INFRASTRUCTURES
PVT. LTD.

DRAWING TITLE :-

COMMUNITY BUILDING
PLANS, SECTIONS &
ELEVATIONS

SCALE : 1:100

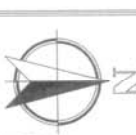

DATE : 4th April, 2013

SHEET NO.

21


DRAWN BY:

LCTEAM


AJ. SANJAY JETHI
ARCHITECT
OWNER

AJ. SANJAY JETHI
CORPORATE ARCHITECTURE
INTERIORS & PROJECT MANAGEMENT


407 GDITL NORTHLEX TOWER-A-09
NETAJI SUBHASH PLACE, PITAM PURA
NEW DELHI - 110034, INDIA
TEL. 9811205100 011-27364056 011-42470000
EMAIL :- linet, concept@ajethi.com
WEBSITE :- www.linetoconcept.in

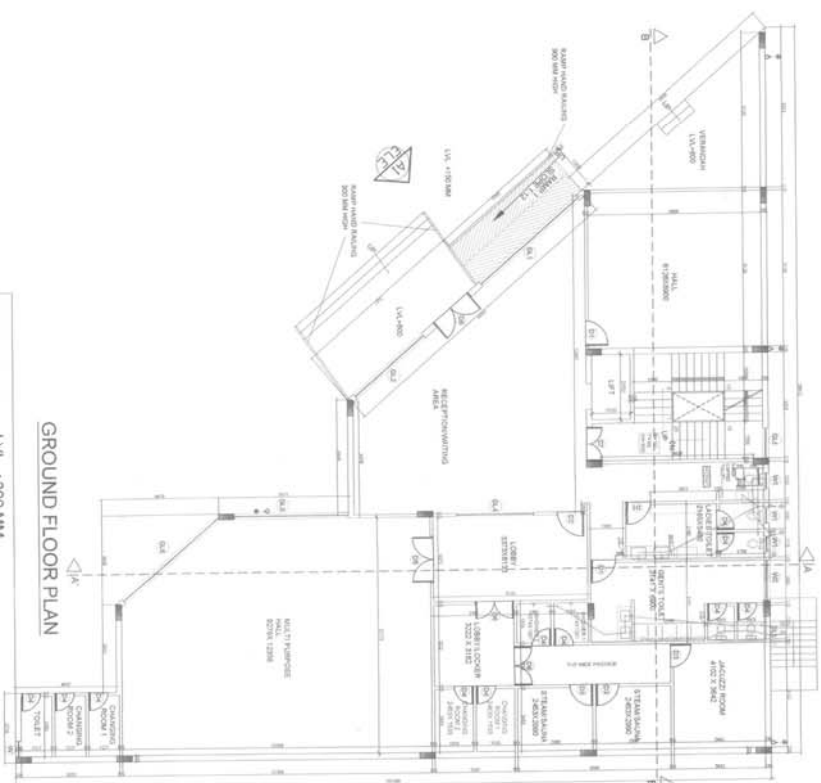

GROUND FLOOR PLAN

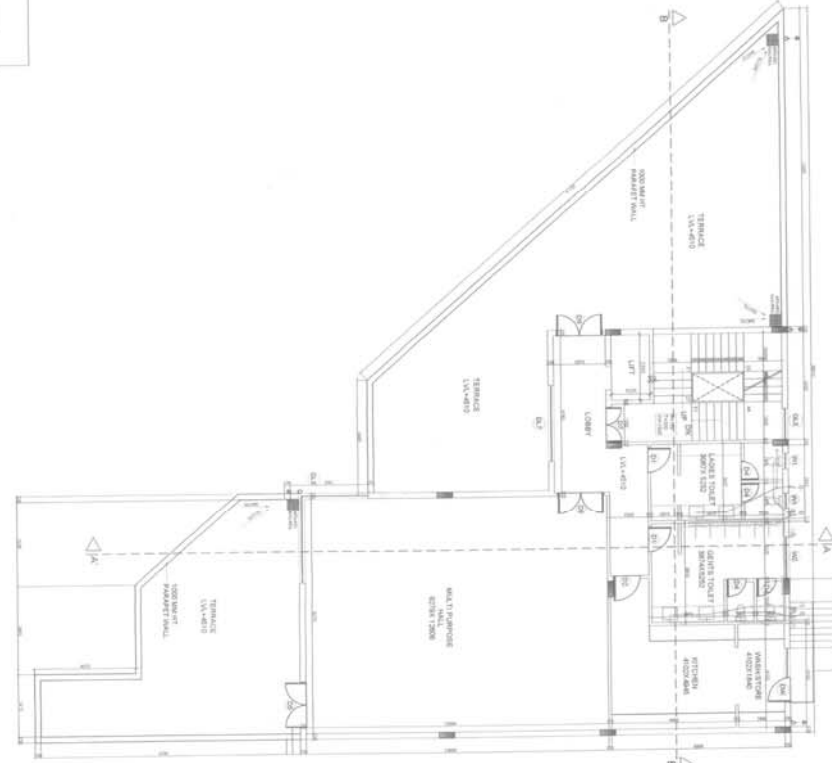

FIRST FLOOR PLAN

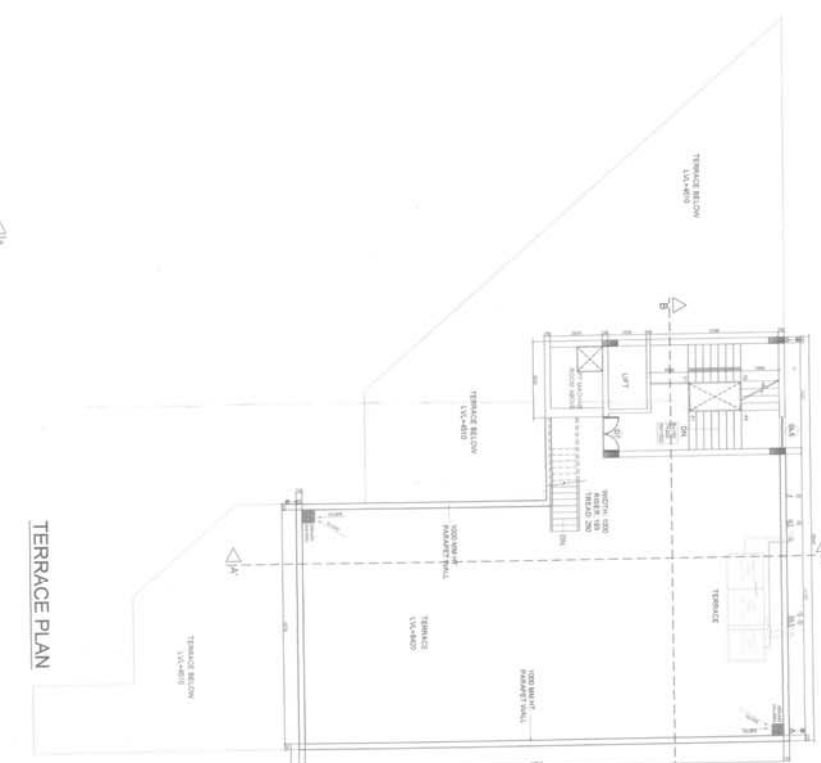


TERRACE PLAN




SWIMMING POOL
LVL -1350 MM



SECTION A-A

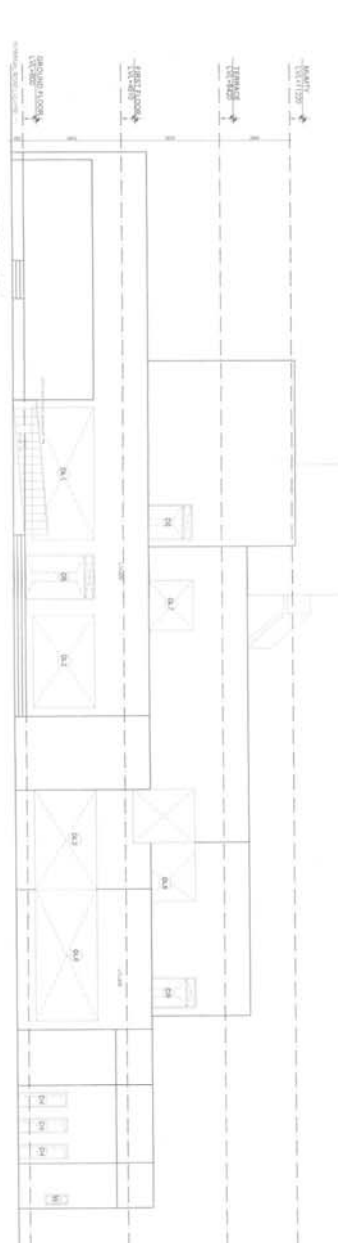

ELEVATION A1

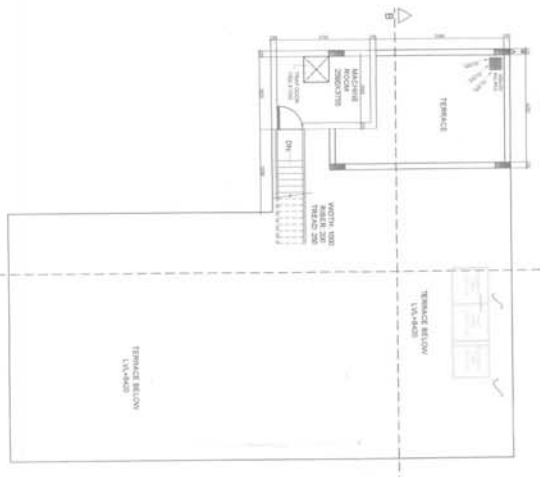

MULTY FLOOR PLAN

NAME	SIZE	Q/L LVL	UNTEL LVL
DW	2147 X 2200	1950	2750
D1	987 X 2100	—	2100
D2	1087 X 2100	—	2100
D3	800 X 2100	—	2100
D4	787 X 2100	—	2100
D5	1840 X 2750	—	2750
D6	1840 X 2100	—	2100
D7	1380 X 2100	—	2100
HC/CH	1280 X 2200	—	2200
W	615 X 2100	600	2100
W1	600 X 2200	1500	2200
W2	1610 X 2200	1500	2200
Q/L1	5147 X 2200	300	2750
Q/L2	3887 X 2200	300	2750
Q/L3	4457 X 2200	300	2750
Q/L4	3087 X 2200	300	2750
Q/L5	1227 X 2200	300	2750
Q/L6	5156 X 2200	300	2750
Q/L7	3000 X 2200	300	2750
Q/L8	6213 X 2200	300	2750

SANCTIONED
To be used in connection with
Drawing No. S-17-2013 DOW 12/2/13