

NOTES :-
ALL DIMENSIONS ARE IN MILLIMETERS

PUBLIC HEALTH LEGEND

1	100 MM DIA SW PIPE
2	100 MM DIA SV PIPE
3	75 MM DIA AS PIPE
4	100 MM DIA RW PIPE
5	DW RISER
6	FW RISER
7	DW SUPPLY

DOOR WINDOW SCHEDULE

S.NO.	SIZE	CALL	LINTEL
D1	900X2100	2100	
D2	750X2100	2100	
DW1	3020X2300	2300	
DW2	2848X2300	2300	
DW3	1628X2300	2300	
DW4	1083X2300	2300	
W1	1050X2300	300	2300
W2	1200X1050	1050	2300
W3	813X1250	1050	2300
W4	613X800	1500	2300

PROJECT :-

Proposed
Group Housing
at Sector-99-A,
Gurgaon

JOB TITLE :-

PROPOSED BUILDING PLAN OF
GROUP HOUSING SCHEME
MEASURING 10.5875 ACRES
(LICENCE NO. 10 OF 2013
DATED 12/3/2013)
IN SECTOR-99-A, GURGAON
MANESAR URBAN COMPLEX
BEING DEVELOPED BY MONEX
INFRASTRUCTURE PVT. LTD.
LC 2753

CLIENT:-

MONEX
INFRASTRUCTURES
PVT. LTD.

DRAWING TITLE :-
TOWER - F
2 BEDROOM BLOCK
PLANS

SCALE: 1:100



DATE: 4th April 2013


2% > 4.4.3

SHEET NO.
15
DRAWN BY:
LC TEAM


OWNER
A/C SANJAY LEHI
ARCHITECT
A/C SANJAY LEHI
OWNER

LINEAR CONCEPTS
CORPORATE ARCHITECTURE
INTERIORS & PROJECT MANAGEMENT
407 GD/TL, NORTH-EX TOWER-A-09
NETAJI SUBHASH PLACE, PITAM PURA
NEW DELHI - 110034, INDIA
TEL: 9811205100, 011-27954068, 011-42470300
EMAIL: > linear_concepts@yahoo.com
WEBSITE: > www.linearconcepts.in

2ND TO 19TH FLOOR PLAN

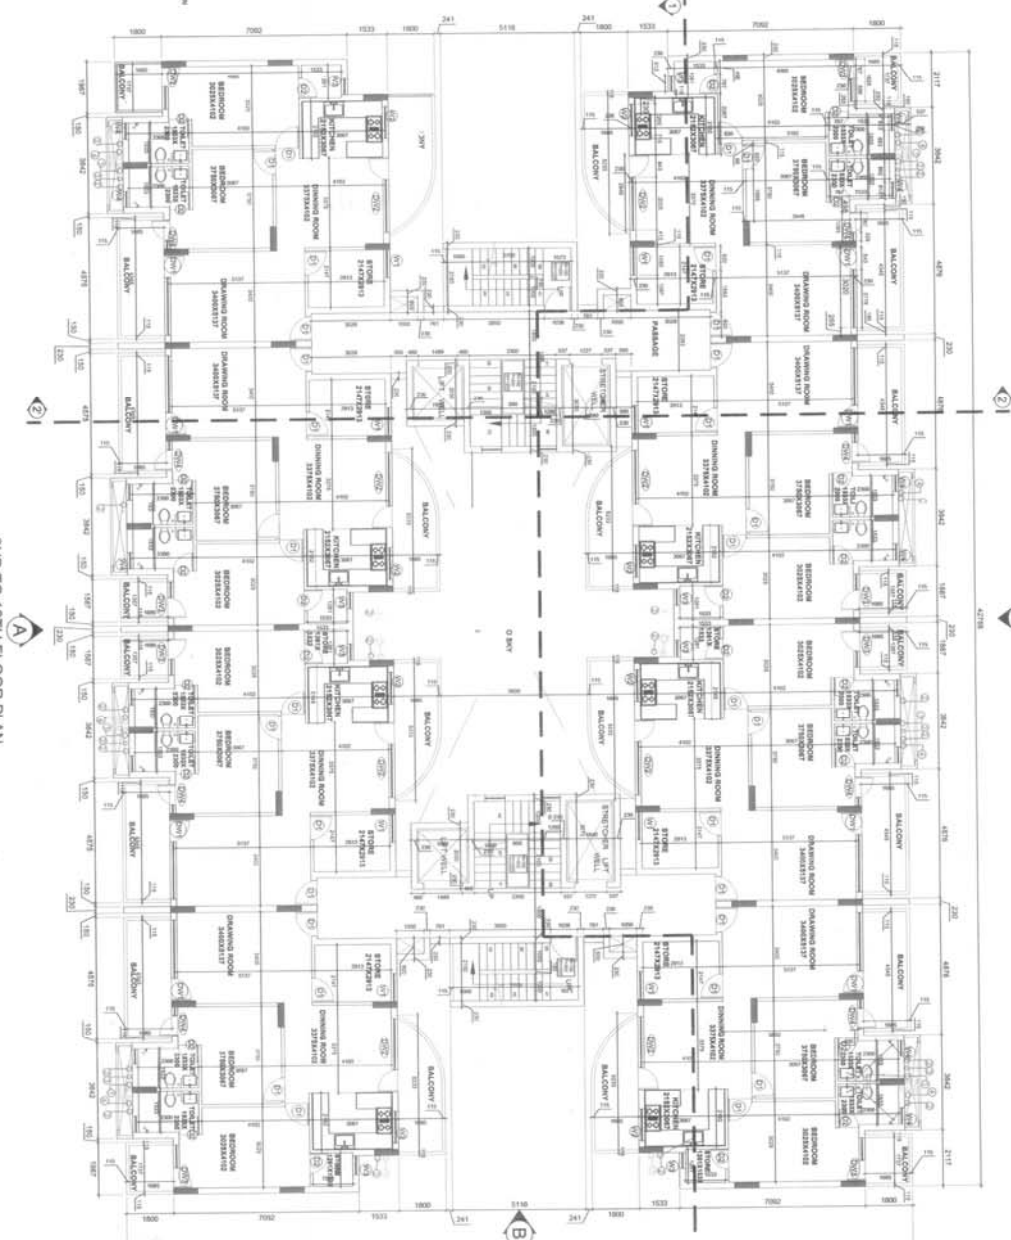

STILT FLOOR PLAN
NO. CARS PARKING=2

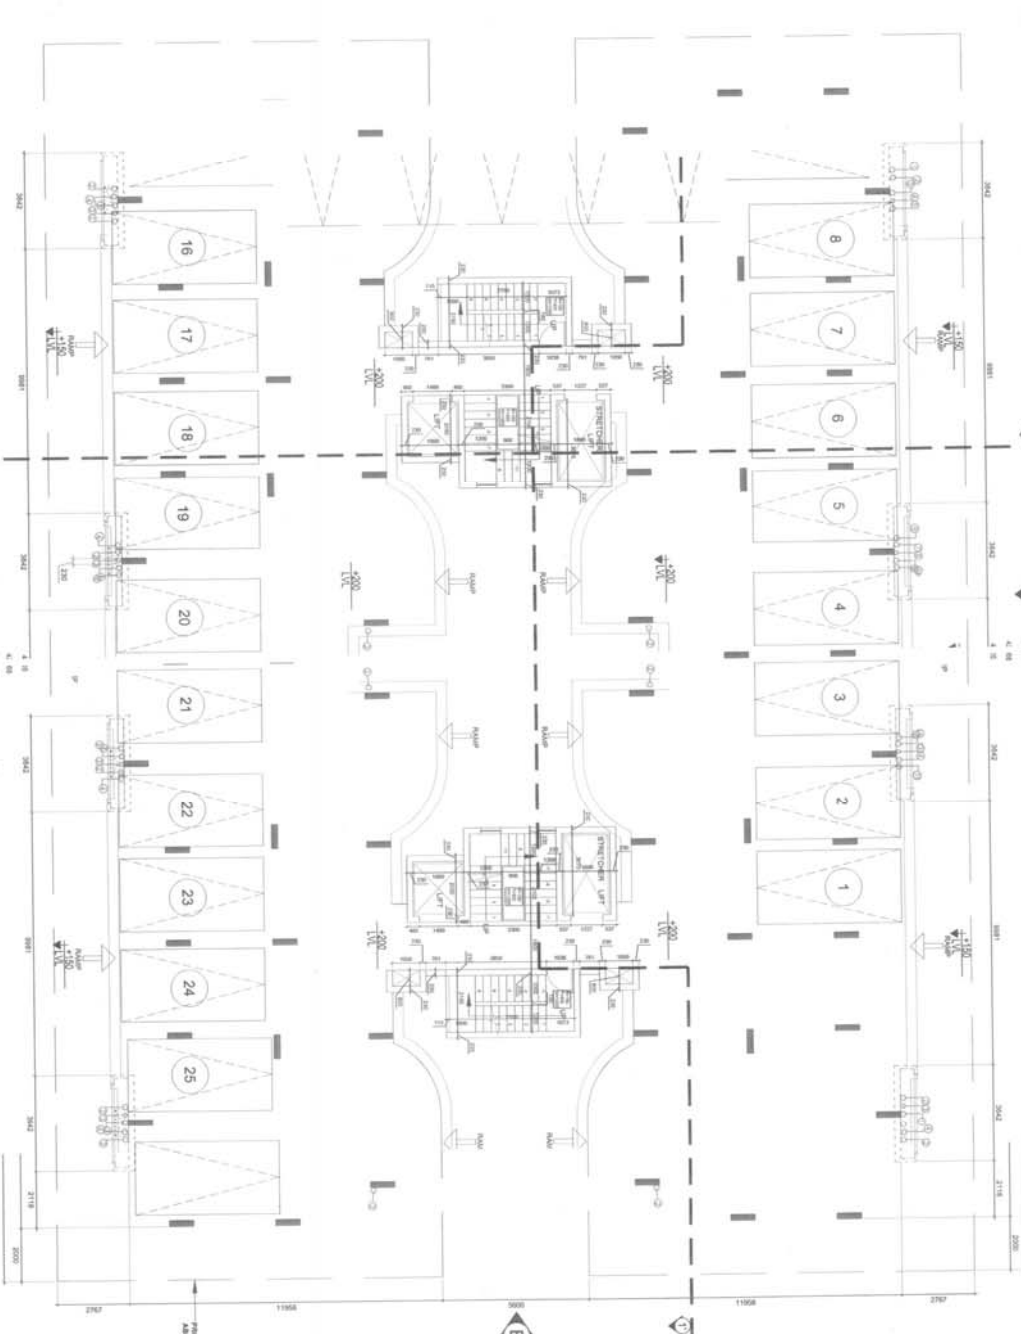

1ST FLOOR PLAN

