

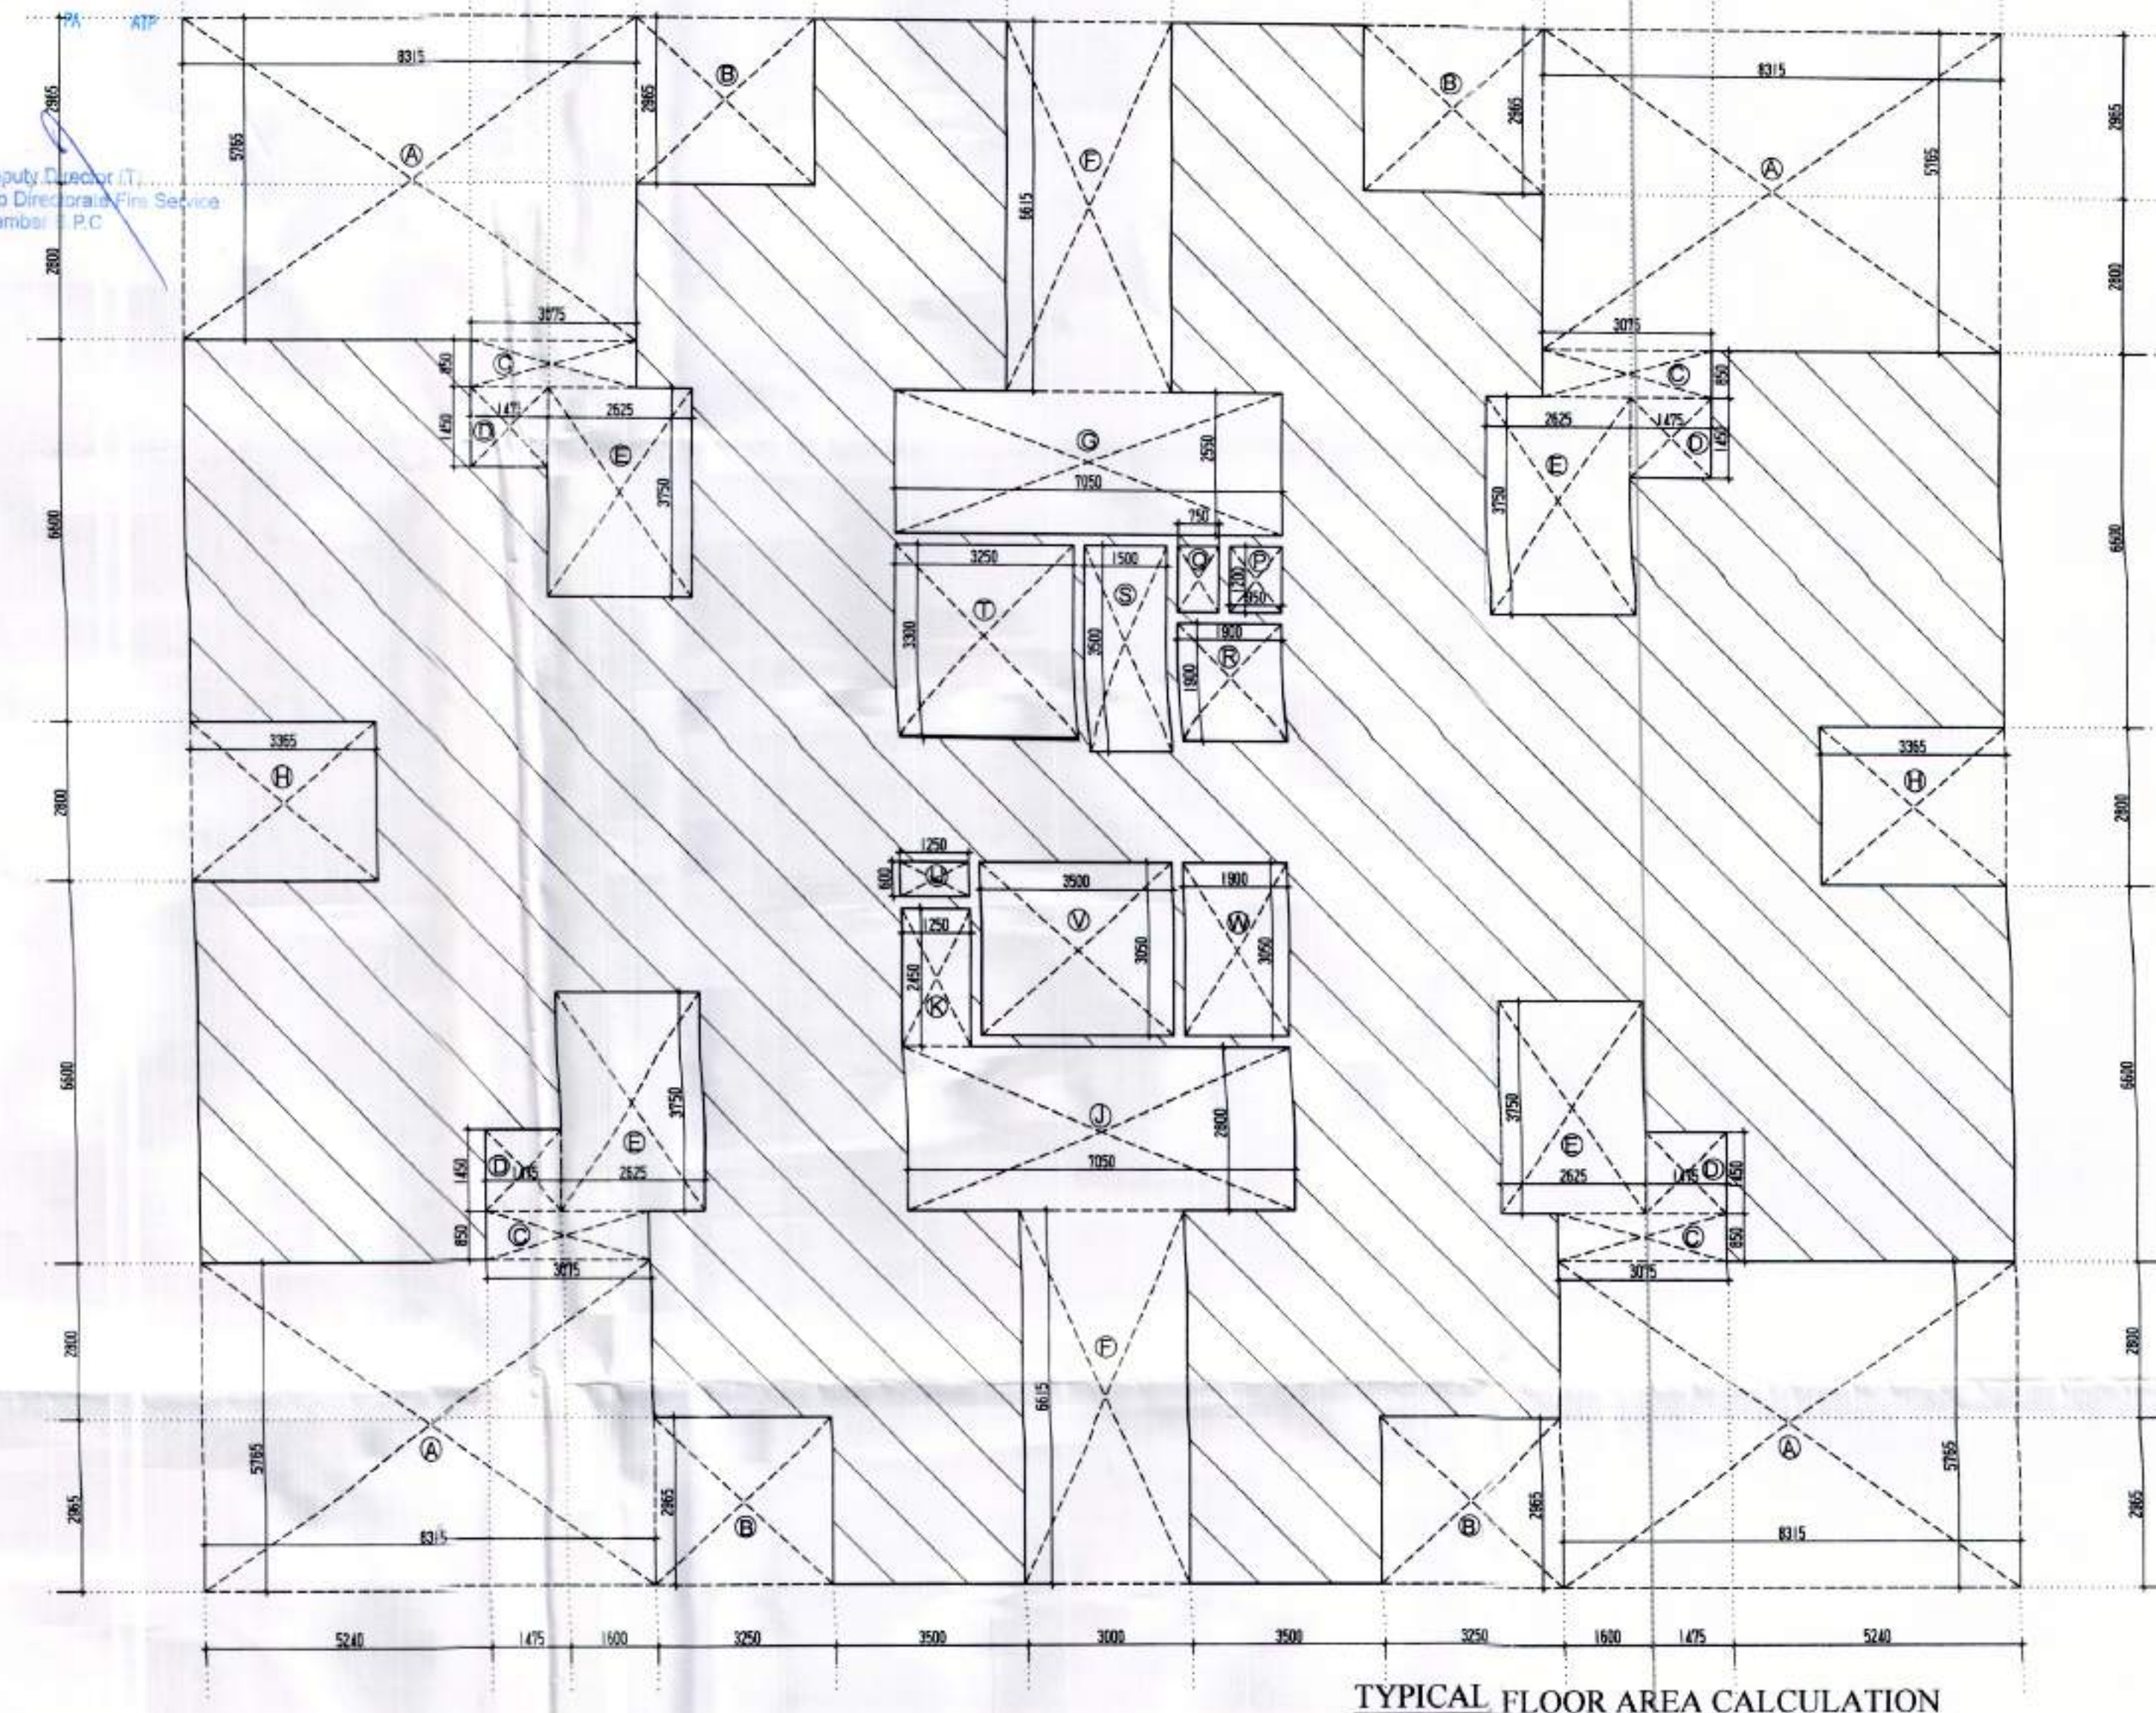


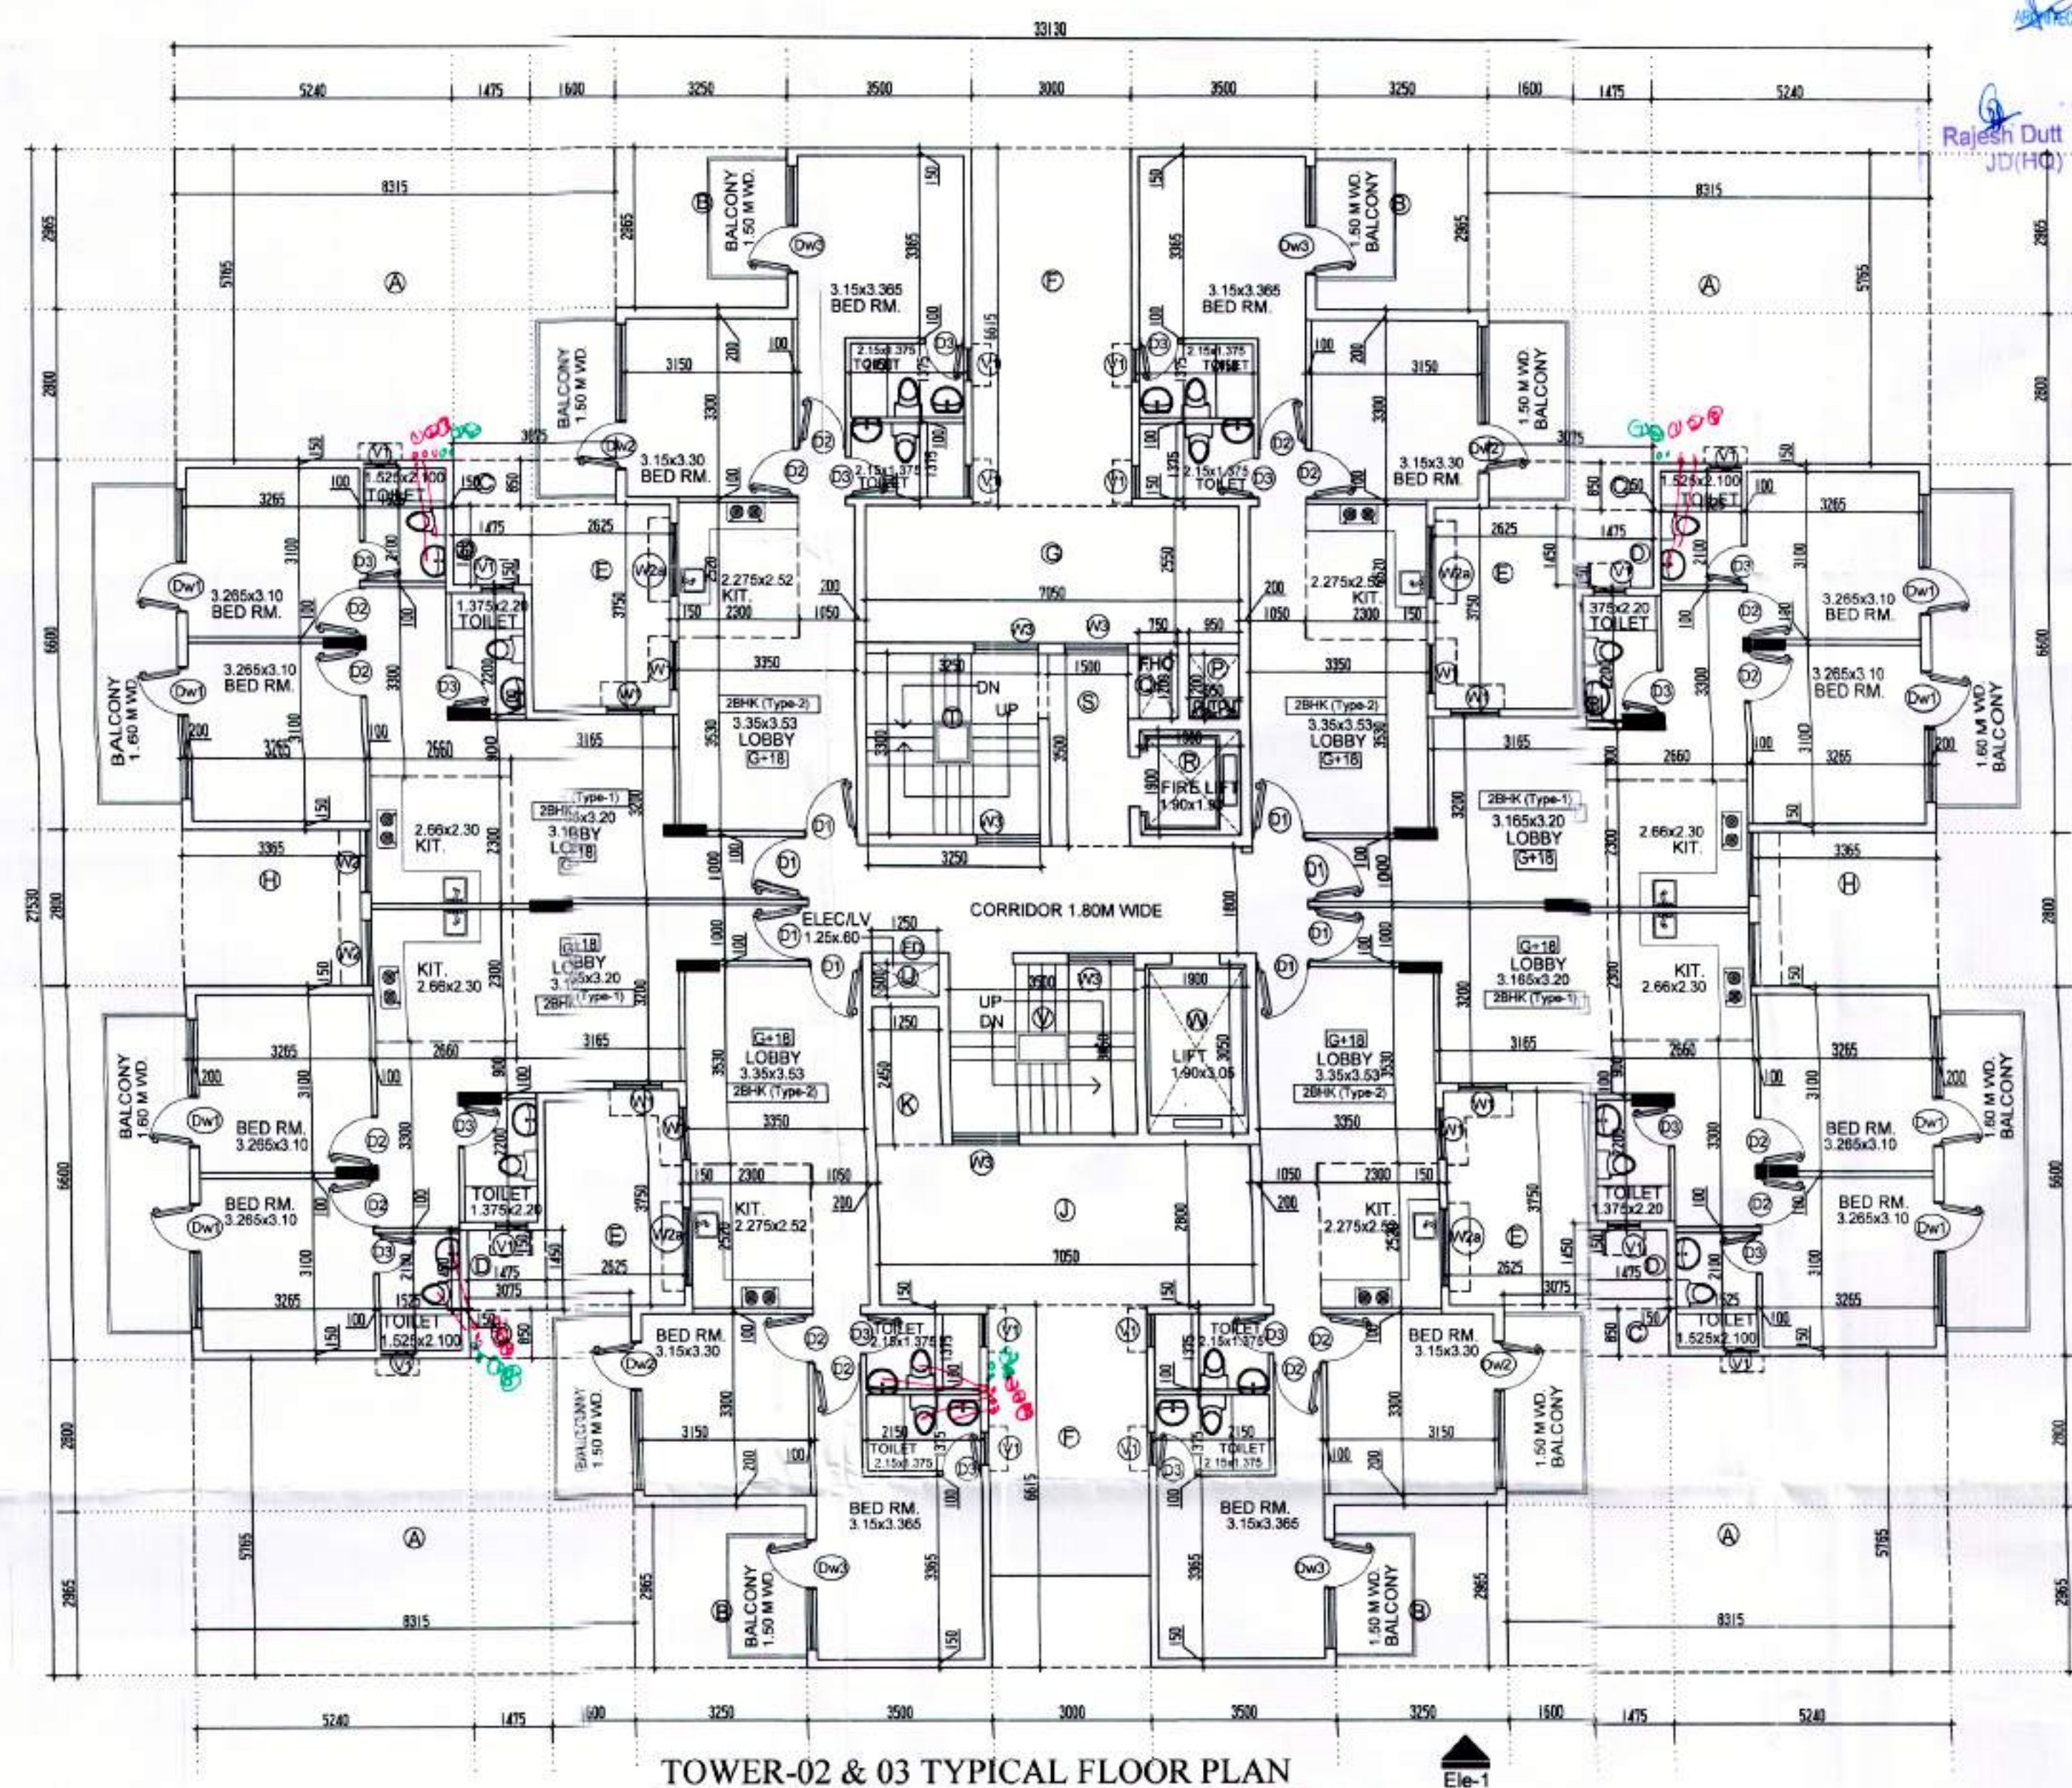


2BHK - TYPE-1 UNIT CARPET AREA DETAIL						
ADDITION						
LABEL	GEOMETRY	NOS.	L	X	W	AREA
1	RECTANGLE	1	2.450	X	1.000	2.450
2	RECTANGLE	1	5.825	X	3.200	18.640
3	RECTANGLE	1	3.000	X	2.300	6.900
4	RECTANGLE	1	1.525	X	2.300	3.508
5	RECTANGLE	1	3.365	X	6.300	21.200
6	RECTANGLE	2	0.200	X	0.900	0.360
TOTAL ADDITION						53.057
TOTAL UNIT 2BHK - TYPE -1 CARPET AREA						53.057


2BHK - TYPE-2 UNIT CARPET AREA DETAIL						
ADDITION						
LABEL	GEOMETRY	NOS.	L	X	W	AREA
1	RECTANGLE	1	1.000	X	0.100	0.100
2	RECTANGLE	1	3.350	X	6.150	20.603
3	RECTANGLE	2	0.200	X	0.900	0.360
4	RECTANGLE	1	6.400	X	3.300	21.120
5	RECTANGLE	1	3.150	X	3.015	9.497
TOTAL ADDITION						51.680
TOTAL UNIT TYPE -2BHK - TYPE- 2 CARPET AREA						51.680

TOWER- 02, 03 1ST-16TH FLOOR F.A.R. AREA DETAIL. (C)					
ADDITION					
AREA OF GROUND COVERAGE					524.081
TOTAL ADDITIONS					524.081
DEDUCTION					
LABEL	GEOMETRY	NOS	L1	W	AREA
P	RECTANGLE	1	0.950 X	1.200	1.140
Q	RECTANGLE	1	0.750 X	1.200	0.900
R	RECTANGLE	1	1.900 X	1.900	3.610
S	RECTANGLE	1	1.500 X	3.500	5.250
T	RECTANGLE	1	3.250 X	3.300	10.725
U	RECTANGLE	1	1.250 X	0.600	0.750
V	RECTANGLE	1	3.500 X	3.050	10.675
W	RECTANGLE	1	1.900 X	3.050	5.795
TOTAL DEDUCTIONS					38.545
TYPICAL FLOOR AREA					485.236

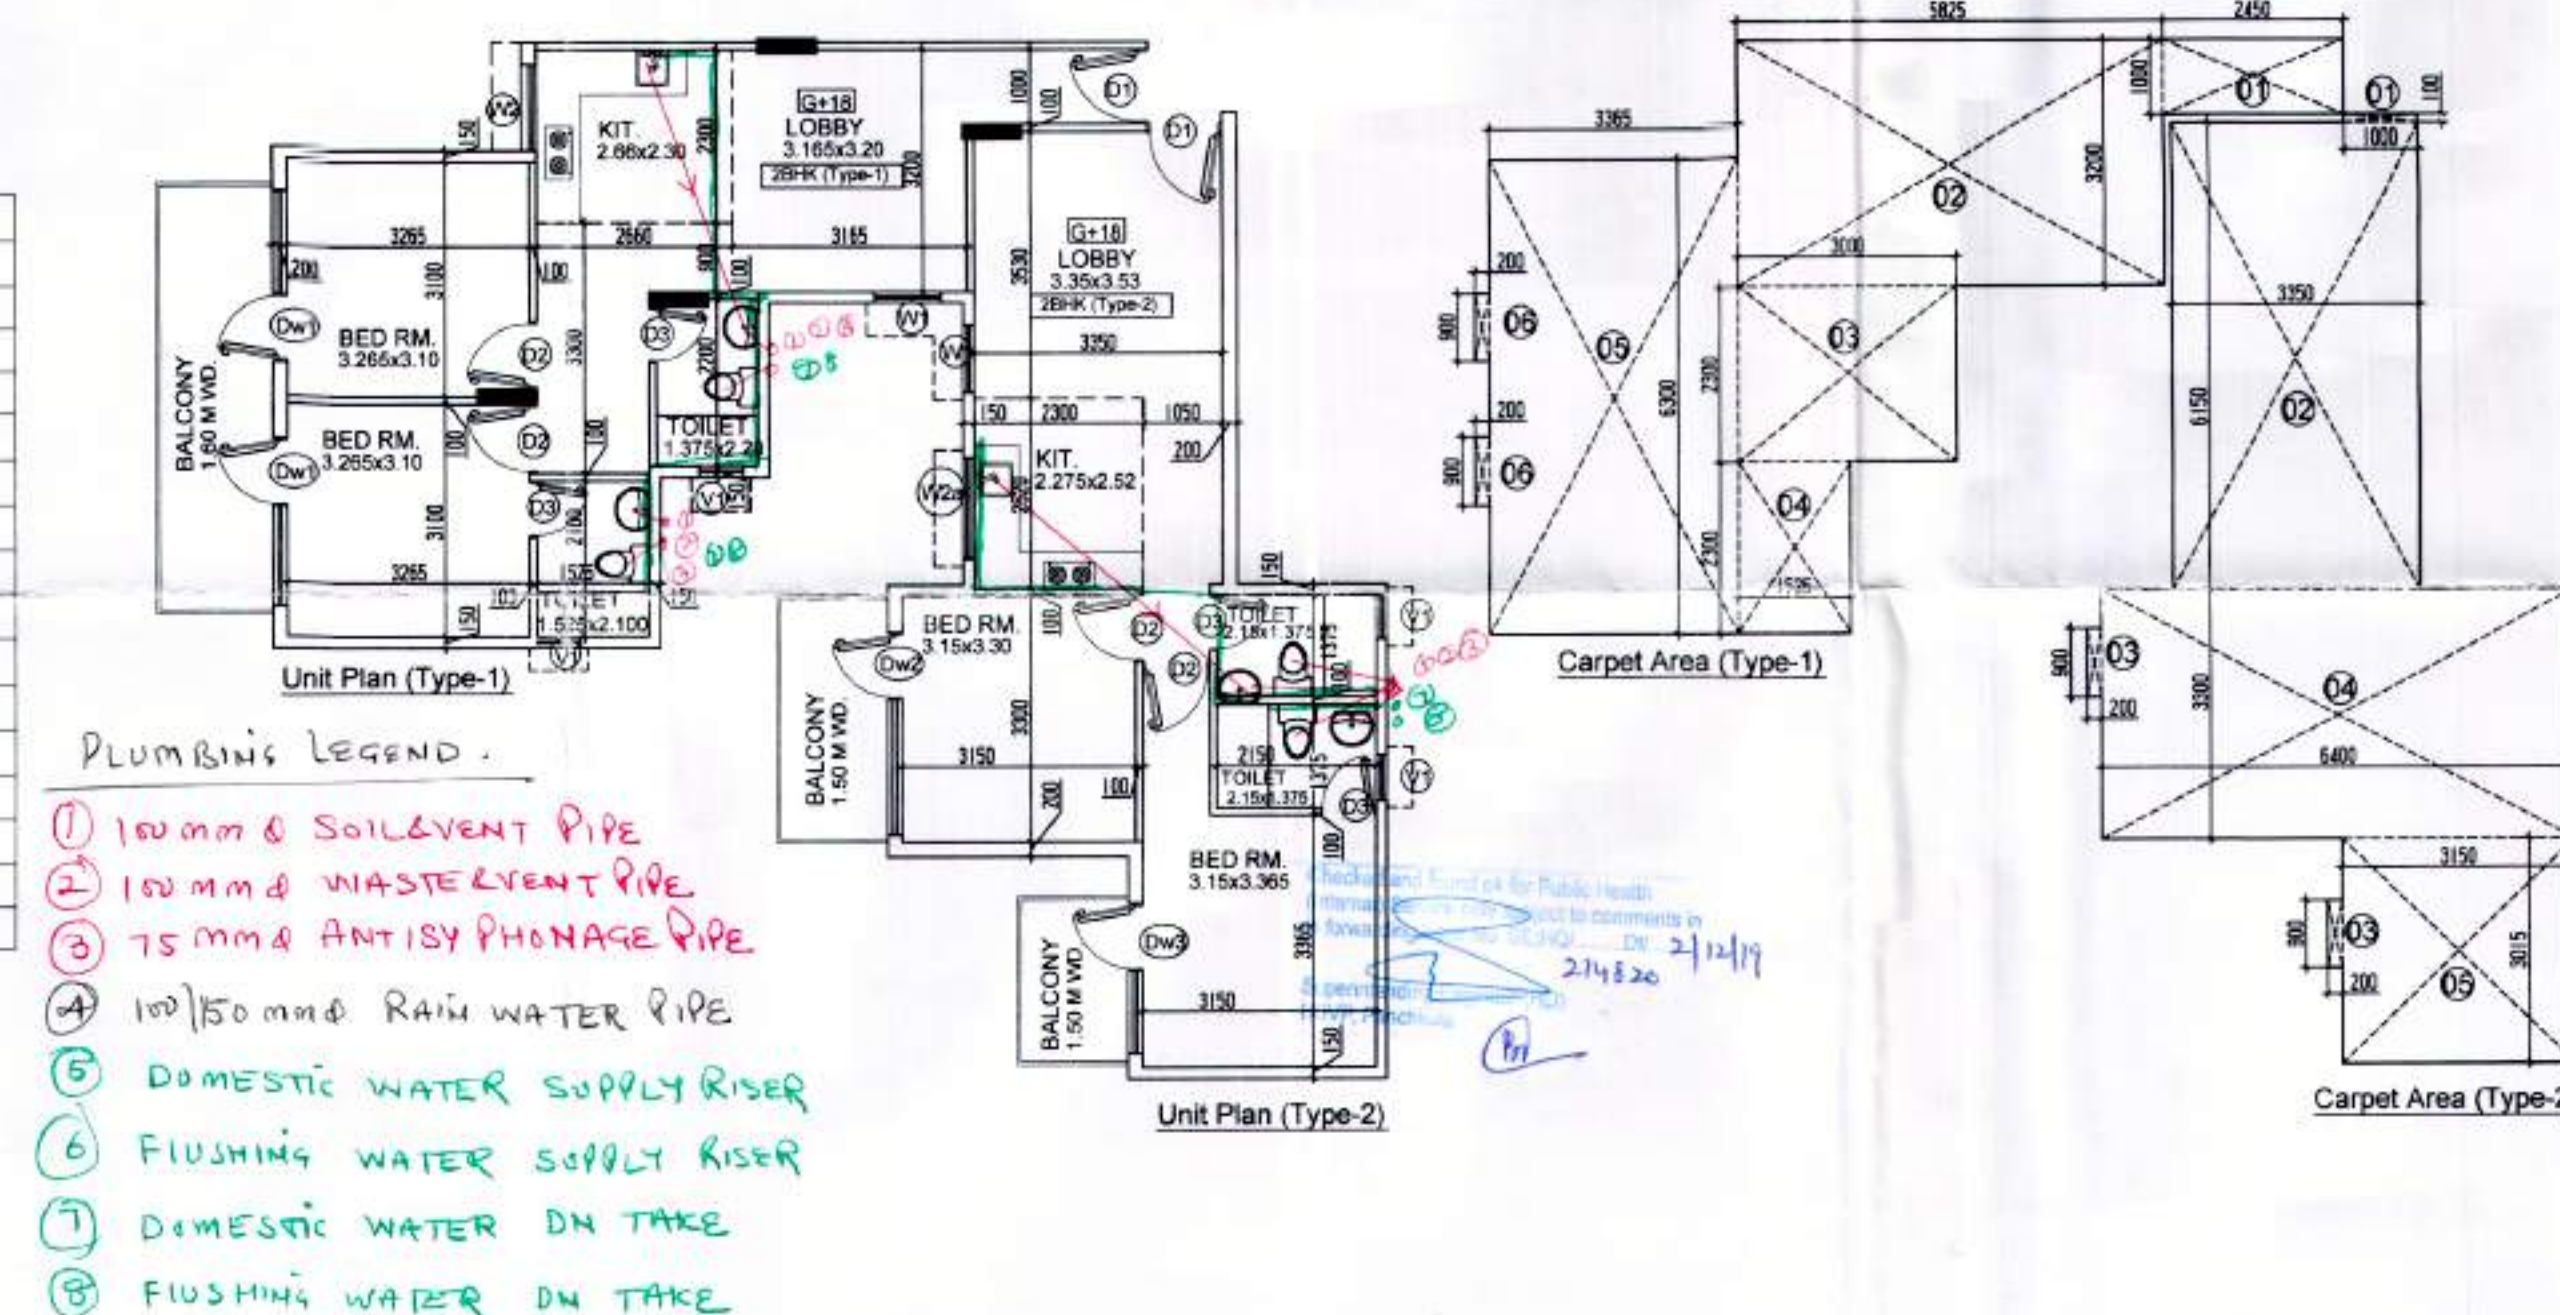

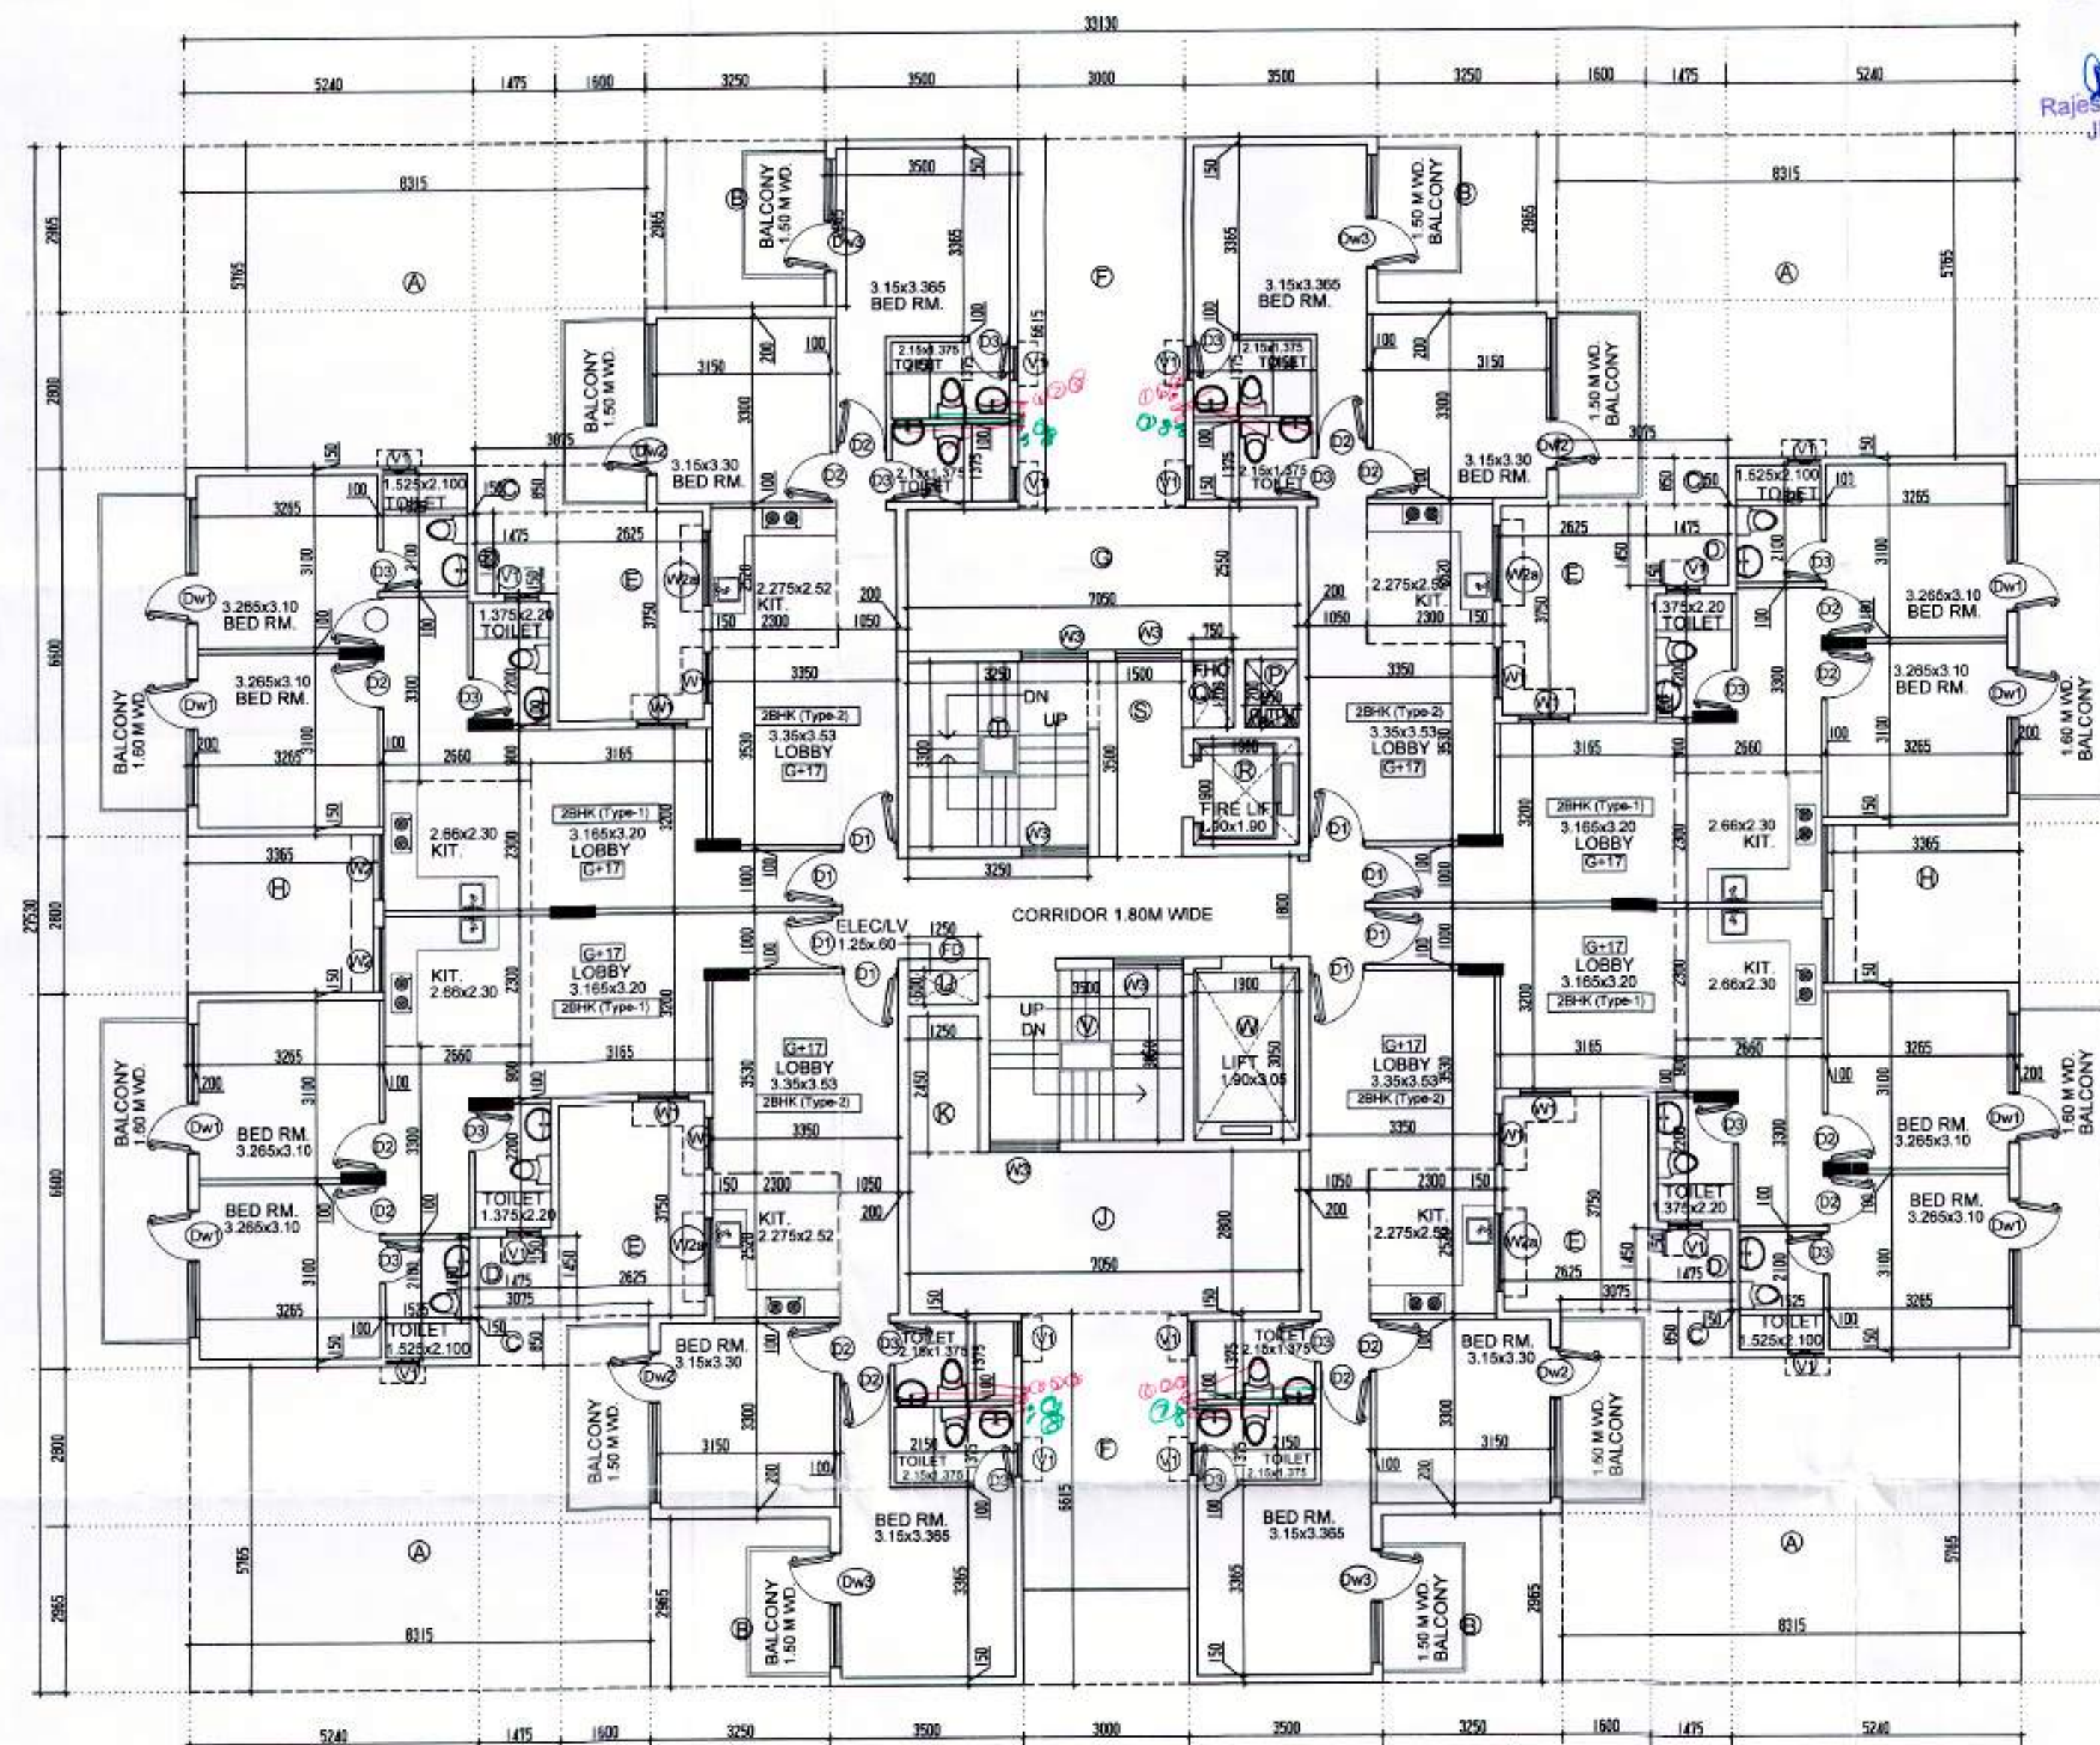

TOWER-04 TYPICAL FLOOR PLAN
1ST-17TH TOILET DETAIL (TYPICAL)


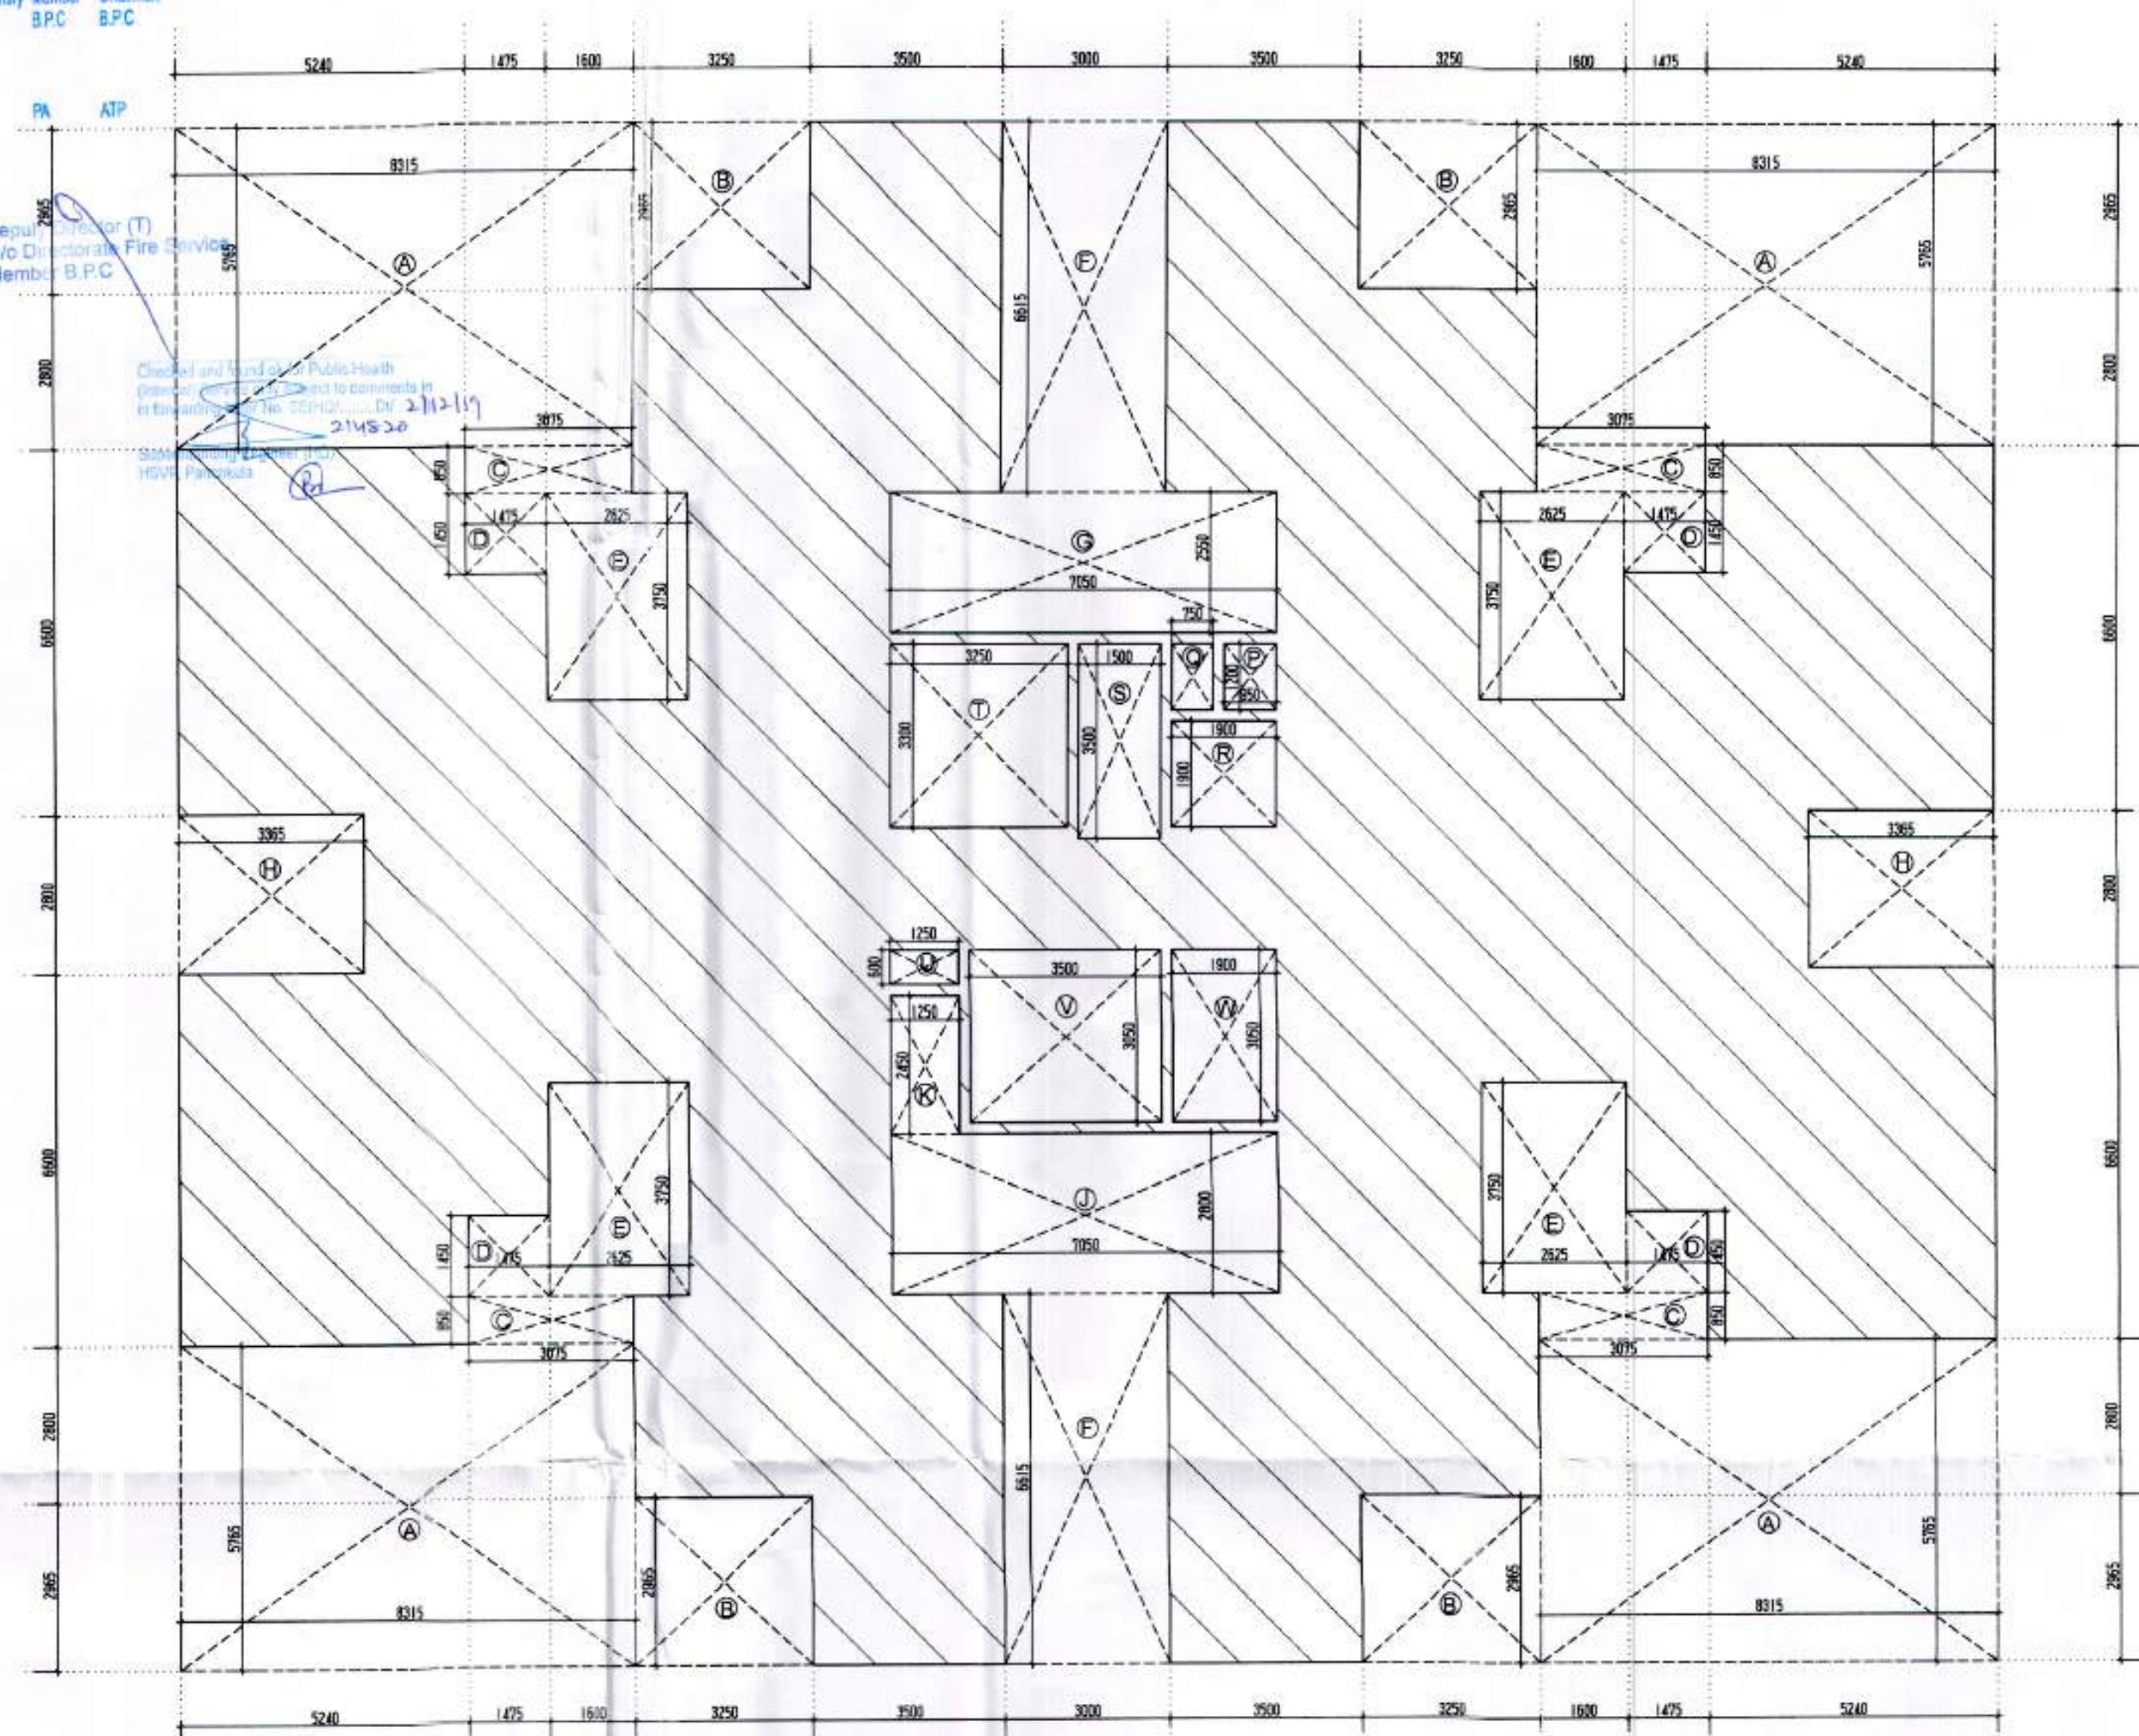


TYPICAL FLOOR AREA CALCULATION
Scale 1:100

2BHK - TYPE-1 UNIT CARPET AREA DETAIL						
ADDITION						
LABEL	GEOMETRY	NOS.	L	X	W	AREA
1	RECTANGLE	1	2.450	X	1.000	2.450
2	RECTANGLE	1	5.825	X	3.200	18.640
3	RECTANGLE	1	3.000	X	2.300	6.900
4	RECTANGLE	1	1.525	X	2.300	3.508
5	RECTANGLE	1	3.365	X	6.300	21.200
6	RECTANGLE	2	0.200	X	0.900	0.360
TOTAL ADDITION						53.057
TOTAL UNIT 2BHK - TYPE -1 CARPET AREA						53.057

2BHK - TYPE-2 UNIT CARPET AREA DETAIL						
ADDITION						
LABEL	GEOMETRY	NOS.	L	X	W	AREA
1	RECTANGLE	1	1.000	X	0.100	0.100
2	RECTANGLE	1	3.350	X	6.150	20.603
3	RECTANGLE	2	0.200	X	0.900	0.360
4	RECTANGLE	1	6.400	X	3.300	21.120
5	RECTANGLE	1	3.150	X	3.015	9.497
TOTAL ADDITION						51.880
TOTAL UNIT TYPE -2BHK - TYPE-2 CARPET AREA						51.880

TOWER-04 1ST-17TH FLOOR F.A.R. AREA DETAIL (C)						
ADDITION						
AREA OF GROUND COVERAGE						534.061
TOTAL ADDITIONS						534.061
DEDUCTION						
LABEL	GEOMETRY	NOS.	L	X	W	AREA
P	RECTANGLE	1	0.950	X	1.200	1.140
Q	RECTANGLE	1	0.750	X	1.200	0.900
R	RECTANGLE	1	1.900	X	1.900	3.610
S	RECTANGLE	1	1.500	X	3.500	5.250
T	RECTANGLE	1	3.250	X	3.300	10.725
U	RECTANGLE	1	1.250	X	0.600	0.750
V	RECTANGLE	1	3.500	X	3.050	10.675
W	RECTANGLE	1	1.900	X	3.050	5.795
2	RECTANGLE	1	0.705	X	10.000	7.050
3	TRIANGLE	0.50	0.586	X	10.000	2.930
TOTAL DEDUCTIONS						48.525
TYPICAL FLOOR AREA						485.236

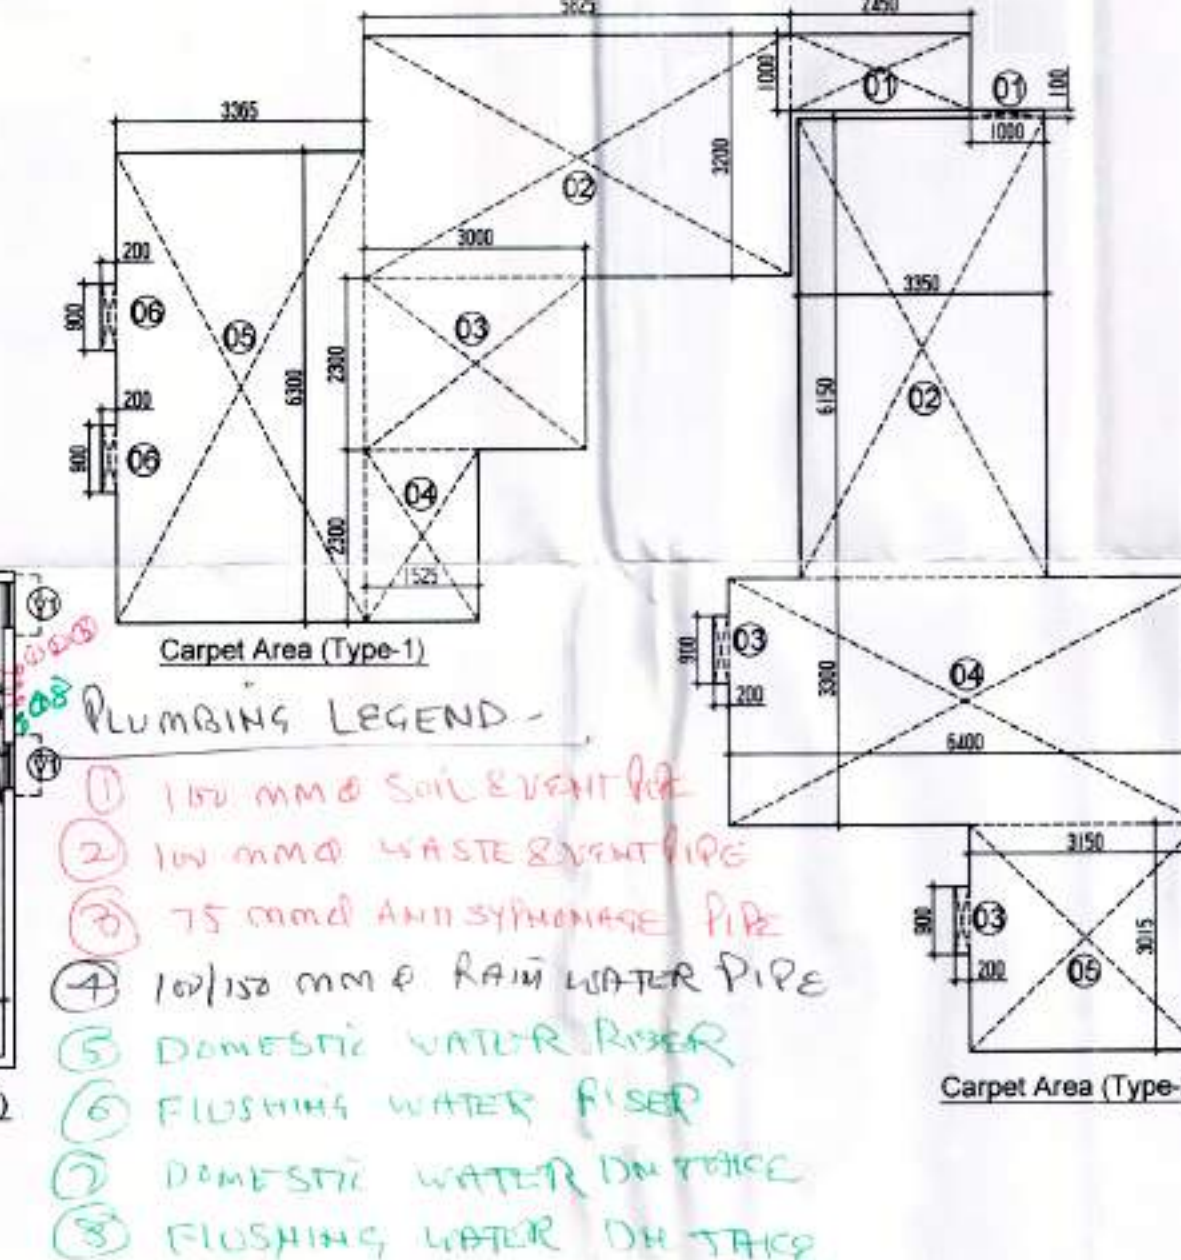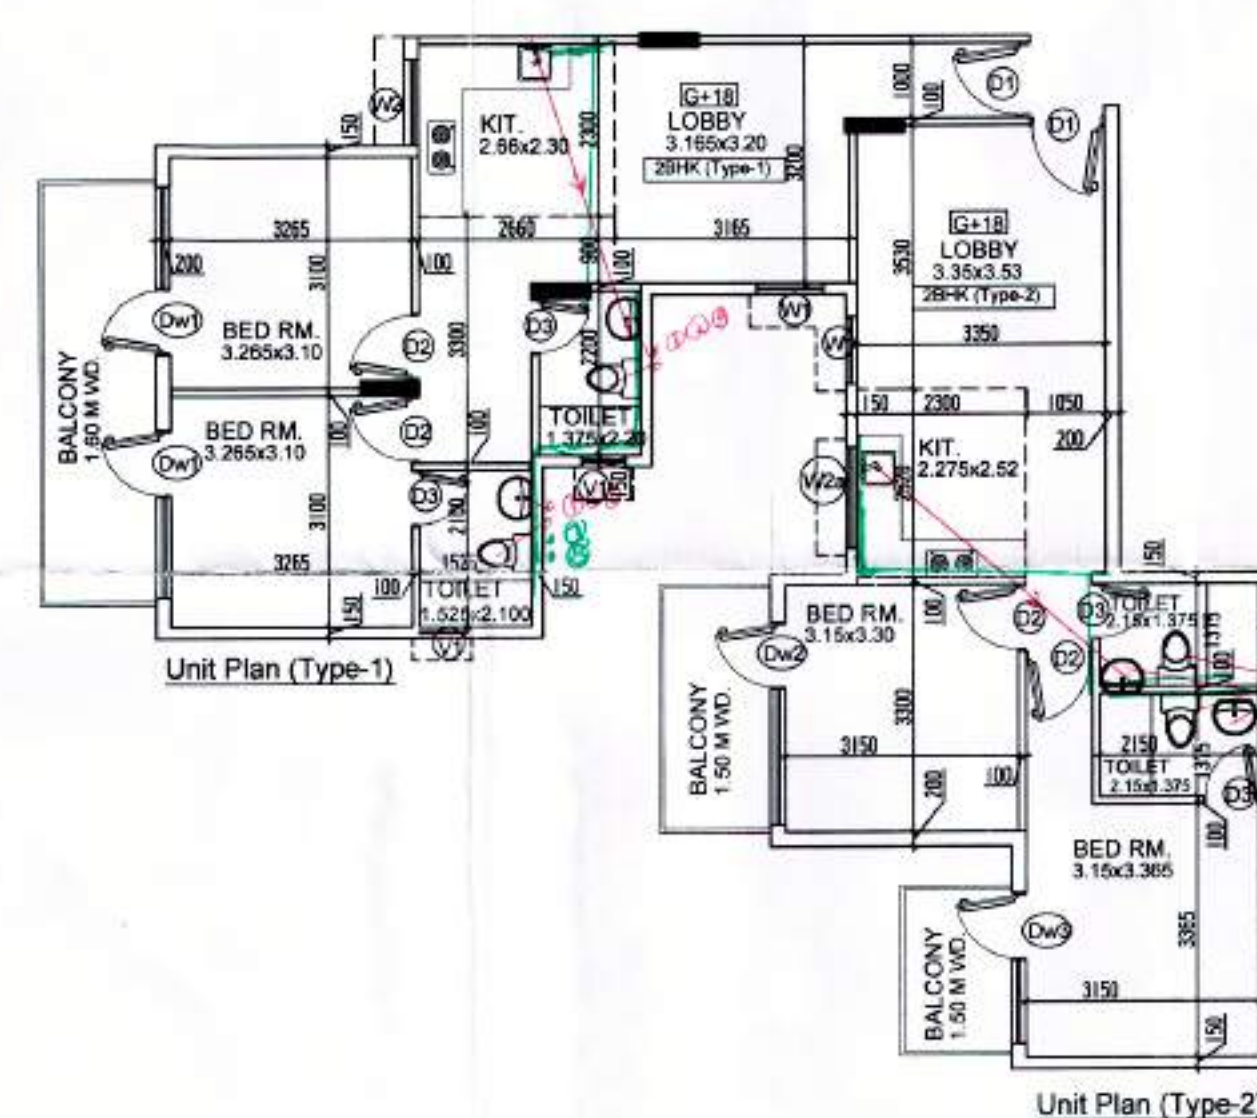

Door Window Schedule				
S. No.	Tag	Size of Opening	Cill. M.	Lin. M.
1	DD	1100X2100	± 000	+ 2100
2	D0	1200X2100	± 000	+ 2100
3	D1	1000X2100	± 000	+ 2100
4	D2	900X2100	± 000	+ 2100
5	D3	750X2100	± 000	+ 2100
6	DW1	2250X2500	000+300	+ 2500
7	DW2	2700X2500	000+300	+ 2500
8	DW3	2100X2500	000+300	+ 2500
9	V1	900X2200	+300	+ 2500
10	V2	1200X1450	+1050	+ 2500
11	V3	1200X1600	+900	+ 2500
12	V1	600X1300	+1200	+ 2500
13	FD	1200X2100		+ 2100
FIRE DOOR				

SIGNATURE OF ARCHITECT

SIGNATURE OF OWNER

ARCHITECT
Ocean Seven Buildtech Pvt. Ltd.
Authorised Signatory

EMBLEM STUDIO
ARCHITECTURE, INTERIORS, PLANNING
619/4 FIRST FLOOR, CHATRAPUR, NEW DELHI - 110074
E-mail : emblemstudio@gmail.com

PROJECT NO:

SCALE 1:100

DRG. NO. : S-4A


DATE : 27-07-19

DRG. TITLE :


Typical Fl. Plan & Area details
(Tower-04)

PROJECT

PROPOSED BUILDING PLAN FOR AFFORDABLE
GROUP HOUSING SCHEME MEASURING 5.088 ACRES
(LICENCE NO. 103 OF 2019 DATED 06/09/2019)
SECTOR-79 GURUGRAM, REVENUE STATE OF VILLAGE
BADSHAHPUR, SECTOR-79 BEING DEVELOPED BY SHRATAN
LAL AND OTHERS IN COLLABORATION WITH OCEAN SEVEN
BUILDTECH PRIVATE LIMITED

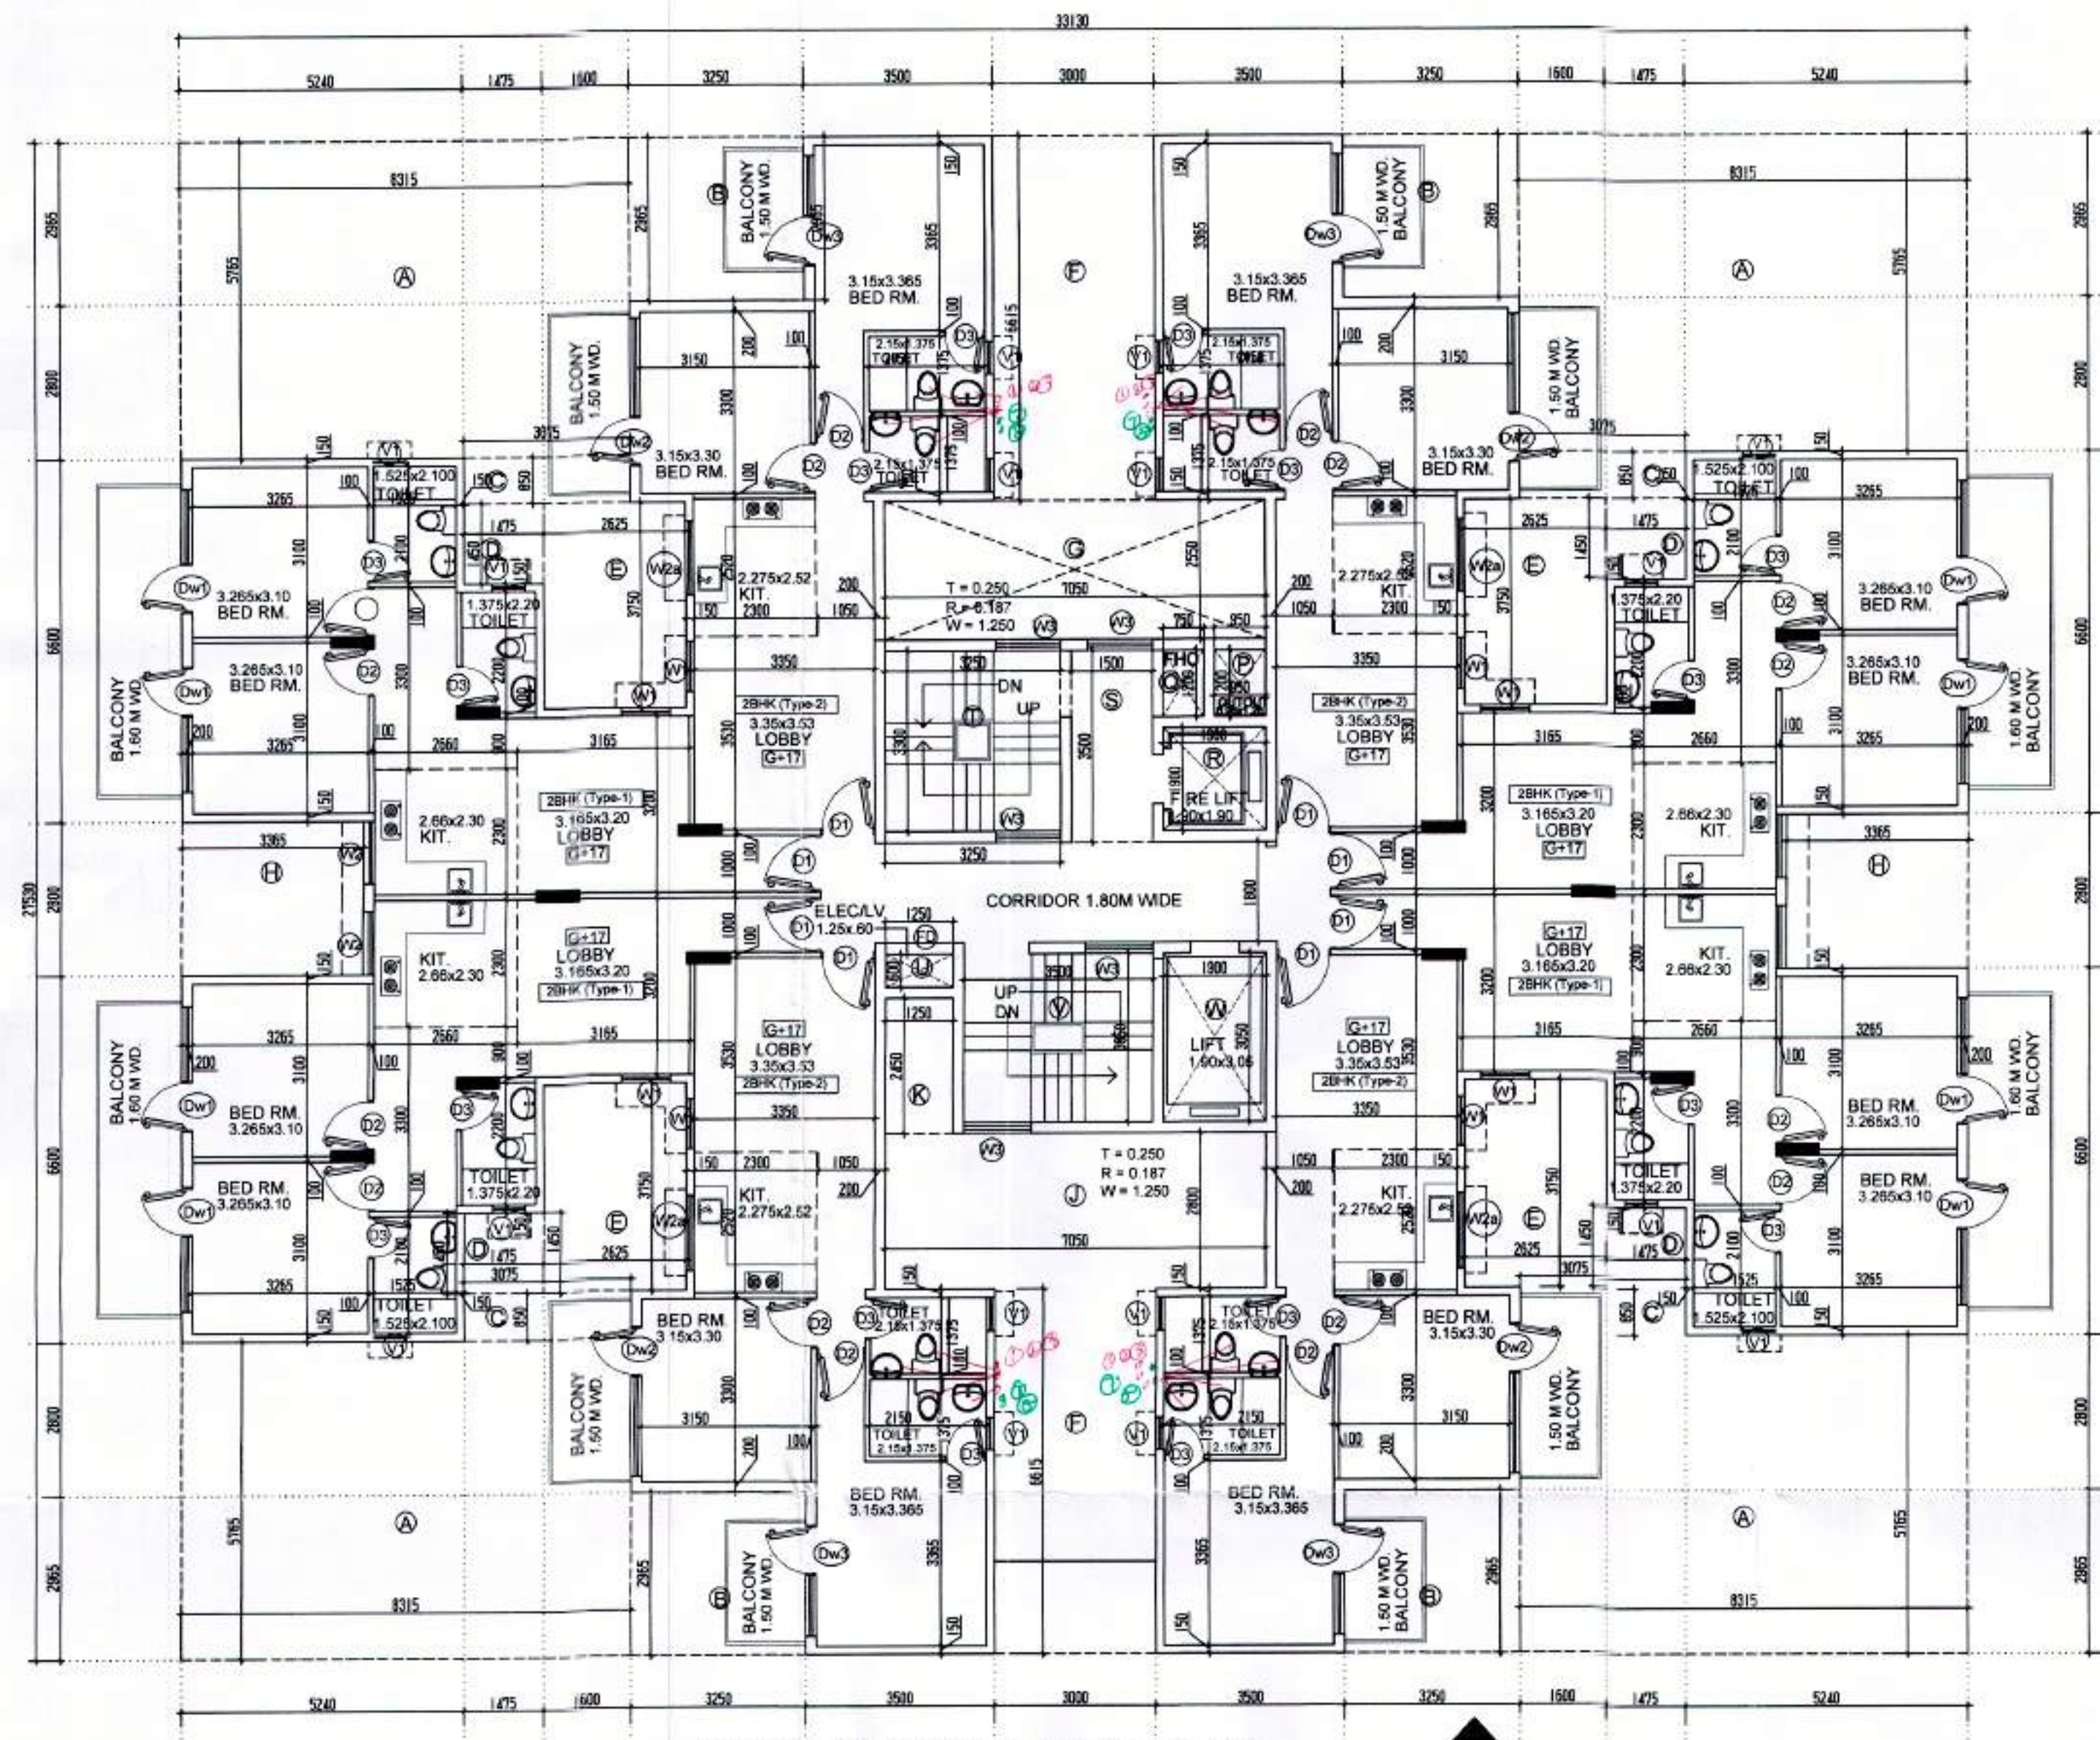

TOWER-05 TYPICAL FLOOR PLAN
1ST-17TH

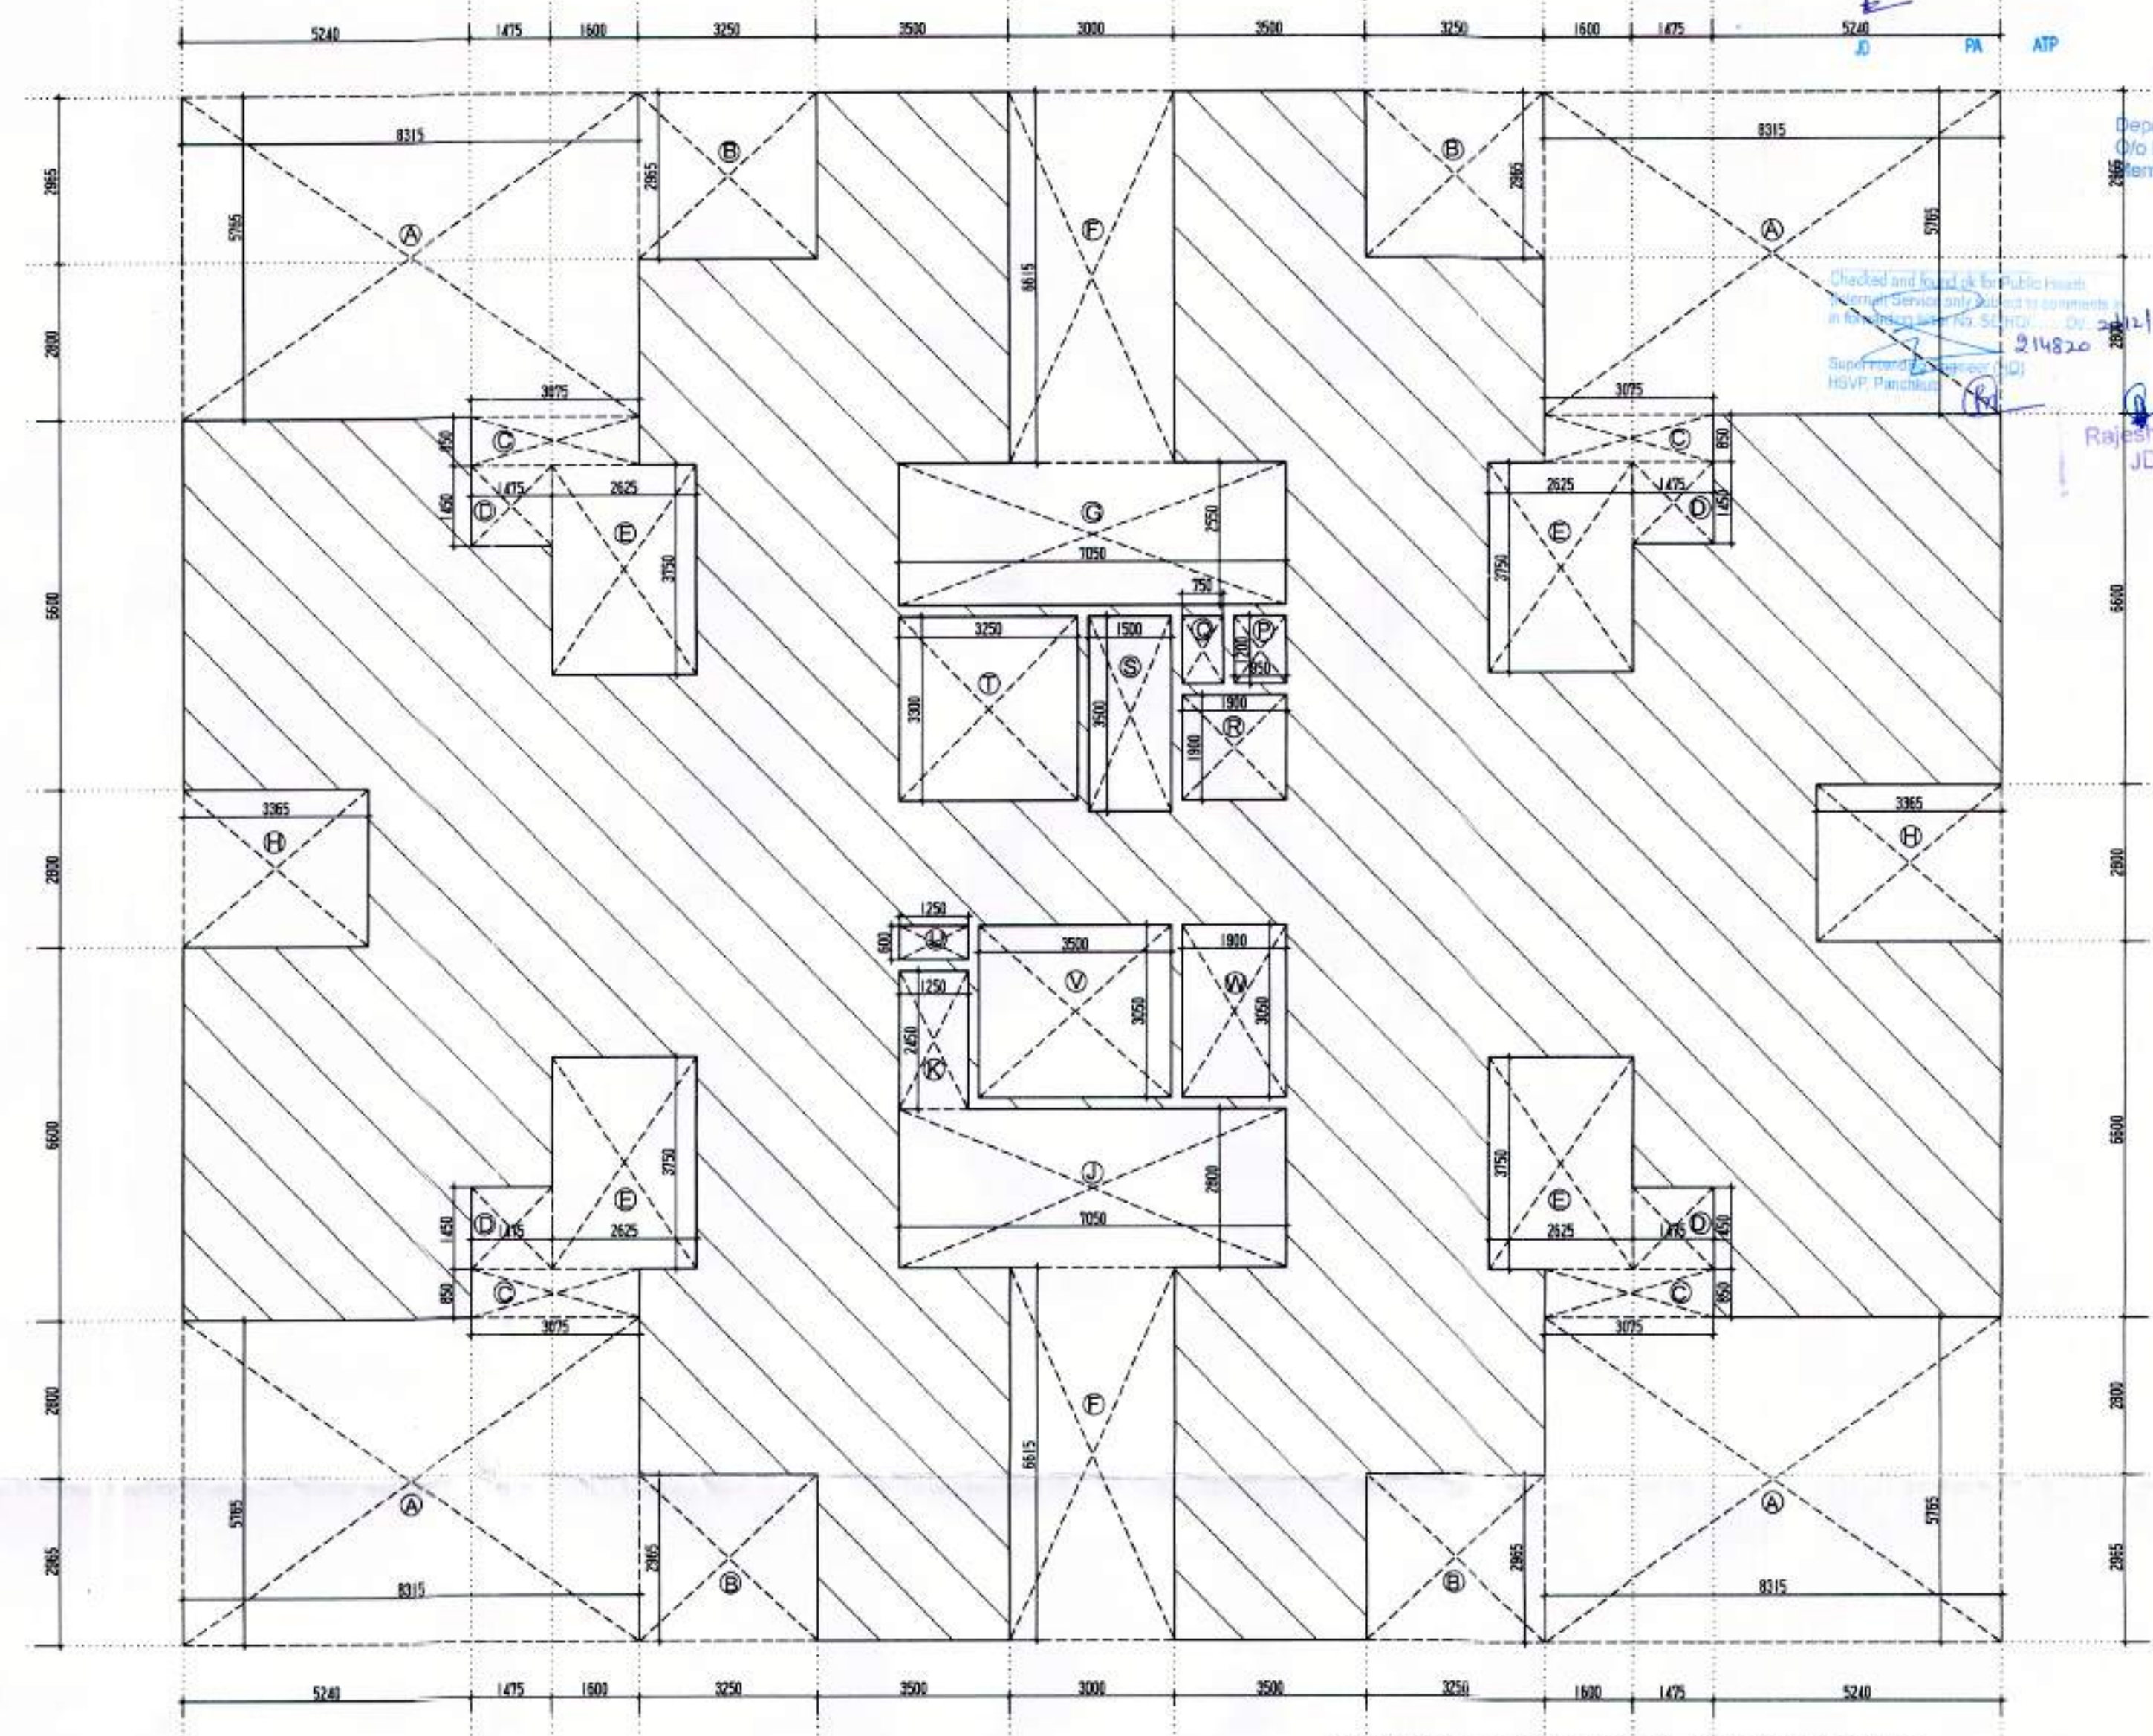



TYPICAL FLOOR AREA CALCULATION
Scale 1:100

2BHK - TYPE-1 UNIT CARPET AREA DETAIL						
ADDITION						
LABEL	GEOMETRY	NOS.	L	X	W	AREA
1	RECTANGLE	1	2.450	X	1.000	2.450
2	RECTANGLE	1	5.825	X	3.200	18.640
3	RECTANGLE	1	3.000	X	2.300	6.900
4	RECTANGLE	1	1.525	X	2.300	3.508
5	RECTANGLE	1	3.365	X	6.300	21.200
6	RECTANGLE	2	0.200	X	0.900	0.360
TOTAL ADDITION						53.057
TOTAL UNIT 2BHK - TYPE -1 CARPET AREA						53.057

2BHK - TYPE-2 UNIT CARPET AREA DETAIL							
ADDITION							
LABEL	GEOMETRY	NOS.	L	X	W	AREA	
1	RECTANGLE	1	1.000	X	0.100	0.100	
2	RECTANGLE	1	3.350	X	6.150	20.603	
3	RECTANGLE	2	0.200	X	0.900	0.360	
4	RECTANGLE	1	6.400	X	3.300	21.120	
5	RECTANGLE	1	3.150	X	3.015	9.497	
TOTAL ADDITION							51.680
TOTAL UNIT TYPE -2BHK - TYPE- 2 CARPET AREA							51.680

TOWER- 05 1ST-17TH FLOOR F.A.R. AREA DETAIL (C)							
ADDITION							
AREA OF GROUND COVERAGE							534.061
TOTAL ADDITIONS							534.061
DEDUCTION							
LABEL	GEOMETRY	NOS	L1		W		AREA
P	RECTANGLE	1	0.950	X	1.200		1.140
Q	RECTANGLE	1	0.750	X	1.200		0.900
R	RECTANGLE	1	1.900	X	1.900		3.610
S	RECTANGLE	1	1.500	X	3.500		5.250
T	RECTANGLE	1	3.250	X	3.300		10.725
U	RECTANGLE	1	1.250	X	0.600		0.750
V	RECTANGLE	1	3.500	X	3.050		10.675
W	RECTANGLE	1	1.900	X	3.050		5.795
2	RECTANGLE	1	0.705	X	10.000		7.050
3	TRIANGLE	0.50	0.586	X	10.000		2.930
TOTAL DEDUCTIONS							48.525
TYPICAL FLOOR AREA							485.236

- P.S. LEGEND
- 100 MM Ø SOIL & VENT PIPE
 - 100 MM Ø WASTE & VENT PIPE
 - 75 MM Ø ANTISIPHON PIPE
 - 100/150 MM Ø RAIN WATER PIPE
 - DOMESTIC WATER CORRY RISE
 - FLUSHING WATER CORRY RISE
 - DOMESTIC WATER DTH TAKE
 - FLUSHING WATER DTH TAKE

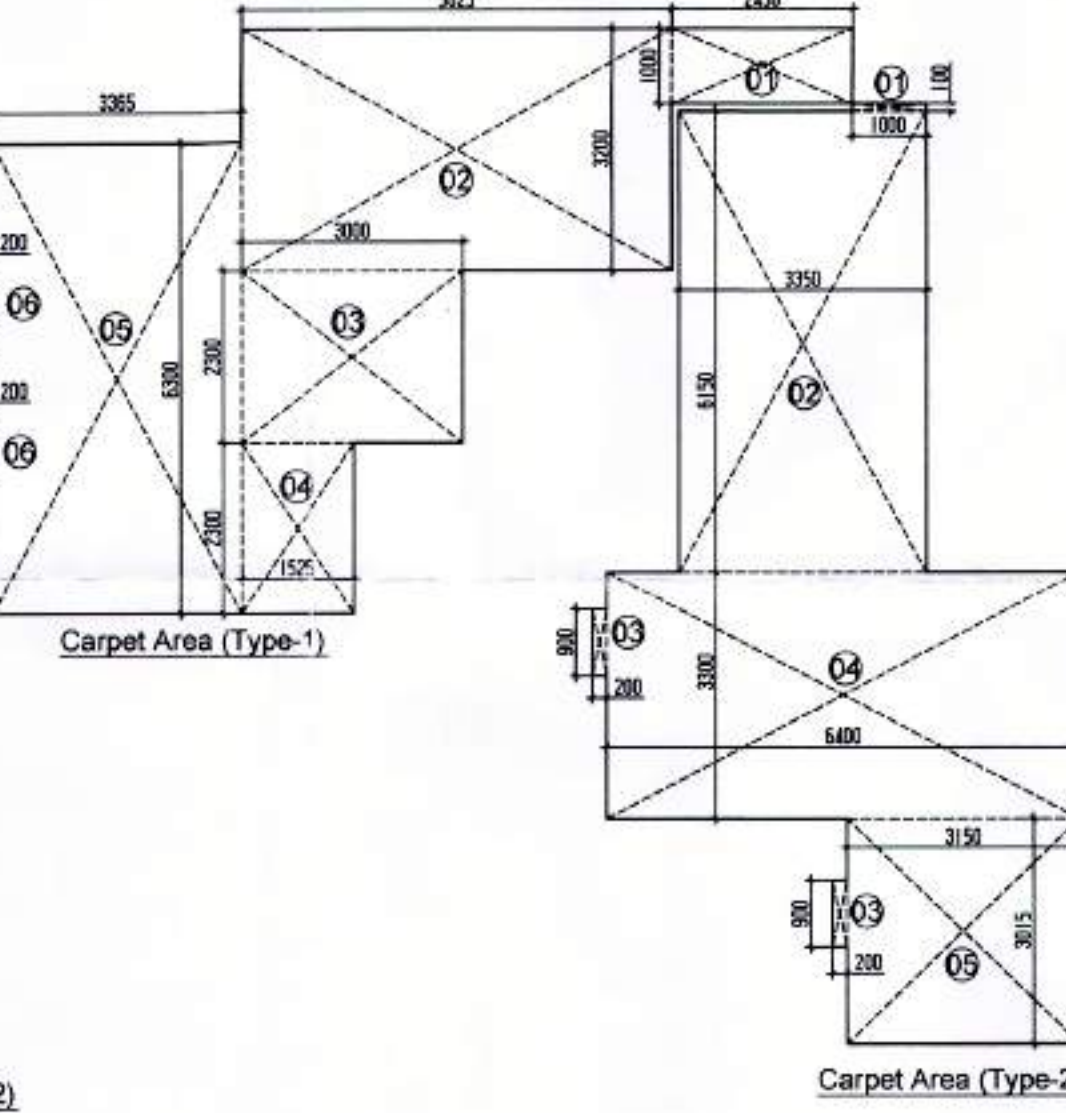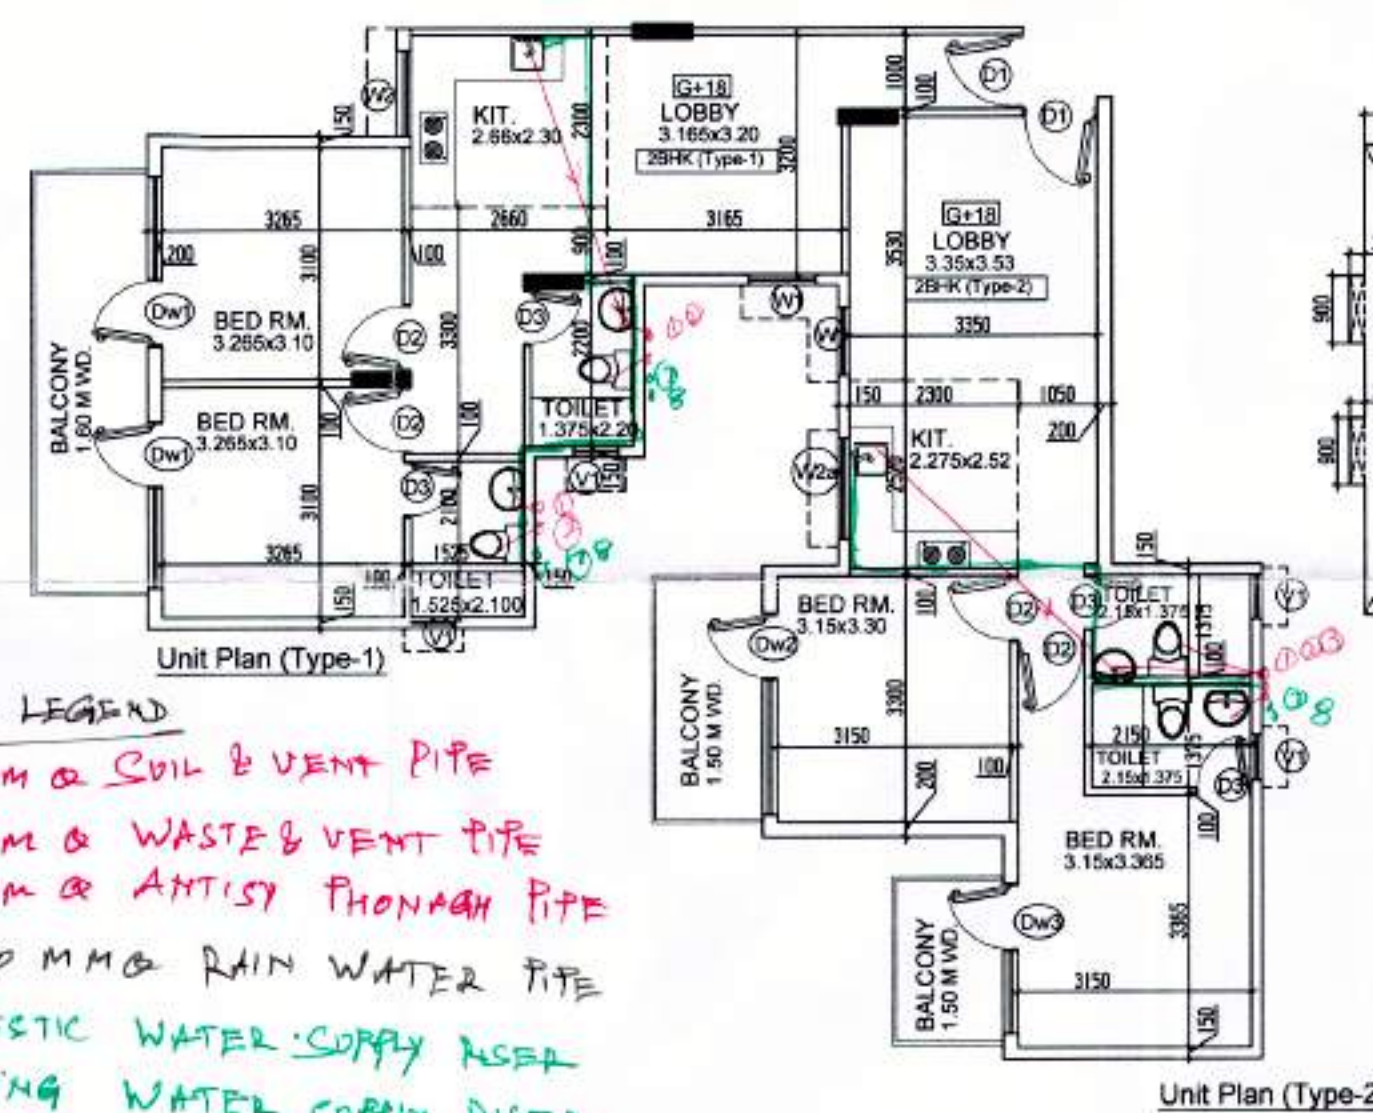

Door Window Schedule					
S. No.	Tag	Size of Opening	Cl. Int.	Lin. Int.	Lin. Int.
1	DD	1100X2100	± 000	+ 2100	
2	DD	1200X2100	± 000	+ 2100	
3	D1	1000X2100	± 000	+ 2100	
4	D2	900X2100	± 000	+ 2100	
5	D3	750X2100	± 000	+ 2100	
6	DW1	2250X2500	000+300	+ 2500	
7	DW2	2700X2500	000+300	+ 2500	
8	DW3	2100X2500	000+300	+ 2500	
9	W1	900X2200	+300	+ 2500	
10	W2	1200X1450	+1050	+ 2500	
11	W3	1200X1800	+900	+ 2500	
12	V1	600X1300	+1200	+ 2500	
13	FD	1200X2100		+ 2100	

SIGNATURE OF ARCHITECT

SIGNATURE OF OWNER

ARCHITECT

EMBLEM STUDIO
ARCHITECTURE, INTERIORS, PLANNING
619/4 FIRST FLOOR, CHATRAPUR, NEW DELHI - 110074
E-mail : emblemstudio@gmail.com


PROJECT NO: SCALE 1:100

DATE : 27-07-19

DEALT : NIMIT


PROJECT

PROPOSED BUILDING PLAN FOR AFFORDABLE GROUP HOUSING SCHEME MEASURING 5.088 ACRES (LICENCE NO. 103 OF 2019 DATED 06/09/2019) SECTOR-70 GURUGRAM, REVENUE STATE OF VILLAGE BADSHAHIPUR, SECTOR-70 BEING DEVELOPED BY SHRATA LAL AND OTHERS IN COLLABORATION WITH OCEAN SEVEN

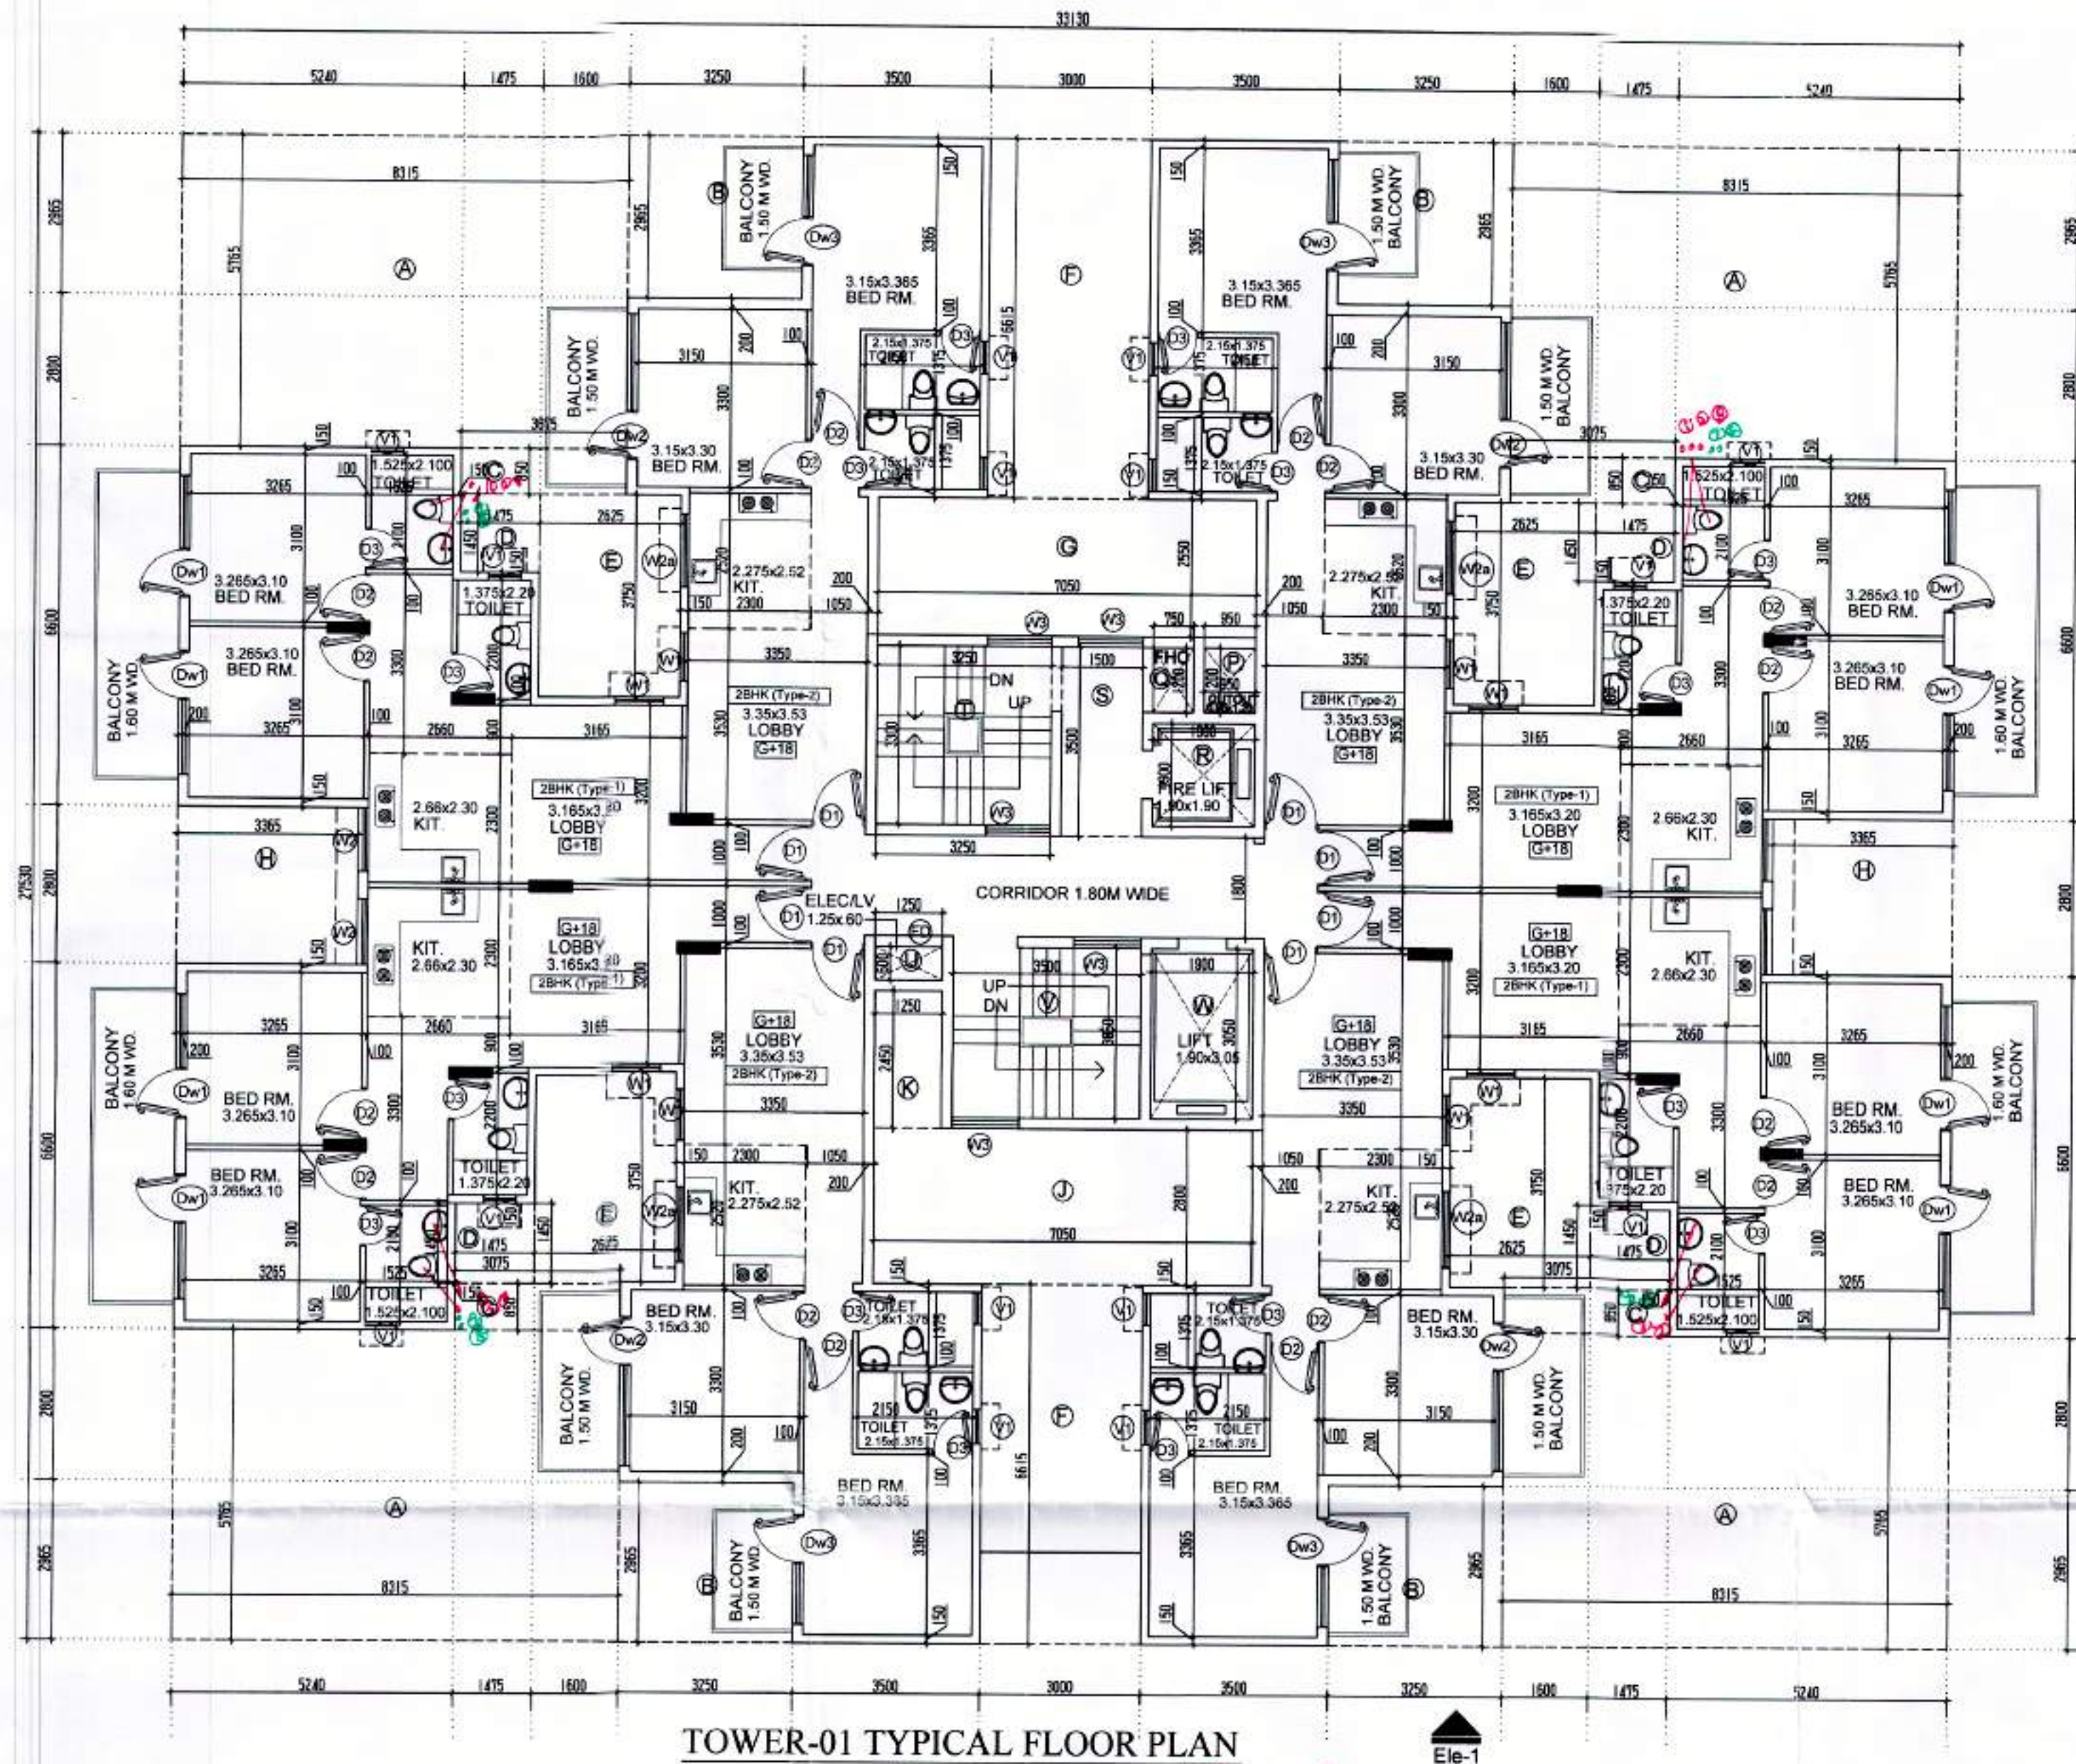

TOWER-01 TYPICAL FLOOR PLAN
1ST-18TH

Ele-1

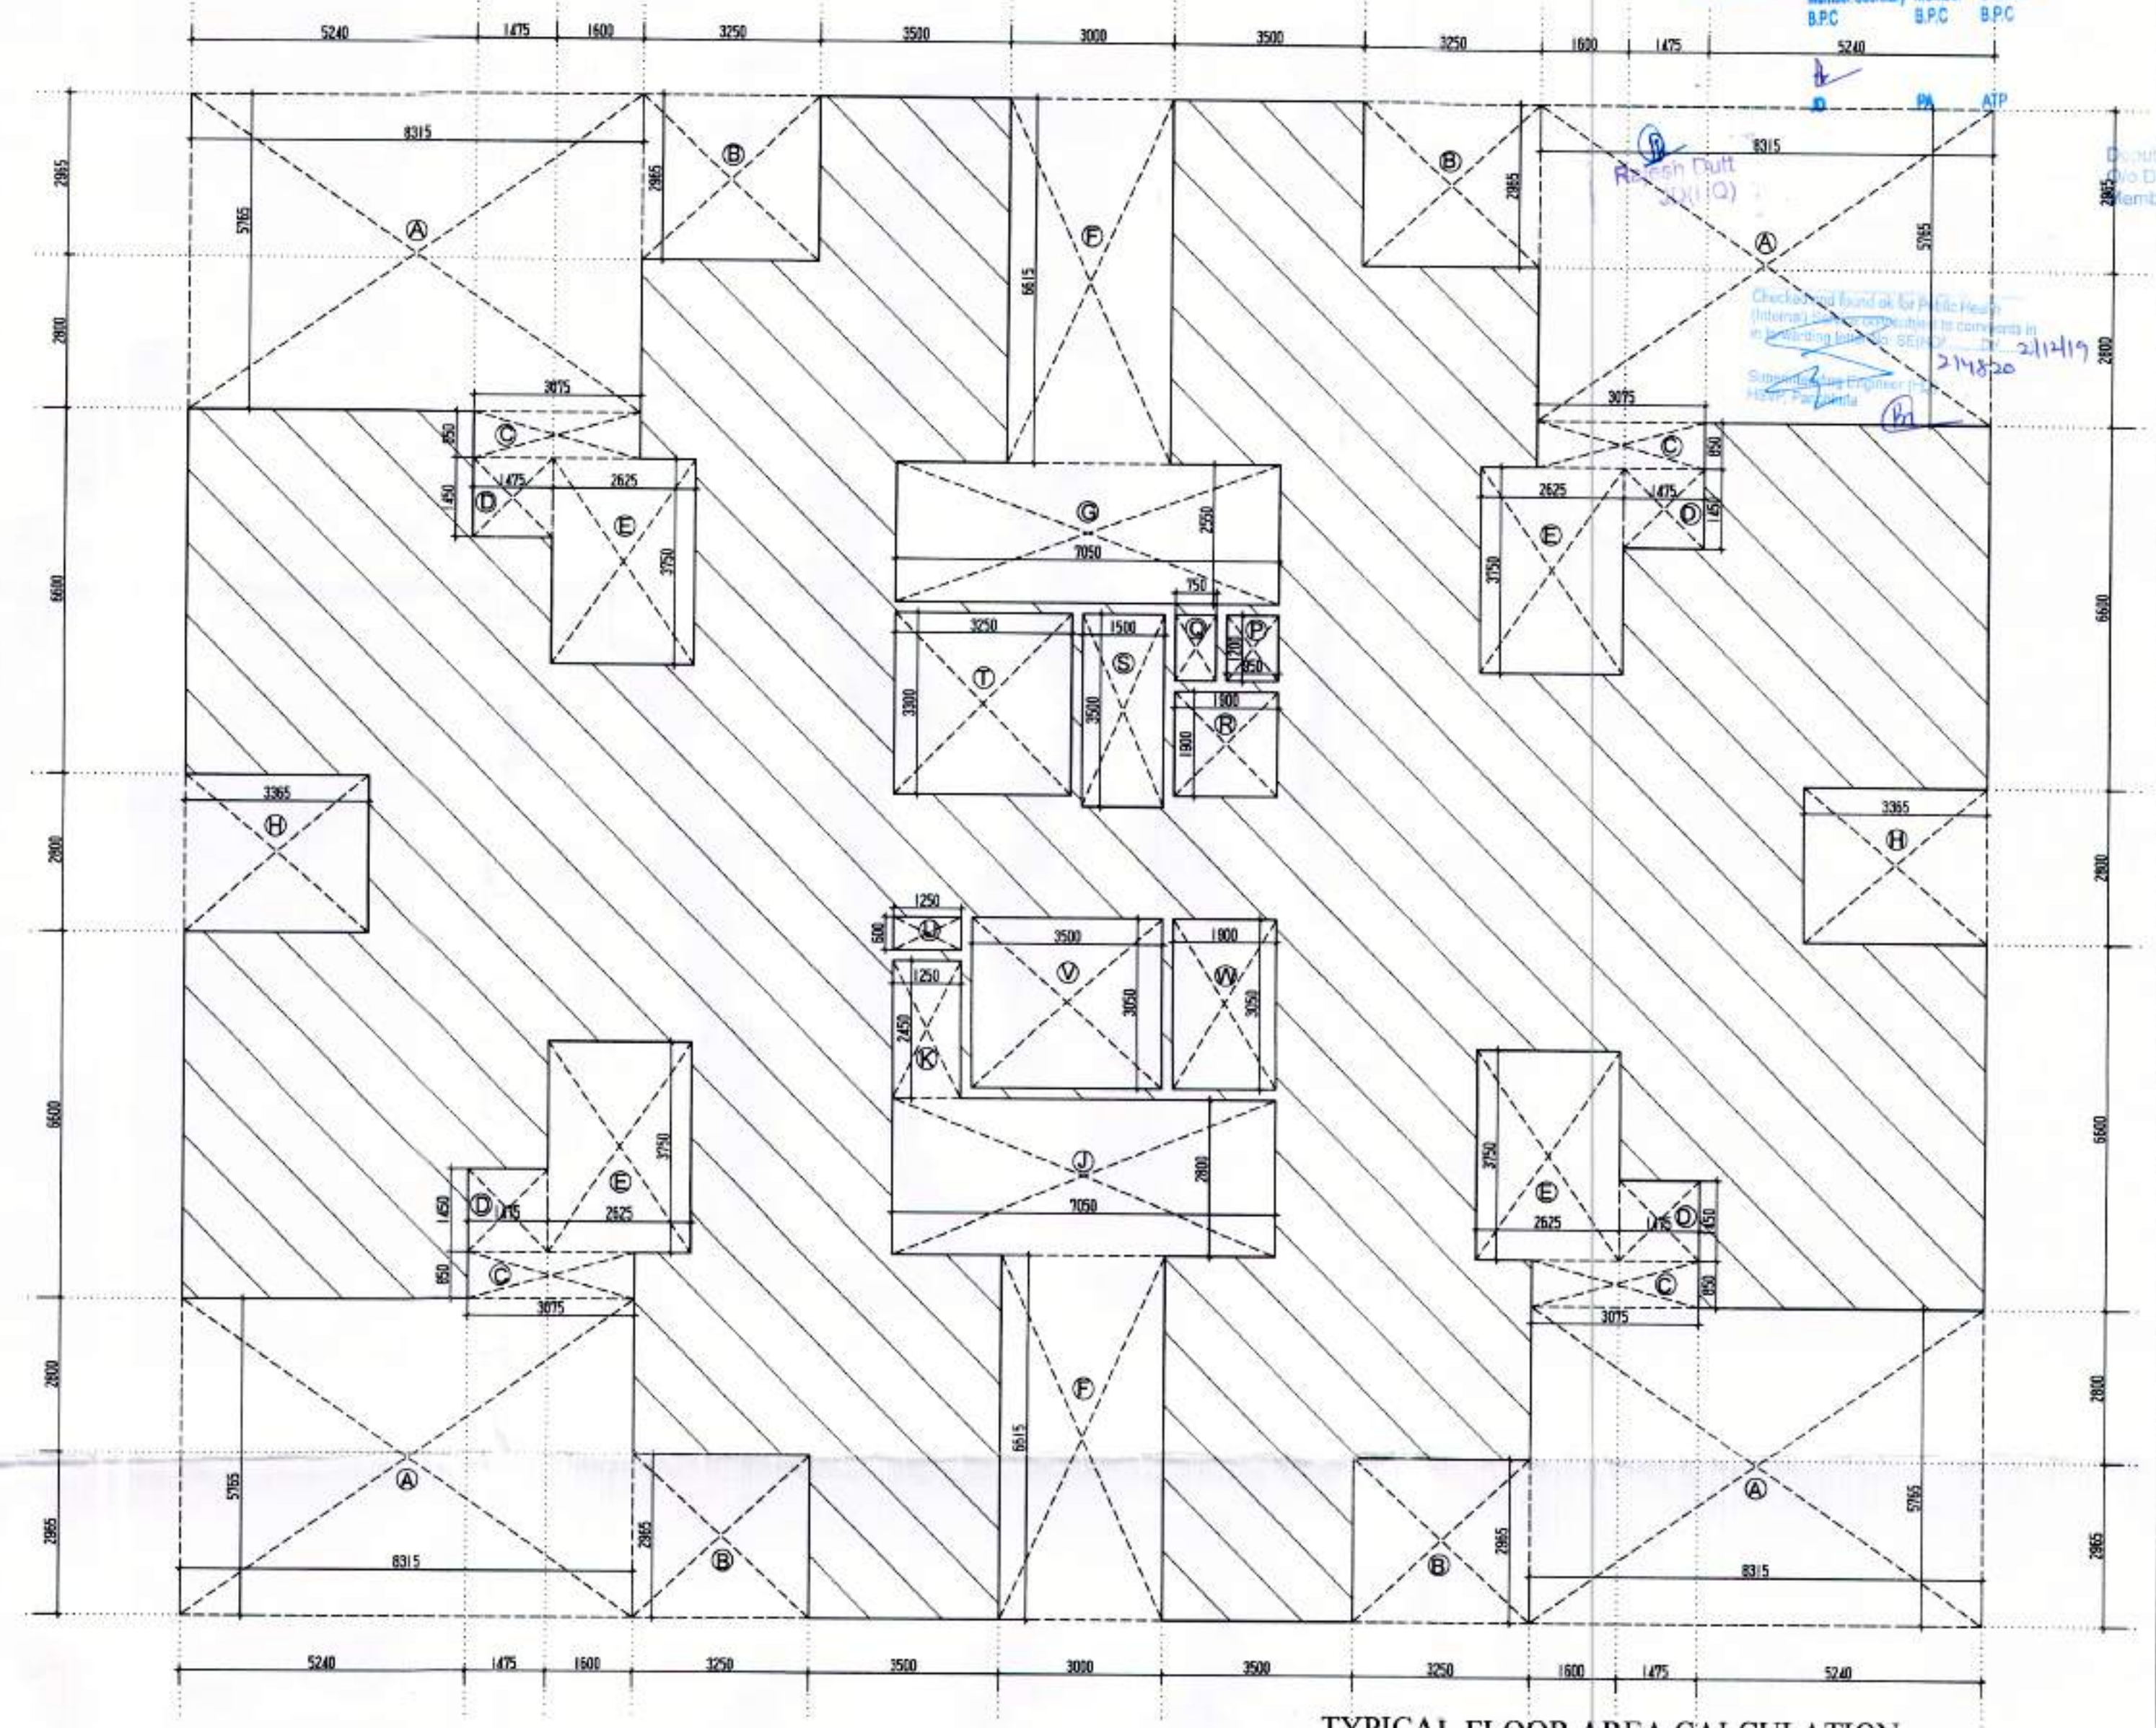

TYPICAL FLOOR AREA CALCULATION
Scale 1:100



2BHK - TYPE-1 UNIT CARPET AREA DETAIL						
ADDITION						
LABEL	GEOMETRY	NOS.	L	X	W	AREA
1	RECTANGLE	1	2.450	X	1.000	2.450
2	RECTANGLE	1	5.825	X	3.200	18.640
3	RECTANGLE	1	3.000	X	2.300	6.900
4	RECTANGLE	1	1.525	X	2.300	3.508
5	RECTANGLE	1	3.365	X	6.300	21.200
6	RECTANGLE	2	0.200	X	0.900	0.360
TOTAL ADDITION						53.057
TOTAL UNIT 2BHK - TYPE -1 CARPET AREA						53.057

2BHK - TYPE-2 UNIT CARPET AREA DETAIL						
ADDITION						
LABEL	GEOMETRY	NOS.	L	X	W	AREA
1	RECTANGLE	1	1.000	X	0.100	0.100
2	RECTANGLE	1	3.350	X	6.150	20.603
3	RECTANGLE	2	0.200	X	0.900	0.360
4	RECTANGLE	1	6.400	X	3.300	21.120
5	RECTANGLE	1	3.150	X	3.015	9.497
TOTAL ADDITION						51.680
TOTAL UNIT TYPE -2BHK - TYPE-2 CARPET AREA						51.680

TOWER-01 1ST-18TH FLOOR F.A.R. AREA DETAIL (C)						
ADDITION						
AREA OF GROUND COVERAGE						534.061
TOTAL ADDITIONS						534.061
DEDUCTION						
LABEL	GEOMETRY	NOS	L1		W	AREA
P	RECTANGLE	1	0.950	X	1.200	1.140
Q	RECTANGLE	1	0.750	X	1.200	0.900
R	RECTANGLE	1	1.900	X	1.900	3.610
S	RECTANGLE	1	1.500	X	3.500	5.250
T	RECTANGLE	1	3.250	X	3.300	10.725
U	RECTANGLE	1	1.250	X	0.600	0.750
V	RECTANGLE	1	3.500	X	3.050	10.675
W	RECTANGLE	1	1.900	X	3.050	5.795
2	RECTANGLE	1	0.705	X	10.000	7.050
3	TRIANGLE	0.50	0.586	X	10.000	2.930
TOTAL DEDUCTIONS						48.525
TYPICAL FLOOR AREA						485.236

PLUMBING LEGEND:

- 100 MM Ø SOIL & WASTE PIPE
- 100 MM Ø WASTE EVENT PIPE
- 75 MM Ø ANTI-SIPHONAGE PIPE
- 100/150 MM Ø RAIN WATER PIPE DUTTER
- DOMESTIC WATER SUPPLY RISER
- FLUSHING WATER SUPPLY RISER
- DOMESTIC WATER SUPPLY DUTTER
- FLUSHING WATER DUTTER

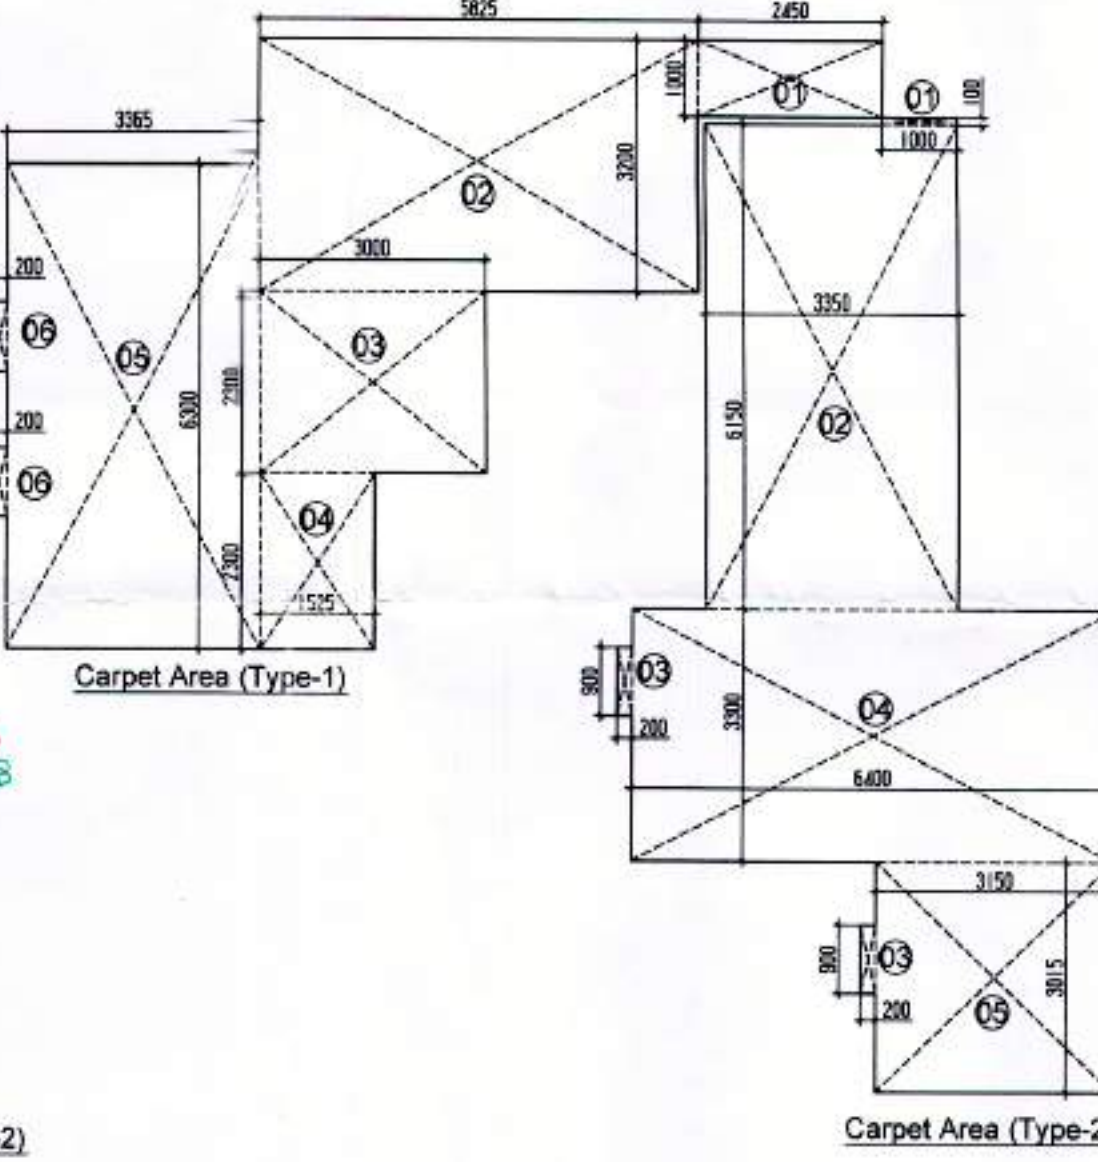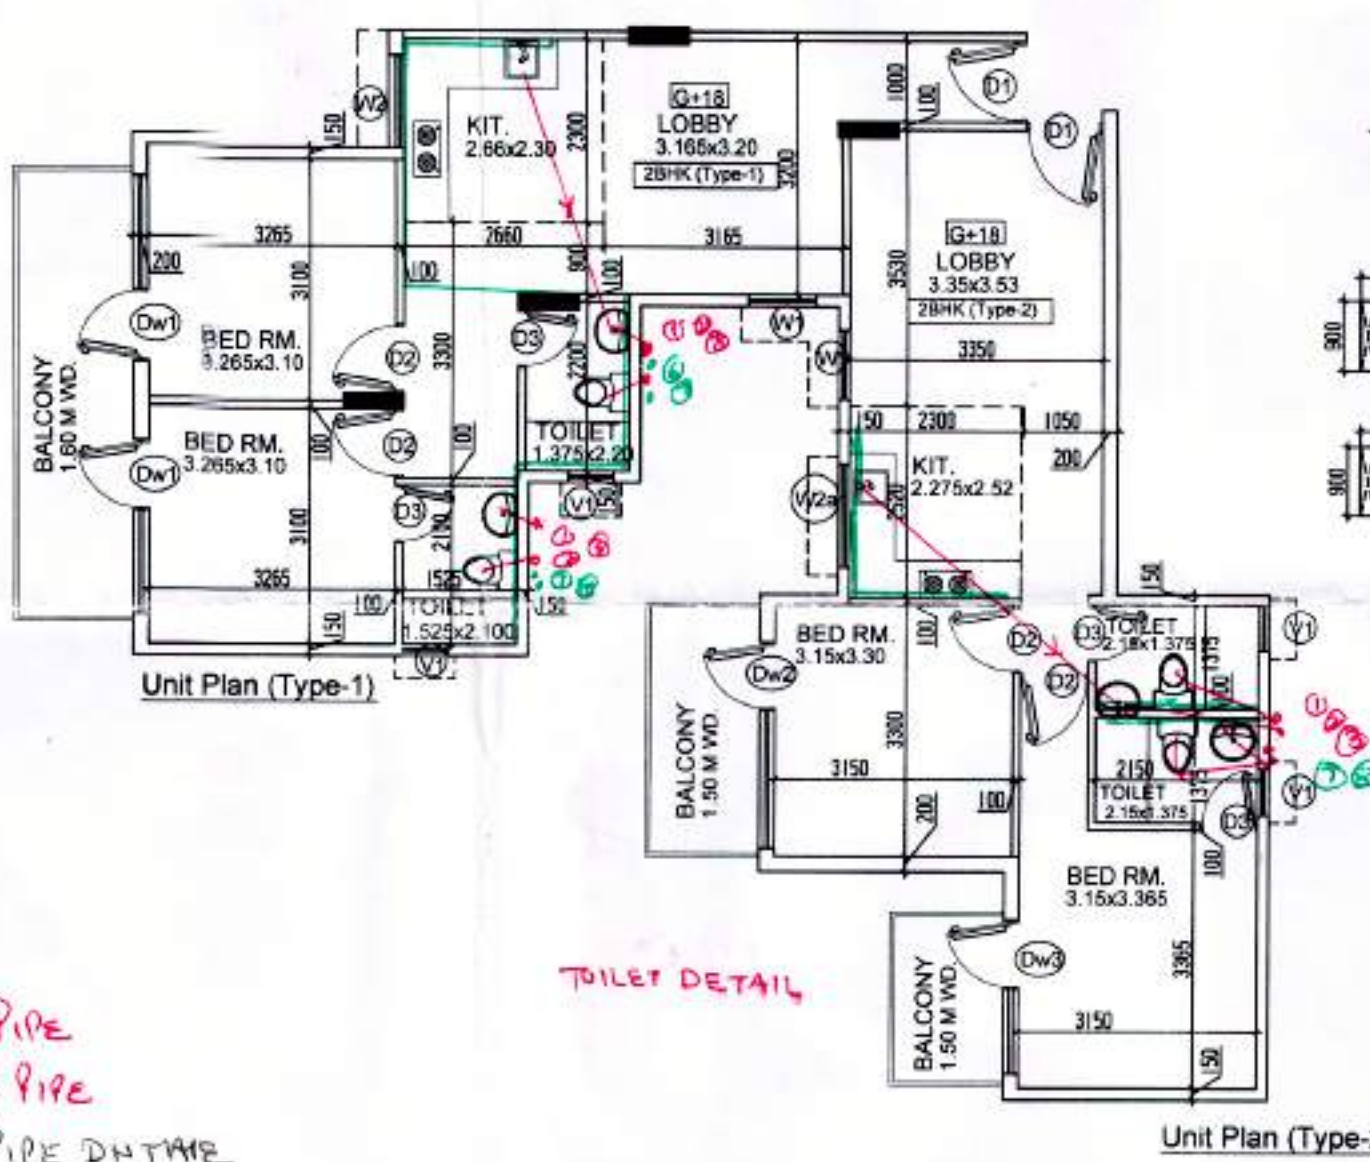

Door Window Schedule					
S. No.	Tag	Size of Opening	Cill. Ht.	Lin. Ht.	
1	DD	1100X2100	± 000	+ 2100	
2	D0	1200X2100	± 000	+ 2100	
3	D1	1000X2100	± 000	+ 2100	
4	D2	900X2100	± 000	+ 2100	
5	D3	750X2100	± 000	+ 2100	
6	DW1	2250X2500	00+300	+ 2500	
7	DW2	2700X2500	00+300	+ 2500	
8	DW3	2100X2500	00+300	+ 2500	
9	W1	900X2200	+300	+ 2500	
10	W2	1200X1450	+1050	+ 2500	
11	W3	1200X1600	+900	+ 2500	
12	V1	800X1300	+1200	+ 2500	
13	FD	1200X2100		+ 2100	
FIRE DOOR					

SIGNATURE OF ARCHITECT

SIGNATURE OF OWNER

ARCHITECT

EMBLEM STUDIO

ARCHITECTURE, INTERIORS, PLANNING
619/4 FIRST FLOOR, CHATAPUR, NEW DELHI - 110074
E-mail : emblemstudio@gmail.com

PROJECT NO:

SCALE: 1:100

DRG. NO.: S-2A

DATE: 27-07-19

DEALT: NIMIT

DRG. TITLE:

Typical Fl. Plan & Area details

(Tower-01)

PROJECT

PROPOSED BUILDING PLAN FOR AFFORDABLE

GROUP HOUSING SCHEME MEASURING 5.088 ACRES

(LICENCE NO. 103 OF 2019 DATED 06/09/2019)

SECTOR-70 GURUGRAM, REVENUE STATE OF VILLAGE

BADSHAHPUR, SECTOR-70 BEING DEVELOPED BY SH RATAI

LAL AND OTHERS IN COLLABORATION WITH OCEAN SEVEN

RE IN PRIVATE LIMITED

ARCHITECT (H) S.T.E/G C.T.P (H)
Member Secretary Member Chairman
BPC BPC BPC


Rajesh Dutt
JD (HQ)

Checked and Certified by Project Engineer
Subject to compliance with the provisions of the Building Bye Laws, New Delhi, 2019
21/12/19
214820
Pr


Deputy Director (T)
O/o Directorate Fire Service
Member B.P.C.

PLUMBING LEGEND:


- 100mm Ø SOIL & VENT PIPE
- 100mm Ø WASTE & VENT PIPE
- 75mm Ø ANTISIPHONAGE PIPE
- 100/150mm Ø RAIN WATER PIPE DNTAKE
- DOMESTIC WATER SUPPLY RISER
- FLUSHING WATER SUPPLY RISER
- DOMESTIC WATER DNTAKE
- FLUSHING WATER DNTAKE

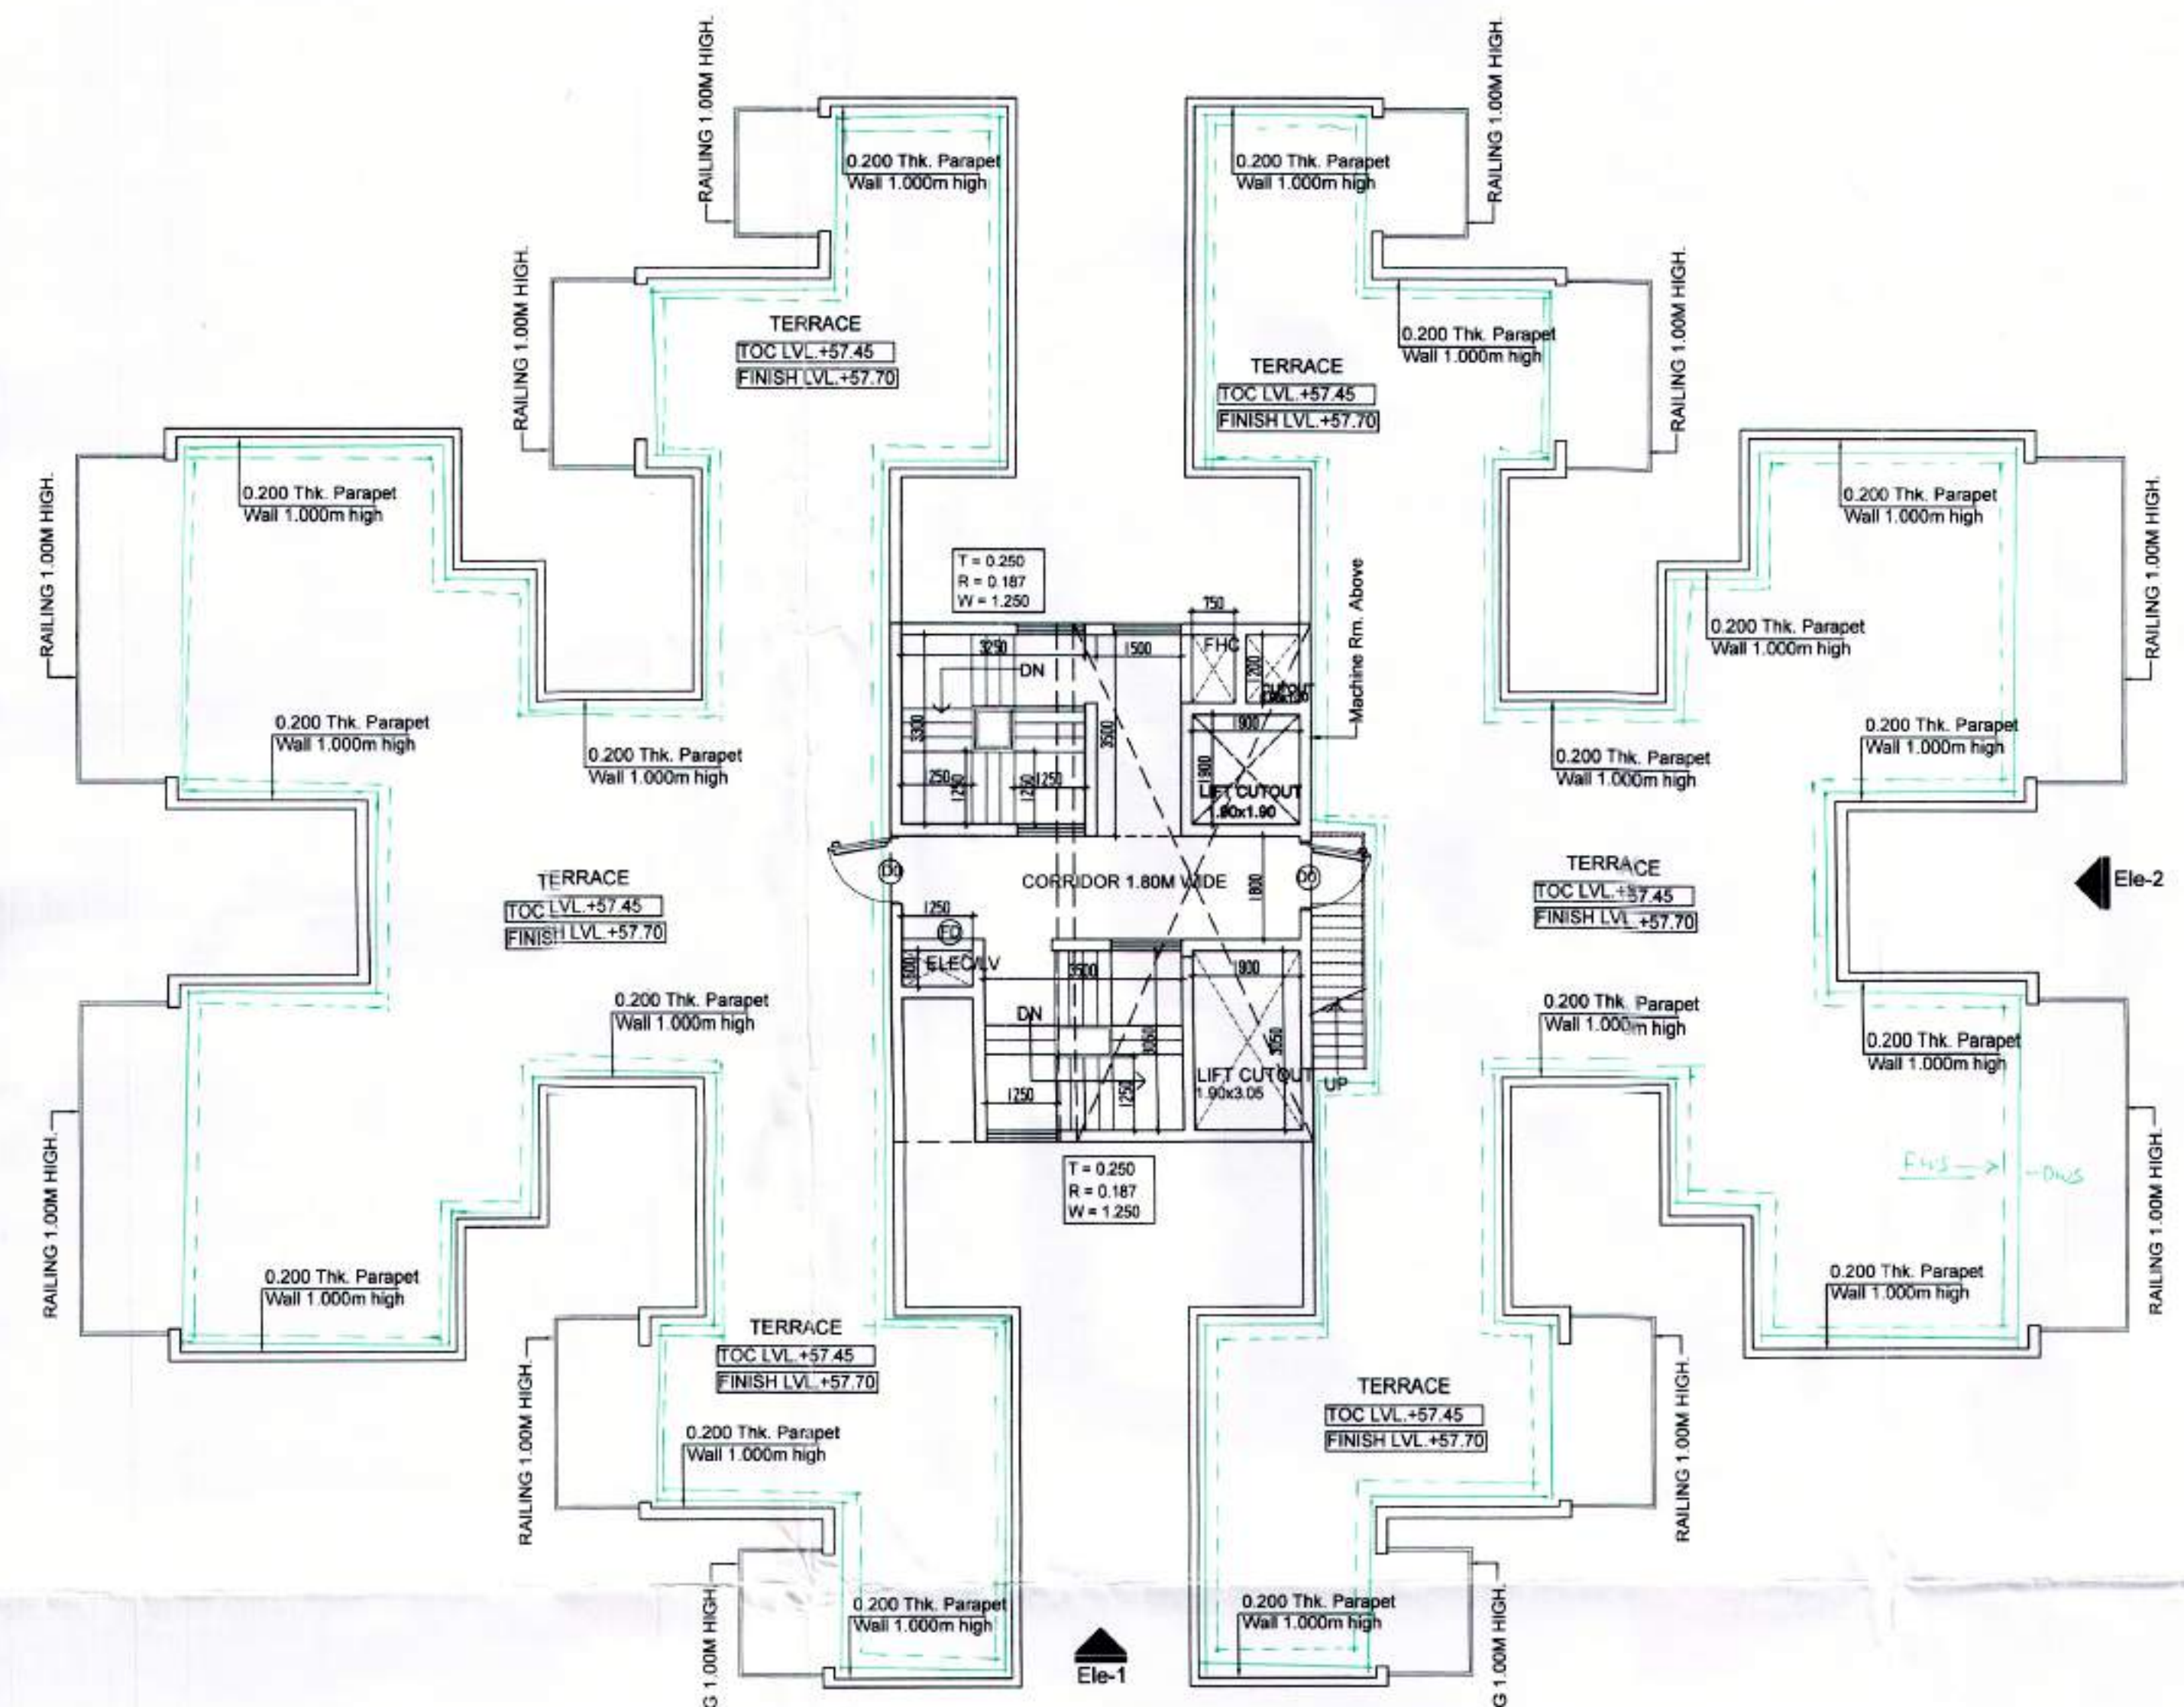

TOWER-02 & 03
TERRACE FLOOR PLAN

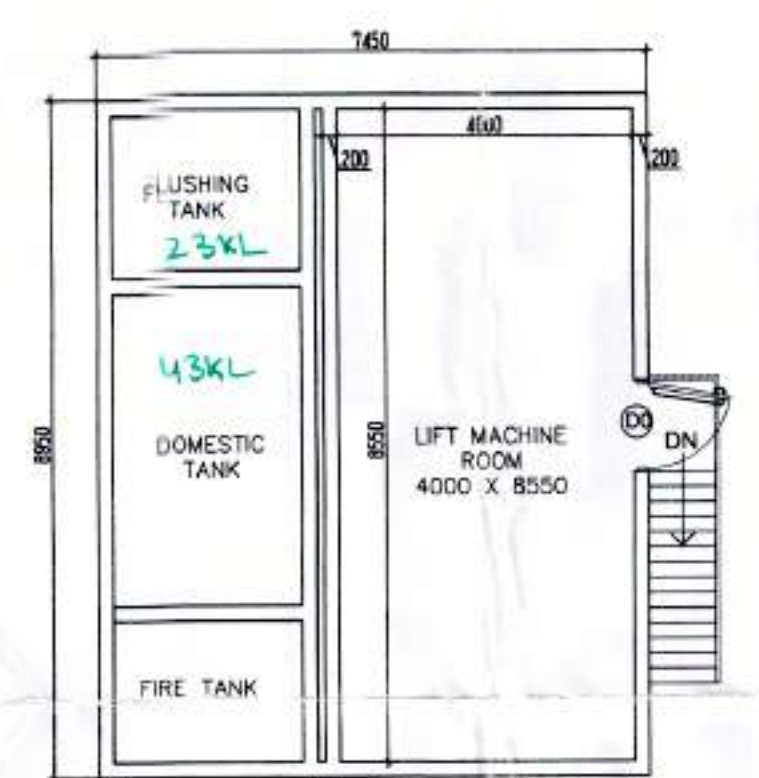

TOWER-02 & 03
MUMTY MACHINE ROOM PLAN

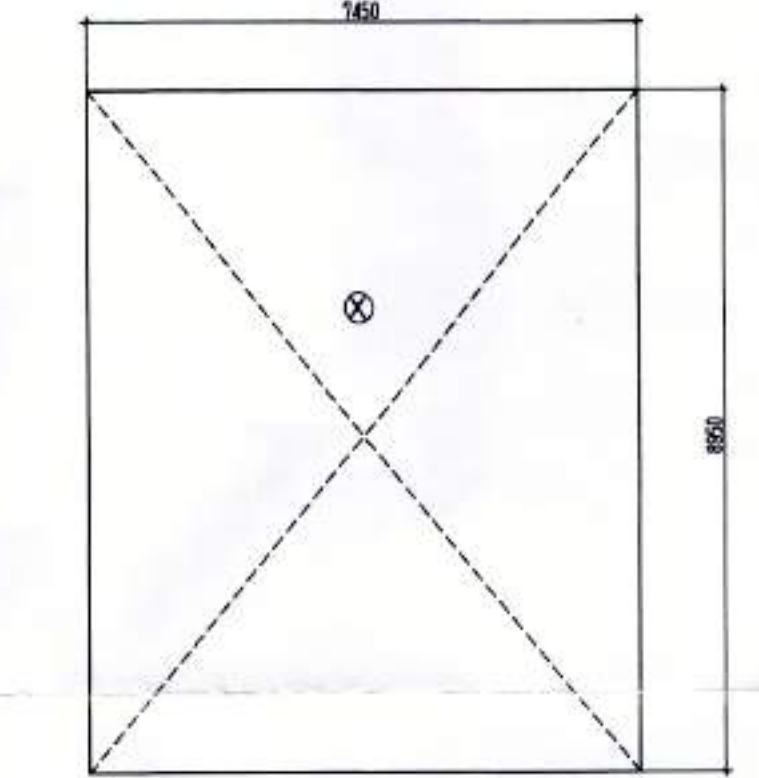

MUMTY MACHINE ROOM AREA CALCULATION

TOWER-02,03 MUMTY/M. ROOM AREA (NON F.A.R.)					
ADDITION					
LABEL	GEOMETRY	NOS	L	W	AREA
X	RECTANGLE	1	7.450	8.950	66.678

Door Window Schedule					
S. No	Tag	Size of Opening	Chil. Mt.	Lin. Mt.	
1	DD	1100X2100	+000	+2100	
2	D0	1200X2100	+000	+2100	
3	D1	1000X2100	+000	+2100	
4	D2	900X2100	+000	+2100	
5	D3	750X2100	+000	+2100	
6	DW1	2250X2500	00+300	+2500	
7	DW2	2700X2500	00+300	+2500	
8	DW3	2100X2500	00+300	+2500	
9	W1	900X2200	+300	+2500	
10	W2	1200X1450	+1050	+2500	
11	W3	1200X1600	+900	+2500	
12	V1	800X1300	+1200	+2500	
13	FD	1200X2100		+2100	
FIRE DOOR					

SIGNATURE OF ARCHITECT

SIGNATURE OF OWNER

ARCHITECT
NIMIT K/65828
CA/2014/65828

Ocean Seven Buildtech Pvt. Ltd.
Approved Signatory

EMBLEM STUDIO
ARCHITECTURE, INTERIORS, PLANNING
619/4 FIRST FLOOR, CHATARPUR, NEW DELHI -110074
E-mail : emblemstudio@gmail.com

PROJECT NO: SCALE : 1:100


DRG. NO. : S-3B DATE : 27-07-19

DEALT : NIMIT


DRG. TITLE :
Typical Fl. Plan & Area details
(Tower- 02 & 03)

PROJECT
PROPOSED BUILDING PLAN FOR AFFORDABLE
GROUP HOUSING SCHEME MEASURING 5.088 ACRES
(LICENCE NO. 103 OF 2019 DATED 06/09/2019)
SECTOR-70 GURUGRAM, REVENUE STATE OF VILLAGE
BADSHAHPUR, SECTOR-70 BEING DEVELOPED BY SH RATAN
LAL AND OTHERS IN COLLABORATION WITH OCEAN SEVEN
BUILDTECH PRIVATE LIMITED


ARCHITECT (HQ) *[Signature]* S.T.P. (H) C.T.P. (H)
 Member Secretary B.P.C. Member Chairman B.P.C.
 J.D. P.A. A.P.
 Rajesh Dutt
 J.D. (HQ)
 Deputy Director (T)
 One Directorate Fire Service
 Member B.P.C.
 Checked and found ok for Public Health
 (Inter-Departmental) Subject to compliance
 in following letter for reference: D.O. 2/12/19
 Supervising Engineer (H)
 H.S.P. Panwar

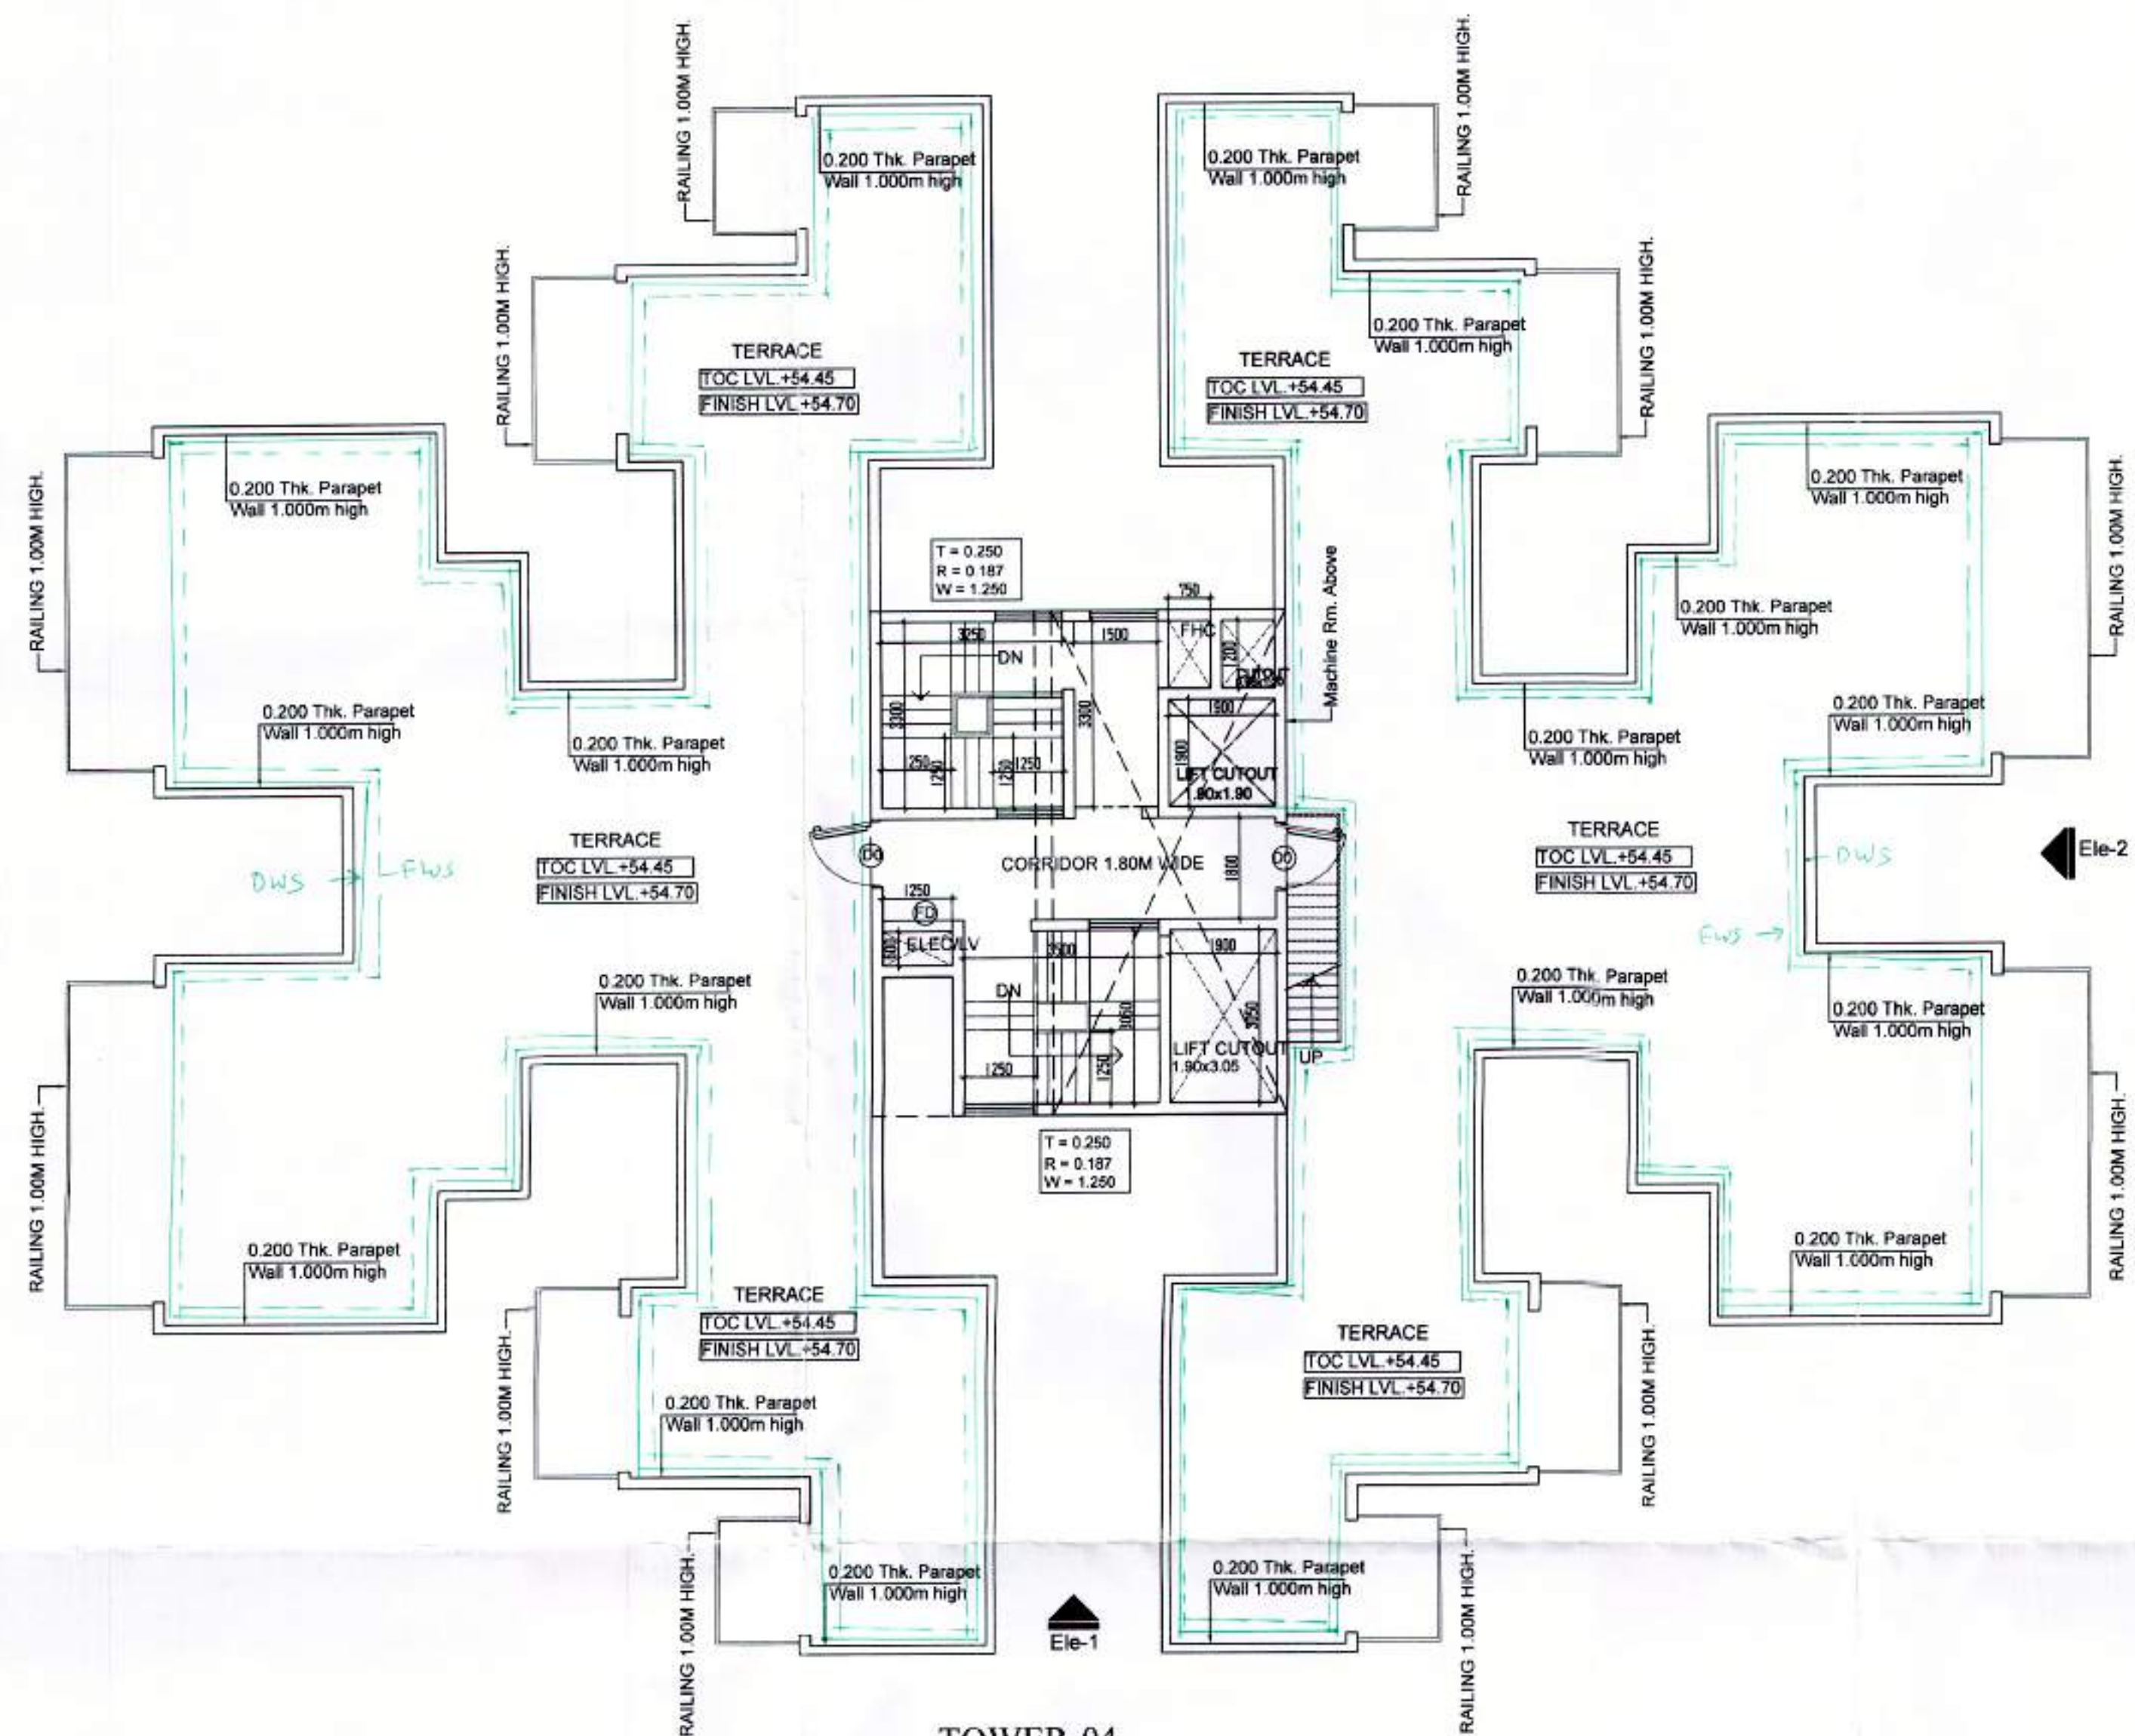

TOWER-04
TERRACE FLOOR PLAN

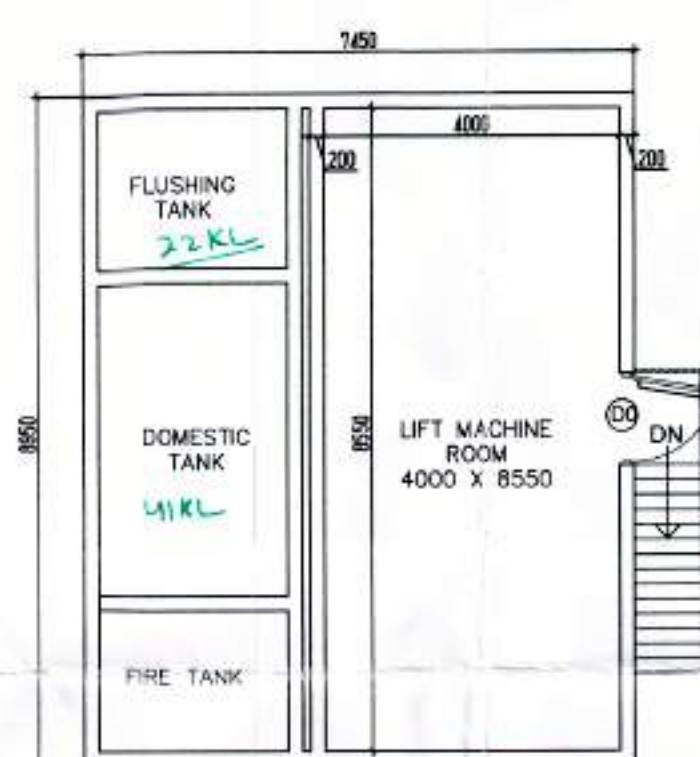

TOWER-04
MUMTY MACHINE ROOM PLAN

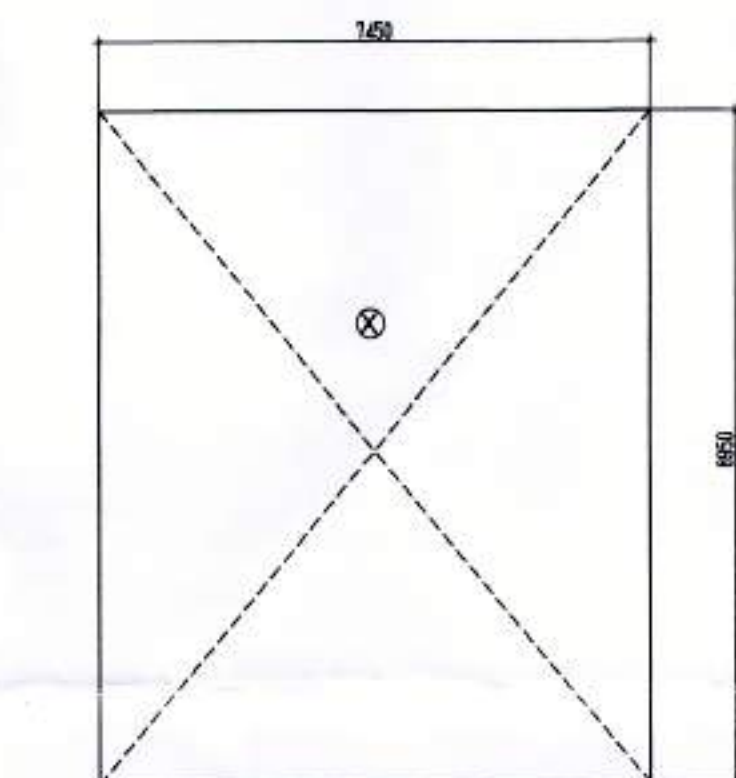

MUMTY MACHINE ROOM AREA CALCULATION

TOWER-01 MUMTY/M. ROOM AREA (NON F.A.R.)					
ADDITION					
LABEL	GEOMETRY	NOS	L	W	AREA
X	RECTANGLE	1	7.450	8.950	66.678

PLUMBING LEGEND:

- ① 100 mm Ø SOIL & VENT PIPE
- ② 100 mm Ø WASTE & VENT PIPE
- ③ 75 mm Ø ANTISTATONATE PIPE
- ④ 100/150 mm Ø RAIN WATER PIPE ON TAKE
- ⑤ DOMESTIC WATER SUPPLY RISER
- ⑥ FLUSHING WATER SUPPLY RISER
- ⑦ DOMESTIC WATER ON TAKE
- ⑧ FLUSHING WATER ON TAKE

Door Window Schedule				
S. No.	Tag	Size of Opening	Cill. lvl.	Lin. lvl.
1	DD	1100X2100	± 000	+2100
2	D0	1200X2100	± 000	+2100
3	D1	1000X2100	± 000	+2100
4	D2	900X2100	± 000	+2100
5	D3	750X2100	± 000	+2100
6	DW1	2250X2500	00+300	+2500
7	DW2	2700X2500	00+300	+2500
8	DW3	2100X2500	00+300	+2500
9	W1	900X2200	+300	+2500
10	W2	1200X1450	+1050	+2500
11	W3	1200X1800	+900	+2500
12	V1	600X1300	+1200	+2500
13	FD	1200X2100		+2100
FIRE DOOR				

SIGNATURE OF ARCHITECT


SIGNATURE OF OWNER

ARCHITECT *[Signature]* Ocean *[Signature]* Buildtech Pvt. Ltd.
 EMBLEM STUDIO
 ARCHITECTURE, INTERIORS, PLANNING
 619/4 FIRST FLOOR, CHAIAPUR, NEW DELHI -110074
 E-mail : emblemstudio@gmail.com


PROJECT NO: SCALE 1:100
 DRG. NO. : S-4B DATE : 27-07-19
 DEALT : NMIT

DRG. TITLE :
 Typical Fl. Plan & Area details
 (Tower- 04)


PROJECT
 PROPOSED BUILDING PLAN FOR AFFORDABLE
 GROUP HOUSING SCHEME MEASURING 5.088 ACRES
 (LICENCE NO. 103 OF 2019 DATED 06/09/2019)
 SECTOR-70 GURUGRAM, REVENUE STATE OF VILLAGE
 BADSHAHIPUR, SECTOR- 70 BEING DEVELOPED BY SHRATAN
 LAL AND OTHERS IN COLLABORATION WITH OCEAN SEVEN
 BUILDTECH PRIVATE LIMITED

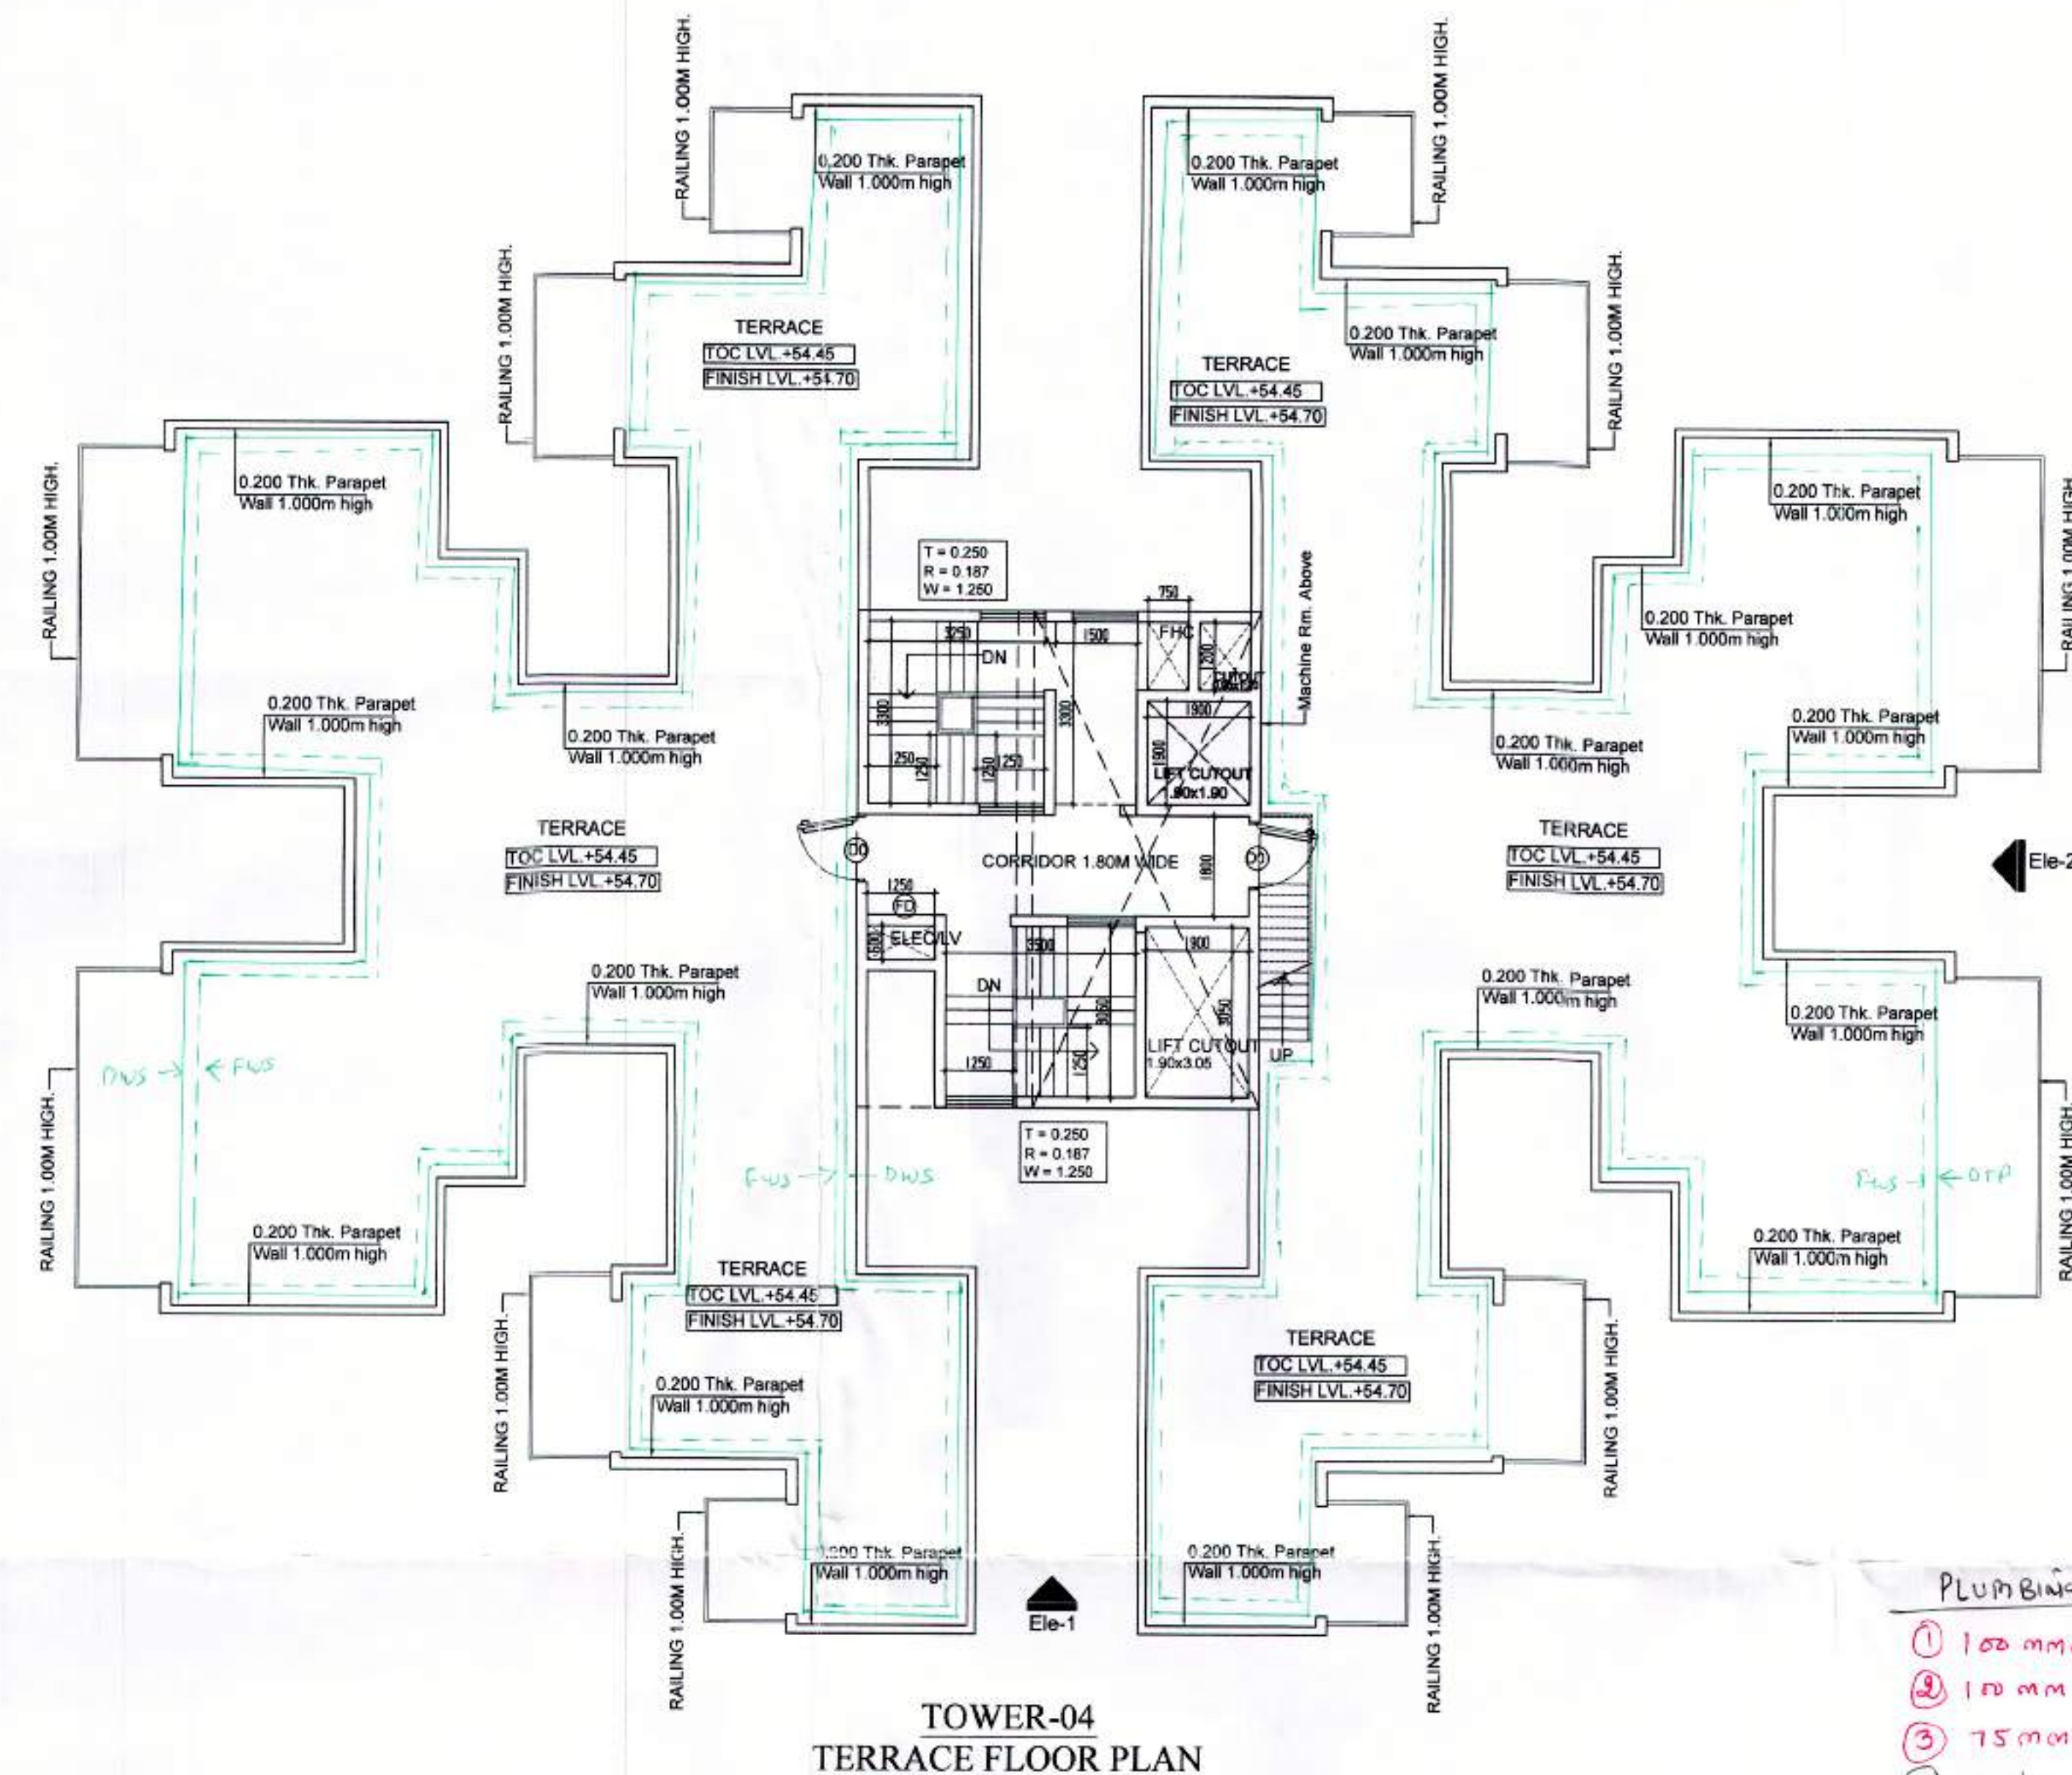

TOWER-04
TERRACE FLOOR PLAN

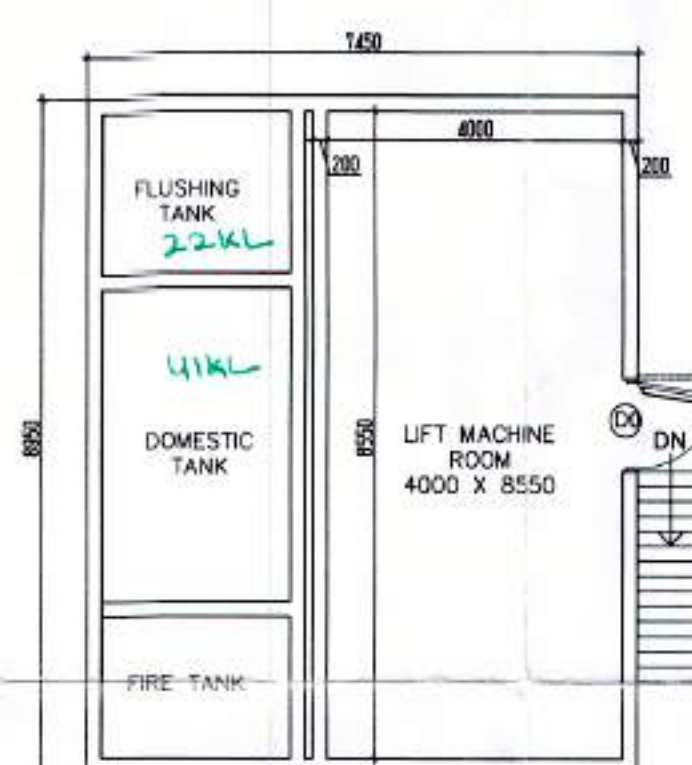

TOWER-05
MUMTY MACHINE ROOM PLAN

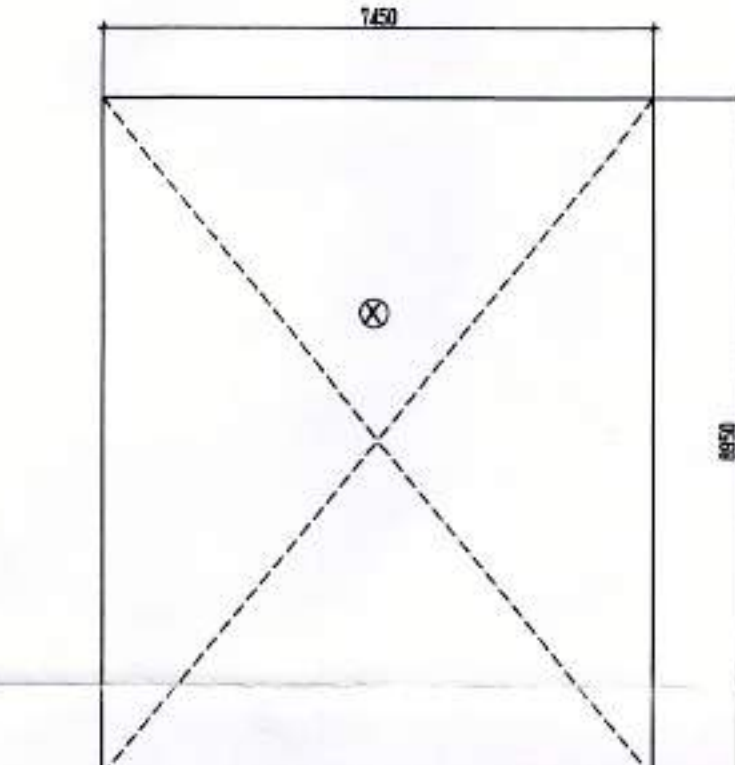

MUMTY MACHINE ROOM AREA CALCULATION

TOWER-01 MUMTY/M. ROOM AREA (NON F.A.R.)				
ADDITION				
LABEL	GEOMETRY	NOS	L	W
X	RECTANGLE	1	7.450	8.950
				66.678

PLUMBING LEGEND

- ① 100 mm Ø SOIL & VENT PIPE
- ② 100 mm Ø WASTE & VENT PIPE
- ③ 75 mm Ø ANTI SYPHONAGE PIPE
- ④ 100/150 mm Ø RAIN WATER PIPE DN TAKE
- ⑤ DOMESTIC WATER SUPPLY RISER
- ⑥ FLUSHING WATER SUPPLY RISER
- ⑦ DOMESTIC WATER SUPPLY DN TAKE
- ⑧ FLUSHING WATER DN TAKE

Door Window Schedule				
S. No	Tag	Size of Opening	Cill. Mt.	Lin. Mt.
1	DD	1100X2100	± 000	+ 2100
2	D0	1200X2100	± 000	+ 2100
3	D1	1000X2100	± 000	+ 2100
4	D2	900X2100	± 000	+ 2100
5	D3	750X2100	± 000	+ 2100
6	DW1	2250X2500	00+300	+ 2500
7	DW2	2700X2500	00+300	+ 2500
8	DW3	2100X2500	00+300	+ 2500
9	W1	900X2200	+300	+ 2500
10	W2	1200X1450	+1050	+ 2500
11	W3	1200X1600	+900	+ 2500
12	V1	600X1300	+1200	+ 2500
13	FD	1200X2100		+ 2100

SIGNATURE OF ARCHITECT

SIGNATURE OF OWNER

ARCHITECT

EMBLEM STUDIO

ARCHITECTURE, INTERIORS, PLANNING

619/4 FIRST FLOOR, CHATARPUR, NEW DELHI - 110074

E-mail : emblemstudio@gmail.com

PROJECT NO. : SCALE 1:100

DRG. NO. : S-58 DATE : 27-07-19

DEALT : NIMIT

DRG. TITLE : Typical Fl. Plan & Area details (Tower- 05)

PROJECT

PROPOSED BUILDING PLAN FOR AFFORDABLE GROUP HOUSING SCHEME MEASURING 5.068 ACRES (LICENCE NO. 103 OF 2019 DATED 06/09/2019) SECTOR-70 GURUGRAM, REVENUE STATE OF VILLAGE BADSHAHPUR, SECTOR-70 BEING DEVELOPED BY SH RATA LAL AND OTHERS IN COLLABORATION WITH OCEAN SEVEN

