 



LEGEND	
SYMBOL	DESCRIPTION
	SEWERAGE MANHOLE
	SEWERAGE LINE

UNDER GROUND TANKS & PLANT ROOM
LOCATION BELOW GROUND FLOOR

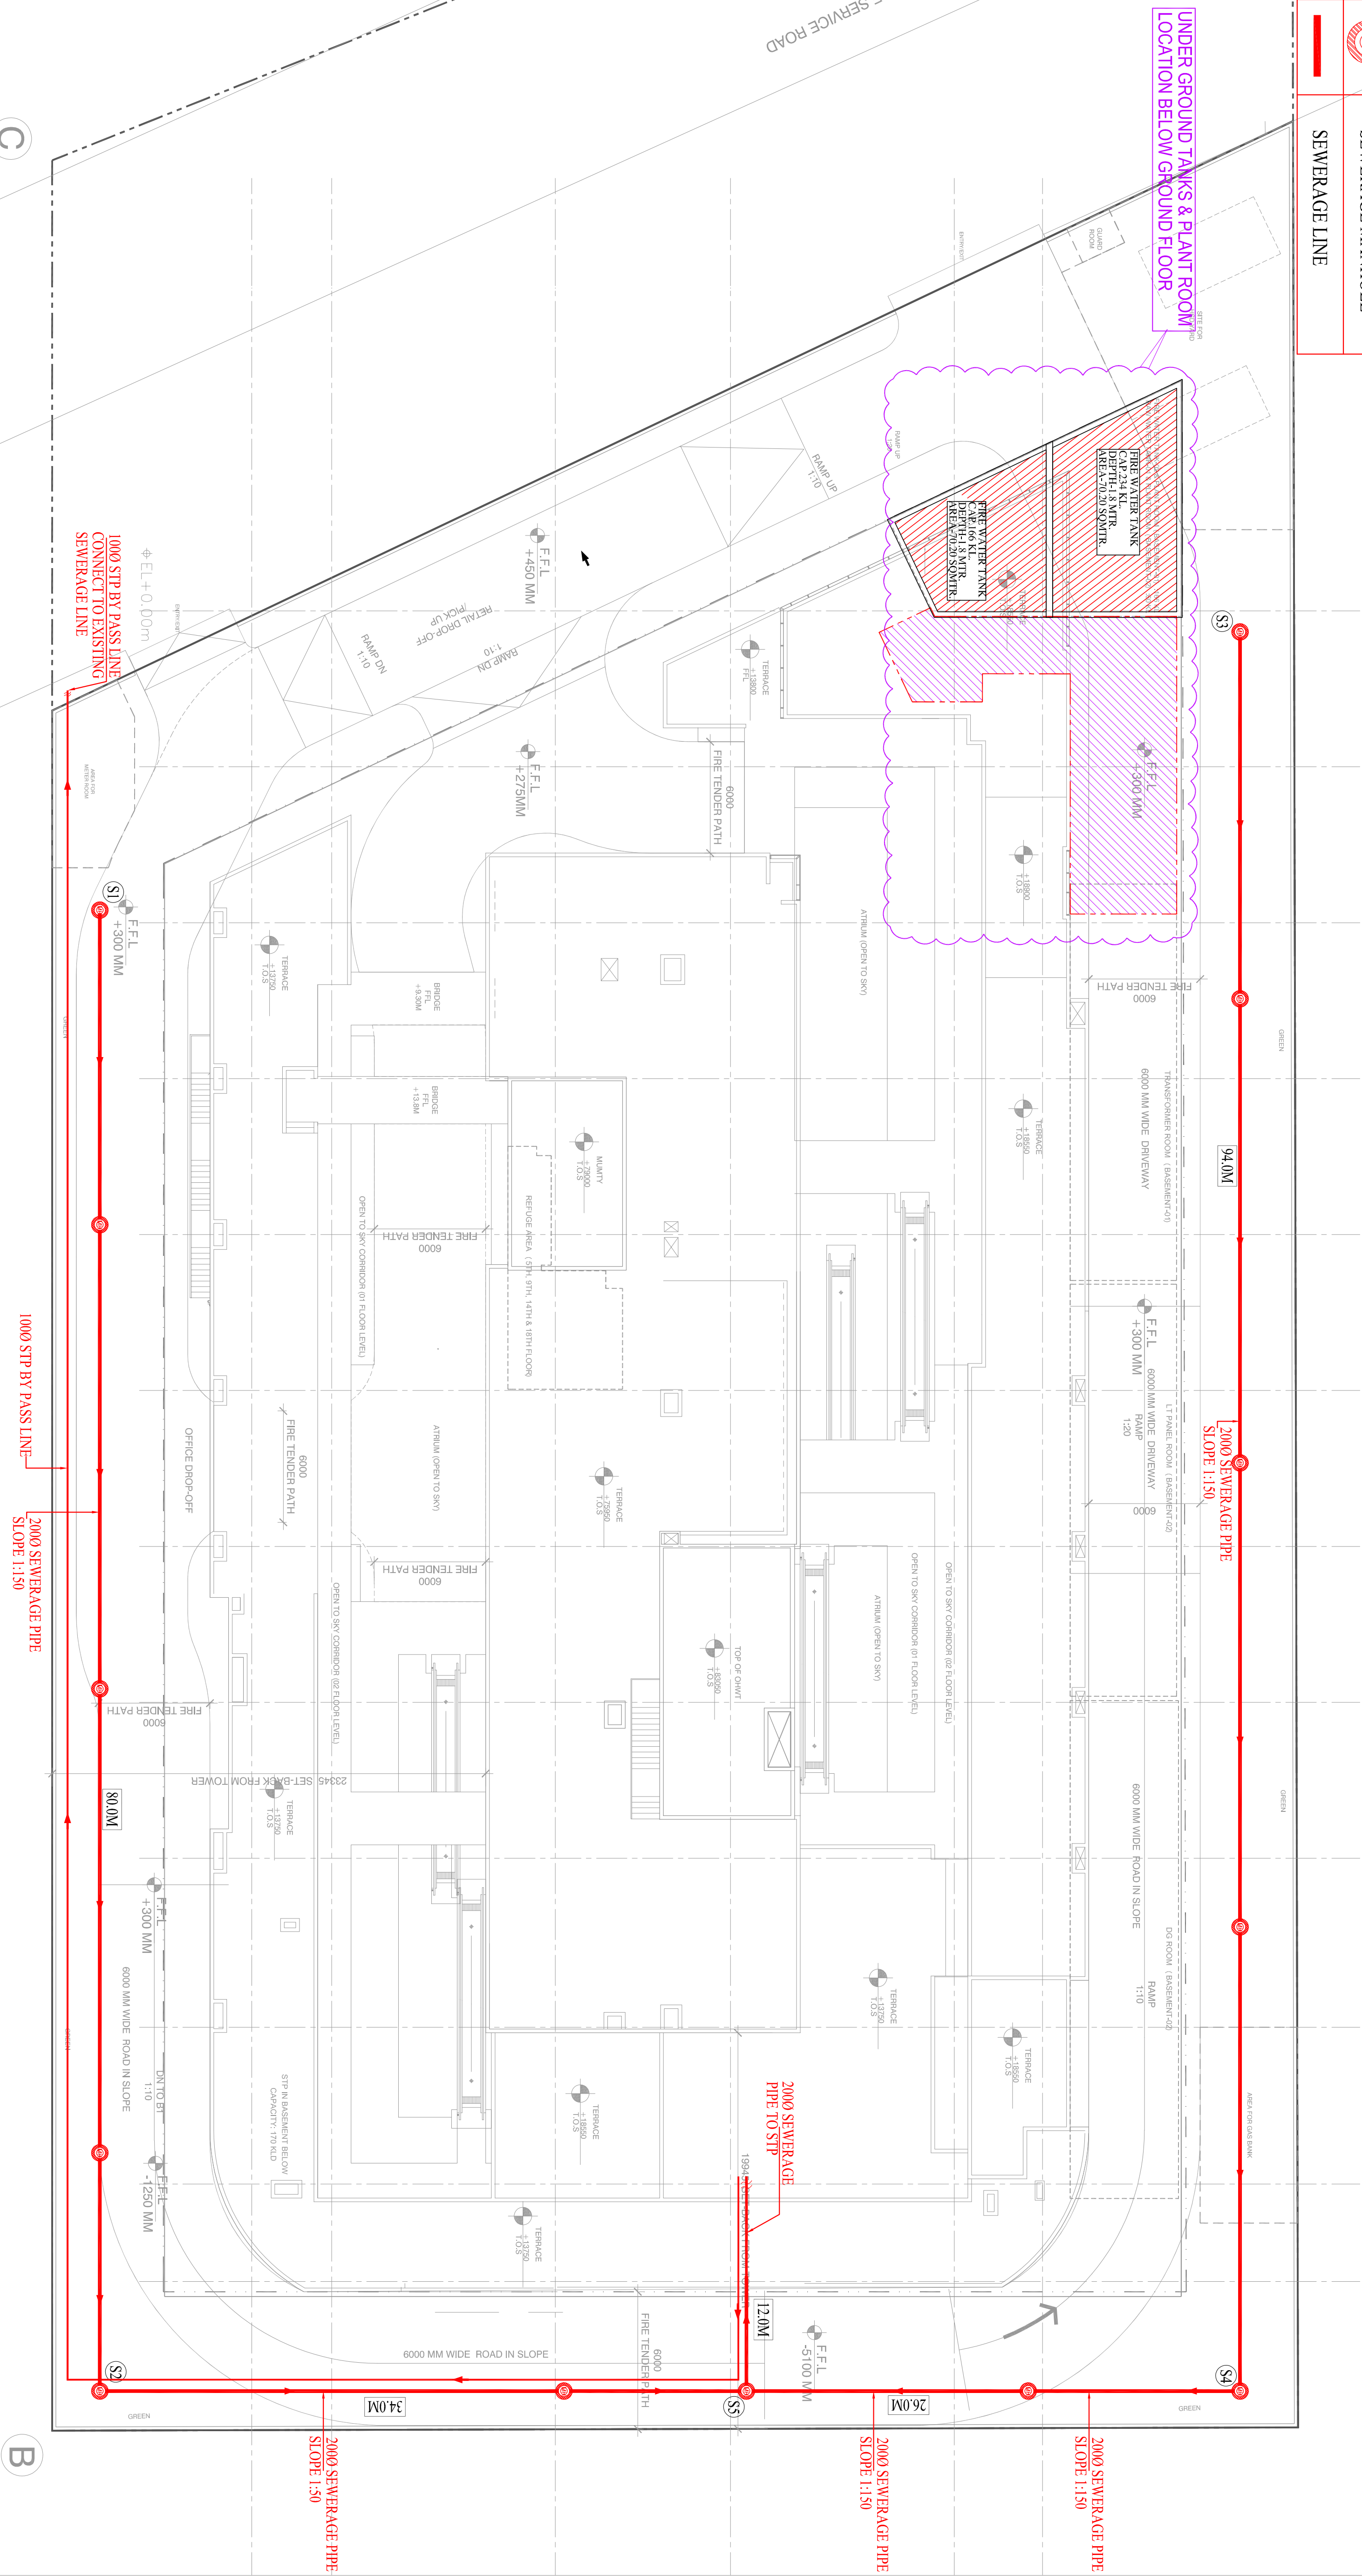

STRUCTURAL CONSULTANTS		CONSTRUCTIVE DESIGN PVT. LTD. 3rd Floor, Akshatik Plaza, Part-1 Pocket B, Mayapuri Vihar, Phase-2 New Delhi-110091 Ph. 01122718008, 22724917 Email: constructur@gmail.com
PROFESSIONAL CONSULTANTS		EPR CONSULTANTS PVT. LTD. Basement-389, Mitt Khanda Indraprastha, Ghaziabad-201010 Ph. 91120486304, 919971122470 Email: samish.singh@ed-group.com www.ed-group.com
WEEK CONSULTANTS		AAPORER CONSULTANCY SERVICES B-222 (Second Floor) Naraina Ind. Area, Phase-1, New Delhi-110028 New Delhi-110028 Ph. 43554718, 41414735 Fax No. 41414735 Mobile: 9918355408 Email: +91991067414735 Website: www.aaporerconsultancy.com
NOTES:		1. ALL DIMENSIONS ARE TO BE READ ONLY. 2. ALL DIMENSIONS ARE IN MM UNLESS MENTIONED ONLY. 3. ALL LEVELS MENTIONED ARE FINISHED FLOOR LEVEL. 4. UNLESS MENTIONED, 1:0.5 = 10' OF 3/4" 8/16 5. DIMENSIONS ARE USED ONLY FOR SERVICES & PARKING. 6. DIMENSIONS ARE TO BE COORDINATED WITH RELEVANT 7. REFER RETAIL DRAWINGS FOR CORRS, STAIRCASES, 8. ALL WALLS ARE 200 MM THICK. 9. ALL WALLS ARE 100 MM THICK. 10. UNLESS OTHERWISE SPECIFIED, ALL WALLS ARE 100 MM THICK. 11. ALL WALLS ARE 100 MM THICK. 12. ALL RETAINING WALL JUNCTIONS ARE AT RIGHT 13. STRUCTURE AND SERVICES LIKE HVAC & PLUMBING 14. UNLESS OTHERWISE SPECIFIED
PROJECT		COLONNADA Building Plan Commercial Colony measuring 2.25 Acres (License No. 63 of 2006 dated 19.08.2006) in Sector 60, Gurugram Mahanagar Urban Complex. BEING DEVELOPED BY: C/O EMAR MGF LAND LTD.
OWNER'S SIGNATURE		
ARCHITECT'S SIGNATURE		
ARCHITECTS		R204DESIGN 923 E. 3RD STREET, SUITE 100 LOS ANGELES, CA 90013 t: +1 213 620 6270 f: +1 213 720 6276
RSA R204 Architects		Suite B 6, W - 43, Greater Kailash - II, New Delhi - 110 048 e: info@rsa204.com t: (011) 4163 6160/8979
PLUMBING & FIRE FIGHTING CONSULTANT:		
KUMAR ENDECON PVT. LTD.		E-212, Greater Kailash- II, New Delhi, 110048
TITLE		SUBMISSION DRAWING SITE PLAN SEWERAGE LAYOUT SCHEME
SCALE		1: 125
DRAWING NO.		SE/PL-01
SEWERAGE LAYOUT		