


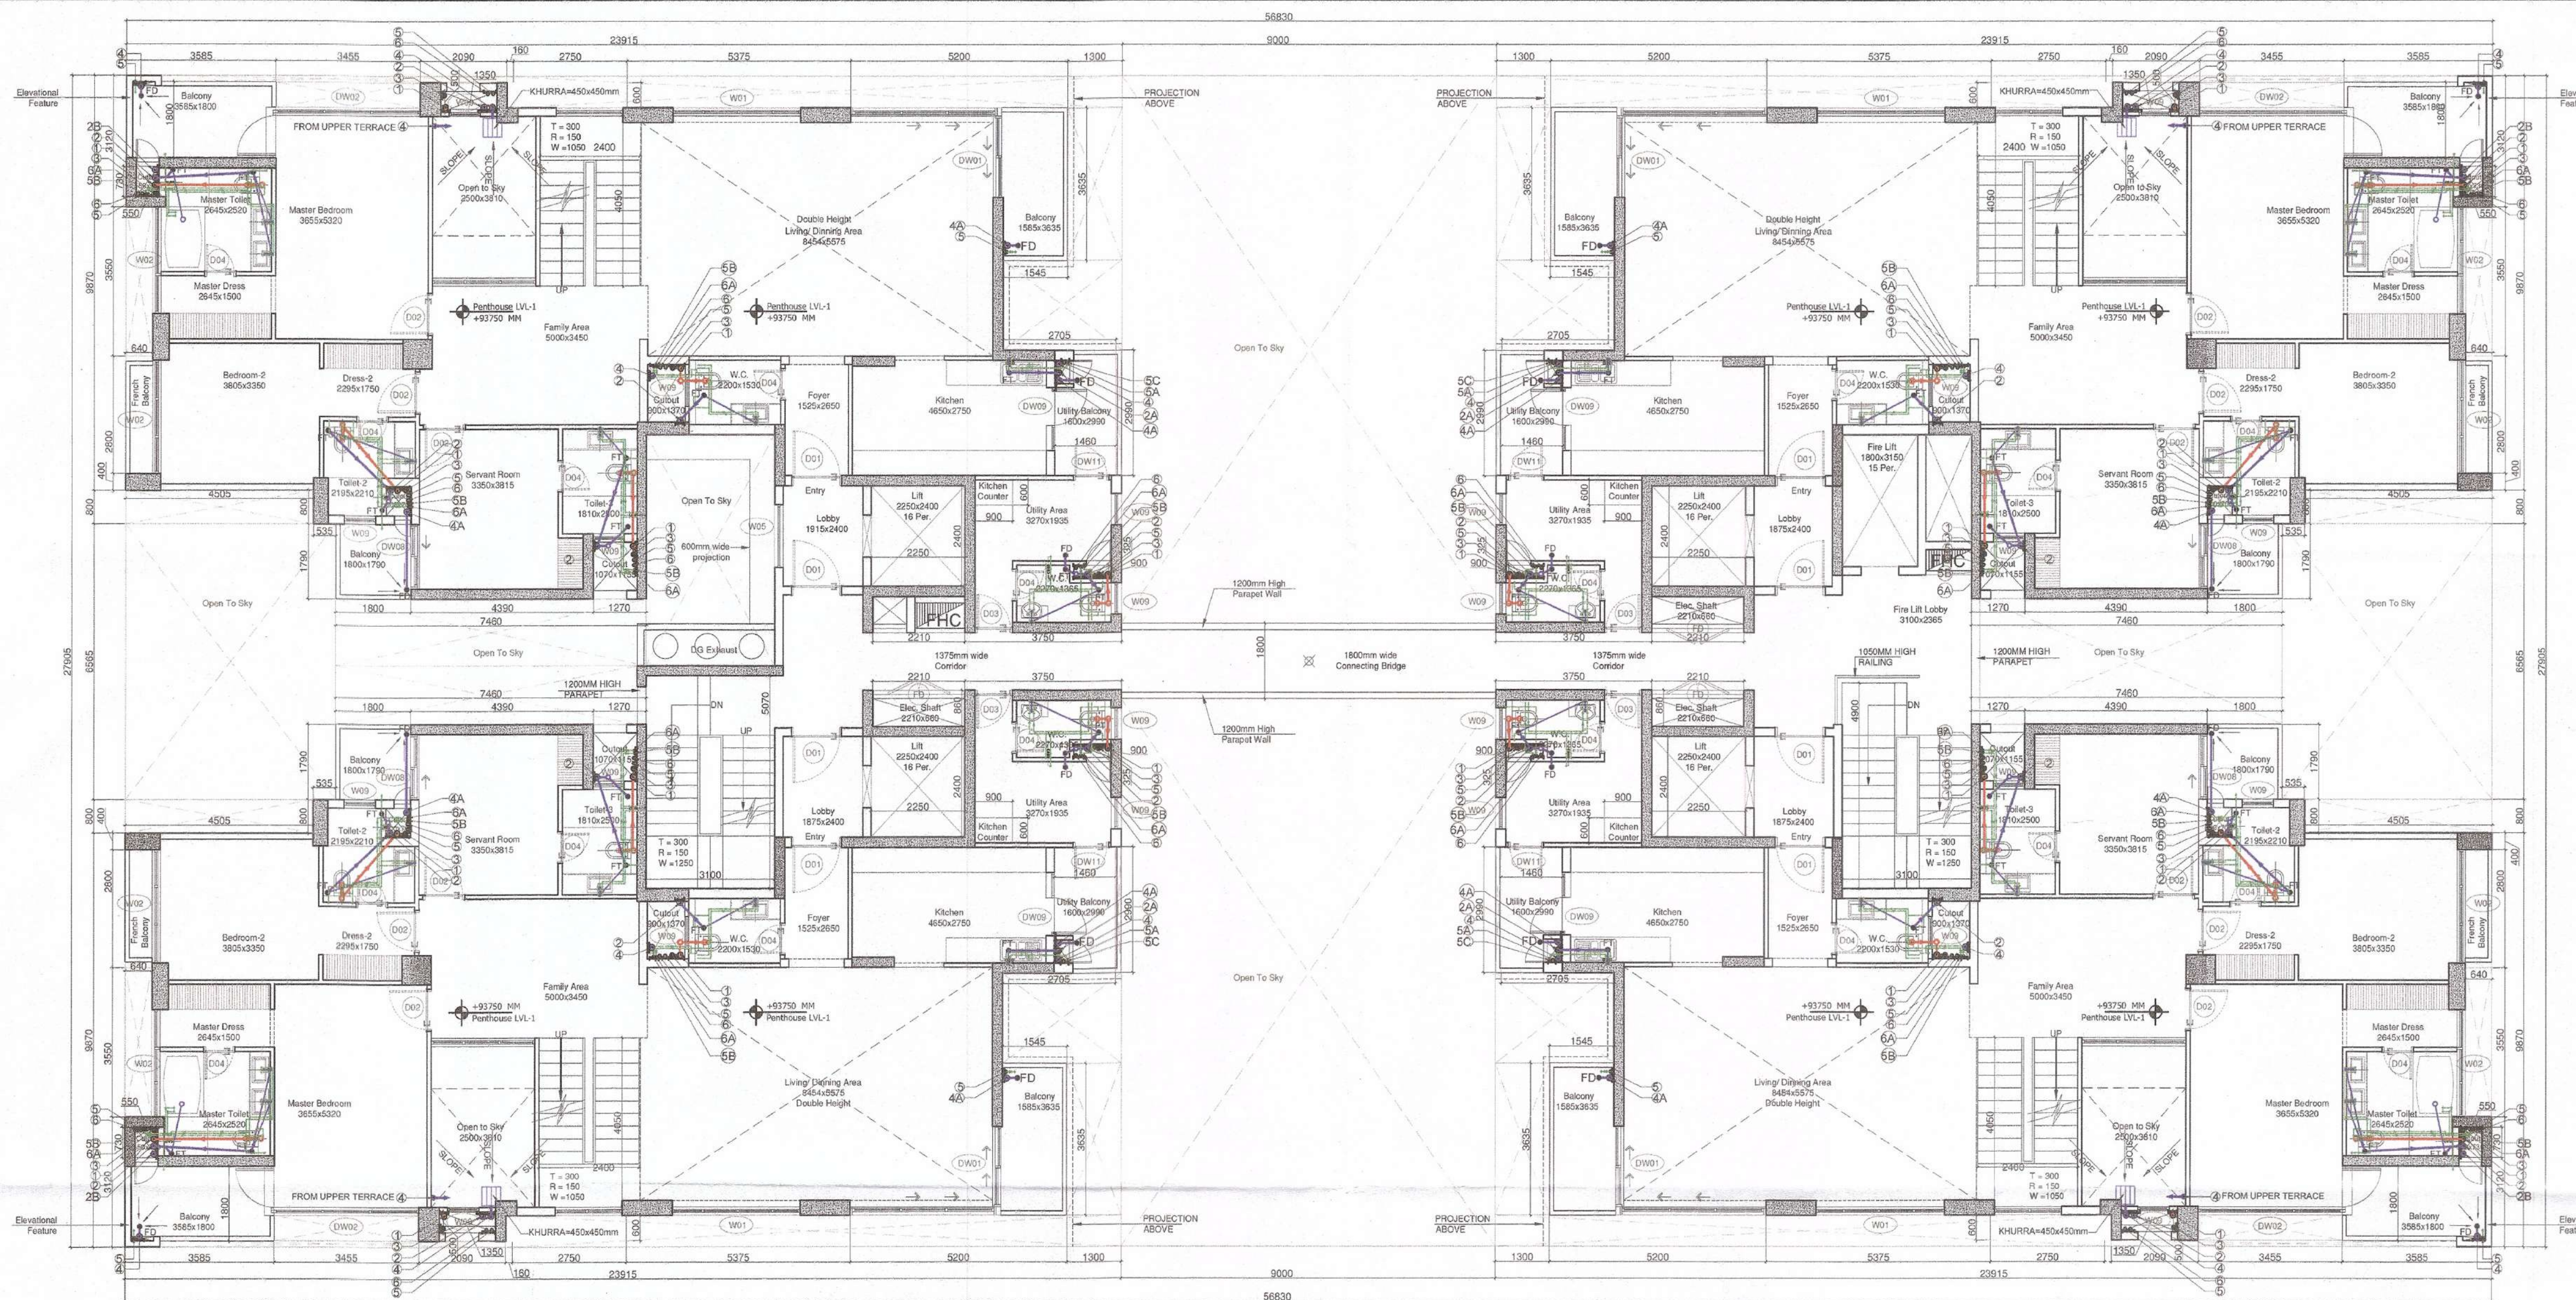

1 Tower - A - 27th Floor Plan (Penthouse Level-1)
Scale: 1:100

DOOR - WINDOW SCHEDULE						
INTERNAL DOORS						
DOOR TAG	ROOM DESCRIPTION	QTY	WIDTH	HEIGHT	CLL	LINTEL
D01	ENTRANCE / PRIVATE LOBBY		1200	2450**	±00	2400
D02	ALL BEDROOMS, UTILITY		1000	2450**	±00	2400
D03	UTILITY		900	2450**	±00	2400
D04	ALL TOILETS		750	2450**	±00	2400
D05	ELECTRICAL ROOM				±00	
D06	TERRACE LOBBY				±00	
FD01	Electrical Shaft		1500	2450**	±00	2400
FD02	STAIRCASE		1250	2450**	±00	2400
FD03	LV SHAFT		600	2450**	±00	2400
EXTERNAL DOORS						
DW01	LIVING / DINING		5510	2650	+100 / +900	2700
DW02	MASTER BEDROOM		4655 (AS / PLAN)	3650 / 1800	+100 / +900	2700
DW02A	SERVANT ROOM		4550 (AS / PLAN)	2650 / 1800	+100 / +900	2700
DW03	LIVING / DINING		4100	2650	+100	2700
DW04	LIVING / DINING		2750	2650	+100	2700
DW05	BEDROOM - 2		2450	2650	+100	2700
DW06	MASTER BEDROOM		2400 (AS / PLAN)	2650 / 1800	+100 / +900	2700
DW07	BEDROOM - 2 / SERVANT ROOM		1660	2650	+100	2700
DW08	BEDROOM - 3		1550	2650	+100	2700
DW09	KITCHEN		1500 (AS / PLAN)	2750 / 1800	±00 / +1200	2700
DW10	MASTER BEDROOM		1000	2650	+100	2700
DW11	UTILITY / KITCHEN		850	2450	+100	2400

DOOR TAG	ROOM DESCRIPTION	QTY	STRUCTURAL OPENING		LEVEL (FROM FFL)	
			WIDTH	HEIGHT	CELL	LINTEL
WINDOWS						
W01	LIVING / DINING		3400	1800	900	2700
W02	BEDROOM - 2 / BEDROOM - 4 / M. TOILET		2570	1800	900	2700
W03	BEDROOM - 2		2100	1800	900	2700
W04	KITCHEN		1925	1500	1200	2700
W05	STAIRCASE / CORRIDOR		1250	1500	1200	2700
W06	MASTER TOILET / TOILET-2		900	1500	1200	2700
W07	STAIRCASE		900	1200	1200	2700
W08	MASTER BEDROOM		800	1800	900	2700
W09	M. TOI. / TOI. - 3 / TOI. - 2 / TOI. / UTILITY / W.C.		750	1500	1200	2700
W10	SERVANT ROOM		600	1800	900	2700

Sign & Stamp

S.T.P. Member Secretary B.P.C. Chairman
 S.T.P. Member Secretary B.P.C. Chairman
 S.T.P. Member Secretary B.P.C. Chairman
 S.T.P. Member Secretary B.P.C. Chairman

KEY PLAN

Checked and found ok for Public Health
 (Internal) services only subject to comments
 forwarding to the S.T.P. Member Secretary B.P.C. Chairman
 S.T.P. Member Secretary B.P.C. Chairman
 S.T.P. Member Secretary B.P.C. Chairman

This is a "PROVISIONAL APPROVED BUILDING PLAN"
 only for purpose of building
 "Not for the general public"

Architect (Pvt.)
 Director of Town and Country Planning,
 Haryana, Chandigarh

PLUMBING LEGEND:-

①	1000 CI SOIL PIPE
②	1000 CI WASTE PIPE
③	1000 CI WASTE PIPE FOR KITCHEN
④	1000 DRAIN PIPE FOR SWIMMING POOL
⑤	750 CI ASP
⑥	1100 UPVC RWP FOR TERRACE
⑦	1100 UPVC RWP FOR BALCONY
⑧	COLD WATER SUPPLY DROP
⑨	COLD WATER SUPPLY DROP FOR KITCHEN
⑩	COLD WATER SUPPLY DROP FOR TOP THREE FLOORS
⑪	COLD WATER SUPPLY DROP FOR KITCHEN TOP THREE FLOORS
⑫	FLUSHING WATER SUPPLY DROP
⑬	FLUSHING WATER SUPPLY DROP FOR TOP THREE FLOORS
⑭	COLD WATER SUPPLY RISER FOR OHT
⑮	FLUSHING WATER SUPPLY RISER FOR OHT
⑯	WATER HEATER CAPACITY-25/15 LTRS
⑰	FLOOR TRAP (100x100)MM
⑱	FLOOR DRAIN (100x50)MM
⑲	BALL VALVE

PROJECT NAME & ADDRESS

APPROVAL OF REVISED BUILDING PLANS OF RESIDENTIAL GROUP
 HOUSING COLONY UNDER TRANSIT ORIENTED DEVELOPMENT
 (TOD) POLICY FOR MIX LAND USE COLONY
 (70% RESIDENTIAL+30%COMMERCIAL) MEASURING 4.85 ACRES
 (LICENSE No. 110 OF 2013 DATED 27.12.2013) IN SECTOR - 28,
 GURUGRAM MANESAR URBAN COMPLEX BEING DEVELOPED BY
 SILVERGLADES INFRASTRUCTURE PVT. LTD.

CLIENT NAME & ADDRESS

GROUP SILVERGLADES
 5th FLOOR, TIME SQUARE BUILDING, B-BLOCK,
 SUSHANT LOK, PHASE-1, GURUGRAM - 122002,
 HARYANA, INDIA

ARCHITECT'S SIGN & STAMP

ANAND SHARMA
 B. Arch (Hons), M.C.A.
 CAT No. 8734, KILAJIA-12710

DRAWING TITLE

Tower - A - 27th Floor Plan
 (Penthouse Level-1)

SCALE	DRAWING NO.	NORTH
1:100 ON A1	011	
DATE		
27-12-2019		