


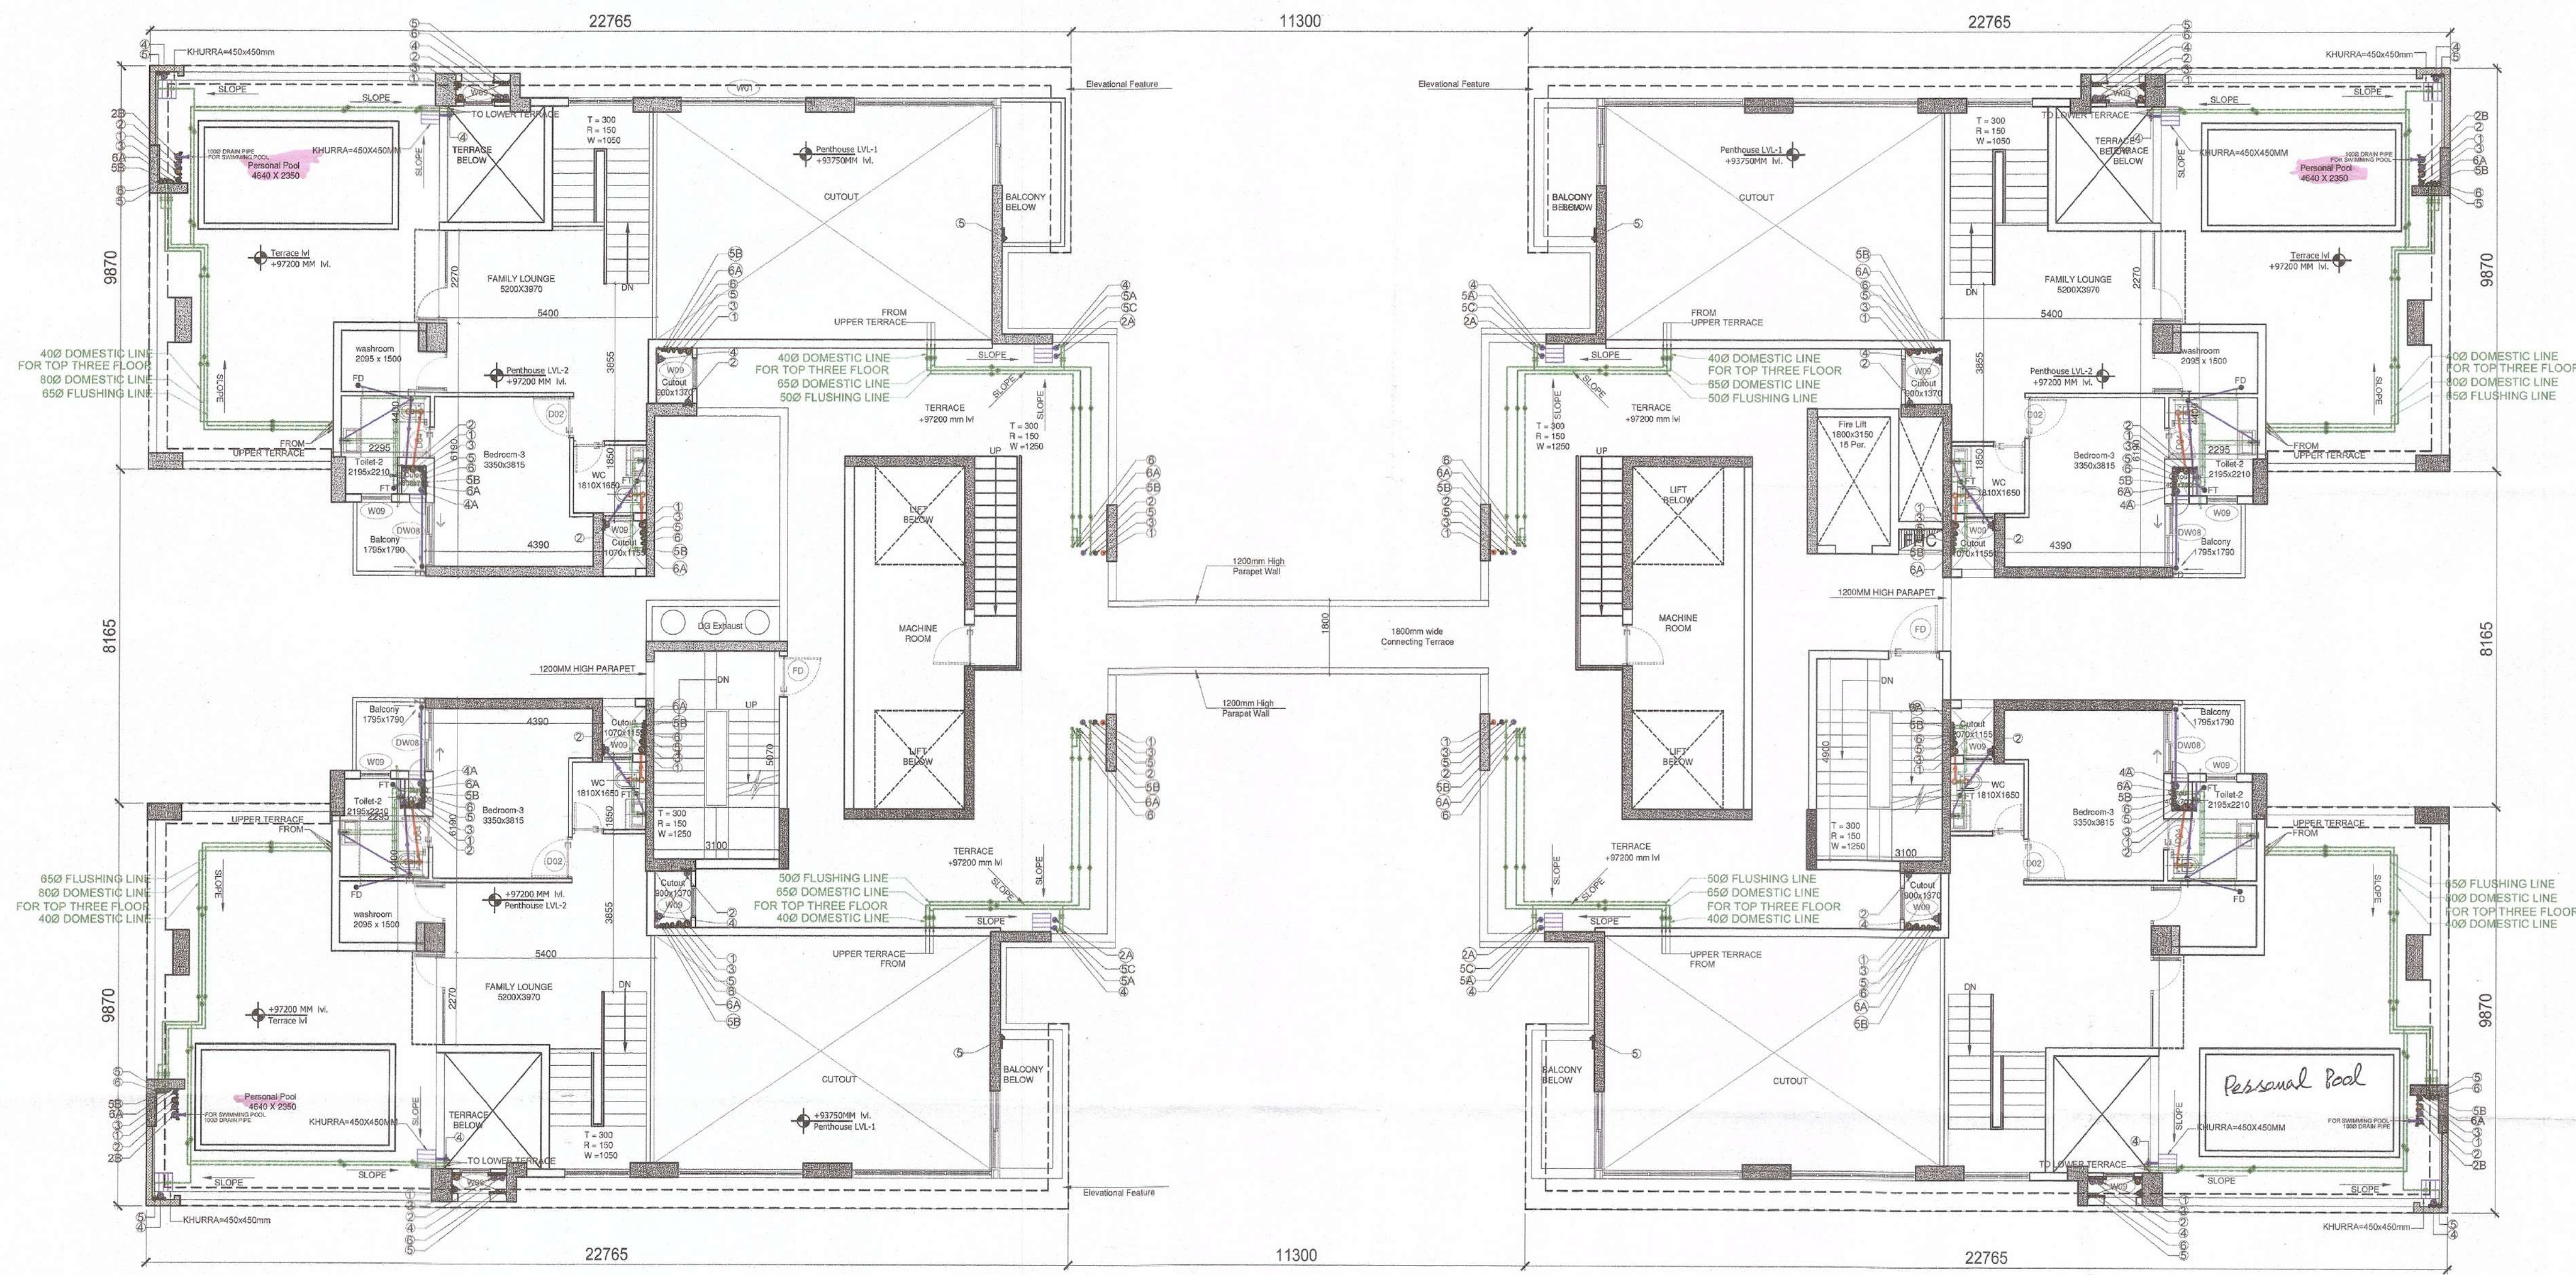


1 Tower - A - 28th Floor (Penthouse Level -2) Plan

Scale: 1:100

DOOR - WINDOW SCHEDULE					
INTERNAL DOORS					
DOOR TAG	ROOM DESCRIPTION	QTY	WIDTH	HEIGHT	LEVEL (FROM FFL)
D01	ENTRANCE / PRIVATE LOBBY		1200	2450**	±00
D02	ALL BEDROOMS, UTILITY,		1000	2450**	±00
D03	UTILITY		900	2450**	±00
D04	ALL TOILETS,		750	2450**	±00
D05	ELECTRICAL ROOM,				±00
D06	TERRACE LOBBY				±00
FD01	Electrical Shaft		1500	2450**	±00
FD02	STAIRCASE		1250	2450**	±00
FD03	LV SHAFT		600	2450**	±00
EXTERNAL DOORS					
DW01	LIVING / DINING		5510	2650	+100 / +900
DW02	MASTER BEDROOM		4655 (AS / PLAN)	2650 / 1800	+100 / +900
DW02A	SERVANT ROOM		4550 (AS / PLAN)	2650 / 1800	+100 / +900
DW03	LIVING / DINING		4100	2650	+100
DW04	LIVING / DINING		2750	2650	+100
DW05	BEDROOM - 2		2450	2650	+100
DW06	MASTER BEDROOM		2400 (AS / PLAN)	2650 / 1800	+100 / +900
DW07	BEDROOM - 2 / SERVANT ROOM		1660	2650	+100
DW08	BEDROOM - 3		1550	2650	+100
DW9	KITCHEN		1550 (AS / PLAN)	2750 / 1800	±00 / +1200
DW10	MASTER BEDROOM		1000	2650	+100
DW11	UTILITY / KITCHEN		850	2450	+100

DOOR TAG						
DOOR TAG	ROOM DESCRIPTION	QTY	STRUCTURAL OPENING		LEVEL (FROM FFL)	
			WIDTH	HEIGHT	CILL	LINTEL
WINDOWS						
W01	LIVING / DINING		3400	1800	900	2700
W02	BEDROOM - 2 / BEDROOM - 4 / M. TOILET		2570	1800	900	2700
W03	BEDROOM - 2,		2100	1800	900	2700
W04	KITCHEN		1925	1500	1200	2700
W05	STAIRCASE / CORRIDOR		1255	1500	1200	2700
W06	MASTER TOILET / TOILET-2		900	1500	1200	2700
W07	STAIRCASE		900	1200	1200	2700
W08	MASTER BEDROOM		800	1800	900	2700
W09	M. TOI. / TOI. - 3 / TOI. - 2 / TOI. / UTILITY W.C.		750	1500	1200	2700
W10	SERVANT ROOM		600	1800	900	2700

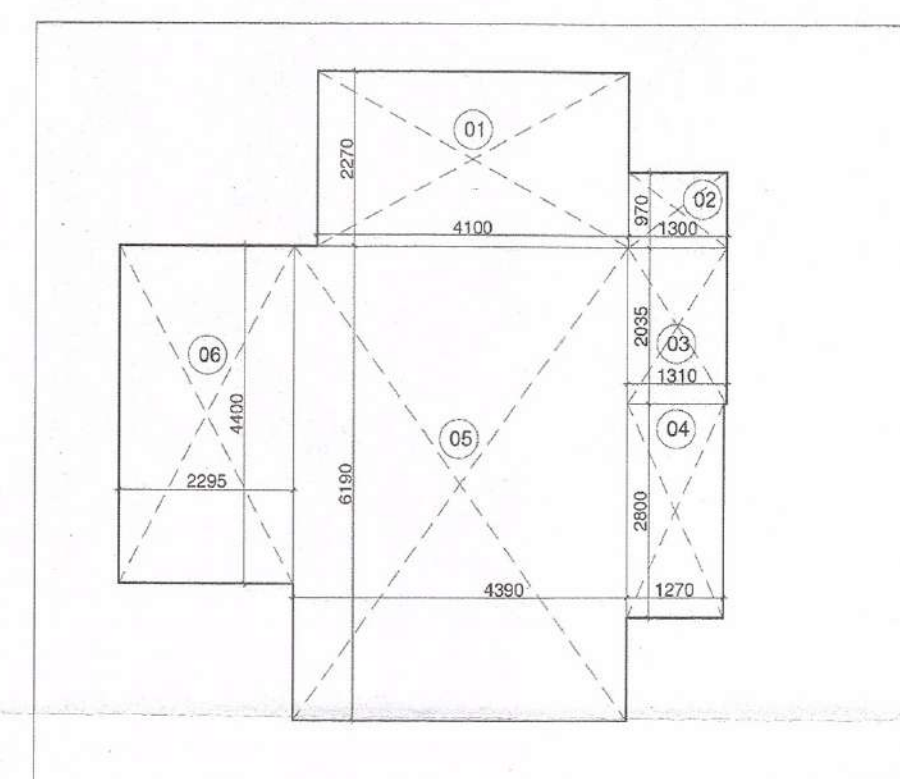

2 Tower - A - 28th Floor (Penthouse Level -2) Area Diagram

Scale: 1:100

TOWER A 28th FLOOR (PENTHOUSE LEVEL-2) FAR AREA CALCULATION						
TYPE	QUANTITY	SHAPE	FORMULA	DETAIL	CALCULATION EACH AREA IN SQ.M	
FAR AREA						
1	4	RECTANGLE	L x B	4.100	2.270	37.228
2	4	RECTANGLE	L x B	1.300	0.970	5.044
3	4	RECTANGLE	L x B	2.035	1.310	10.663
4	4	RECTANGLE	L x B	2.800	1.270	14.224
5	4	RECTANGLE	L x B	6.190	3.990	108.696
6	4	RECTANGLE	L x B	4.400	2.295	40.392
TOTAL FAR AREA						216.248

Sign & Stamp

S.D. (B) C.T.P. (B) Chairman
 Member Secretary BPC
 BPC
 JD PA ATP

Deputy Director (T)
 O/o Directorate of Town and Country Planning
 Member BPC

KEY PLAN

Checked and found ok for Public Health
 (Internal Services) subject to comments in
 forwarded No. SEP/CO/2019/141/2020
 26/11/2020
 S.D. (B) C.T.P. (B) Chairman
 Member Secretary BPC

This is a "PROVISIONAL APPROVED BUILDING PLAN"
 only for purpose of inviting
 competition from the general public
 Director of Town and Country Planning,
 Haryana, Chandigarh

PLUMBING LEGEND :-

①	1000 CI SOIL PIPE
②	1000 CI WASTE PIPE
③	1000 CI WASTE PIPE FOR KITCHEN
④	1000 CI DRAIN PIPE FOR SWIMMING POOL
⑤	750 CI ASP
⑥	1100 UPVC RWP FOR TERRACE
⑦	1100 UPVC RWP FOR BALCONY
⑧	COLD WATER SUPPLY DROP
⑨	COLD WATER SUPPLY DROP FOR KITCHEN
⑩	COLD WATER SUPPLY DROP FOR TOP THREE FLOORS
⑪	COLD WATER SUPPLY DROP FOR KITCHEN TOP THREE FLOORS
⑫	FLUSHING WATER SUPPLY DROP
⑬	FLUSHING WATER SUPPLY DROP FOR TOP THREE FLOORS
⑭	COLD WATER SUPPLY RISER FOR OHT
⑮	FLUSHING WATER SUPPLY RISER FOR OHT
⑯	WATER HEATER CAPACITY-25/15 LTRS
⑰	FLOOR TRAP (100x100)MM
⑱	FLOOR DRAIN (100x50)MM
⑲	BALL VALVE

PROJECT NAME & ADDRESS

APPROVAL OF REVISED BUILDING PLANS OF RESIDENTIAL GROUP
 HOUSING COLONY UNDER TRANSIT ORIENTED DEVELOPMENT
 (TOD) POLICY FOR MIX LAND USE COLONY
 (70% RESIDENTIAL + 30% COMMERCIAL) MEASURING 4.85 ACRES
 (LICENSE No. 110 OF 2013 DATED 27.12.2013) IN SECTOR - 28,
 GURUGRAM MANESAR URBAN COMPLEX BEING DEVELOPED BY
 SILVERGLADES INFRASTRUCTURE PVT. LTD.

CLIENT NAME & ADDRESS

GROUP SILVERGLADES
 8th FLOOR, TIME SQUARE BUILDING, B-BLOCK,
 SUSHANT LOK, PHASE-1, GURUGRAM - 122002,
 HARYANA, INDIA

ARCHITECT'S SIGN & STAMP

ANAND SHARMA
 B. Arch (Hons), M.C.A.
 CAPS (18739, AIIA/A-1238)

DRAWING TITLE

Tower - A - 28th Floor (Penthouse
 Level -2) and Area Diagram

SCALE

1:100 ON A1

DATE

27-12-2019

DRAWING NO.

013

NORTH