



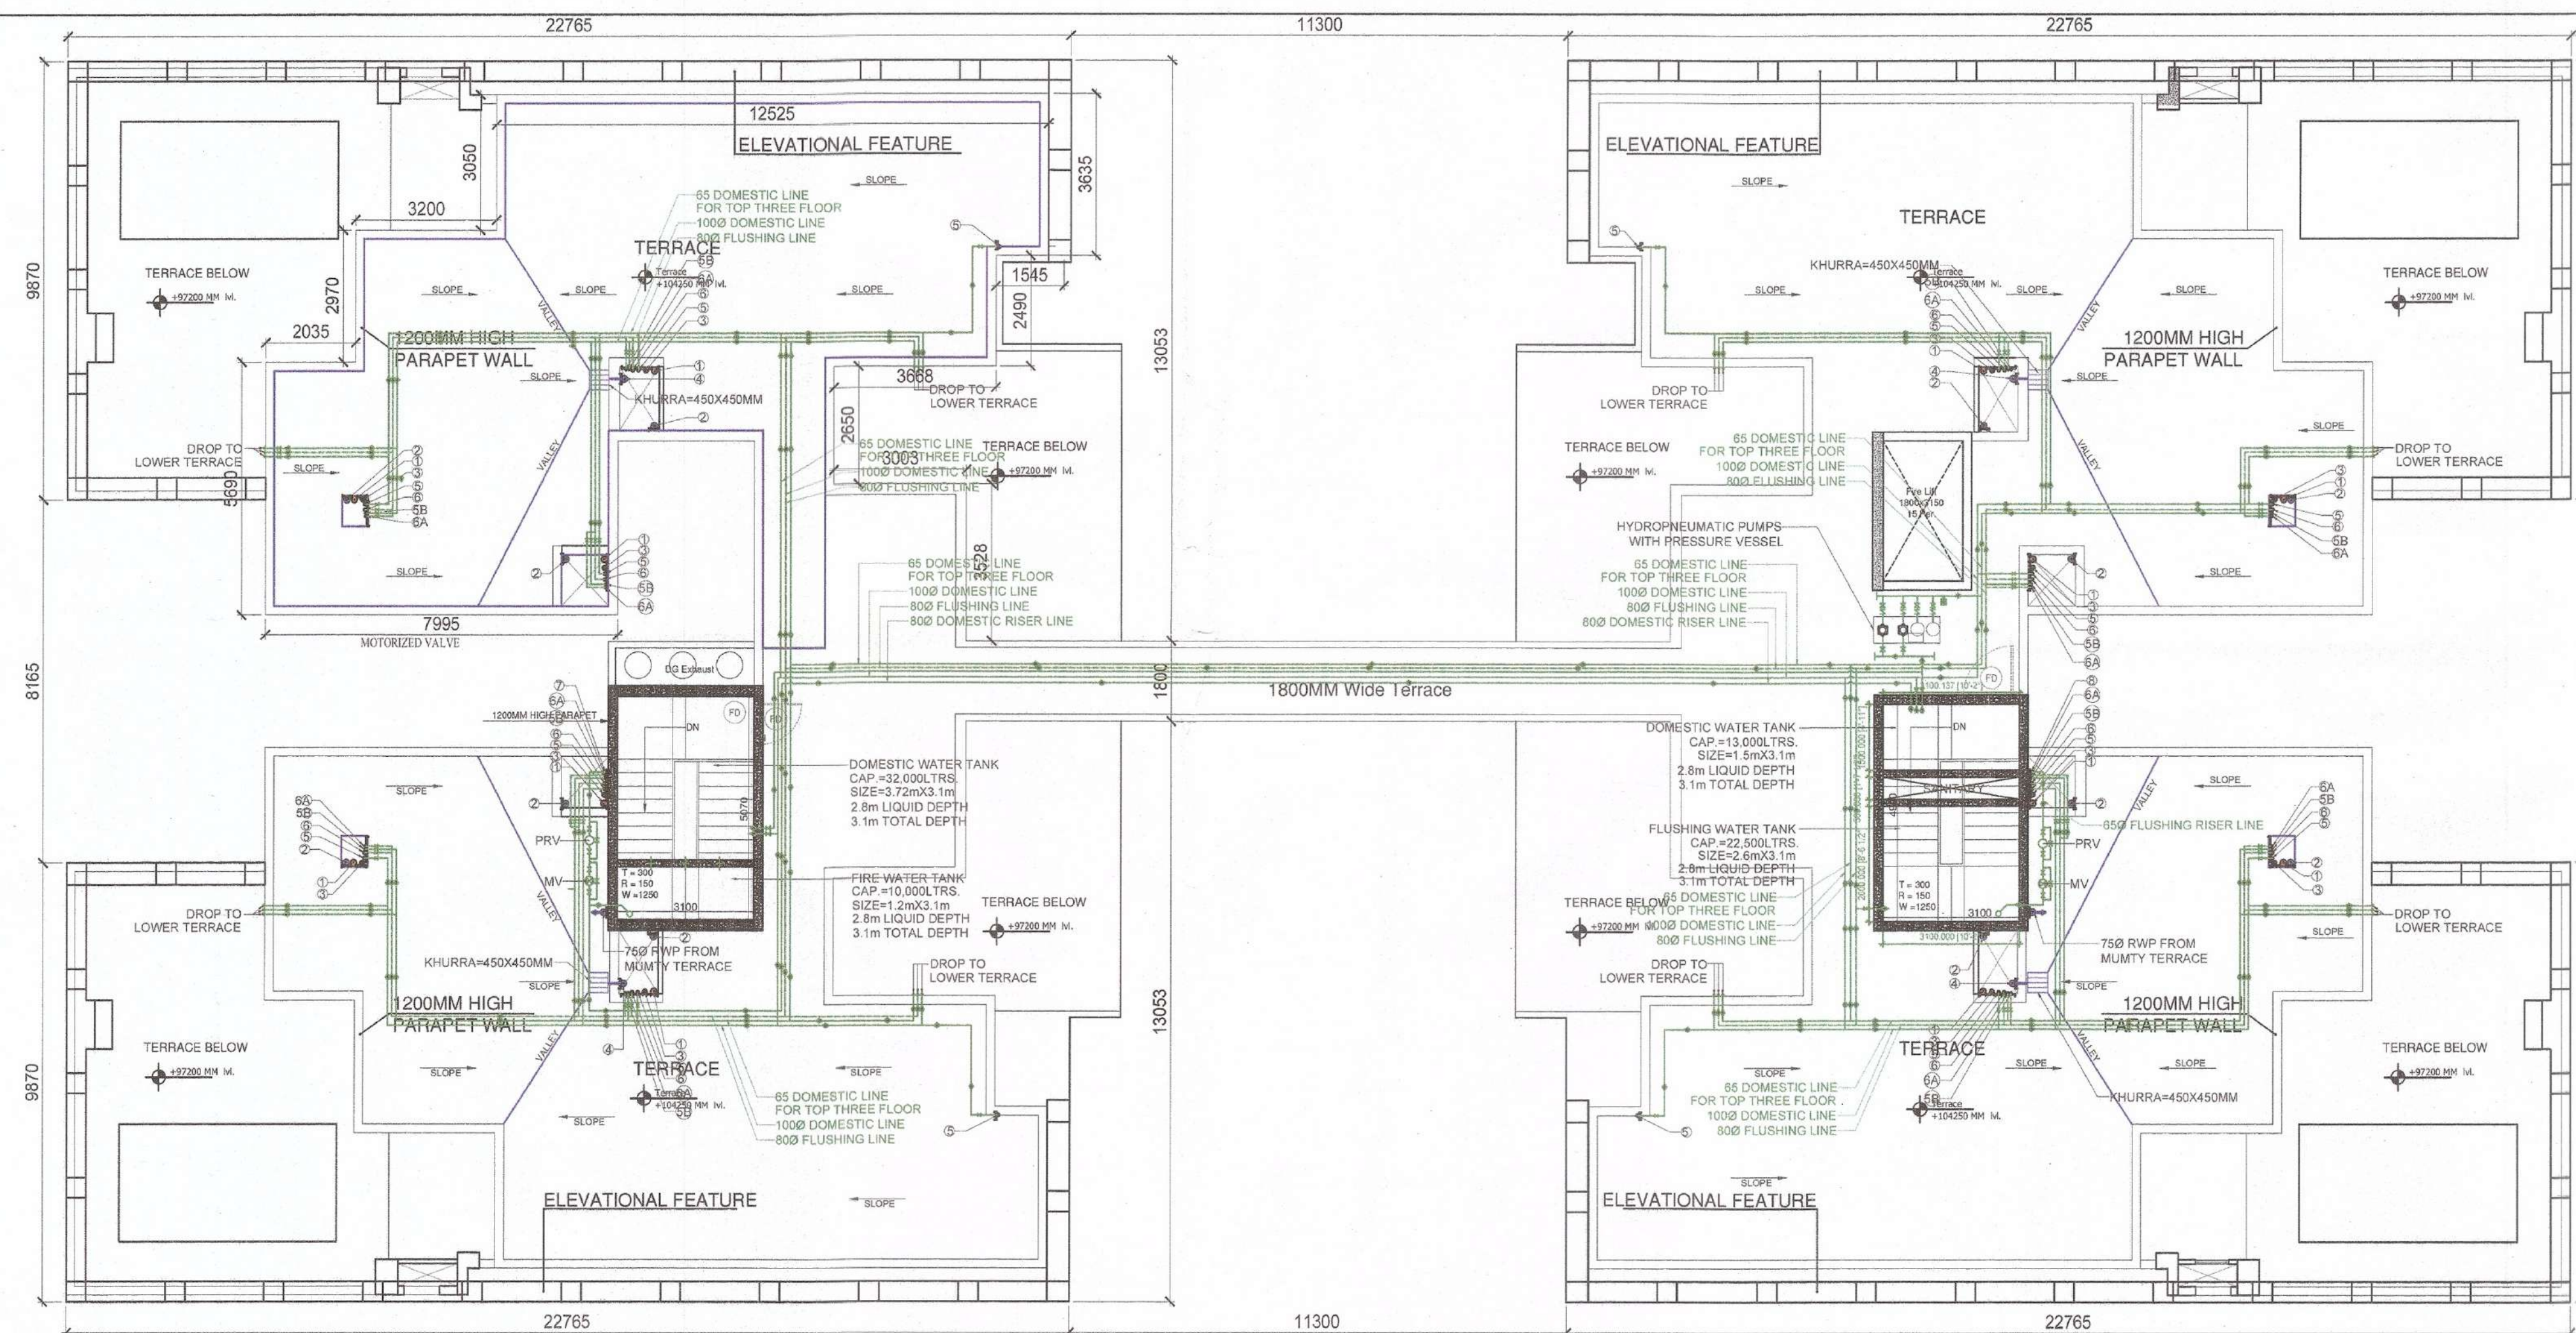

1 Tower - A - Terrace Plan
Scale: 1:100

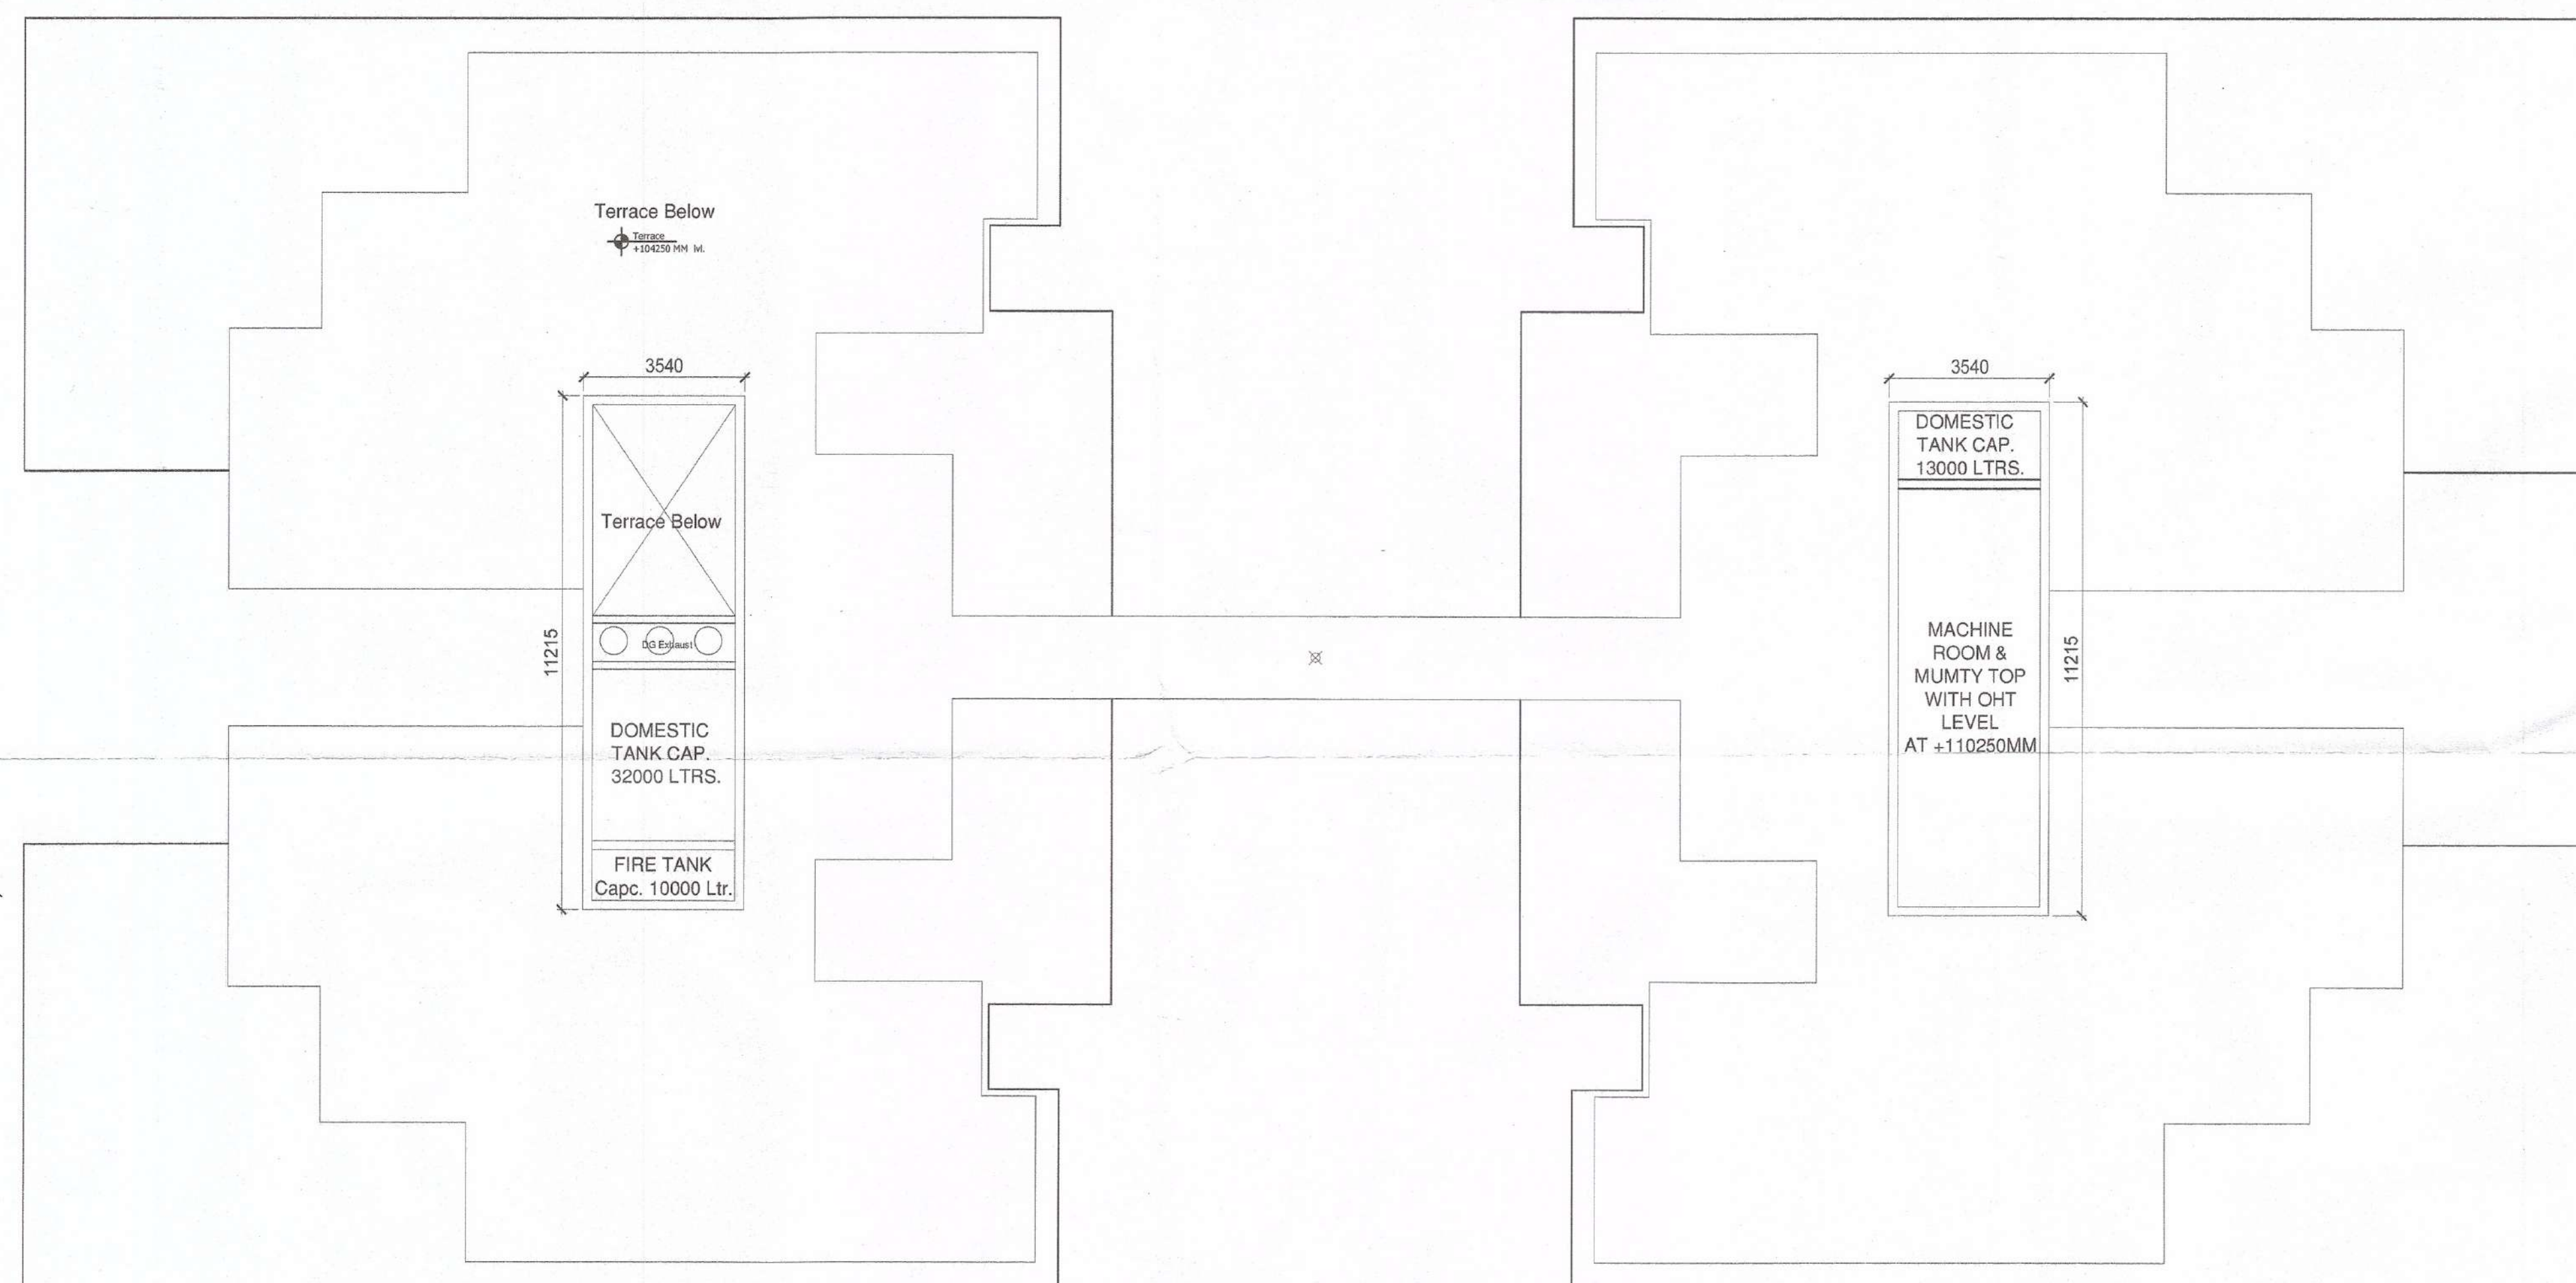

2 Tower - A - Mumty & OHWT Floor Plan
Scale: 1:100

Sign & Stamp

APPROVED FOR THE PROJECT BY THE CHAIRMAN OF THE BOARD OF P&C
S.T.P. (S) C.T.P. (M)
Member Secretary Member Chairman
B.P.C. B.P.C.
J.D. P.A. A.P.

Deputy Director (T)
O/o Directorate Fire Service
Member B.P.C.

KEY PLAN

Checked and found ok for Public Health
(Internal) services subject to comments in
forwarding letter No. SE/HQ/.../2020
25/1/2020
Superintendent Engineer (H)
HSVP, Panipat

This is a PROVISIONAL APPROVED BUILDING PLAN
only for purpose of levelling
objection from the general public

Architect (H)
Directorate of Town and Country Planning
Haryana, Chandigarh

PLUMBING LEGEND :-

①	1000 CI SOIL PIPE	
②	1000 CI WASTE PIPE	
③	1000 CI WASTE PIPE FOR KITCHEN	
④	1000 DRAIN PIPE FOR SWIMMING POOL	
⑤	750 CI ASP	
⑥	1100 UPVC RWP FOR TERRACE	
⑦	1100 UPVC RWP FOR BALCONY	
⑧	COLD WATER SUPPLY DROP	
⑨	COLD WATER SUPPLY DROP FOR KITCHEN	
⑩	COLD WATER SUPPLY DROP FOR TOP THREE FLOORS	
⑪	COLD WATER SUPPLY DROP FOR KITCHEN TOP THREE FLOORS	
⑫	FLUSHING WATER SUPPLY DROP	
⑬	FLUSHING WATER SUPPLY DROP FOR TOP THREE FLOORS	
⑭	COLD WATER SUPPLY RISER FOR OHT	
⑮	FLUSHING WATER SUPPLY RISER FOR OHT	
⑯	WATER HEATER CAPACITY: 25/15 LTRS	
⑰	FLOOR TRAP (100x100)MM	FT
⑱	FLOOR DRAIN (100x50)MM	FD
⑲	BALL VALVE	BV

PROJECT NAME & ADDRESS

APPROVAL OF REVISED BUILDING PLANS OF RESIDENTIAL GROUP HOUSING COLONY UNDER TRANSIT ORIENTED DEVELOPMENT (TOD) POLICY FOR MIX LAND USE COLONY (70% RESIDENTIAL+30%COMMERCIAL) MEASURING 4.85 ACRES (LICENSE No. 110 OF 2013 DATED 27.12.2013) IN SECTOR - 28, GURUGRAM MANESAR URBAN COMPLEX BEING DEVELOPED BY SILVERGLADES INFRASTRUCTURE PVT. LTD.

CLIENT NAME & ADDRESS

GROUP SILVERGLADES
5th FLOOR, TIME SQUARE BUILDING, B-BLOCK,
SUSHANT LOK, PHASE-1, GURUGRAM - 122002,
HARYANA, INDIA

ARCHITECT'S SIGN & STAMP

ANAND SHARMA
B. Arch (Hons), M.C.A.
CA/55/18738, N/A/A-12738

CLIENT'S SIGN & STAMP

Signature of Client
New Delhi

DRAWING TITLE

Tower - A - Terrace, Mumty & OHWT Level Plan

SCALE

1:100 ON A1
DATE
27-12-2019

DRAWING NO.

014

NORTH