



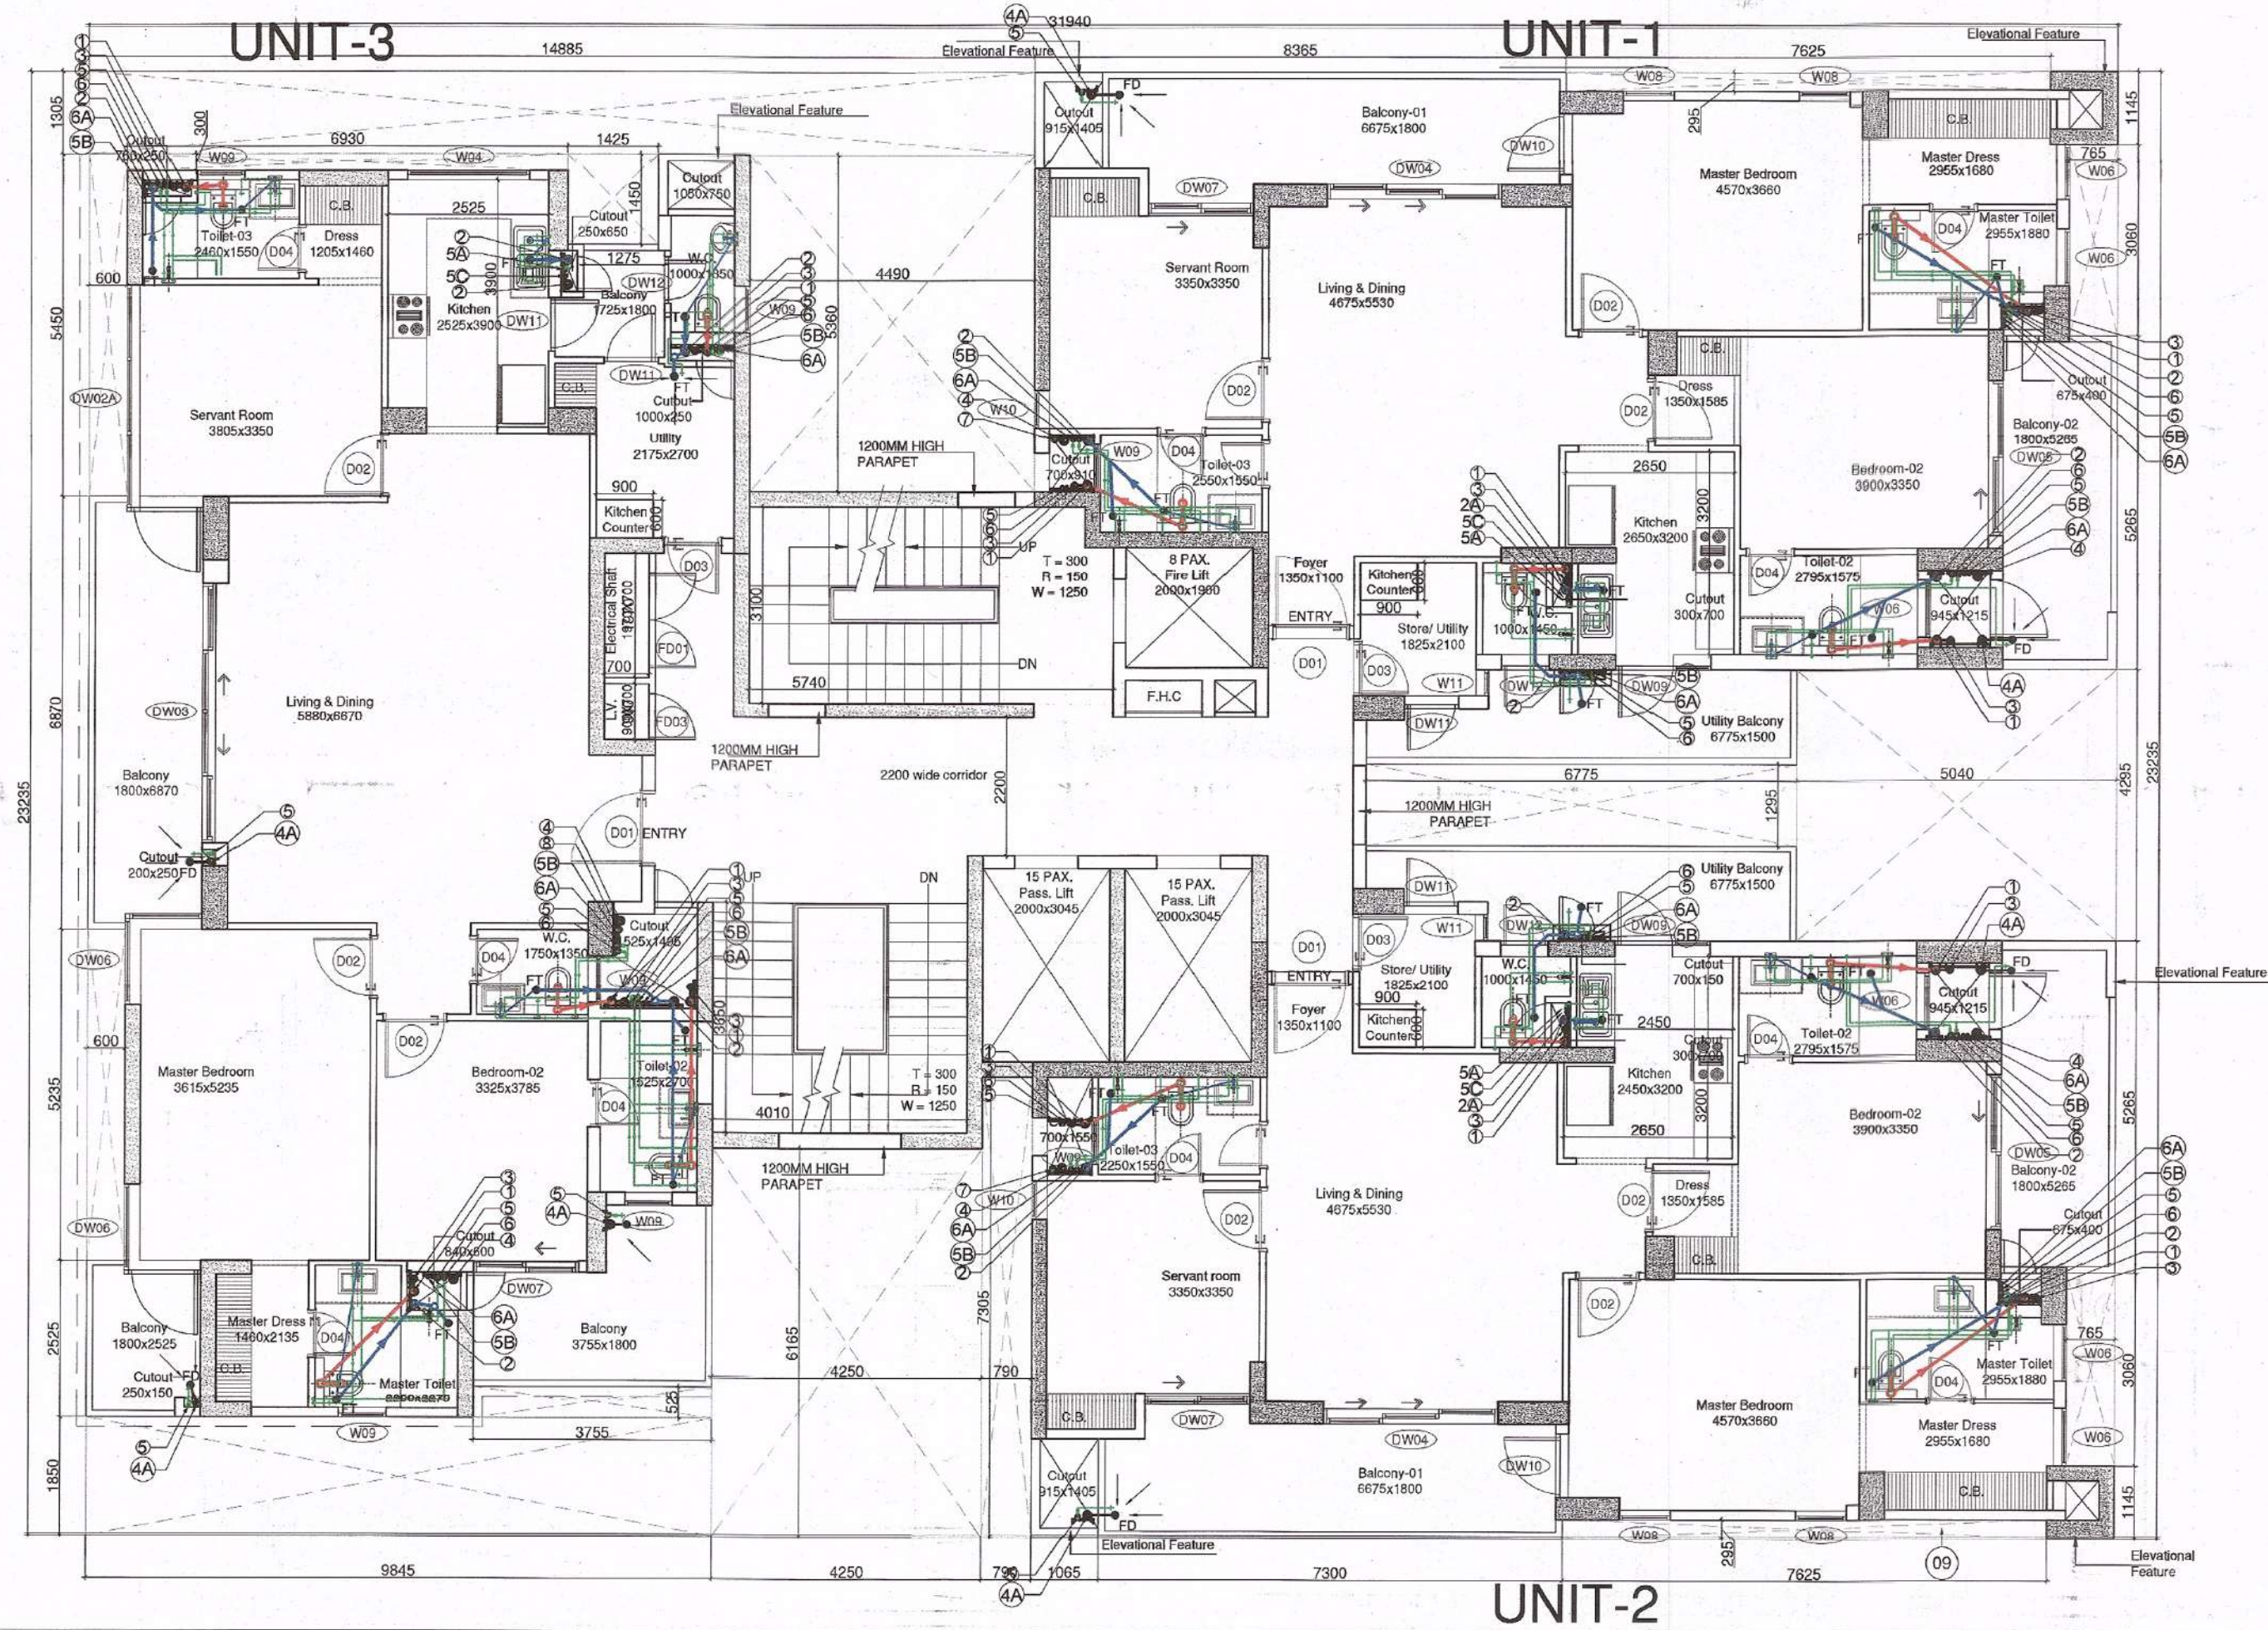

1 Tower B 1st to 23rd Typical Floor Plan (Except 16th Floor)
Scale: 1:100

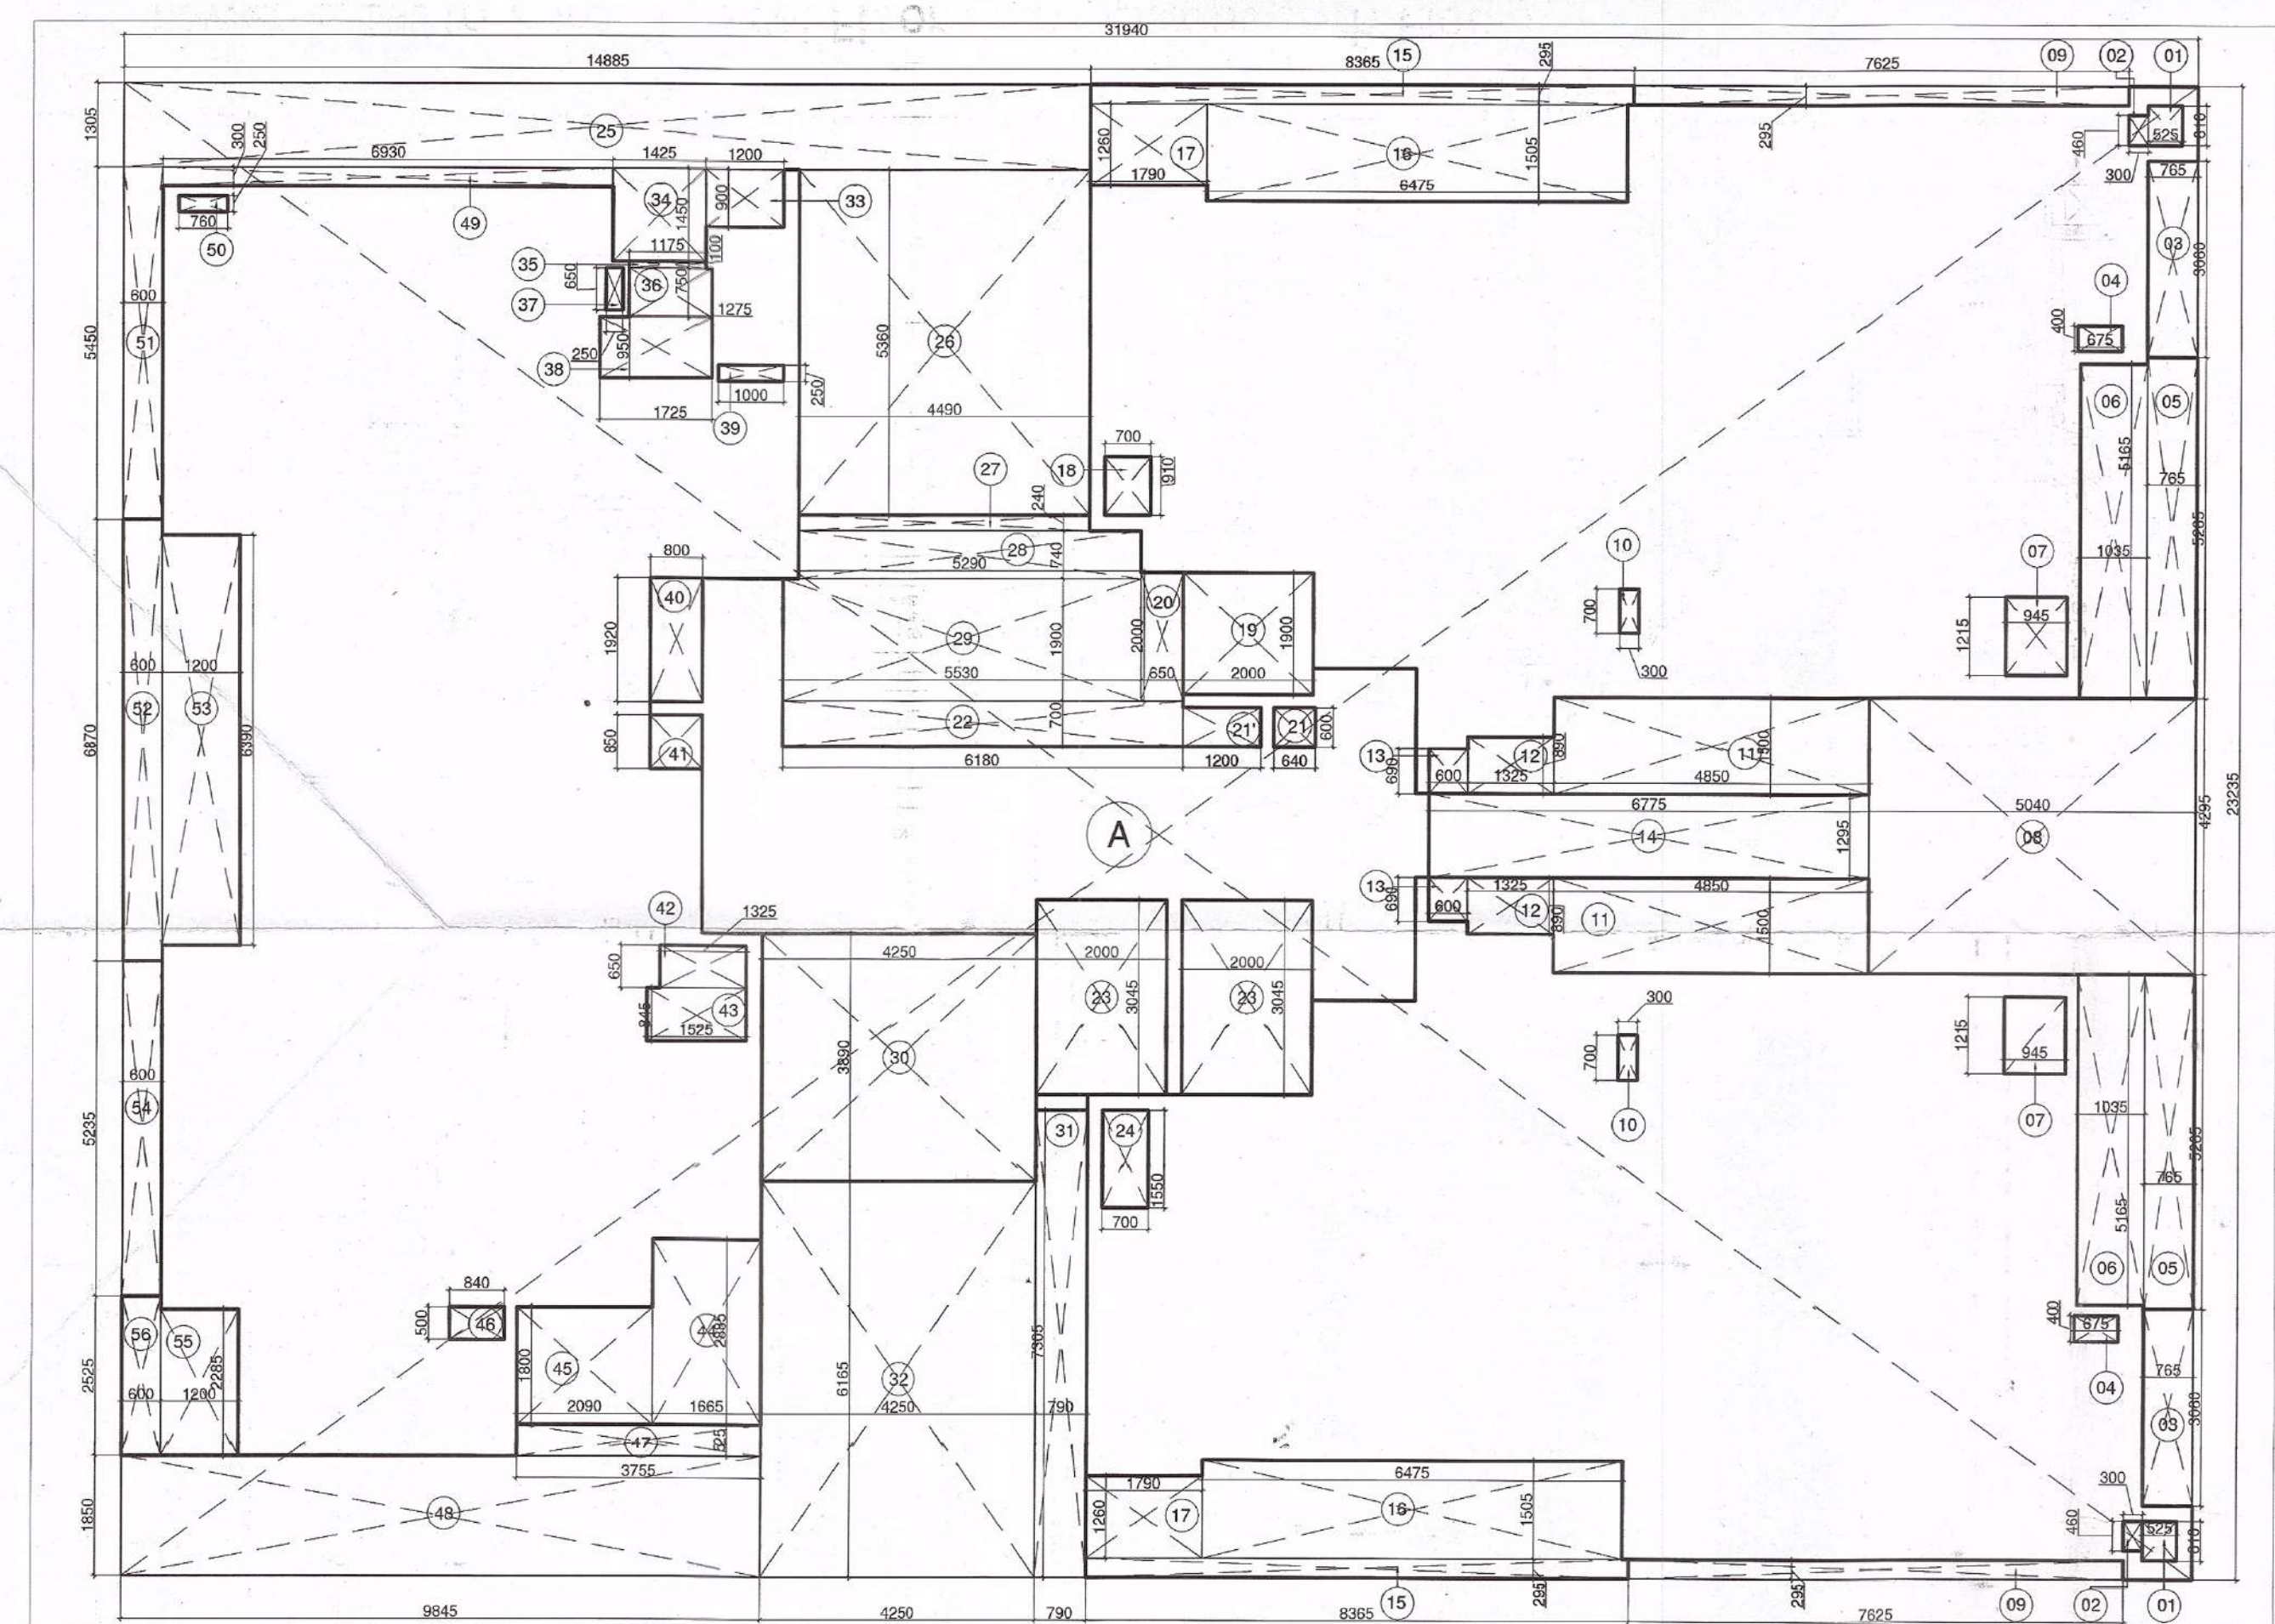

2 Tower B 1st to 23rd Typical Floor Plan (Except 16th Floor) Area Diagram
Scale: 1:100

DOOR - WINDOW SCHEDULE					
INTERNAL DOORS					
DOOR TAG	ROOM DESCRIPTION	QTY	STRUCTURAL OPENING		LEVEL (FROM FFL)
			WIDTH	HEIGHT	
D01	ENTRANCE / PRIVATE LOBBY		1200	2450**	±00
D02	ALL BEDROOMS, UTILITY.		1000	2450**	±00
D03	UTILITY		900	2450**	±00
D04	ALL TOILETS.		750	2450**	±00
D05	ELECTRICAL ROOM				±00
FD01	Electrical Shaft		1500	2450**	±00
FD02	STAIRCASE		1250	2450**	±00
FD03	L.V. SHAFT		600	2450**	±00
EXTERNAL DOORS					
DW01	LIVING / DINING		5510	2650	+100 / +900
DW02	MASTER BEDROOM		4655 (AS / PLAN)	2650 / 1800	+100 / +900
DW02A	SERVANT ROOM		4550 (AS / PLAN)	2650 / 1800	+100 / +900
DW03	LIVING / DINING		4100	2650	+100
DW04	LIVING / DINING		2750	2650	+100
DW05	BEDROOM - 2		2450	2650	+100
DW06	MASTER BEDROOM		2400 (AS / PLAN)	2650 / 1800	+100 / +900
DW07	BEDROOM - 2 / SERVANT ROOM		1660	2650	+100
DW08	BEDROOM - 3		1550	2650	+100
DW9	KITCHEN		1500 (AS / PLAN)	2750 / 1800	+00 / +1200
DW10	MASTER BEDROOM		1000	2650	+100
DW11	UTILITY / KITCHEN		850	2450	+100
DW12	TOILET / W.C.		750	2350	+100
WINDOWS					
W01	LIVING / DINING		3400	1800	900
W02	BEDROOM - 2 / BEDROOM - 4 / M. TOILET		2570	1800	900
W03	BEDROOM - 2.		2100	1800	900
W04	KITCHEN		1925	1500	1200
W05	STAIRCASE / CORRIDOR		1250	1500	1200
W06	MASTER TOILET / TOILET-2		900	1500	1200
W07	STAIRCASE		900	1200	1200
W08	MASTER BEDROOM		800	1800	900
W09	M. TOI. / TOI. - 3 / TOI. - 2 / TOI. / UTILITY / W.C.		750	1500	1200
W10	SERVANT ROOM		600	1800	900
W11	UTILITY		410	1800	900

TOWER B 1st to 23rd AND TOWER C 4th to 23rd TYPICAL FLOOR AREA CALCULATION					
TYPE	QUANTITY	SHAPE	FORMULA	DETAIL	CALCULATION EACH AREA IN SQ.M
OUTLINE AREA					
A	1	RECTANGLE	L x B	31.940	23.235
TOTAL OUTLINE AREA					742.126
NON FAR AREA					
1	2	RECTANGLE	L x B	0.610	0.525
2	2	RECTANGLE	L x B	0.460	0.300
4	2	RECTANGLE	L x B	0.675	0.400
5	2	RECTANGLE	L x B	5.265	0.765
6	2	RECTANGLE	L x B	5.165	1.035
7	2	RECTANGLE	L x B	1.215	0.945
10	2	RECTANGLE	L x B	0.700	0.300
11	2	RECTANGLE	L x B	4.850	1.500
12	2	RECTANGLE	L x B	1.325	0.890
13	2	RECTANGLE	L x B	0.690	0.600
15	2	RECTANGLE	L x B	8.365	0.295
16	2	RECTANGLE	L x B	6.475	1.505
17	2	RECTANGLE	L x B	1.790	1.260
18	1	RECTANGLE	L x B	0.910	0.700
20	1	RECTANGLE	L x B	2.000	0.650
21	1	RECTANGLE	L x B	0.600	0.640
21'	1	RECTANGLE	L x B	1.200	0.600
22	1	RECTANGLE	L x B	6.180	0.700
24	1	RECTANGLE	L x B	1.550	0.700
27	1	RECTANGLE	L x B	4.490	0.240
28	1	RECTANGLE	L x B	5.290	0.740
29	1	RECTANGLE	L x B	5.530	1.900
30	1	RECTANGLE	L x B	4.250	3.890
35	1	RECTANGLE	L x B	1.175	0.100
36	1	RECTANGLE	L x B	1.275	0.750
37	1	RECTANGLE	L x B	0.650	0.250
38	1	RECTANGLE	L x B	1.725	0.950
39	1	RECTANGLE	L x B	1.000	0.250
40	1	RECTANGLE	L x B	1.920	0.800
41	1	RECTANGLE	L x B	0.850	0.800
42	1	RECTANGLE	L x B	1.325	0.650
43	1	RECTANGLE	L x B	1.525	0.845
44	1	RECTANGLE	L x B	2.885	1.665
45	1	RECTANGLE	L x B	2.090	1.800
46	1	RECTANGLE	L x B	0.840	0.500
50	1	RECTANGLE	L x B	0.760	0.250
52	1	RECTANGLE	L x B	6.870	0.600
53	1	RECTANGLE	L x B	6.390	1.200
55	1	RECTANGLE	L x B	2.285	1.200
56	1	RECTANGLE	L x B	2.525	0.600
TOTAL NON FAR AREA					142.789
CUTOUT'S AREA (NON FAR)					
3	2	RECTANGLE	L x B	3.060	0.765
8	1	RECTANGLE	L x B	5.040	4.295
9	2	RECTANGLE	L x B	7.625	0.295
14	1	RECTANGLE	L x B	6.775	1.295
19	1	RECTANGLE	L x B	2.000	1.900
23	2	RECTANGLE	L x B	3.045	2.000
25	1	RECTANGLE	L x B	14.885	1.305
26	1	RECTANGLE	L x B	5.360	4.490
31	1	RECTANGLE	L x B	7.305	0.790
32	1	RECTANGLE	L x B	6.165	4.250
33	1	RECTANGLE	L x B	1.200	0.900
34	1	RECTANGLE	L x B	1.450	1.425
47	1	RECTANGLE	L x B	3.755	0.525
48	1	RECTANGLE	L x B	9.845	1.850
49	1	RECTANGLE	L x B	6.930	0.300
51	1	RECTANGLE	L x B	5.450	0.600
54	1	RECTANGLE	L x B	5.235	0.600
TOTAL CUTOUT'S AREA					162.865
TOTAL BUILT UP AREA = TOTAL OUTLINE AREA - TOTAL CUTOUT'S AREA					579.261
FAR AREA = TOTAL OUTLINE AREA - (TOTAL NON FAR AREA + TOTAL CUTOUT'S AREA)					436.471

Sign & Stamp


 Sd/- Anand Sharma
 B.P.C. Member Secretary
 B.P.C. Chairman
 B.P.C. Member

Deputy Director (T)
City Directorate, Fire Service
Member B.P.C.

KEY PLAN

Checked and found ok for Public Health
 (Informal) subject to comments in
 Forwarding Letter No. 55/10/2019
 20/11/2019
 Sd/- Anand Sharma
 B.P.C. Member Secretary
 B.P.C. Chairman
 B.P.C. Member

This is a PROVISIONAL APPROVED BUILDING PLAN
 only for purpose of inviting
 objection from the public.
 Sd/- Anand Sharma
 B.P.C. Member Secretary
 B.P.C. Chairman
 B.P.C. Member

PLUMBING LEGEND :-

①	1000 CI SOIL PIPE
②	1000 CI WASTE PIPE
③	1000 CI WASTE PIPE FOR KITCHEN
④	1000 DRAIN PIPE FOR SWIMMING POOL
⑤	750 CI ASP
⑥	1100 UPVC RWP FOR TERRACE
⑦	1100 UPVC RWP FOR BALCONY
⑧	COLD WATER SUPPLY DROP
⑨	COLD WATER SUPPLY DROP FOR KITCHEN
⑩	COLD WATER SUPPLY DROP FOR TOP THREE FLOORS
⑪	COLD WATER SUPPLY DROP FOR KITCHEN TOP THREE FLOORS
⑫	FLUSHING WATER SUPPLY DROP
⑬	FLUSHING WATER SUPPLY DROP FOR TOP THREE FLOORS
⑭	COLD WATER SUPPLY RISER FOR OHT
⑮	FLUSHING WATER SUPPLY RISER FOR OHT
⑯	WATER HEATER CAPACITY-25/15 LTRS
⑰	FLOOR TRAP (100x100)MM
⑱	FLOOR DRAIN (100x50)MM
⑲	BALL VALVE

PROJECT NAME & ADDRESS

APPROVAL OF REVISED BUILDING PLANS OF RESIDENTIAL GROUP
 HOUSING COLONY UNDER TRANSIT ORIENTED DEVELOPMENT
 (TOD) POLICY FOR MIX LAND USE COLONY
 (70% RESIDENTIAL+30%COMMERCIAL) MEASURING 4.85 ACRES
 (LICENSE No. 110 OF 2013 DATED 27.12.2013) IN SECTOR - 28,
 GURUGRAM MANESAR URBAN COMPLEX BEING DEVELOPED BY
 SILVERGLADES INFRASTRUCTURE PVT. LTD.

CLIENT NAME & ADDRESS

GROUP SILVERGLADES
 5th FLOOR, TIME SQUARE BUILDING, B-BLOCK,
 SUSHANT LOK, PHASE-1, GURUGRAM - 122002,
 HARYANA, INDIA

ARCHITECT'S SIGN & STAMP

ANAND SHARMA
 B. Arch (Hons), M.C.A.
 CUGS/18738, AIR/AJ-12/1992


CLIENT'S SIGN & STAMP



DRAWING TITLE

Tower B 1st to 23rd Typical Floor Plan
 (Except 16th Floor) and Area Calculation

SCALE	DRAWING NO.	NORTH
1:100 ON A1	020	
DATE		
31-12-2019		