



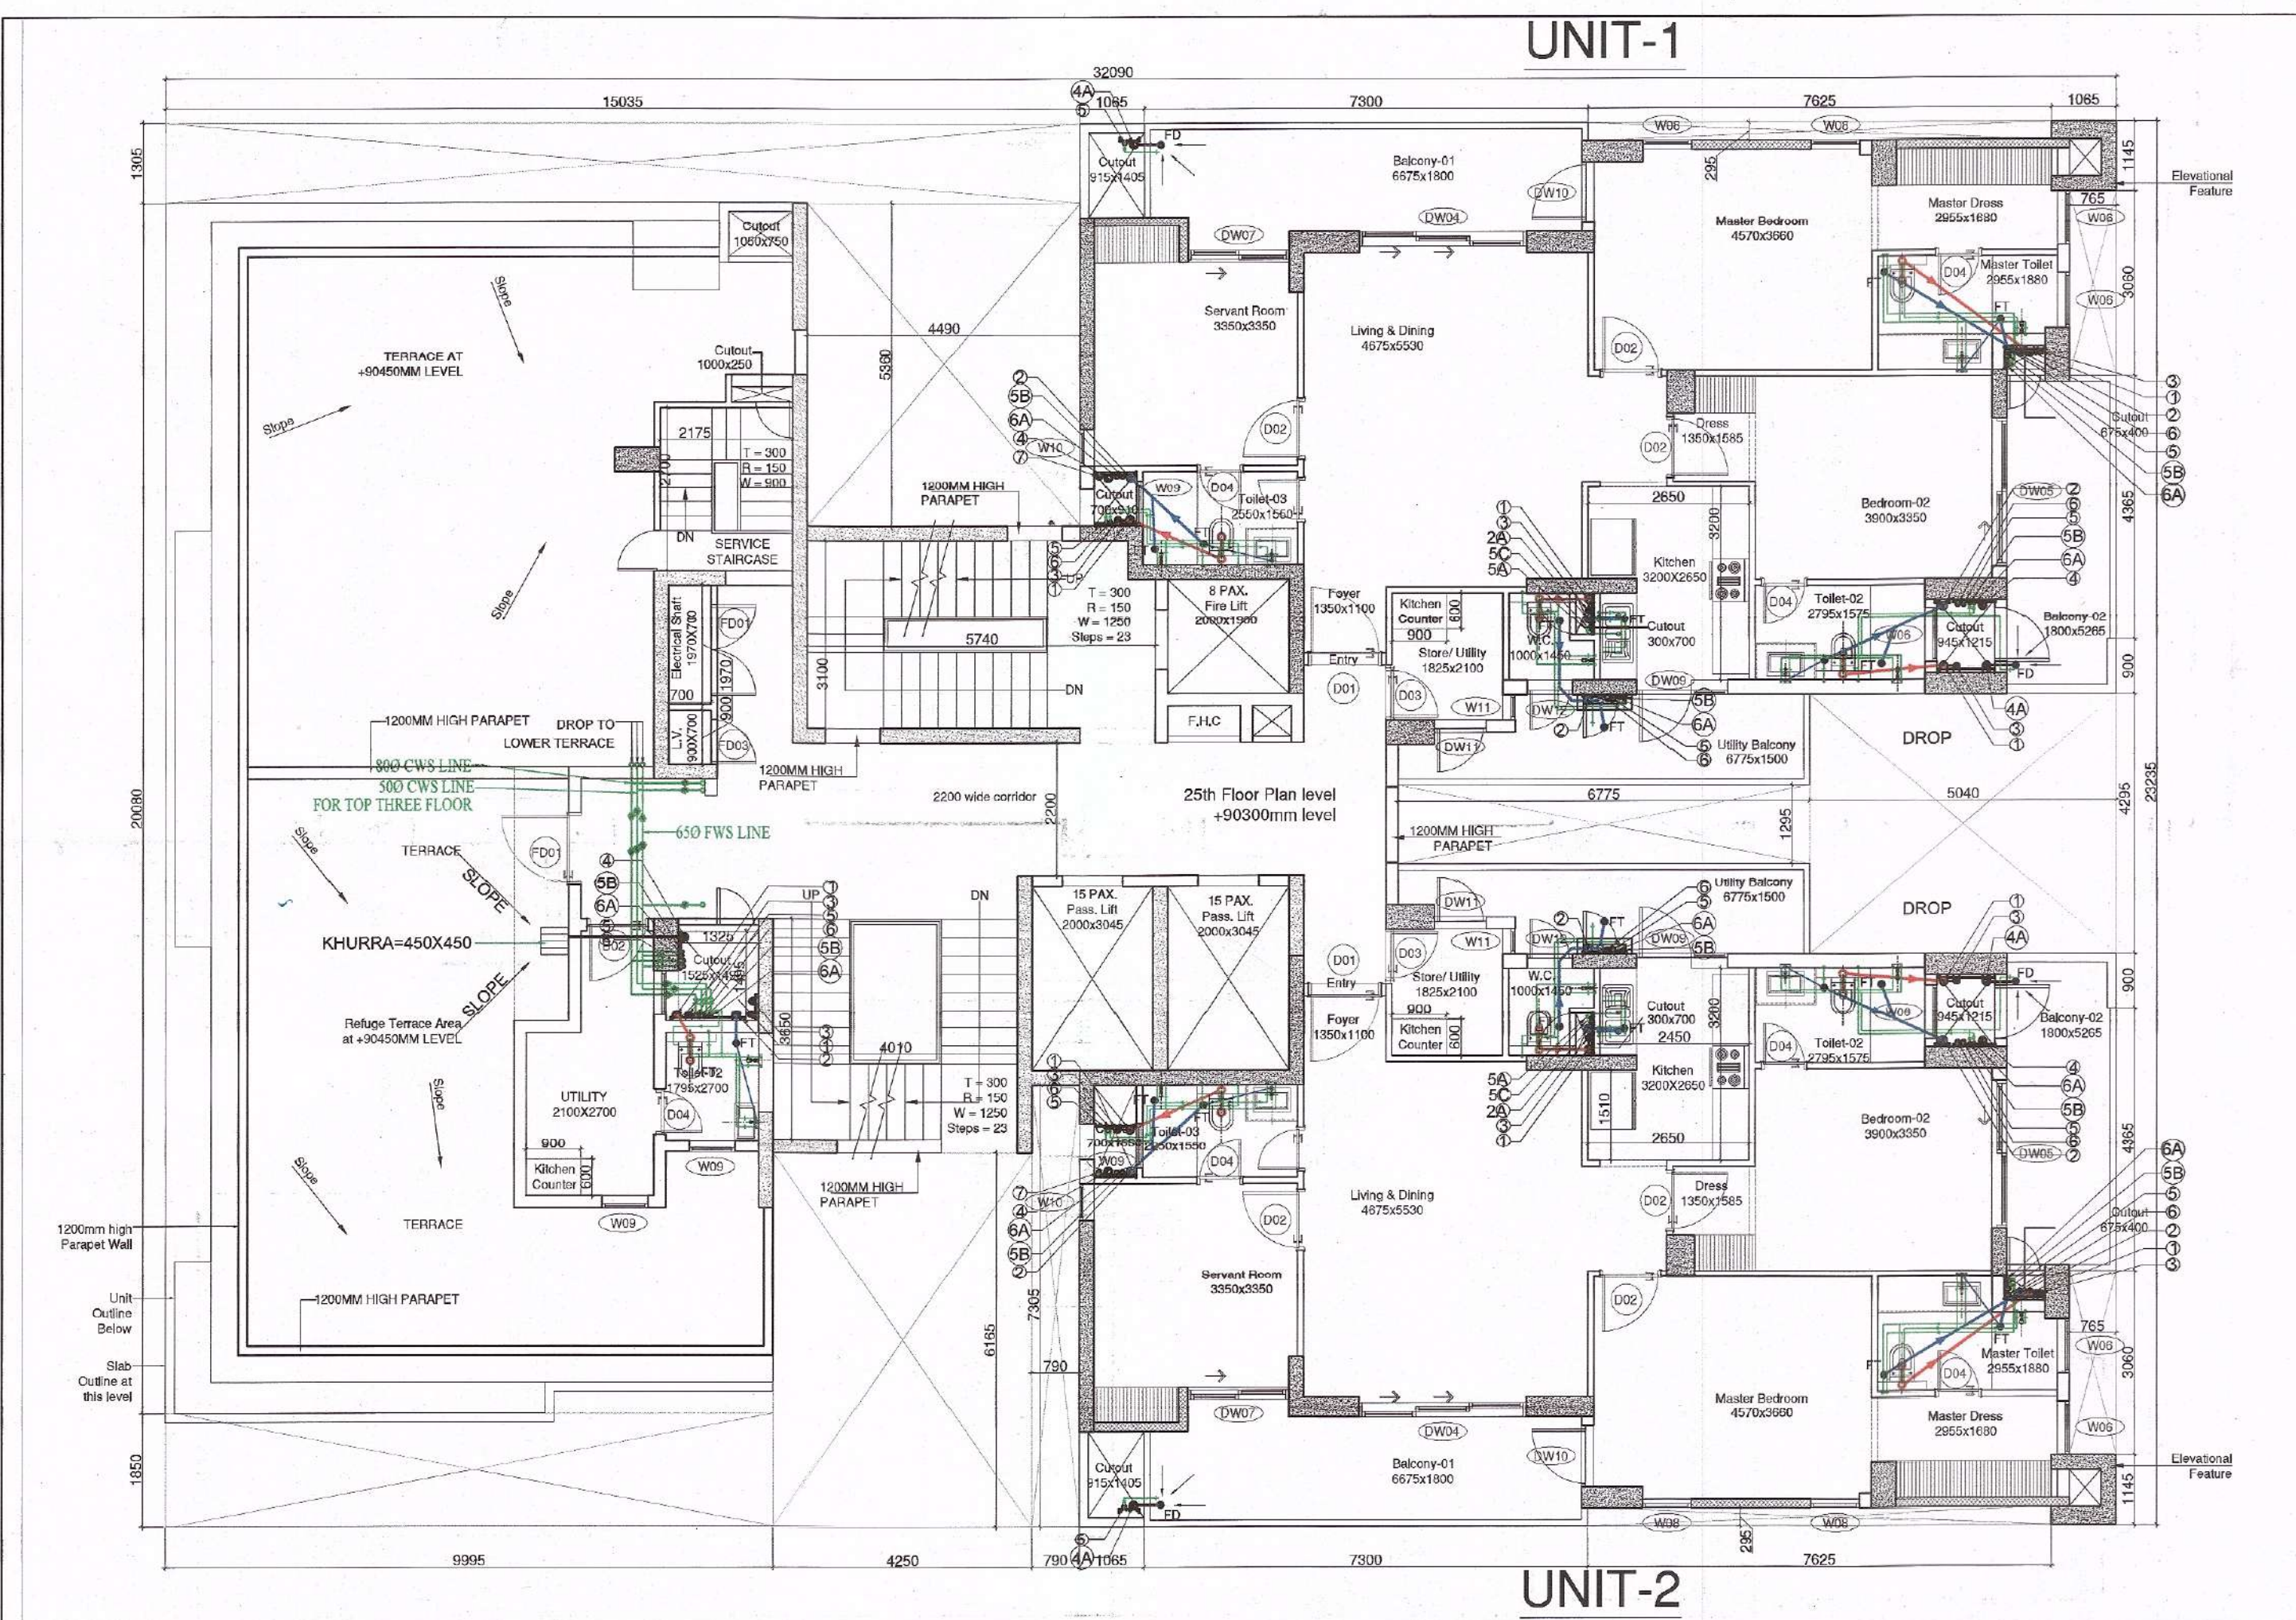

1 Tower B 25th Floor Plan
Scale: 1:100

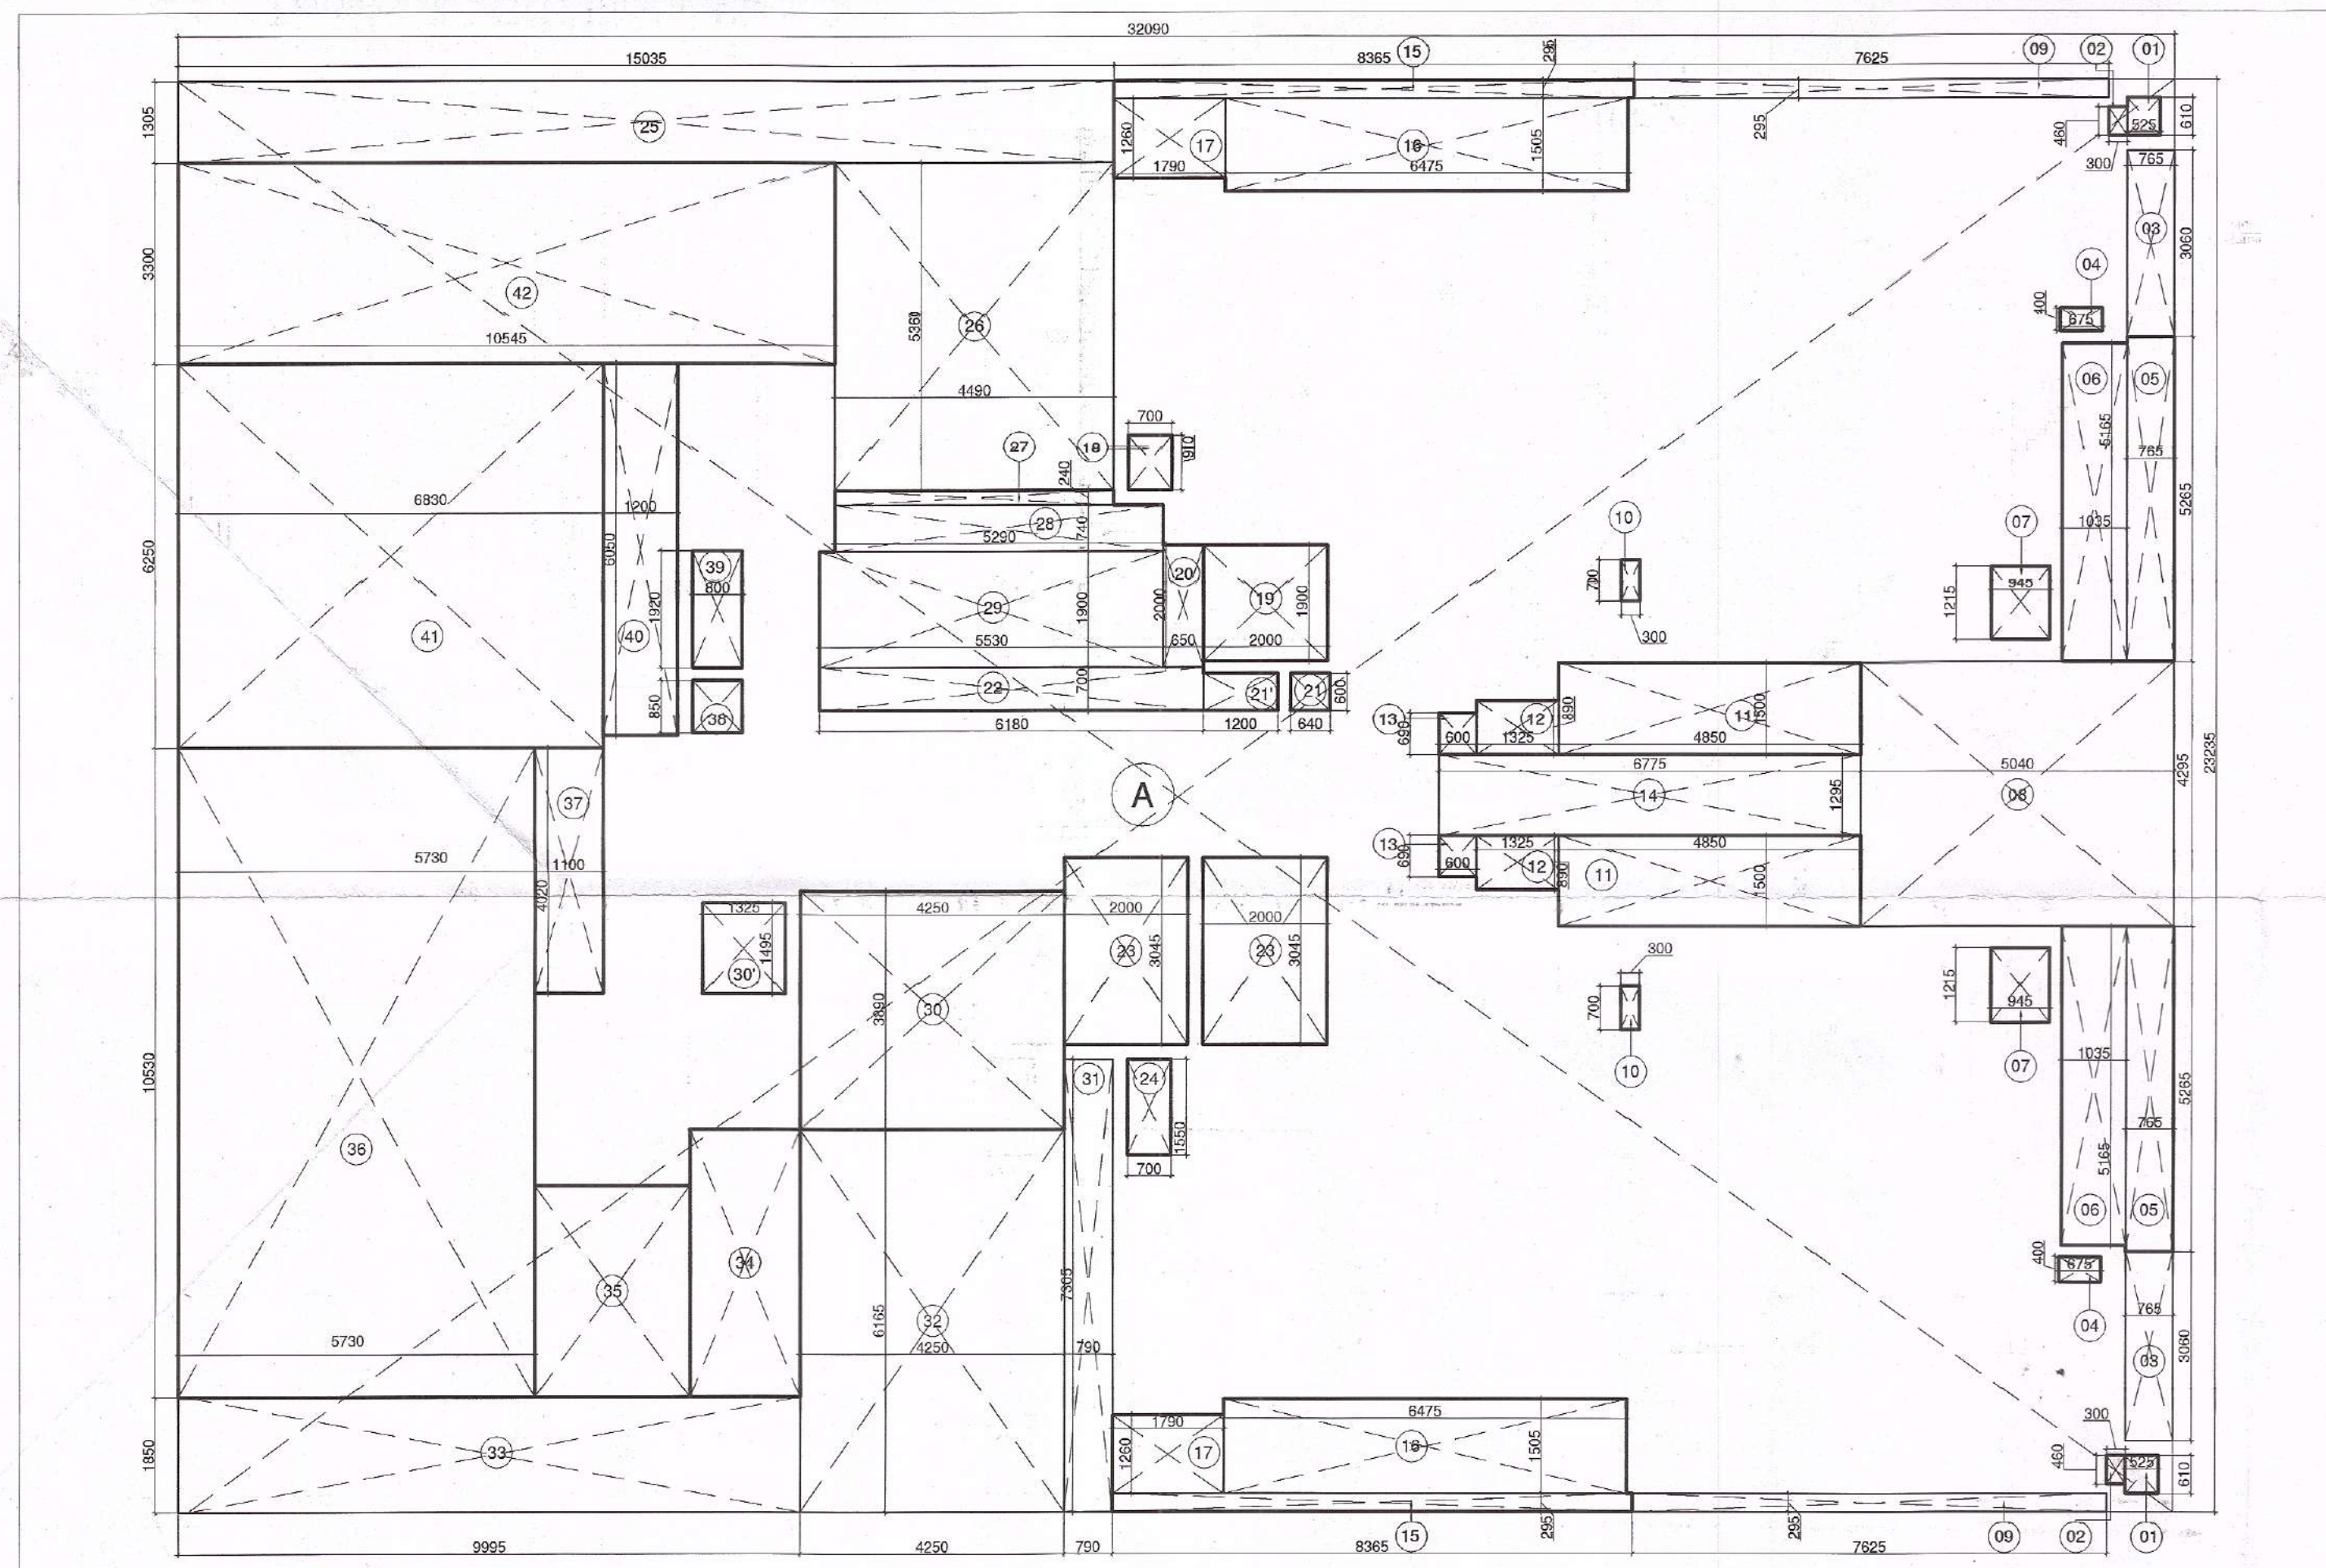

2 Tower B 25th Floor Level Area Diagram
Scale: 1:100

DOOR - WINDOW SCHEDULE						
INTERNAL DOORS						
DOOR TAG	ROOM DESCRIPTION	QTY	STRUCTURAL OPENING		LEVEL (FROM FFL)	
			WIDTH	HEIGHT	OLL	UNTEL
D01	ENTRANCE / PRIVATE LOBBY		1200	2450**	±00	2400
D02	ALL BEDROOMS, UTILITY.		1000	2450**	±00	2400
D03	UTILITY		900	2450**	±00	2400
D04	ALL TOILETS.		750	2450**	±00	2400
D05	ELECTRICAL ROOM				±00	
D06	TERRACE LOBBY				±00	
FD01	Electrical Shaft		1500	2450**	±00	2400
FD02	STAIRCASE		1250	2450**	±00	2400
FD03	LV SHAFT		600	2450**	±00	2400
EXTERNAL DOORS						
DW01	LIVING / DINNING		5510	2650	+100 / +900	2700
DW02	MASTER BEDROOM		4655 (AS / PLAN)	2650 / 1800	+100 / +900	2700
DW02A	SERVANT ROOM		4550 (AS / PLAN)	2650 / 1800	+100 / +900	2700
DW03	LIVING / DINNING		4100	2650	+100	2700
DW04	LIVING / DINNING		2750	2650	+100	2700
DW05	BEDROOM - 2		2450	2650	+100	2700
DW06	MASTER BEDROOM		2400 (AS / PLAN)	2650 / 1800	+100 / +900	2700
DW07	BEDROOM - 2 / SERVANT ROOM		1660	2650	+100	2700
DW08	BEDROOM - 3		1550	2650	+100	2700
DW9	KITCHEN		1500 (AS / PLAN)	2750 / 1800	±00 / +1200	2700
DW10	MASTER BEDROOM		1000	2650	+100	2700
DW11	UTILITY / KITCHEN		850	2450	+100	2400
DW12	TOILET / W.C.		750	2350	+100	2400
WINDOWS						
W01	LIVING / DINNING		3400	1800	900	2700
W02	BEDROOM - 2 / BEDROOM - 4 / M. TOILET		2570	1800	900	2700
W03	BEDROOM - 2.		2100	1800	900	2700
W04	KITCHEN		1925	1500	1200	2700
W05	STAIRCASE / CORRIDOR		1250	1500	1200	2700
W06	MASTER TOILET / TOILET-2		900	1500	1200	2700
W07	STAIRCASE		900	1200	1200	2700
W08	MASTER BEDROOM		800	1800	900	2700
W09	M. TOI. / TOI. - 3 / TOI. - 2 / TOI. / UTILITY / W.C.		750	1500	1200	2700
W10	SERVANT ROOM		600	1800	900	2700
W11	UTILITY		410	1800	900	2700

TOWER B & C 25th FLOOR AREA CALCULATION						
TYPE	QUANTITY	SHAPE	FORMULA	DETAIL	CALCULATION EACH AREA IN SQ.M	
OUTLINE AREA						
A	1	RECTANGLE	L x B	32.090	23.235	745.611
TOTAL OUTLINE AREA						745.611
NON FAR AREA						
1	2	RECTANGLE	L x B	0.610	0.525	0.641
2	2	RECTANGLE	L x B	0.460	0.300	0.276
4	2	RECTANGLE	L x B	0.675	0.400	0.540
5	2	RECTANGLE	L x B	5.265	0.765	8.055
6	2	RECTANGLE	L x B	5.165	1.035	10.692
7	2	RECTANGLE	L x B	1.215	0.945	2.296
10	2	RECTANGLE	L x B	0.700	0.300	0.420
11	2	RECTANGLE	L x B	4.850	1.500	14.550
12	2	RECTANGLE	L x B	1.325	0.890	2.359
13	2	RECTANGLE	L x B	0.690	0.600	0.828
15	2	RECTANGLE	L x B	8.365	0.295	4.935
16	2	RECTANGLE	L x B	6.475	1.505	19.490
17	2	RECTANGLE	L x B	1.790	1.260	4.511
18	1	RECTANGLE	L x B	0.910	0.700	0.637
20	1	RECTANGLE	L x B	2.000	0.650	1.300
21	1	RECTANGLE	L x B	0.600	0.640	0.384
21'	1	RECTANGLE	L x B	1.200	0.600	0.720
22	1	RECTANGLE	L x B	6.180	0.700	4.326
24	1	RECTANGLE	L x B	1.550	0.700	1.085
27	1	RECTANGLE	L x B	4.490	0.240	1.078
28	1	RECTANGLE	L x B	5.290	0.740	3.915
29	1	RECTANGLE	L x B	5.530	1.900	10.507
30	1	RECTANGLE	L x B	4.250	3.890	16.533
34	1	RECTANGLE	L x B	5.730	4.315	24.725
34'	1	RECTANGLE	L x B	4.265	3.410	14.544
35	1	RECTANGLE	L x B	6.411	5.730	36.735
35'	1	RECTANGLE	L x B	1.765	0.905	1.597
36	1	RECTANGLE	L x B	4.217	1.100	4.639
37	1	RECTANGLE	L x B	0.800	0.850	0.680
38	1	RECTANGLE	L x B	1.920	0.800	1.536
39	1	RECTANGLE	L x B	8.030	6.053	48.606
40	1	RECTANGLE	L x B	10.545	3.300	34.799
TOTAL NON FAR AREA						277.936
CUTOUT'S AREA (NON FAR)						
3	2	RECTANGLE	L x B	3.060	0.765	4.682
8	1	RECTANGLE	L x B	5.040	4.295	21.647
9	2	RECTANGLE	L x B	7.625	0.295	4.499
14	1	RECTANGLE	L x B	6.775	1.295	8.774
19	1	RECTANGLE	L x B	2.000	1.900	3.800
23	2	RECTANGLE	L x B	3.045	2.000	12.180
25	1	RECTANGLE	L x B	15.035	1.305	19.621
26	1	RECTANGLE	L x B	5.360	4.490	24.066
30'	1	RECTANGLE	L x B	1.495	1.325	1.981
31	1	RECTANGLE	L x B	7.305	0.790	5.771
32	1	RECTANGLE	L x B	6.165	4.250	26.201
33	1	RECTANGLE	L x B	9.995	1.850	18.491
TOTAL CUTOUT'S AREA						151.712
TOTAL BUILT UP AREA = TOTAL OUTLINE AREA - TOTAL CUTOUT'S AREA						593.899
FAR AREA = TOTAL OUTLINE AREA - (TOTAL NON FAR AREA+TOTAL CUTOUT'S AREA)						315.964

Sign & Stamp

Deputy Director (T)
O/o Directorate Fire Service
Member B.P.C.

Checked and found ok for Public Health
(Internal) Service and subject to comments in
forwarded No. SE(HQ).....D/04/02/2020
20/11/20
Superintendent (H)
HSVP, Panchsheel

This is a PROVISIONAL APPROVED BUILDING PLAN
for purpose of inviting
specification from the general public.

Architect (H)
Directorate of Town and Country Planning,
Haryana, Chandigarh

PLUMBING LEGEND :-

①	1000 CI SOIL PIPE
②	1000 CI WASTE PIPE
②A	1000 CI WASTE PIPE FOR KITCHEN
②B	1000 DRAIN PIPE FOR SWIMMING POOL
③	750 CI ASP
④	1100 UPVC RWP FOR TERRACE
④A	1100 UPVC RWP FOR BALCONY
⑤	COLD WATER SUPPLY DROP
⑤A	COLD WATER SUPPLY DROP FOR KITCHEN
⑤B	COLD WATER SUPPLY DROP FOR TOP THREE FLOORS
⑤C	COLD WATER SUPPLY DROP FOR KITCHEN TOP THREE FLOORS
⑥	FLUSHING WATER SUPPLY DROP
⑥A	FLUSHING WATER SUPPLY DROP FOR TOP THREE FLOORS
⑦	COLD WATER SUPPLY RISER FOR OHT
⑧	FLUSHING WATER SUPPLY RISER FOR OHT
⑨	WATER HEATER CAPACITY-25/15 LTRS
⑩	FLOOR TRAP (100x100)MM
⑪	FLOOR DRAIN (100x50)MM
⑫	BALL VALVE

PROJECT NAME & ADDRESS

APPROVAL OF REVISED BUILDING PLANS OF RESIDENTIAL GROUP HOUSING COLONY UNDER TRANSIT ORIENTED DEVELOPMENT (TOD) POLICY FOR MIX LAND USE COLONY (70% RESIDENTIAL+30%COMMERCIAL) MEASURING 4.85 ACRES (LICENSE No. 110 OF 2013 DATED 27.12.2013) IN SECTOR - 28, GURUGRAM MANESAR URBAN COMPLEX BEING DEVELOPED BY SILVERGLADES INFRASTRUCTURE PVT. LTD.

CLIENT NAME & ADDRESS

GROUP SILVERGLADES
5th FLOOR, TIME SQUARE BUILDING, B-BLOCK,
SUSHANT LOK, PHASE-1, GURUGRAM - 122002,
HARYANA, INDIA

ARCHITECT'S SIGN & STAMP

CLIENT'S SIGN & STAMP

ANAND SHARMA
B.Arch (Reg.), L.L.C.A.
CA/551/0738, AH/AN-12795
New Delhi

GROUP SILVERGLADES
5th FLOOR, TIME SQUARE BUILDING, B-BLOCK,
SUSHANT LOK, PHASE-1, GURUGRAM - 122002,
HARYANA, INDIA

DRAWING TITLE

Tower B 25th Floor Plan
and Area Calculation

SCALE

1:100 ON A1

DRAWING NO.

027

NORTH

DATE

31-12-2019