



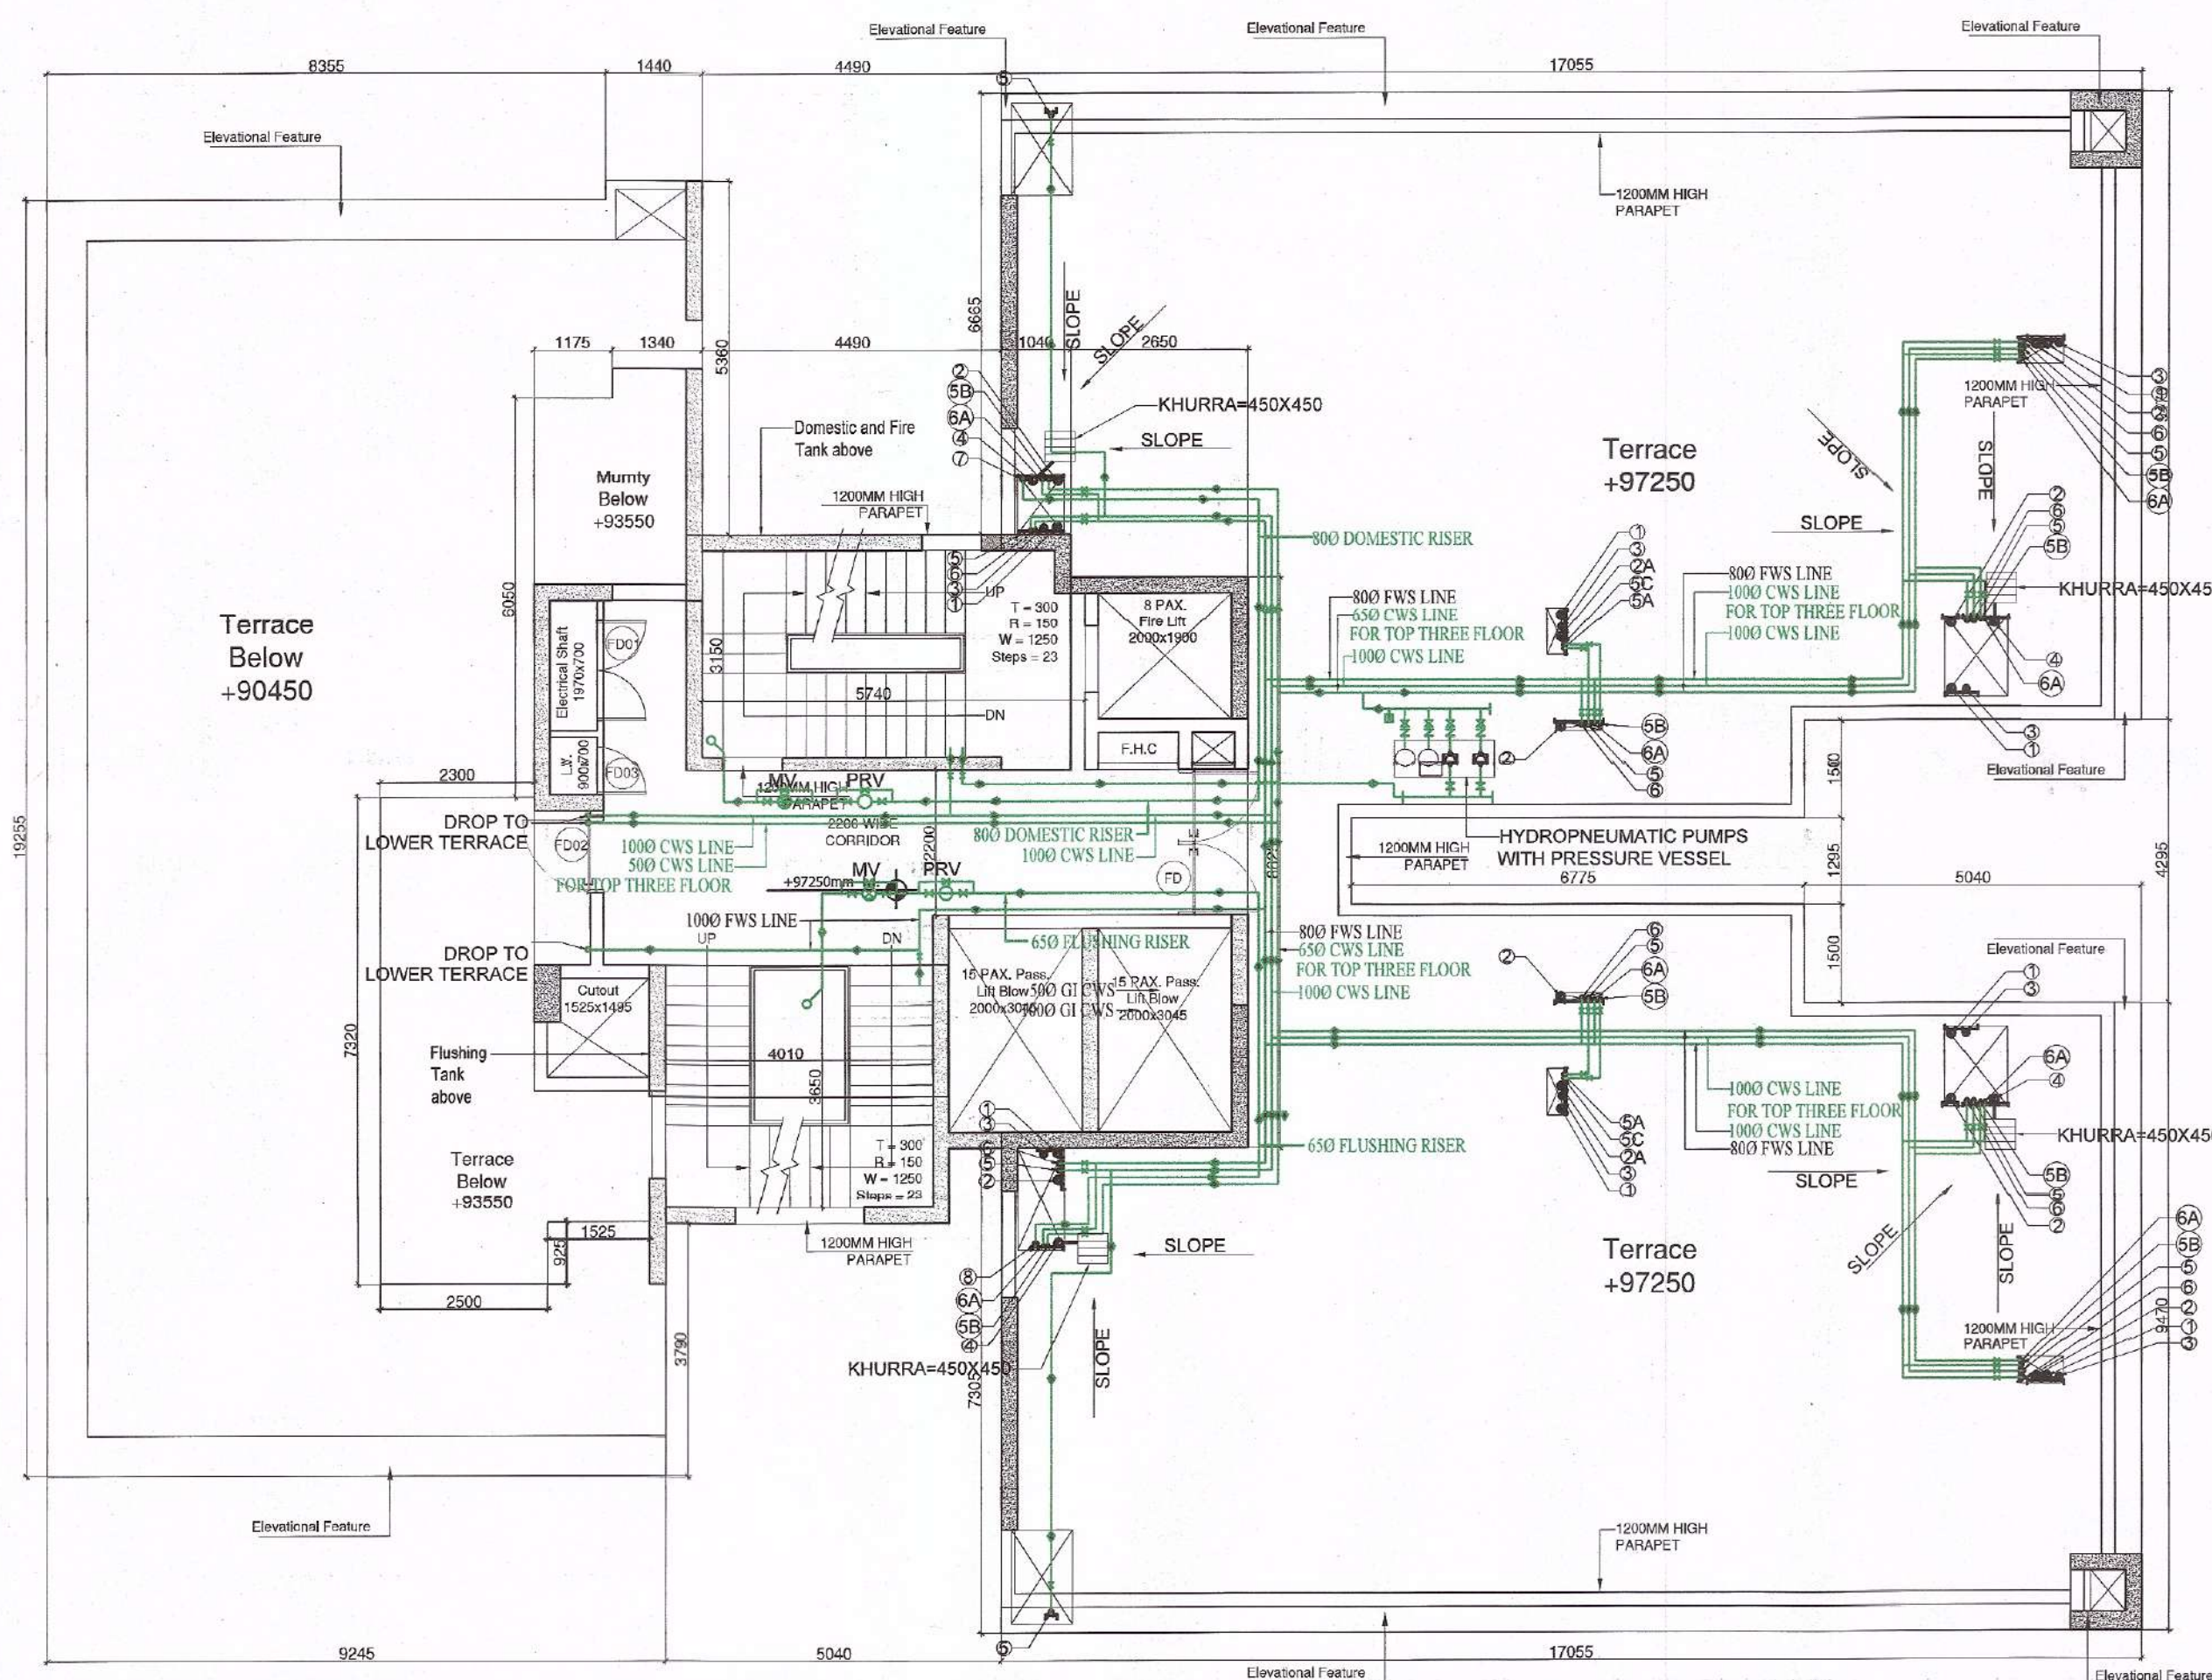

1 Tower B Terrace Floor Plan
Scale: 1:100

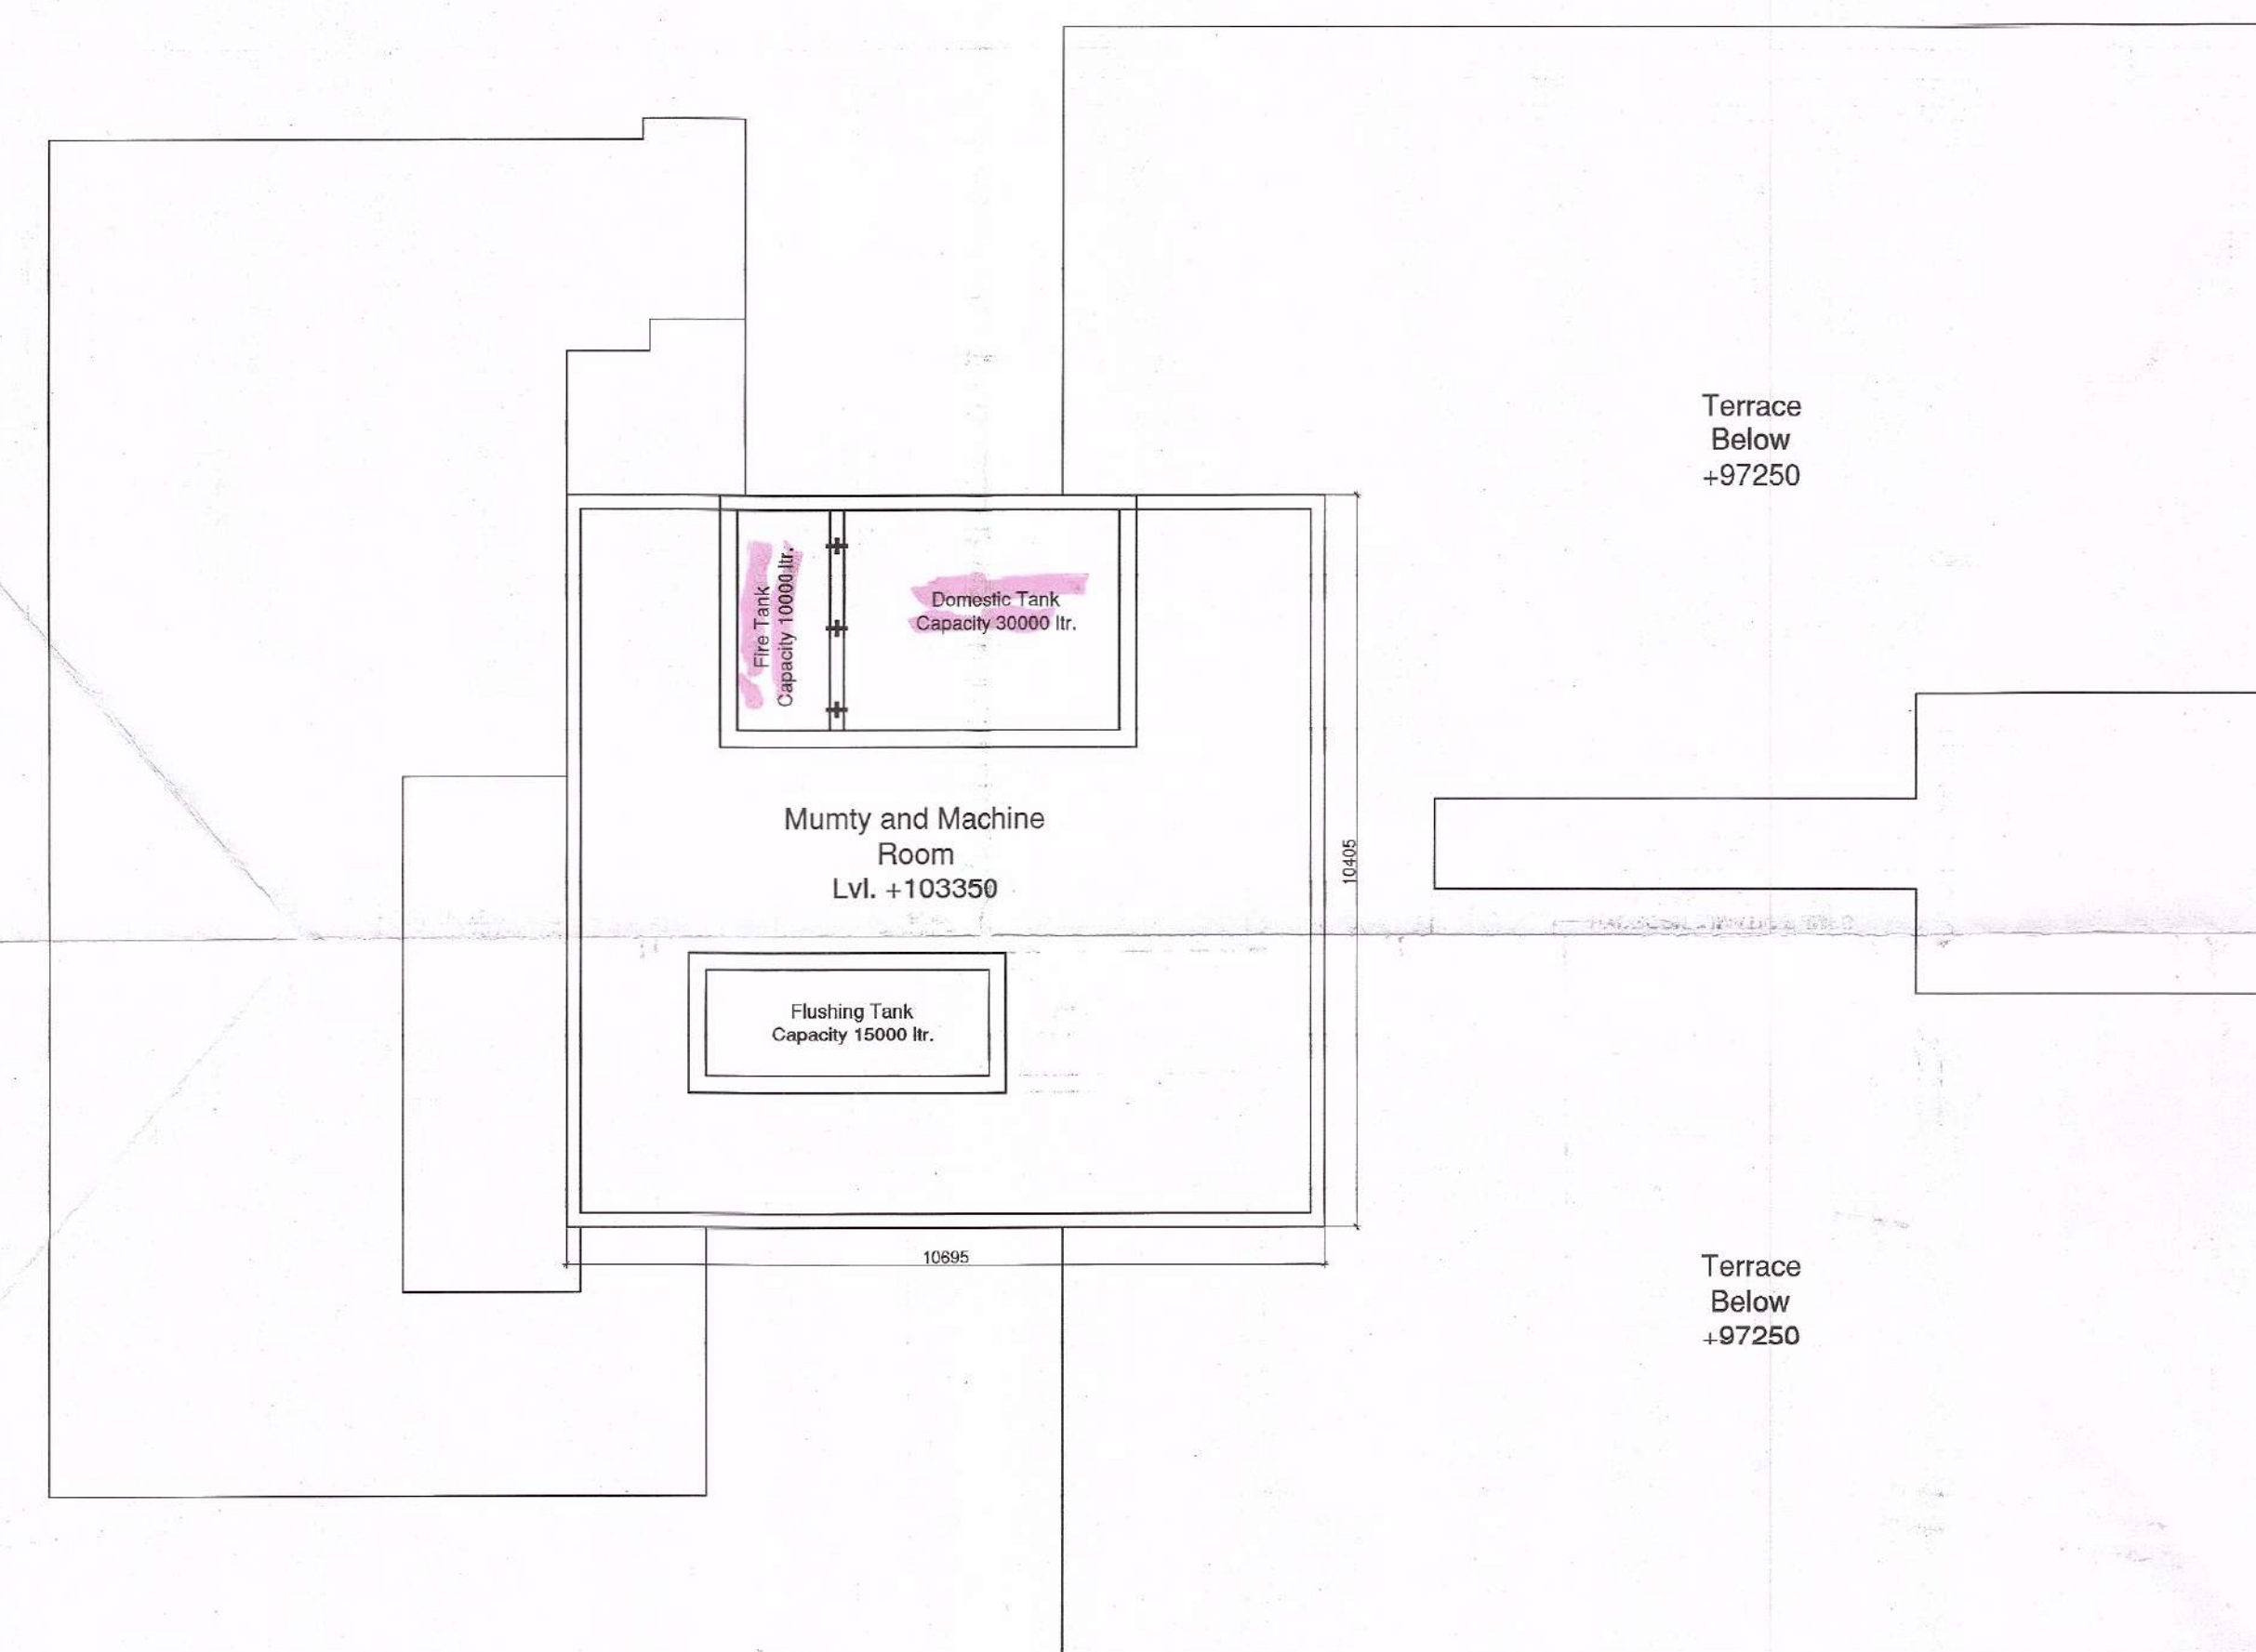

2 Tower B Mumty & OHWT Level Plan
Scale: 1:100

Sign & Stamp		
Checked and found ok for Public Health (Internal) subject to comments forwarded later to SE(HO) DV/42/200 Supervisor HSRP, Faridkot 24/7/20 This is a PROVISIONAL APPROVED BUILDING PLAN only for purpose of inviting invitation from the general public Architect (P) Director of Town and Country Planning, Haryana, Chandigarh		
KEY PLAN		
PLUMBING LEGEND :-		
①	1000 CI SOIL PIPE	
②	1000 CI WASTE PIPE	
2A	1000 CI WASTE PIPE FOR KITCHEN	
2B	1000 DRAIN PIPE FOR SWIMMING POOL	
③	750 CI ASP	
④	1100 UPVC RWP FOR TERRACE	
4A	1100 UPVC RWP FOR BALCONY	
⑤	COLD WATER SUPPLY DROP	
5A	COLD WATER SUPPLY DROP FOR KITCHEN	
5B	COLD WATER SUPPLY DROP FOR TOP THREE FLOORS	
5C	COLD WATER SUPPLY DROP FOR KITCHEN TOP THREE FLOORS	
⑥	FLUSHING WATER SUPPLY DROP	
6A	FLUSHING WATER SUPPLY DROP FOR TOP THREE FLOORS	
⑦	COLD WATER SUPPLY RISER FOR OHT	
⑧	FLUSHING WATER SUPPLY RISER FOR OHT	
⑨	WATER HEATER CAPACITY -25/15 LTRS	
⑩	FLOOR TRAP (100x100)MM	
⑪	FLOOR DRAIN (100x50)MM	
⑫	BALL VALVE	
PROJECT NAME & ADDRESS		
APPROVAL OF REVISED BUILDING PLANS OF RESIDENTIAL GROUP HOUSING COLONY UNDER TRANSIT ORIENTED DEVELOPMENT (TOD) POLICY FOR MIX LAND USE COLONY (70% RESIDENTIAL+30%COMMERCIAL) MEASURING 4.85 ACRES (LICENSE No. 110 OF 2013 DATED 27.12.2013) IN SECTOR - 28, GURUGRAM MANESAR URBAN COMPLEX BEING DEVELOPED BY SILVERGLADES INFRASTRUCTURE PVT. LTD.		
CLIENT NAME & ADDRESS		
GROUP SILVERGLADES 5th FLOOR, TIME SQUARE BUILDING, B-BLOCK, SUSHANT LOK, PHASE-1, GURUGRAM - 122002, HARYANA, INDIA		
ARCHITECT'S SIGN & STAMP	CLIENT'S SIGN & STAMP	
ANAND SHARMA Arch (Hons), M.C.A. 5118735, A/AWA-12766	New Den	
DRAWING TITLE		
Tower B Terrace Plan, mumty & OHWT Floor Plan		
SCALE	DRAWING NO.	NORTH
1:100 ON A1	029	
DATE		
31-12-2019		