



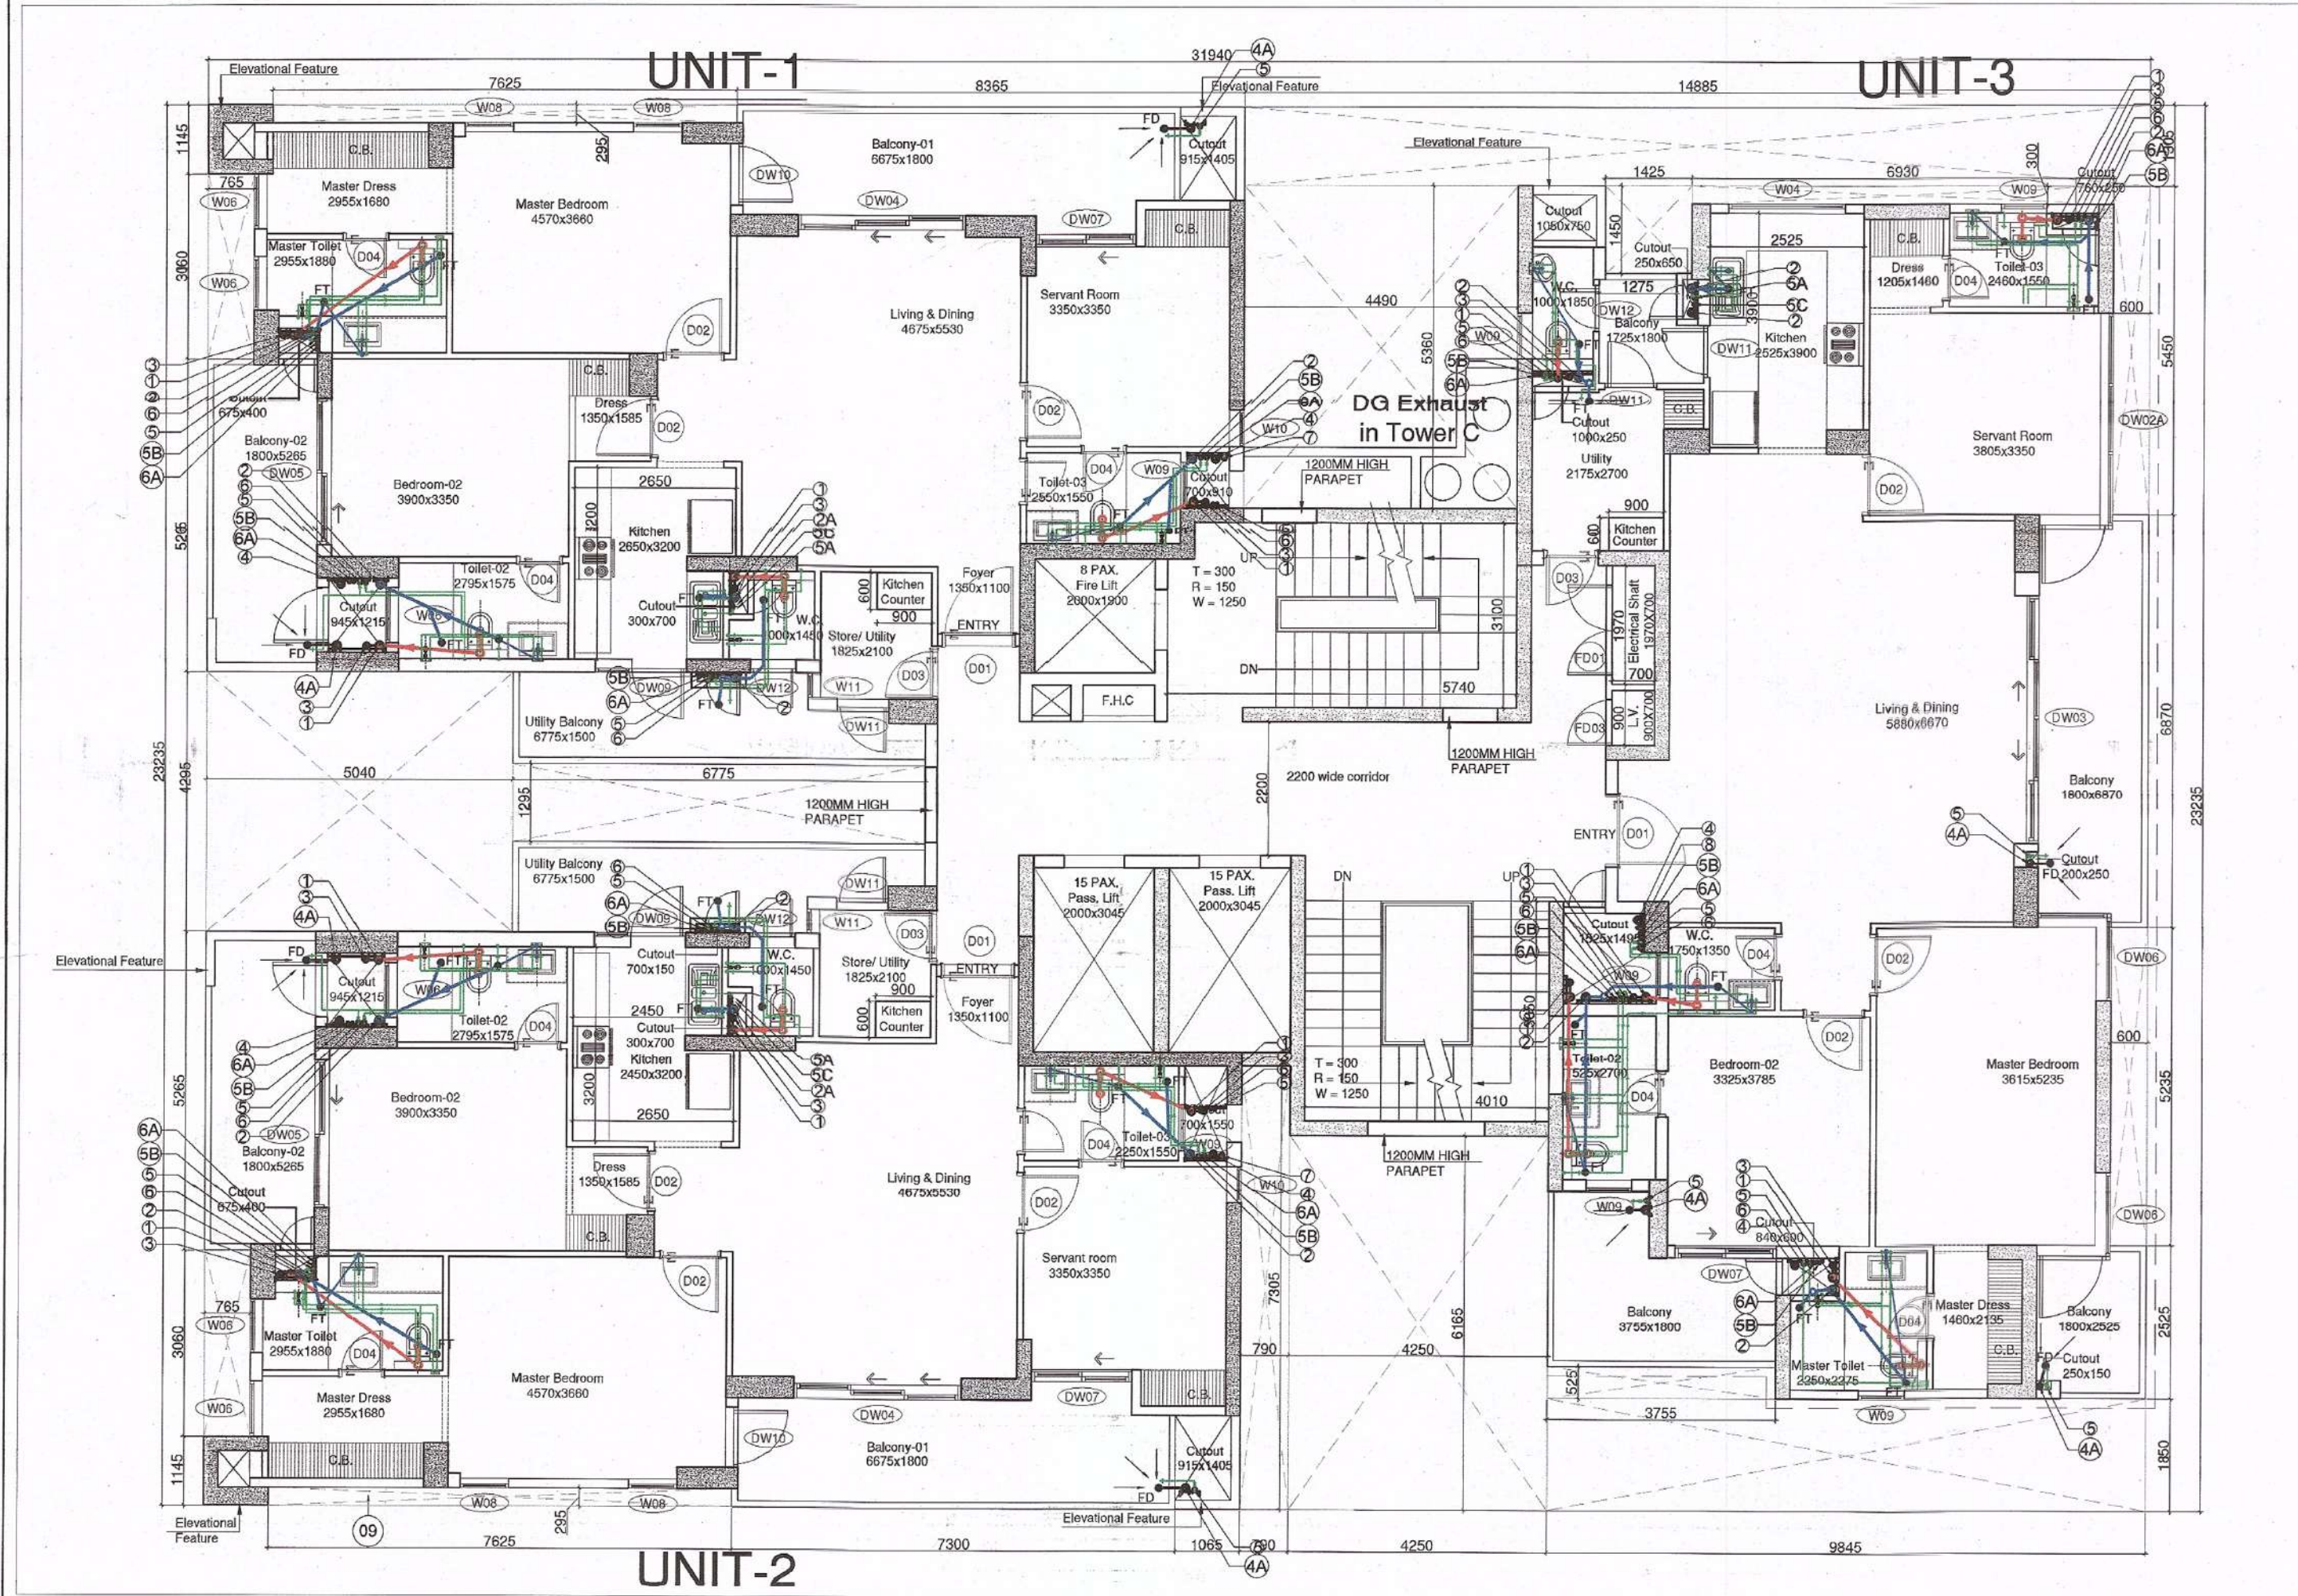

1 Tower C 4th to 23rd Typical Floor Plan (Except 16th Floor)

Scale: 1:100

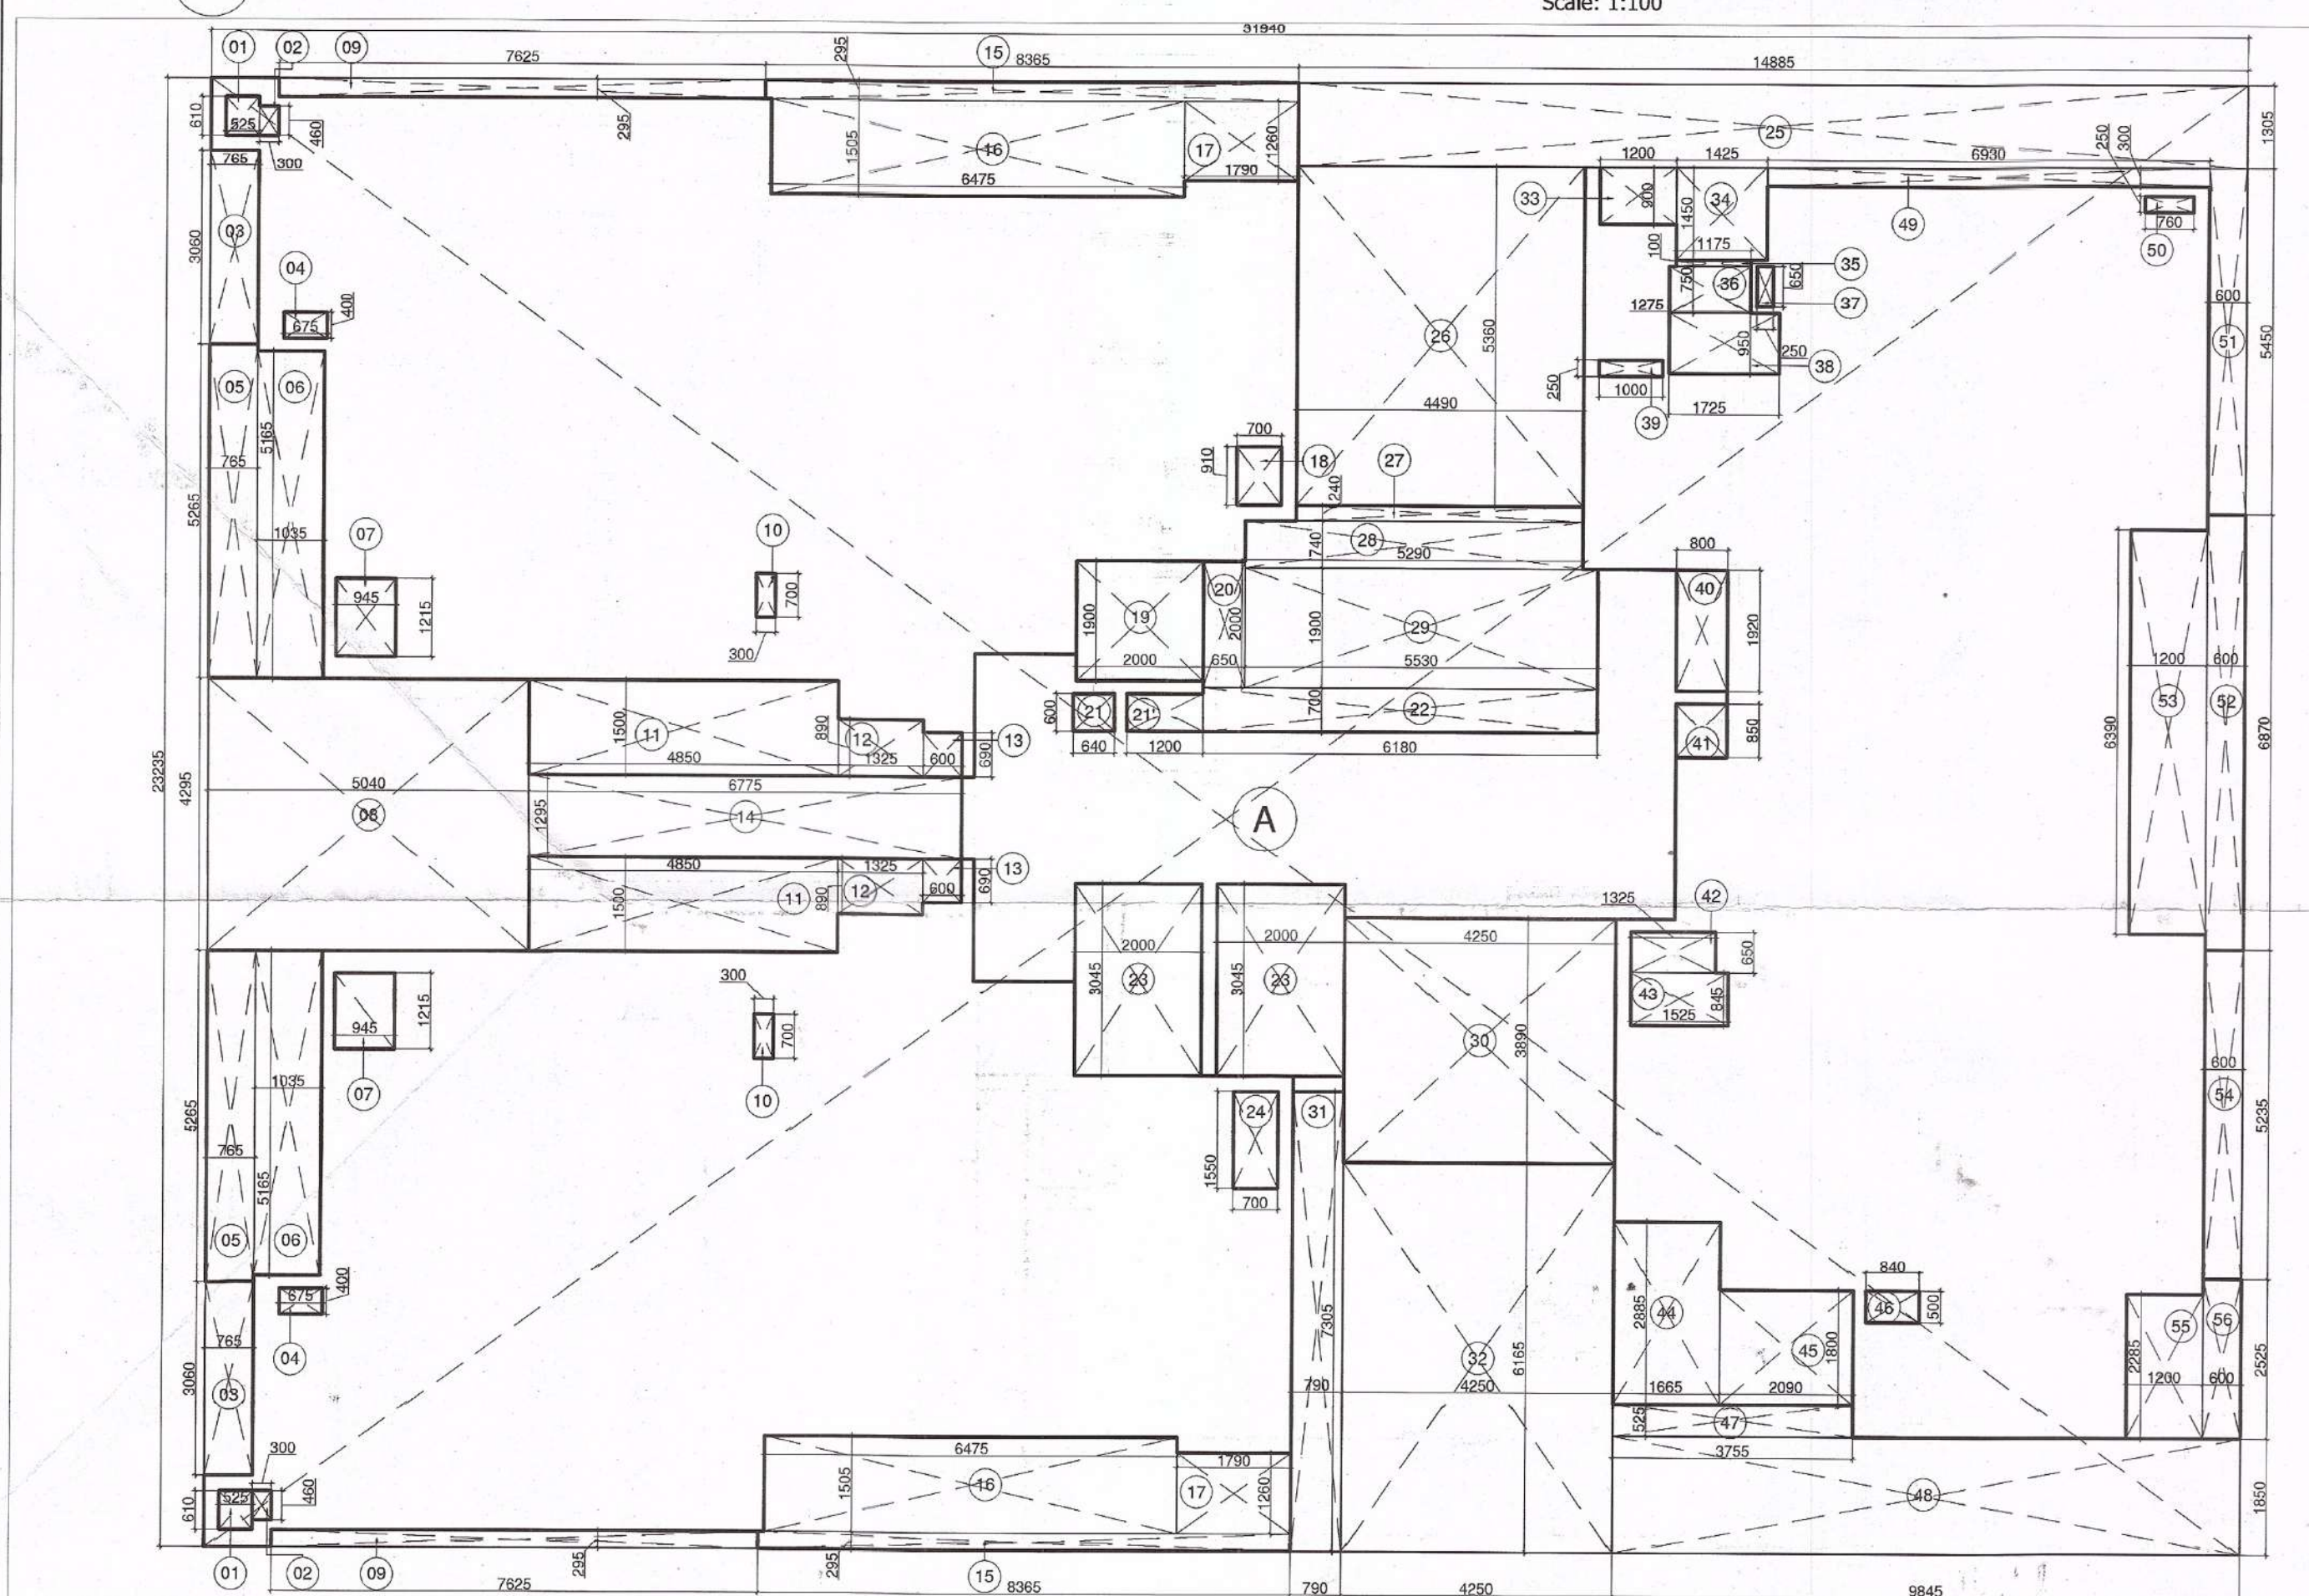

2 Tower C 4th to 23rd Typical Floor Plan (Except 16th Floor) Area Diagram

Scale: 1:100

DOOR - WINDOW SCHEDULE					
INTERNAL DOORS					
DOOR TAG	ROOM DESCRIPTION	QTY	STRUCTURAL OPENING		LEVEL (FROM FFL)
			WIDTH	HEIGHT	
D01	ENTRANCE / PRIVATE LOBBY		1200	2450**	+00
D02	ALL BEDROOMS, UTILITY,		1000	2450**	+00
D03	UTILITY		900	2450**	+00
D04	ALL TOILETS		750	2450**	+00
D05	ELECTRICAL ROOM				+00
D06	TERRACE LOBBY				+00
FD01	Electrical Shaft		1500	2450**	+00
FD02	STAIRCASE		1250	2450**	+00
FD03	LV SHAFT		600	2450**	+00
EXTERNAL DOORS					
DW01	LIVING / DINING		5510	2650	+100 / +900
DW02	MASTER BEDROOM		4655 (AS / PLAN)	2650 / 1800	+100 / +900
DW02A	SERVANT ROOM		4550 (AS / PLAN)	2650 / 1800	+100 / +900
DW03	LIVING / DINING		4100	2650	+100
DW04	LIVING / DINING		2750	2650	+100
DW05	BEDROOM - 2		2450	2650	+100
DW06	MASTER BEDROOM		2400 (AS / PLAN)	2650 / 1800	+100 / +900
DW07	BEDROOM - 2 / SERVANT ROOM		1660	2650	+100
DW08	BEDROOM - 3		1550	2650	+100
DW9	KITCHEN		1500 (AS / PLAN)	2750 / 1800	+100 / +1200
DW10	MASTER BEDROOM		1000	2650	+100
DW11	UTILITY / KITCHEN		850	2450	+100
DW12	TOILET / W.C.		750	2350	+100
WINDOWS					
W01	LIVING / DINING		3400	1800	900
W02	BEDROOM - 2 / BEDROOM - 4 / M. TOILET		2570	1800	900
W03	BEDROOM - 2		2100	1800	900
W04	KITCHEN		1925	1500	1200
W05	STAIRCASE / CORRIDOR		1250	1500	1200
W06	MASTER TOILET / TOILET - 2		900	1500	1200
W07	STAIRCASE		900	1200	1200
W08	MASTER BEDROOM		800	1800	900
W09	M. TOI. / TOI. - 3 / TOI. - 2 / TOI. / UTILITY / W.C.		750	1500	1200
W10	SERVANT ROOM		600	1800	900
W11	UTILITY		410	1800	900

TOWER B 1st to 23rd AND TOWER C 4th to 23rd TYPICAL FLOOR AREA CALCULATION					
TYPE	QUANTITY	SHAPE	FORMULA	DETAIL	CALCULATION EACH AREA IN SQ.M
OUTLINE AREA					
A	1	RECTANGLE	L x B	31.940	23.235
TOTAL OUTLINE AREA					742.126
NON FAR AREA					
1	2	RECTANGLE	L x B	0.610	0.525
2	2	RECTANGLE	L x B	0.460	0.300
4	2	RECTANGLE	L x B	0.675	0.400
5	2	RECTANGLE	L x B	5.265	0.765
6	2	RECTANGLE	L x B	5.165	1.035
7	2	RECTANGLE	L x B	1.215	0.945
10	2	RECTANGLE	L x B	0.700	0.300
11	2	RECTANGLE	L x B	4.850	1.500
12	2	RECTANGLE	L x B	1.325	0.890
13	2	RECTANGLE	L x B	0.690	0.600
15	2	RECTANGLE	L x B	8.365	0.295
16	2	RECTANGLE	L x B	6.475	1.505
17	2	RECTANGLE	L x B	1.790	1.260
18	1	RECTANGLE	L x B	0.910	0.700
20	1	RECTANGLE	L x B	2.000	0.650
21	1	RECTANGLE	L x B	0.600	0.640
21'	1	RECTANGLE	L x B	1.200	0.600
22	1	RECTANGLE	L x B	6.180	0.700
24	1	RECTANGLE	L x B	1.550	0.700
27	1	RECTANGLE	L x B	4.490	0.240
28	1	RECTANGLE	L x B	5.290	0.740
29	1	RECTANGLE	L x B	5.530	1.900
30	1	RECTANGLE	L x B	4.250	3.890
35	1	RECTANGLE	L x B	1.175	0.100
36	1	RECTANGLE	L x B	1.275	0.750
37	1	RECTANGLE	L x B	0.650	0.250
38	1	RECTANGLE	L x B	1.725	0.950
39	1	RECTANGLE	L x B	1.000	0.250
40	1	RECTANGLE	L x B	1.920	0.880
41	1	RECTANGLE	L x B	0.850	0.880
42	1	RECTANGLE	L x B	1.325	0.680
43	1	RECTANGLE	L x B	1.525	0.845
44	1	RECTANGLE	L x B	2.885	1.445
45	1	RECTANGLE	L x B	2.050	1.800
46	1	RECTANGLE	L x B	0.840	0.500
50	1	RECTANGLE	L x B	0.760	0.250
52	1	RECTANGLE	L x B	6.870	0.600
53	1	RECTANGLE	L x B	6.390	1.200
55	1	RECTANGLE	L x B	2.285	1.200
56	1	RECTANGLE	L x B	2.525	0.600
TOTAL NON FAR AREA					142.789
CUTOUT'S AREA (NON FAR)					
3	2	RECTANGLE	L x B	3.060	0.765
8	1	RECTANGLE	L x B	5.040	4.295
9	2	RECTANGLE	L x B	7.625	0.295
14	1	RECTANGLE	L x B	6.775	1.295
19	1	RECTANGLE	L x B	2.000	1.900
23	2	RECTANGLE	L x B	3.045	2.000
25	1	RECTANGLE	L x B	14.885	1.305
26	1	RECTANGLE	L x B	5.360	4.470
31	1	RECTANGLE	L x B	7.305	0.790
32	1	RECTANGLE	L x B	6.165	4.250
33	1	RECTANGLE	L x B	1.200	0.900
34	1	RECTANGLE	L x B	1.450	1.425
47	1	RECTANGLE	L x B	3.755	0.525
48	1	RECTANGLE	L x B	9.845	1.850
49	1	RECTANGLE	L x B	6.930	0.300
51	1	RECTANGLE	L x B	5.450	0.600
54	1	RECTANGLE	L x B	5.235	0.600
TOTAL CUTOUT'S AREA					162.865
TOTAL BUILT UP AREA = TOTAL OUTLINE AREA - TOTAL CUTOUT'S AREA					579.261
FAR AREA = TOTAL OUTLINE AREA - (TOTAL NON FAR AREA + TOTAL CUTOUT'S AREA)					436.471

Sign & Stamp

PROJECTED BY: *[Signature]*
 MEMBER SECRETARY: *[Signature]*
 MEMBER: *[Signature]*
 CHAIRMAN: *[Signature]*
 B.P.C. B.P.C. B.P.C.

Deputy Director (T)
 O/o Directorate Fin. Service
 Member B.P.C.

KEY PLAN

Checked and found ok for Public Health
 (Internal) and for compliance to town and
 forwarding to the SE/DO, D. 1/1/2020
 Sd/-
 Sd/-

This is a "PROVISIONAL APPROVED BUILDING PLAN"
 only for purpose of building
 sanction from the general public

Approved by:
 District of Town and Country Planning
 Rayachoti, Chaudhary

PLUMBING LEGEND -

①	1000 CI SOIL PIPE
②	1000 CI WASTE PIPE
③	1000 CI WASTE PIPE FOR KITCHEN
④	1000 DRAIN PIPE FOR SWIMMING POOL
⑤	750 CI ASP
⑥	1100 UPVC RWP FOR TERRACE
⑦	1100 UPVC RWP FOR BALCONY
⑧	COLD WATER SUPPLY DROP
⑨	COLD WATER SUPPLY DROP FOR KITCHEN
⑩	COLD WATER SUPPLY DROP FOR TOP THREE FLOORS
⑪	COLD WATER SUPPLY DROP FOR KITCHEN TOP THREE FLOORS
⑫	FLUSHING WATER SUPPLY DROP
⑬	FLUSHING WATER SUPPLY DROP FOR TOP THREE FLOORS
⑭	COLD WATER SUPPLY RISER FOR OHT
⑮	FLUSHING WATER SUPPLY RISER FOR OHT
⑯	WATER HEATER CAPACITY-25/15 LTRS
⑰	FLOOR TRAP (100x100)MM
⑱	FLOOR DRAIN (100x50)MM
⑲	BALL VALVE

PROJECT NAME & ADDRESS

APPROVAL OF REVISED BUILDING PLANS OF RESIDENTIAL GROUP
 HOUSING COLONY UNDER TRANSIT ORIENTED DEVELOPMENT
 (TOD) POLICY FOR MDX LAND USE COLONY
 (70% RESIDENTIAL+30%COMMERCIAL) MEASURING 4.85 ACRES
 (LICENSE No. 110 of 2013 DATED 27.12.2013) IN SECTOR - 28,
 GURUGRAM PANDESK URBAN COMPLEX BEING DEVELOPED BY
 SILVERGLADES INFRASTRUCTURE Pvt. Ltd.

CLIENT NAME & ADDRESS

GROUP SILVERGLADES
 5th FLOOR, TIME SQUARE BUILDING, B-BLOCK,
 SUSHANT LOK, PHASE-I, GURUGRAM - 122002,
 HARYANA, INDIA

ARCHITECT'S SIGN & STAMP

ANAND SHARMA
 R. No. 11150, P.O. 11150,
 CA/15/18739, ANAND-12202
 New Delhi

DRAWING TITLE

Tower C 4th to 23rd Typical Floor Plan
 (Except 16th Floor) and Area Diagram

SCALE

1:100 ON A1

DATE

31-12-2019

DRAWING NO.

021

NORTH