

01	STORM LINE	
02	STORM MANHOLE	
03	DE-SILTING CHAMBER (2000X1200)	DSC
04	OIL GREASE SEPARATOR (2000X1200)	OGS
05	RECHARGE PIT (3000Ø)	RWH
06	CATCH BASIN	 CB
S.N	PLUMBING LEGENDS:-	
01	SEWER LINE	
02	SEWER MANHOLE	
S.N	PLUMBING LEGENDS:-	
01	DOMESTIC WATER SUPPLY	
02	FLUSHING WATER SUPPLY	
03	BORE WELL & MUNICIPAL LINE	
04	IRRIGATION LINE	
05	GARDEN HYDRANT	



TOTAL GREEN AREA			
4,332.43			
382.12	X	4.04	12
=	X	4.87	11
=	X	3.15	10
87.08	X	2,151.19	9
75.94	X	34,985	8
202.91	X	64,785	7
177.68	X	2,650	6
272.69	X	38,955	5
277.87	X	6,000	4
265.36	X	13,055	3
115.48	X	4,560	2
316.67	X	14,660	1
161.46	X	27,618	
1,545.60	X	47,770	

GREEN AREA CHART

[illegible]

TOTAL NO. OF ECS IN OPEN AREA = 4720.99 / 23 = 205.26 ECS

STILT PARKING AREA TOWER-1 & 2 = 529.38 X 2 = 1058.76 SQMT

STILT PARKING AREA TOWER-3 & 4 & 5 = 886.89 X 3 = 2660.67 SQMT

STILT PARKING AREA TOWER-6 & 7 = 740.03 X 2 = 1480.06 SQMT

= 5199.49 SQMT

TOTAL NO. OF ECS IN STILT PARKING AREA = 1058.76 + 2660.67 + 1480.06 = 5199.49 / 28 = 185 ECS

TOTAL NO. OF ECS = 205 + 185 + 28 = 418 ECS

 
PARKING AREA CHART

CLIENT:- PAGASUS LAND AND HOUSING PVT.LTD

ARCHITECTS

PRIMAAR ARCHITECTS PVT. LTD.

808, SECTOR 14, GURGAON
HARYANA




DRAWING NO.

SCALE : 1:100

SITE PLAN

SITE PLAN & PARKING DETAILS AND

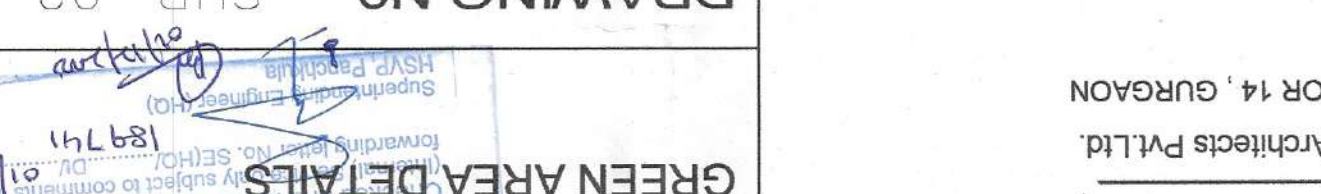

DRAWING NO.

SCALE : 1:100

APPLICANTS SIGN

Attested Signature

Registrar Housing Pw. Ltd.

ARCHITECTS SIGN

VIMAL BAJAJ

Architect C/A/96/19791
938, Sector-14, Gurgaon