

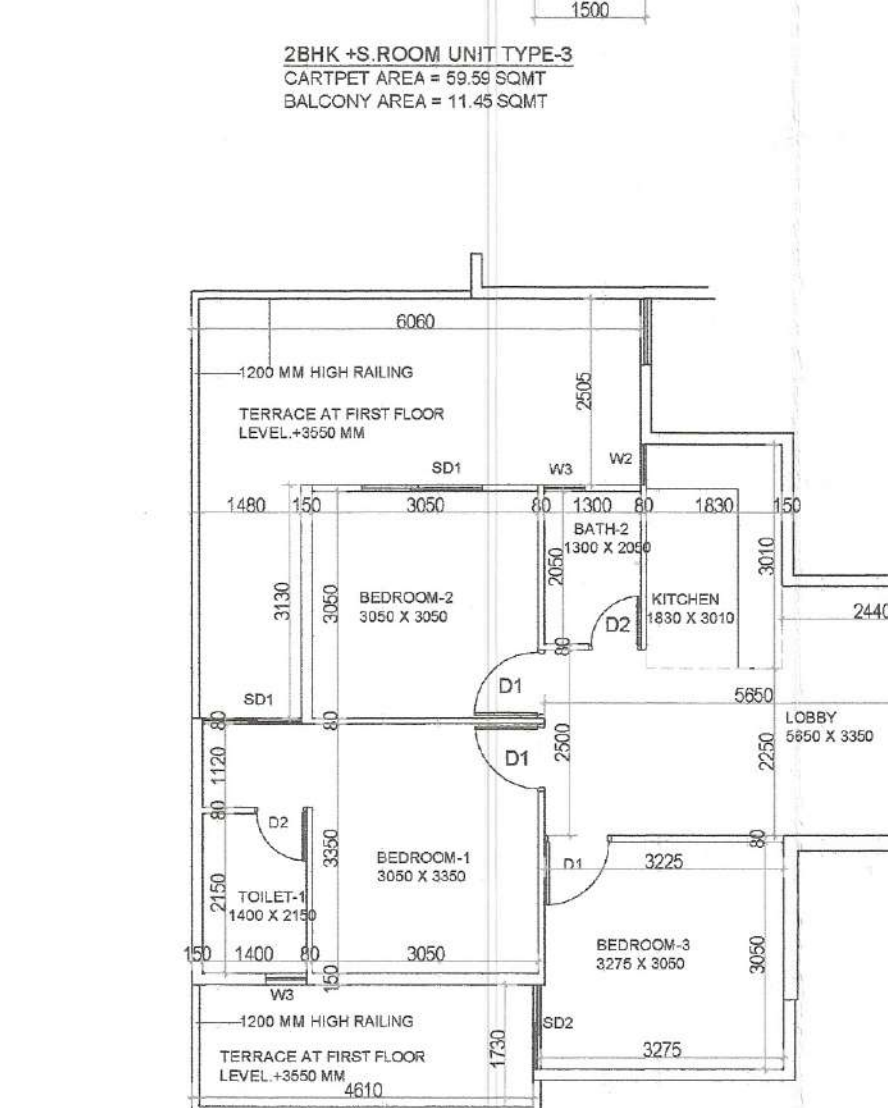
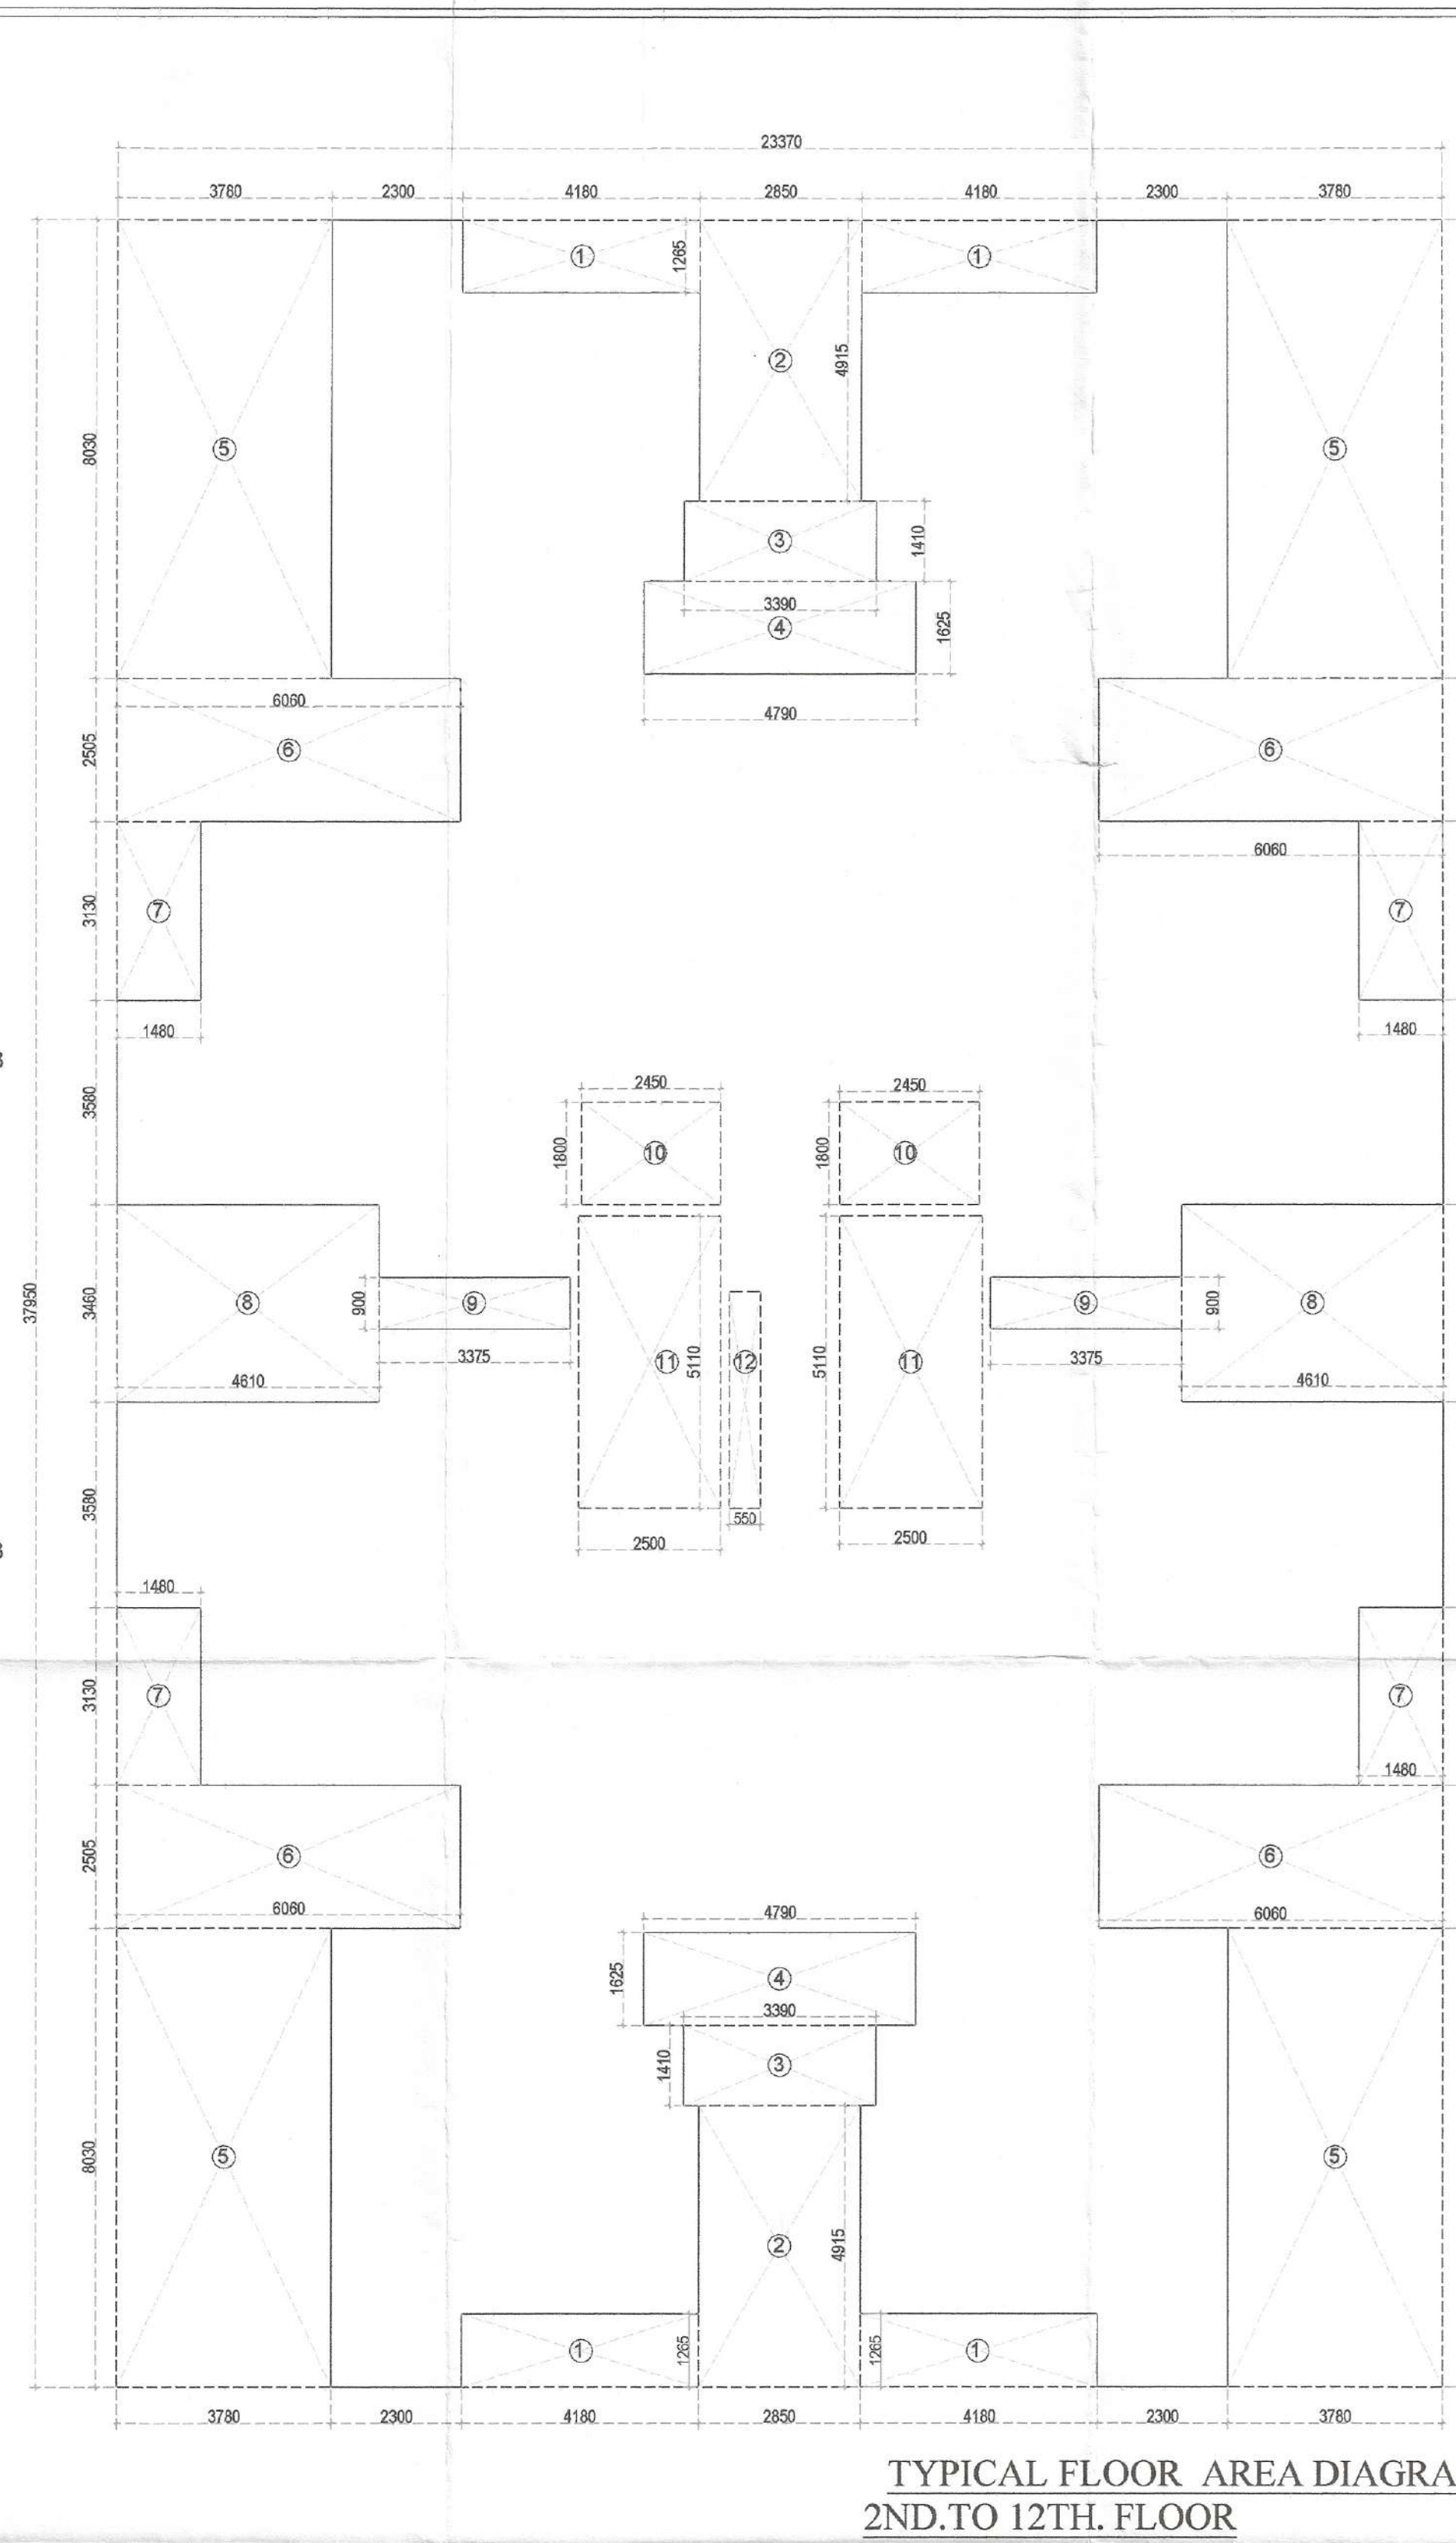



Diagram illustrating the layout of a room with a bay window, showing dimensions and carpet area calculations. The room dimensions are 3225mm (width) and 7760mm (height). The bay window dimensions are 1830mm (width) and 1530mm (height). The layout includes a central carpet area (3) and four side areas (1, 2, 4, 5). The dimensions for the side areas are: 1 (1830mm x 630mm), 2 (2440mm x 350mm), 4 (1480mm x 3130mm), and 5 (1480mm x 3350mm).

CARPET AREA CHART TYPE-3A


1	1.830	X	0.630	=	1.153
2	2.440	X	3.350	=	8.174
3	3.225	X	7.760	=	25.026
4	3.130	X	6.480	=	20.282
5	1.480	X	3.350	=	4.958
NET CARPRT AREA				=	59.59

TERRACE AREA CHART TYPE-3A

1	6.060	X	2.505	=	15.180
2	1.480	X	3.130	=	4.632
3	4.610	X	1.730	=	7.975

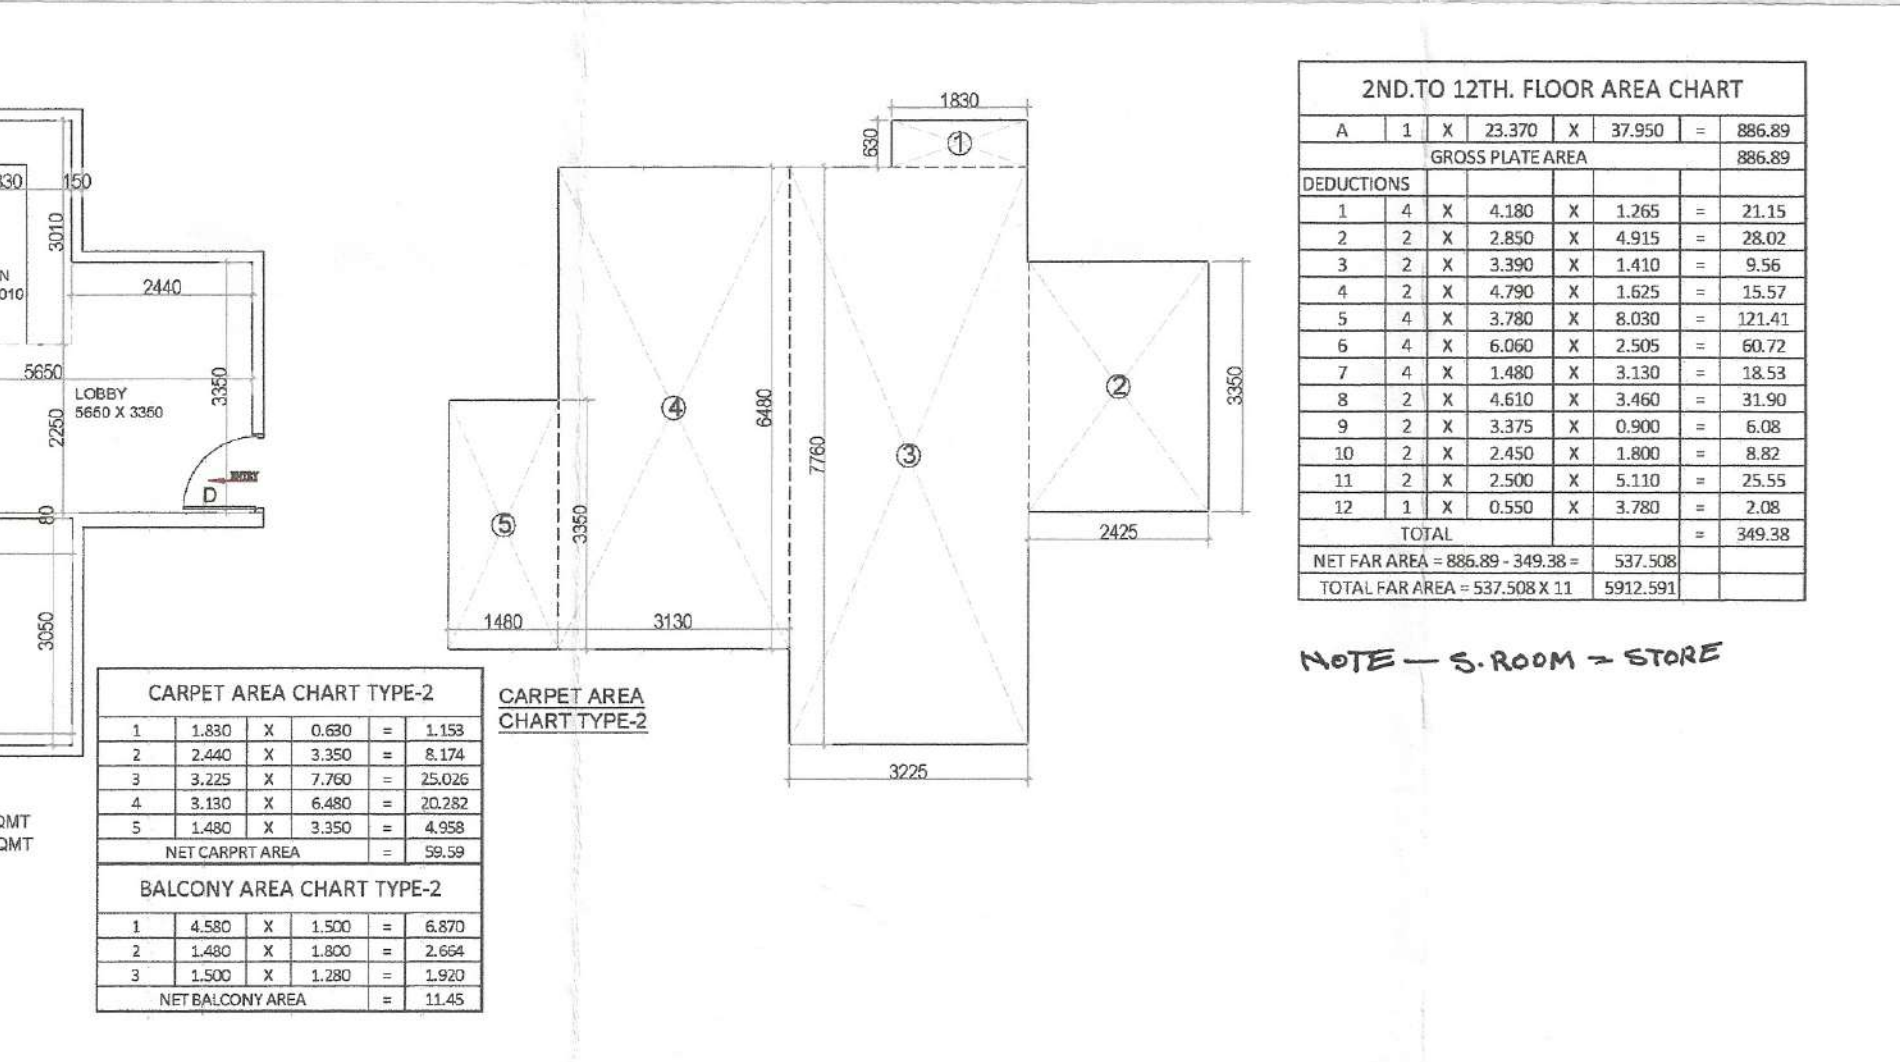

PLUMBING LEGEND:-		
S.NO.	DESCRIPTION	SYMBOL
1.	110 xD UPVC VERTICAL SOIL & VENT PIPE	①
2.	110 xD UPVC VERTICAL WASTE & VENT PIPE	②
3.	ANTISYPHONAGE PIPE	③
4.	DOMESTIC WATER SUPPLY DOWN TAKE PIPE	④
5.	FLUSHING WATER SUPPLY DOWN TAKE PIPE	⑤
6.	110 xD UPVC RAIN WATER PIPE FOR TERRACE	⑥
7.	75 xD UPVC RAIN WATER BALCONY DRAIN PIPE	⑦
8.	DOMESTIC WATER SUPPLY RISER PIPE	⑧
9.	FLUSHING WATER SUPPLY RISER PIPE	⑨
10.	FLOOR TRAP	FT 
11.	FLOOR DRAIN	FD 
12.	FLOOR CLEAN OUT	FCO 
13.	COLD WATER SUPPLY (DOMESTIC)	CWS 
14.	FLUSHING WATER SUPPLY	FWS 
15.	ISOLATION VALVE	

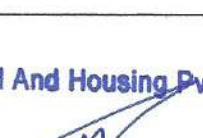CLIENT:- PEGASUS LAND AND HOUSING PVT.LTD	
PROJECT :- PROPOSED BUILDING PLAN OF AFFORDABLE GROUP HOUSING COLONY FOR AN AREA MEASURING 5.03403 ACRE (LICENCE NO.19 OF 2020 DATED.01.08.2020) IN SECTOR-93 GURGRAM MANESAR URBAN COMPLEX BEING DEVELOPED BY PEGASUS LAND AND HOUSING PVT. LTD.	
ARCHITECTS  Pirade Architects Pvt.Ltd. 908 , SECTOR 14 , GURGAON HARYANA	SCALE : 1:100 DRAWING NAME TOWERS-3 & 5 TYPICAL FLOOR PLAN & TYPICAL AREA DIAGRAM,& TERRACE, UNITS PLAN &
Pegasus Land And Housing Pvt. Ltd.  Authorised Signatory	DRAWING NO. SUB - 11 VIMAL BAJAR Architect CA/96/19791 938, Sector-14, Gurgaon