


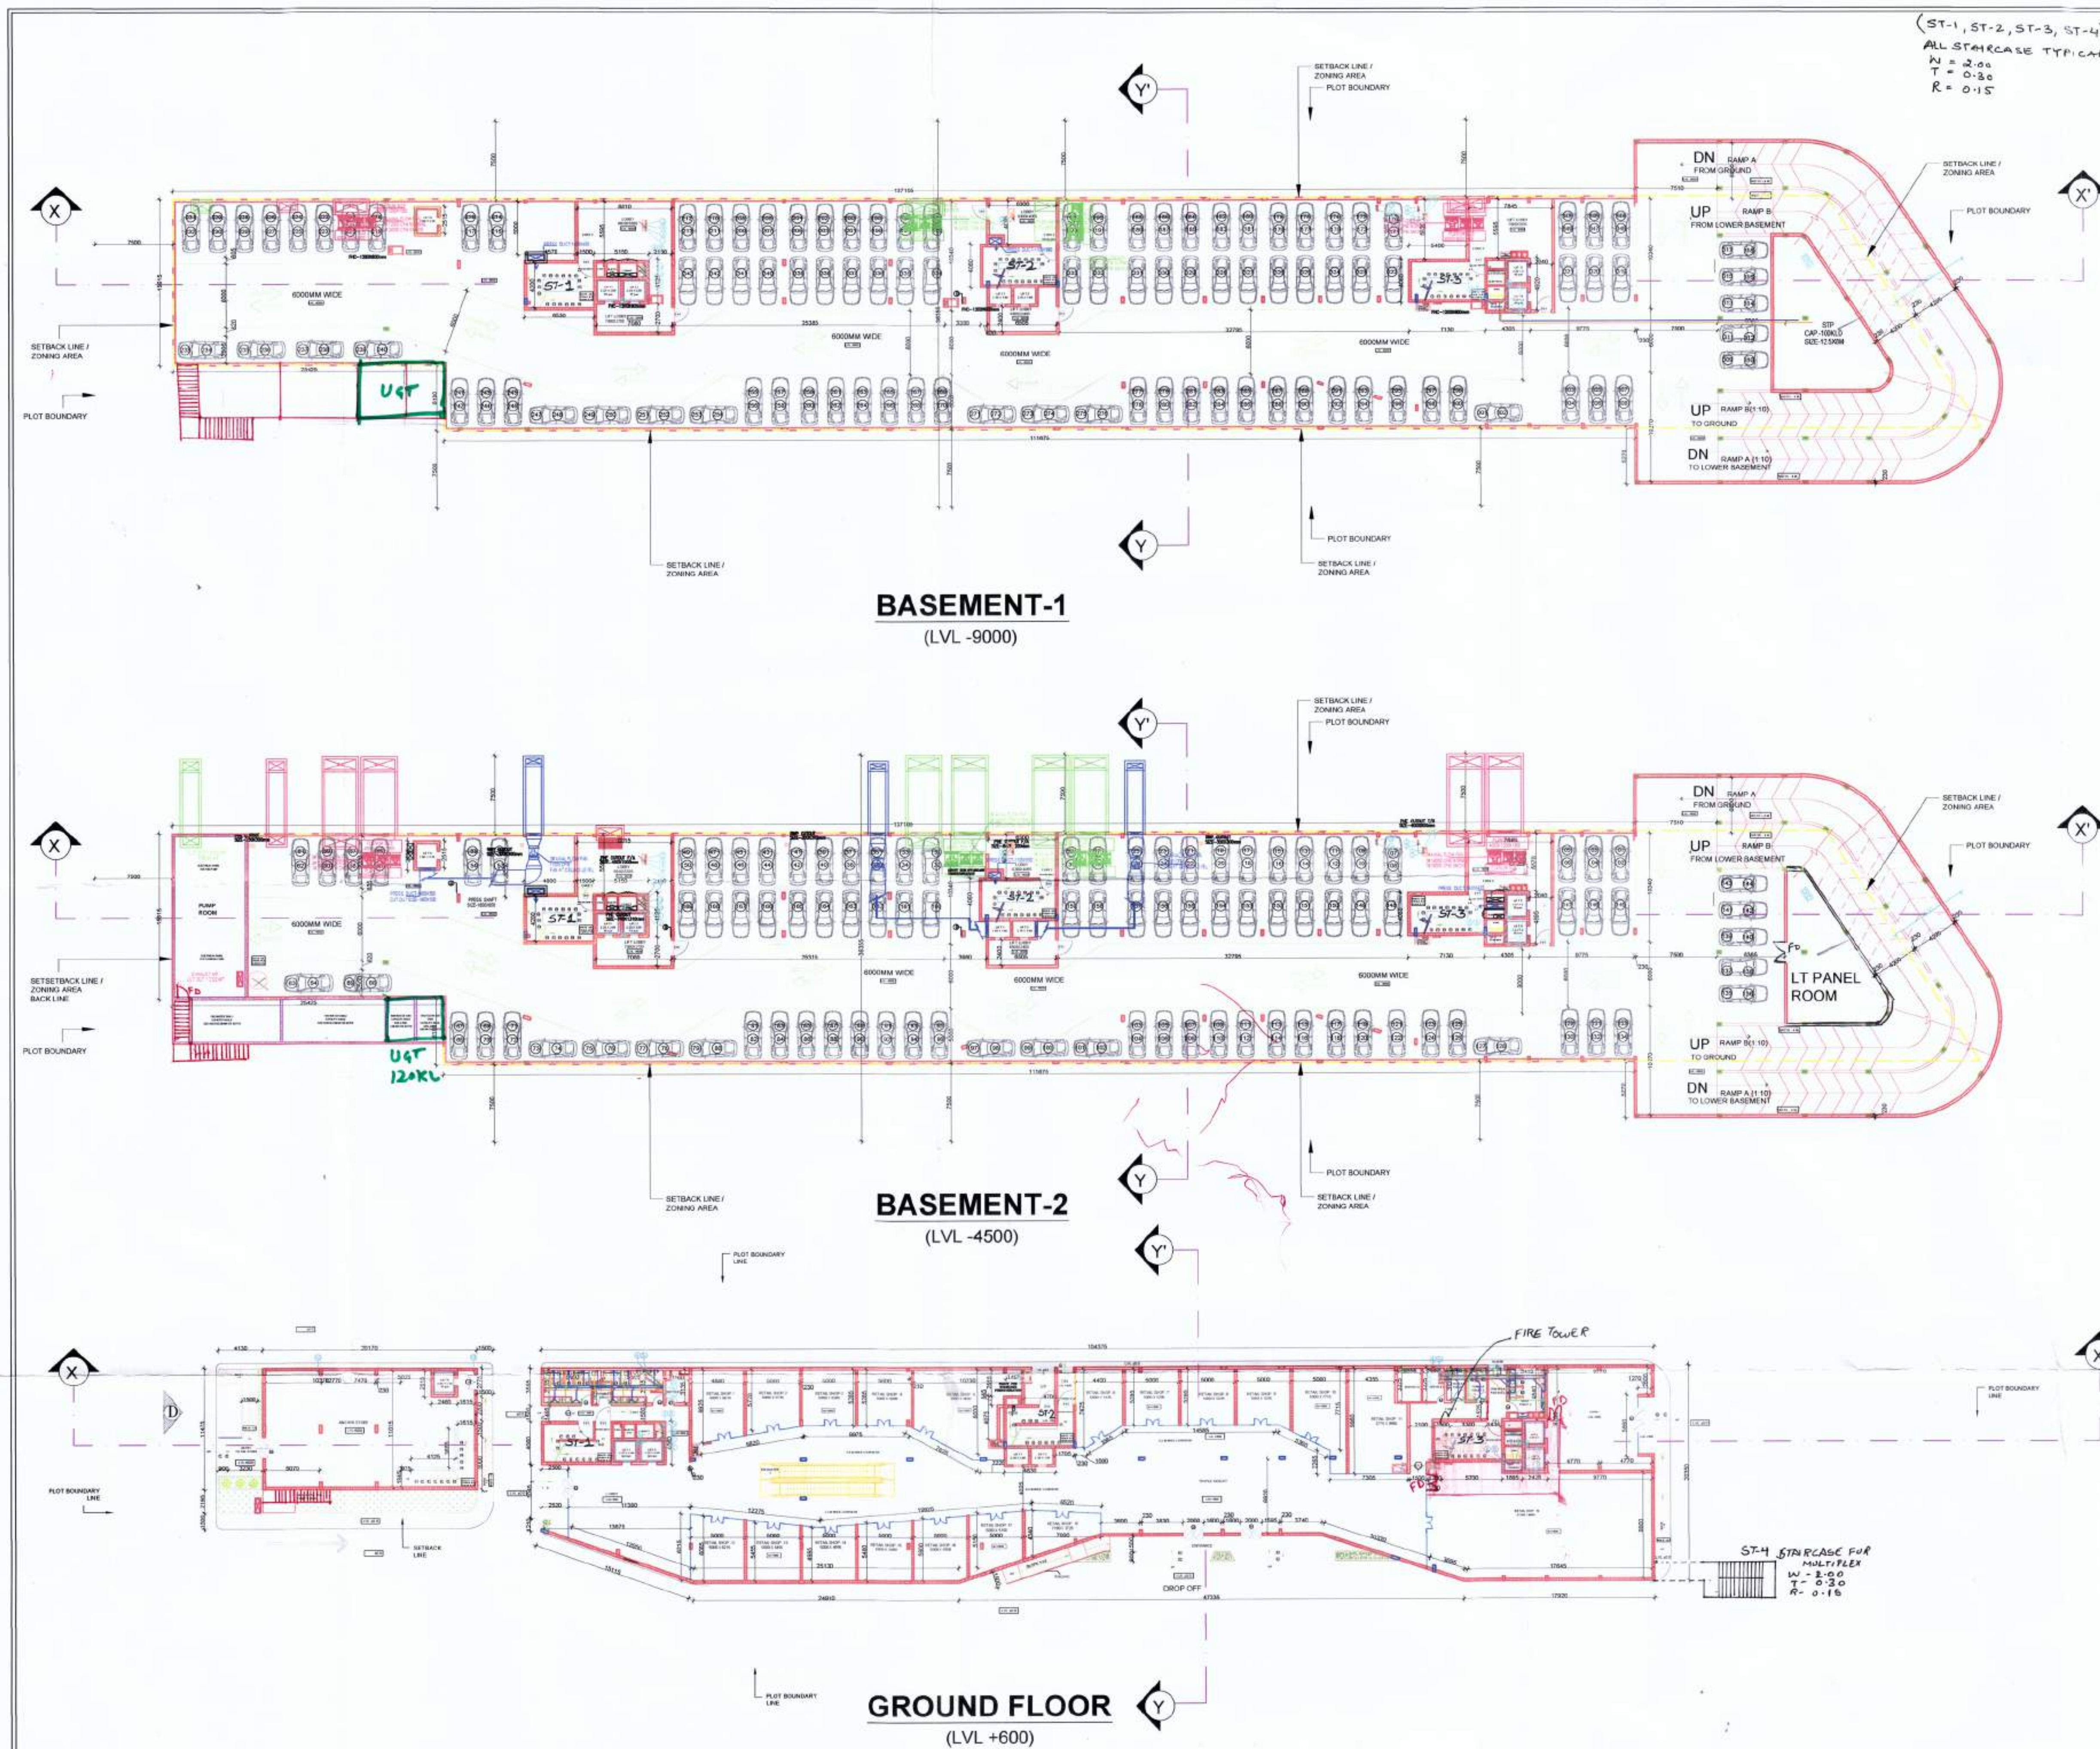

PLUMBING LEGEND:-

DESCRIPTION	SYMBOL
1100 SOIL PIPE	(1)
1600 SOIL PIPE	(2)
1100 WASTE PIPE	(3)
1100 WASTE PIPE	(4)
DOMESTIC WATER SUPPLY (GUEST FLOOR)	(5)
DOMESTIC WATER SUPPLY PIPE FROM OHT TO RING	(6)
DOMESTIC WATER SUPPLY RISER FROM OHT TO SUPPLY RING & OHT (TANK FILLING)	(7)
DOMESTIC WATER SUPPLY PIPE FROM OHT TO OFFICE & RETAIL FLOOR	(8)
DOMESTIC WATER SUPPLY RISER PIPE	(9)
FLUSHING WATER SUPPLY PIPE	(10)
FLUSHING WATER SUPPLY PIPE RISER	(11)
HOT WATER SUPPLY PIPE (GUEST FLOOR)	(12)
HOT WATER SUPPLY PIPE HEAT PUMP TO SUPPLY RING	(13)
HOT WATER SUPPLY PIPE HEAT PUMP TO BOH AREA	(14)
HOT WATER RETURN PIPE	(15)
HOT WATER RETURN PIPE RING TO MIXING TANK	(16)
HOT WATER RETURN PIPE BOH AREA TO MIXING TANK	(17)
750 VENT PIPE	(18)
1500 RAIN WATER PIPE	(19)
2000 RAIN WATER PIPE	(20)
1100 RAIN WATER PIPE	(21)
750 DRAIN PIPE	(22)
FLOOR DRAIN	(23)
FLOOR TRAP	(24)
CLEAN OUT PLUG	(25)
FLOOR CLEAN OUT	(26)

PROJECT:
COMMERCIAL COLONY AREA MEASURING 2.625 ACRES IN SECTOR 34, SONHA BEING DEVELOPED BY SMT. MONIKA RAIZADA W/O SH. NAVEEN RIZADA IN COLLABORATION WITH NAVI ESTATES LLP.
(LICENCE NO 79. OF 2018 DATED 17/11/2018)

CLIENT: NAVI ESTATES, LLP
NEW DELHI

REVISION SCHEDULE:

SNO	NOTES	DATED

ARCHITECT SIG:
[Signature]
STHAPATI ASSOCIATES (P) LTD.
REGISTERED ARCHITECT
GATEWAY
GATEWAY

OWNER SIG:
[Signature]
NAVI ESTATES, LLP

BUILDING TYPE: COMMERCIAL

GENERAL NOTES:
1. All dimensions are in MM
2. Only written dimensions should be followed
3. All dimensions should be checked and verified before execution inconsistency if any should be brought to the notice of the architect


DRAWING TITLE: BASEMENT-1, BASEMENT-2 & GROUND FLOOR PLAN

DRAWING NO: AR-LF-19-02
DATE: 01/08/2019

SCALE: 1:200
NORTH:

STHAPATI ASSOCIATES (P) LTD.
architects, interior designers,
landscape consultants,
& project consultants.

Lucknow Studio: 1/24, Vipul Khand, Gomti Nagar, Lucknow
Ph no. 0522 - 4027793
T - 34/ 702, Common Wealth Games Village,
Delhi - 110092
Ph no. 011 - 21211409

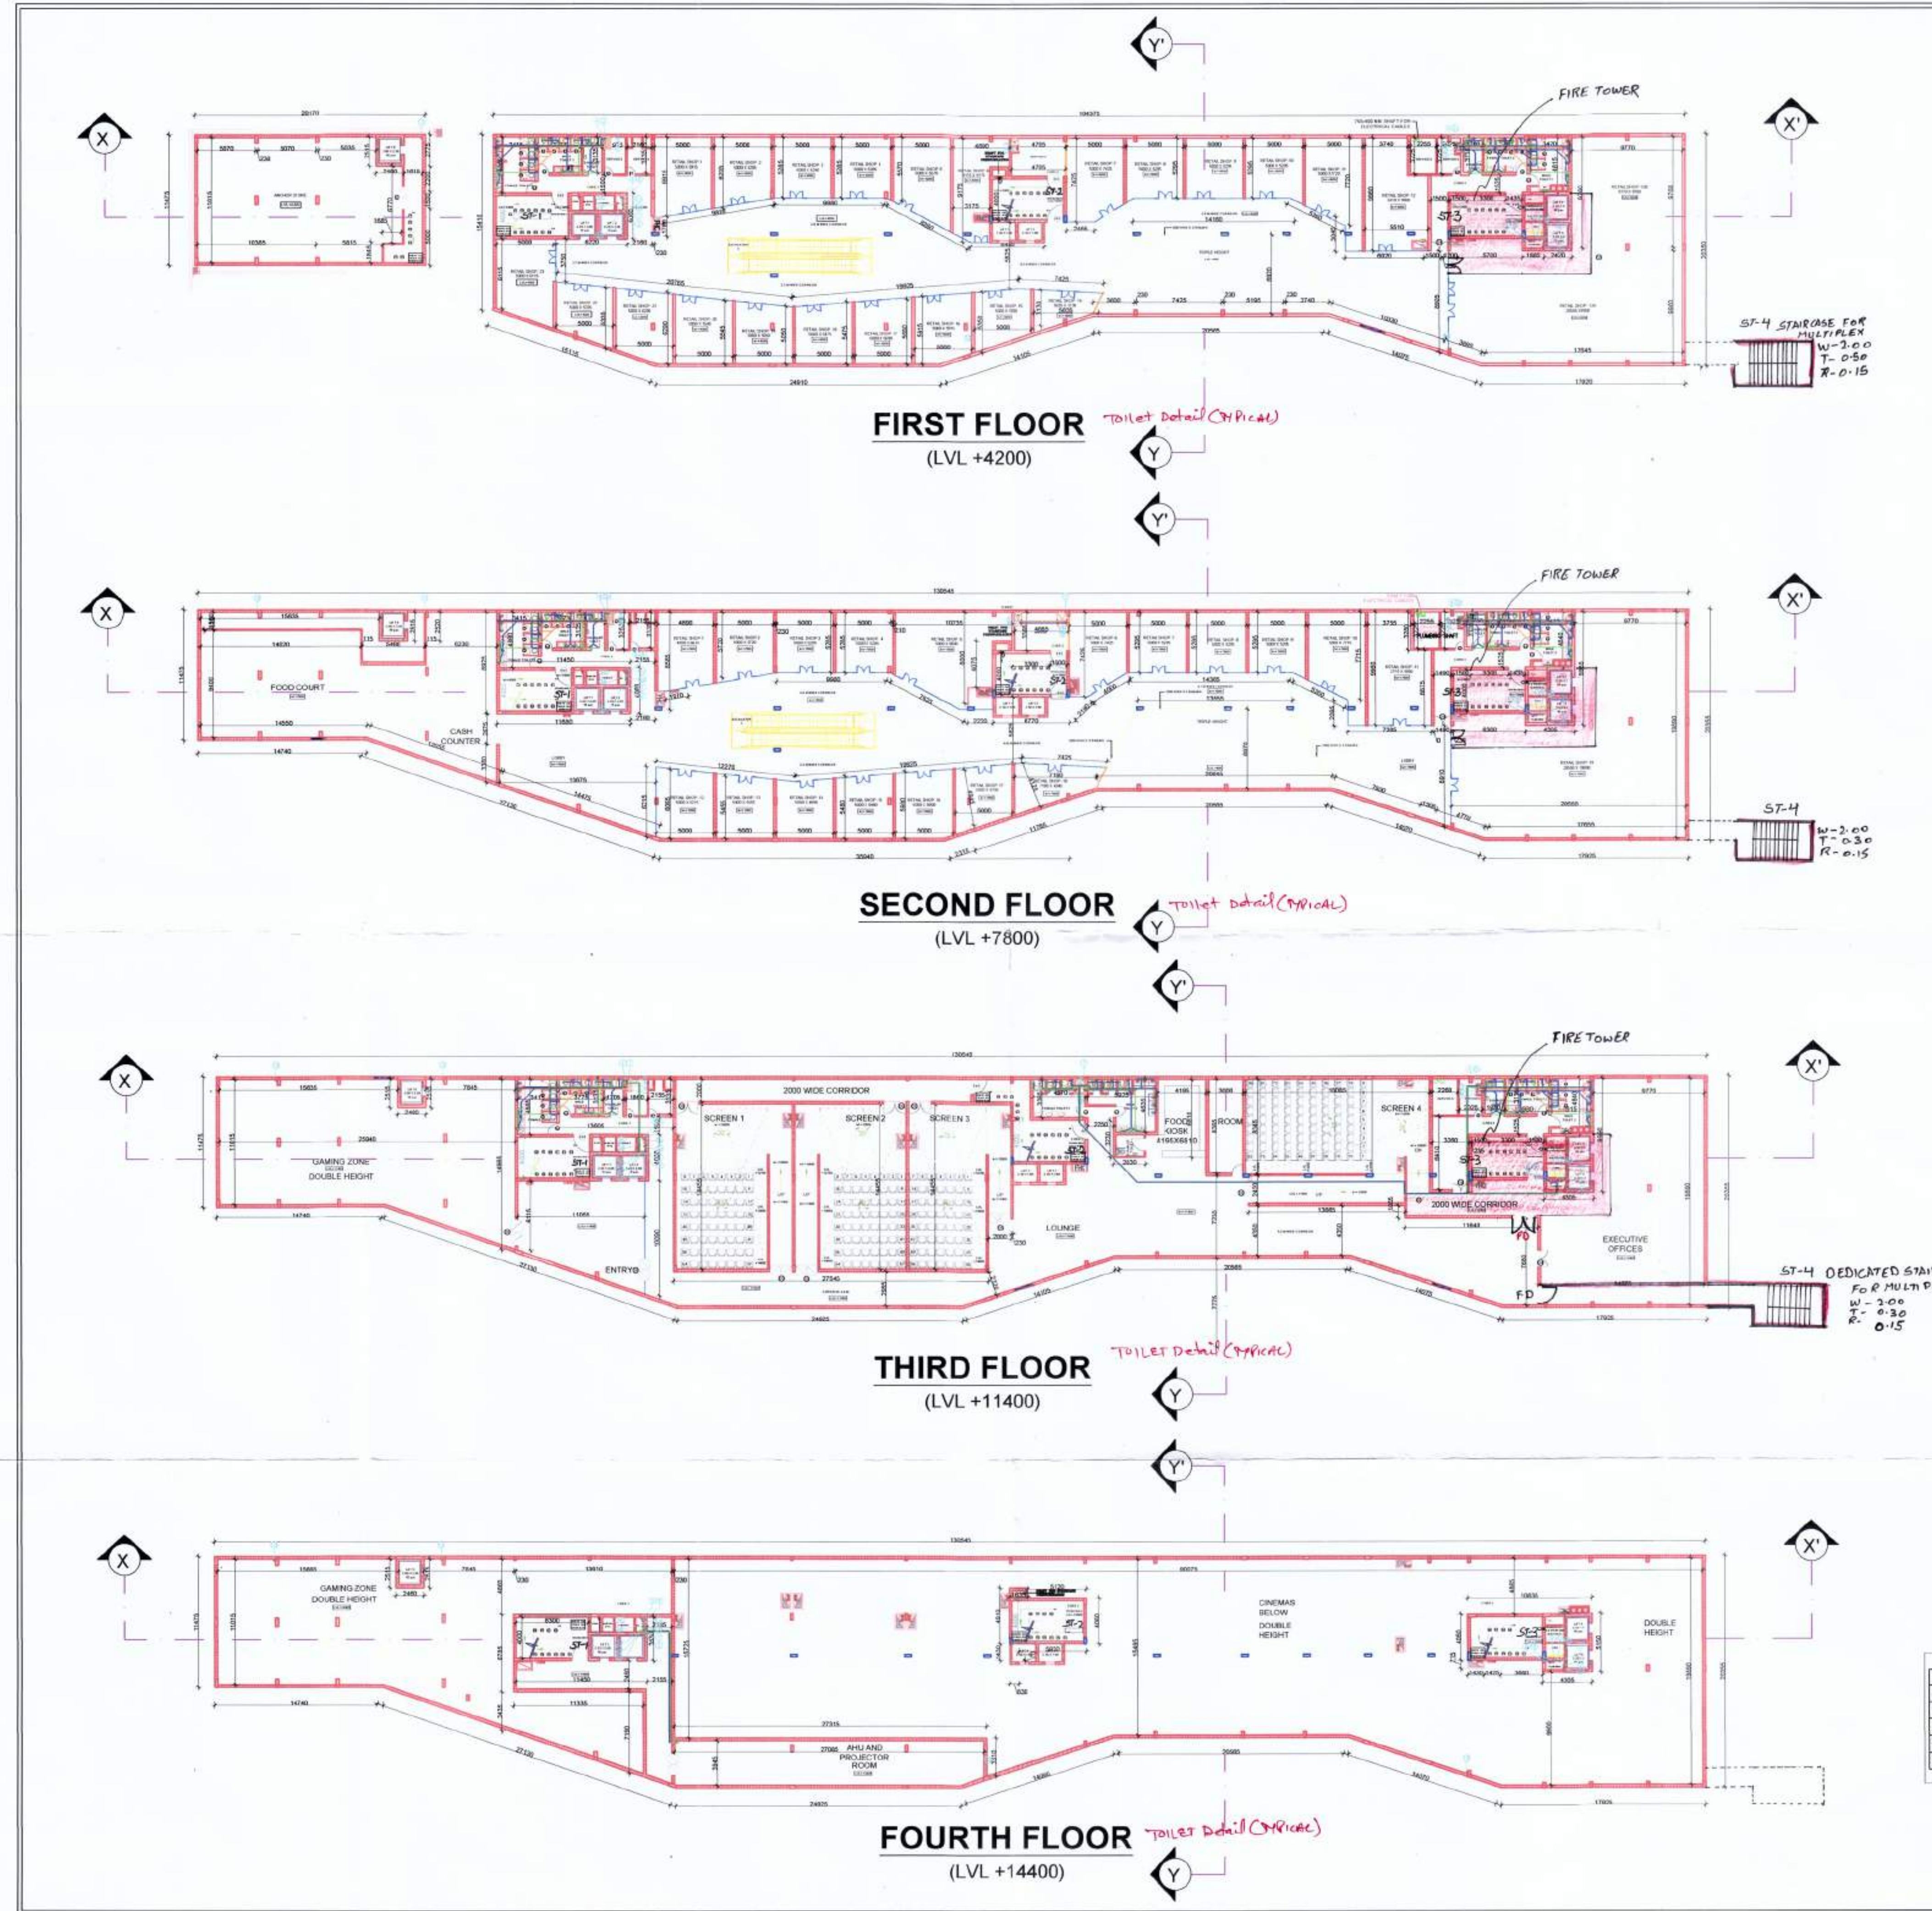

(ST-1, ST-2, ST-3, ST-4)
ALL STAIRCASE TYPICAL
W-2.00
T-0.30
R-0.15

Deputy Director (T)
O/o Directorate Fire Service
Member B.P.C.

Ram Avtar Bansi
AD(HQ)

KEY PLAN:1

PROJECT:

COMMERCIAL COLONY AREA MEASURING 2.625 ACRES IN SECTOR 34, SOHNA BEING DEVELOPED BY SMT. MONIKA RAIZADA W/O SH. NAVEEN RIZADA IN COLLABORATION WITH NAVI ESTATES LLP. (LICENCE NO 79. OF 2018 DATED 17/11/2018)

CLIENT:

NAVI ESTATES, LLP
NEW DELHI

REVISION SCHEDULE:

SNO	NOTES	DATED

ARCHITECT SIG:

[Signature]

OWNER SIG:

[Signature]

BUILDING TYPE:

COMMERCIAL

GENERAL NOTES:

1. All dimensions are in MM
2. Only written dimensions should be followed.
3. All dimensions should be checked and verified before execution. Inconsistency if any should be brought to the notice of the architect.

DRAWING TITLE:

SECOND, THIRD & FOURTH FLOOR PLAN

DRAWING NO:

AR-LF-19-03


DATE:

01/08/2019

SCALE:

1:200

NORTH:

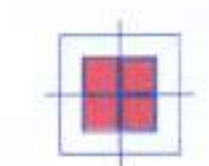

STHAPATI ASSOCIATES (P) LTD.
architects, interior designers,
landscape consultants,
& project consultants.

Lucknow Studio: 1/24, Vipul Khand, Gomti Nagar, Lucknow
Ph no. 0522 - 4027793
Delhi Studio: T - 34/ 702, Common Wealth Games Village,
Delhi - 110092
Ph no. 011 - 21211409



* FR = FIRE RESISTANT

PLUMBING LEGEND:-	
	DESCRIPTION
(1)	110ø SOIL PIPE
(1ø)	160ø SOIL PIPE
(2)	110ø WASTE PIPE
(2ø)	160ø WASTE PIPE
(3)	DOMESTIC WATER SUPPLY (GUEST FLOOR)
(3ø)	DOMESTIC WATER SUPPLY PIPE FROM TO RING
(3b)	DOMESTIC WATER SUPPLY RISER FROM TO SUPPLY RING & OHT (TANK FILLING)
(3c)	DOMESTIC WATER SUPPLY PIPE FROM TO OFFICE & RETAIL FLOOR
(3d)	DOMESTIC WATER SUPPLY RISER PIPE
(4)	FLUSHING WATER SUPPLY PIPE
(4ø)	FLUSHING WATER SUPPLY PIPE RISER
(5)	HOT WATER SUPPLY PIPE (GUEST FLOOR)
(5ø)	HOT WATER SUPPLY PIPE HEAT PUMP TO SUPPLY RING
(5b)	HOT WATER SUPPLY PIPE HEAT PUMP TO BOH AREA
(6)	HOT WATER RETURN PIPE
(6ø)	HOT WATER RETURN PIPE RING TO MIXING TANK
(6b)	HOT WATER RETURN PIPE BOH AREA TO MIXING TANK
(7)	75ø VENT PIPE
(8)	150ø RAIN WATER PIPE
(9)	200ø RAIN WATER PIPE
(10)	110ø RAIN WATER PIPE
(11)	75ø DRAIN PIPE
FD	FLOOR DRAIN
FT	FLOOR TRAP
CF	CLEAN OUT PLUG
FOF	FLOOR CLEAN OUT

NOTE -	
①	WASH BASIN TO FLOOR TRAP 40 OD PIPE
②	FLOOR DRAIN TO FLOOR TRAP 63 OD PIPE
③	URINAL TO FLOOR TRAP 50 OD PIPE
④	WC TO VERTICAL STACK 110 OD PIPE
⑤	FLOOR TRAP TO VERTICAL STACK 110 OD PIPE

KEY PLAN:1

PROJECT:

COMMERCIAL COLONY AREA MEASURING
2.625 ACRES IN SECTOR 34, SOHNA BEING
DEVELOP BY SMT. MONIKA RAIZADA W/O SH.
NAVEEN RIZADA IN COLLABORATION WITH
NAVI ESTATES LLP.
(LICENCE NO 79. OF 2018 DATED 17/11/2018)

CLIENT:	NAVI ESTATES, LLP NEW DELHI
---------	--------------------------------

REVISION SCHEDULE:

SNO	NOTES	DATED

ARCHITECT SIG:



OWNER SIG:

Ajay Patel

BUILDING TYPE:	COMMERCIAL
----------------	------------

GENERAL NOTES:

1. All dimensions are in MM
2. Only written dimensions should be followed
3. All dimensions should be checked and verified before execution, inconsistency if any should be brought to the notice of the architect.

DRAWING TITLE:	FIFTH, SERVICE, SIXTH & SEVENTH FLOOR PLAN
----------------	---

DRAWING NO:
AR-LF-19-04


SCALE:
AS SPECIFIED

DATE:

01/08/2019

SCALE:

	NORTH
--	-------

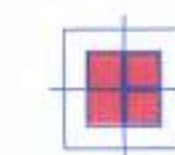

STHAPATI
ASSOCIATES (P) LTD.
architects,interior designers,
landscape consultants,
& project consultants.

Lucknow Studio: 1/24, Vipul Khand, Gomti Nagar, Lucknow
Ph no.0522 - 4027793
Delhi Studio: T - 34/ 702, Common Wealth Games Village
Delhi - 110092
Ph no. 011 - 21211409



EIGHTH FLOOR
(LVL +30000)



NINTH FLOOR
(LVL +33000)



TENTH FLOOR
(LVL +36000)



TERRACE PLAN
(LVL +39000)

(ST-1, ST-2, ST-3, ST-4)
ALL STAIRCASE TYPICAL
W- 2.00
T- 0.30
R- 0.15

KEY PLAN:1

PROJECT:

COMMERCIAL COLONY AREA MEASURING
2.625 ACRES IN SECTOR 34, SOHNA BEING
DEVELOP BY SMT. MONIKA RAIZADA W/O SH.
NAVEEN RIZADA IN COLLABORATION WITH
NAVI ESTATES LLP.
(LICENCE NO 79. OF 2018 DATED 17/11/2018)

CLIENT:

NAVI ESTATES, LLP
NEW DELHI

REVISION SCHEDULE:

SNO	NOTES	DATED

ARCHITECT SIG:

[Signature]

OWNER SIG:

[Signature]

BUILDING TYPE:

COMMERCIAL

GENERAL NOTES:

1. All dimensions are in MM
2. Only written dimensions should be followed
3. All dimensions should be checked and verified before execution, inconsistency if any should be brought to the notice of the architect

DRAWING TITLE:

EIGHTH, NINTH, TENTH &
TERRACE PLAN

DRAWING NO:

AR-LF-19-05

DATE:

01/08/2019

SCALE:


AS SPECIFIED

NORTH:







PLUMBING LEGEND:-	DESCRIPTION
(1)	110Ø SOIL PIPE
(10)	160Ø SOIL PIPE
(2)	110Ø WASTE PIPE
(20)	160Ø WASTE PIPE
(3)	DOMESTIC WATER SUPPLY (GUEST FLOOR)
(30)	DOMESTIC WATER SUPPLY PIPE FROM OHT TO RING
(30)	DOMESTIC WATER SUPPLY RISER FROM UGT TO SUPPLY RING & OHT (TANK FILLING)
(30)	DOMESTIC WATER SUPPLY PIPE FROM OHT TO OFFICE & RETAIL FLOOR
(30)	DOMESTIC WATER SUPPLY RISER PIPE
(4)	FLUSHING WATER SUPPLY PIPE
(40)	FLUSHING WATER SUPPLY PIPE RISER
(5)	HOT WATER SUPPLY PIPE (GUEST FLOOR)
(50)	HOT WATER SUPPLY PIPE HEAT PUMP TO SUPPLY RING
(50)	HOT WATER SUPPLY PIPE HEAT PUMP TO BOH AREA
(6)	HOT WATER RETURN PIPE
(60)	HOT WATER RETURN PIPE RING TO MIXING TANK
(60)	HOT WATER RETURN PIPE BOH AREA TO MIXING TANK
(7)	75Ø VENT PIPE
(8)	150Ø RAIN WATER PIPE
(9)	200Ø RAIN WATER PIPE
(10)	110Ø RAIN WATER PIPE
(11)	75Ø DRAIN PIPE
FD	FLOOR DRAIN
FT	FLOOR TRAP
COF	CLEAN OUT PLUG
FCD	FLOOR CLEAN OUT

NOTE -
(1) WASH BASIN TO FLOOR TRAP 40 OD PIPE
(2) FLOOR DRAIN TO FLOOR TRAP 63 OD PIPE
(3) URINAL TO FLOOR TRAP 50 OD PIPE
(4) WC TO VERTICAL STACK 110 OD PIPE
(5) FLOOR TRAP TO VERTICAL STACK 110 OD PIPE

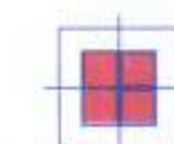

STHAPATI ASSOCIATES (P) LTD.
architects, interior designers,
landscape consultants,
& project consultants.

Lucknow Studio: 1/24, Vipul Khand, Gomti Nagar, Lucknow
Ph no. 0522 - 4027793
Delhi Studio: T - 34/ 702, Common Wealth Games Village,
Delhi - 110092
Ph no. 011 - 21211409

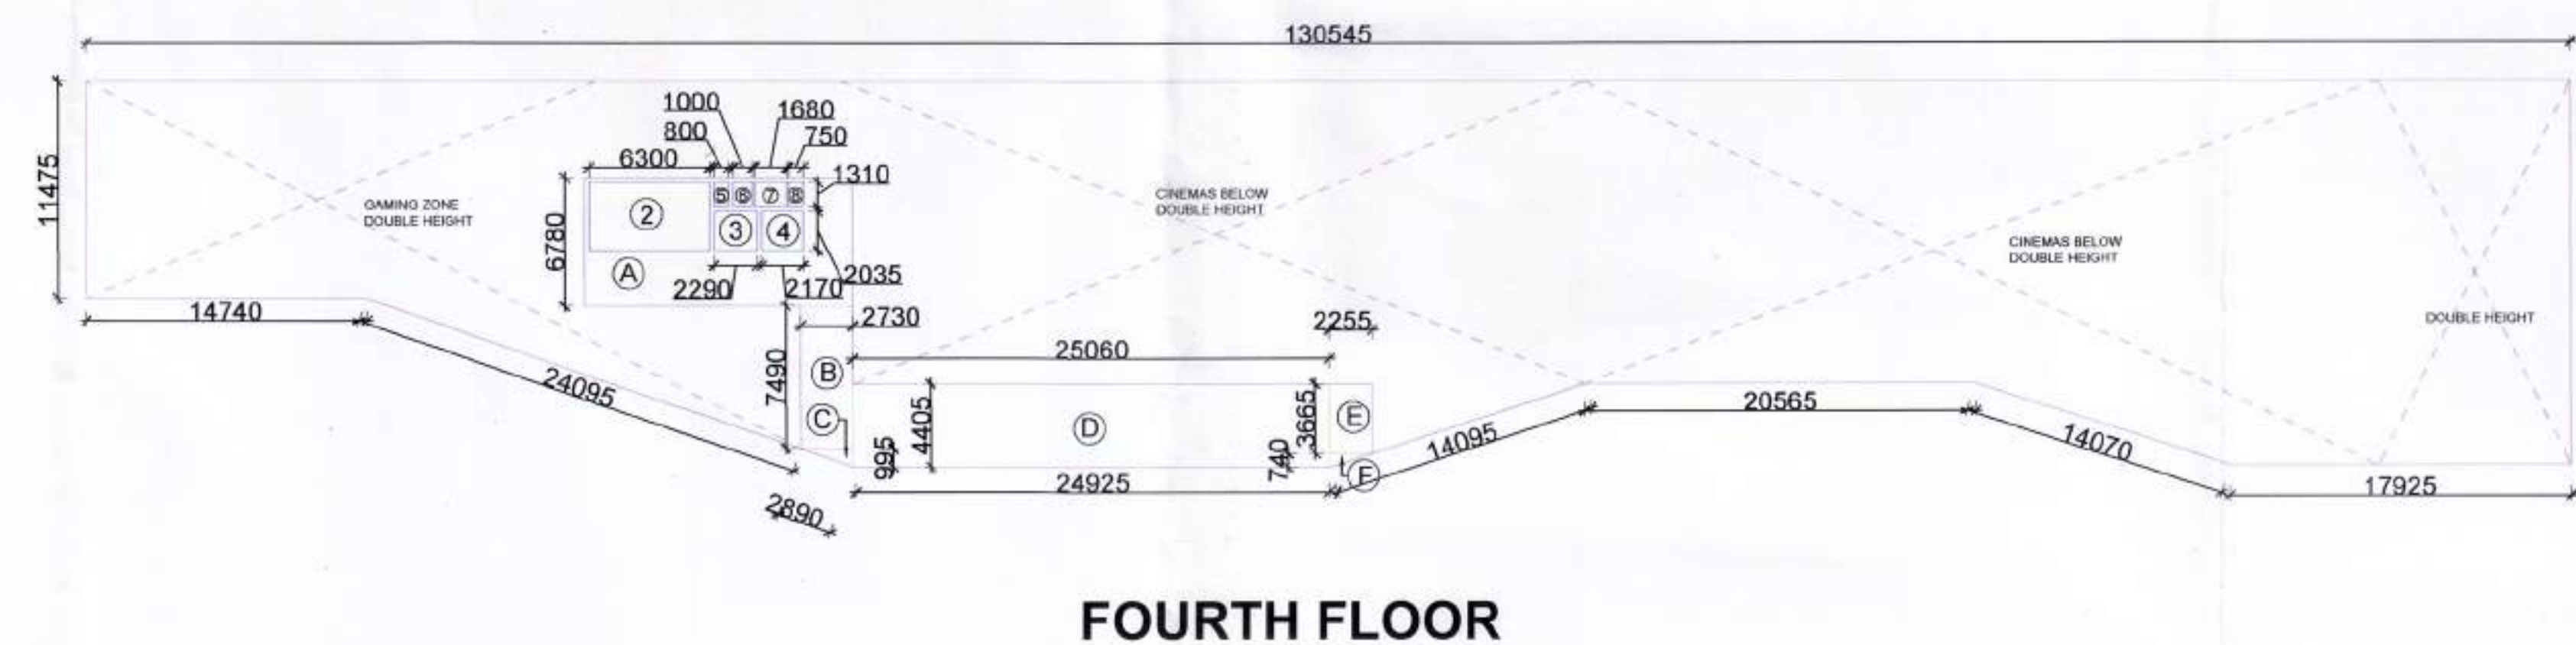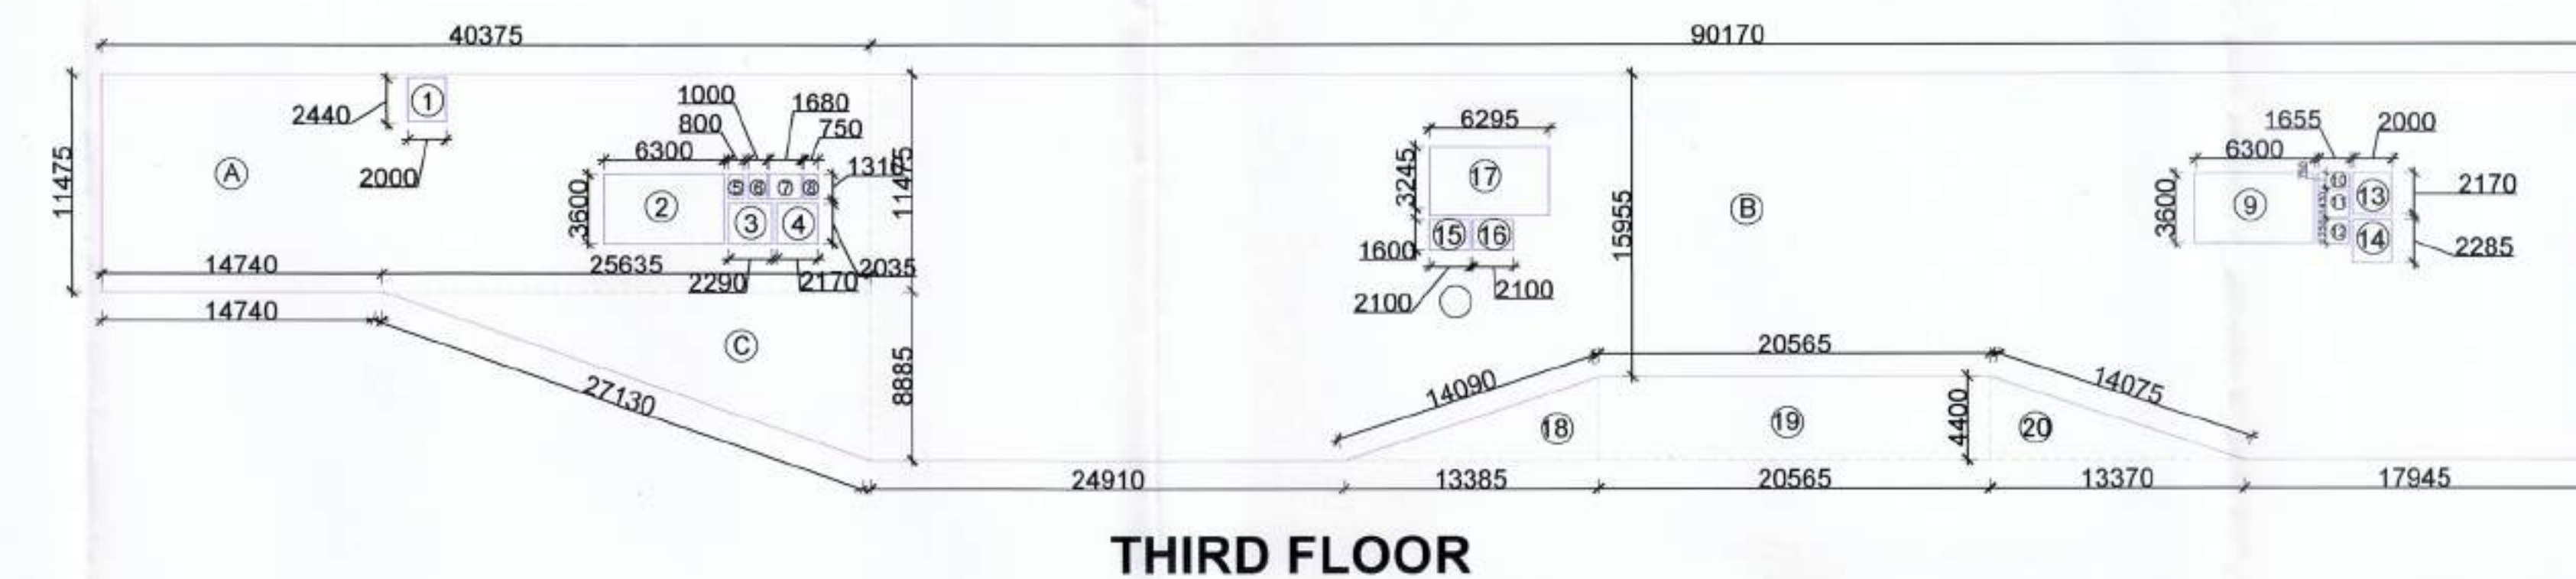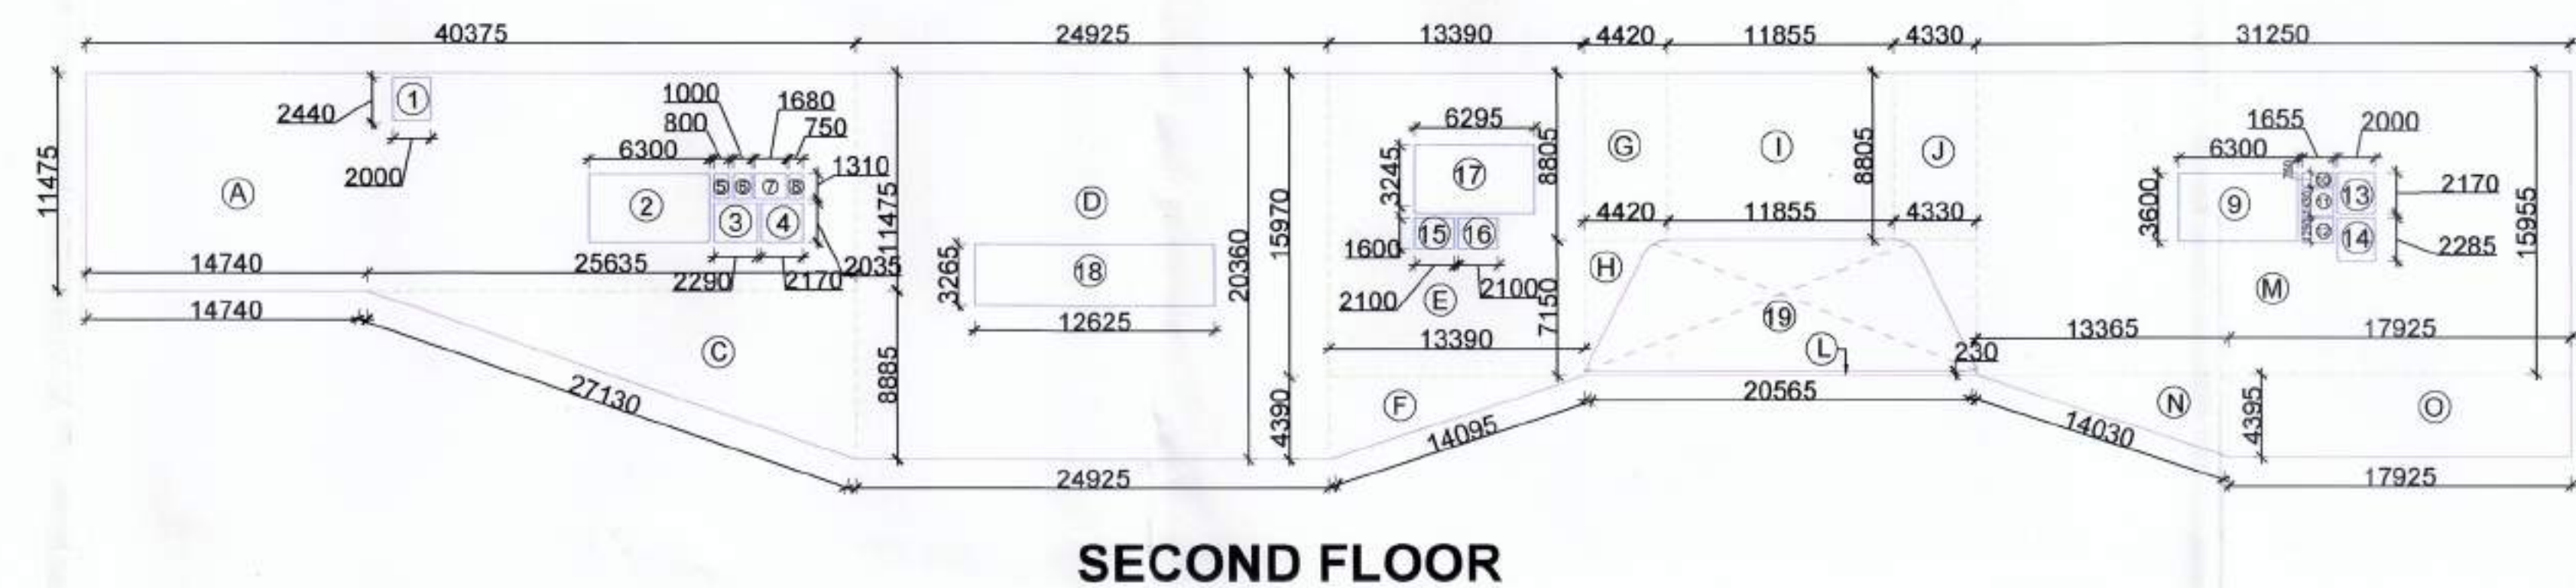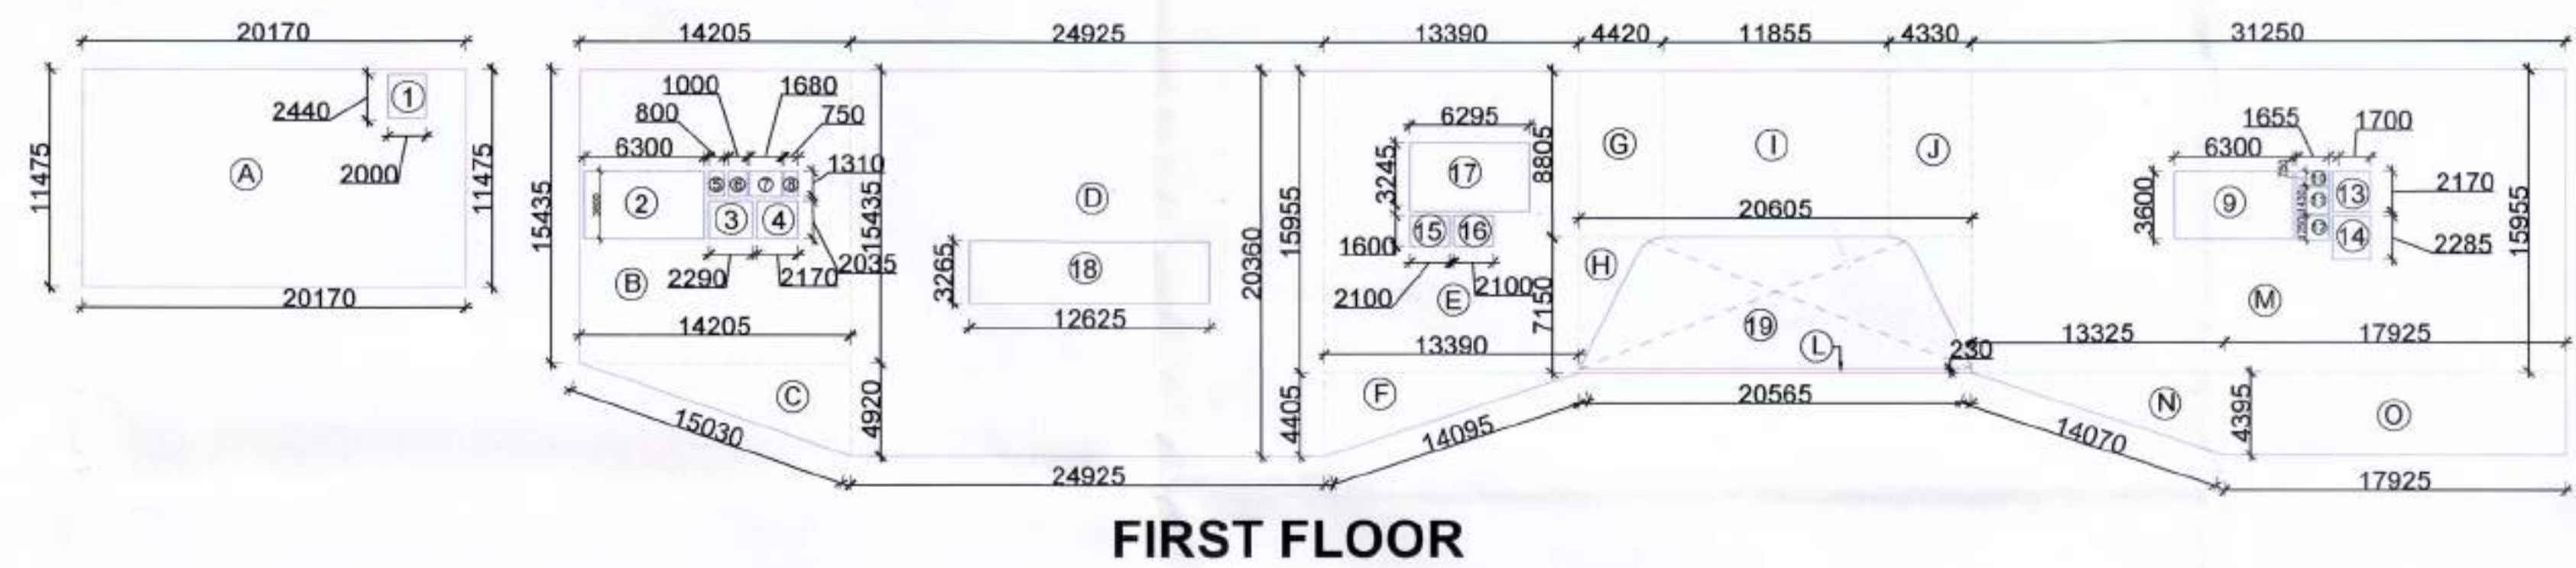

AREA CALCULATION FIRST FLOOR				
NAME	LENGTH(M)	WIDTH(M)	NO.	AREA(SQ.M)
A	20.17	11.47	1	231.95
B	14.20	15.43	1	219.11
C	14.20	4.92	0.50	34.93
D	24.92	20.36	1	507.37
E	13.39	15.95	1	213.57
F	13.39	4.40	0.50	29.46
G	4.42	8.80	1	38.90
H	20.60	7.15	1	11.89
I	11.85	8.80	1	104.28
J	4.33	8.80	1	38.10
K	20.56	10.25	1	47.73
MI	31.25	15.93	1	498.44
N	13.32	4.39	0.50	29.24
O	17.92	20.36	1	364.85
TOTAL AREA				2326.21

REDUCTION				
1	2	2.44	1	4.88
2	6.3	3.0	1	22.68
3	2.29	2.63	1	4.65
4	2.17	2.03	1	4.41
5	0.88	1.31	1	1.05
6	1	1.31	1	1.31
7	1.68	1.31	1	2.20
8	0.75	1.31	1	0.98
9	6.3	3.6	1	22.68
10	1.65	0.75	1	1.24
11	1.65	1.43	1	2.36
12	1.65	1.25	1	2.06
13	1.7	2.17	1	3.69
14	1.7	1.28	1	2.18
15	2.1	1.6	1	3.36
16	2.1	1.6	1	3.36
17	6.29	3.24	1	26.38
18	12.62	3.26	1	41.14
19	"	"	1	118.41
TOTAL NON F.A.R AREA				263.01
TOTAL F.A.R AREA				2063.20

AREA CALCULATION SECOND FLOOR				
NAME	LENGTH(M)	WIDTH(M)	NO.	AREA(SQ.M)
A	40.37	11.47	1	463.04
C	25.63	8.88	0.50	113.80
D	24.92	20.36	1	507.37
E	13.39	15.97	1	213.94
F	13.39	4.38	0.50	29.39
G	4.42	8.80	1	38.10
H	20.56	7.15	1	147.00
I	11.85	8.80	1	104.28
J	4.33	8.80	1	38.10
L	20.56	0.23	1	4.73
M	31.25	15.95	1	498.44
N	13.36	4.39	0.50	29.33
O	17.97	4.39	1	78.67
P	13.39	4.39	0.5	29.39
Q	20.40	4.39	1	90.43
R	13.32	4.39	0.5	29.24
TOTAL AREA				2415.95

REDUCTION			
1	2	2.44	1 4.88
2	6.3	3.6	1 22.68
3	2.29	2.03	1 4.65
4	2.17	2.01	1 4.41
5	0.88	1.33	1 1.65
6	1	1.33	1 1.33
7	1.68	1.32	1 2.20
8	0.75	1.31	1 0.98
9	6.3	3.6	1 22.68
10	1.65	0.75	1 1.24
11	1.65	1.43	1 2.36
12	1.65	1.25	1 2.06
13	2	2.17	1 4.34
14	2	1.28	1 2.56
15	2.1	1.6	1 3.36
16	2.1	1.6	1 3.36
17	6.29	3.24	1 20.38
18	12.62	3.26	1 41.14
19			1 118.41
TOTAL NON F.A.R AREA			264.05
TOTAL F.A.R AREA			2151.40

AREA CALCULATION THIRD FLOOR				
NAME	LENGTH(M)	WIDTH(M)	NO.	AREA(SQ.M)
A	40.37	11.47	1	463.04
B	90.17	20.35	1	1834.96
C	25.63	8.88	0.5	113.80
TOTAL AREA				2411.80

REDUCTION			
1	2	2.44	1
2	6.3	3.6	1
3	2.29	2.03	1
4	2.17	2.03	1
5	1.8	1.31	1
6	1.8	1.31	1
7	1.68	1.31	1
8	0.75	1.31	1
9	6.3	3.6	1
10	1.65	0.75	1
11	1.65	1.43	1
12	1.65	1.25	1
13	2	2.17	1
14	2	1.28	1
15	2.1	1.6	1
16	2.1	1.6	1
17	6.29	3.24	1
18	13.38	4.40	0.5
19	20.56	4.40	1
20	13.37	4.40	0.5
TOTAL NON F.A.R AREA			253.81
			2157.99

AREA CALCULATION FOURTH FLOOR				
NAME	LENGTH(M)	WIDTH(M)	NO.	AREA(SQ.M)
A	14.07	6.78	1	95.
B	2.73	7.49	1	20.45
C	2.73	0.99	0.50	1.35
D	25.06	4.40	1	110.26
E	2.25	3.66	1	8.24
F	2.25	9.74	0.50	0.83
TOTAL AREA				236.53

REDUCTION				
2	6.3	3.6	1	22.68
3	2.29	2.03	1	4.65
4	2.17	2.03	1	4.41
5	0.8	1.31	1	1.05
6	1	1.31	1	1.31
7	1.68	1.31	1	2.20
8	0.75	1.31	1	0.98
TOTAL NON F.A.R AREA				37.28
TOTAL F.A.R AREA				199.25

AD (HQ) (10) STP (10) STP (10) CTP (10)

Member Secretary Member Chairman

BPC BPC BPC

JD H ATP

Ram Avtar Bassi
AD(HQ)

Deputy Director (T)
O/o Directorate Fire Service
Member B.P.C.

CLIENT:	NAVI ESTATES, LLP NEW DELHI
---------	--------------------------------

REVISION SCHEDULE:

SNO	NOTES	DATED

ARCHITECT SIG:



Khushbhina Bansal

OWNER SIG:

Vijay K Patel


BUILDING TYPE:	COMMERCIAL
----------------	------------

GENERAL NOTES:
1. All dimensions are in MM
2. Only written dimensions should be followed
3. All dimensions should be checked and verified before execution. Inconsistency if any should be brought to the notice of the architect

DRAWING NO: AREA CALCULATION
FIRST FLOOR TO FOURTH FLOOR


DRAWING NO: AR-AS-02	DATE: 01/08/2019
-------------------------	---------------------

SCALE: AS SPECIFIED	NORTH: 
----------------------------	---

 
 **STHAPATI**
ASSOCIATES (P) LTD.
architects, interior designers,
landscape consultants,
& project consultants.

Lucknow Studio: 1/24, Vipul Khand, Gomti Nagar, Lucknow
Ph no. 0522 - 4027793


Delhi Studio: T - 34/ 702, Common Wealth Games Village,
Delhi - 110092
Ph no. 011 - 21211409

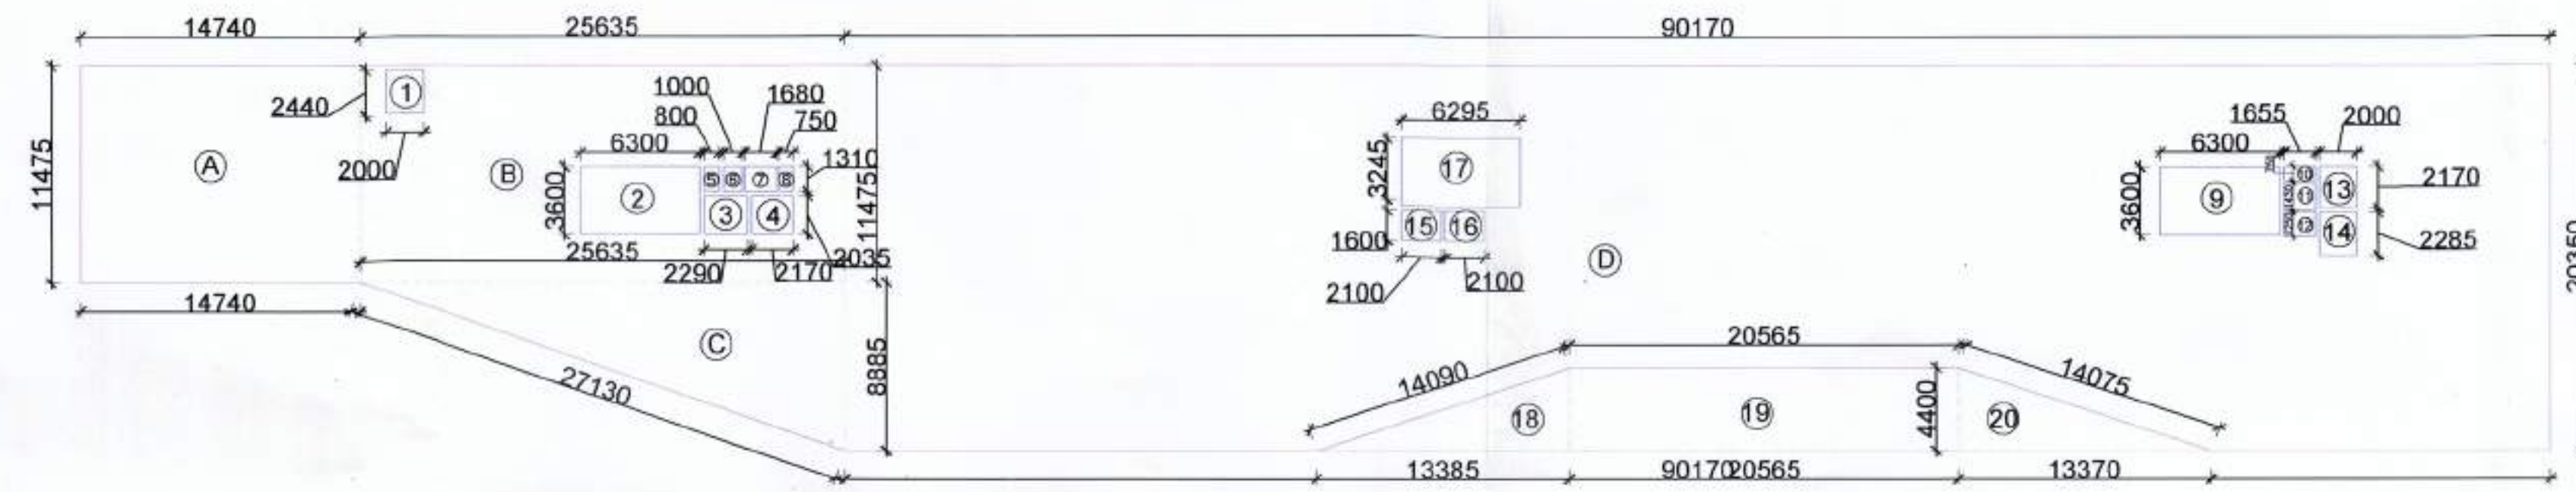


FIFTH FLOOR

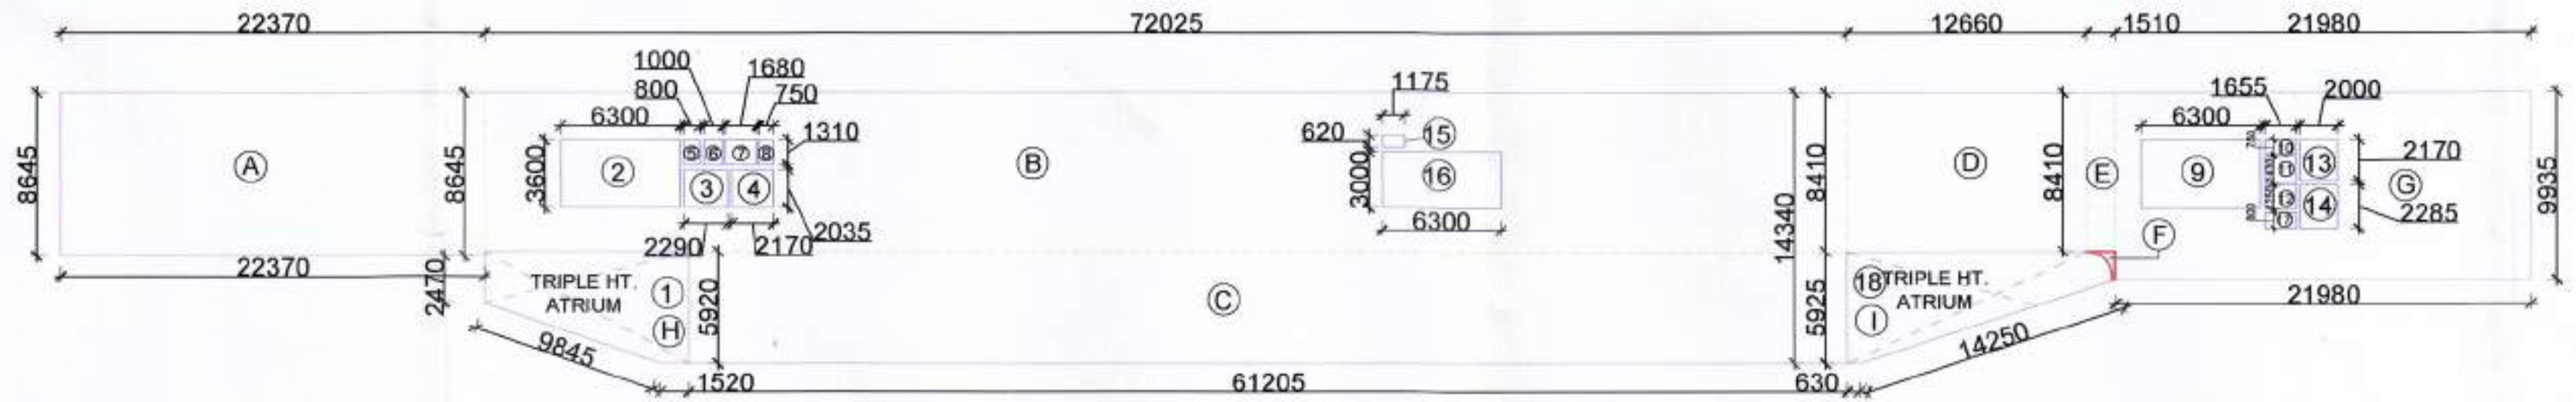

SIXTH FLOOR

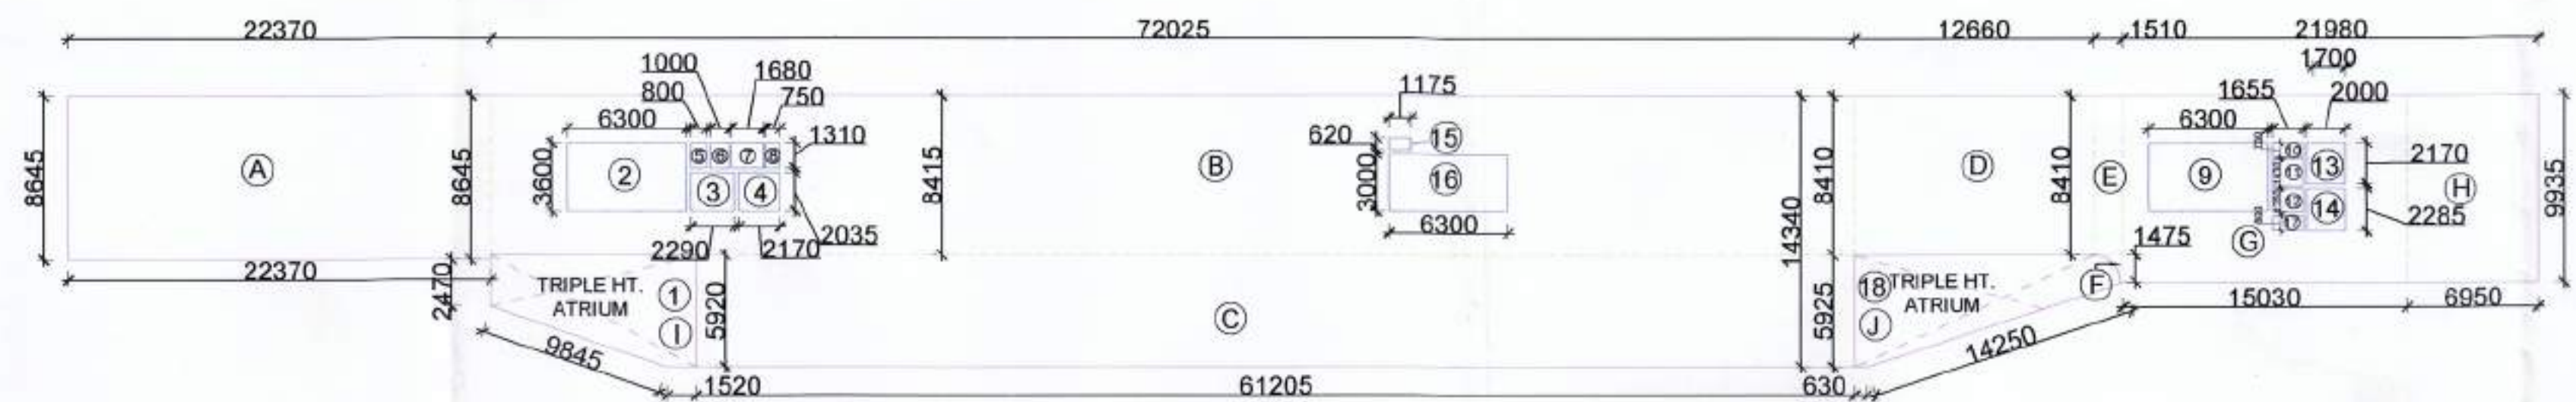

SEVENTH FLOOR

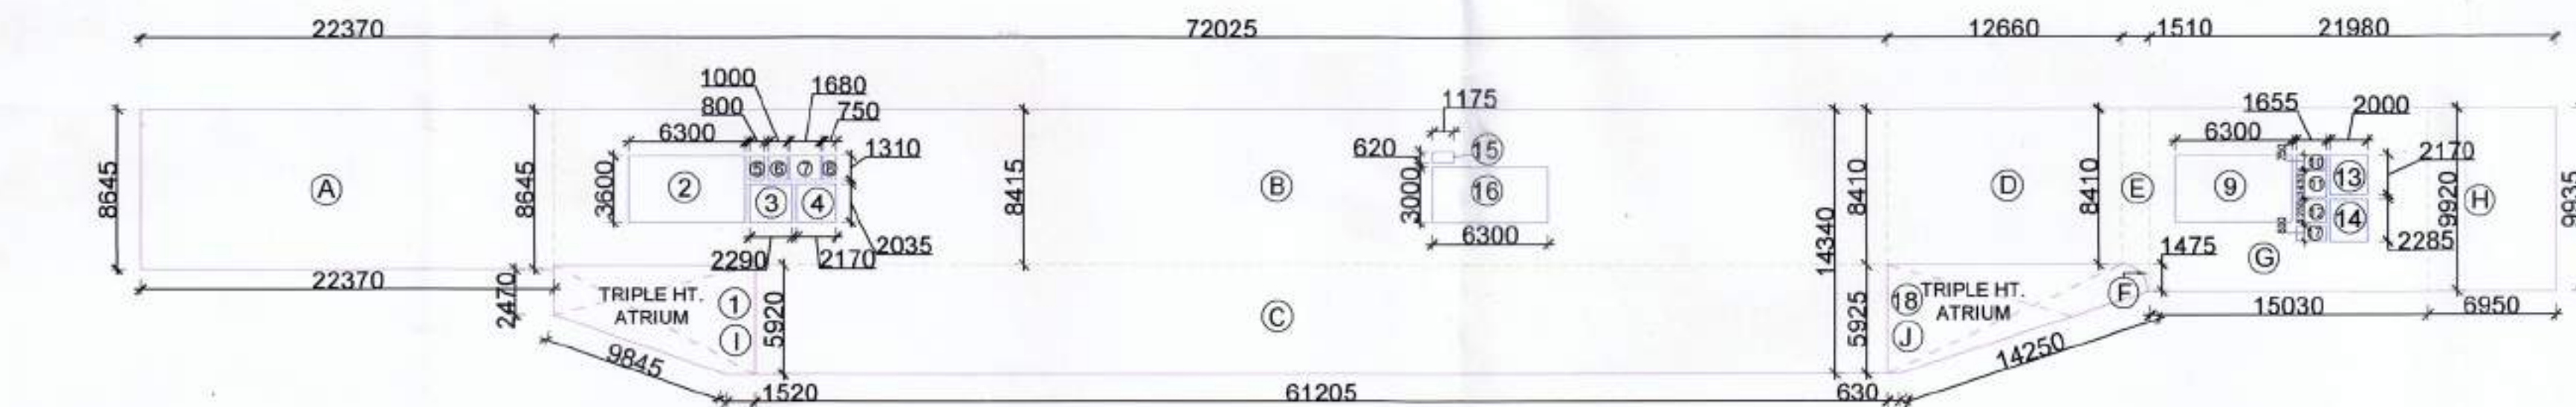

EIGHTH FLOOR

AREA CALCULATION FIFTH FLOOR				
NAME	LENGTH(M)	WIDTH(M)	NO.	AREA(SQ.M)
A	14.74	11.47	1	169.07
B	25.63	11.47	1	293.98
C	25.63	8.88	0.5	113.80
D	90.17	20.35	1	1834.96
TOTAL AREA				2411.80
REDUCTION				
1	2	2.44	1	4.88
2	6.3	3.6	1	22.68
3	2.29	2.03	1	4.65
4	2.17	2.03	1	4.41
5	0.8	1.31	1	1.05
6	1	1.31	1	1.31
7	1.68	1.31	1	2.20
8	0.75	1.31	1	0.98
9	6.3	3.6	1	22.68
10	1.65	0.75	1	1.24
11	1.65	1.43	1	2.36
12	1.65	1.25	1	2.06
13	2	2.17	1	4.34
14	2	1.28	1	2.56
15	2.1	1.6	1	3.36
16	2.1	1.6	1	3.36
17	6.29	3.24	1	20.38
TOTAL NON F.A.R AREA				104.49
TOTAL F.A.R AREA				2307.31

AREA CALCULATION SIXTH FLOOR				
NAME	LENGTH(M)	WIDTH(M)	NO.	AREA(SQ.M)
A	22.37	8.64	1	193.28
B	72.02	8.64	1	622.25
C	61.21	5.92	1	362.36
D	12.66	8.41	1	106.47
E	1.51	8.41	1	12.70
F	-	-	1	0.62
G	21.98	9.93	1	218.26
H	-	-	1	49.03
I	-	-	1	53.15
TOTAL AREA				1618.12
REDUCTION				
1	-	-	1	49.03
2	6.3	3.6	1	22.68
3	2.29	2.03	1	4.65
4	2.17	2.03	1	4.41
5	0.8	1.31	1	1.05
6	1	1.31	1	1.31
7	1.68	1.31	1	2.20
8	0.75	1.31	1	0.98
9	6.3	3.6	1	22.68
10	1.65	0.75	1	1.24
11	1.65	1.43	1	2.36
12	1.65	1.25	1	2.06
13	2	2.17	1	4.34
14	2	1.28	1	2.56
15	1.17	0.62	1	0.73
16	6.3	3	1	18.90
17	1.65	0.8	1	1.32
18	-	-	1	53.15
TOTAL NON F.A.R AREA				146.61
TOTAL F.A.R AREA				1471.51

AREA CALCULATION SEVENTH FLOOR				
NAME	LENGTH(M)	WIDTH(M)	NO.	AREA(SQ.M)
A	22.37	8.64	1	193.28
B	72.02	8.64	1	622.25
C	61.21	5.92	1	362.36
D	12.66	8.41	1	106.47
E	1.51	8.41	1	12.70
F	-	-	1	0.62
G	15.03	9.92	1	149.10
H	6.95	9.94	1	69.06
I	-	-	1	49.03
J	-	-	1	53.15
TOTAL AREA				1618.02
REDUCTION				
1	-	-	1	49.03
2	6.3	3.6	1	22.68
3	2.29	2.03	1	4.65
4	2.17	2.03	1	4.41
5	0.8	1.31	1	1.05
6	1	1.31	1	1.31
7	1.68	1.31	1	2.20
8	0.75	1.31	1	0.98
9	6.3	3.6	1	22.68
10	1.65	0.75	1	1.24
11	1.65	1.43	1	2.36
12	1.65	1.25	1	2.06
13	2	2.17	1	4.34
14	2	1.28	1	2.56
15	1.17	0.62	1	0.73
16	6.3	3	1	18.90
17	1.65	0.8	1	1.32
18	-	-	1	53.15
TOTAL NON F.A.R AREA				146.61
TOTAL F.A.R AREA				1471.41

AREA CALCULATION EIGHTH FLOOR				
NAME	LENGTH(M)	WIDTH(M)	NO.	AREA(SQ.M)
A	22.37	8.64	1	193.28
B	72.02	8.64	1	622.25
C	61.21	5.92	1	362.36
D	12.66	8.41	1	106.47
E	1.51	8.41	1	12.70
F	-	-	1	0.62
G	15.03	9.92	1	149.10
H	6.95	9.94	1	69.06
I	-	-	1	49.03
J	-	-	1	53.15
TOTAL AREA				1548.30
REDUCTION				
1	-	-	1	49.03
2	6.3	3.6	1	22.68
3	2.29	2.03	1	4.6487
4	2.17	2.03	1	4.4051
5	0.8	1.31	1	1.048
6	1	1.31	1	1.31
7	1.68	1.31	1	2.2008
8	0.75	1.31	1	0.9825
9	6.3	3.6	1	22.68
10	1.65	0.75	1	1.2375
11	1.65	1.43	1	2.3595
12	1.65	1.25	1	2.0625
13	2	2.17	1	4.34
14	2	1.28	1	2.56
15	1.17	0.62	1	0.7254
16	6.3	3	1	18.9
17	1.65	0.8	1	1.32
18	-	-	1	53.15
TOTAL NON F.A.R AREA				146.61
TOTAL F.A.R AREA				1499.27

PROJECT:

COMMERCIAL COLONY AREA MEASURING 2.625 ACRES IN SECTOR 34, SOHNA BEING DEVELOPED BY SMT. MONIKA RAIZADA W/O SH. NAVEEN RIZADA IN COLLABORATION WITH NAVI ESTATES LLP.

CLIENT: NAVI ESTATES, LLP
NEW DELHI

REVISION SCHEDULE:

SNO	NOTES	DATED

ARCHITECT SIG:



OWNER SIG:

BUILDING TYPE: COMMERCIAL

GENERAL NOTES:

1. All dimensions are in MM
2. Only written dimensions should be followed
3. All dimensions should be checked and verified before execution/inconsistency if any should be brought to the notice of the architect.

DRAWING NO: AREA CALCULATION
FIFTH FLOOR TO EIGHTH FLOOR


DRAWING NO: AR-AS-03

DATE: 01/08/2019

SCALE:


AS SPECIFIED

NORTH:

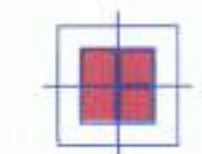


STHAPATI ASSOCIATES (P) LTD.
architects, interior designers,
landscape consultants,
& project consultants.

Lucknow Studio: 1/24, Vipul Khand, Gomti Nagar, Lucknow
Ph no. 0522 - 4027793
T - 34/ 702, Common Wealth Games Village,
Delhi - 110092
Ph no. 011 - 21211409

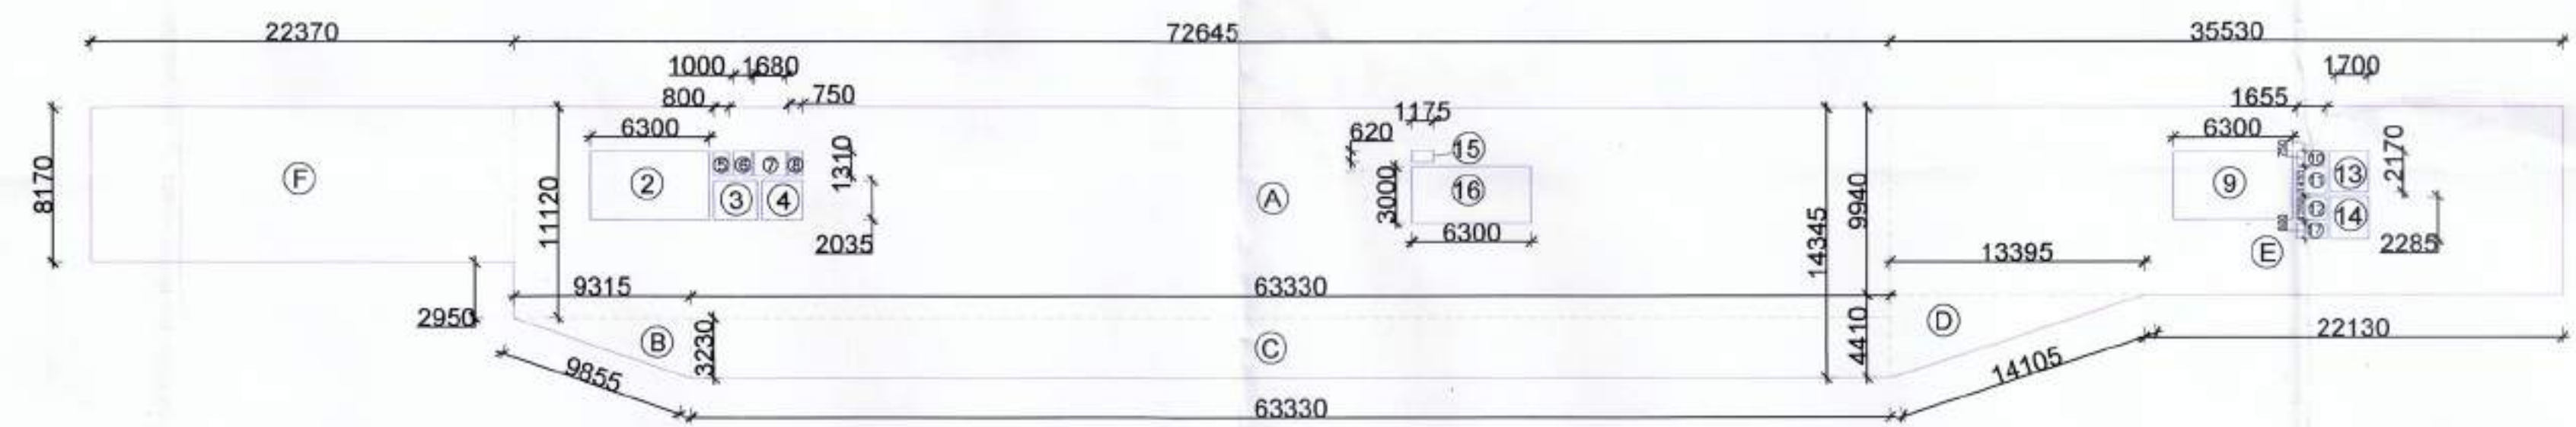


NINTH FLOOR

AREA CALCULATION NINTH FLOOR				
NAME	LENGTH(M)	WIDTH(M)	NO.	AREA(SQ.M)
A	72.64	11.12	1	807.76
B	9.31	3.23	0.5	15.04
C	63.33	3.23	1	204.56
D	13.39	4.41	0.5	29.52
E	35.53	9.94	1	353.17
F	22.37	8.17	1	182.76
TOTAL AREA				1592.80
REDUCTION				
2	6.3	3.6	1	22.68
3	2.29	2.03	1	4.65
4	2.17	2.03	1	4.41
5	0.8	1.31	1	1.05
6	1	1.31	1	1.31
7	1.68	1.31	1	2.20
8	0.75	1.31	1	0.98
9	6.3	3.6	1	22.68
10	1.65	0.75	1	1.24
11	1.65	1.43	1	2.36
12	1.65	1.25	1	2.06
13	2	2.17	1	4.34
14	2	1.28	1	2.56
15	1.17	0.62	1	0.73
16	6.3	3	1	18.90
17	1.65	0.8	1	1.32
TOTAL NON F.A.R AREA				93.46
TOTAL F.A.R AREA				1499.34

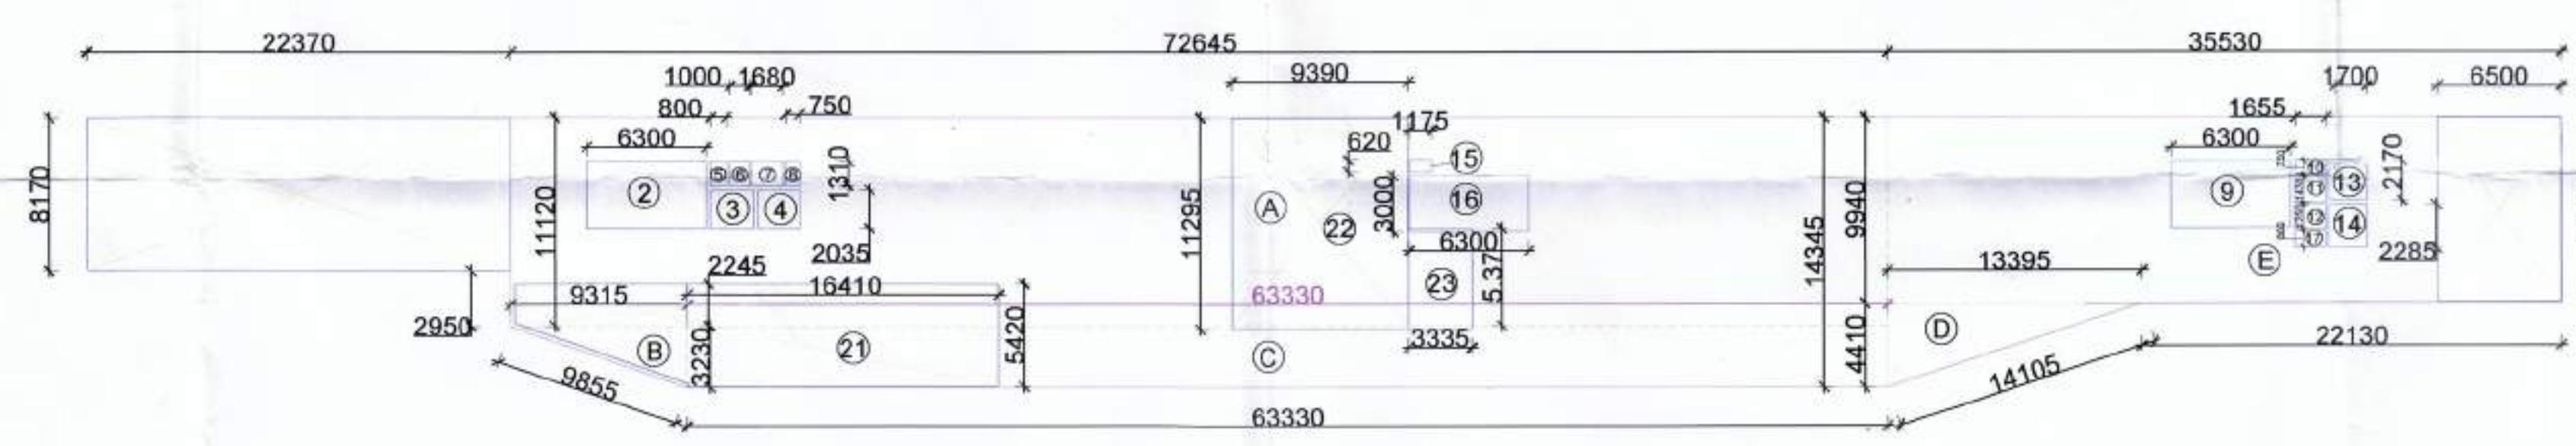

TENTH FLOOR

AREA CALCULATION TENTH FLOOR				
NAME	LENGTH(M)	WIDTH(M)	NO.	AREA(SQ.M)
A	72.64	11.12	1	807.76
B	9.35	3.24	0.5	15.15
C	63.33	3.23	1	204.56
D	13.39	3.42	0.5	17.77
E	35.53	9.94	1	353.15
TOTAL AREA				1488.19
REDUCTION				
2	6.3	3.6	1	22.68
3	2.29	2.03	1	4.687
4	2.17	2.03	1	4.4051
5	0.8	1.31	1	1.048
6	1	1.31	1	1.31
7	1.68	1.31	1	2.2008
8	0.75	1.31	1	0.9825
9	6.3	3.6	1	22.68
10	1.65	0.75	1	1.2375
11	1.65	1.43	1	2.3695
12	1.65	1.25	1	2.0625
13	2	2.17	1	4.34
14	2	1.28	1	2.56
15	1.17	0.62	1	0.7254
16	6.3	3	1	18.9
17	1.65	0.8	1	1.32
TOTAL NON F.A.R AREA				93.45
TOTAL F.A.R AREA				993.74

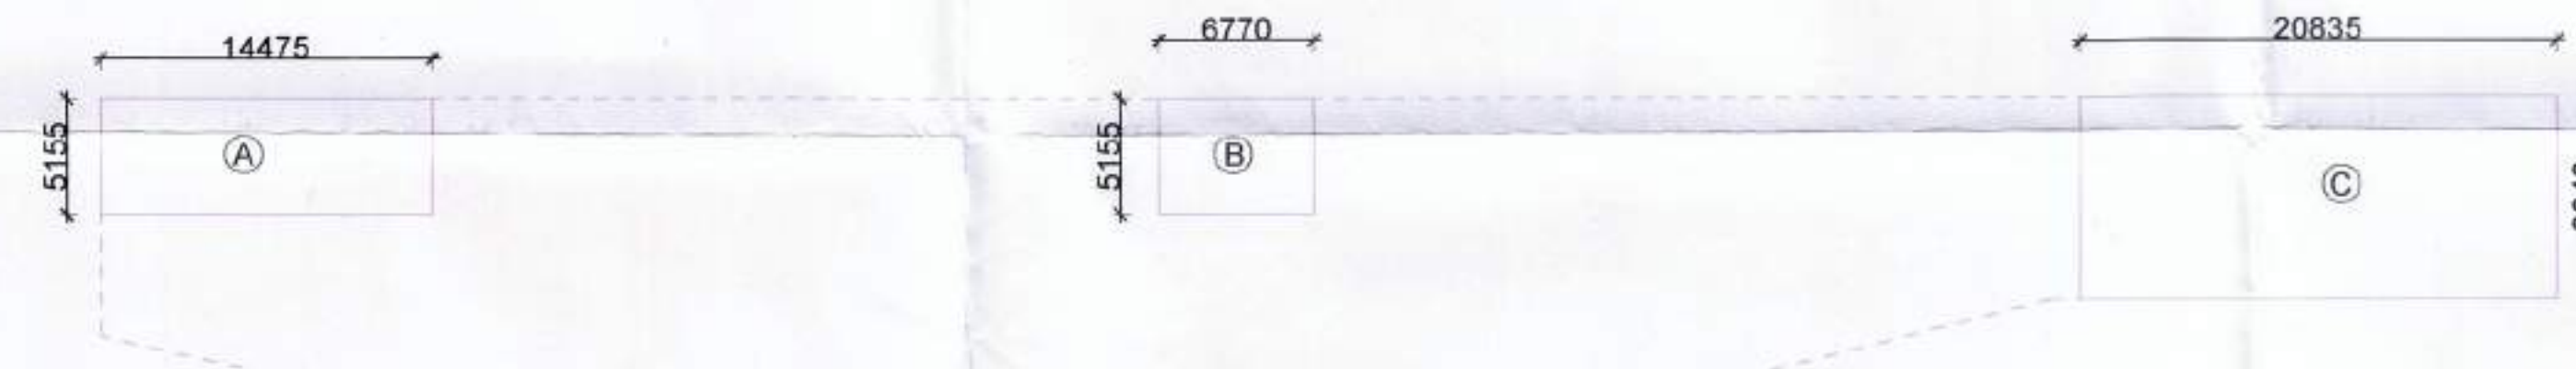

TERRACE PLAN

AREA CALCULATION TERRACE FLOOR				
NAME	LENGTH(M)	WIDTH(M)	NO.	AREA(SQ.M)
A	14.48	5.15	1	74.57
B	6.77	5.16	1	34.93
C	20.83	8.94	1	186.22
TOTAL F.A.R AREA				295.73

STP
Monitor Secretary
BPC

CTP
Chairman
BPC

ATP

Ram Avtar Bassi
AD(HQ)

Deputy Director (T)
City Directorate Fire Services
Member B.P.C.

PROJECT:
COMMERCIAL COLONY AREA MEASURING
2.625 ACRES IN SECTOR 34, SOHNA BEING
DEVELOP BY SMT. MONIKA RAIZADA W/O SH.
NAVEEN RIZADA IN COLLABORATION WITH
NAVI ESTATES LLP.

CLIENT: NAVI ESTATES, LLP
NEW DELHI

REVISION SCHEDULE:		
SNO	NOTES	DATED

ARCHITECT SIG:

OWNER SIG:

BUILDING TYPE: COMMERCIAL

GENERAL NOTES:
1. All dimensions are in MM
2. Only written dimensions should be followed.
3. All dimensions should be checked and verified before execution/inconsistency if any should be brought to the notice of the architect.

DRAWING NO: AREA CALCULATION
NINTH, TENTH & TERRACE FLOOR

DRAWING NO: AR-AS-04 DATE: 01/08/2019

SCALE: AS SPECIFIED NORTH:

STHAPATI
ASSOCIATES (P) LTD.
architects,interior designers,
landscape consultants,
& project consultants.

Lucknow Studio: 1/24, Vipul Khand, Gomti Nagar, Lucknow
Ph no.0522 - 4027793
Delhi Studio: T - 34/ 702, Common Wealth Games Village,
Delhi - 110092
Ph no. 011 - 21211409