



SCHEDULE OF OPENINGS					
S.NO.	TYPE	WIDTH	HEIGHT	DATE	REMARKS
1	DOOR	1000	2100	11/12/2017	DOOR TO STAIRS
2	WINDOW	1500	1800	11/12/2017	WINDOW TO STAIRS
3	DOOR	1000	2100	11/12/2017	DOOR TO STAIRS
4	DOOR	1000	2100	11/12/2017	DOOR TO STAIRS

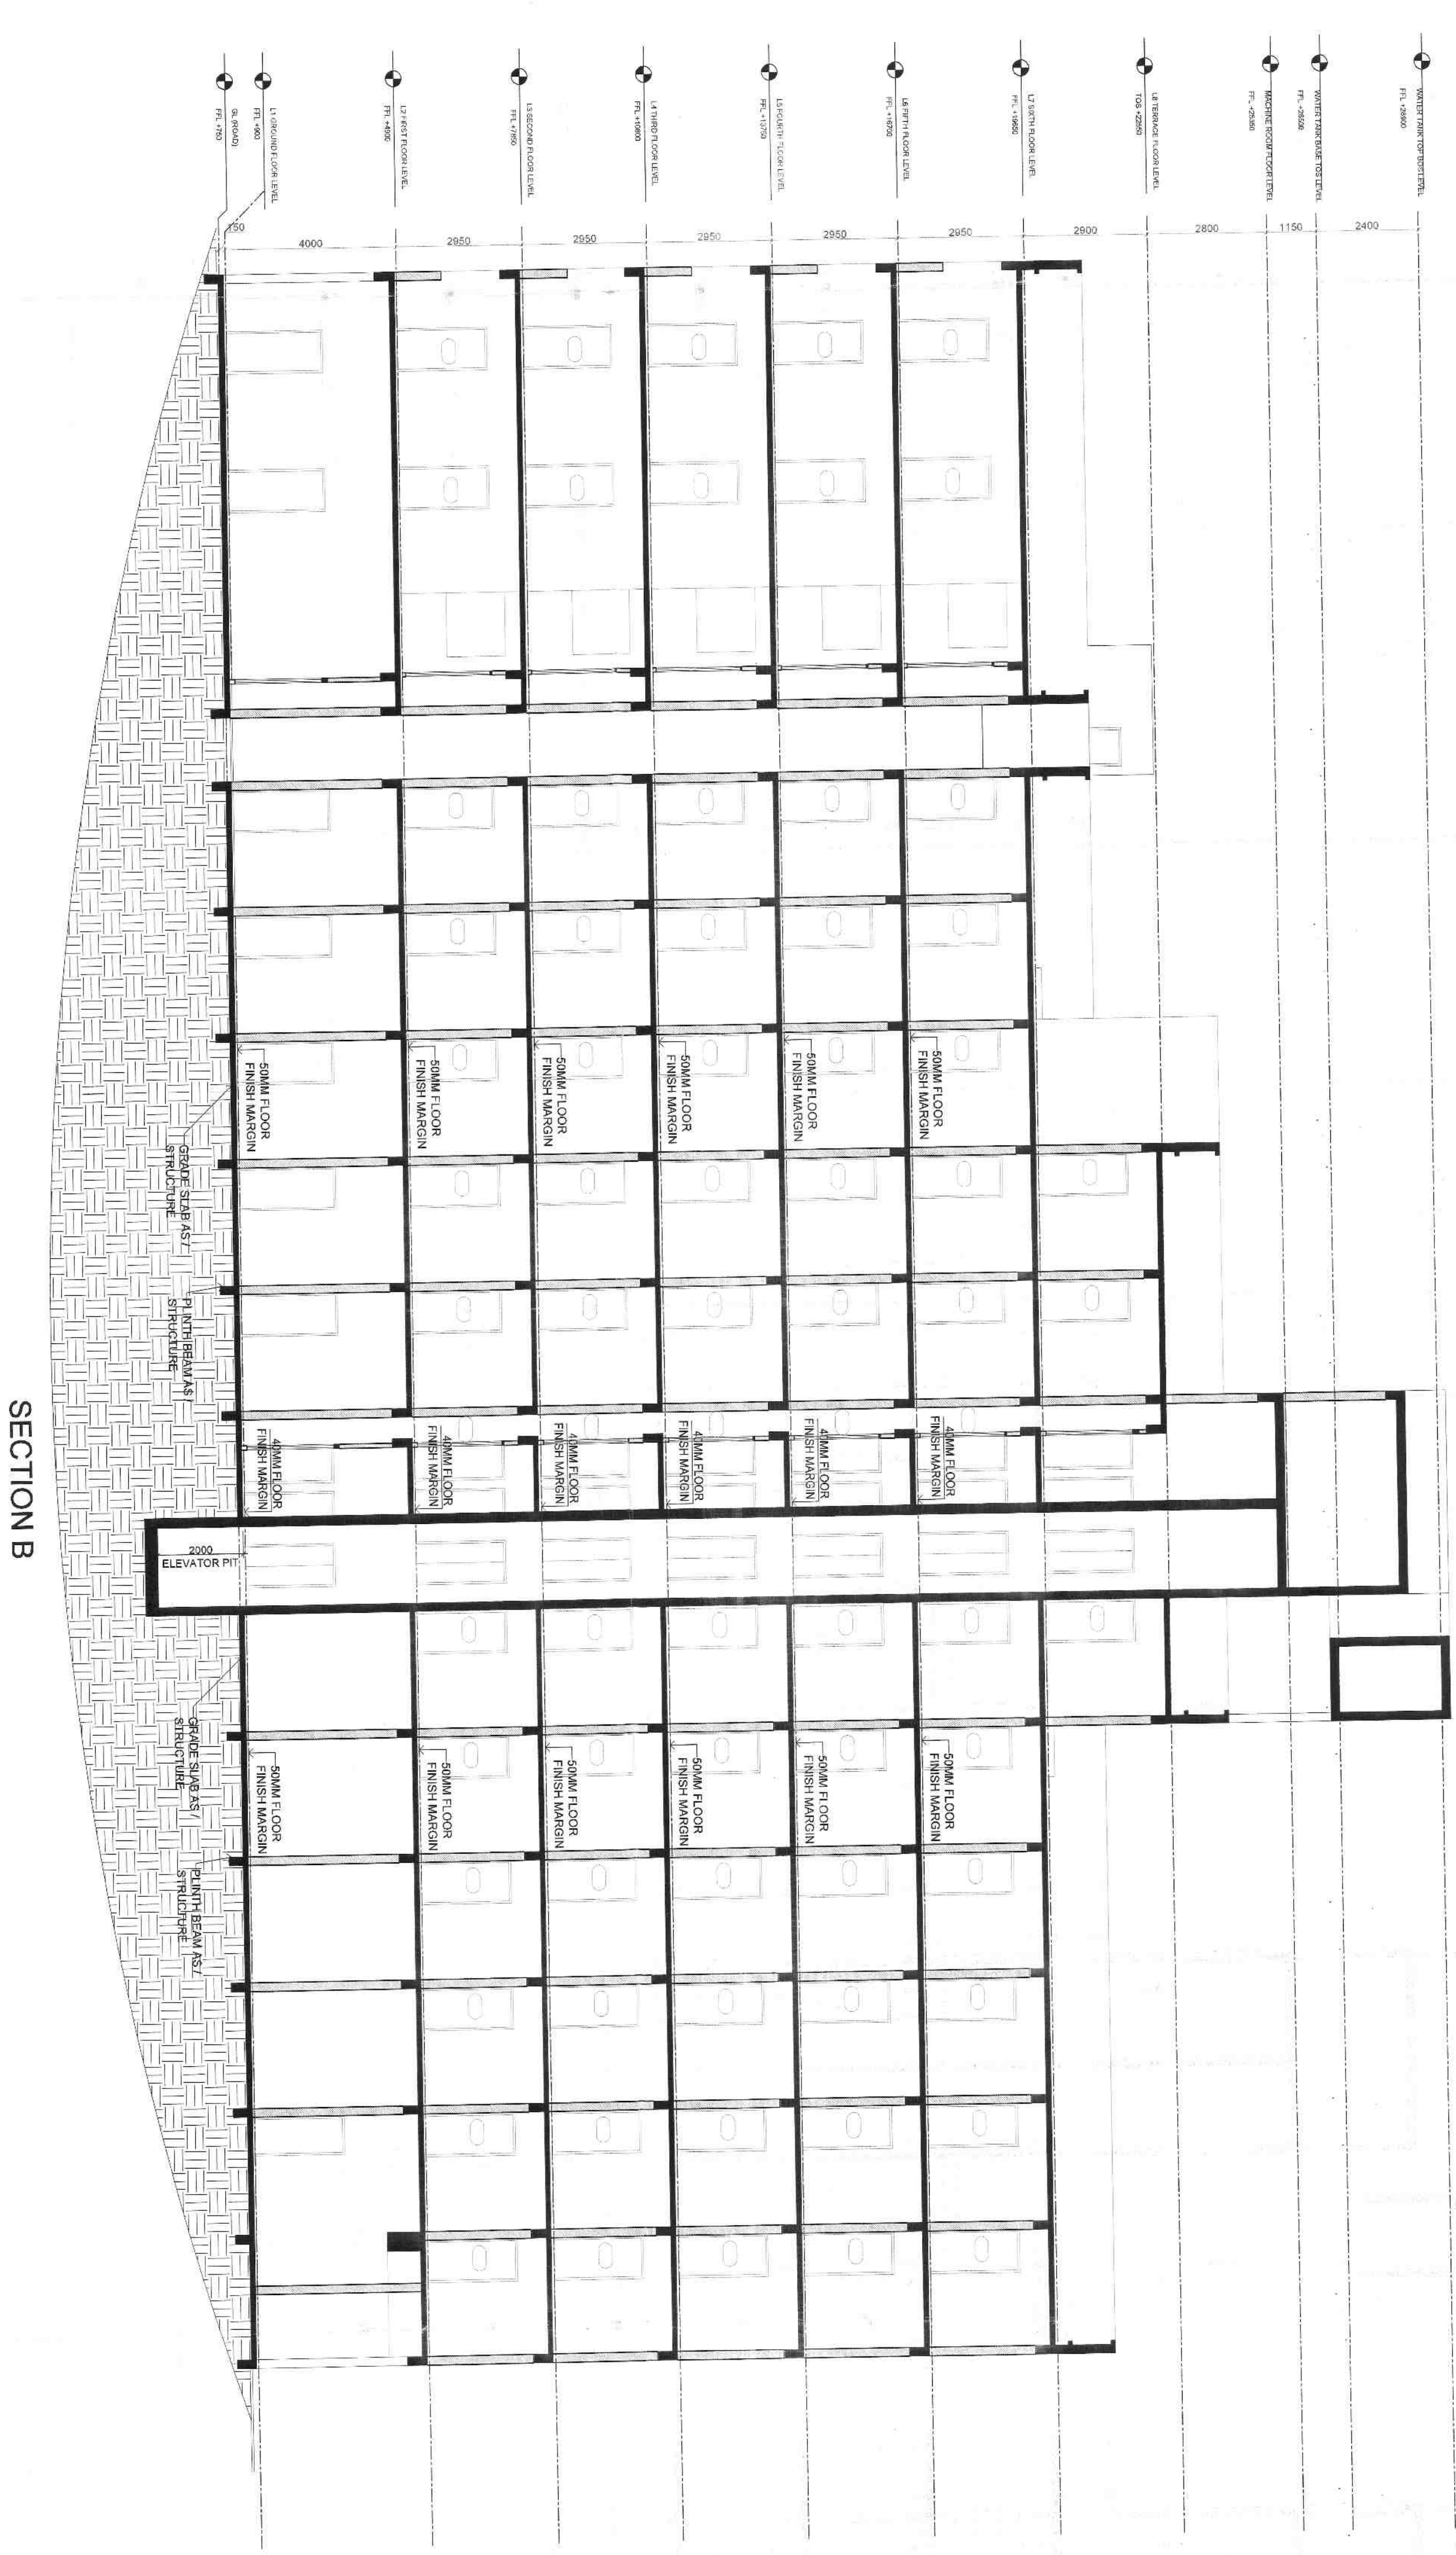

SECTION B

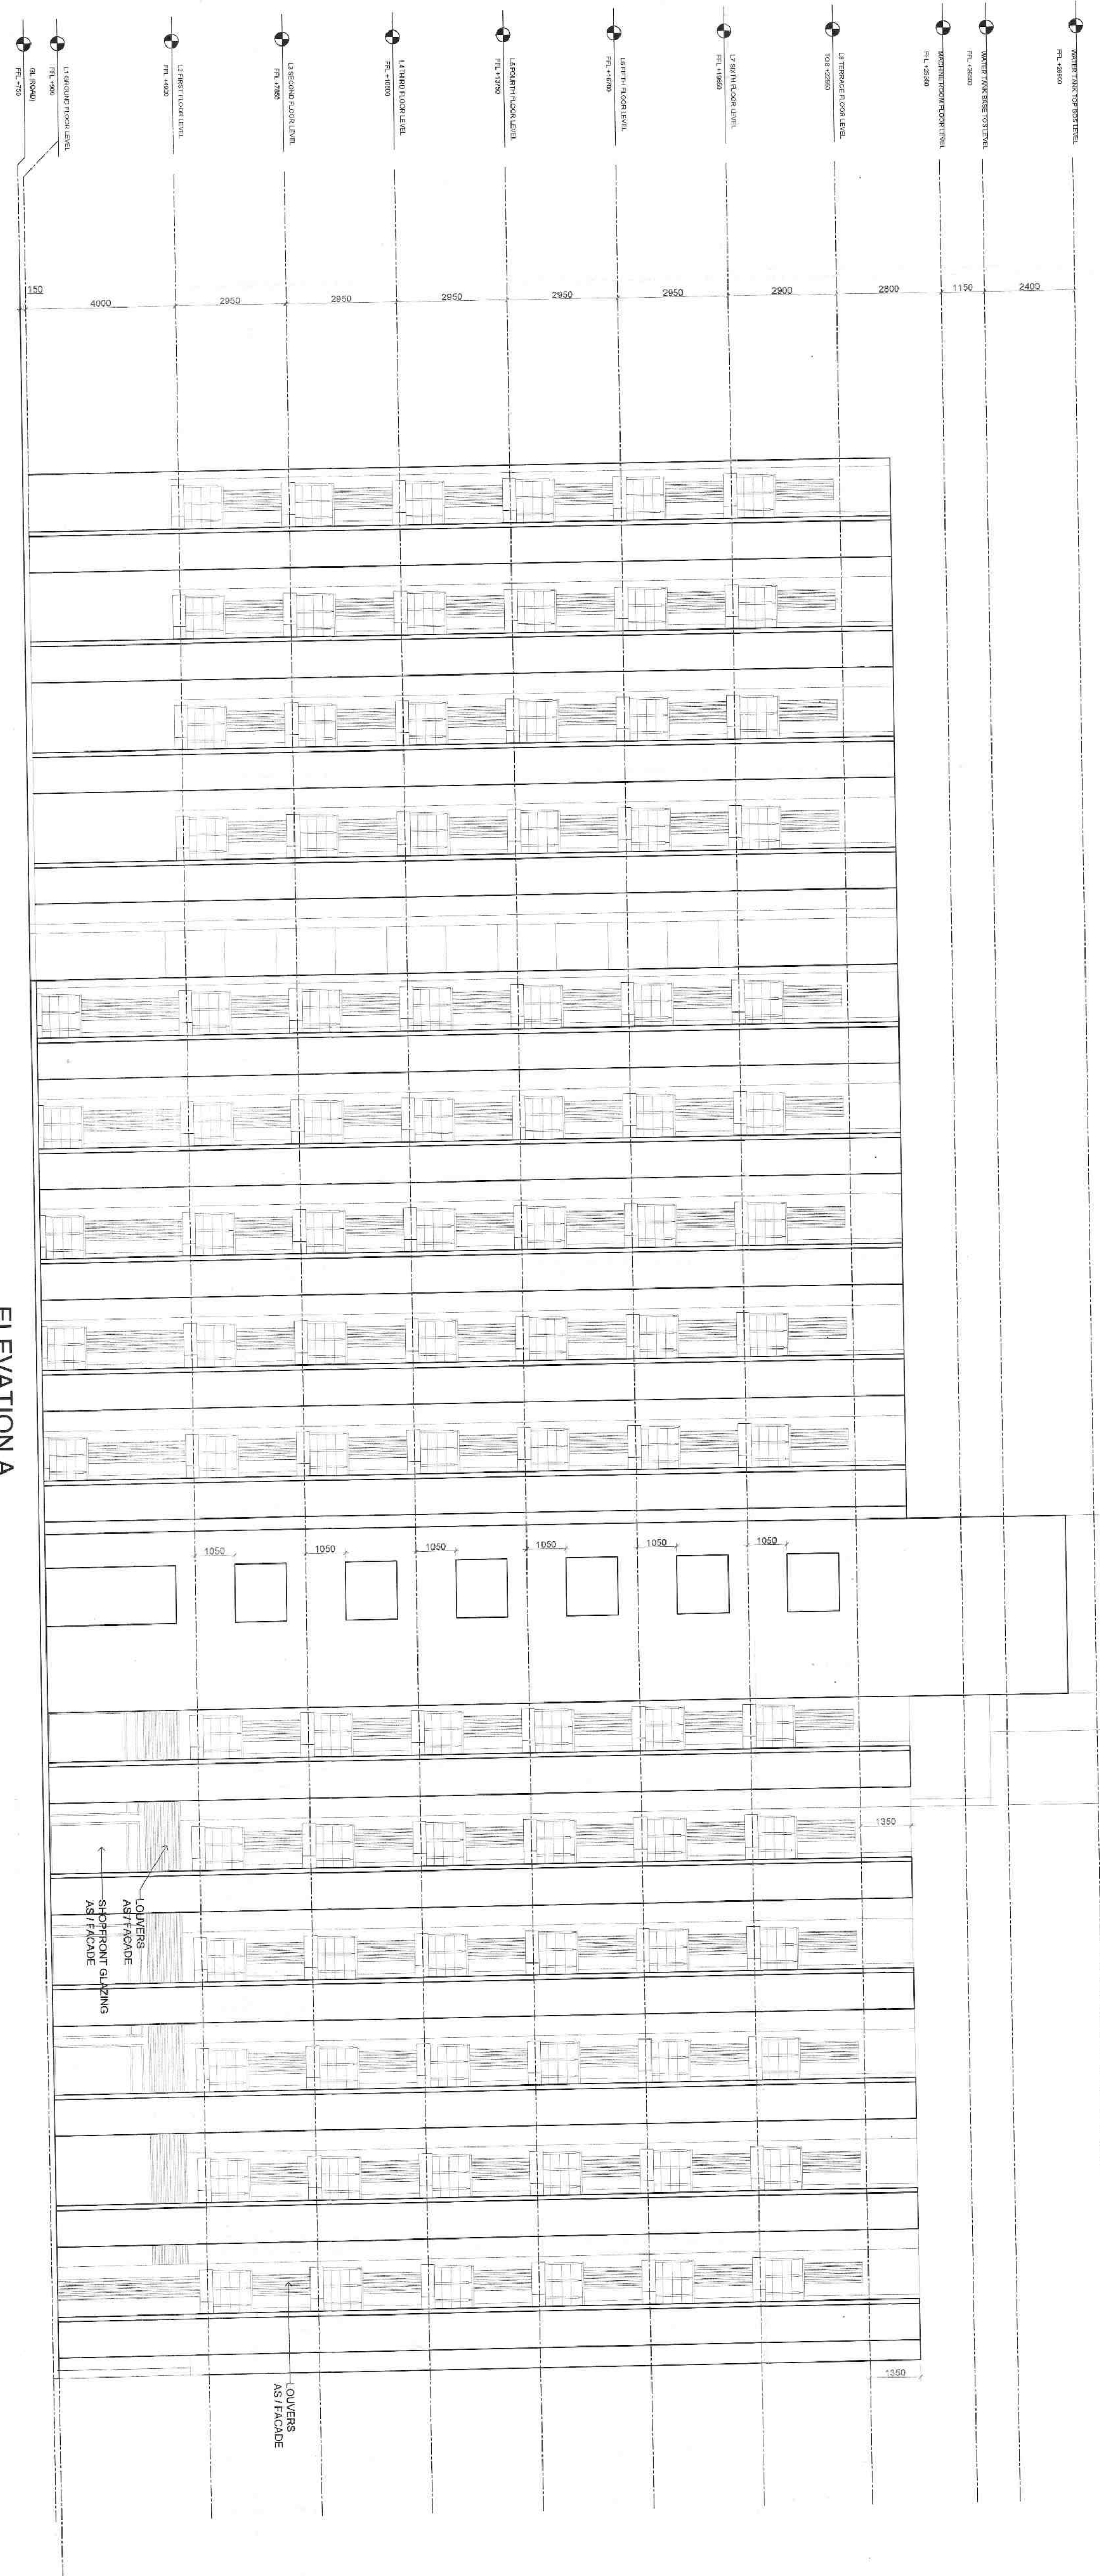

ELEVATION A

PLUMBING LEGEND

S.NO	SYMBOL	DESCRIPTION
1	①	110 OD SOIL & VENT PIPE
2	②	110 OD WASTE & VENT PIPE (COLLECT)
3	③	80 OD ANTIPHONAGE PIPE
4	④	COLD WATER SUPPLY
5	⑤	FLUSHING WATER SUPPLY
6	⑥	160 OD RAIN WATER PIPE (TERRACE)
7	⑦	DOMESTIC WATER SUPPLY RISER
8	⑧	FLUSHING WATER SUPPLY RISER
9	⑨	110 OD RAIN WATER PIPE (BALCONY)
10	⑩	FLOOR DRAIN OF BALCONY
11	⑪	AC DRAIN DRAIN OF BALCONY
12	⑫	HOT WATER RETURN
13	⑬	CLEAN OUT FLUG
14	⑭	CLEAN OUT FLUG

PROJECT :-
GROUP HOUSING SCHEME, KARUNGA
DATED 11.12.2017, 1.8.875 ACRES LICENCE NO.
85 OF 2012 DATED 28.8.2012 AND 1.86976
ACRES LICENCE NO. 86 OF 2012 DATED
28.8.2012
TOTAL 21.04375 ACRES IN SECTION-112 & 113,
GURUGRAM MANESAR URBAN COMPLEX, 12, BEHIND
SH. NAWATI SO SH. S.P. GUPTA, A.N.
BUDWELL PVT. LTD. AND OTHERS.

DRG TITLE :-
CONVENIENT SHOPPING & EWS
ELEVATION & SECTION

REVISION	JOB NO. :-	DRG NO. :-	DATE :-
1	BEWS-102	11/12/2017	08-SEP-15

SCALE :-
1:100

DATE :-
08-SEP-15

FILE :-
BEWS-102

BY :-
[Signature]

CHECKED APPROVED

SIGNATURE & SEAL OF ARCHITECT :-
[Signature]

SIGNATURE & SEAL OF OWNER :-
[Signature]

CSN ENGINEERING