



- Notes
1. ALL LIFTS SHALL HAVE 100% POWER BACK-UP
 2. ALL ELECTRICAL INSTALLATIONS SHALL BE AS PER PROVISIONS OF NBC.
 3. ALL FIRE FIGHTING EQUIPMENTS SHALL BE AS PER RELEVANT NBC PROVISIONS.
 4. BUILDING STRUCTURE DESIGNED EARTH QUAKE RESISTANT.
 5. BUILDING STRUCTURE DESIGNED EARTH QUAKE DESIGN.
 6. PLOT BOUNDARY
 7. PLOT BOUNDARY
 8. PLOT BOUNDARY
 9. KITCHEN & TOILET EXHAUST FANS PROVIDED MECHANICALLY LIFT & VENTILATED.
 10. MECHANICALLY LIFT & VENTILATED.
 11. SERVICES LAYOUT SHEET SYSTEM SHALL BE PROVIDED AS PER GREEN WORKING.

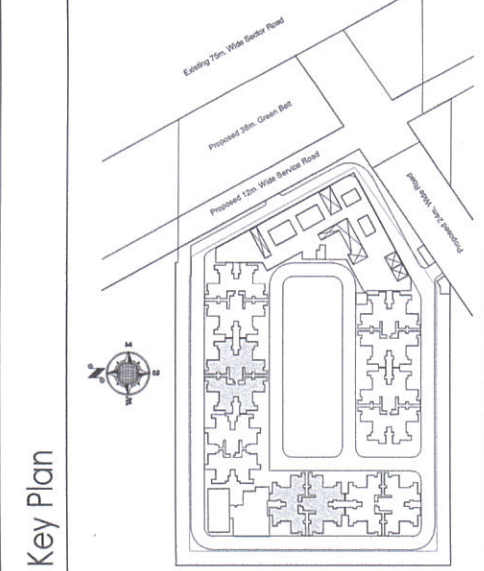


Owner's Signature

Architect's Signature


Client	M/S PRIME INFRA DEVELOPERS PRIVATE LIMITED
Architect	AIICOP ASSOCIATES PVT. LTD.
Project Name	Proposed Building Plan of Affordable Group Housing Complex and Industrial Area at Sector 99A, Gurgaon, Haryana being developed by Prime Infra Developer Private Limited.
Drawing Title	TOWER A3 A7 SECTIONS
Drawing No.	2020/01
Checked	A-16
Drawn	Scale
Date	28.11.2020
Sheet No.	1100

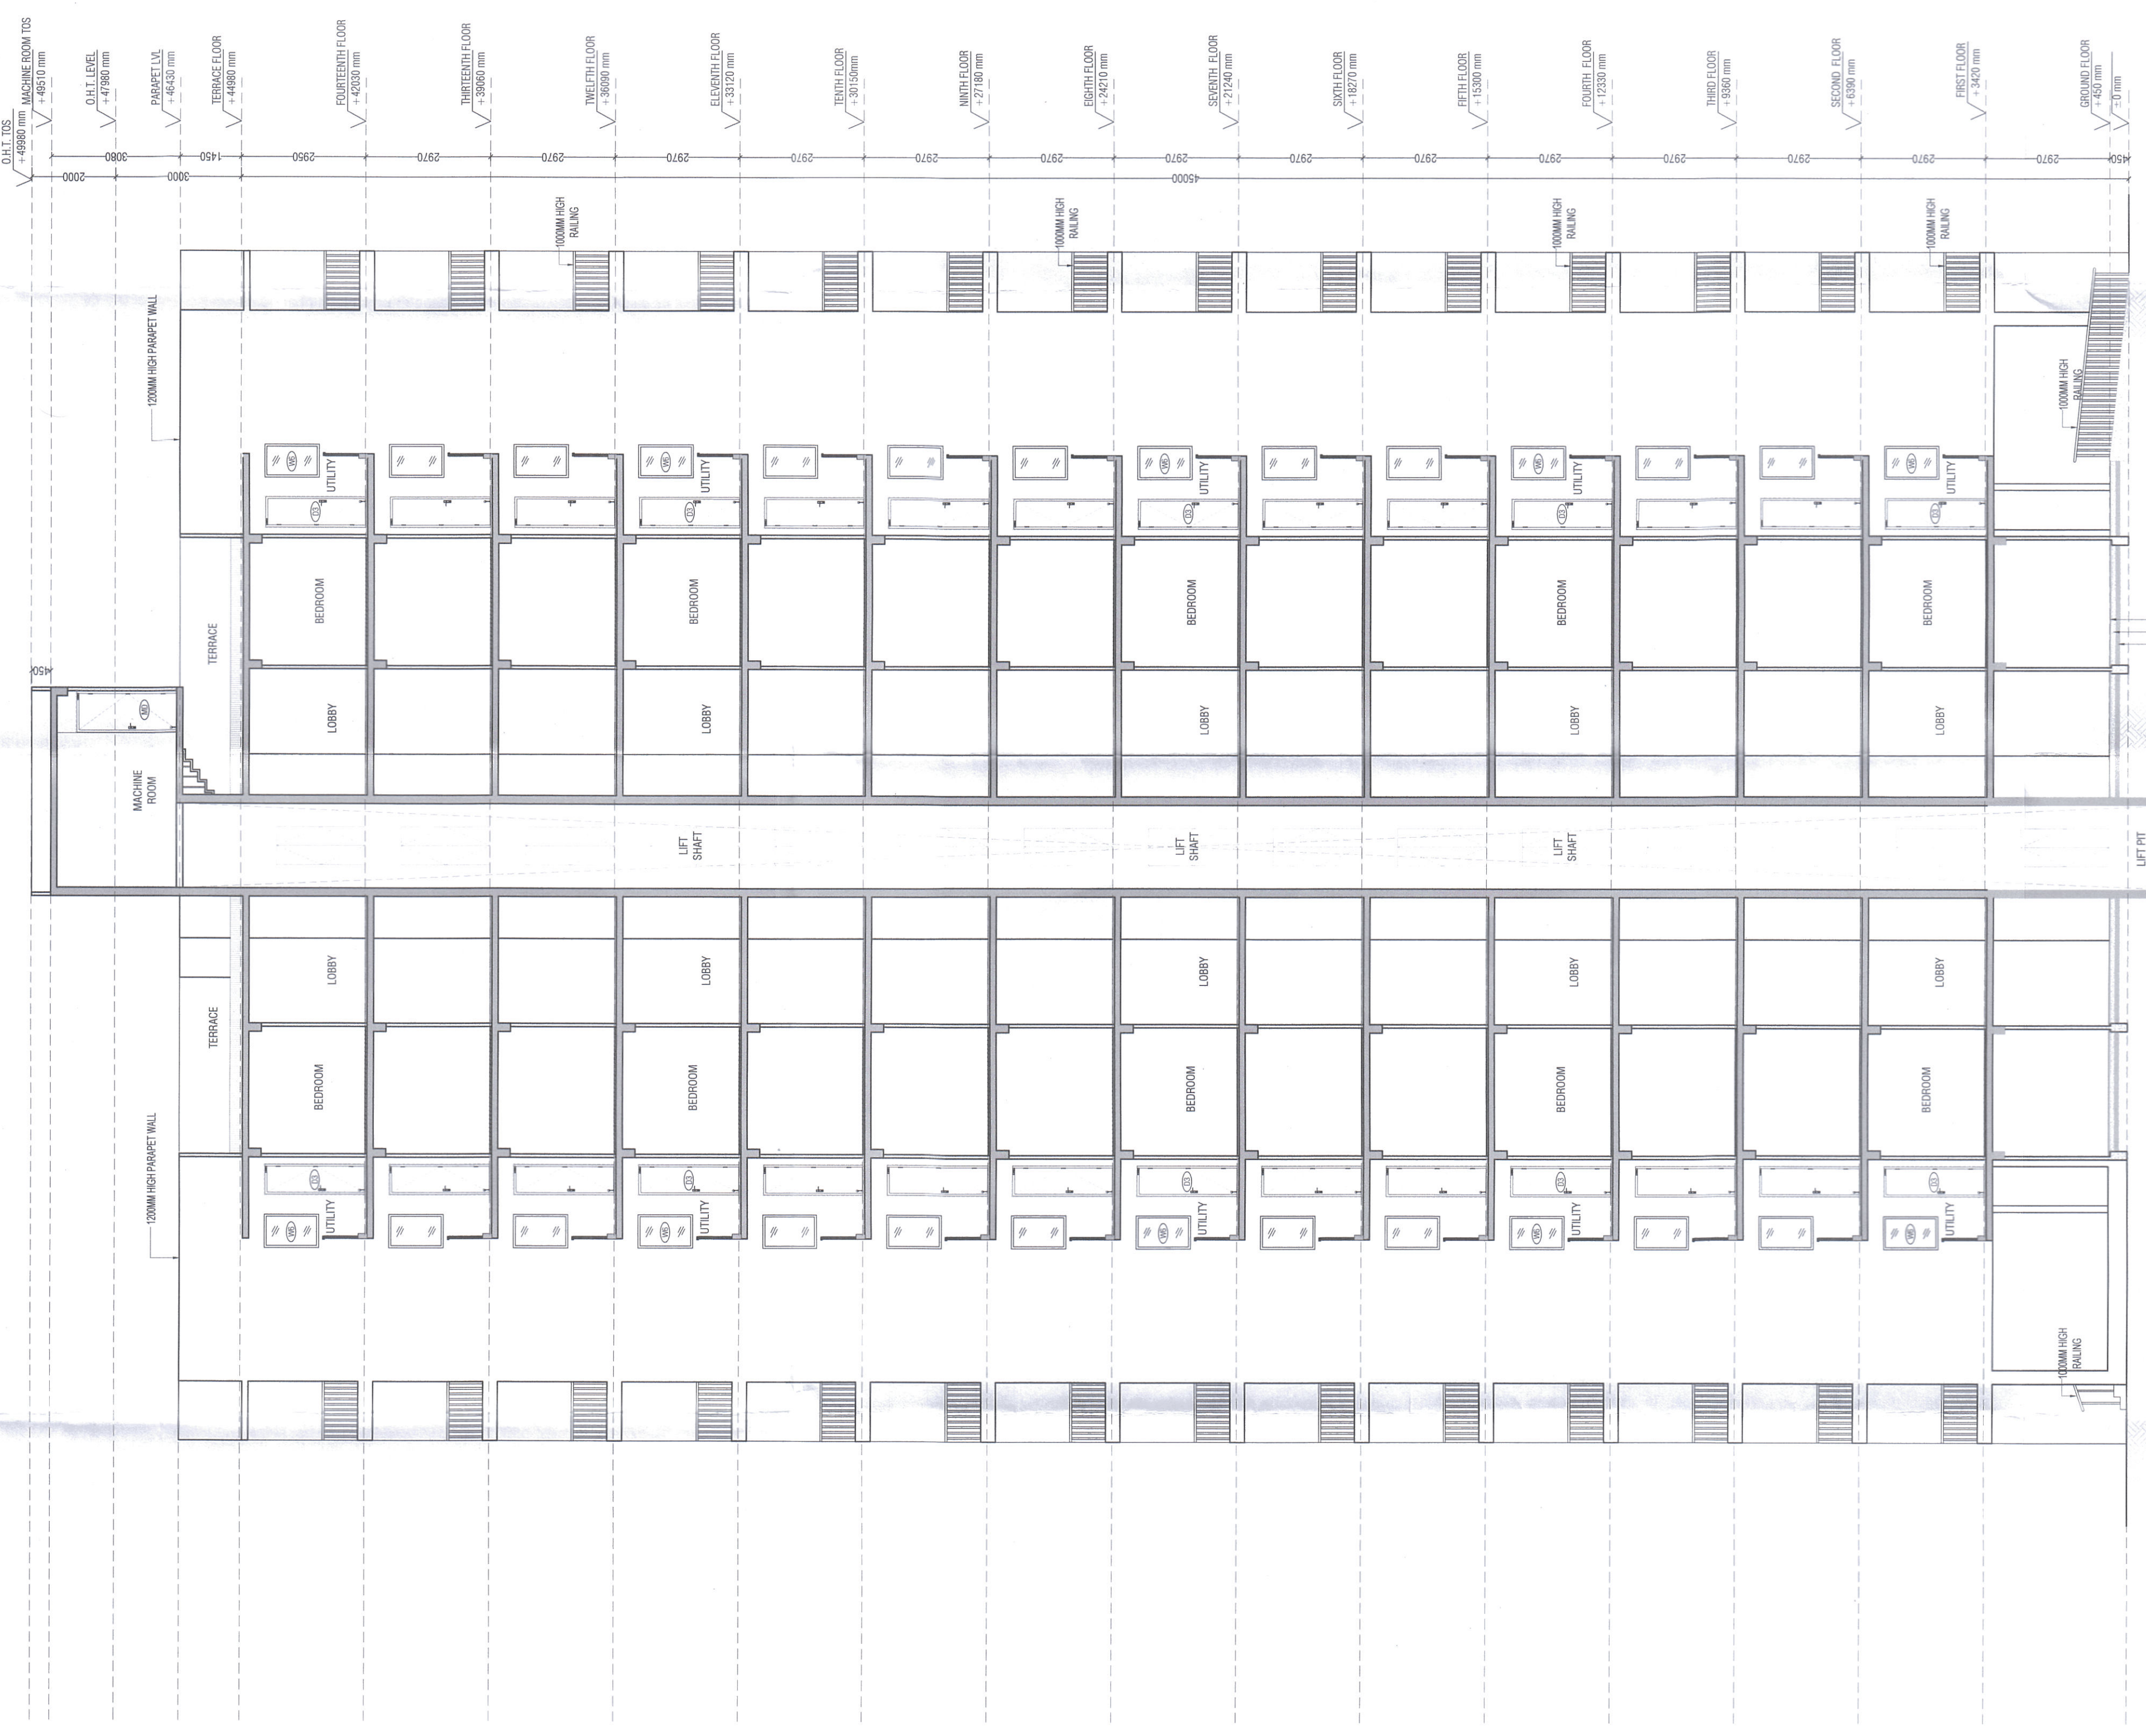

TOWER A3 A7 SECTION-B

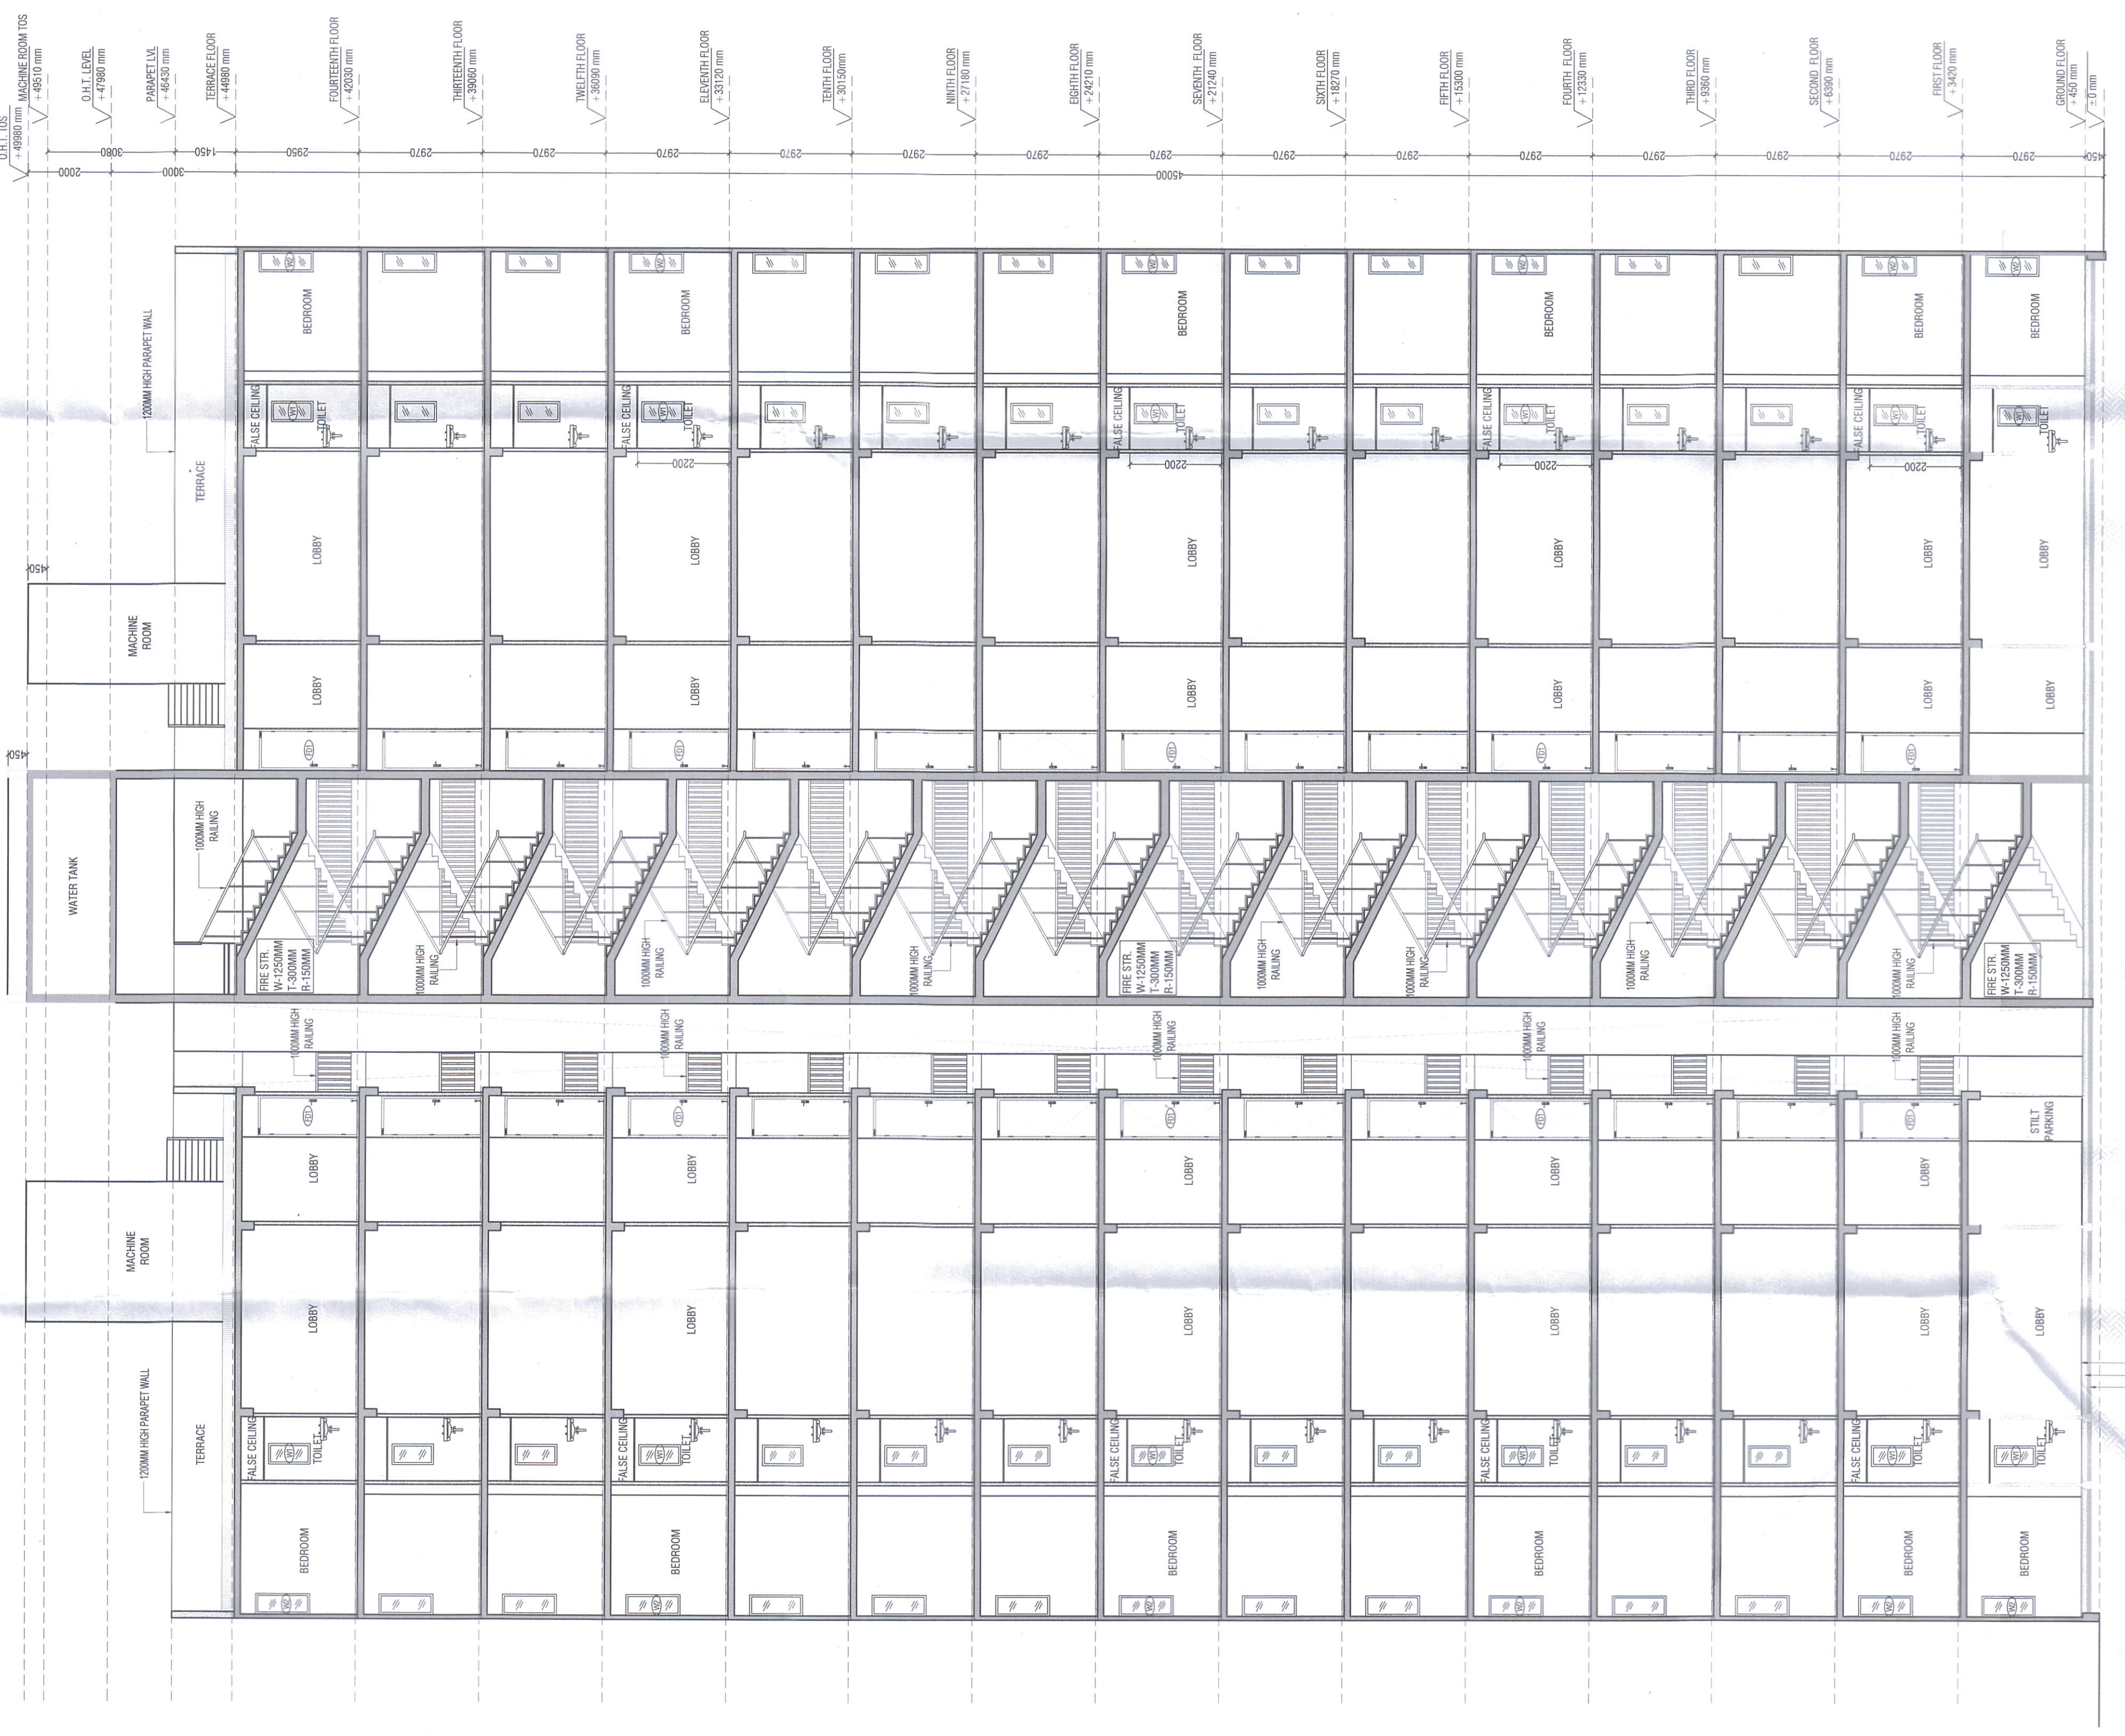

TOWER A3 A7 SECTION-A

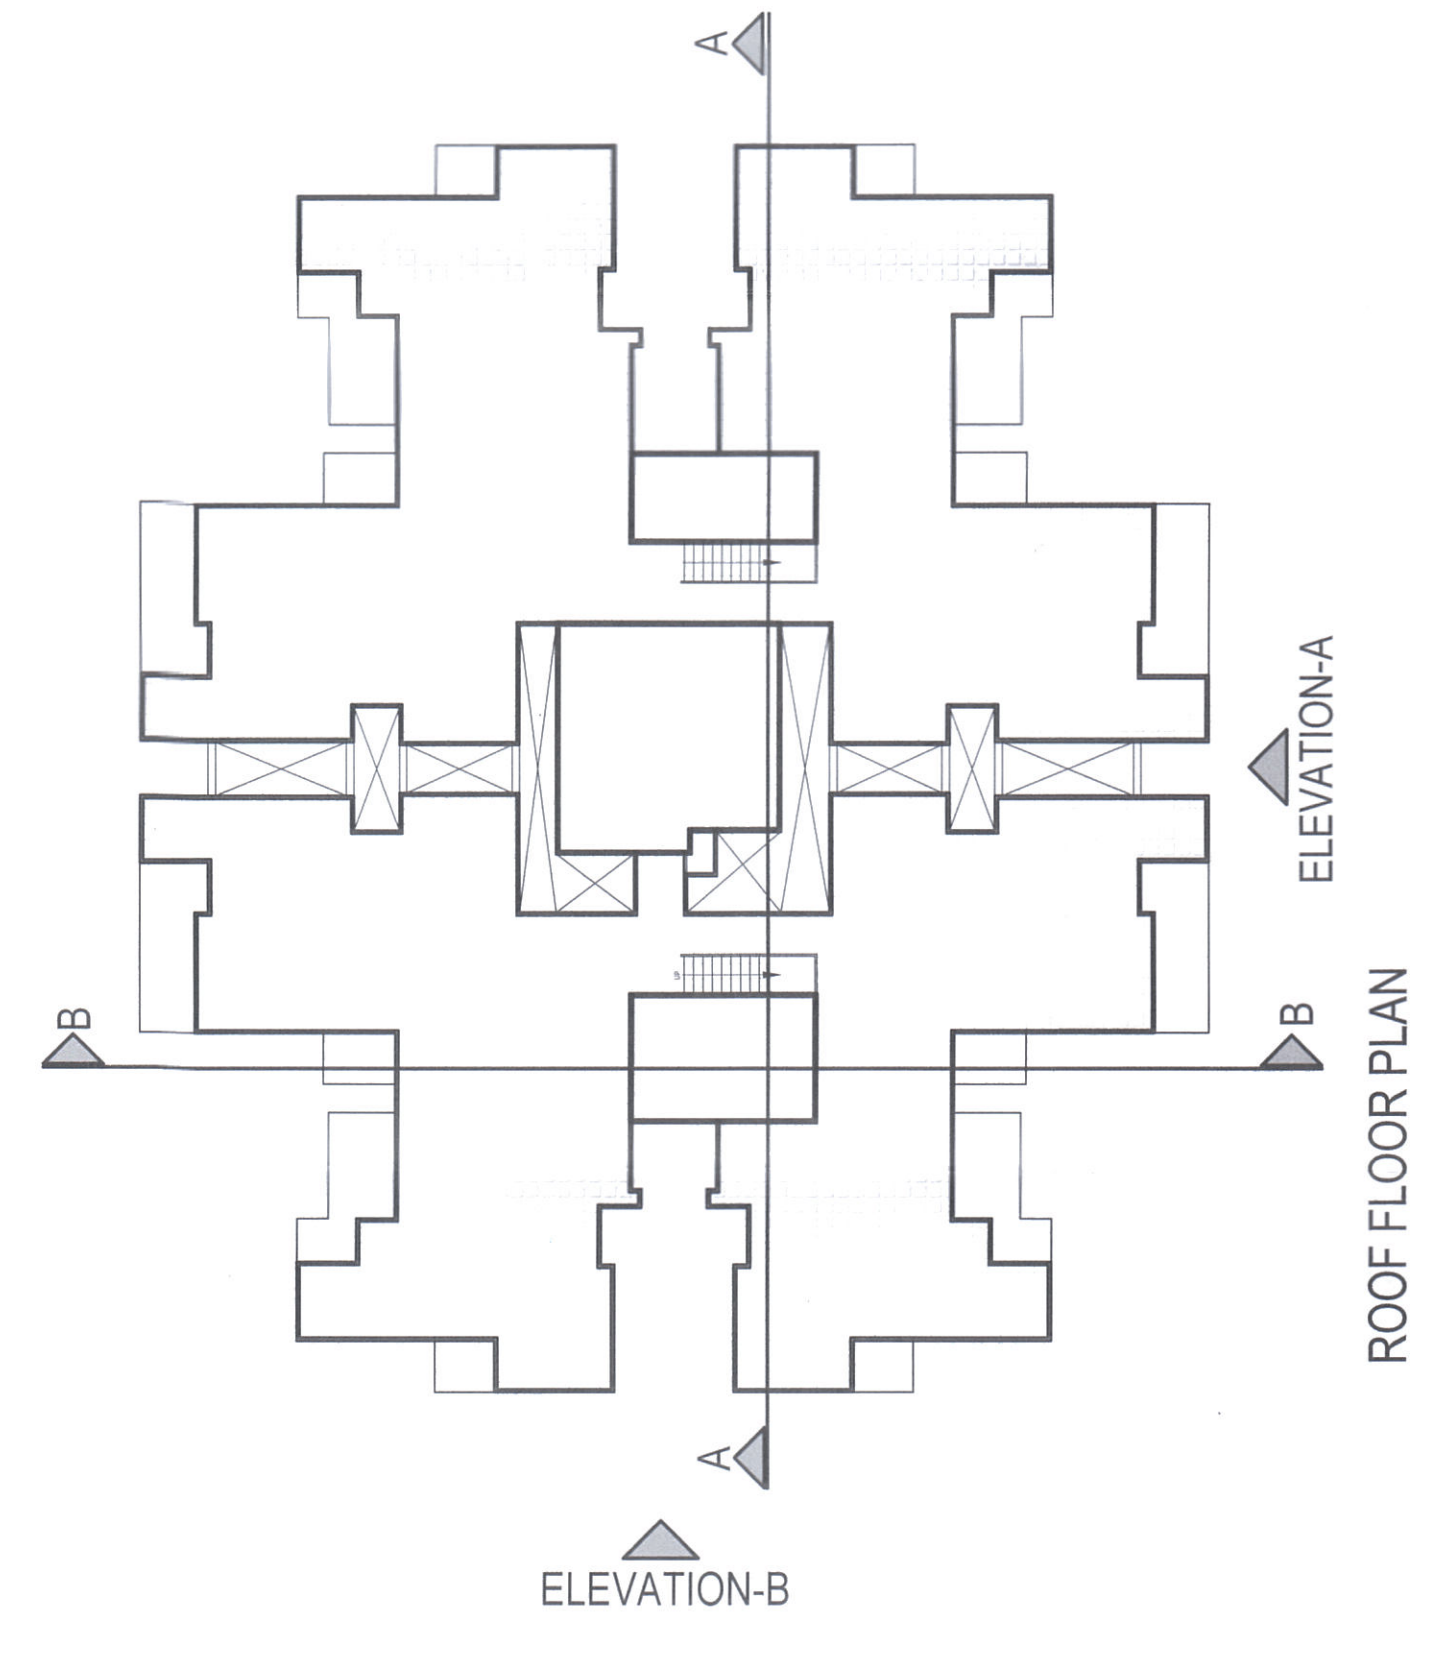

ROOF FLOOR PLAN