

6/1

NOTES:-
1. ALL DIMENSIONS ARE IN MM UNLESS OTHERWISE SPECIFIED.
2. ALL DIMENSIONS ARE IN MM UNLESS OTHERWISE SPECIFIED.
3. ALL DIMENSIONS ARE IN MM UNLESS OTHERWISE SPECIFIED.
4. ALL DIMENSIONS ARE IN MM UNLESS OTHERWISE SPECIFIED.
5. ALL DIMENSIONS ARE IN MM UNLESS OTHERWISE SPECIFIED.
6. ALL DIMENSIONS ARE IN MM UNLESS OTHERWISE SPECIFIED.

S.NO.	ITEMS	QTY	UNIT	REMARKS
1	1000	2100	2100	2100
2	1000	2100	2100	2100
3	1000	2100	2100	2100
4	1000	2100	2100	2100
5	1000	2100	2100	2100
6	1000	2100	2100	2100
7	1000	2100	2100	2100
8	1000	2100	2100	2100
9	1000	2100	2100	2100
10	1000	2100	2100	2100
11	1000	2100	2100	2100
12	1000	2100	2100	2100
13	1000	2100	2100	2100
14	1000	2100	2100	2100
15	1000	2100	2100	2100
16	1000	2100	2100	2100
17	1000	2100	2100	2100
18	1000	2100	2100	2100
19	1000	2100	2100	2100
20	1000	2100	2100	2100
21	1000	2100	2100	2100
22	1000	2100	2100	2100
23	1000	2100	2100	2100
24	1000	2100	2100	2100
25	1000	2100	2100	2100
26	1000	2100	2100	2100
27	1000	2100	2100	2100
28	1000	2100	2100	2100
29	1000	2100	2100	2100
30	1000	2100	2100	2100
31	1000	2100	2100	2100
32	1000	2100	2100	2100
33	1000	2100	2100	2100
34	1000	2100	2100	2100
35	1000	2100	2100	2100
36	1000	2100	2100	2100

SEWAGE LINE
BY-PASS LINE
CATCH BASIN 300X300 mm
SEWERAGE MANHOLE (9100)

PLUMBING & FIRE FIGHTING CONSULTANT
ENTRONS
BUILDING SERVICES CONSULTANTS
A-14 BASEMENT, SHIVAJI
NEW DELHI-110017
PHONE: 011-2674787, 2674793

OWNERS SIGNATURE

ARCHITECT'S SIGNATURE
CA/92/14687

OWNER'S
MR.

PROJECT:-
BUILDING PLAN OF IT PARK, CYBER PARK COLONY
MEASURING 61375 ACRES (LICENSE NO. 112 OF
2012 DATED 27.10.2012) IN SECTOR -66,
GURGRAM MANESAR URBAN COMPLEX BEING
DEVELOPED BY GUPTA PROMOTERS PVT. LTD.

DRG. TITLE:-
SITE PLAN
A/REVENUE/REVENUE/REVENUE

DRG. NO.:
S-01
SCALE
1:250
DATE
02-05-20

S.NO.	DESCRIPTION	SYMBOL
1.	DOM. WATER RISER PIPE	○
2.	MANHOLE (SEWER/CIRCULAR)	●
3.	FLUSHING WATER RISER PIPE	○
4.	WATER METER	○
5.	WATER CHAMBER SIZE 600X600	○
6.	VALVE	○

S.NO.	DESCRIPTION	SYMBOL
1.	FLUSHING WATER RISER PIPE	○
2.	GARDEN HYDRANT	○

S.NO.	DESCRIPTION	SYMBOL
1.	FIRE LINE	○
2.	EXTERNAL FIRE HYDRANT	○
3.	FIRE BRIGADE CONNECTION	○


S.NO.	DESCRIPTION	SYMBOL
1.	STORM WATER PIPE LINE	○
2.	STORM WATER MANHOLE (CIRCULAR)	○
3.	RAIN WATER HARVESTING	○

AREA CALCULATIONS	
ITEM AREA	AREA
1. TOTAL AREA OF THE SITE	10000.00
2. TOTAL AREA OF THE BUILDING	10000.00
3. TOTAL AREA OF THE ROADS	10000.00
4. TOTAL AREA OF THE PARKS	10000.00
5. TOTAL AREA OF THE OTHERS	10000.00

FLOOR AREA DETAILS	
FLOOR	AREA
1. GROUND FLOOR	10000.00
2. FIRST FLOOR	10000.00
3. SECOND FLOOR	10000.00
4. THIRD FLOOR	10000.00
5. FOURTH FLOOR	10000.00
6. FIFTH FLOOR	10000.00
7. SIXTH FLOOR	10000.00
8. SEVENTH FLOOR	10000.00
9. EIGHTH FLOOR	10000.00
10. NINTH FLOOR	10000.00
11. TENTH FLOOR	10000.00

TOILET REQUIREMENT FOR IT PARK	
FLOOR	AREA
1. GROUND FLOOR	10000.00
2. FIRST FLOOR	10000.00
3. SECOND FLOOR	10000.00
4. THIRD FLOOR	10000.00
5. FOURTH FLOOR	10000.00
6. FIFTH FLOOR	10000.00
7. SIXTH FLOOR	10000.00
8. SEVENTH FLOOR	10000.00
9. EIGHTH FLOOR	10000.00
10. NINTH FLOOR	10000.00
11. TENTH FLOOR	10000.00

TOILET REQUIREMENT FOR COMMERCIAL	
FLOOR	AREA
1. GROUND FLOOR	10000.00
2. FIRST FLOOR	10000.00
3. SECOND FLOOR	10000.00
4. THIRD FLOOR	10000.00
5. FOURTH FLOOR	10000.00
6. FIFTH FLOOR	10000.00
7. SIXTH FLOOR	10000.00
8. SEVENTH FLOOR	10000.00
9. EIGHTH FLOOR	10000.00
10. NINTH FLOOR	10000.00
11. TENTH FLOOR	10000.00

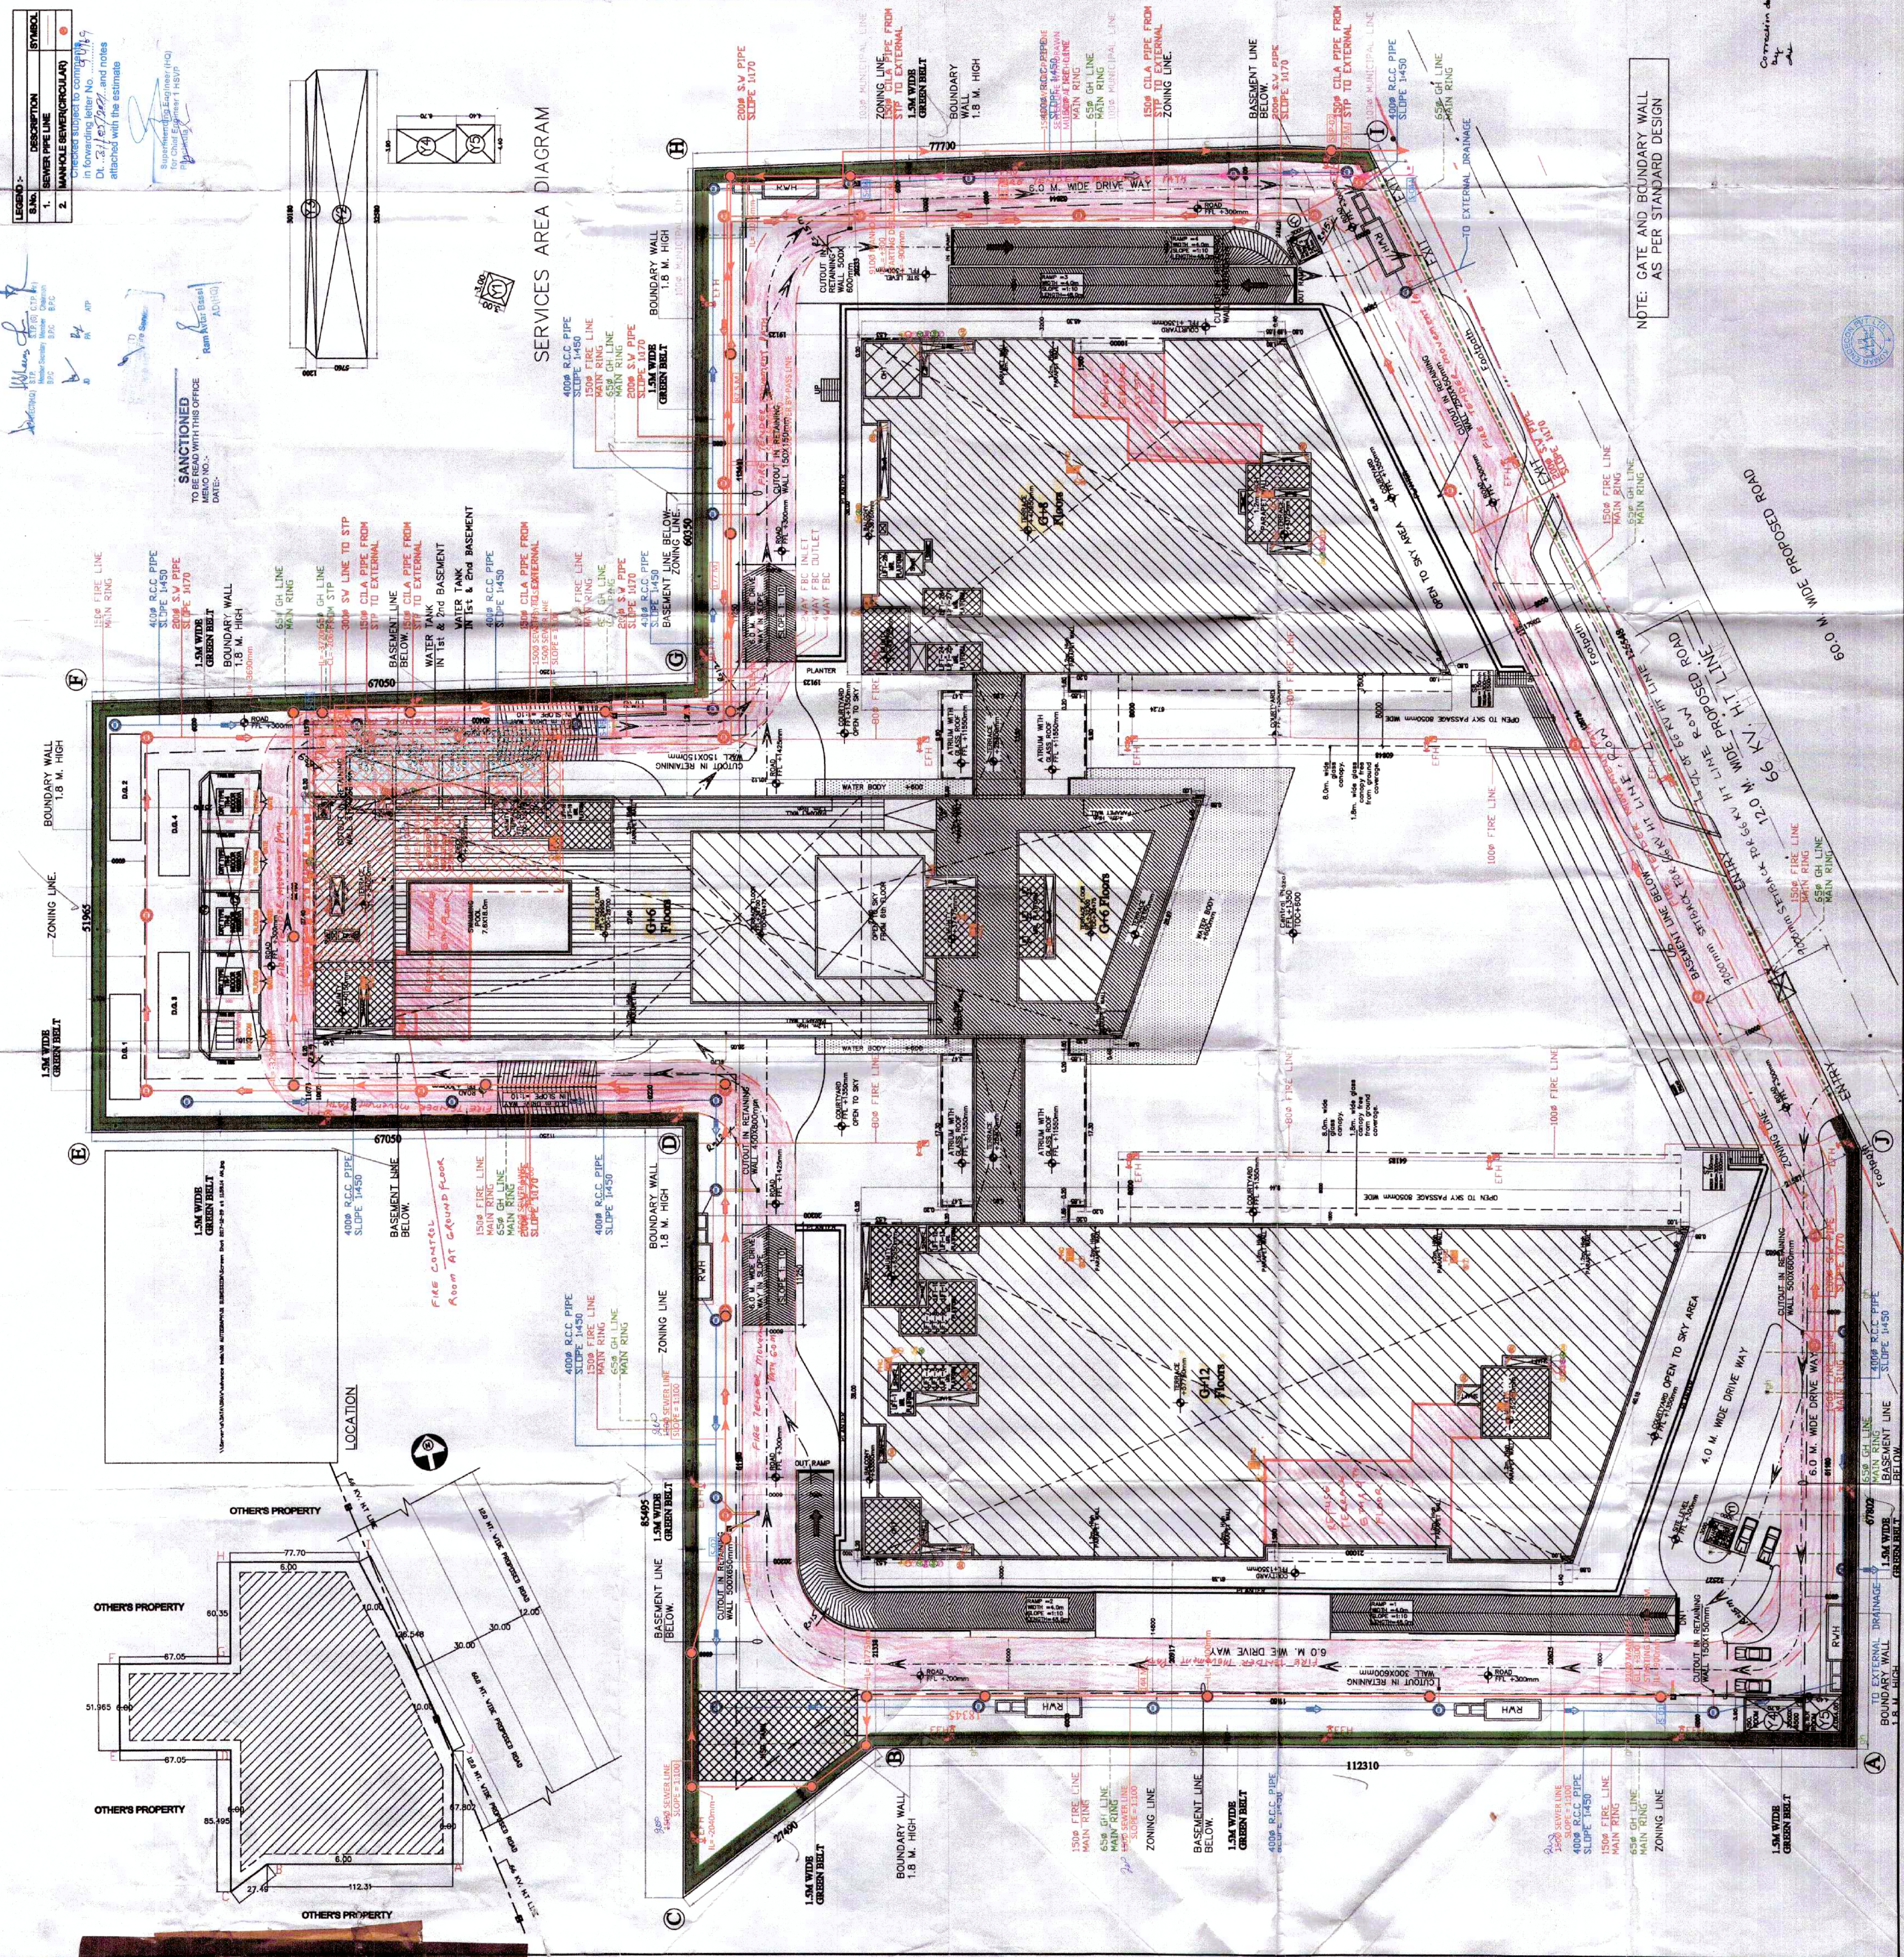

NOTE: GATE AND BOUNDARY WALL
AS PER STANDARD DESIGN