

swd
Date: 27.10.2012
By: [Signature]

NOTES: -
1. ALL DIMENSIONS ARE IN MM UNLESS OTHERWISE SPECIFIED.
2. ALL BUILDING EXCLUDING BASEMENTS FULLY AIR CONDITIONED AS PER M.C. NORMS.
3. ALL BASEMENTS ARE MECHANICALLY LIGHTED AND VENTILATED AS PER M.C. NORMS.
4. ALL BUILDING INCLUDING BASEMENT FULLY SPRINKLERED AS PER M.C. NORMS.
5. ALL PARTITION WALLS IN TOILET ARE 2400 HIGH.
6. ALL TOILETS ARE MECHANICALLY VENTILATED AND LIGHTED.

S.NO.	ITEMS	WIDTH	HEIGHT	REMARKS
1	FD1	1000	2100	2100 SERVER ROOM
2	FD2	1000	2100	2100 SERVER ROOM
3	FD3	1000	2100	2100 SERVER ROOM
100	FD100	1000	2100	2100 SERVER ROOM

STORM LINE
STORM MANHOLE (9100)

STORM MANHOLE (9100)
FIRE - FIGHTING LEGEND

PLUMBING & FIRE FIGHTING CONSULTANT
ENTRONS
BUILDING SERVICES CONSULTANTS
A-14 BASEMENT, SHIVAJI
NEW DELHI-110017
PHONE: 011-2687477/2687478

OWNERS SIGNATURE

ARCHITECT'S SIGNATURE
CAB214687

KANAL BATHA
CA 192 / 14887

OWNER'S SIGNATURE

PROJECT:-

BUILDING PLAN OF IT PARK/ CYBER PARK COLONY
MEASURING 6.1375 ACRES (LICENSE NO 112 OF
2012 DATED 27.10.2012) IN SECTOR -66,
GURGRAM MANESAR URBAN COMPLEX BEING
DEVELOPED BY GUPTA PROMOTERS PVT. LTD.

DRG. TITLE:-

SITE PLAN
AREA DIAGRAM AND CALCULATION
STORM LAYOUT

DRG. NO.:-

S-01

SCALE

1:250

DATE

02-05-20

LEGEND -	SYMBOL
1. DRAIN WATER RISER PIPE	1
2. MANHOLE LINE	2
3. FLUSHING WATER RISER PIPE	3
4. WATER METER	4
5. VALVE CHAMBER SIZE 600MM	5
6. VALVE	6

LEGEND -	SYMBOL
1. PLUMBING WATER RISER PIPE	1
2. GARDEN HYDRANT LINE	2
3. GARDEN HYDRANT	3


LEGEND -	SYMBOL
1. FIRE LINE	1
2. FIRE BRIGADE CONNECTION	2

LEGEND -	SYMBOL
1. STORM WATER PIPE LINE	1
2. STORM WATER MANHOLE (CIRCULAR)	2
3. RAIN WATER HARVESTING	3

SERVICES AREA DIAGRAM

LEGEND -	SYMBOL
1. SEWER PIPE LINE	1
2. MANHOLE (SEWER/CIRCULAR)	2

SANCTIONED
TO BE READ WITH THIS OFFICE
DATE:-

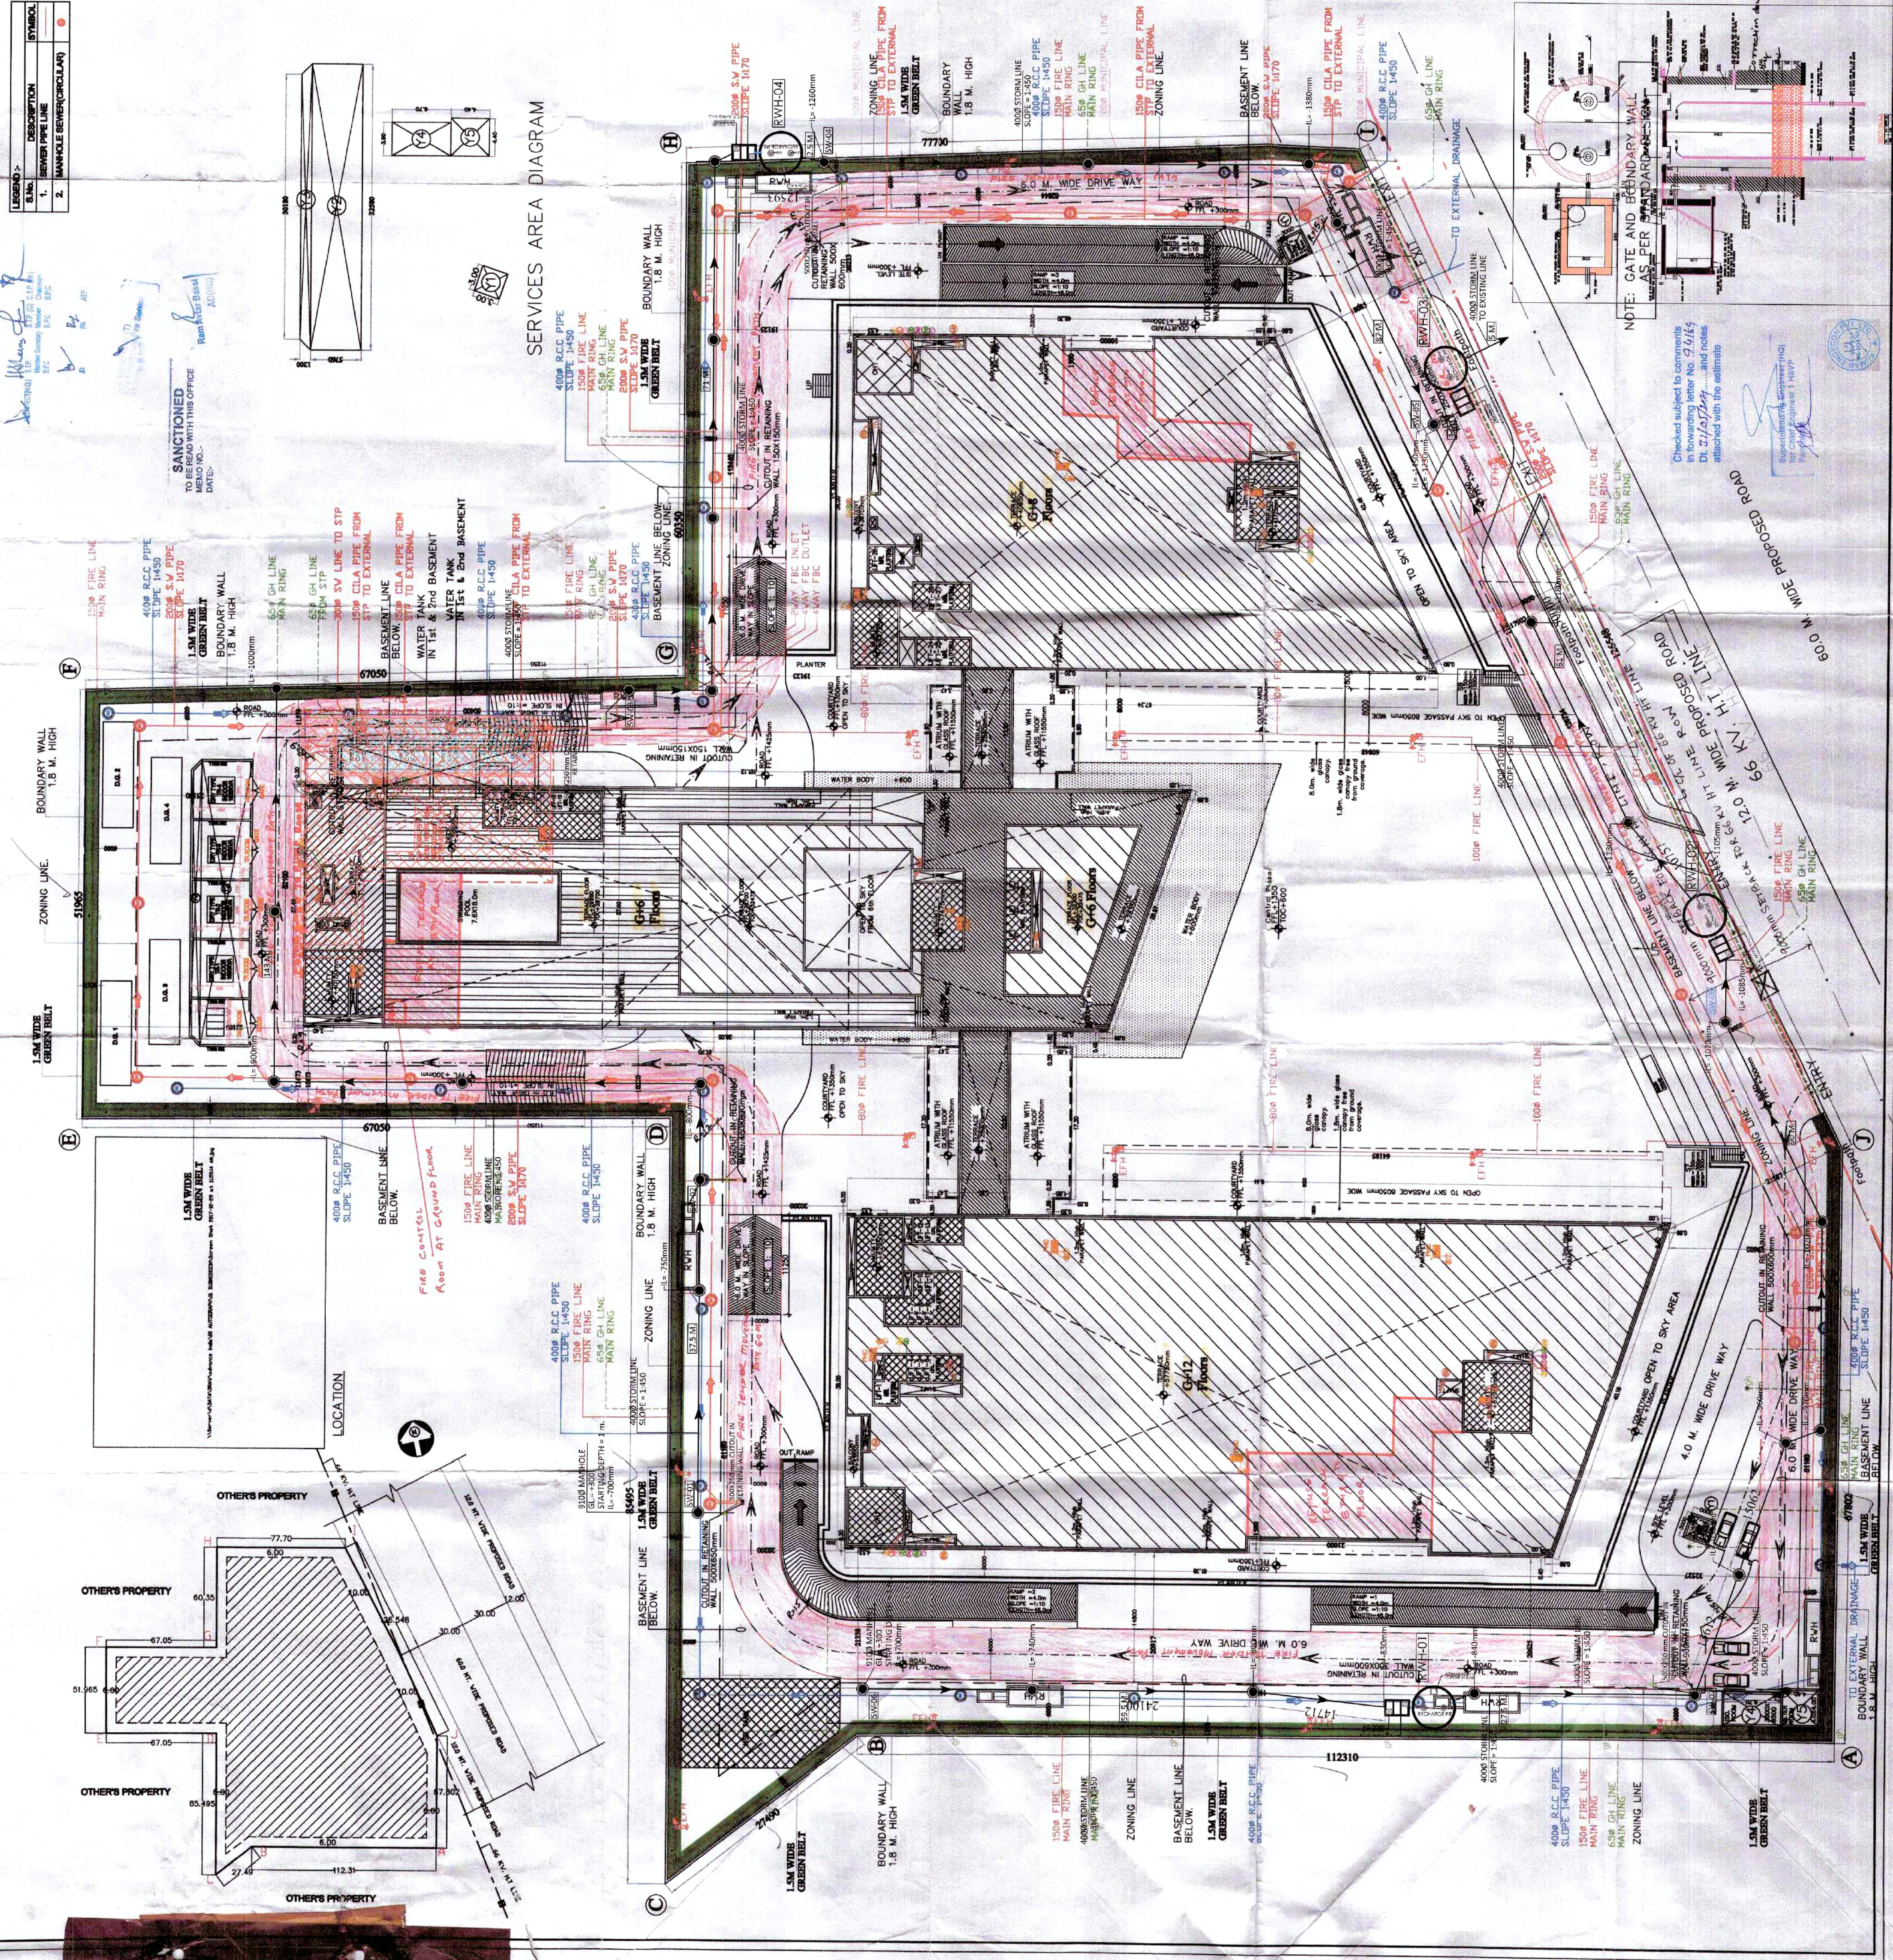

Checked subject to comments
in forwarding letter No. 3/164
Dt. 27/10/2012 and notes
attached with the estimate

Superintending Engineer
Gurgram Manesar Urban Complex
Gurgram Manesar Urban Complex
Gurgram Manesar Urban Complex

Signature