


LEGEND table with 4 columns: S.NO, ITEMS, WIDTH, HEIGHT. Includes items like 100mm M.S. DRAIN PIPE, 100mm SOIL PIPE, 100mm WASTE PIPE, etc.

NOTES:- 1. ALL DIMENSIONS ARE IN MM UNLESS OTHERWISE SPECIFIED. 2. ALL BUILDING EXCLUDING BASEMENTS FULLY AIR CONDITIONED AS PER N.B.C. NORMS. 3. ALL BASEMENTS ARE MECHANICALLY LIGHTED AND VENTILATED AS PER N.B.C. NORMS. 4. ALL BUILDING INCLUDING BASEMENT FULLY SPRINKLERED AS PER N.B.C. NORMS. 5. ALL PARTITION WALLS IN TOILET ARE 2400 HIGH. 6. ALL TOILETS ARE MECHANICALLY VENTILATED AND LIGHTED.

Table with 4 columns: S.NO, ITEMS, WIDTH, HEIGHT. Lists various plumbing fixtures and their specifications.

LEGEND WINTER CURTAIN

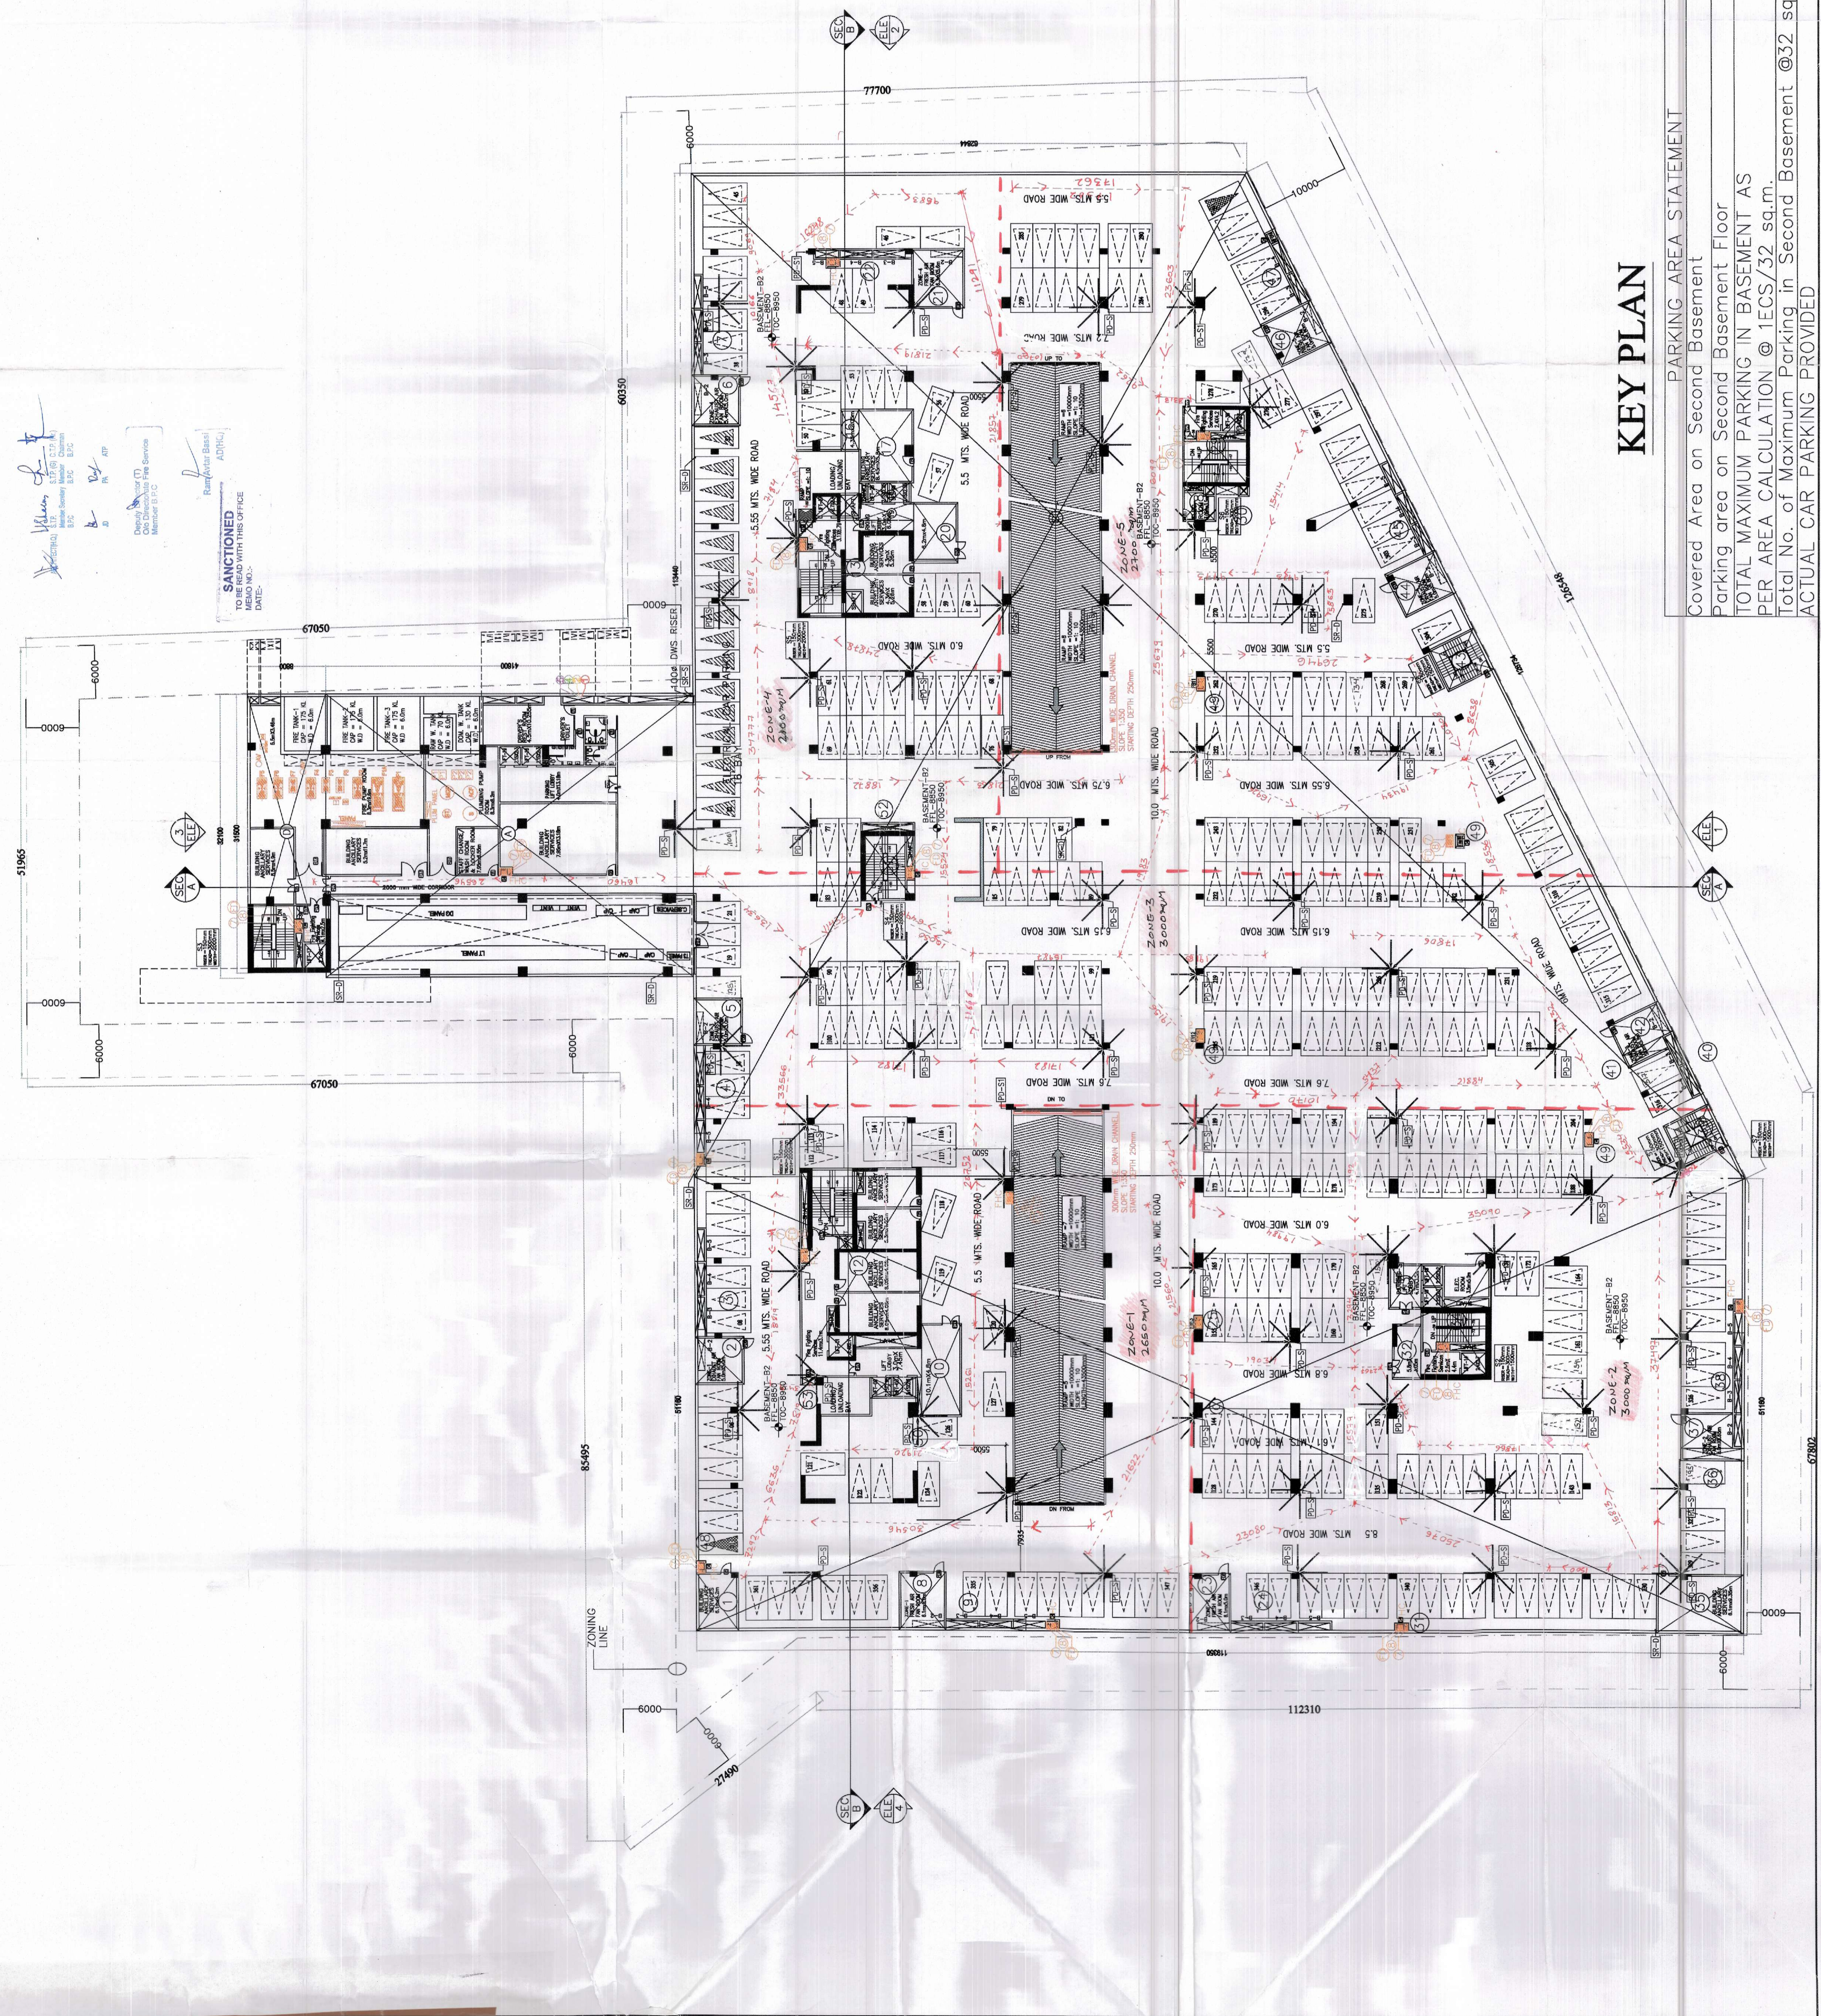

KEY PLAN

PARKING AREA STATEMENT table with 2 columns: Description, Area. Includes rows for Covered Area on Second Basement, Parking area on Second Basement Floor, etc.

PLUMBING & FIRE FIGHTING CONSULTANT ENTIRON BUILDING SERVICES CONSULTANTS A-14 BASEMENT, SHIVAJI NEW DELHI-110017 PHONE:-011-26874787,26874793

OWNERS SIGNATURE

ARCHITECTS SIGNATURE CA92/14687

OWNER:- MR. For Gupta Promoters Private Limited Authorized Signatory

PROJECT:- BUILDING PLAN OF IT PARK/ CYBER PARK COLONY MEASURING 6.1375 ACRES (LICENCE NO 112 OF 2012 DATED 27.10.2012) IN SECTOR -66, GURUGRAM MANESAR URBAN COMPLEX BEING DEVELOPED BY GUPTA PROMOTERS PVT. LTD.

DRG. TITLE:- BASEMENT -2

DRG. NO.: S-16 SCALE 1:250 DATE 02-05-20