


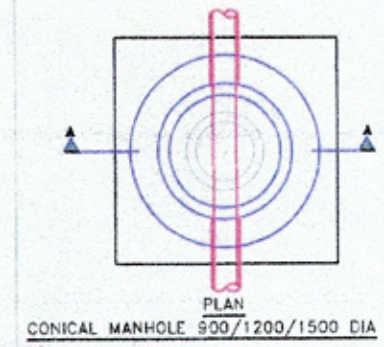

For Service Estimate only

Executive Engineer
HSPV Division No. 1
Gurugram

Superintending Engineer
HSPV Circle-II, Gurugram


Additional Chief Engineer
HSPV, Gurugram

Director
Town & Country Planning
Haryana, Chandigarh

- Notes
1. ALL UTILITY SHALL HAVE 100% POWER BACK-UP.
 2. ALL ELECTRICAL INSTALLATIONS SHALL BE AS PER PROVISIONS OF NBC.
 3. VENTILATION IN BASEMENTS SHALL BE AS PER RELEVANT NBC PROVISIONS 12-15 AIR CHANGES PER HOUR FOR NORMAL OPERATION 30 AIR CHANGES PER HOUR FOR OPERATION IN CASE OF FIRE.
 4. FIRE FIGHTING / SAFETY PROVISIONS SHALL BE AS PER RELEVANT NBC PROVISIONS.
 5. BUILDING STRUCTURE DESIGNED EARTH QUAKE RESISTANT.
 6. ALL RAMP ARE IN 1:10 SLOPE FOR CARS & 1:20 FOR HANDICAPPED UNLESS SPECIFIED.
 7. 200 mm WIDE (H&V) BLOCKS SHALL BE USED FOR EXTERNAL WALLS & 100 mm WIDE (H&V) BLOCKS SHALL BE USED FOR INTERNAL WALLS.
 8. KITCHEN & TOILETS EXHAUST FAN PROVIDED / MECHANICALLY UT & VENTILATED.

PLUMBING LEGEND :	DESCRIPTION	SYMBOL
PERFORATED DRAINAGE MANHOLE (900/1200/1500MM DIA)		
RAINWATER HARVESTING	RWH	
STORM WATER DRAINAGE LINE		
CATCH BASIN ROAD GULLY CHAMBER	CB	


Key Plan

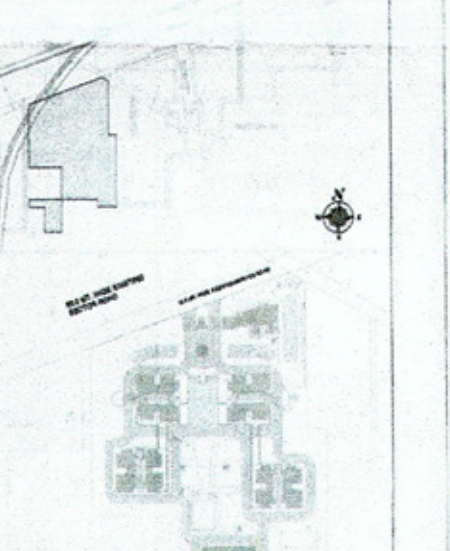

Architect's Signature
Dinesh Kumar
SD (HQ)
JO(HQ)
Owner's Signature
Labib Alam, Architect
Council of Architecture
Registration No. CA/2001/12744
Architects
Arcop Associates Pvt. Ltd.
B-11, Sector 14, Gurgaon
New Delhi, India
Job Title
SITE PLAN PARKING & GREEN AREA CALCULATION
Job No.
2011/68
Drawing No.
A-01
Drawn
ASHOK
Checked
LABIB
Date
10.10.2018
Scale
1:300
Revisions

Checked subject to comments in forwarding letter No. 110.575 Dt. 25.06.19 and notes attached with the estimate

Superintending Engineer (HQ) for Chief Engineer, HSPV
Panchkula

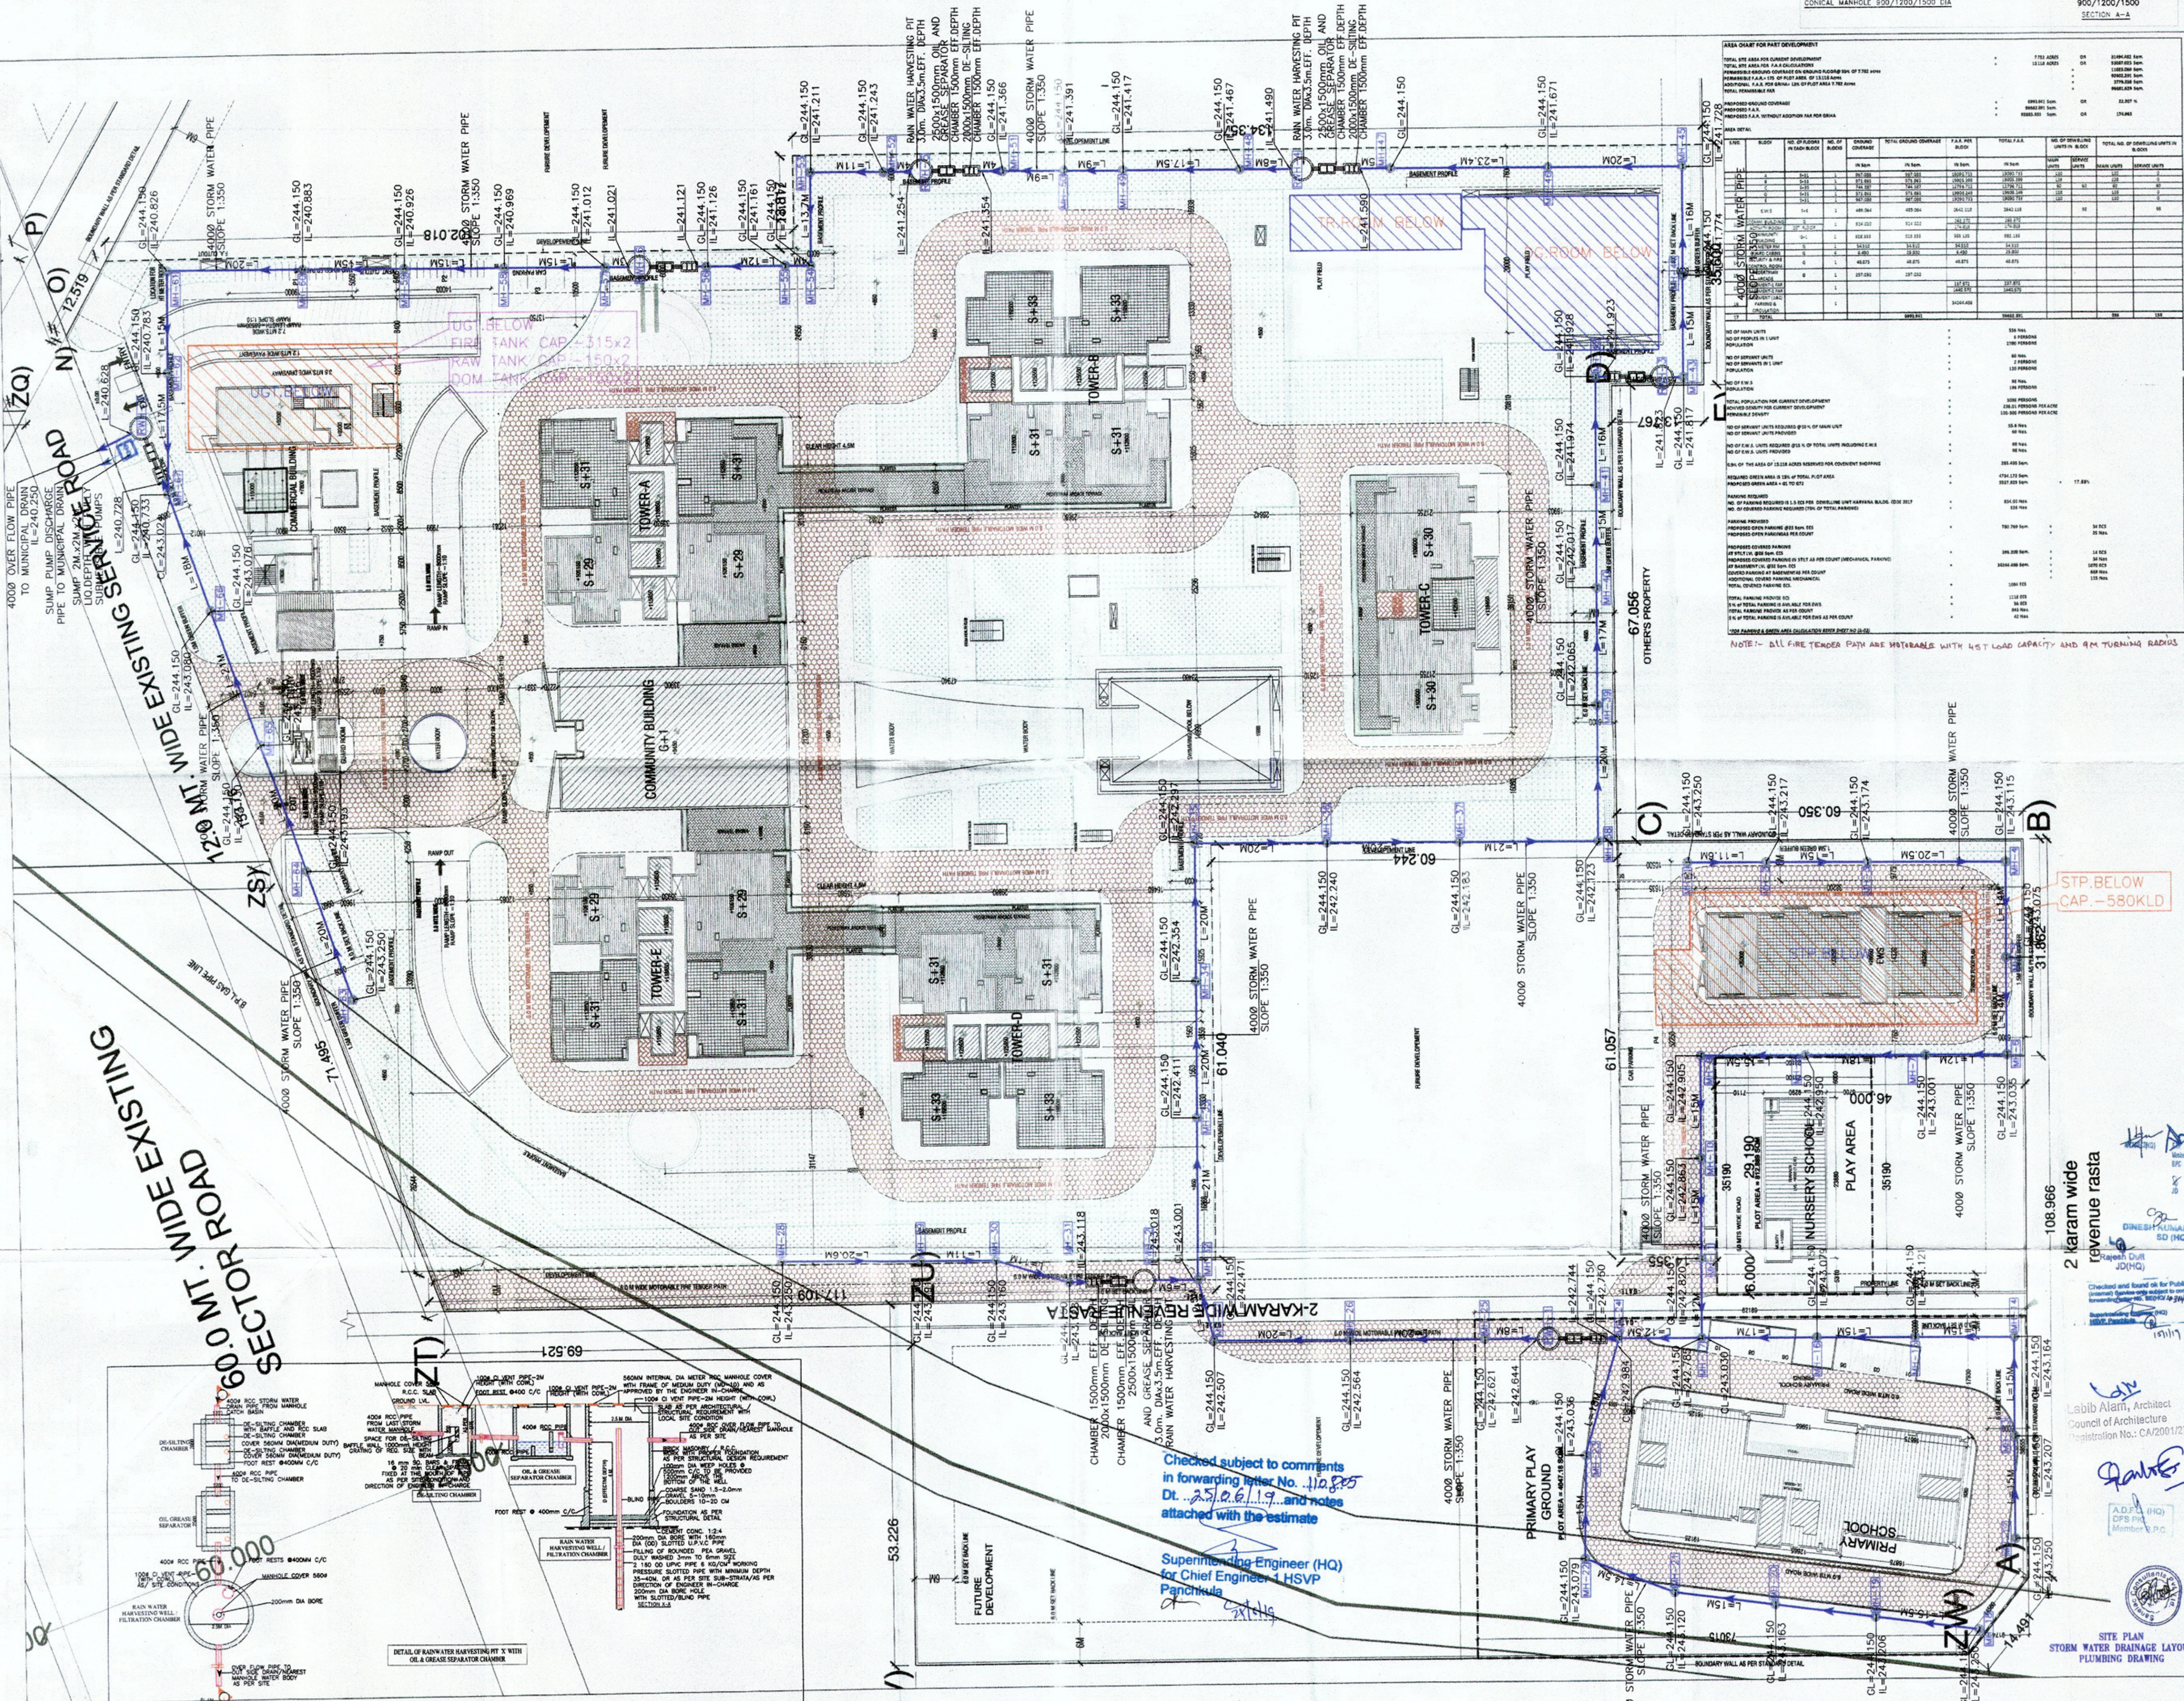

60.000
60.000 MT. WIDE EXISTING
SECTOR ROAD

STP. BELOW
CAP - 580KLD

2 karam wide
revenue rasta

Labib Alam, Architect
Council of Architecture
Registration No. CA/2001/12744

10.10.2018 1:300