


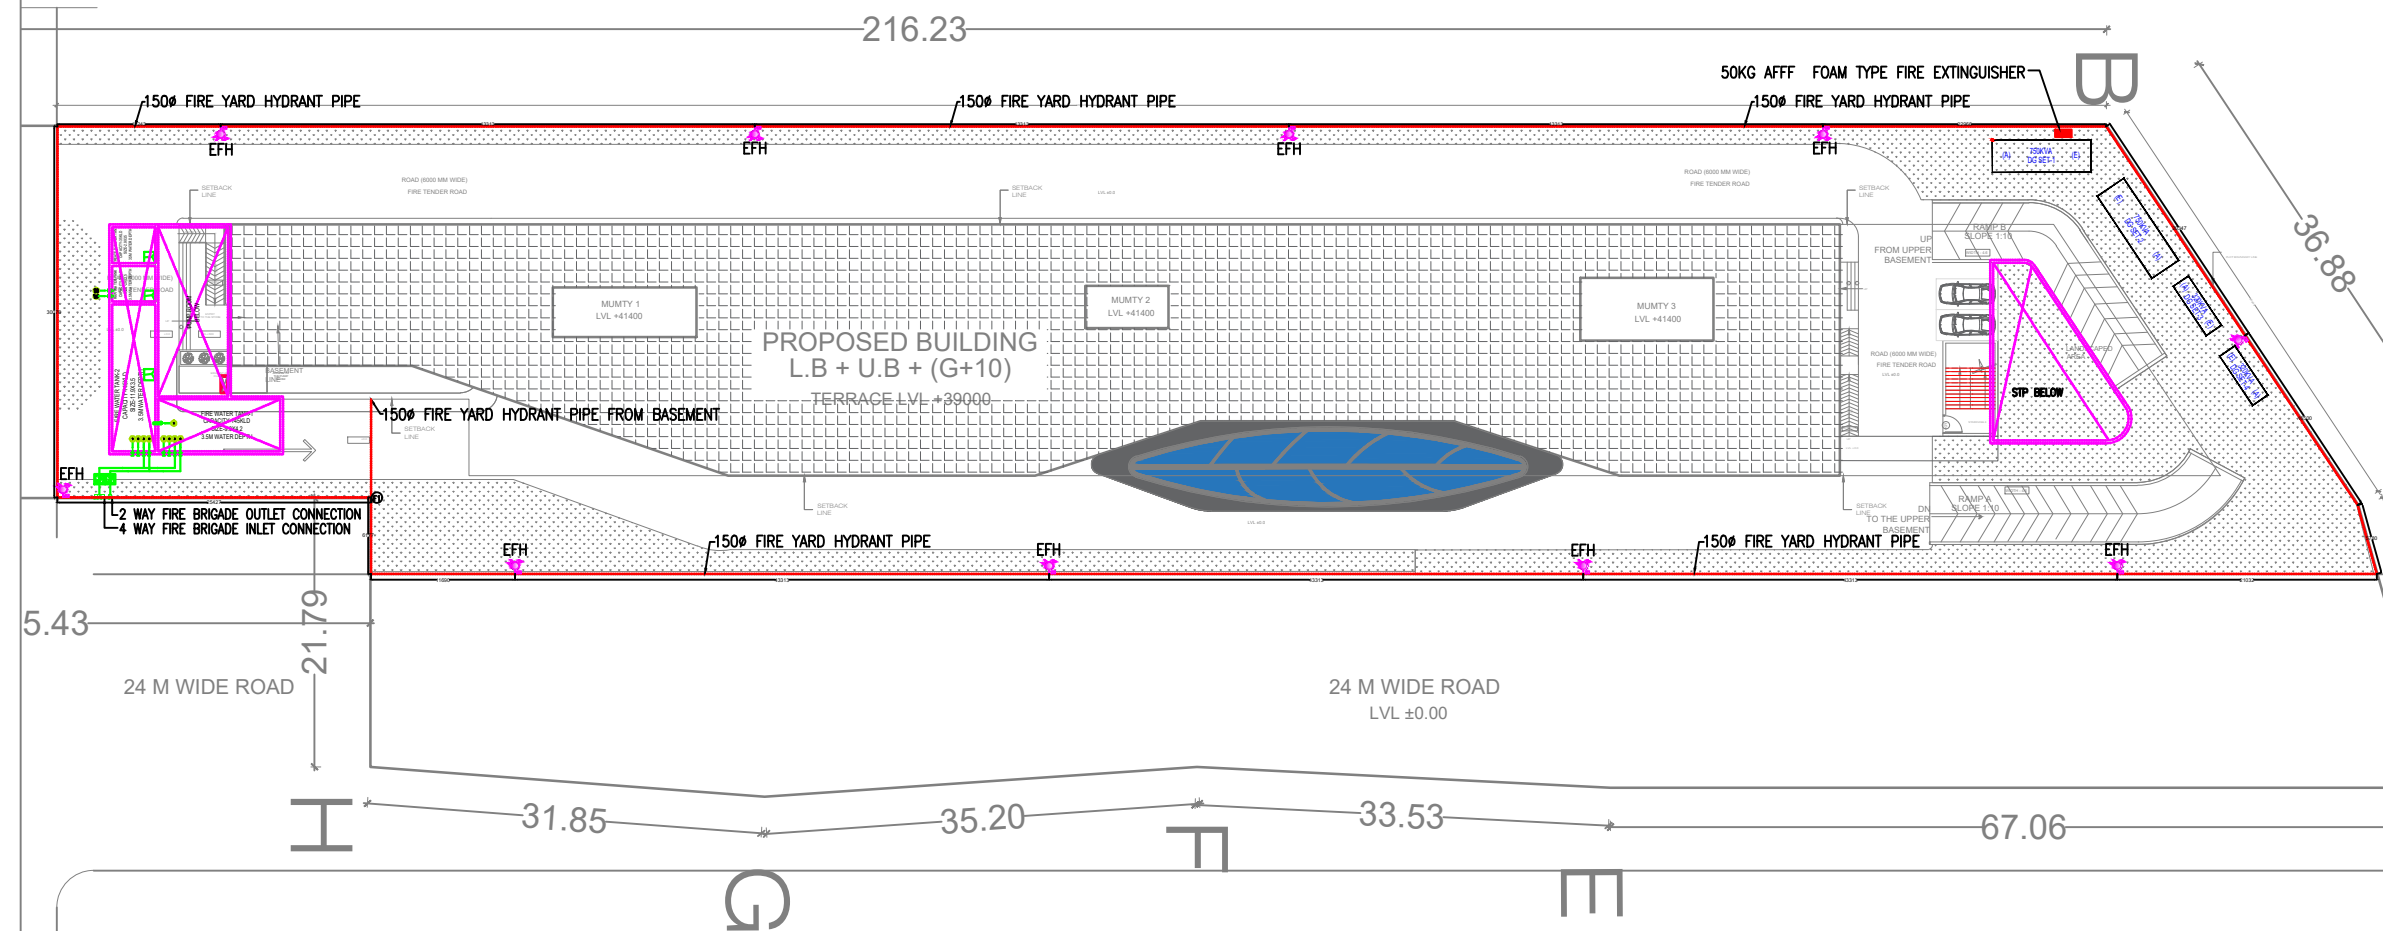

KEY PLAN:1

MEP CONSULTANT
INNOVATIVE CONSULTING ENGINEERS
G79/3, 2nd Floor
Jasola-Kalindi Kunj Road,
New Delhi-110025
Ph: 011-26941605
Email :- innovative.FF@gmail.com

PROJECT:
COMMERCIAL COLONY AREA MEASURING
2.625 ACRES IN SECTOR 34, SOHNA BEING
DEVELOP BY SMT. MONIKA RAIZADA W/O SH.
NAVEEN RIZADA IN COLLABORATION WITH
NAVI ESTATES LLP.
(LICENCE NO 79. OF 2018 DATED 17/11/2018)

CLIENT: NAVI ESTATES, LLP
NEW DELHI

REVISION SCHEDULE:		
SNO	NOTES	DATED

ARCHITECT SIG:	OWNER SIG:

BUILDING TYPE: COMMERCIAL


GENERAL NOTES:
1. All dimensions are in MM
2. Only vertical dimensions should be followed
3. All dimensions should be checked and verified before execution, inconsistency if any should be brought to the notice of the architect.

DRAWING TITLE: FIRE FIGHTING LAYOUT

DRAWING NO: FF-01 DATE: 21/04/2021

SCALE: 1:300@A3 NORTH:

 **STHAPATI ASSOCIATES (P) LTD.**
architects,interior designers,
landscape consultants,
& project consultants.
Lucknow Studio: 1/24, Vipul Khand, Gomti Nagar, Lucknow
Ph no.0522 - 4027793
Delhi Studio: T - 34/ 702, Common Wealth Games Village,
Delhi - 110082
Ph no. 011 - 21211409

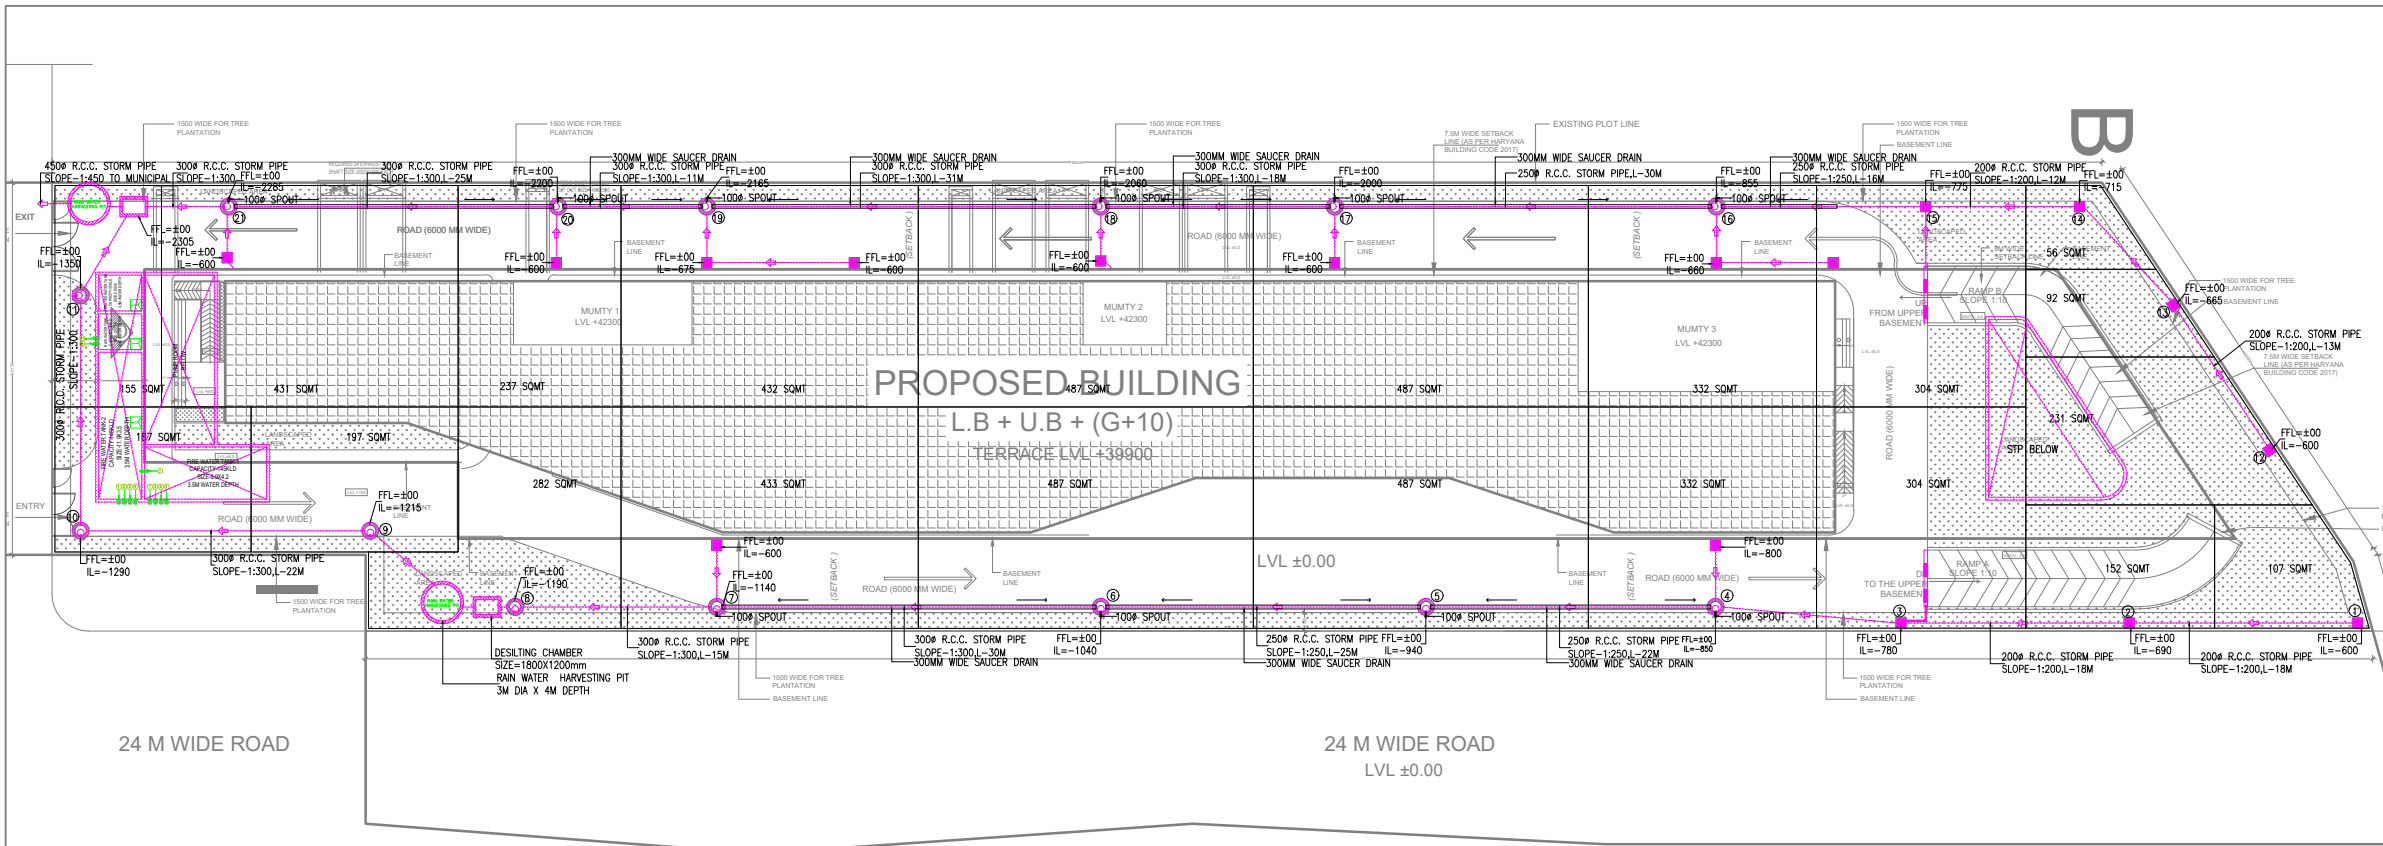

PLUMBING LEGEND	
S. No.	DESCRIPTION
⑤	100Ø C.I. SOIL & VENT PIPE
⑥	100Ø C.I. WASTE & VENT PIPE
⑦	75Ø C.I. VENT PIPE
⑧	DWS DN. TAKE PIPE FROM OVER HEAD TANK
⑨	FWS DN. TAKE PIPE FROM OVER HEAD TANK
⑩	DOMESTIC WATER RISER PIPE
⑪	FLUSHING WATER RISER PIPE
⑫	150Ø RAIN WATER PIPE
GULLY TRAP 300X300MM	
CATCH BASIN 600X600MM	
CIRCULAR SEWER MANHOLE	
CIRCULAR STORM MANHOLE	

KEY PLAN:1

MEP CONSULTANT
INNOVATIVE CONSULTING ENGINEERS
G79/3, 2nd Floor
Jasola-Kalindi Kunj Road,
New Delhi-110025
Ph: 011-26941605
Email :- innovative.FF@gmail.com

PROJECT:
COMMERCIAL COLONY AREA MEASURING
2.625 ACRES IN SECTOR 34, SOHNA BEING
DEVELOP BY SMT. MONIKA RAIZADA W/O SH.
NAVEEN RIZADA IN COLLABORATION WITH
NAVI ESTATES LLP.
(LICENCE NO 79. OF 2018 DATED 17/11/2018)

CLIENT: NAVI ESTATES, LLP
NEW DELHI

REVISION SCHEDULE:		
SNO	NOTES	DATED

ARCHITECT SIG:	OWNER SIG:

BUILDING TYPE: COMMERCIAL


GENERAL NOTES:
1. All dimensions are in MM
2. Only vertical dimensions should be followed
3. All dimensions should be checked and verified before execution, inconsistency if any should be brought to the notice of the architect.

DRAWING TITLE: STORM LAYOUT

DRAWING NO: ST-01 DATE: 21/04/2021

SCALE: 1:375@A2 NORTH:

STHAPATI ASSOCIATES (P) LTD.
architects,interior designers,
landscape consultants,
& project consultants.
Lucknow Studio: 1/24, Vipul Khand, Gomti Nagar, Lucknow
Ph no.0522 - 4027793
Delhi Studio: T - 34/ 702, Common Wealth Games Village,
Delhi - 110008
Ph no. 011 - 21211409

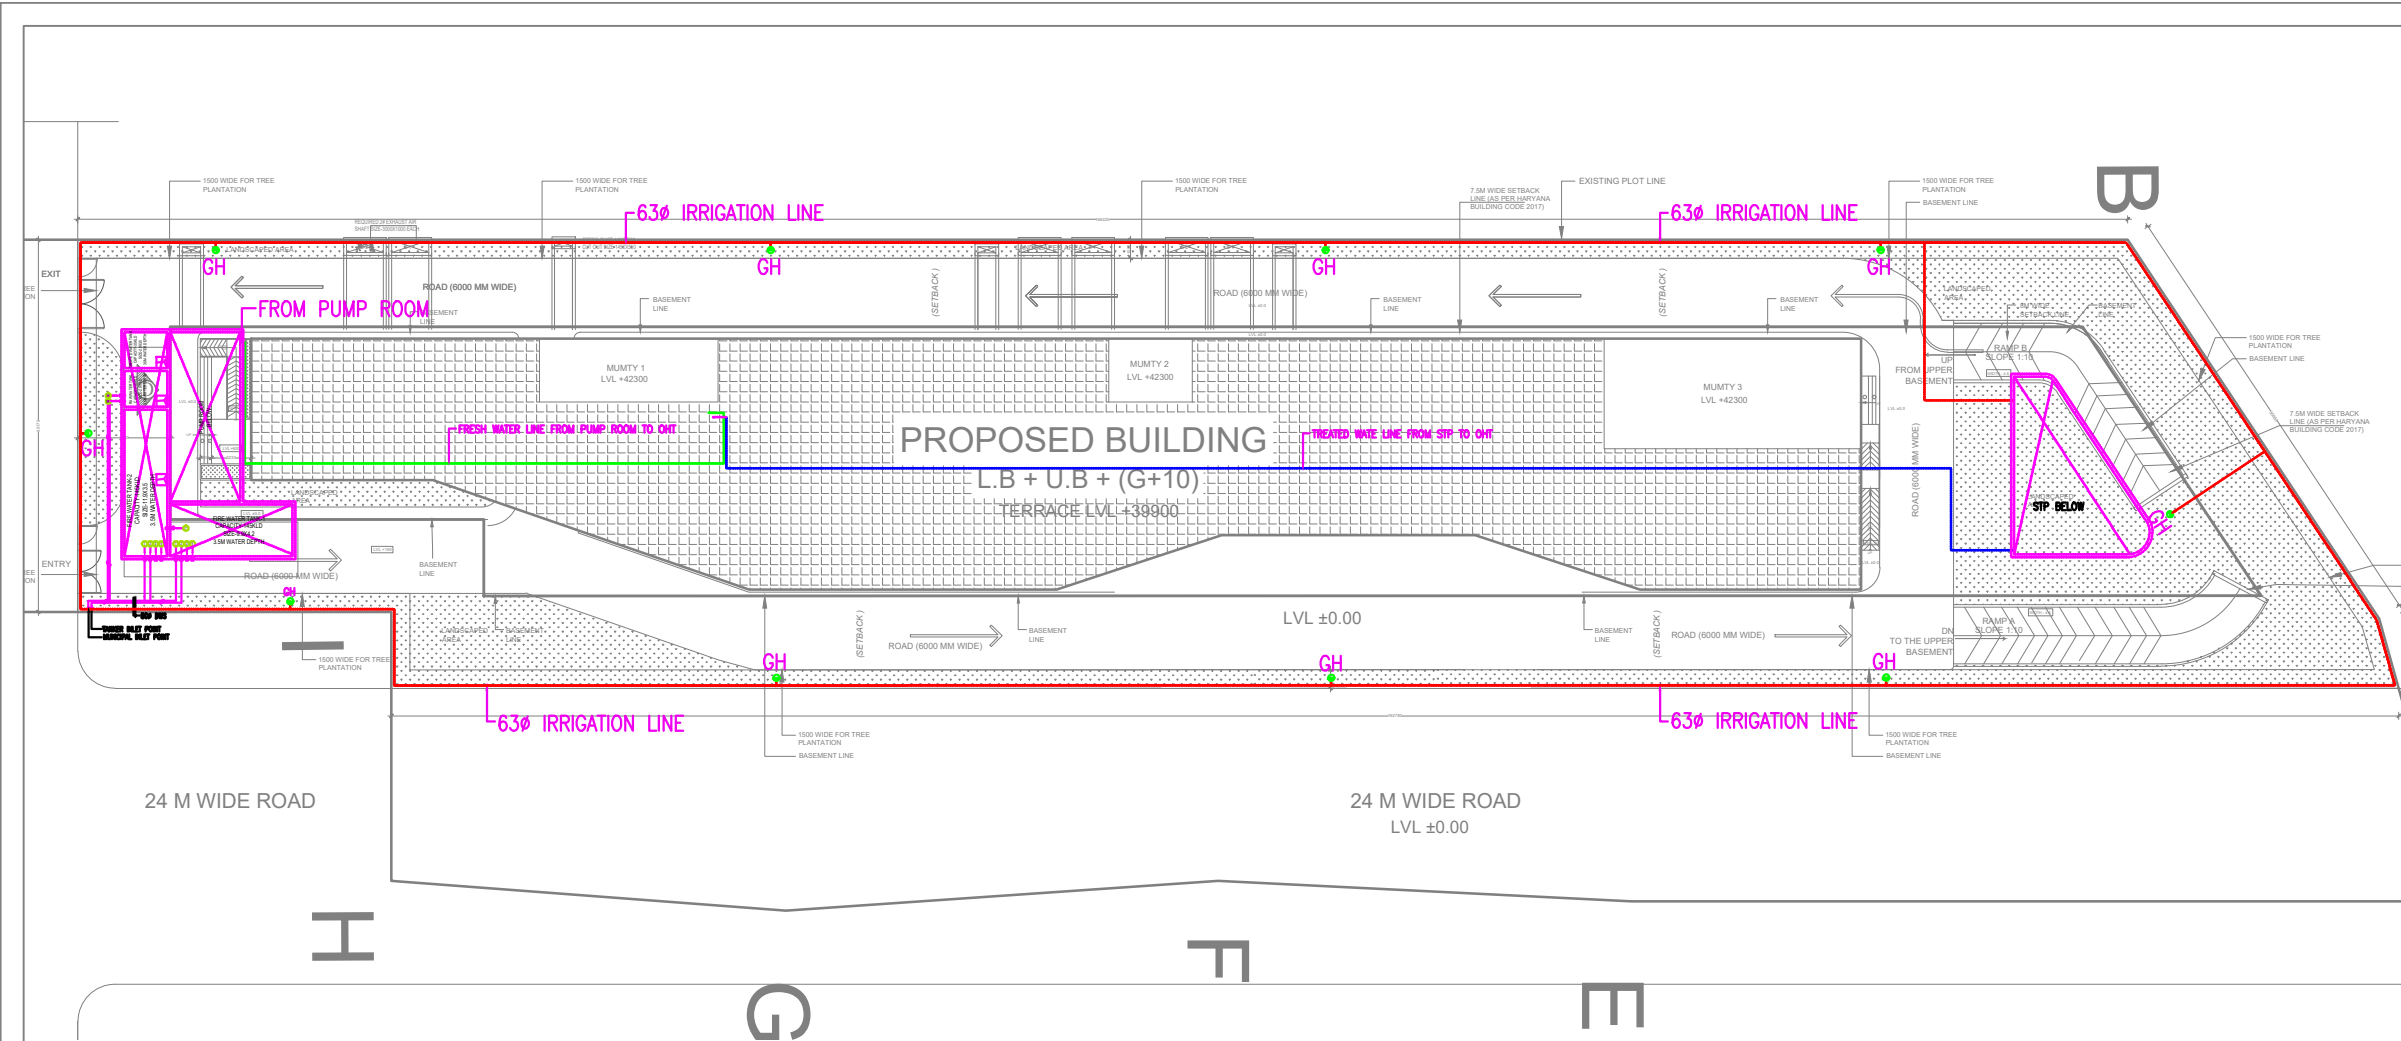

PLUMBING LEGEND	
S. No.	DESCRIPTION
1	FRESH WATER LINE
2	TREATED WATER LINE
3	IRRIGATION WATER LINE

KEY PLAN:1

MEP CONSULTANT
INNOVATIVE CONSULTING ENGINEERS
G79/3, 2nd Floor
Jasola-Kalindi Kunj Road,
New Delhi-110025
Ph: 011-26941605
Email :- innovative.FF@gmail.com

PROJECT:
COMMERCIAL COLONY AREA MEASURING
2.625 ACRES IN SECTOR 34, SOHNA BEING
DEVELOP BY SMT. MONIKA RAIZADA W/O SH.
NAVEEN RIZADA IN COLLABORATION WITH
NAVI ESTATES LLP.
(LICENCE NO 79. OF 2018 DATED 17/11/2018)

CLIENT: NAVI ESTATES, LLP
NEW DELHI

REVISION SCHEDULE:		
SNO	NOTES	DATED

ARCHITECT SIG:	OWNER SIG:

BUILDING TYPE: COMMERCIAL


GENERAL NOTES:
1. All dimensions are in MM
2. Only vertical dimensions should be followed
3. All dimensions should be checked and verified before execution, inconsistency if any should be brought to the notice of the architect.

DRAWING TITLE: WATER SUPPLY & IRRIGATION LAYOUT

DRAWING NO: WS-01
DATE: 21/04/2021

SCALE: 1:375@A2
NORTH:

 **STHAPATI ASSOCIATES (P) LTD.**
architects,interior designers,
landscape consultants,
& project consultants.
Lucknow Studio: 1/24, Vipul Khand, Gomti Nagar, Lucknow
Ph no.0522 - 4027793
Delhi Studio: T - 34/ 702, Common Wealth Games Village,
Delhi - 110082
Ph no. 011 - 21211409

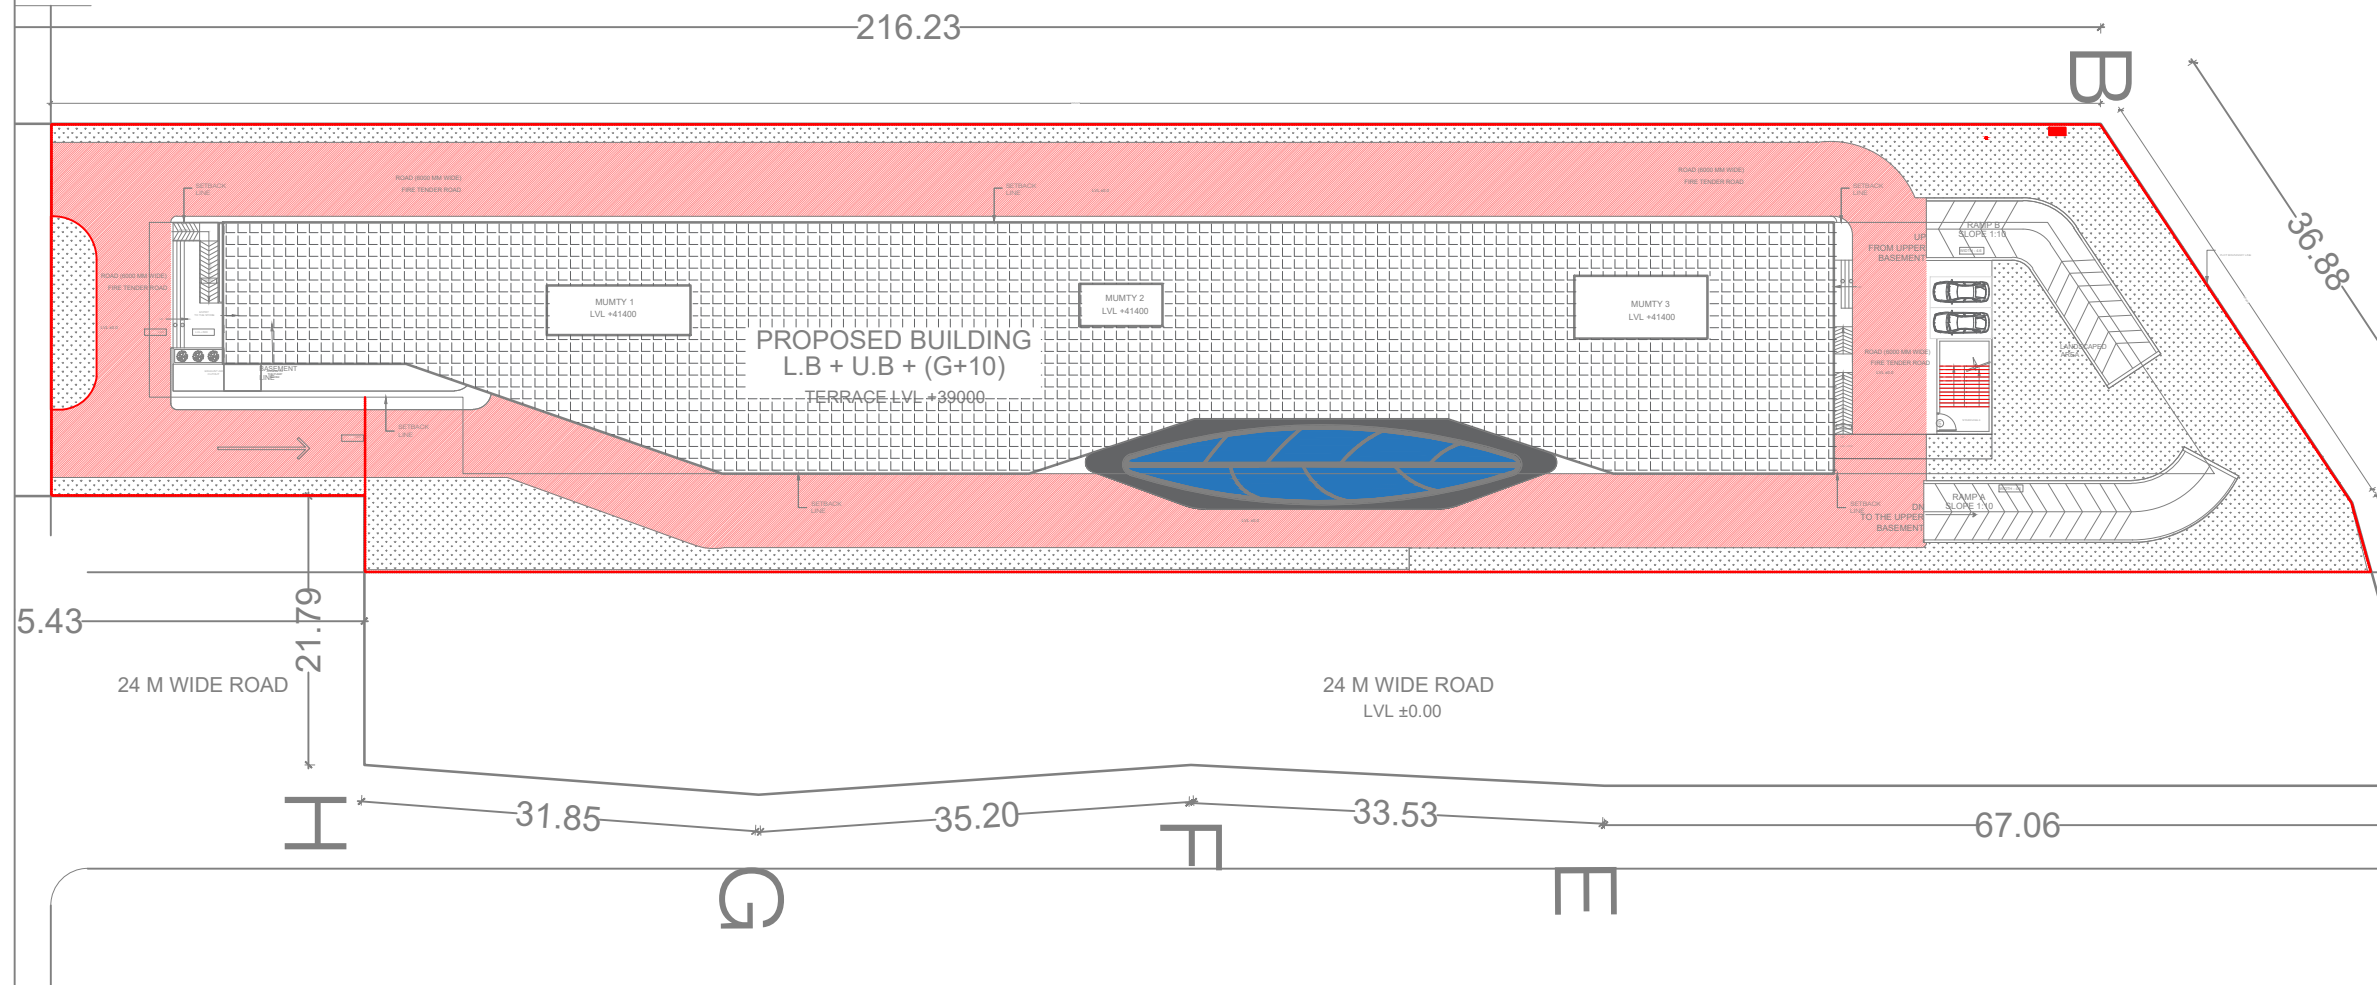

LEGEND	
	6M WIDE PERIPHERAL ROAD ALL AROUND THE BUILDING

KEY PLAN:1

MEP CONSULTANT
INNOVATIVE CONSULTING ENGINEERS
G79/3, 2nd Floor
Jasola-Kalindi Kunj Road,
New Delhi-110025
Ph: 011-26941605
Email :- innovative.FF@gmail.com

PROJECT:
COMMERCIAL COLONY AREA MEASURING 2.625 ACRES IN SECTOR 34, SOHNA BEING DEVELOPED BY SMT. MONIKA RAIZADA W/O SH. NAVEEN RIZADA IN COLLABORATION WITH NAVI ESTATES LLP.
(LICENCE NO 79. OF 2018 DATED 17/11/2018)

CLIENT: NAVI ESTATES, LLP
NEW DELHI

REVISION SCHEDULE:		
SNO	NOTES	DATED

ARCHITECT SIG:	OWNER SIG:

BUILDING TYPE: COMMERCIAL

GENERAL NOTES:
1. All dimensions are in MM
2. Only vertical dimensions should be followed
3. All dimensions should be checked and verified before execution. Inconsistency if any should be brought to the notice of the architect.

DRAWING TITLE: ROAD LAYOUT

DRAWING NO: FF-01
DATE: 21/04/2021

SCALE: 1:300@A3
NORTH:

STHAPATI ASSOCIATES (P) LTD.
architects,interior designers,
landscape consultants,
& project consultants.
Lucknow Studio: 1/24, Vipul Khand, Gomti Nagar, Lucknow
Ph no.0522 - 4027793
Delhi Studio: T - 34/ 702, Common Wealth Games Village,
Delhi - 110082
Ph no. 011 - 21211409