



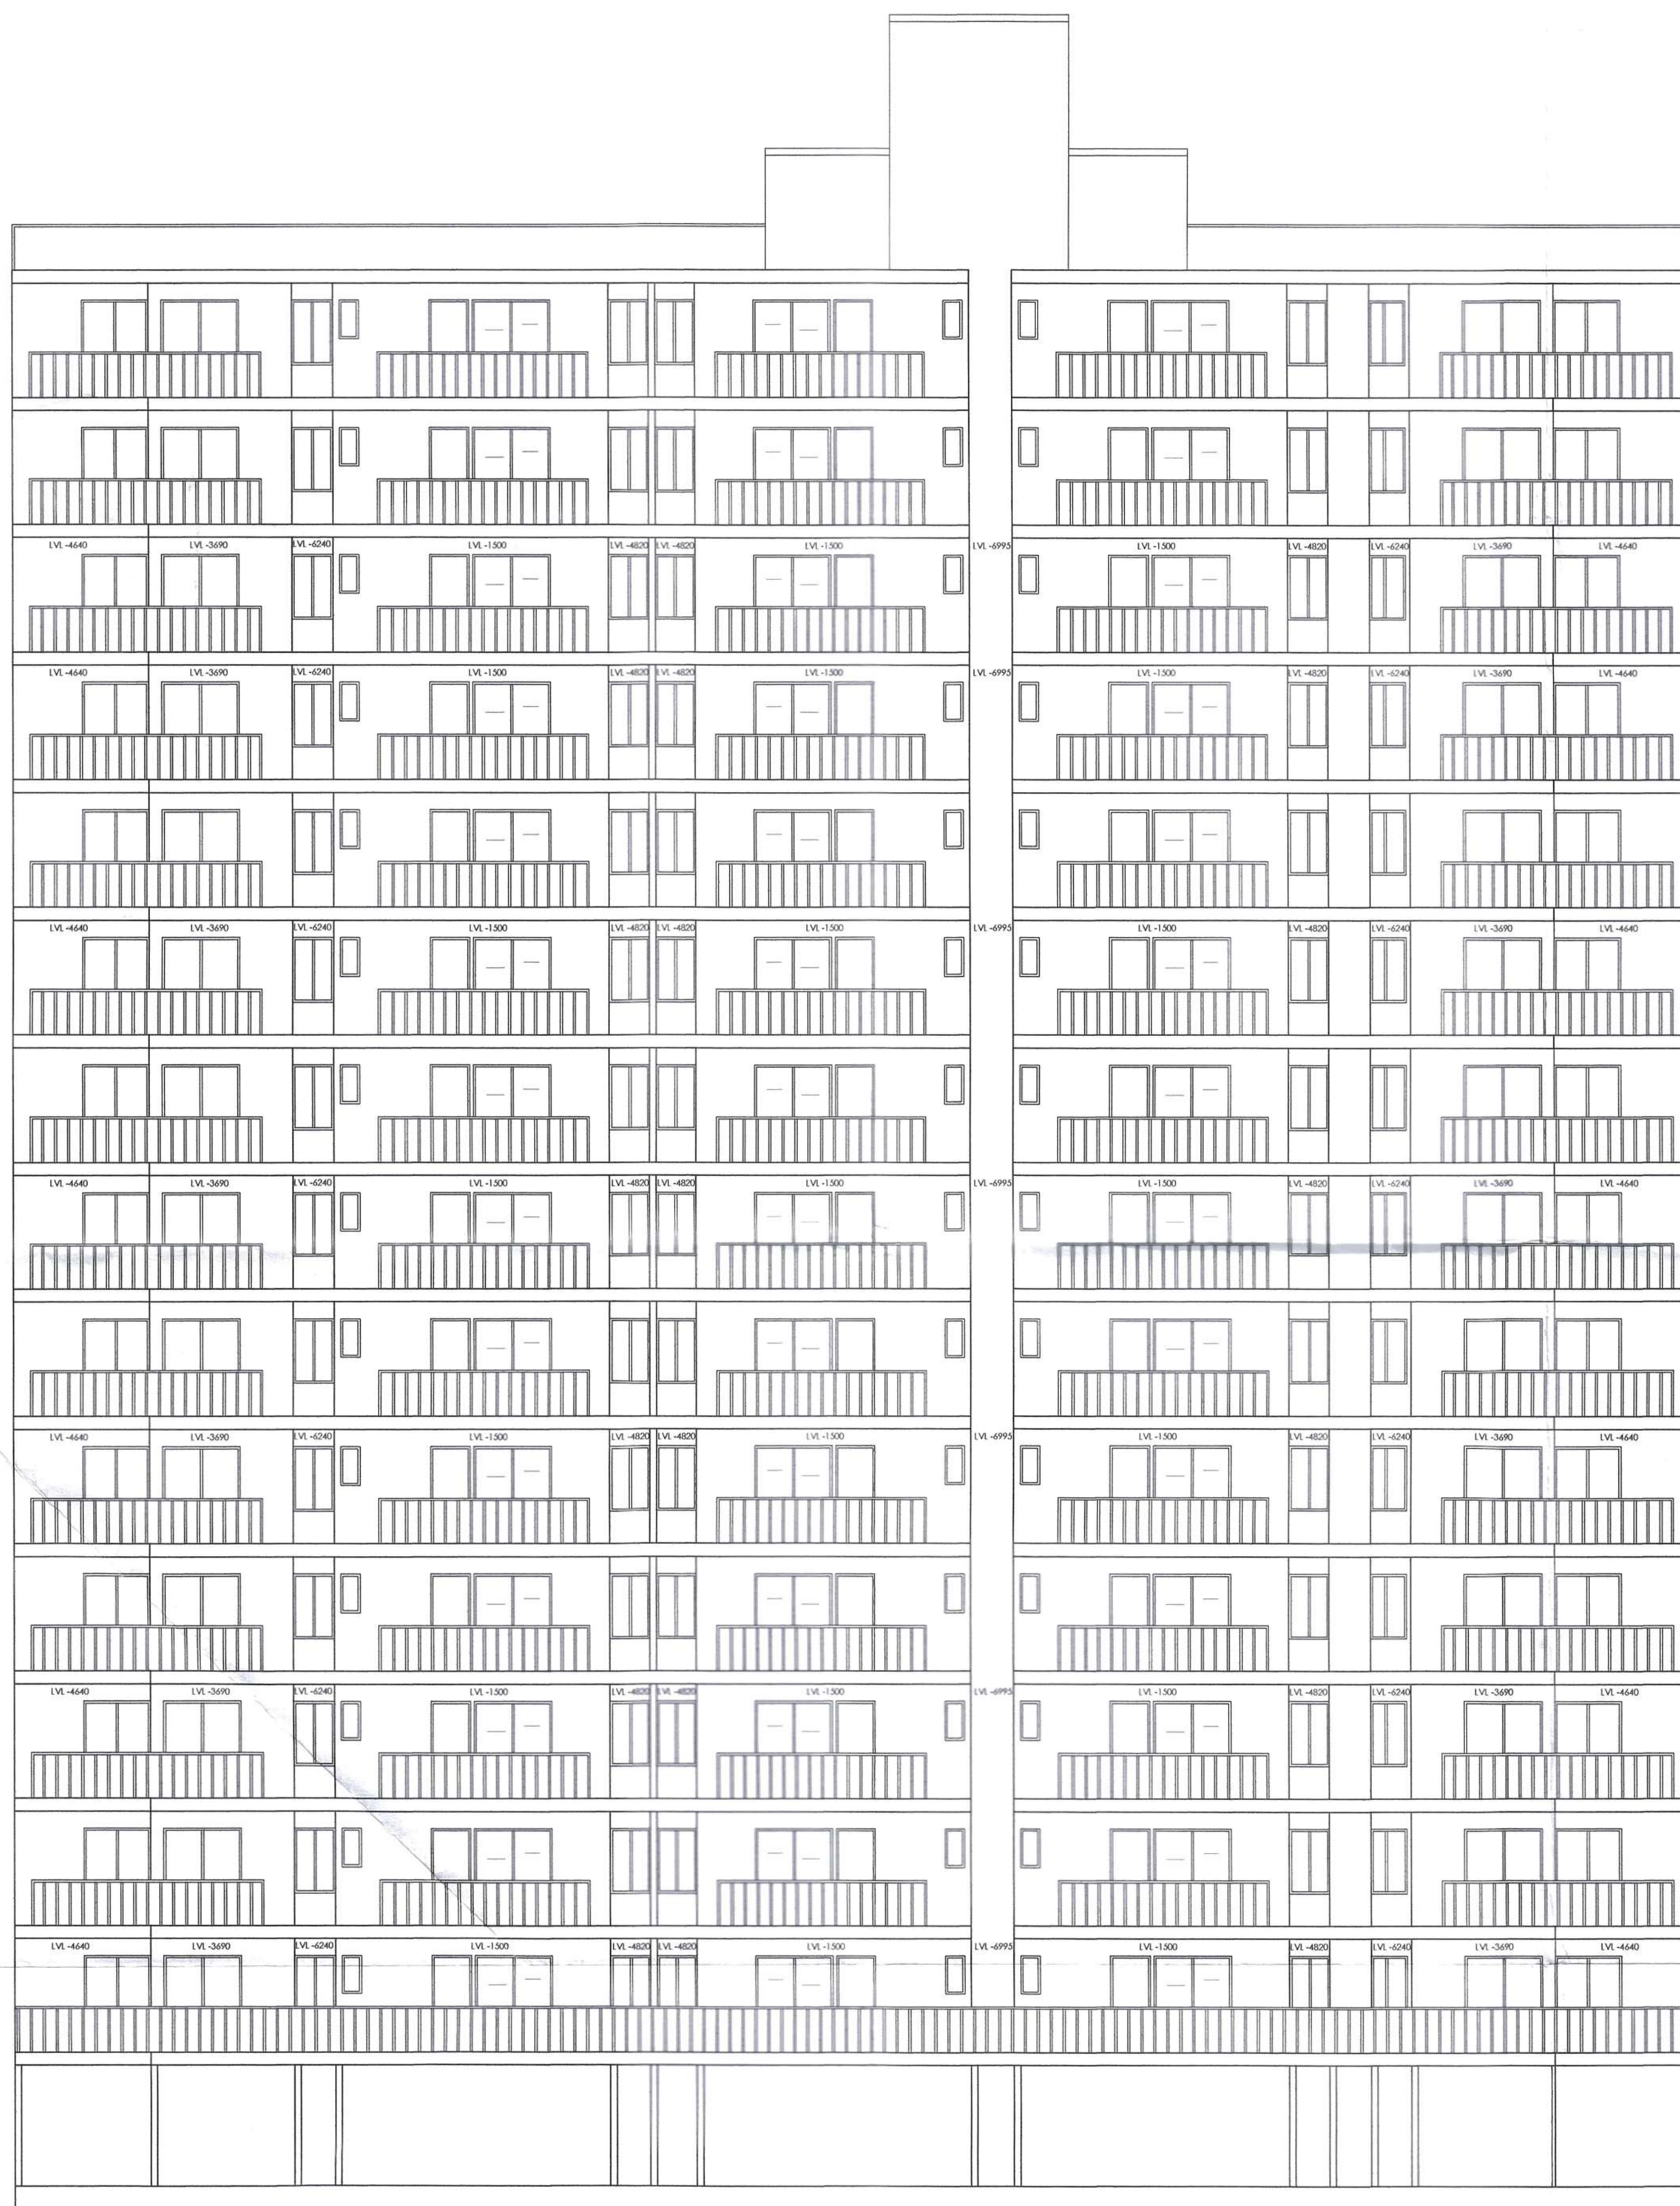


ELEVATION AT E2&E4

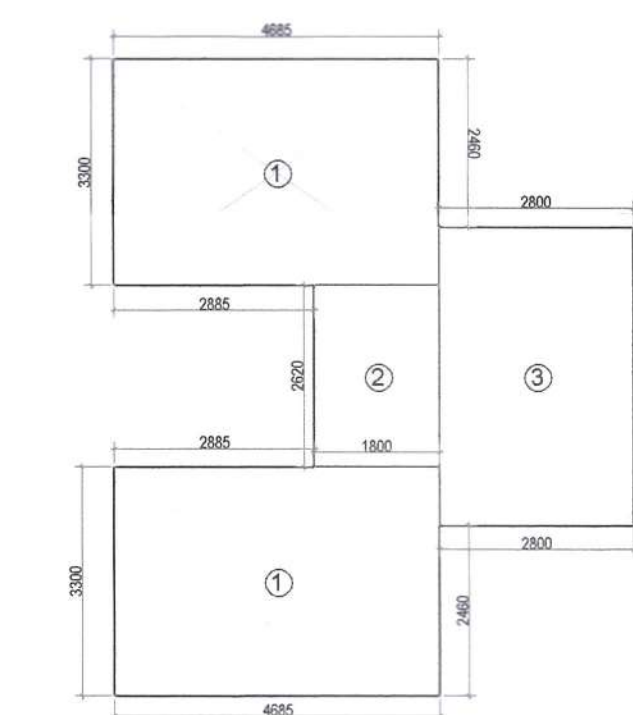


MUMTY MACHINE ROOM NON FAR AREA CHART

S.NO.	DESCRIPTION	AREA
1	2 X 4.685 X 3.300	= 30.92
2	1 X 1.800 X 2.520	= 4.52
3	1 X 2.800 X 4.300	= 12.04
TOTAL FAR		47.48

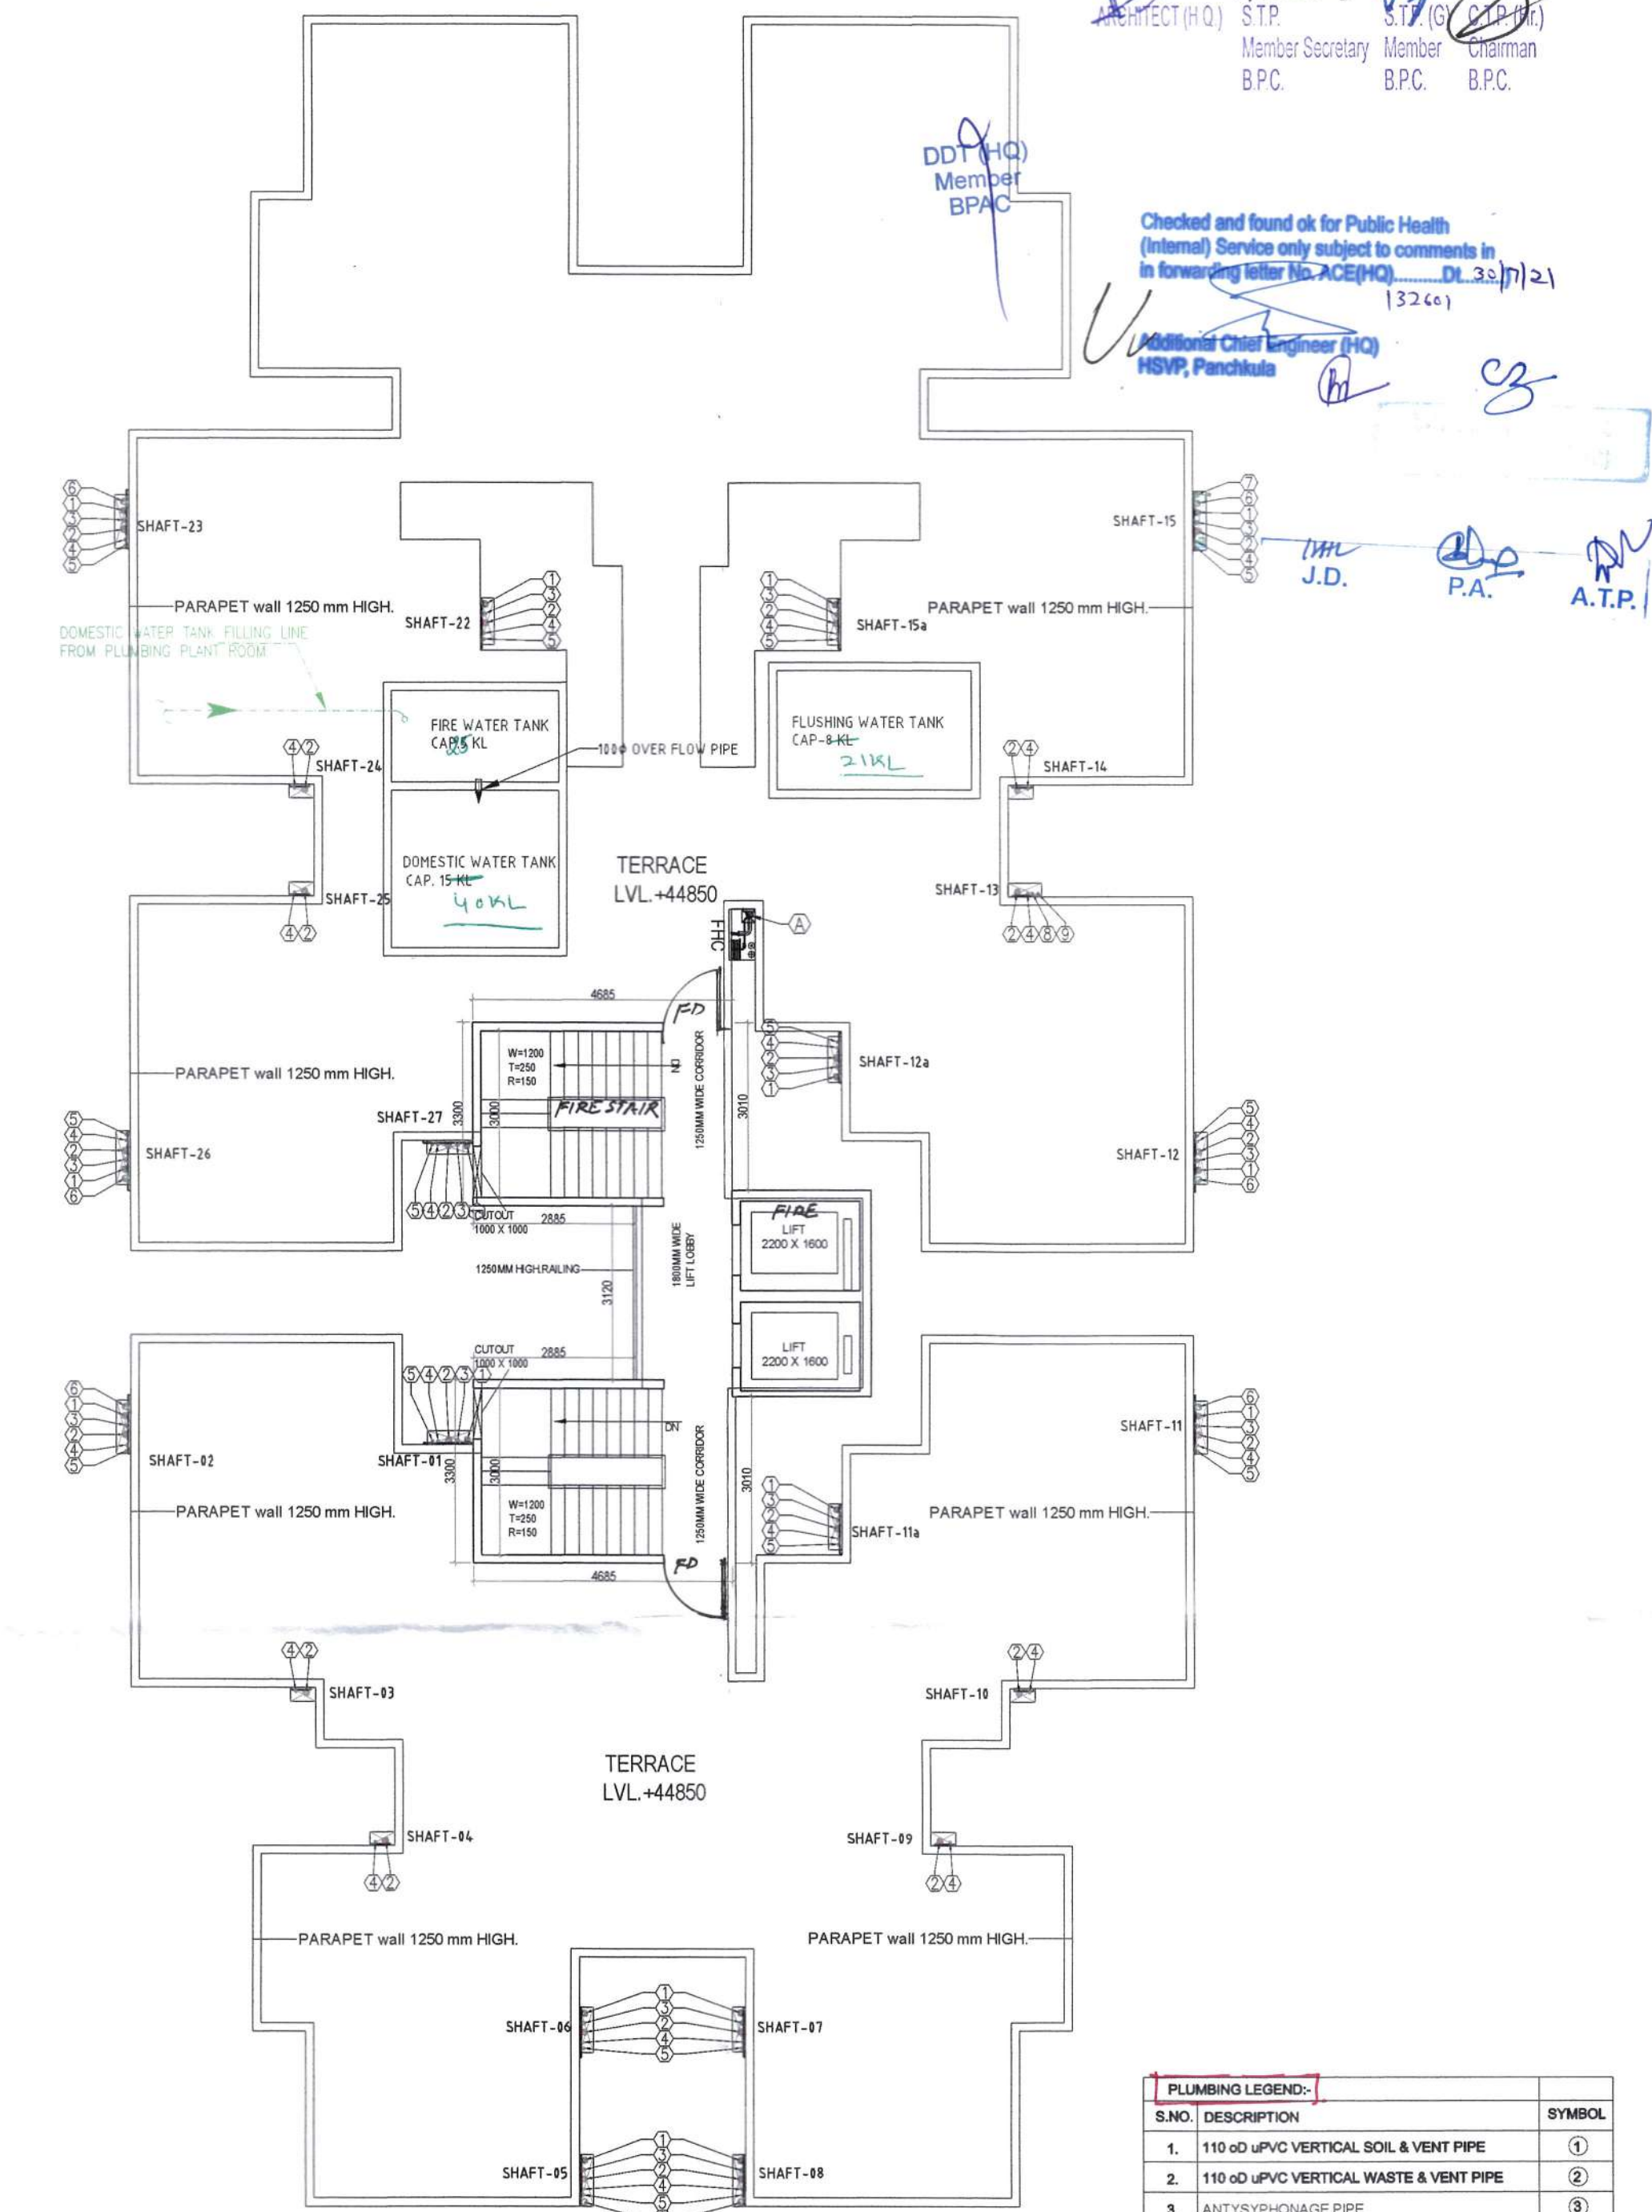

TERRACE FLOOR PLAN

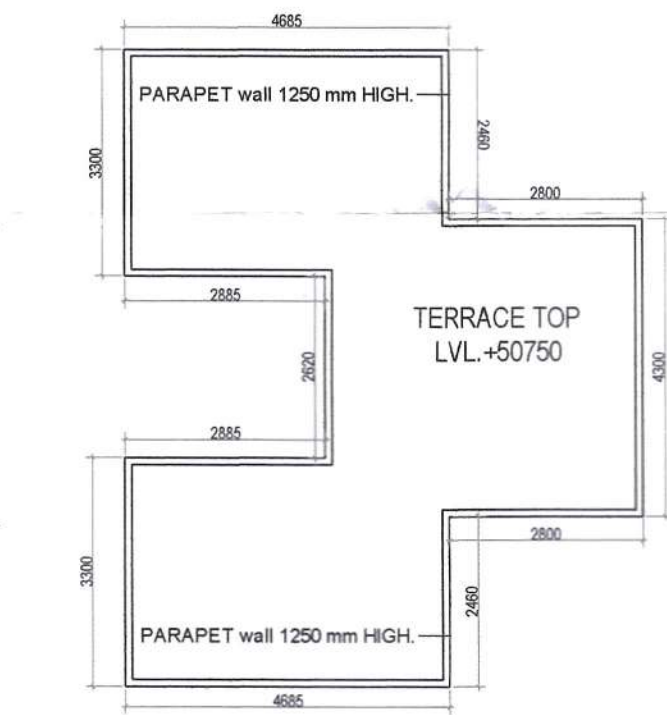

TERRACE TOP LVL. +50750

PLUMBING LEGEND:

S.NO.	DESCRIPTION	SYMBOL
1.	110 o.d UPVC VERTICAL SOIL & VENT PIPE	①
2.	110 o.d UPVC VERTICAL WASTE & VENT PIPE	②
3.	ANTI-SIPHONAGE PIPE	③
4.	DOMESTIC WATER SUPPLY DOWN TAKE PIPE	④
5.	FLUSHING WATER SUPPLY DOWN TAKE PIPE	⑤
6.	110 o.d UPVC RAIN WATER PIPE FOR TERRACE	⑥
7.	75 o.d UPVC RAIN WATER BALCONY DRAIN PIPE	⑦
8.	DOMESTIC WATER SUPPLY RISER PIPE	⑧
9.	FLUSHING WATER SUPPLY RISER PIPE	⑨
10.	FLOOR TRAP	FT
11.	FLOOR DRAIN	FD
12.	FLOOR CLEAN OUT	FCO
13.	COLD WATER SUPPLY (DOMESTIC)	CWB
14.	FLUSHING WATER SUPPLY	FWS
15.	ISOLATION VALVE	IV

CLIENT:- M/S GLS INFRAPROJECTS PVT. LTD.

PROJECT :-

ARCHITECTS
Primada Architects Pvt. Ltd.
G28, SECTOR 14, GURGAON
HARYANA

SCALE : 1:100
DRAWING NAME
TOWER-5
TYPICAL FLOOR PLAN & AREA
DIAGRAM & UNITS PLAN & AREA

DRAWING NO. SUB-13

For GLS INFRAPROJECTS PVT. LTD.

APPLICANT'S SIGN.

VIMAL BAJAJ
Architect CA/96/19791
938, Sector 14, Gurgaon
ARCHITECT'S SIGN

ARCHITECT (H.O.) S.T.P. (G) S.T.P. (H)
Member Secretary Member Chairman
B.P.C. B.P.C. B.P.C.
Checked and found ok for Public Health
(Internal) Service only subject to comments in
in forwarding letter No. ACE(HQ) DL 32/7/21
Additional Chief Engineer (H.O.)
HSVP, Panchkula