
 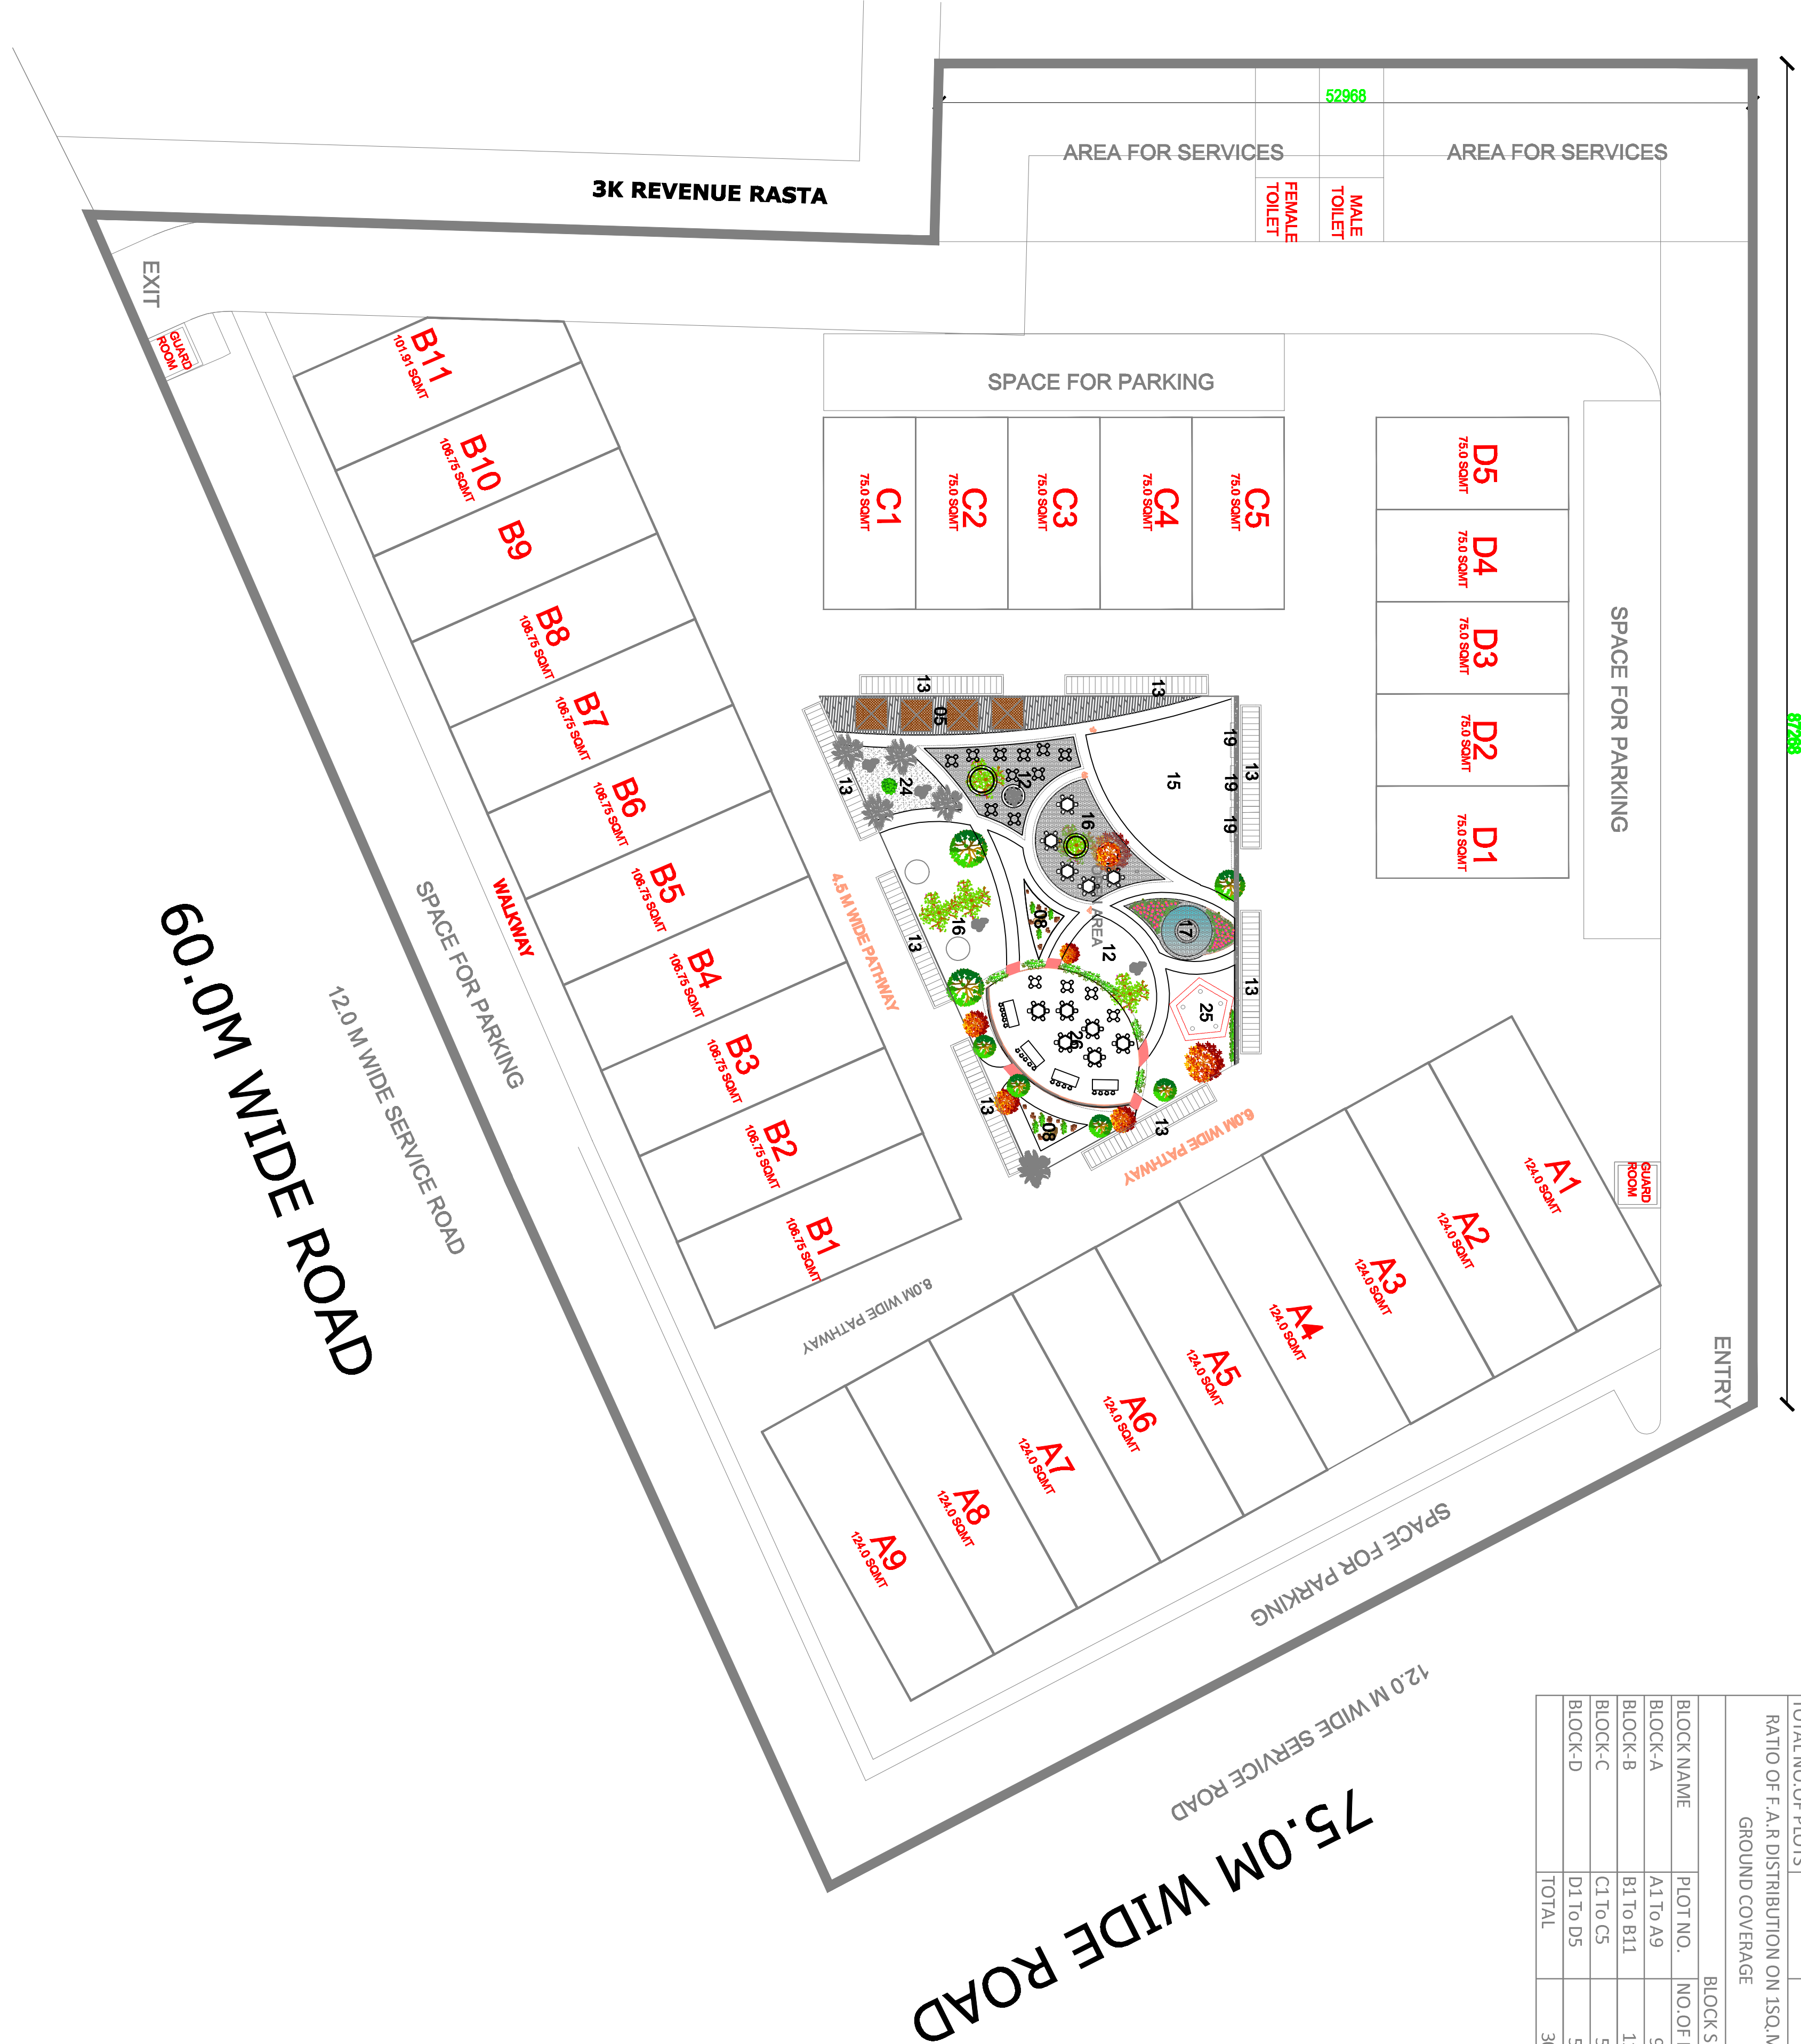


S.N.	PLUMBING LEGENDS:-	
01	DOMESTIC WATER SUPPLY	
02	IRRIGATION LINE	
03	GARDEN HYDRANT	⊕ GH
04	VALVE CHAMBER	

AREA DESCRIPTION				
DESCRIPTION	FACTOR	ACRES	SQ.MT	
SITE AREA		2.143	8672.602	
PERMISSIBLE G.C	35%	0.750	3035.411	
PERMISSIBLE F.A.R	1.5		13008.903	
PROPOSED G.C	35%		3035.410	
PROPOSED F.A.R	1.5		13008.857	
TOTAL NO.OF PLOTS			30	
RATIO OF F.A.R DISTRIBUTION ON 1SQ.MT OF GROUND COVERAGE			4.2875	
BLOCK SUMMARY				
BLOCK NAME	PLOT NO.	NO.OF PLOTS	PROPOSED G.C	PROPOSED F.A.R
BLOCK-A	A1 To A9	9	1116.00	4782.8412
BLOCK-B	B1 To B11	11	1169.41	5011.740437
BLOCK-C	C1 To C5	5	375.00	1607.1375
BLOCK-D	D1 To D5	5	375.00	1607.1375
	TOTAL	30	3035.41	13008.857



MEP CONSULTANTS			
 ONE DESIGN & CONSULTANTS E-175, SECTOR-63 NOIDA, UTTAR PRADESH E-MAIL:- onedesignconsultants@gmail.com web mail:- info@onedesignconsultants.com			
PROJECT NAME & ADDRESS :			
SITE PLAN OF PROPOSED LICENSED FOR SETTING UP COMMERCIAL PLOTTED COLONY ON AN AREA MEASURING 2.143 ACRES IN THE REVENUE ESTATE OF VILLAGE BADHA,SECTOR-93, GURUGRAM-DIVERSE			
DEVELOPED BY			
M/S DIVERSE DEVELOPERS LLP			
ARCHITECT'S SIGNATURE :		OWNERS SIGNATURE :	
DRAWING TITLE : EXT.WATER SUPPLY LAYOUT SITE PLAN			
DRAWING NO:-	DRN. BY:-	S.K.	NORTH :
ODC-PL-WSL-04	CHD. BY:-	A.S.	N
SCALE : 1 : 450		DATE:-31-07-2021	REV NO.:- R3
			