
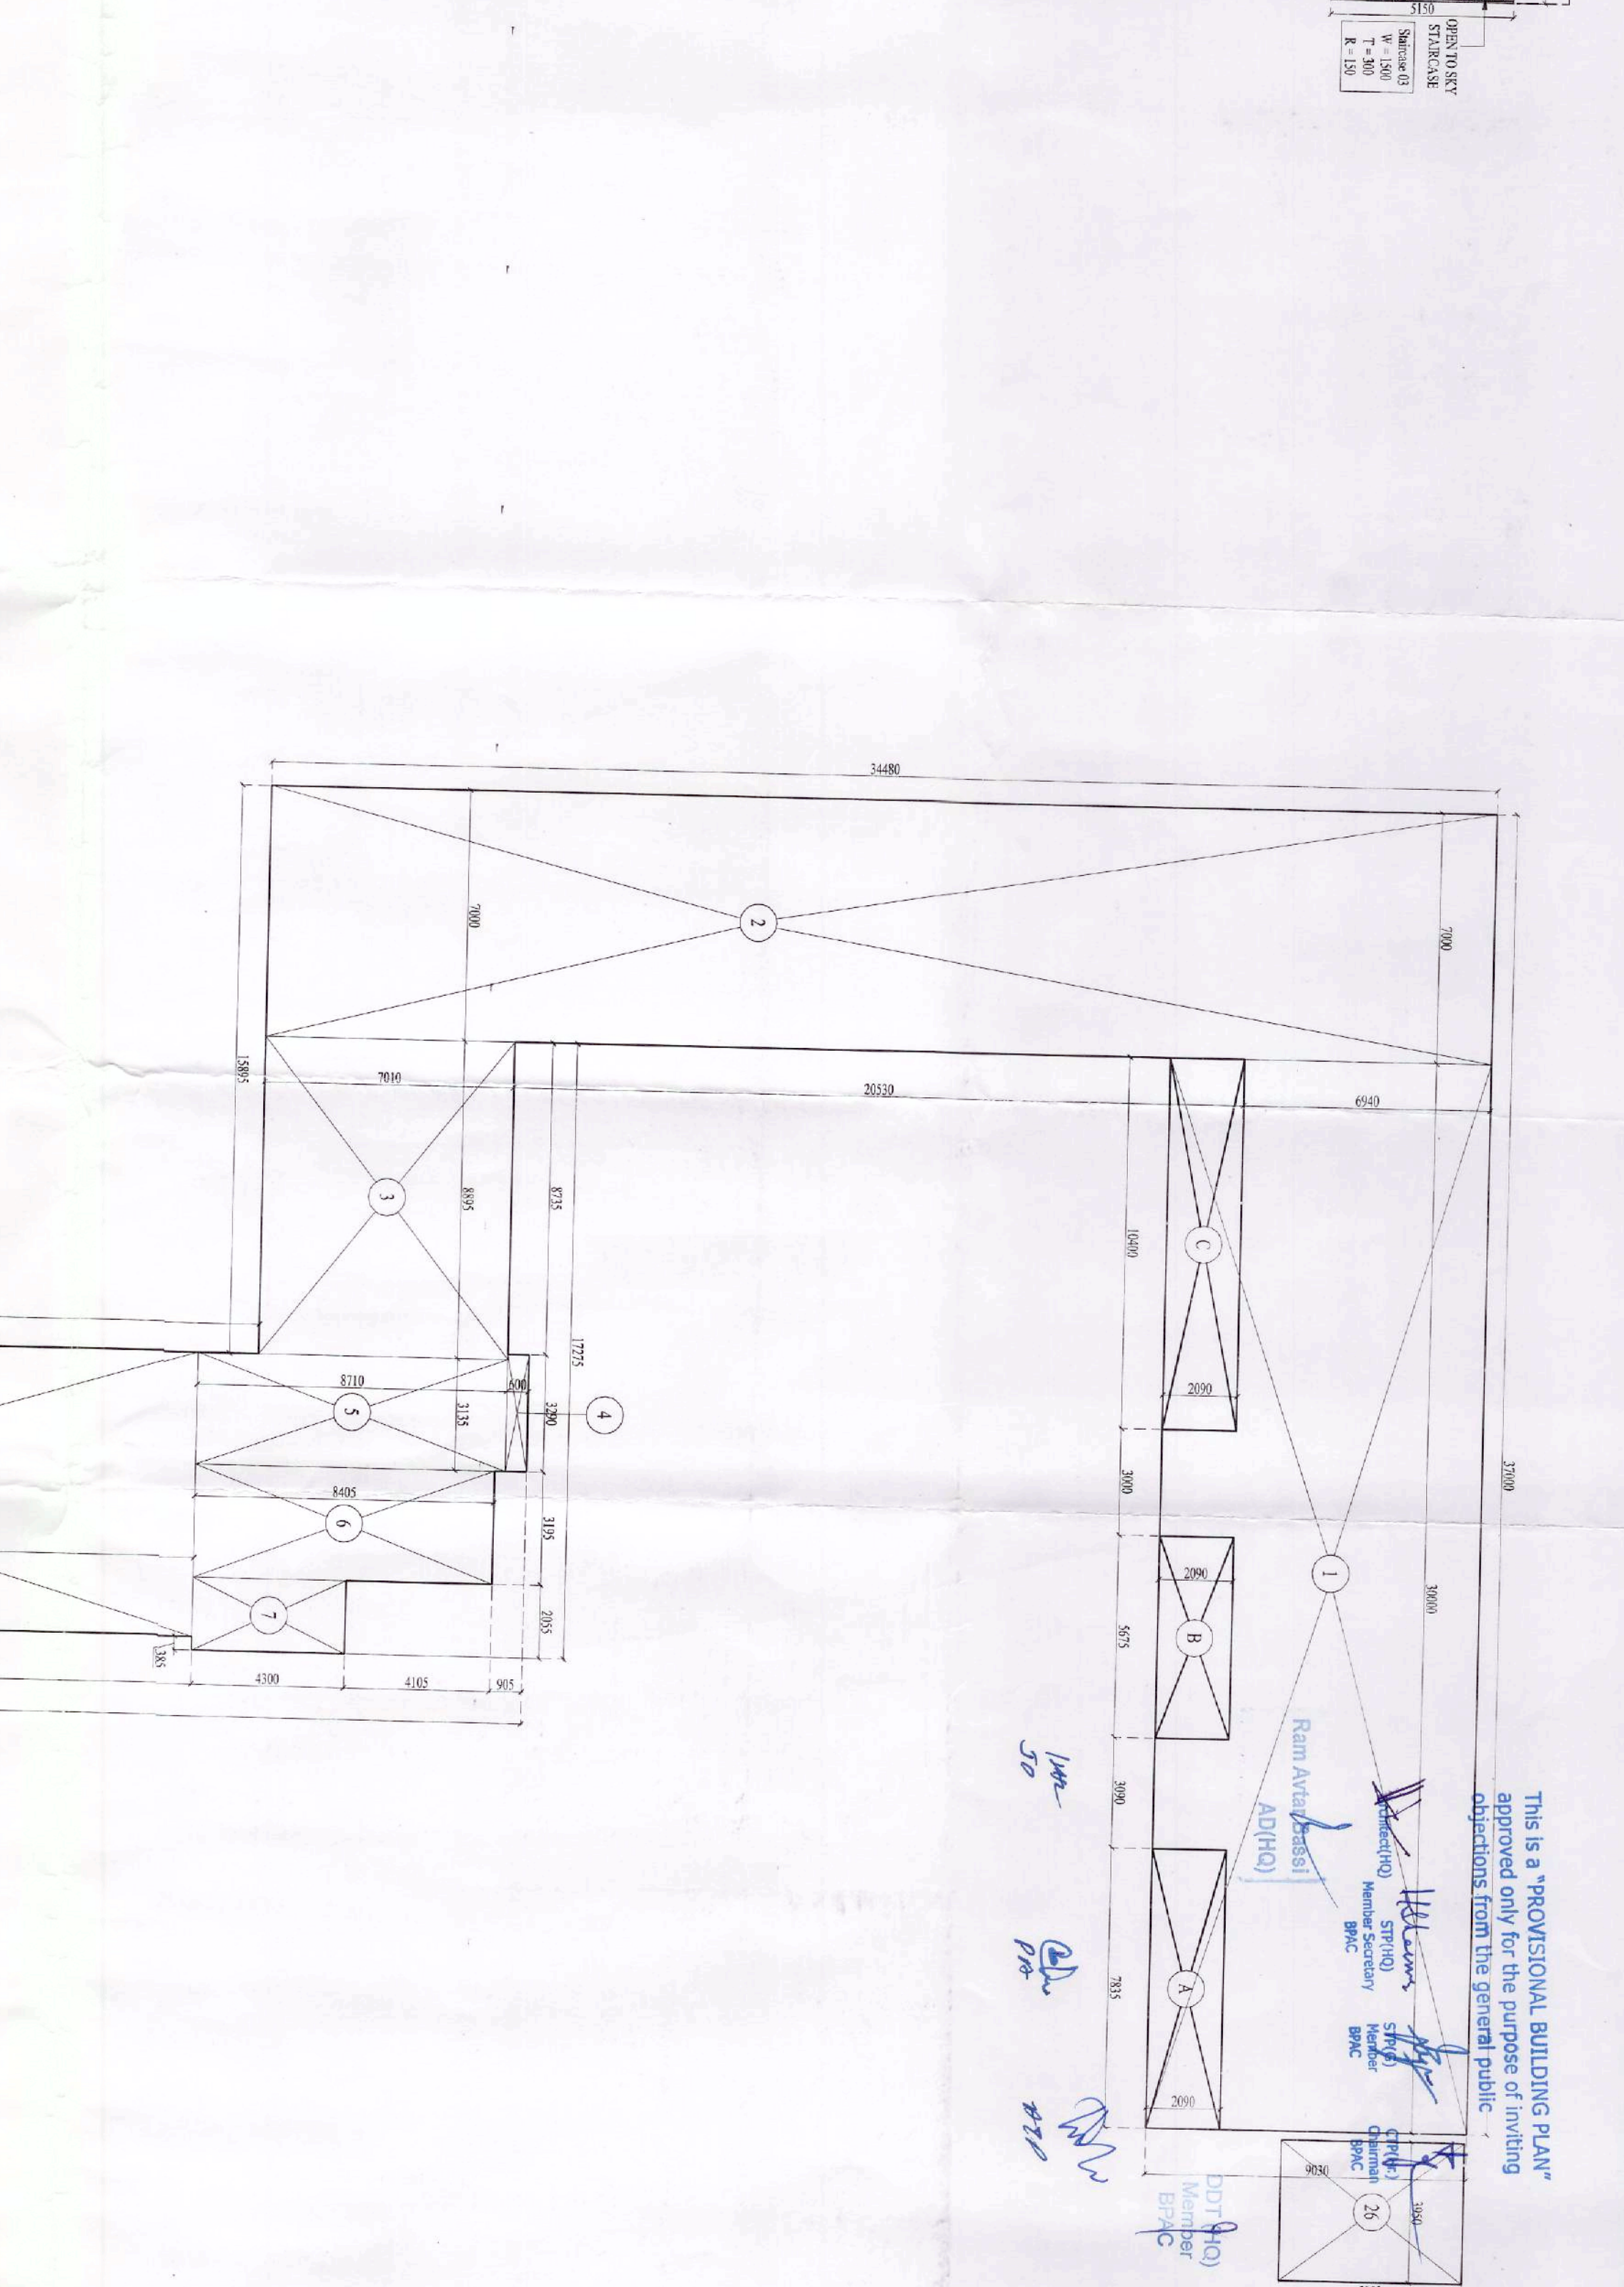


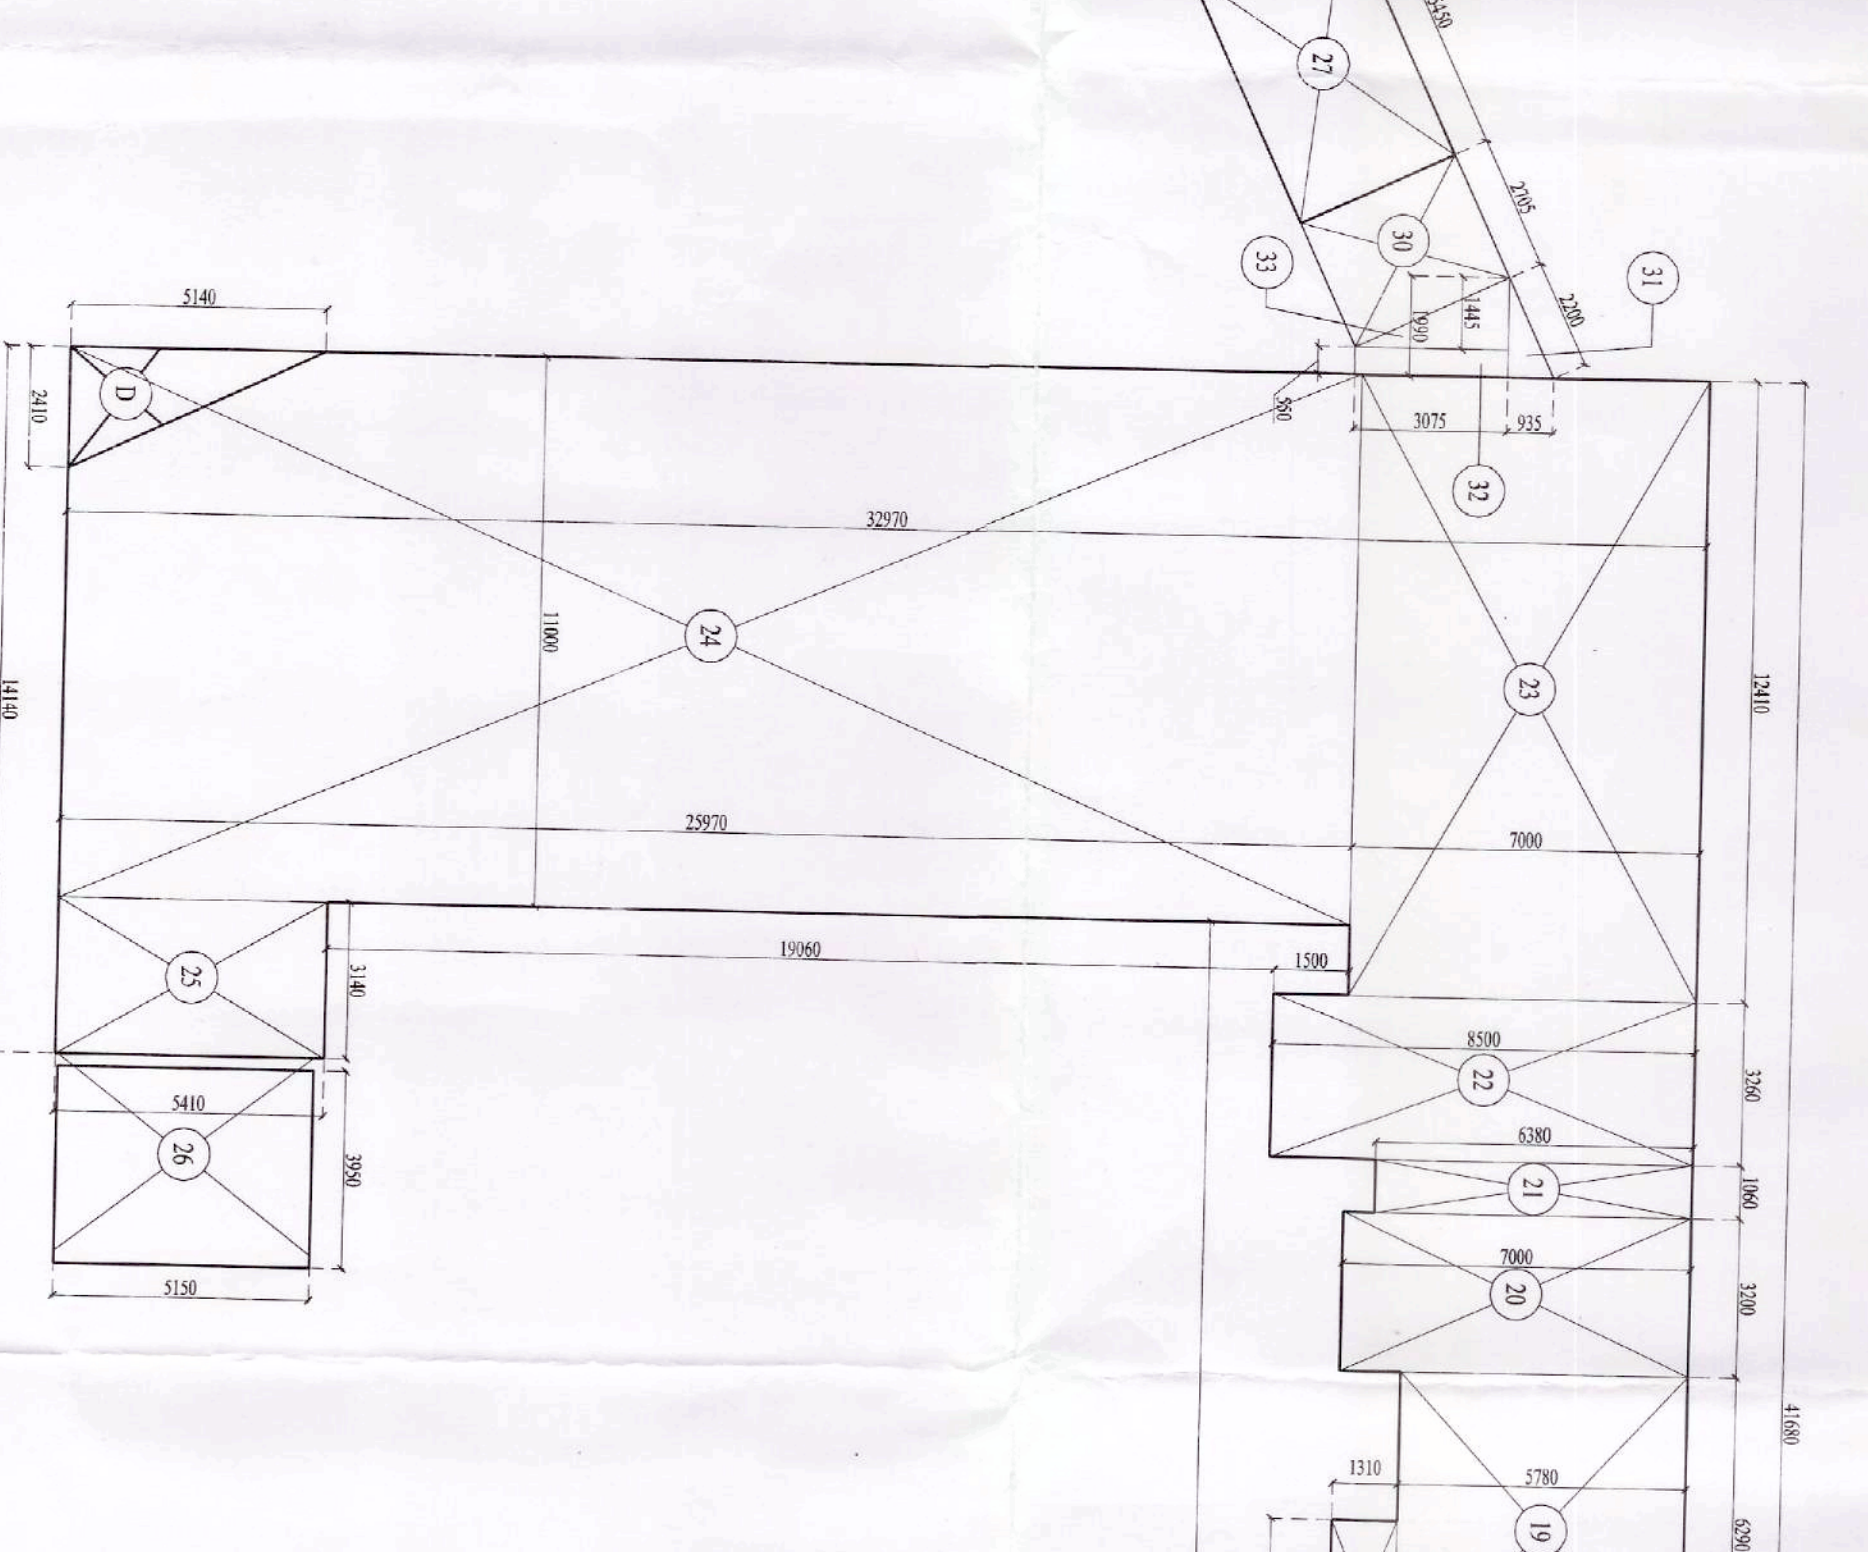

1. TOTAL ADDITION	664,457
2. DEDUCTION - Y*	

					TOTAL F.A.R. AREA IN BASEMENT
		2. TOTAL DEDUCTION			
		ADDITION (XV)	DEDUCTION	SOL.	614.387
1	Rectangular	5.100	19.890	1	19.890
2	Rectangular	2.000	L.X.B 4.000	2	8.000
3	Rectangular	6.600	1 X B 21.780	1	21.780

RESIDENT SANITARY REQUIREMENT

[illegible]

GENERAL COVERAGE									
AREA VARIATION OF COMBINED AREA BUILDING:									
1	BASEMENT FLOOR	1	1	1	1	1	1	1	1
2	BASEMENT FLOOR	2	2	2	2	2	2	2	2
3	FIRST FLOOR FLOOR	3	3	3	3	3	3	3	3
4	FIRST FLOOR FLOOR	4	4	4	4	4	4	4	4
5	FIRST FLOOR FLOOR	5	5	5	5	5	5	5	5
6	FIRST FLOOR FLOOR	6	6	6	6	6	6	6	6
7	FIRST FLOOR FLOOR	7	7	7	7	7	7	7	7
8	FIRST FLOOR FLOOR	8	8	8	8	8	8	8	8
9	FIRST FLOOR FLOOR	9	9	9	9	9	9	9	9
10	FIRST FLOOR FLOOR	10	10	10	10	10	10	10	10
11	FIRST FLOOR FLOOR	11	11	11	11	11	11	11	11
12	FIRST FLOOR FLOOR	12	12	12	12	12	12	12	12
13	FIRST FLOOR FLOOR	13	13	13	13	13	13	13	13
14	FIRST FLOOR FLOOR	14	14	14	14	14	14	14	14
15	FIRST FLOOR FLOOR	15	15	15	15	15	15	15	15
16	FIRST FLOOR FLOOR	16	16	16	16	16	16	16	16
17	FIRST FLOOR FLOOR	17	17	17	17	17	17	17	17
18	FIRST FLOOR FLOOR	18	18	18	18	18	18	18	18
19	FIRST FLOOR FLOOR	19	19	19	19	19	19	19	19
20	FIRST FLOOR FLOOR	20	20	20	20	20	20	20	20
21	FIRST FLOOR FLOOR	21	21	21	21	21	21	21	21
22	FIRST FLOOR FLOOR	22	22	22	22	22	22	22	22
23	FIRST FLOOR FLOOR	23	23	23	23	23	23	23	23
24	FIRST FLOOR FLOOR	24	24	24	24	24	24	24	24
25	FIRST FLOOR FLOOR	25	25	25	25	25	25	25	25
26	FIRST FLOOR FLOOR	26	26	26	26	26	26	26	26
27	FIRST FLOOR FLOOR	27	27	27	27	27	27	27	27
28	FIRST FLOOR FLOOR	28	28	28	28	28	28	28	28
29	FIRST FLOOR FLOOR	29	29	29	29	29	29	29	29
30	FIRST FLOOR FLOOR	30	30	30	30	30	30	30	30
31	FIRST FLOOR FLOOR	31	31	31	31	31	31	31	31
32	FIRST FLOOR FLOOR	32	32	32	32	32	32	32	32
33	FIRST FLOOR FLOOR	33	33	33	33	33	33	33	33
34	FIRST FLOOR FLOOR	34	34	34	34	34	34	34	34
35	FIRST FLOOR FLOOR	35	35	35	35	35	35	35	35
36	FIRST FLOOR FLOOR	36	36	36	36	36	36	36	36
37	FIRST FLOOR FLOOR	37	37	37	37	37	37	37	37
38	FIRST FLOOR FLOOR	38	38	38	38	38	38	38	38
39	FIRST FLOOR FLOOR	39	39	39	39	39	39	39	39
40	FIRST FLOOR FLOOR	40	40	40	40	40	40	40	40
41	FIRST FLOOR FLOOR	41	41	41	41	41	41	41	41
42	FIRST FLOOR FLOOR	42	42	42	42	42	42	42	42
43	FIRST FLOOR FLOOR	43	43	43	43	43	43	43	43
44	FIRST FLOOR FLOOR	44	44	44	44	44	44	44	44
45	FIRST FLOOR FLOOR	45	45	45	45	45	45	45	45
46	FIRST FLOOR FLOOR	46	46	46	46	46	46	46	46
47	FIRST FLOOR FLOOR	47	47	47	47	47	47	47	47
48	FIRST FLOOR FLOOR	48	48	48	48	48	48	48	48
49	FIRST FLOOR FLOOR	49	49	49	49	49	49	49	49
50	FIRST FLOOR FLOOR	50	50	50	50	50	50	50	50

PROJECT

RENOVATED BUILDING PLAN OF AFFORDABLE HOUSING
FOR THE LOW- AND MIDDLE- INCOME GROUPS
ACROSS THE NINE PROVINCES OF MALAYSIA
SECTION 7C, GEMILANG MANSION, BERKAS COMPOUND
BENING DEVELOPMENT BY REINAKA HARBERS PVT LTD
(LC-2019)

RENOVATED BUILDING PLAN OF AFFORDABLE HOUSING
FOR THE LOW- AND MIDDLE- INCOME GROUPS
ACROSS THE NINE PROVINCES OF MALAYSIA
SECTION 7C, GEMILANG MANSION, BERKAS COMPOUND
BENING DEVELOPMENT BY REINAKA HARBERS PVT LTD
(LC-2019)

PLUMBING LEGEND

- ① 100 mm dia Soil & Sewer Pipe
- ② 100 mm dia Waste Water Pipe
- ③ 75 mm dia Air Vent Pressure Pipe
- ④ 100 mm dia Siphon & Rain Water Pipe
- ⑤ Domestic Water Rise
- ⑥ Pressurized Water Rise
- ⑦ Domestic Water Drainage
- ⑧ Flushing Water Drainage

Basement				
SN	TOOLS	WIDTH	CEL	INTEL.
1	D1	759	400	2306
2	D2	930	400	2109
3	D3	1200	400	2110
4	D4	1500	400	2300
5	G01	2085	110	2400
6	G02	6000	440	2400

4	CD	2000	±0	2000	2000
5	CD	2000	±0	2000	2000
6	CD	2000	±0	2000	2000
7	CD	2000	±0	2000	2000
8	CD	2000	±0	2000	2000
9	CD	2000	±0	2000	2000
10	CD	2000	±0	2000	2000
11	CD	2000	±0	2000	2000
12	CD	2000	±0	2000	2000

2. DEBITION - NY		1. TOTAL ADDITION	
NY	A	16,375	1
NY	B	1,861	1
NY	C	2,000	1
NY	D	10,000	1
NY	E	2,110	1
NY	F	1,110	1
NY	G	1,000	1
NY	H	1,000	1
NY	I	1,000	1
NY	J	1,000	1
NY	K	1,000	1
NY	L	1,000	1
NY	M	1,000	1
NY	N	1,000	1
NY	O	1,000	1
NY	P	1,000	1
NY	Q	1,000	1
NY	R	1,000	1
NY	S	1,000	1
NY	T	1,000	1
NY	U	1,000	1
NY	V	1,000	1
NY	W	1,000	1
NY	X	1,000	1
NY	Y	1,000	1
NY	Z	1,000	1
NY	AA	1,000	1
NY	AB	1,000	1
NY	AC	1,000	1
NY	AD	1,000	1
NY	AE	1,000	1
NY	AF	1,000	1
NY	AG	1,000	1
NY	AH	1,000	1
NY	AI	1,000	1
NY	AJ	1,000	1
NY	AK	1,000	1
NY	AL	1,000	1
NY	AM	1,000	1
NY	AN	1,000	1
NY	AO	1,000	1
NY	AP	1,000	1
NY	AQ	1,000	1
NY	AR	1,000	1
NY	AS	1,000	1
NY	AT	1,000	1
NY	AU	1,000	1
NY	AV	1,000	1
NY	AW	1,000	1
NY	AX	1,000	1
NY	AY	1,000	1
NY	AZ	1,000	1
NY	BA	1,000	1
NY	BB	1,000	1
NY	BC	1,000	1
NY	BD	1,000	1
NY	BE	1,000	1
NY	BF	1,000	1
NY	BG	1,000	1
NY	BH	1,000	1
NY	BI	1,000	1
NY	BJ	1,000	1
NY	BK	1,000	1
NY	BL	1,000	1
NY	BM	1,000	1
NY	BN	1,000	1
NY	BO	1,000	1
NY	BP	1,000	1
NY	BQ	1,000	1
NY	BR	1,000	1
NY	BS	1,000	1
NY	BT	1,000	1
NY	BU	1,000	1
NY	BV	1,000	1
NY	BW	1,000	1
NY	BX	1,000	1
NY	BY	1,000	1
NY	BZ	1,000	1
NY	CA	1,000	1
NY	CB	1,000	1
NY	CC	1,000	1
NY	CD	1,000	1
NY	CE	1,000	1
NY	CF	1,000	1
NY	CG	1,000	1
NY	CH	1,000	1
NY	CI	1,000	1
NY	CJ	1,000	1
NY	CK	1,000	1
NY	CL	1,000	1
NY	CM	1,000	1
NY	CN	1,000	1
NY	CO	1,000	1
NY	CP	1,000	1
NY	CQ	1,000	1
NY	CR	1,000	1
NY	CS	1,000	1
NY	CT	1,000	1
NY	CU	1,000	1
NY	CV	1,000	1
NY	CW	1,000	1
NY	CX	1,000	1
NY	CY	1,000	1
NY	CZ	1,000	1
NY	DA	1,000	1
NY	DB	1,000	1
NY	DC	1,000	1
NY	DD	1,000	1
NY	DE	1,000	1
NY	DF	1,000	1
NY	DG	1,000	1
NY	DH	1,000	1
NY	DI	1,000	1
NY	DJ	1,000	1
NY	DK	1,000	1
NY	DL	1,000	1
NY	DM	1,000	1
NY	DN	1,000	1
NY	DO	1,000	1
NY	DP	1,000	1
NY	DQ	1,000	1
NY	DR	1,000	1
NY	DS	1,000	1
NY	DT	1,000	1
NY	DU	1,000	1
NY	DV	1,000	1
NY	DW	1,000	1
NY	DX	1,000	1
NY	DY	1,000	1
NY	DZ	1,000	1
NY	EA	1,000	1
NY	EB	1,000	1
NY	EC	1,000	1
NY	ED	1,000	1
NY	EE	1,000	1
NY	EF	1,000	1
NY	EG	1,000	1
NY	EH	1,000	1
NY	EI	1,000	1
NY	EJ	1,000	1
NY	EK	1,000	1
NY	EL	1,000	1
NY	EM	1,000	1
NY	EN	1,000	1
NY	EO	1,000	1
NY	EP	1,000	1
NY	EQ	1,000	1
NY	ER	1,000	1
NY	ES	1,000	1
NY	ET	1,000	1
NY	EU	1,000	1
NY	EV	1,000	1
NY	EW	1,000	1
NY	EX	1,000	1
NY	EY	1,000	1
NY	EZ	1,000	1
NY	FA	1,000	1
NY	FB	1,000	1
NY	FC	1,000	1
NY	FD	1,000	1
NY	FE	1,000	1
NY	FF	1,000	1
NY	FG	1,000	1
NY	FH	1,000	1
NY	FI	1,000	1
NY	FJ	1,000	1
NY	FK	1,000	1
NY	FL	1,000	1
NY	FM	1,000	1
NY	FN	1,000	1
NY	FO	1,000	1
NY	FP	1,000	1
NY	FQ	1,000	1
NY	FR	1,000	1
NY	FS	1,000	1
NY	FT	1,000	1
NY	FU	1,000	1
NY	FV	1,000	1
NY	FW	1,000	1
NY	FX	1,000	1
NY	FY	1,000	1
NY	FZ	1,000	1
NY	GA	1,000	1
NY	GB	1,000	1
NY	GC	1,000	1
NY	GD	1,000	1
NY	GE	1,000	1
NY	GF	1,000	1
NY	GG	1,000	1
NY	GH	1,000	1
NY	GI	1,000	1
NY	GJ	1,000	1
NY	GK	1,000	1
NY	GL	1,000	1
NY	GM	1,000	1
NY	GN	1,000	1
NY	GO	1,000	1
NY	GP	1,000	1
NY	GQ	1,000	1
NY	GR	1,000	1
NY	GS	1,000	1
NY	GT	1,000	1
NY	GU	1,000	1
NY	GV	1,000	1
NY	GW	1,000	1
NY	GX	1,000	1
NY	GY	1,000	1
NY	GZ	1,000	1
NY	HA	1,000	1
NY	HB	1,000	1
NY	HC	1,000	1
NY	HD	1,000	1
NY	HE	1,000	1
NY	HF	1,000	1
NY	HG	1,000	1
NY	HH	1,000	1
NY	HI	1,000	1
NY	HJ	1,000	1
NY	HK	1,000	1
NY	HL	1,000	1
NY	HM	1,000	1
NY	HN	1,000	1
NY	HO	1,000	1
NY	HP	1,000	1
NY	HQ	1,000	1
NY	HR	1,000	1
NY	HS	1,000	1
NY	HT	1,000	1
NY	HU	1,000	1
NY	HV	1,000	1
NY	HW	1,000	1
NY	HX	1,000	1
NY	HY	1,000	1
NY	HZ	1,000	1
NY	IA	1,000	1
NY	IB	1,000	1
NY	IC	1,000	1
NY	ID	1,000	1
NY	IE	1,000	1
NY	IF	1,000	1
NY	IG	1,000	1
NY	IH	1,000	1
NY	II	1,000	1
NY	IJ	1,000	1
NY	IK	1,000	1
NY	IL	1,000	1
NY	IM	1,000	1
NY	IN	1,000	1
NY	IO	1,000	1
NY	IP	1,000	1
NY	IQ	1,000	1
NY	IR	1,000	1
NY	IS	1,000	1
NY	IT	1,000	1
NY	IU	1,000	1
NY	IV	1,000	1
NY	IW	1,000	1
NY	IX	1,000	1
NY	IY	1,000	1
NY	IZ	1,000	1
NY	JA	1,000	1
NY	JB	1,000	1
NY	JC	1,000	1
NY	JD	1,000	1
NY	JE	1,000	1
NY	JF	1,000	1
NY	JG	1,000	1
NY	JH	1,000	1
NY	JI	1,000	1
NY	JJ	1,000	1
NY	JK	1,000	1
NY	JL	1,000	1
NY	JM	1,000	1
NY	JN	1,000	1
NY	JO	1,000	1
NY	JP	1,000	1
NY	JQ	1,000	1
NY	JR	1,000	1
NY	JS	1,000	1
NY	JT	1,000	1
NY	JU	1,000	1
NY	JV	1,000	1
NY	JW	1,000	1
NY	JX	1,000	1
NY	JY	1,000	1
NY	JZ	1,000	1
NY	KA	1,000	1
NY	KB	1,000	1
NY	KC	1,000	1
NY	KD	1,000	1
NY	KE	1,000	1
NY	KF	1,000	1
NY	KG	1,000	1
NY	KH	1,000	1
NY	KI	1,000	1
NY	KJ	1,000	1
NY	KK	1,000	1
NY	KL	1,000	1
NY	KM	1,000	1
NY	KN	1,000	1
NY	KO	1,000	1
NY	KP	1,000	1
NY	KQ	1,000	1
NY	KR	1,000	1
NY	KS	1,000	1
NY	KT	1,000	1
NY	KU	1,000	1
NY	KV	1,000	1
NY	KW	1,000	1
NY	KX	1,000	1
NY	KY	1,000	1
NY	KZ	1,000	1
NY	LA	1,000	1
NY	LB	1,000	1
NY	LC	1,000	1
NY	LD	1,000	1
NY	LE	1,000	1
NY	LF	1,000	1
NY	LG	1,000	1
NY	LH	1,000	1
NY	LI	1,000	1
NY	LJ	1,000	1
NY	LK	1,000	1
NY	LL	1,000	1
NY	LM	1,000	1
NY	LN	1,000	1
NY	LO	1,000	1
NY	LP	1,000	1
NY	LQ	1,000	1
NY	LR	1,000	1
NY	LS	1,000	1
NY	LT	1,000	1
NY	LU	1,000	1
NY	LV	1,000	1
NY	LW	1,000	1
NY	LX	1,000	1
NY	LY	1,000	1
NY	LZ	1,000	1
NY	MA	1,000	1
NY	MB	1,000	1
NY	MC	1,000	1
NY	MD	1,000	1
NY	ME	1,000	1
NY	MF	1,000	1
NY	MG	1,000	1
NY	MH	1,000	1
NY	MI	1,000	1
NY	MJ	1,000	1
NY	MK	1,000	1
NY	ML	1,000	1
NY	MM	1,000	1
NY	MN	1,000	1
NY	MO	1,000	1
NY	MP	1,000	1
NY	MQ	1,000	1
NY	MR	1,000	1
NY	MS	1,000	1
NY	MT	1,000	1
NY	MU	1,000	1
NY	MV	1,000	1
NY	MW	1,000	1
NY	MX	1,000	1
NY	MY	1,000	1
NY	MZ	1,000	1
NY	NA	1,000	1
NY	NB	1,000	1
NY	NC	1,000	1
NY	ND	1,000	1
NY	NE	1,000	1
NY	NF	1,000	1
NY	NG	1,000	1
NY	NH	1,000	1
NY	NI	1,000	1
NY	NJ	1,000	1
NY	NK	1,000	1
NY	NL	1,000	1
NY	NM	1,000	1
NY	NN	1,000	1
NY	NO	1,000	1
NY	NP	1,000	1
NY	NQ	1,000	1
NY	NR	1,000	1
NY	NS	1,000	1
NY	NT	1,000	1
NY	NU	1,000	1
NY	NV	1,000	1
NY	NW	1,00	

ARCHITECTS SIGN

ANOTRENTA
B. Arch. (Hons.)
CAP051879

SCALE AS MARKED

SHEET NO.

RENTAL (P) LTD
NEW DELHI

RENTAL (P) LTD
NEW DELHI