

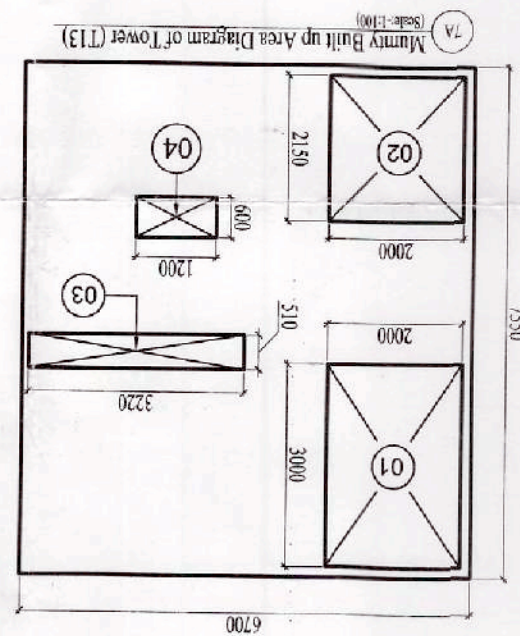
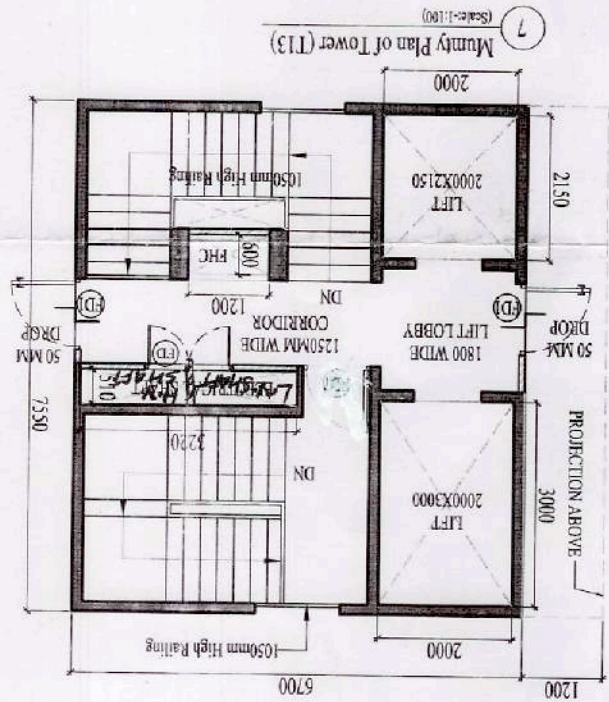


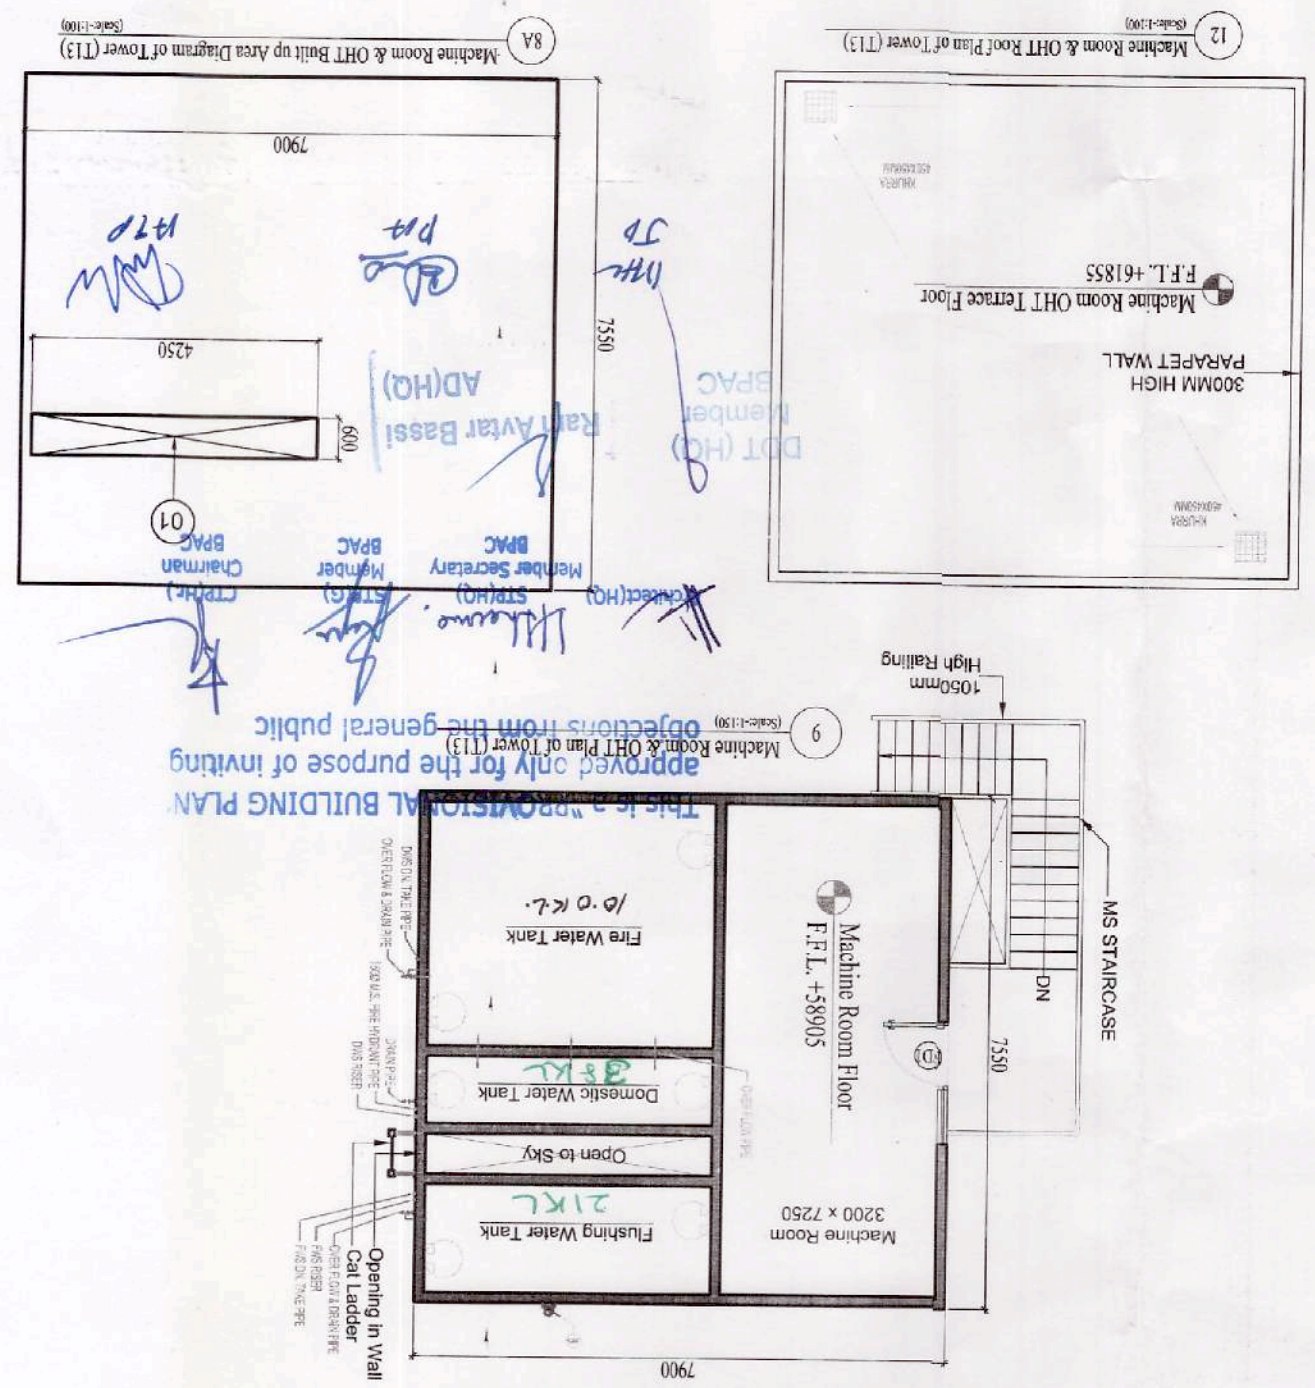

MAJHI BLUE-IP AREA OF TOWER (1.13)									
S.No	NAME	SHAPE	LENGTH	WIDTH	HEIGHT	FORMAL AREA	QUANTITY	TOTAL	UNIT
ADDITION									
1	A	Rectangular	7.50	6.70	-	1 X B	50.65	1	50.65
DEDUCTION									
1	B	Rectangular	2.00	1.00	-	1 X B	2.00	1	2.00
2	C	Rectangular	2.150	2.00	-	1 X B	4.300	1	4.300
3	D	Rectangular	0.510	1.20	-	1 X B	0.612	1	0.612
4	E	Rectangular	0.600	1.20	-	1 X B	0.720	1	0.720
TOTAL ADDITION									
50.65									
TOTAL									
50.65									
MAJHI BLUE-IP AREA OF TOWER (1.13)									
ADDITION (X) - DEDUCTION (Y)									
S.No	TOTAL								
1	50.65								
2	2.00								
3	4.300								
4	0.612								
5	0.720								
TOTAL DEDUCTION									
7.632									
TOTAL									
43.018									

S.No.	NAME	SHRIP	LENGTH	WIDTH	HEIGHT	FORMULA	AREA OF FLOOR (sq. ft.)	UNIT
1.	ADDITION X Y	A						
2.	RETAINING			7.50		1 X B	59.45	SQ. FT.
3.	RETAINING			7.50		1 X B	59.45	SQ. FT.
4.	ADDITION X Y					1 X B	2.55	SQ. FT.
5.	RETAINING			4.50		1 X B	2.55	SQ. FT.
6.	ADDITION X Y						2.55	SQ. FT.
7.	ADDITION X Y						2.55	SQ. FT.
8.	ADDITION X Y						2.55	SQ. FT.
67.	ADDITION X Y						2.55	SQ. FT.
68.	ADDITION X Y						2.	

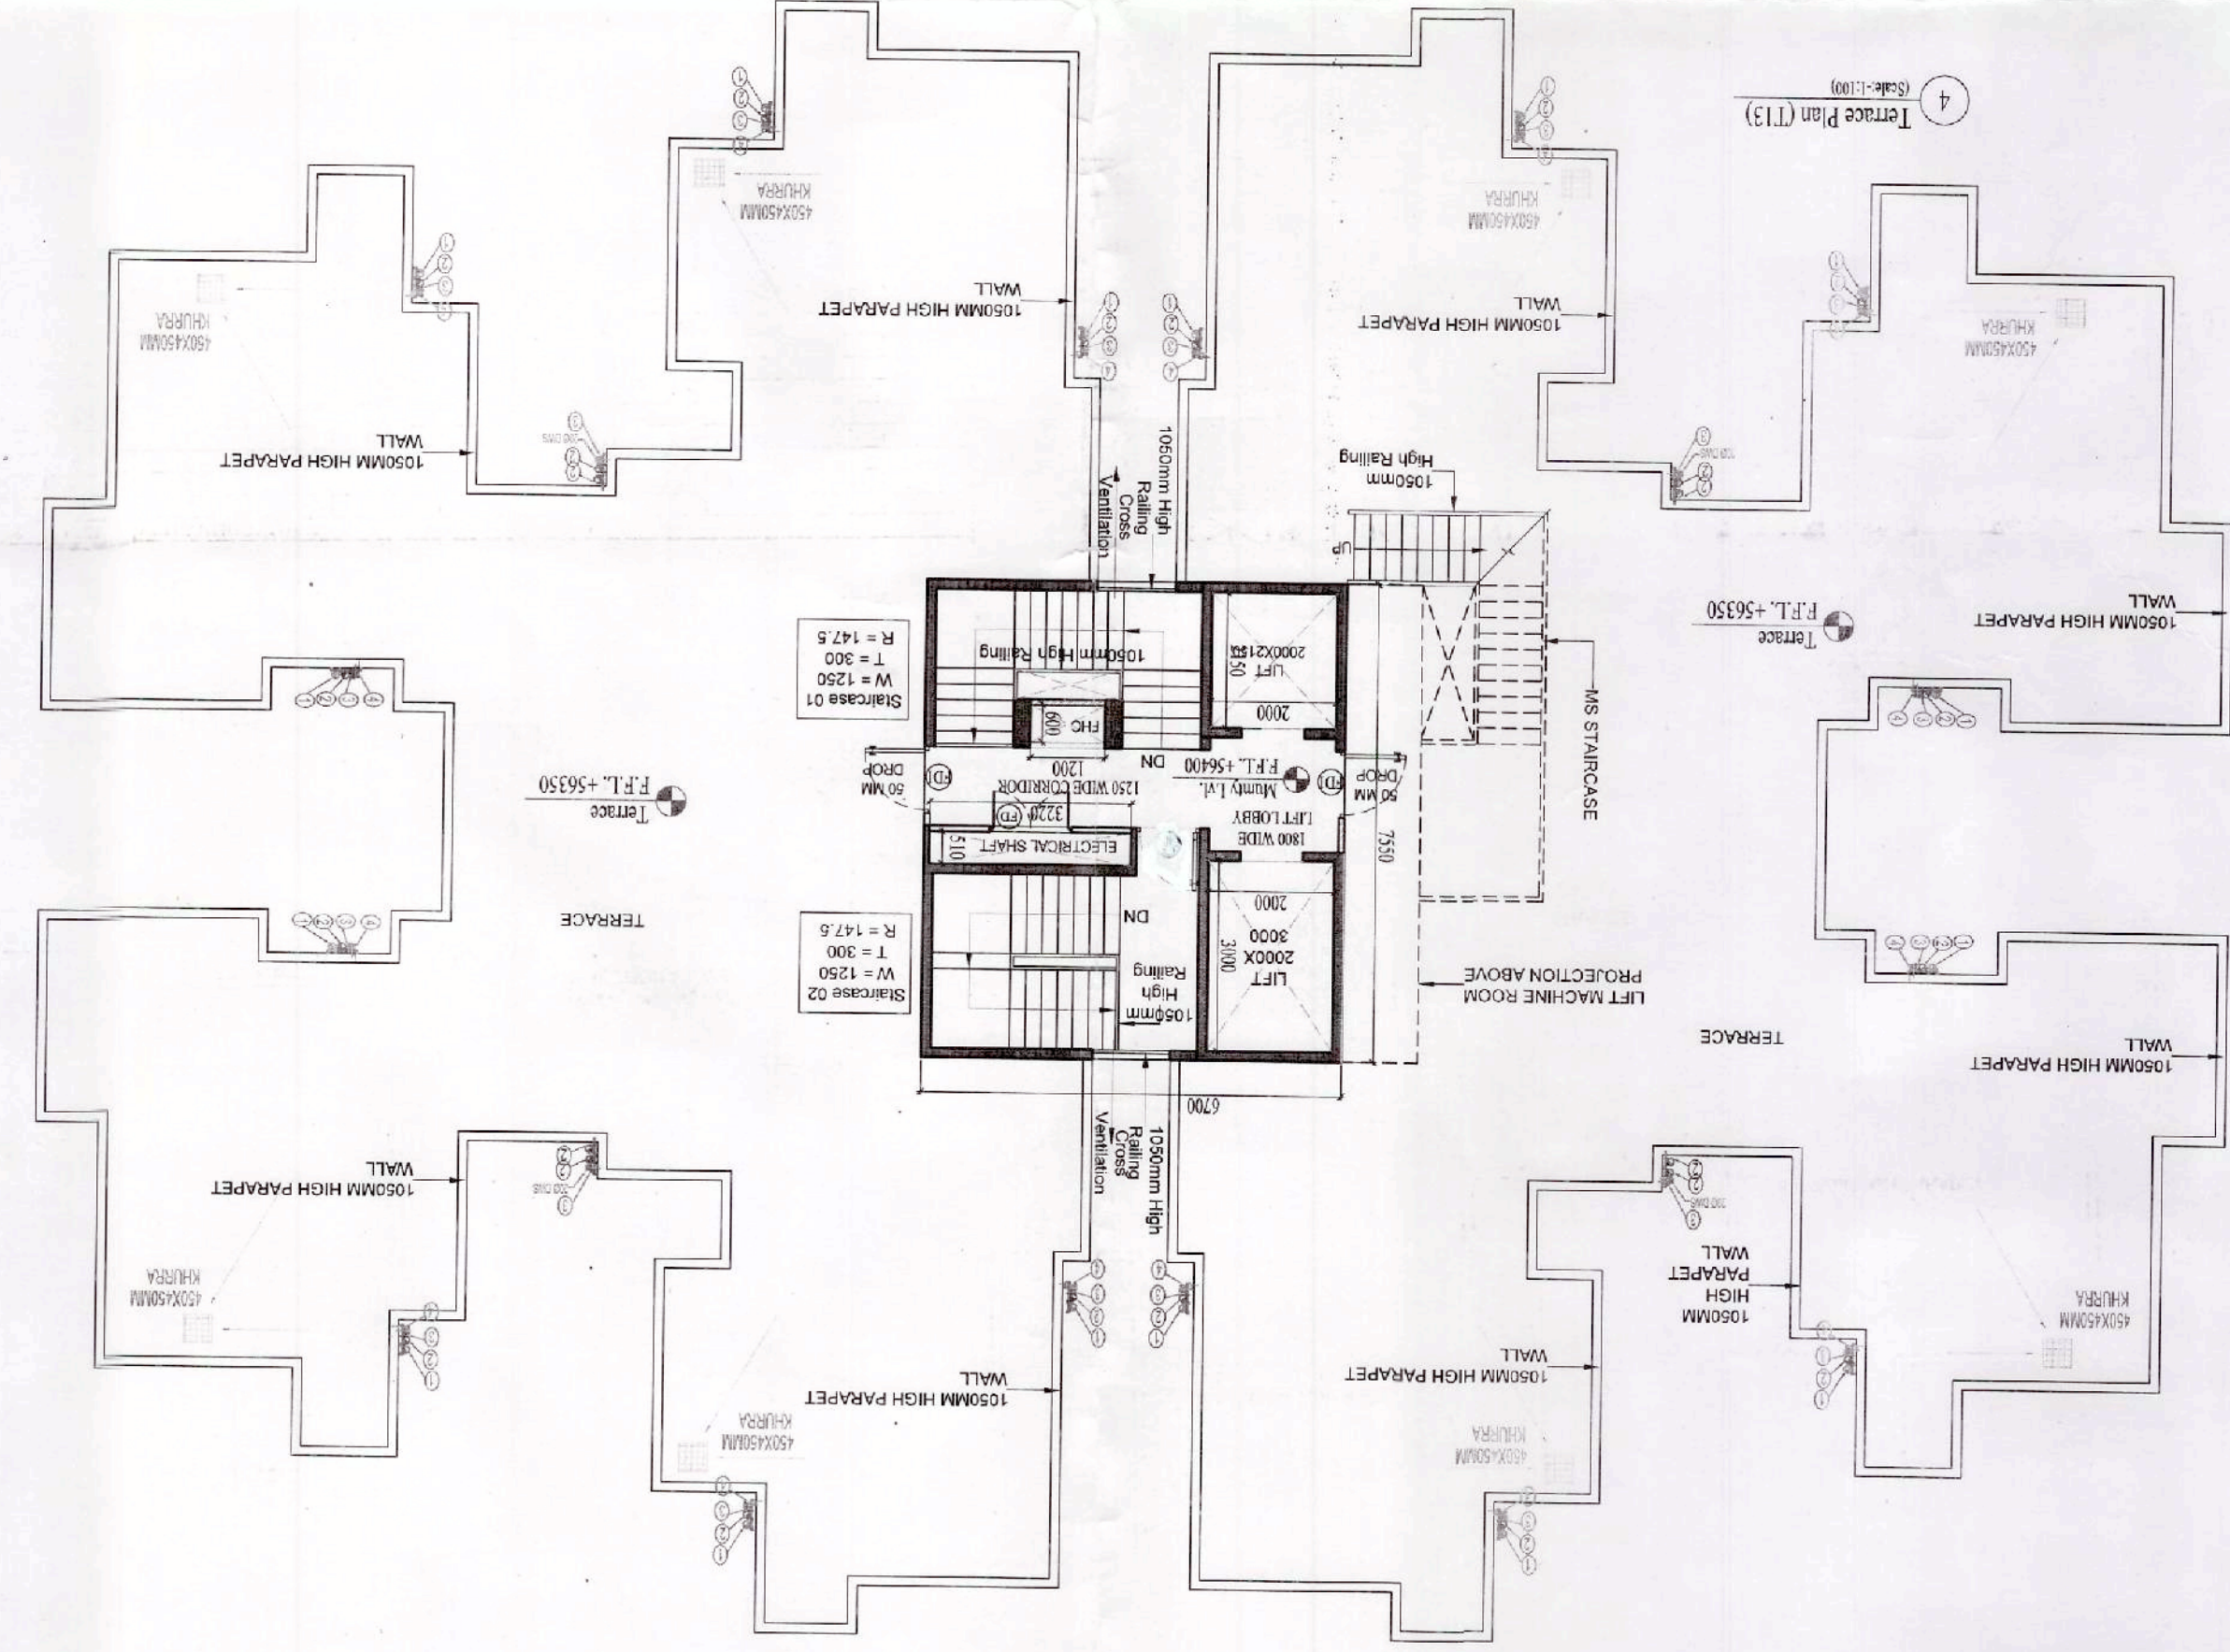

PROJECT
PROPOSED RESEARCHING OF AGRICULTURE IN GERMANY
FOR THE STUDENT OF THE UNIVERSITY OF AGRICULTURE
AND FORESTRY, WETZLAR, GERMANY
INSTITUTE OF AGRICULTURE
WETZLAR, GERMANY
PROJECT ARCHITECT
DESIGN FORUM
INTERNATIONAL
PHONE NO. 011-45555000
FAX NO. 011-45555000
ADDRESS: 100 NEW DELHI
NEW DELHI
LIMITED
ARCHITECT'S SIGN
DATE: 25.02.2007
12
SCALE AS MARKED
SHEET NO.

[illegible]

PLUMBING LEGEND.

approved only for the purpose of inviting objections from the general public