



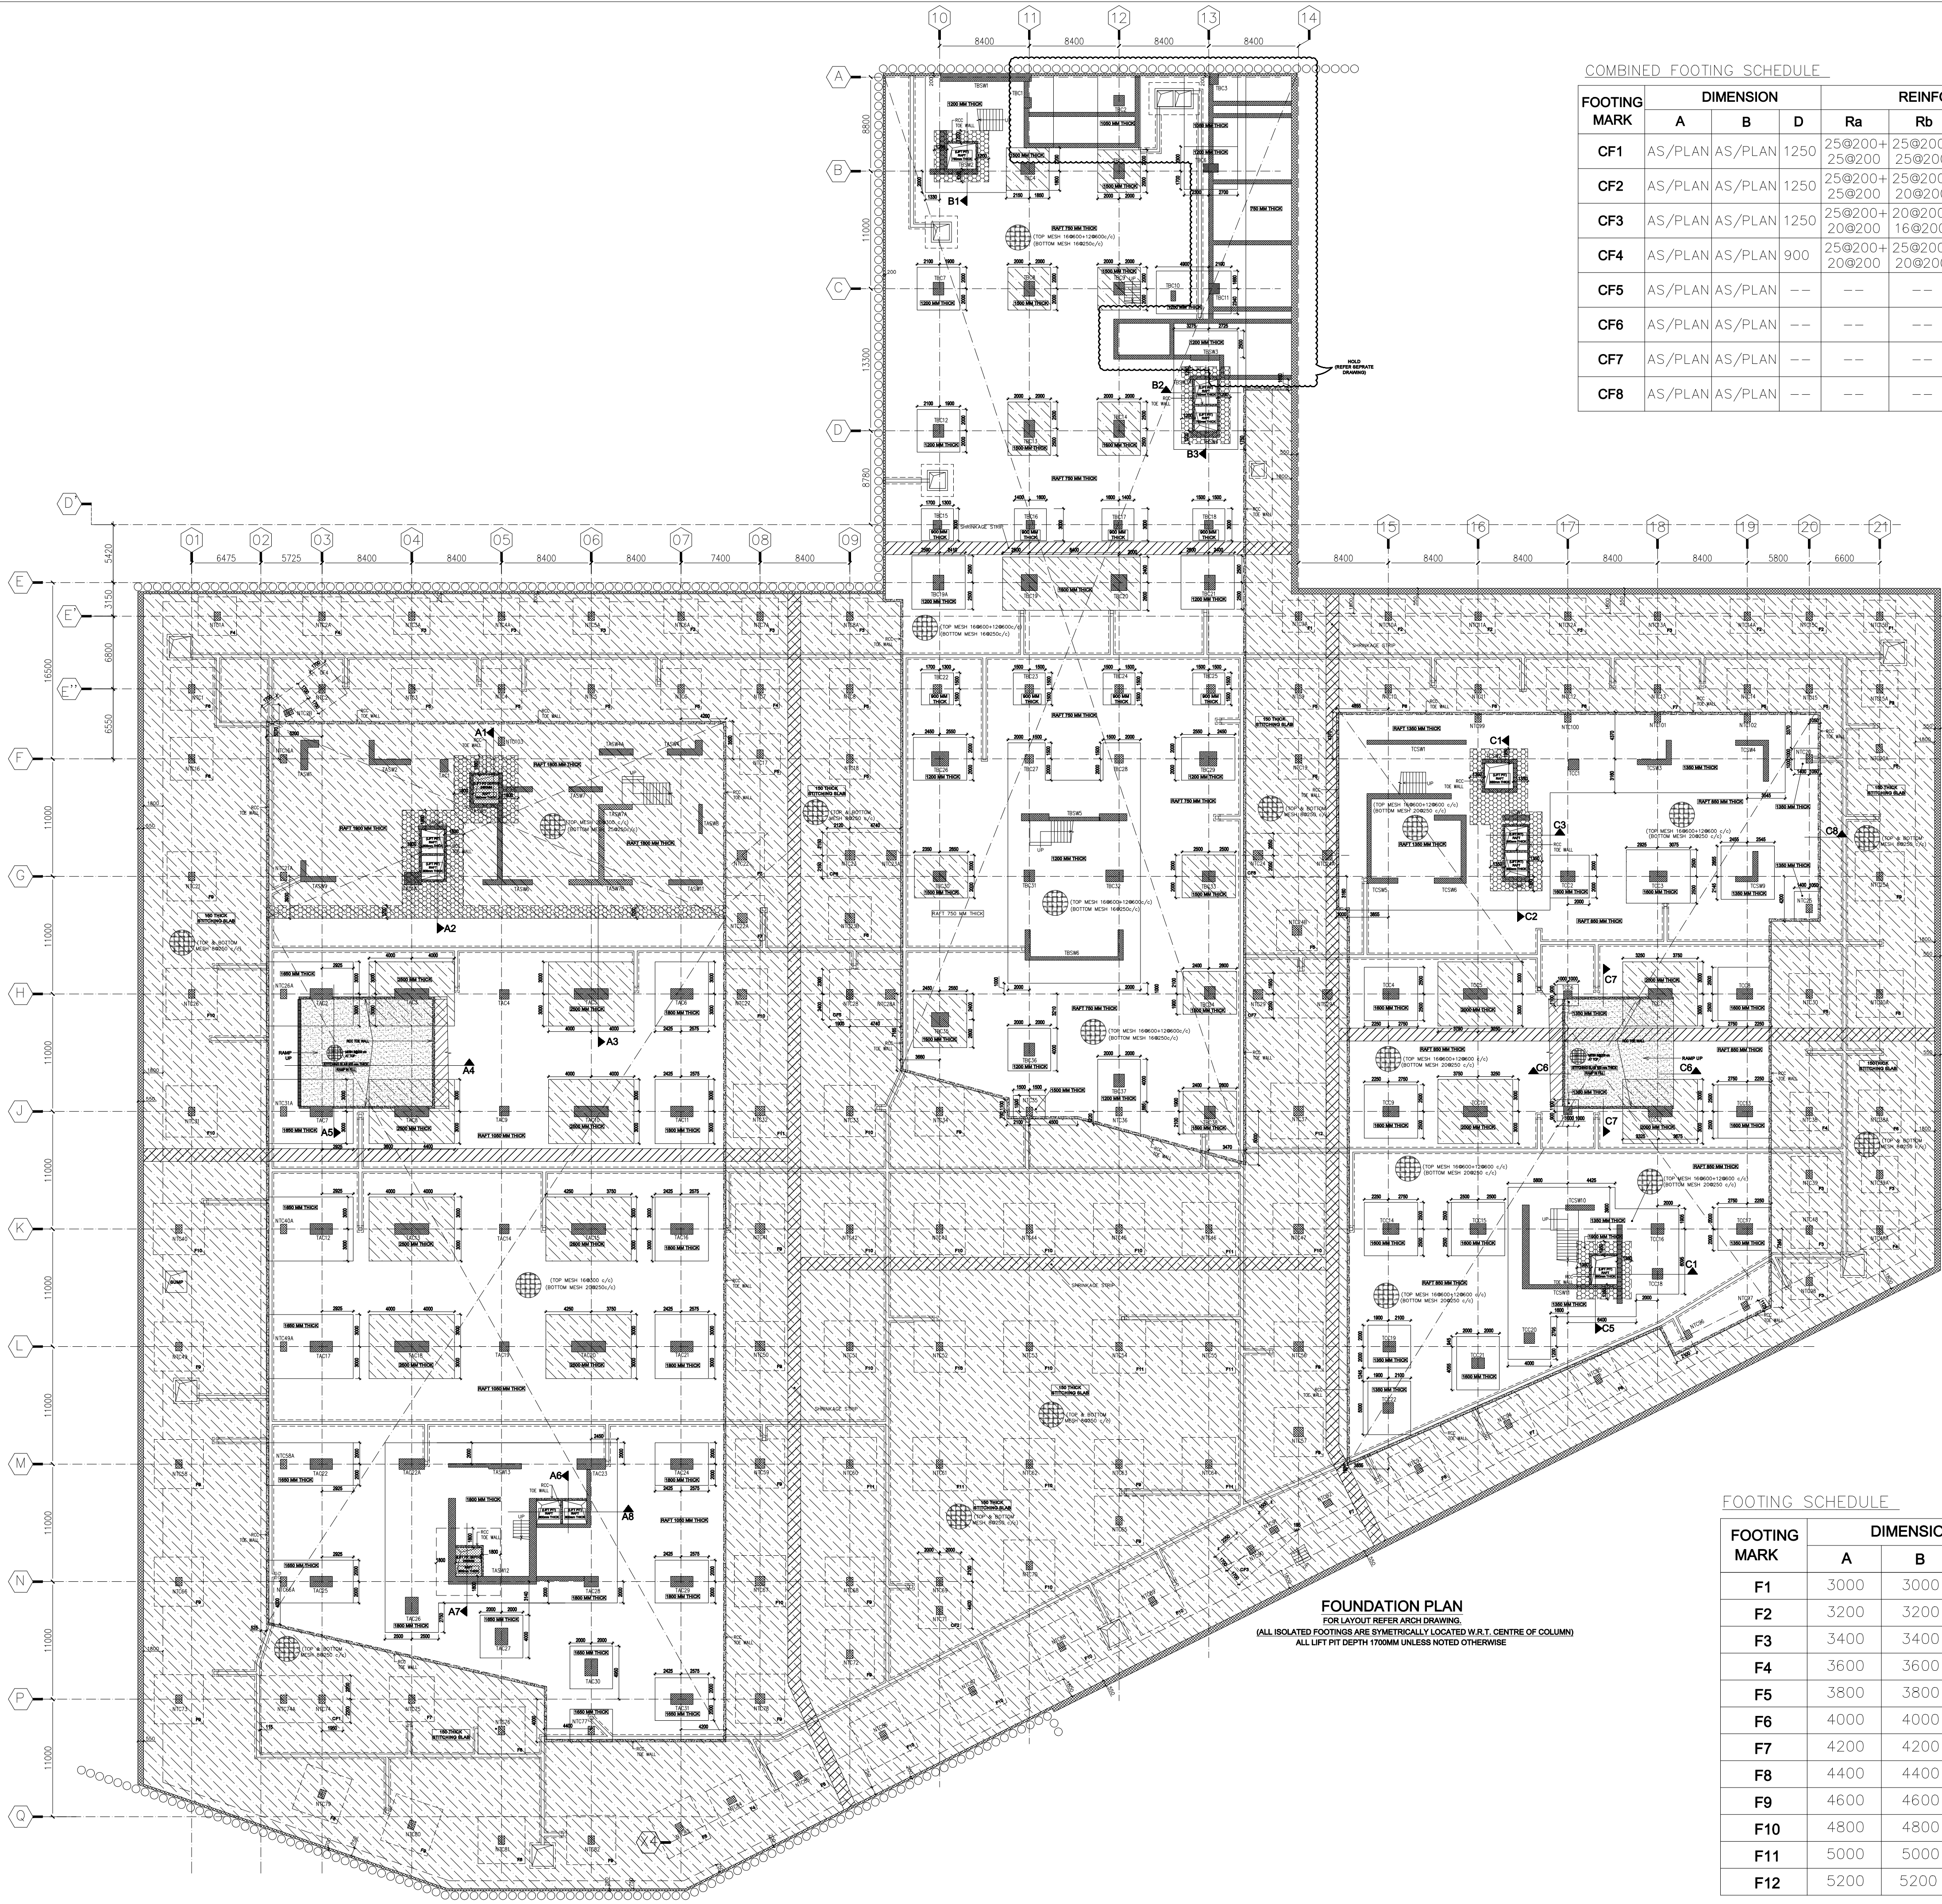

COMBINED FOOTING SCHEDULE

FOOTING MARK	DIMENSION			REINFORCEMENT			
	A	B	D	Ra	Rb	Rc	Rd
CF1	AS/PLAN	AS/PLAN	1250	25@200+25@200	25@200+25@200	12@150	12@150
CF2	AS/PLAN	AS/PLAN	1250	25@200+25@200	25@200+20@200	12@150	12@150
CF3	AS/PLAN	AS/PLAN	1250	25@200+20@200	20@200+16@200	12@150	12@150
CF4	AS/PLAN	AS/PLAN	900	25@200+20@200	25@200+20@200	12@200	12@200
CF5	AS/PLAN	AS/PLAN	--	--	--	--	--
CF6	AS/PLAN	AS/PLAN	--	--	--	--	--
CF7	AS/PLAN	AS/PLAN	--	--	--	--	--
CF8	AS/PLAN	AS/PLAN	--	--	--	--	--

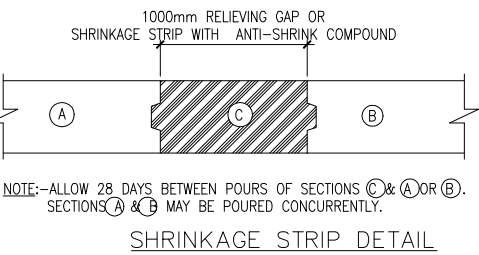

GRADE OF CONCRETE	
TOWER RAFT	M35
NON TOWER FOUNDATION	M30
NON TOWER COLUMN	M40
TOWER COL./S.WALL	M50/M40
RETAINING WALL	M30

GRADE OF STEEL Fe 550D

LEGEND OF HATCH

TOS LEVEL (-17650)	
RAFT FOLD	
LIFT PIT DEPTH (2400MM)	

FOOTING SCHEDULE

FOOTING MARK	DIMENSION			REINFORCEMENT	
	A	B	D	Rb	Ra
F1	3000	3000	750	12@100	12@100
F2	3200	3200	750	16@150	16@150
F3	3400	3400	850	16@125	16@125
F4	3600	3600	950	16@100	16@100
F5	3800	3800	1050	16@100	16@100
F6	4000	4000	1050	16@100	16@100
F7	4200	4200	1150	20@150	20@150
F8	4400	4400	1150	20@125	20@125
F9	4600	4600	1250	20@150	20@150
F10	4800	4800	1350	20@150	20@150
F11	5000	5000	1350	20@150	20@150
F12	5200	5200	1500	20@125	20@125

LANDSPAED CONSULTANT

ORACLE'S
Landscape Design Planning & Conservation
G-98, KALKAJI
NEW DELHI-110029
PHONE:- 011-26674787,26674793
TEL./FAX:- 29501584
E-MAIL:- mail@oracleslandscape.in

PLUMBING AND FIRE FIGHTING Consultants

ENVIRON'S
BUILDING SERVICES CONSULTANTS
A-14 BASEMENT, SHIVAJI
NEW DELHI-110017
PHONE:- 011-26674787,26674793
TEL./FAX:- 29501584
E-MAIL:- environ@envirovars@gmail.com

ELECTRICAL Consultants

Kanwar Krishen Associates Private Ltd.
Engineers & Consultants
F - 301, Laxmi Sagar, New Delhi - 110 030, INDIA
Tel: +91-11-2952 1180, 29521181,2952 1182
Fax: +91-11-29521183
E-mail: kkanwar@rediffmail.com

HVAC Consultants

UDAYAN CHAUDHARI & ASSOCIATES PVT. LTD.
40/60, 2nd FLOOR, CHITTARANJAN PARK
NEW DELHI - 110 025
TEL : 26418363, 26471312
FAX : 26253542
E-MAIL: udayanauthor@gmail.com

STRUCTURAL CONSULTANTS :

BMSF Design Consultants Pvt. Ltd.

S-13/25, (Gr.Floor)
DLF Phase - II,
Gurgaon - 122002
PH: 0124-4113252

Design & Executive Architects

MAas

G-223, Basement
Sarodhya Enclave, New Delhi
011-41829971,71,72

Concept Architects

Benoy

CLIENT

aiplA
values that build worth

Project title

BUILDING PLAN OF I.T. PARK/ CYBER PARK COLONY
MEASURING 6.1375 ACRES (LICENSE No.112 OF 2012
DATED 27-10-2012) IN SECTOR-86,
GURUGRAM MANESAR URBAN COMPLEX
BEING DEVELOPED BY ADVANCE INDIA PROJECTS LTD.

Drawing title

FOUNDATION PLAN

Job No.

Drawn
A. KATARIA

Checked
KHALIQE

Date
30-08-21

Drawing No.

BAS-S-11.B4

Revisions

Scale
1:1