


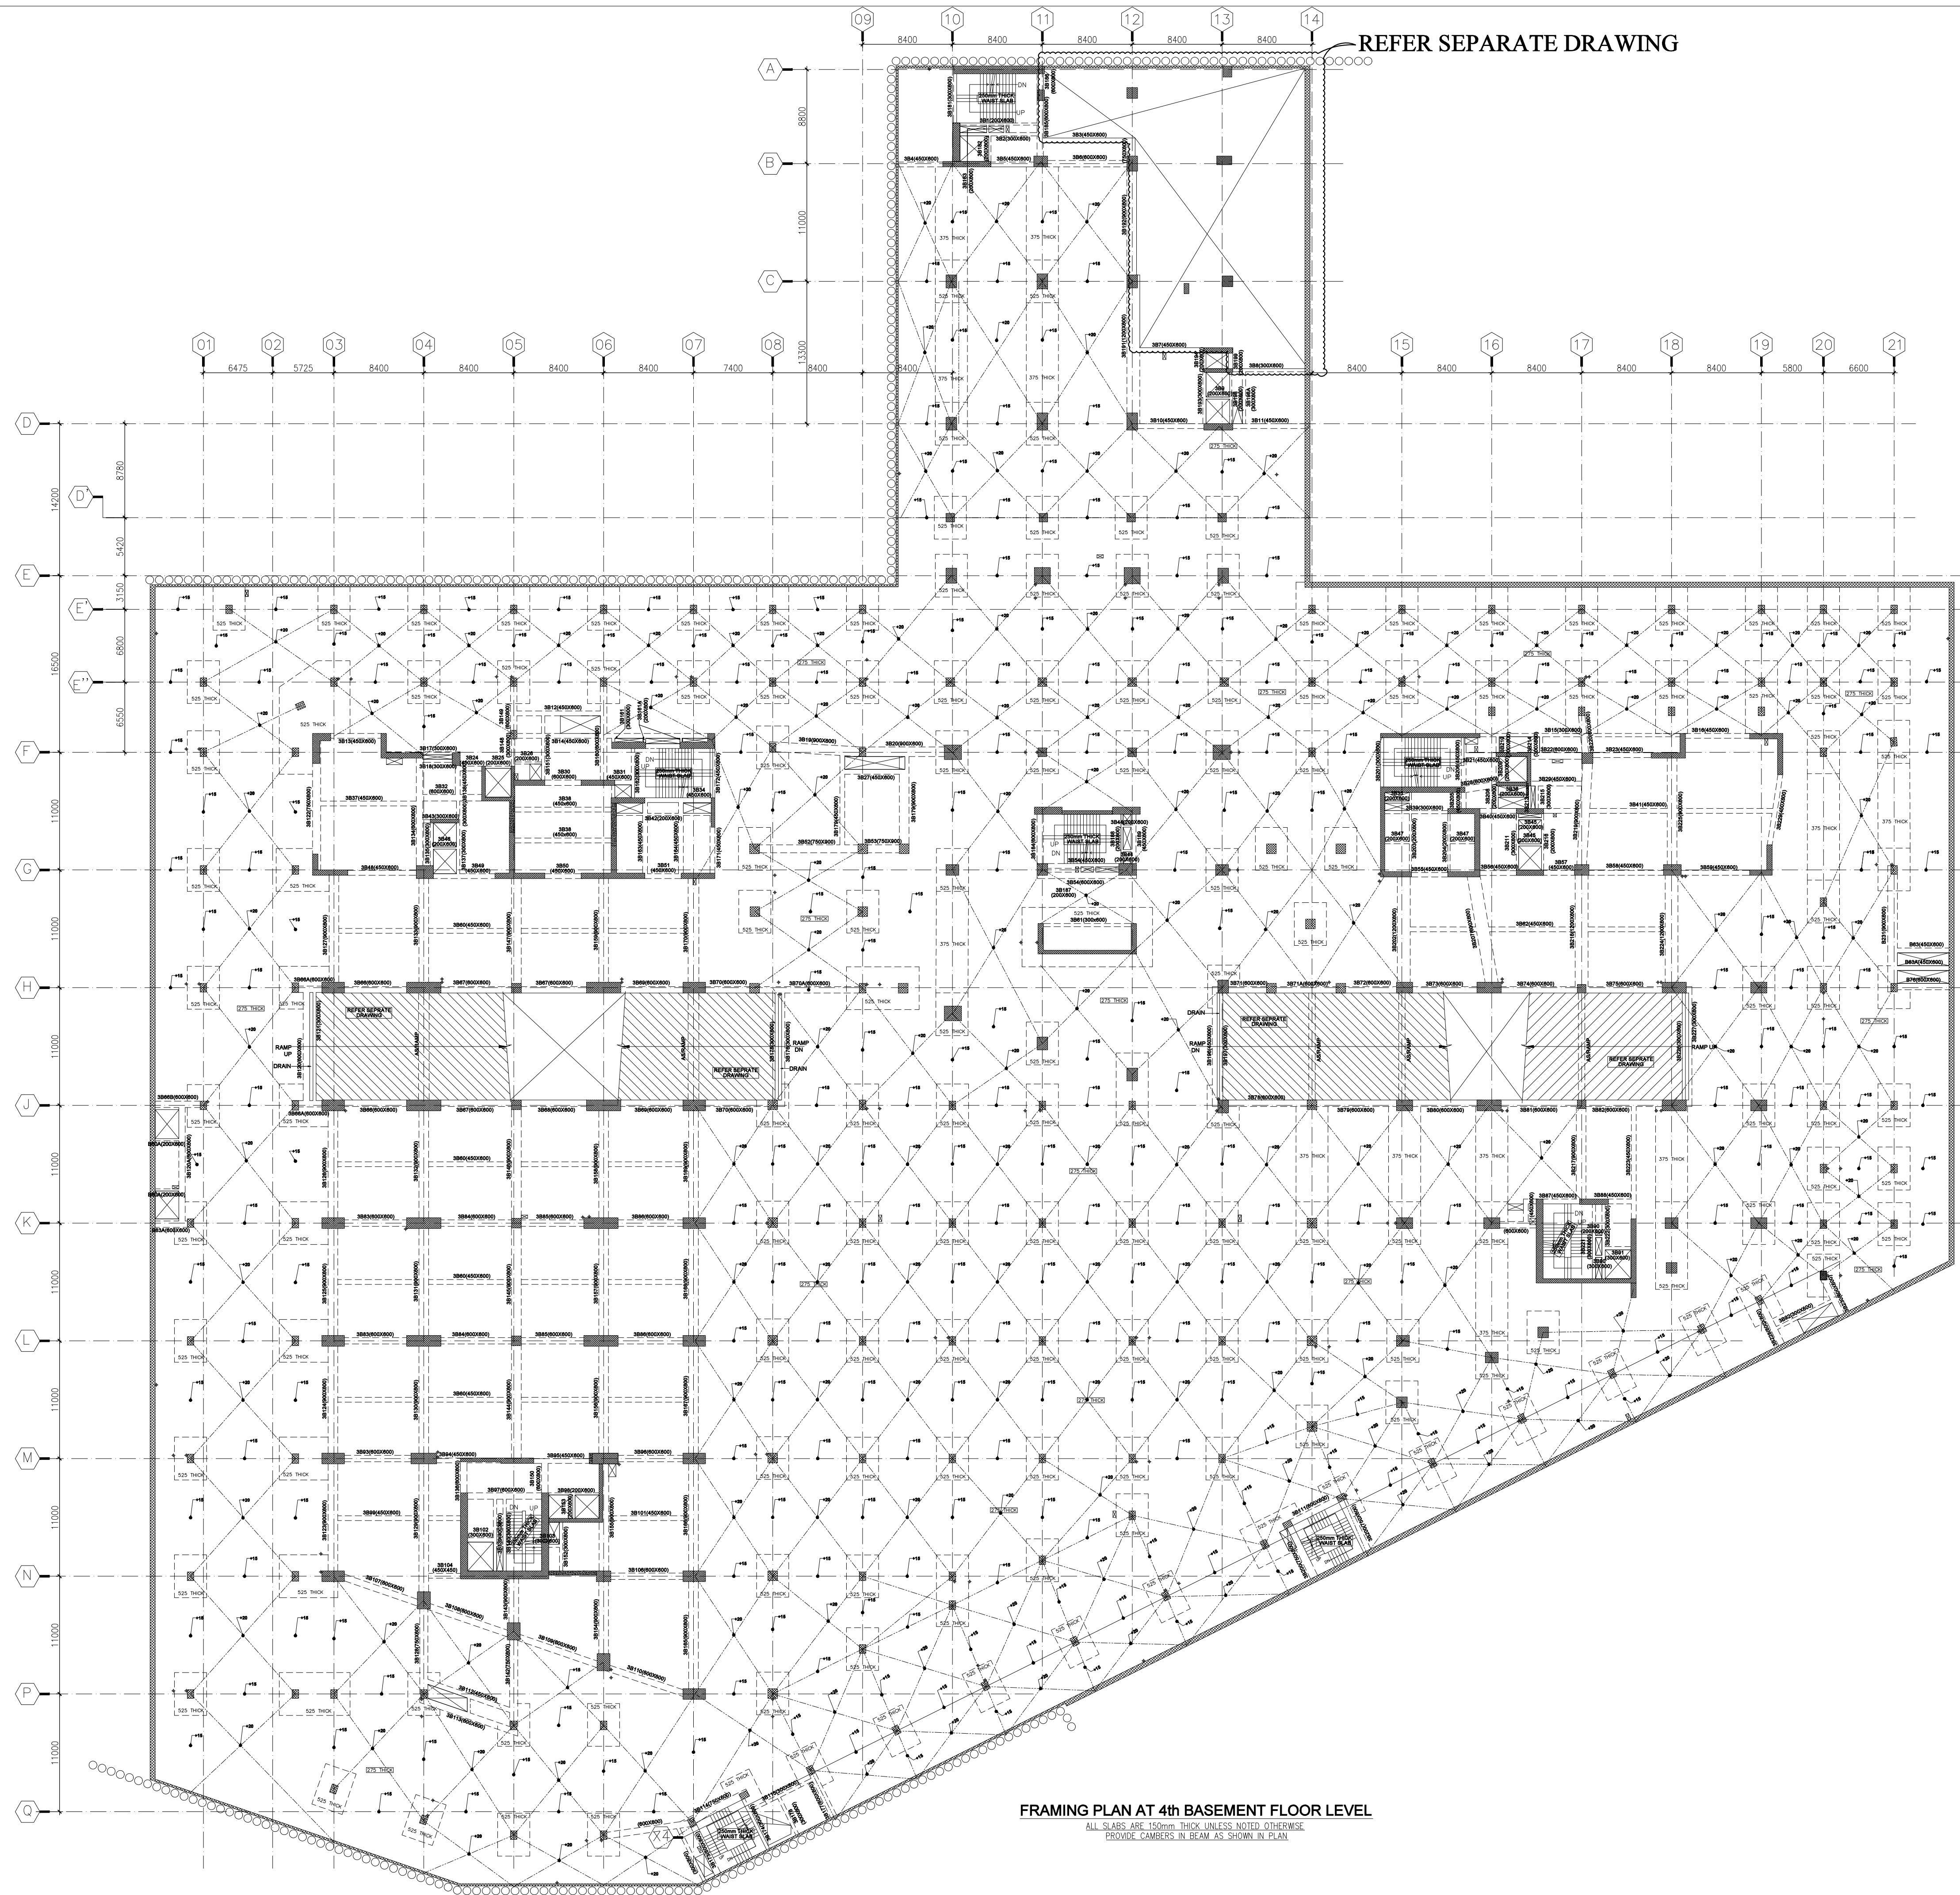

FRAMING PLAN AT 4th BASEMENT FLOOR LEVEL
ALL SLABS ARE 150mm THICK UNLESS NOTED OTHERWISE
PROVIDE CAMBERS IN BEAM AS SHOWN IN PLAN

BMSF DESIGN CONSULTANTS PVT. LTD.
S 13/25 DLF PHASE III
GURGAON, HARYANA

LANDSCAPE CONSULTANT

ORACLES
Landscape Design/Planning & Conservation

G-10, SECTOR-10, GURGAON
PHONE: 011-26481835, 2644500, 2642261
EMAIL: info@oracleslandscape.in

PLUMBING AND FIRE FIGHTING CONSULTANTS

ENVIRONIS
BUILDING SERVICES CONSULTANTS

A-14, BACHENDRA, DHAULI
NEW DELHI-110017
PHONE: 011-26478182, 26474743
TEL/FAX: 26510848
EMAIL: enviro@environis.com

ELECTRICAL CONSULTANTS

Kanwer Krishan Associates Private Ltd.
Engineers & Consultants

F-101, Loka Singh, New Delhi-110 030, INDIA
Tel: +91-11-2652 1185, 2652181, 2652 1182
Fax: +91-11-26521183
E-mail: kaa@kanwer.com

HVAC CONSULTANTS

KIRANAY CREATIVE & ARCHITECTURE PVT. LTD.

40/60, 2nd FLOOR, CHITRAKUT PARK
NEW DELHI-110 021
TEL: 26418362, 26471512
FAX: 26520842
E-MAIL: info@kiranay.com

STRUCTURAL CONSULTANTS:

BMSF Design Consultants Pvt. Ltd.

S-13/25, DLF Phase III
Gurgaon, Haryana
Phone: 2644500
Fax: 2644501

Design & Executive Architects

MAas
D-227, Basement

Somviya, Enclave, New Delhi
011-41829971, 71, 72

Client

Benoy

values that build worth

Project title

BUILDING PLAN OF LT. PARK CYBER PARK COLONY

MEASURING 6.1375 ACRES (LICENSE No.112 OF 2012

DATED 27-10-2012) IN SECTOR-66,

GURGRAM MANESAR URBAN COMPLEX

BEING DEVELOPED BY ADVANCE INDIA PROJECTS LTD.

Drawing title

FRAMING PLAN AT 4th BASEMENT FLOOR LEVEL

Job No. Drawing No.
Drawn: AKASH Checked: KK AHMAD BAS-S-13.04
Date: Scale: Revisions:
30-08-21 NTS