
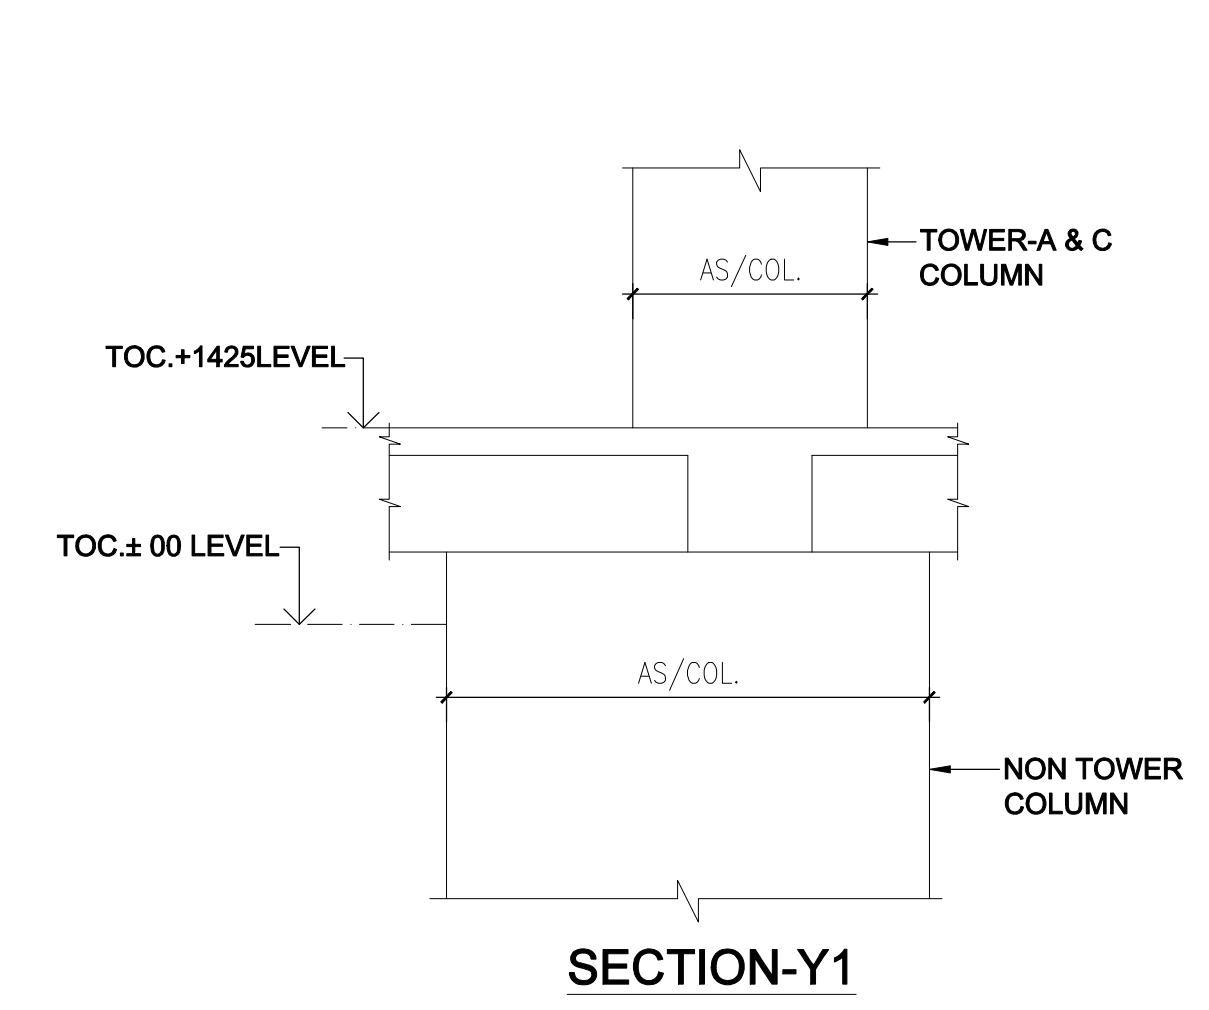
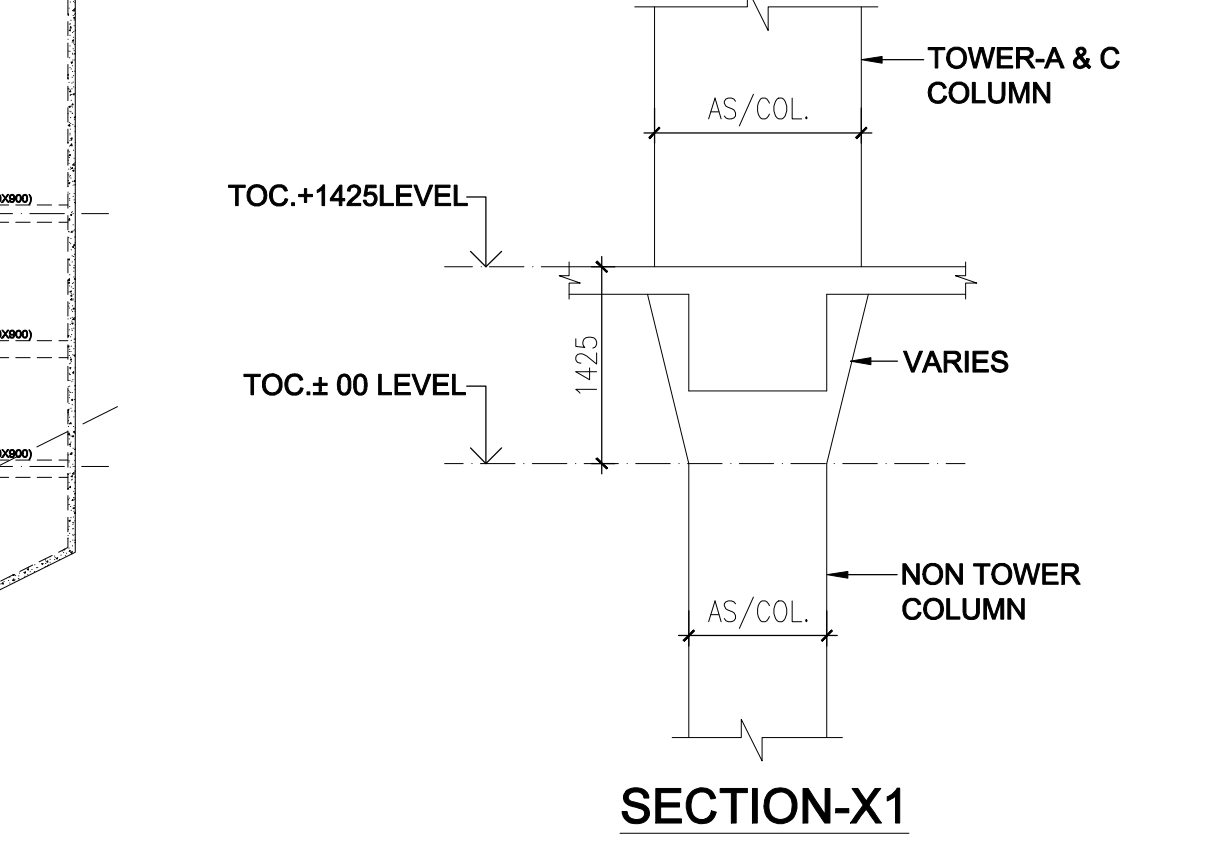
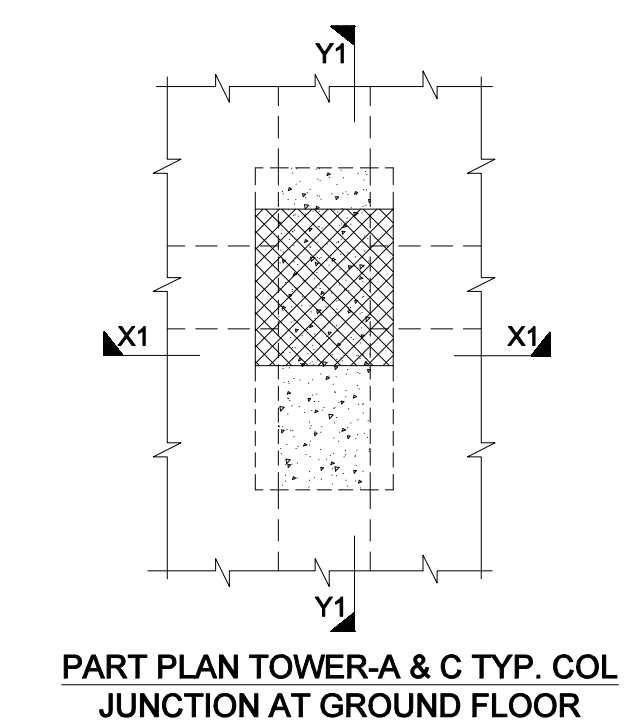
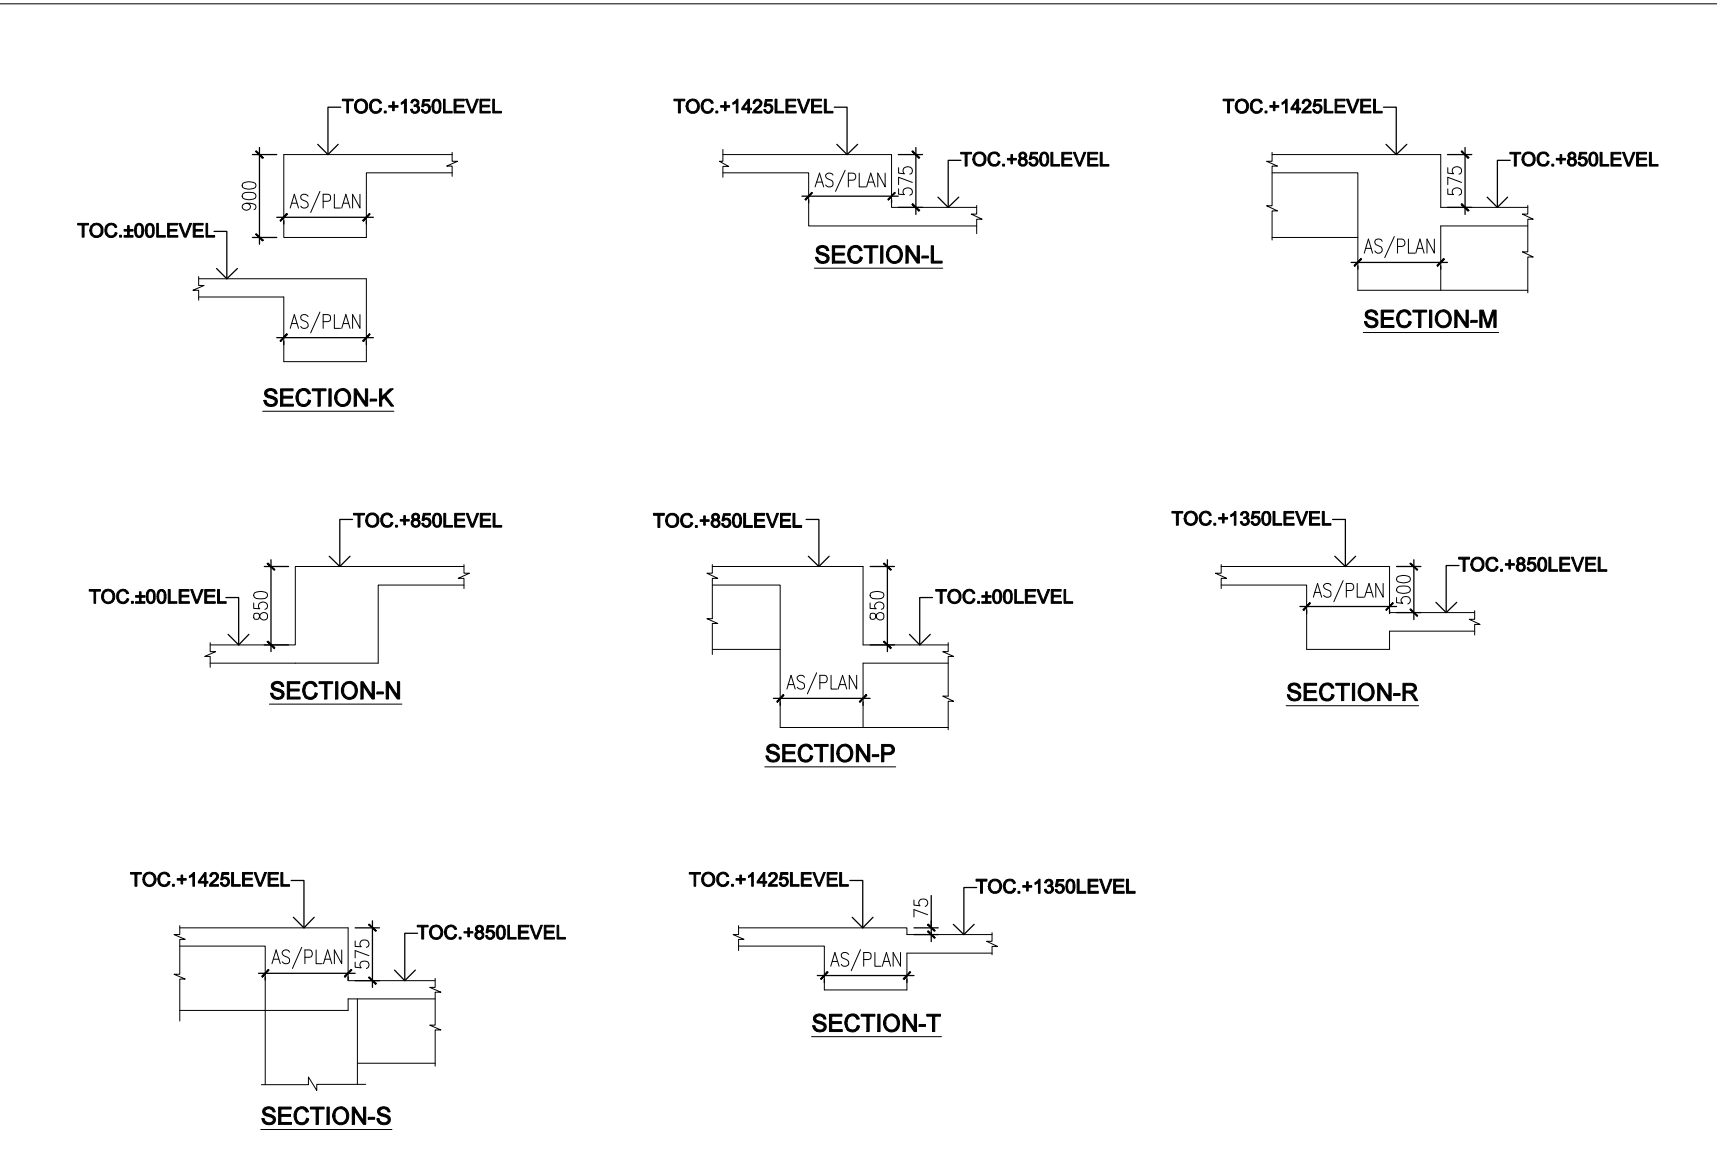
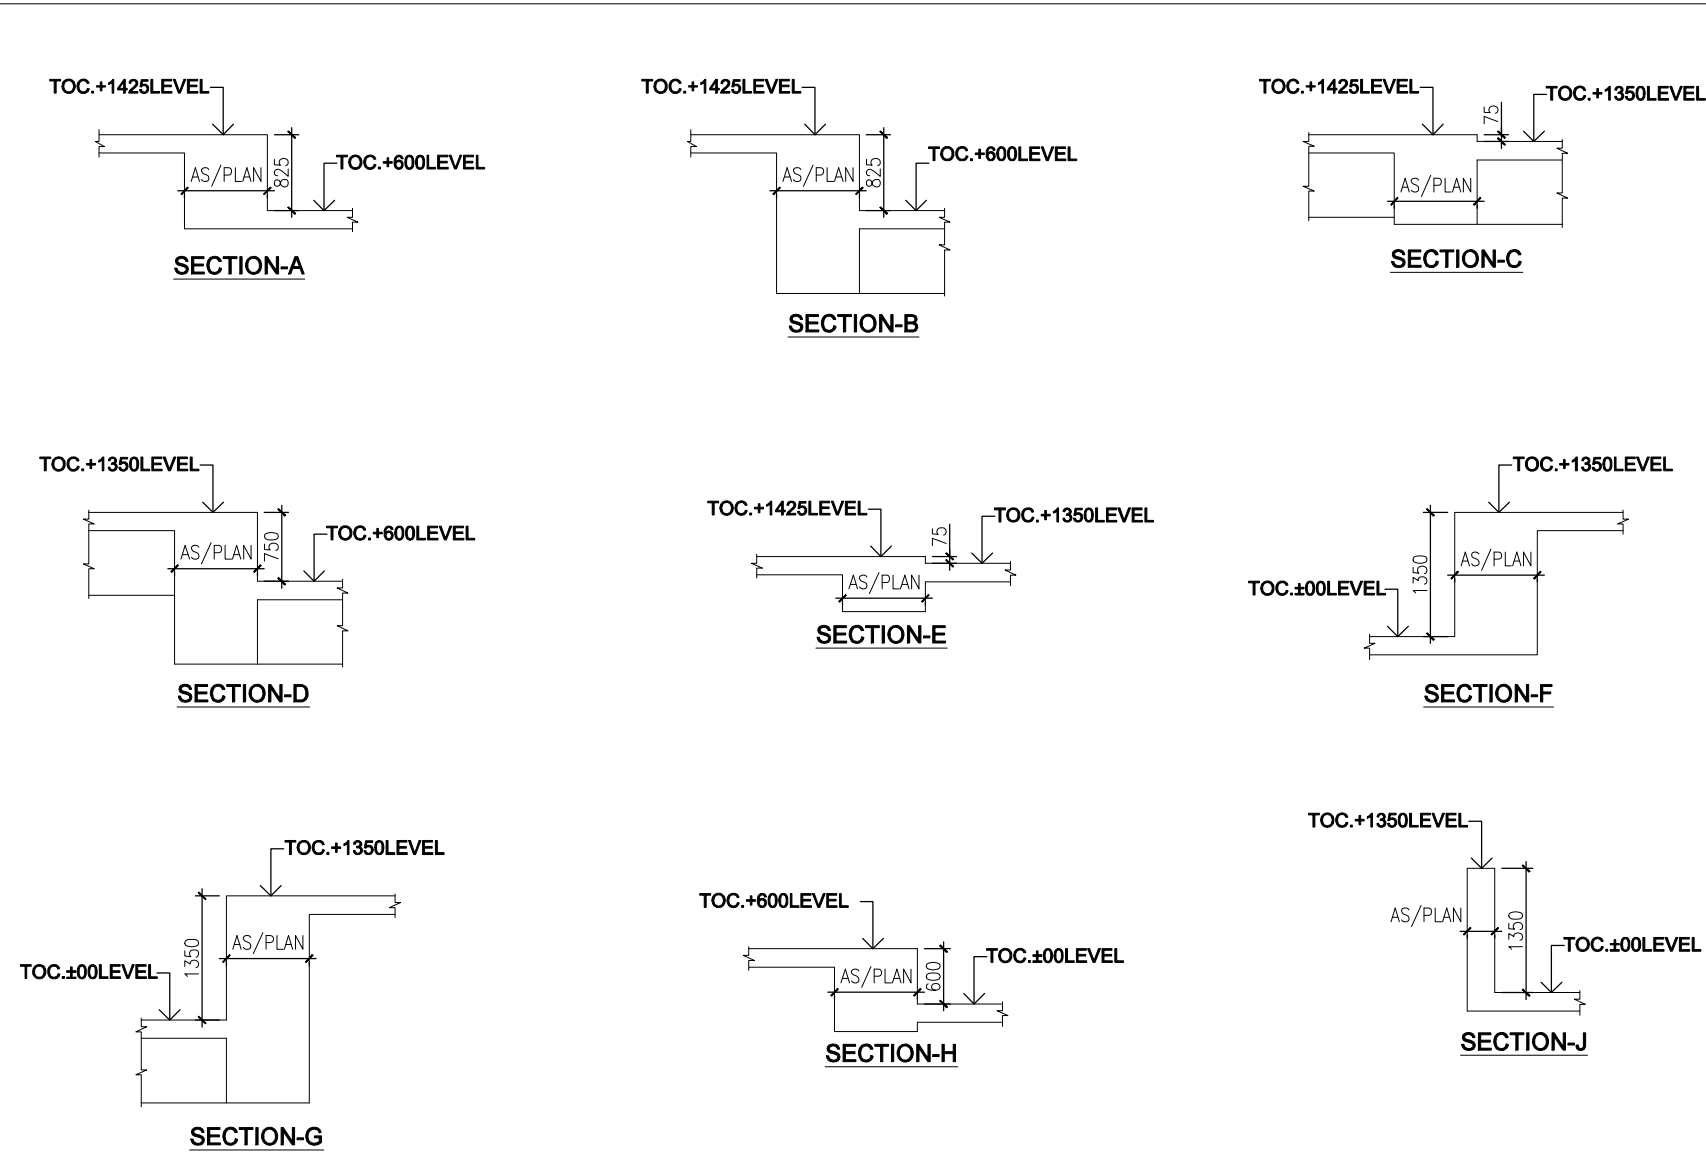


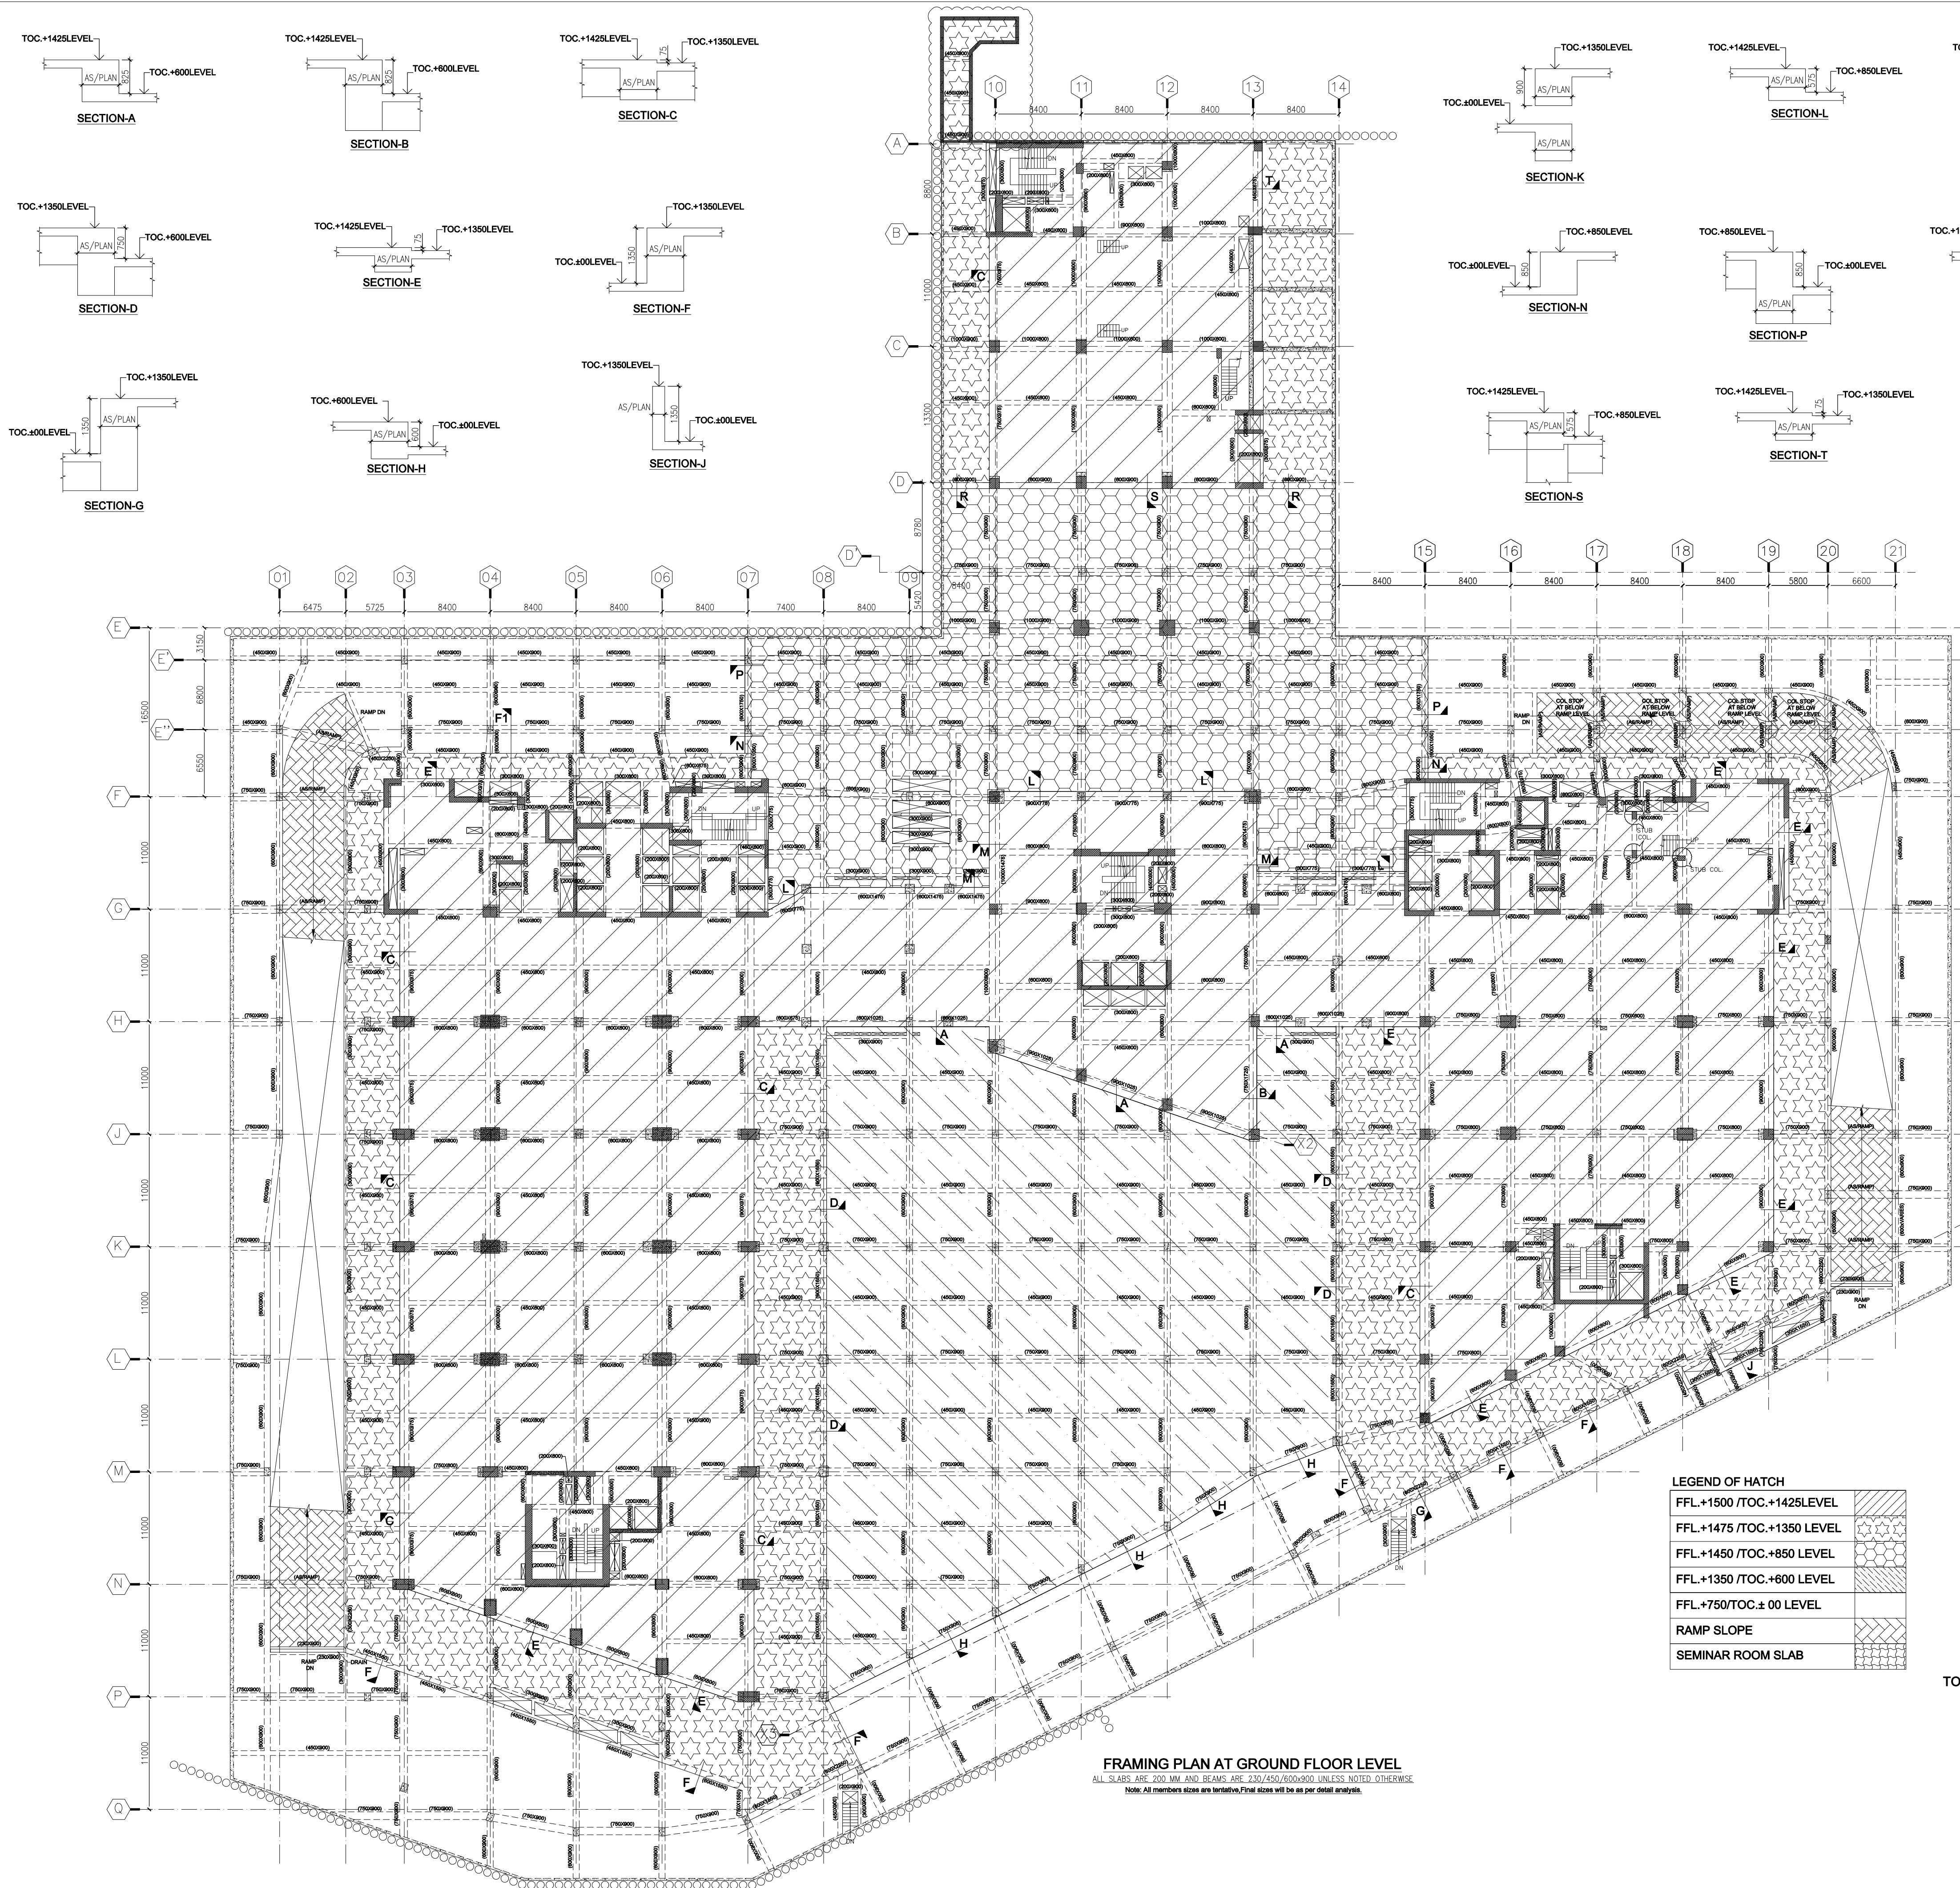

LANDSCAPE CONSULTANT
ORACLES
 Landscape Design/Planning & Conservation
 G-10, Kirti Nagar, New Delhi - 110028
 Phone: +91-11-2652 1185, 26521185, 26521185
 Email: oracles@oracleslandscape.in

PLUMBING AND FIRE FIGHTING CONSULTANTS
ENVIRON
 BUILDING SERVICES CONSULTANTS
 A-14, BANGSAR, DELHI
 NEW DELHI-110027
 Phone: +91-11-2652 1185, 26521185, 26521185
 Email: enviro@enviroconsultants.com

ELECTRICAL CONSULTANTS
Kanwar Krishan Associates Private Ltd.
 Engineers & Consultants
 F-105, Connaught Place, New Delhi - 110 008, INDIA
 Tel: +91-11-2652 1185, 26521185, 26521185
 Fax: +91-11-26521185
 E-mail: kkanwar@kanwarassociates.com

HVAC CONSULTANTS
KIRATYAN CREATIVE & ARCHITECTURE PVT. LTD.
 40/60, 2ND FLOOR, CHITRAKUT PARK
 NEW DELHI - 110 021
 Tel: +91-11-2652 1185, 26521185, 26521185
 Fax: +91-11-26521185
 E-mail: kiran@kiratyancreative.com

STRUCTURAL CONSULTANTS:
BMSF Design Consultants Pvt. Ltd.
 S-13/25, (Gr/Floor)
 G-10, Kirti Nagar, New Delhi - 110 028
 Phone: +91-11-2652 1185, 26521185, 26521185
 Email: bmsf@bmsfdesign.com

Design & Executive Architects
MAas
 D-229, Basement
 Surveyor's Enclave, New Delhi
 011-41829971, 71, 72

Concept Architects
Benoy
 CLIENT

Project title
 BUILDING PLAN OF I.T. PARK/ CYBER PARK COLONY
 MEASURING 6.1375 ACRES (LICENSE No.112 OF 2012
 DATED 27-10-2012) IN SECTOR-66,
 GURUGRAM MANESAR URBAN COMPLEX
 BEING DEVELOPED BY ADVANCE INDIA PROJECTS LTD.

Drawing title
 FRAMING PLAN AT GROUND FLOOR LEVEL

Job No.	Drawing No.
Drawn: KATARIA	RET-S-13.00
Checked: KK AHMAD	Revisions
Date: 30-08-21	NTS