


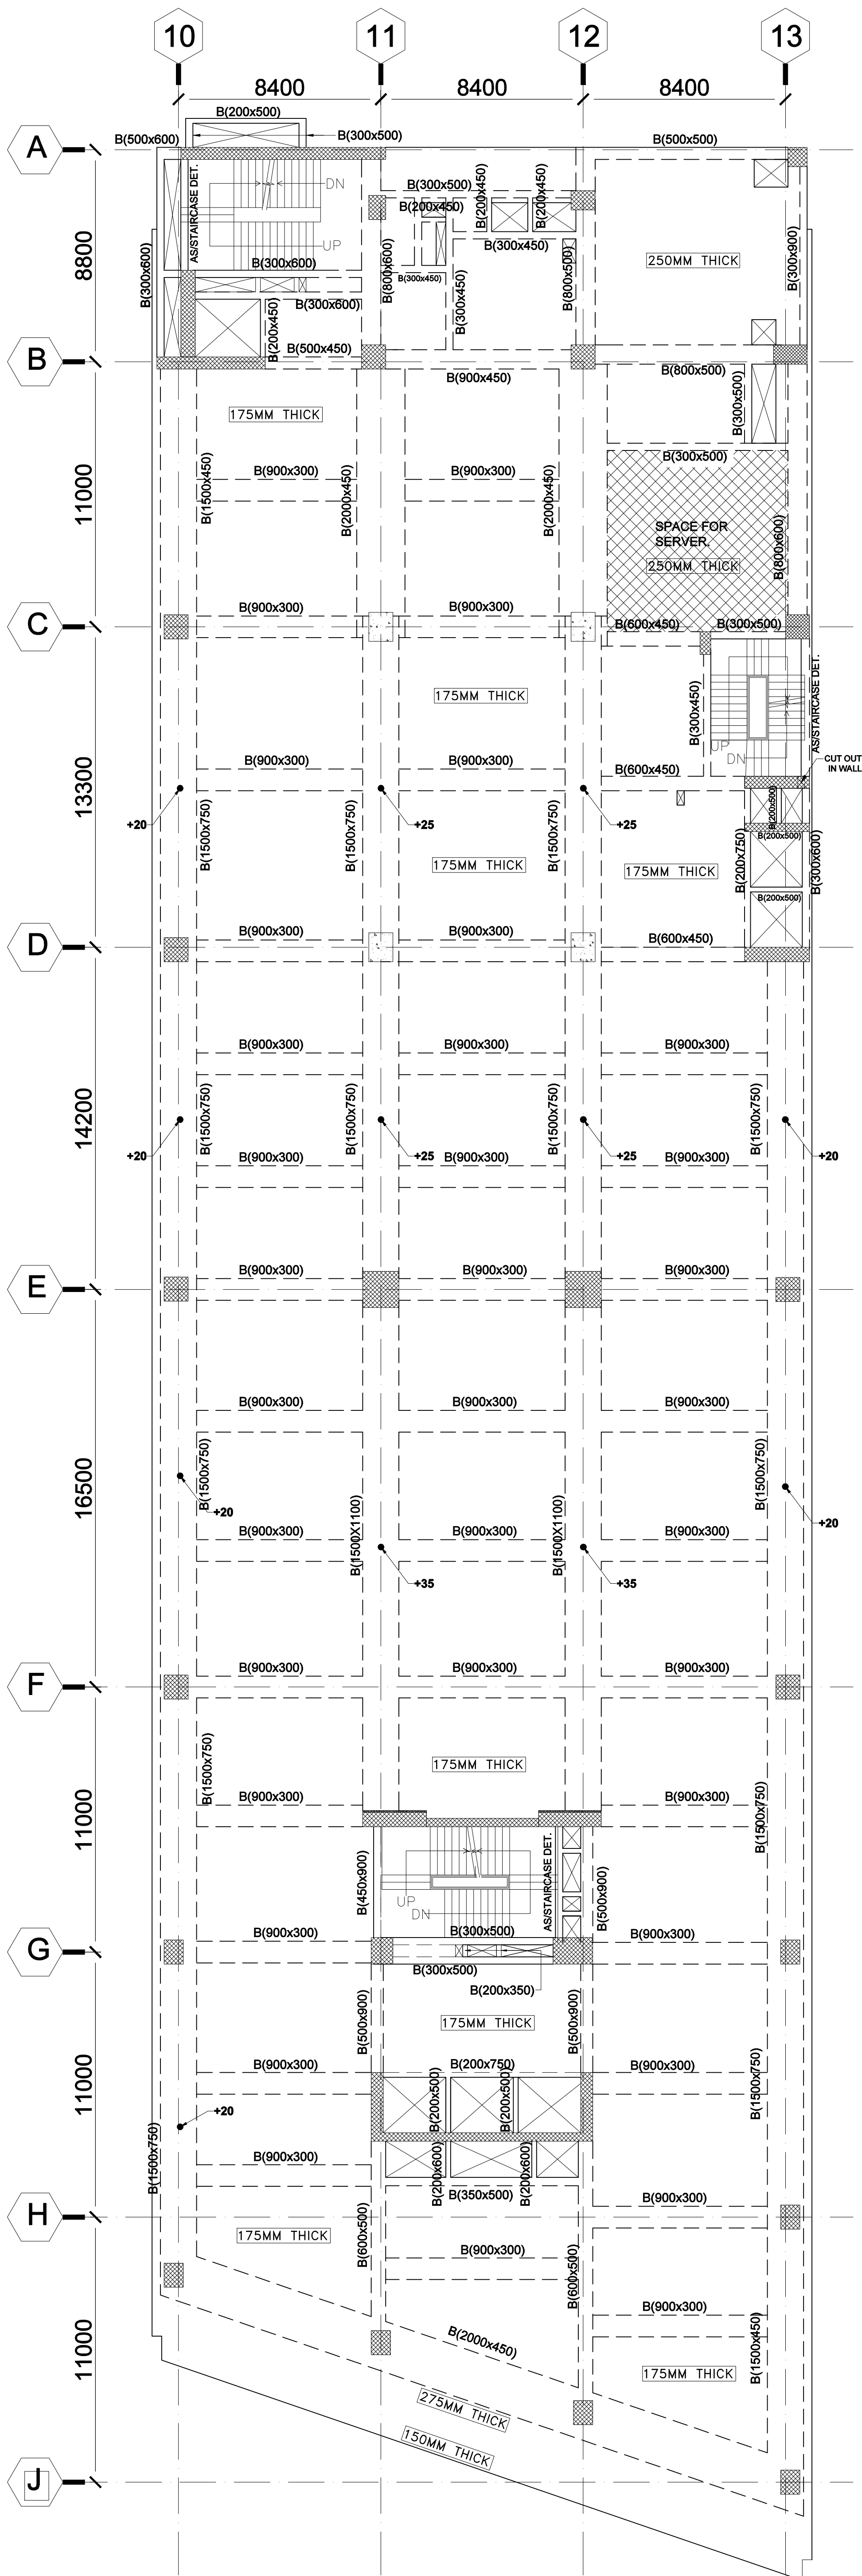

FRAMING PLAN AT TERRACE FLOOR LEVEL (TOWER-B)
ALL SLABS ARE 150MM THICK UNLESS NOTED OTHERWISE



LANDSCAPE CONSULTANT

ORACLES
Landscape Design, Planning & Conservation
G-98, KALKAJI
NEW DELHI-110019
PHONE :- 011-26481630, 26445095, 26462591
EMAIL :- mail@oracleslandscape.in

PLUMBING AND FIRE FIGHTING Consultants

ENVIRONS
BUILDING SERVICES CONSULTANTS
A-14 BASEMENT, SHIVAJI
NEW DELHI-110017
PHONE :- 011-2674787, 2674793
TEL/FAX :- 2952556
EMAIL :- environsconsultants@gmail.com

ELECTRICAL Consultants

Kanwar Krishen Associates Private Ltd.
Engineers & Consultants
F - 301, Lado Sarai, New Delhi - 110 035, INDIA
Tel: +91-11-2952 1180, 29521181, 2952 1182
Fax: +91-11-29521183
E-mail: kko@kkaapl.com

HVAC Consultants

UDAYAN CHAUDHARI & ASSOCIATES PVT. LTD.
40/60, 2nd FLOOR, CHITTARANJAN PARK
NEW DELHI - 110 019
TEL : 26415363, 26473312
FAX : 26283942
E-MAIL: udayan@udayari@gmail.com

STRUCTURAL CONSULTANT'S :

BMSF Design Consultants Pvt. Ltd.
S-13/25, (Gr.Floor)
DLF Phase-III,
Gurgaon - 122002
Haryana - 122002
PH: 0124-4113252

Design & Executive Architects

MAas
D-223, Basement
Sarvodaya Enclave, New Delhi
011-41829971, 71, 72

Concept Architects

Benoy

CLEINT



Project title
BUILDING PLAN OF I.T. PARK/ CYBER PARK COLONY
MEASURING 6.1375 ACRES (LICENSE No.112 OF 2012
DATED 27-10-2012) IN SECTOR-66,
GURUGRAM MANESAR URBAN COMPLEX
BEING DEVELOPED BY ADVANCE INDIA PROJECTS LTD.

Drawing title

FRAMING PLAN AT TERRACE FLOOR LEVEL
(TOWER- B)

Job No.

Drawn RAWAT Checked KK AHMAD

Date 30-08-21 Scale NTS

Drawing No.

OFF-S-13.R1

Revisions