


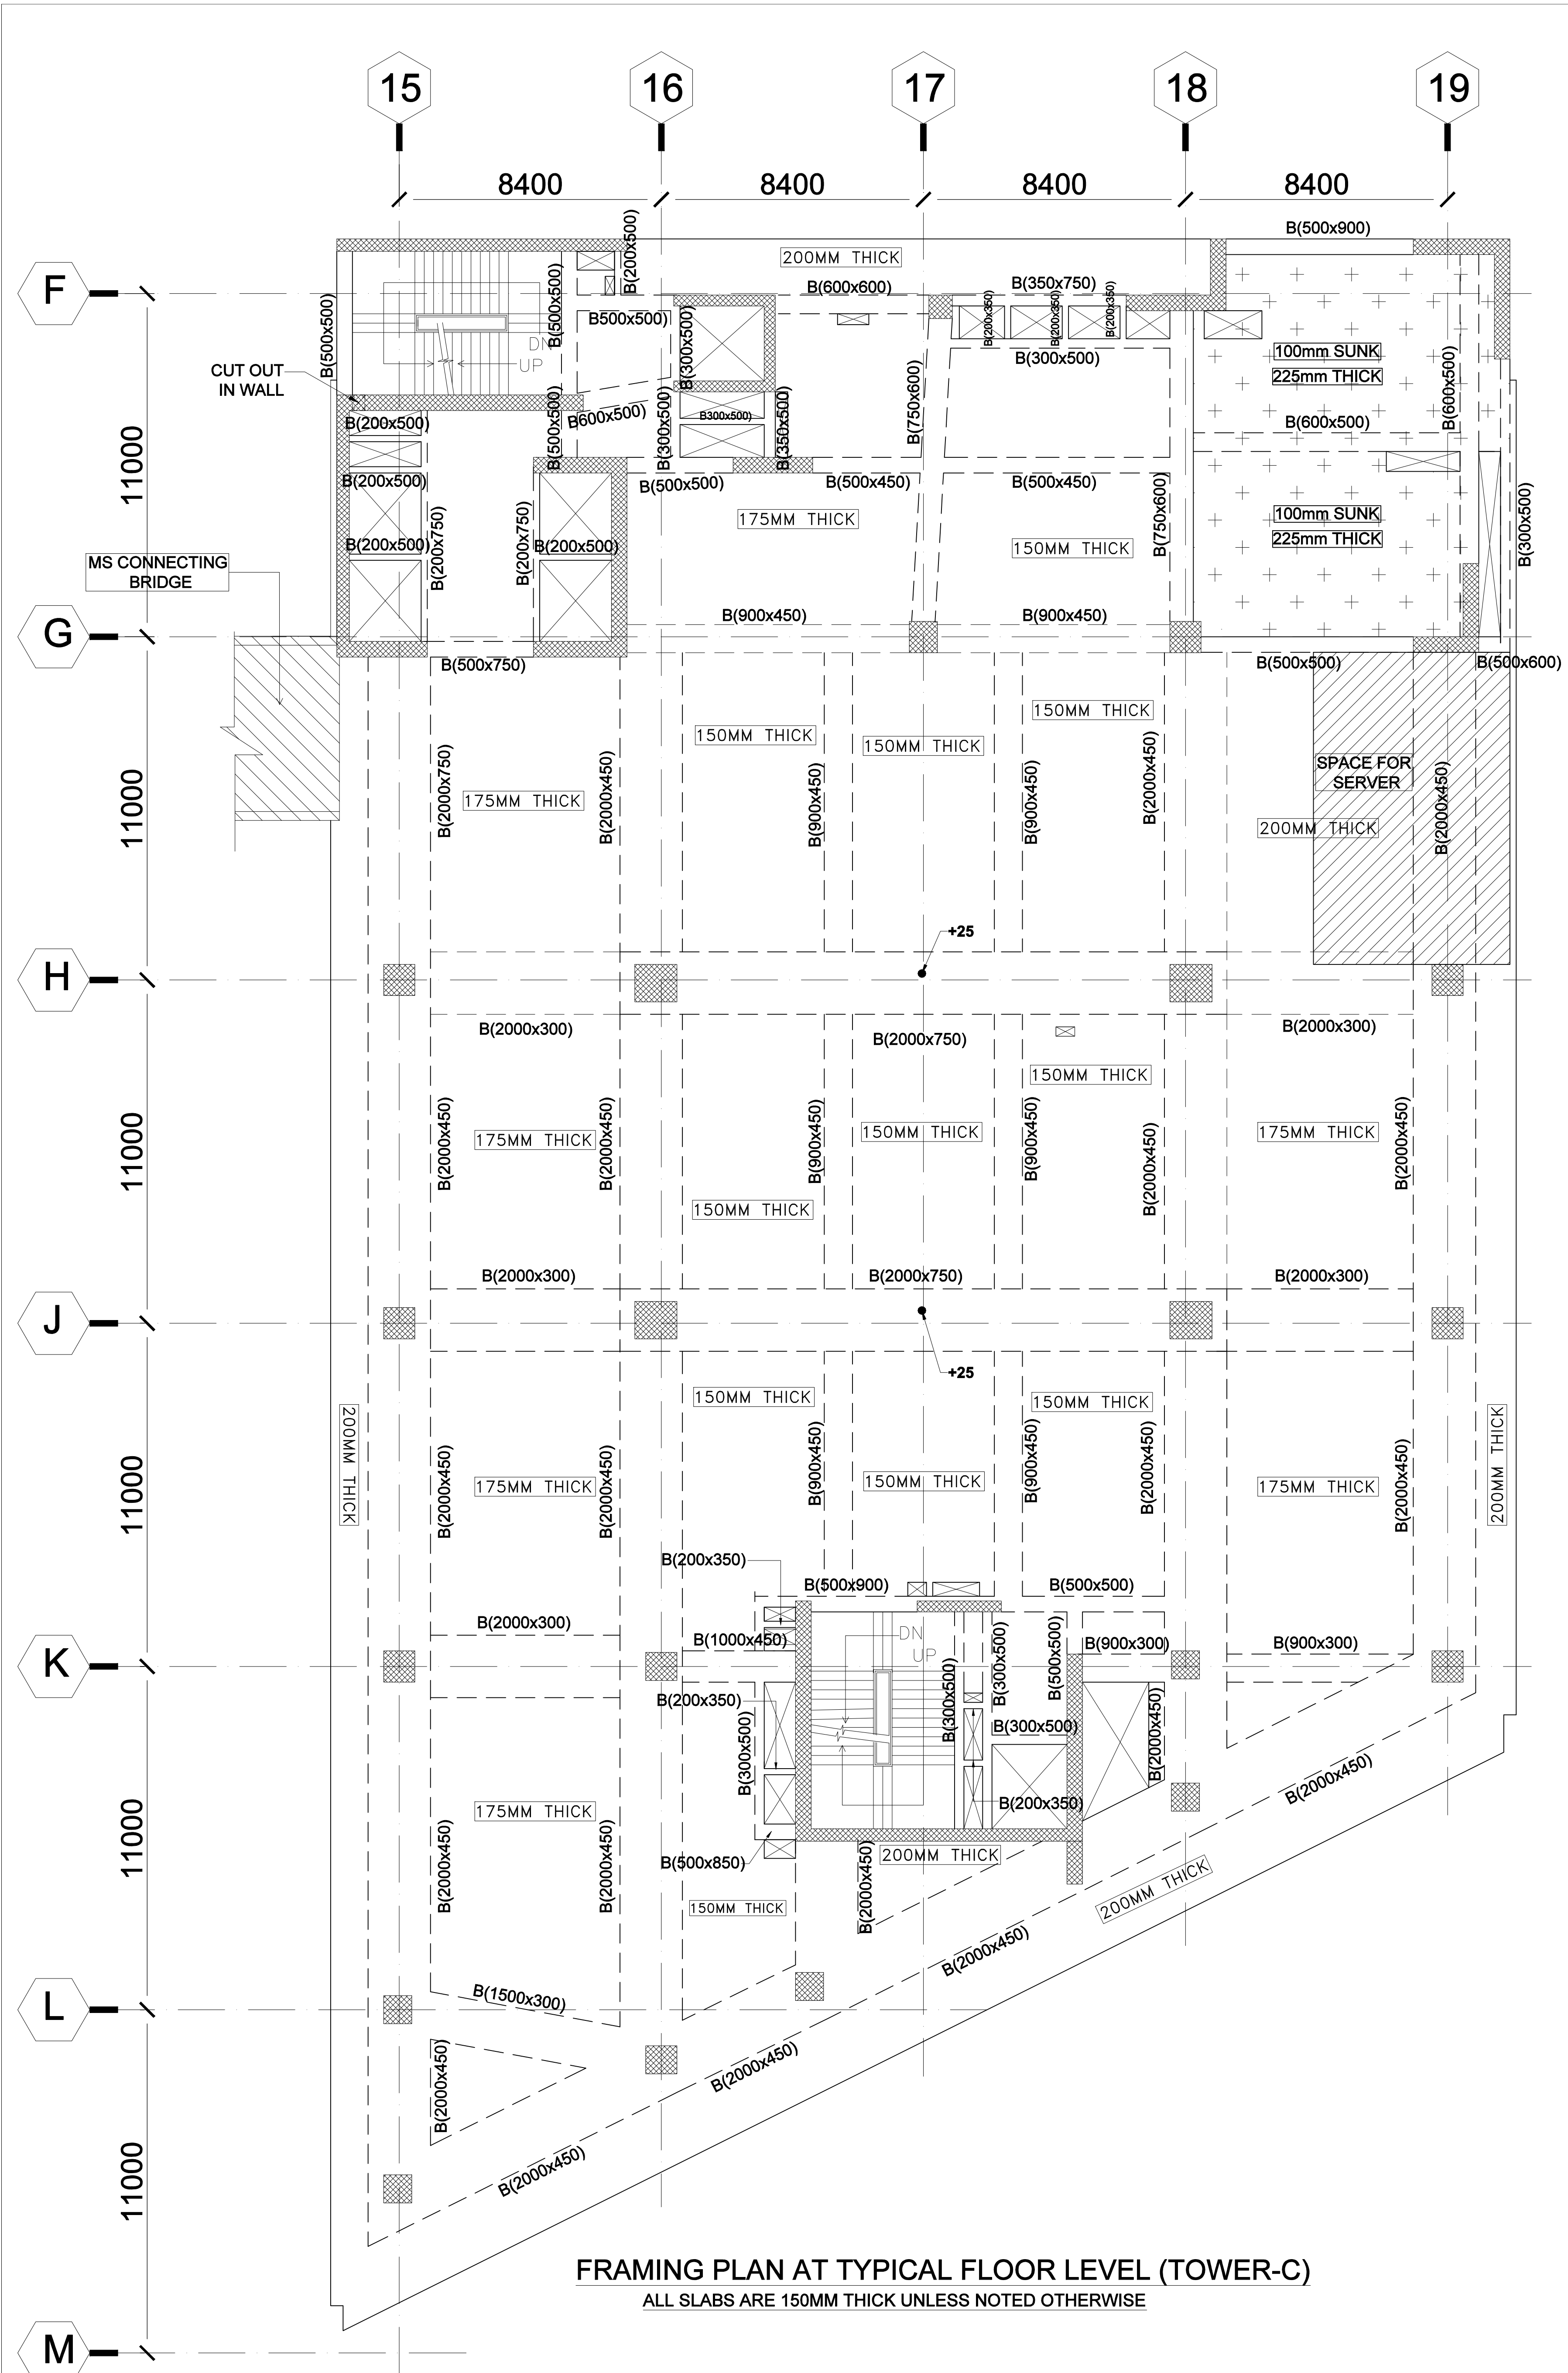

FRAMING PLAN AT TYPICAL FLOOR LEVEL (TOWER-C)
ALL SLABS ARE 150MM THICK UNLESS NOTED OTHERWISE



LANDSCAPE CONSULTANT

ORACLES
Landscape Design, Planning & Conservation
G-98, KALKAJI
NEW DELHI-110019
PHONE:- 011-26481630, 26445095, 26462591
EMAIL:- mail@oracleslandscape.in

PLUMBING AND FIRE FIGHTING Consultants
ENVIRONS
BUILDING SERVICES CONSULTANTS
A-14, BASEMENT, SHIVAJI
NEW DELHI-110017
PHONE:- 011-2674787, 26674793
TEL/FAX:- 29521564
EMAIL:- environsconsultants@gmail.com

ELECTRICAL Consultants
Kanwar Krishen Associates Private Ltd.
Engineers & Consultants
F - 301, Lado Sarai, New Delhi - 110 035, INDIA
Tel: +91-11-2952 1180, 29521181, 2952 1182
Fax: +91-11-29521183
E-mail: kko@kkaapl.com

HVAC Consultants
UDAYAN CHAUDHARI & ASSOCIATES PVT. LTD.
40/60, 2nd FLOOR, CHITTARANJAN PARK
NEW DELHI - 110 019
TEL: + 26418363, 26471312
FAX: + 26283942
E-MAIL: udayanchoudhari@gmail.com

STRUCTURAL CONSULTANT'S :
BMSF Design Consultants Pvt. Ltd.
S-13/25, (Gr.Floor)
DLF Phase -III,
Gurgaon - 122002
Haryana - 122002
PH: 0124-4113252

Design & Executive Architects
MAas
D-223, Basement
Sarvodaya Enclave, New Delhi
011-41829971, 71, 72

Concept Architects
Benoy

CLEINT
aip/Δ
values that build worth

Project title
BUILDING PLAN OF I.T. PARK/ CYBER PARK COLONY
MEASURING 6.1375 ACRES (LICENSE No.112 OF 2012
DATED 27-10-2012) IN SECTOR-86,
GURUGRAM MANESAR URBAN COMPLEX
BEING DEVELOPED BY ADVANCE INDIA PROJECTS LTD.

Drawing title
FRAMING PLAN AT TYPICAL FLOOR LEVEL
(TOWER- C)

Job No.		Drawing No.	
Drawn	Checked	OFF-S-13.ZZ	
RAWAT	KK AHMAD		
Date	Scale	Revisions	
30-08-21	NTS		