


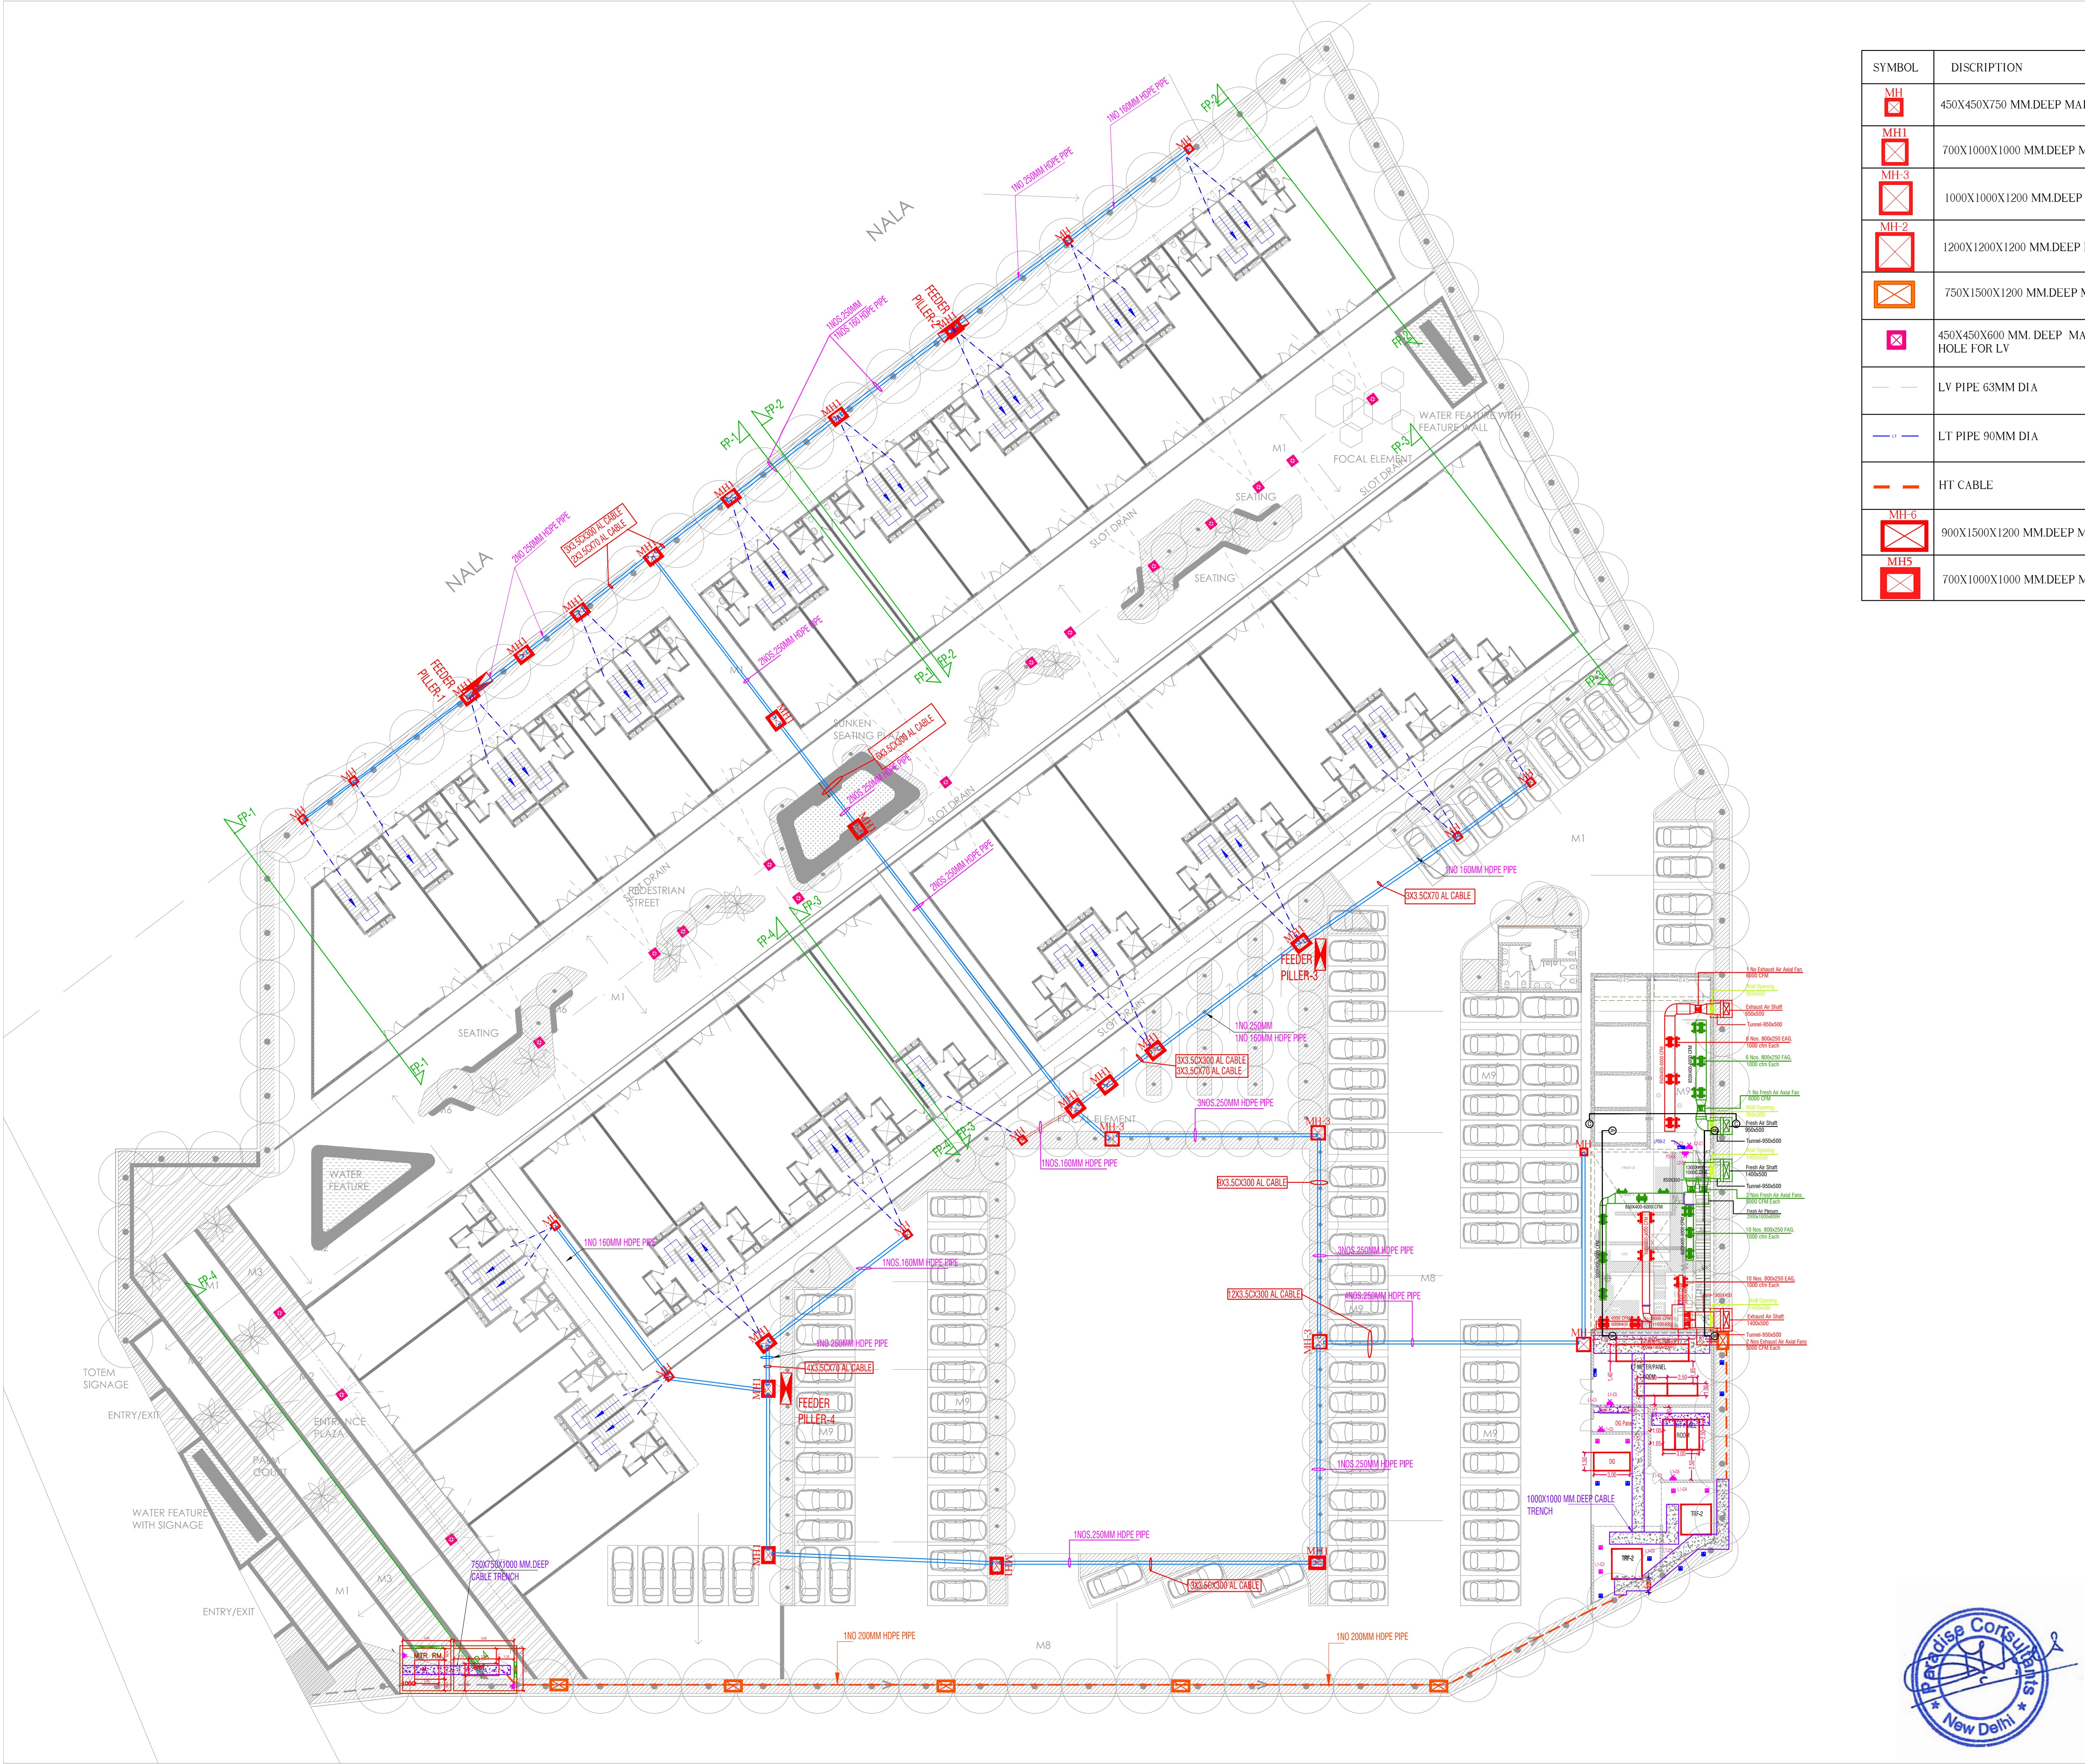

SYMBOL	DISCRIPTION
	450X450X750 MM.DEEP MAIN HOLE
	700X1000X1000 MM.DEEP MAIN HOLE
	1000X1000X1200 MM.DEEP MAIN HOLE
	1200X1200X1200 MM.DEEP MAIN HOLE
	750X1500X1200 MM.DEEP MAIN HOLE
	450X450X600 MM. DEEP MAIN HOLE FOR LV
	LV PIPE 63MM DIA
	LT PIPE 90MM DIA
	HT CABLE
	900X1500X1200 MM.DEEP MAIN HOLE
	700X1000X1000 MM.DEEP MAIN HOLE

ISSUES				
NO.	DATE	BY	DESCRIPTION	PRINTS

REVISIONS				
NO.	DATE	BY	DESCRIPTION	

OWNER'S SIGNATURE

MEP CONSULTANTS:

PARADISE CONSULTANTS
Paradise ConsultantsPlot No. 96,
Basement, Pocket 1
Near Living Style Mall, Jasola Vihar
New Delhi - 110025Landline
+91-11-29943601, 41030619
Web www.paradiseconsultants.com

ARCHITECT'S SIGNATURE

MAAS
ARCHITECTURE, INTERIORS, PLANNING
D-229, Basement, sarvodaya Enclave, New Delhi-110017
Ph. : 011-41829970/71/72/74
E-mail : studio@maasarchitects.net
Website : www.maasarchitects.net

OWNER:-

M/S EMAAR INDIA LTD.

PROJECT:-

Proposed Plan of Commercial Plotted Colony (SCO) EBD 89 NXT on land measuring 2.99375 Acres falling in the revenue estate of village Badha, Sec-89, Gurugram being developed by Emaar India Ltd.

DRAWING TITLE :			
<u>EXTERNAL SITE PLAN (PART 2)</u> ELECTRICAL LAYOUT			
scale :	1:300(A1)	drawn by :	M.S
date :	11/08/21	checked by :	ATIQ
project no :	-----	approved by :	NAFEES
drawing no :		EL-PC-SCO-SITE-102	
REVISION	RO		