
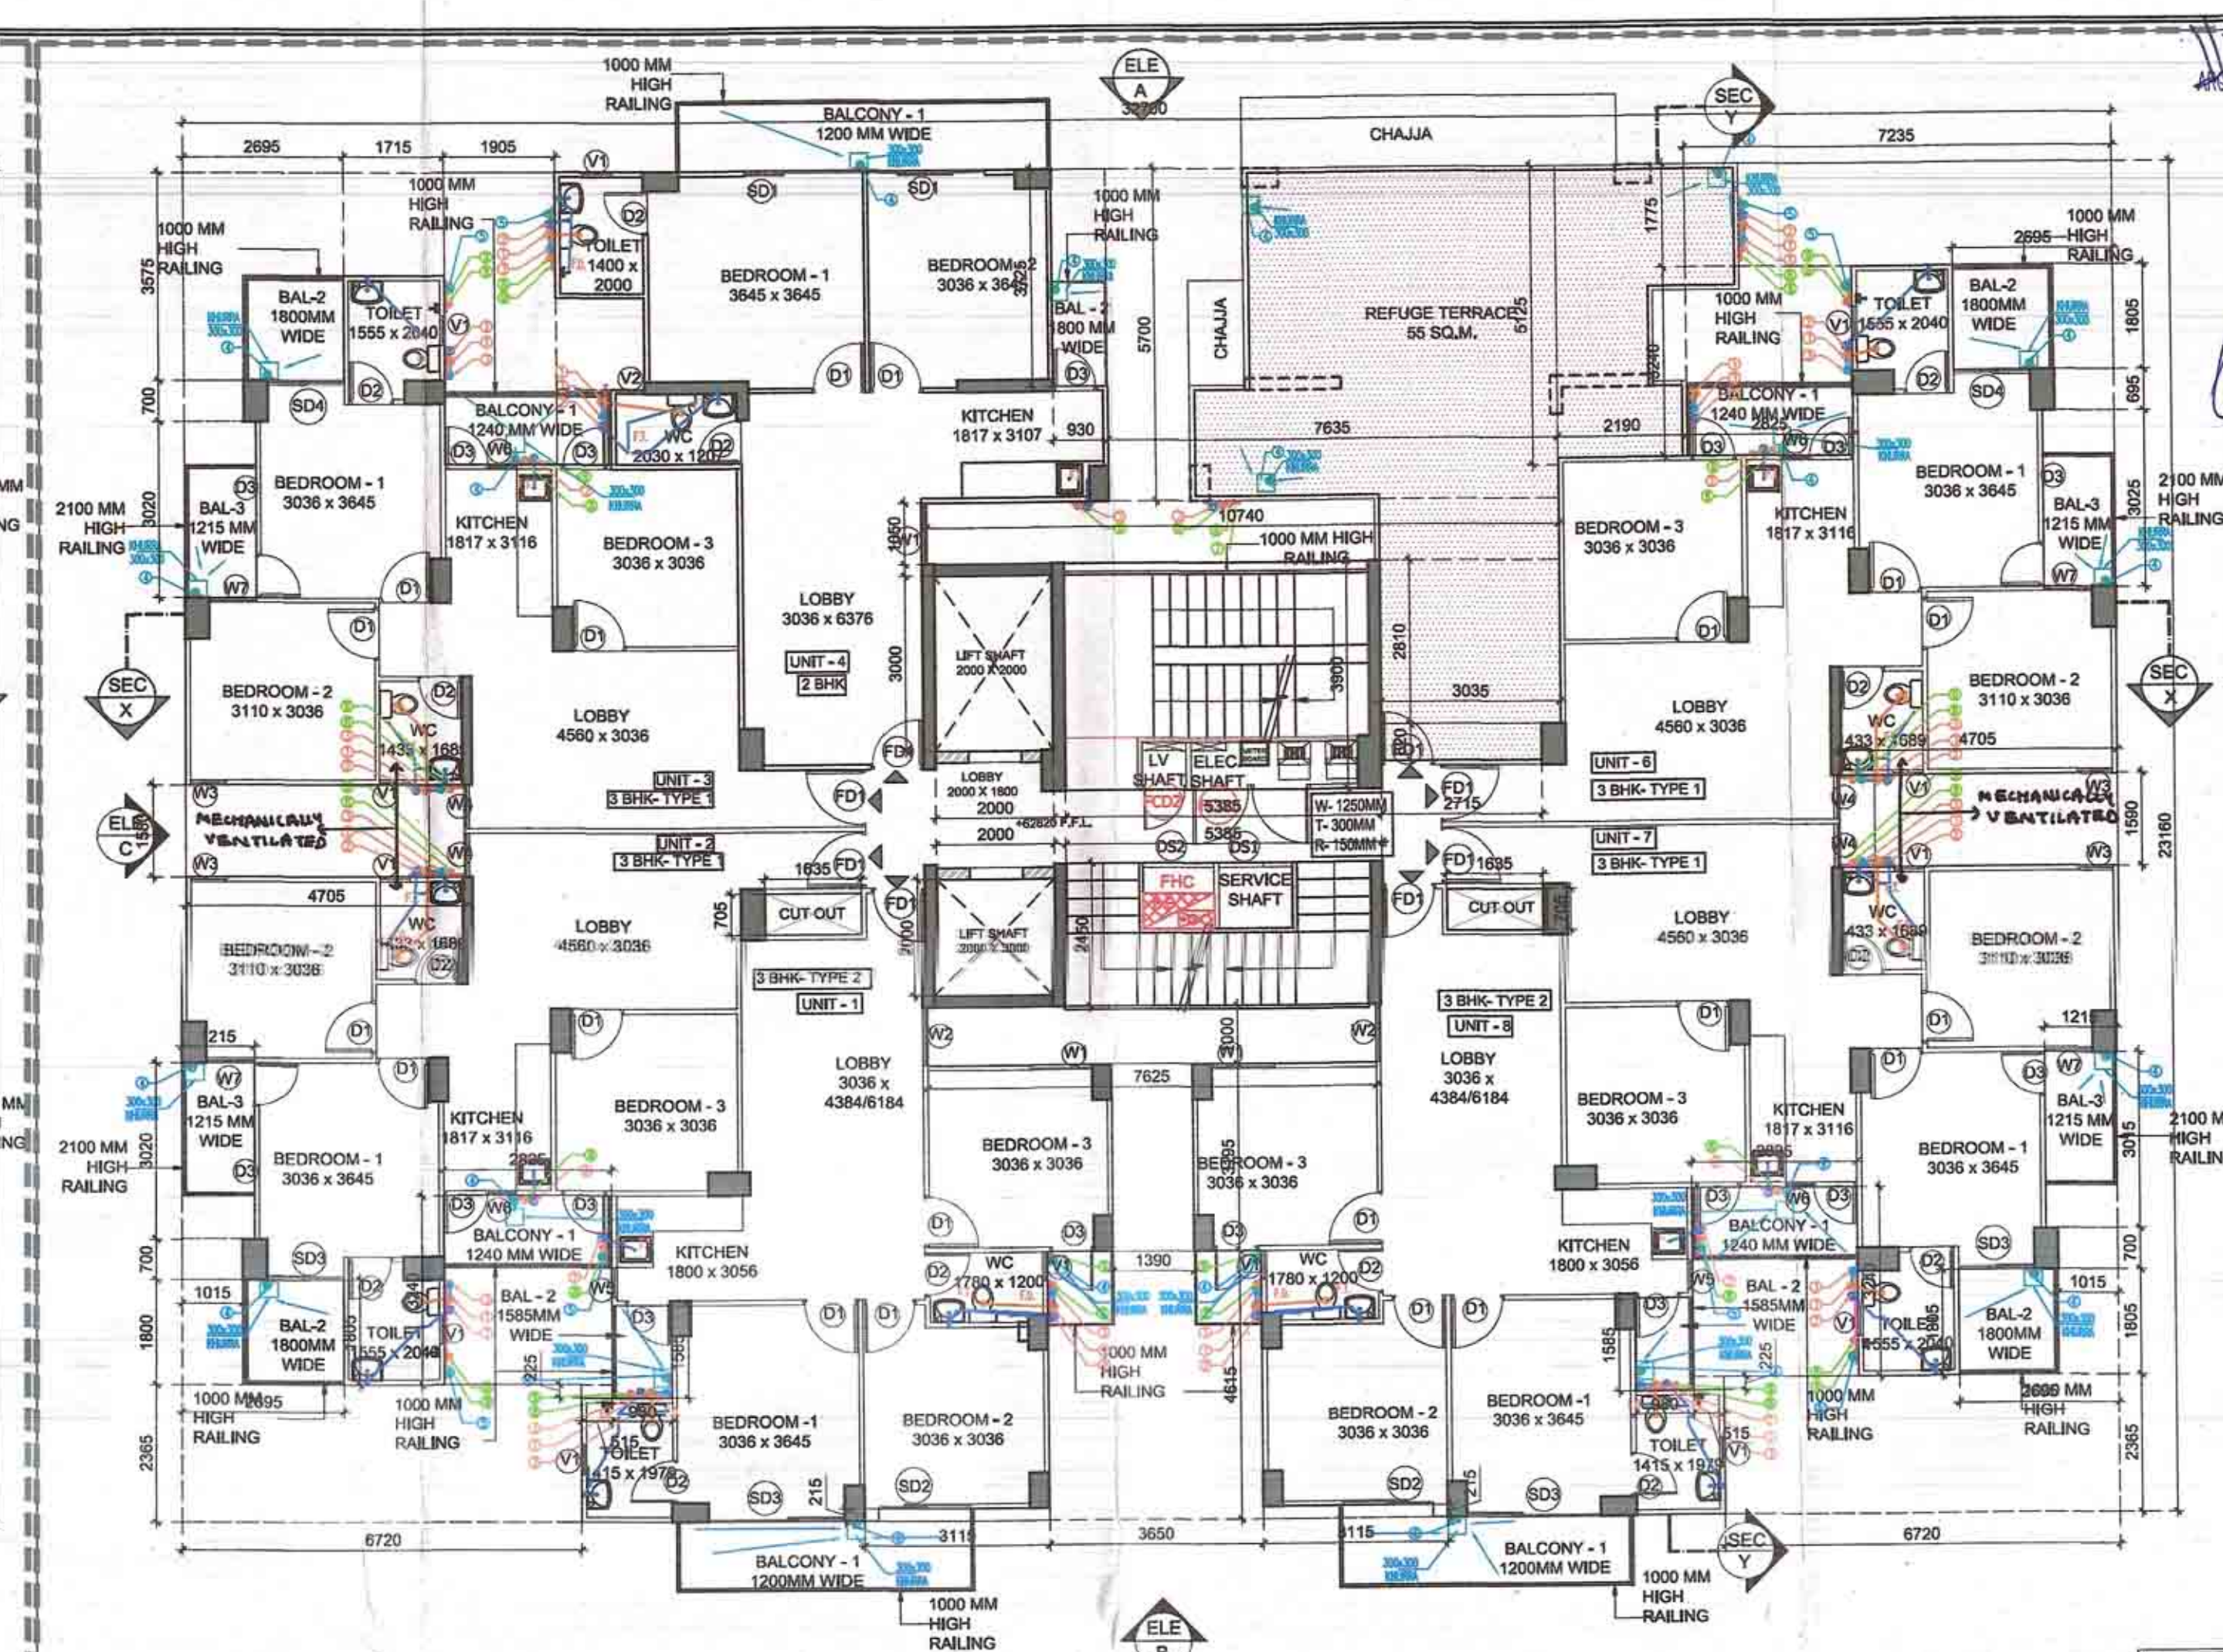
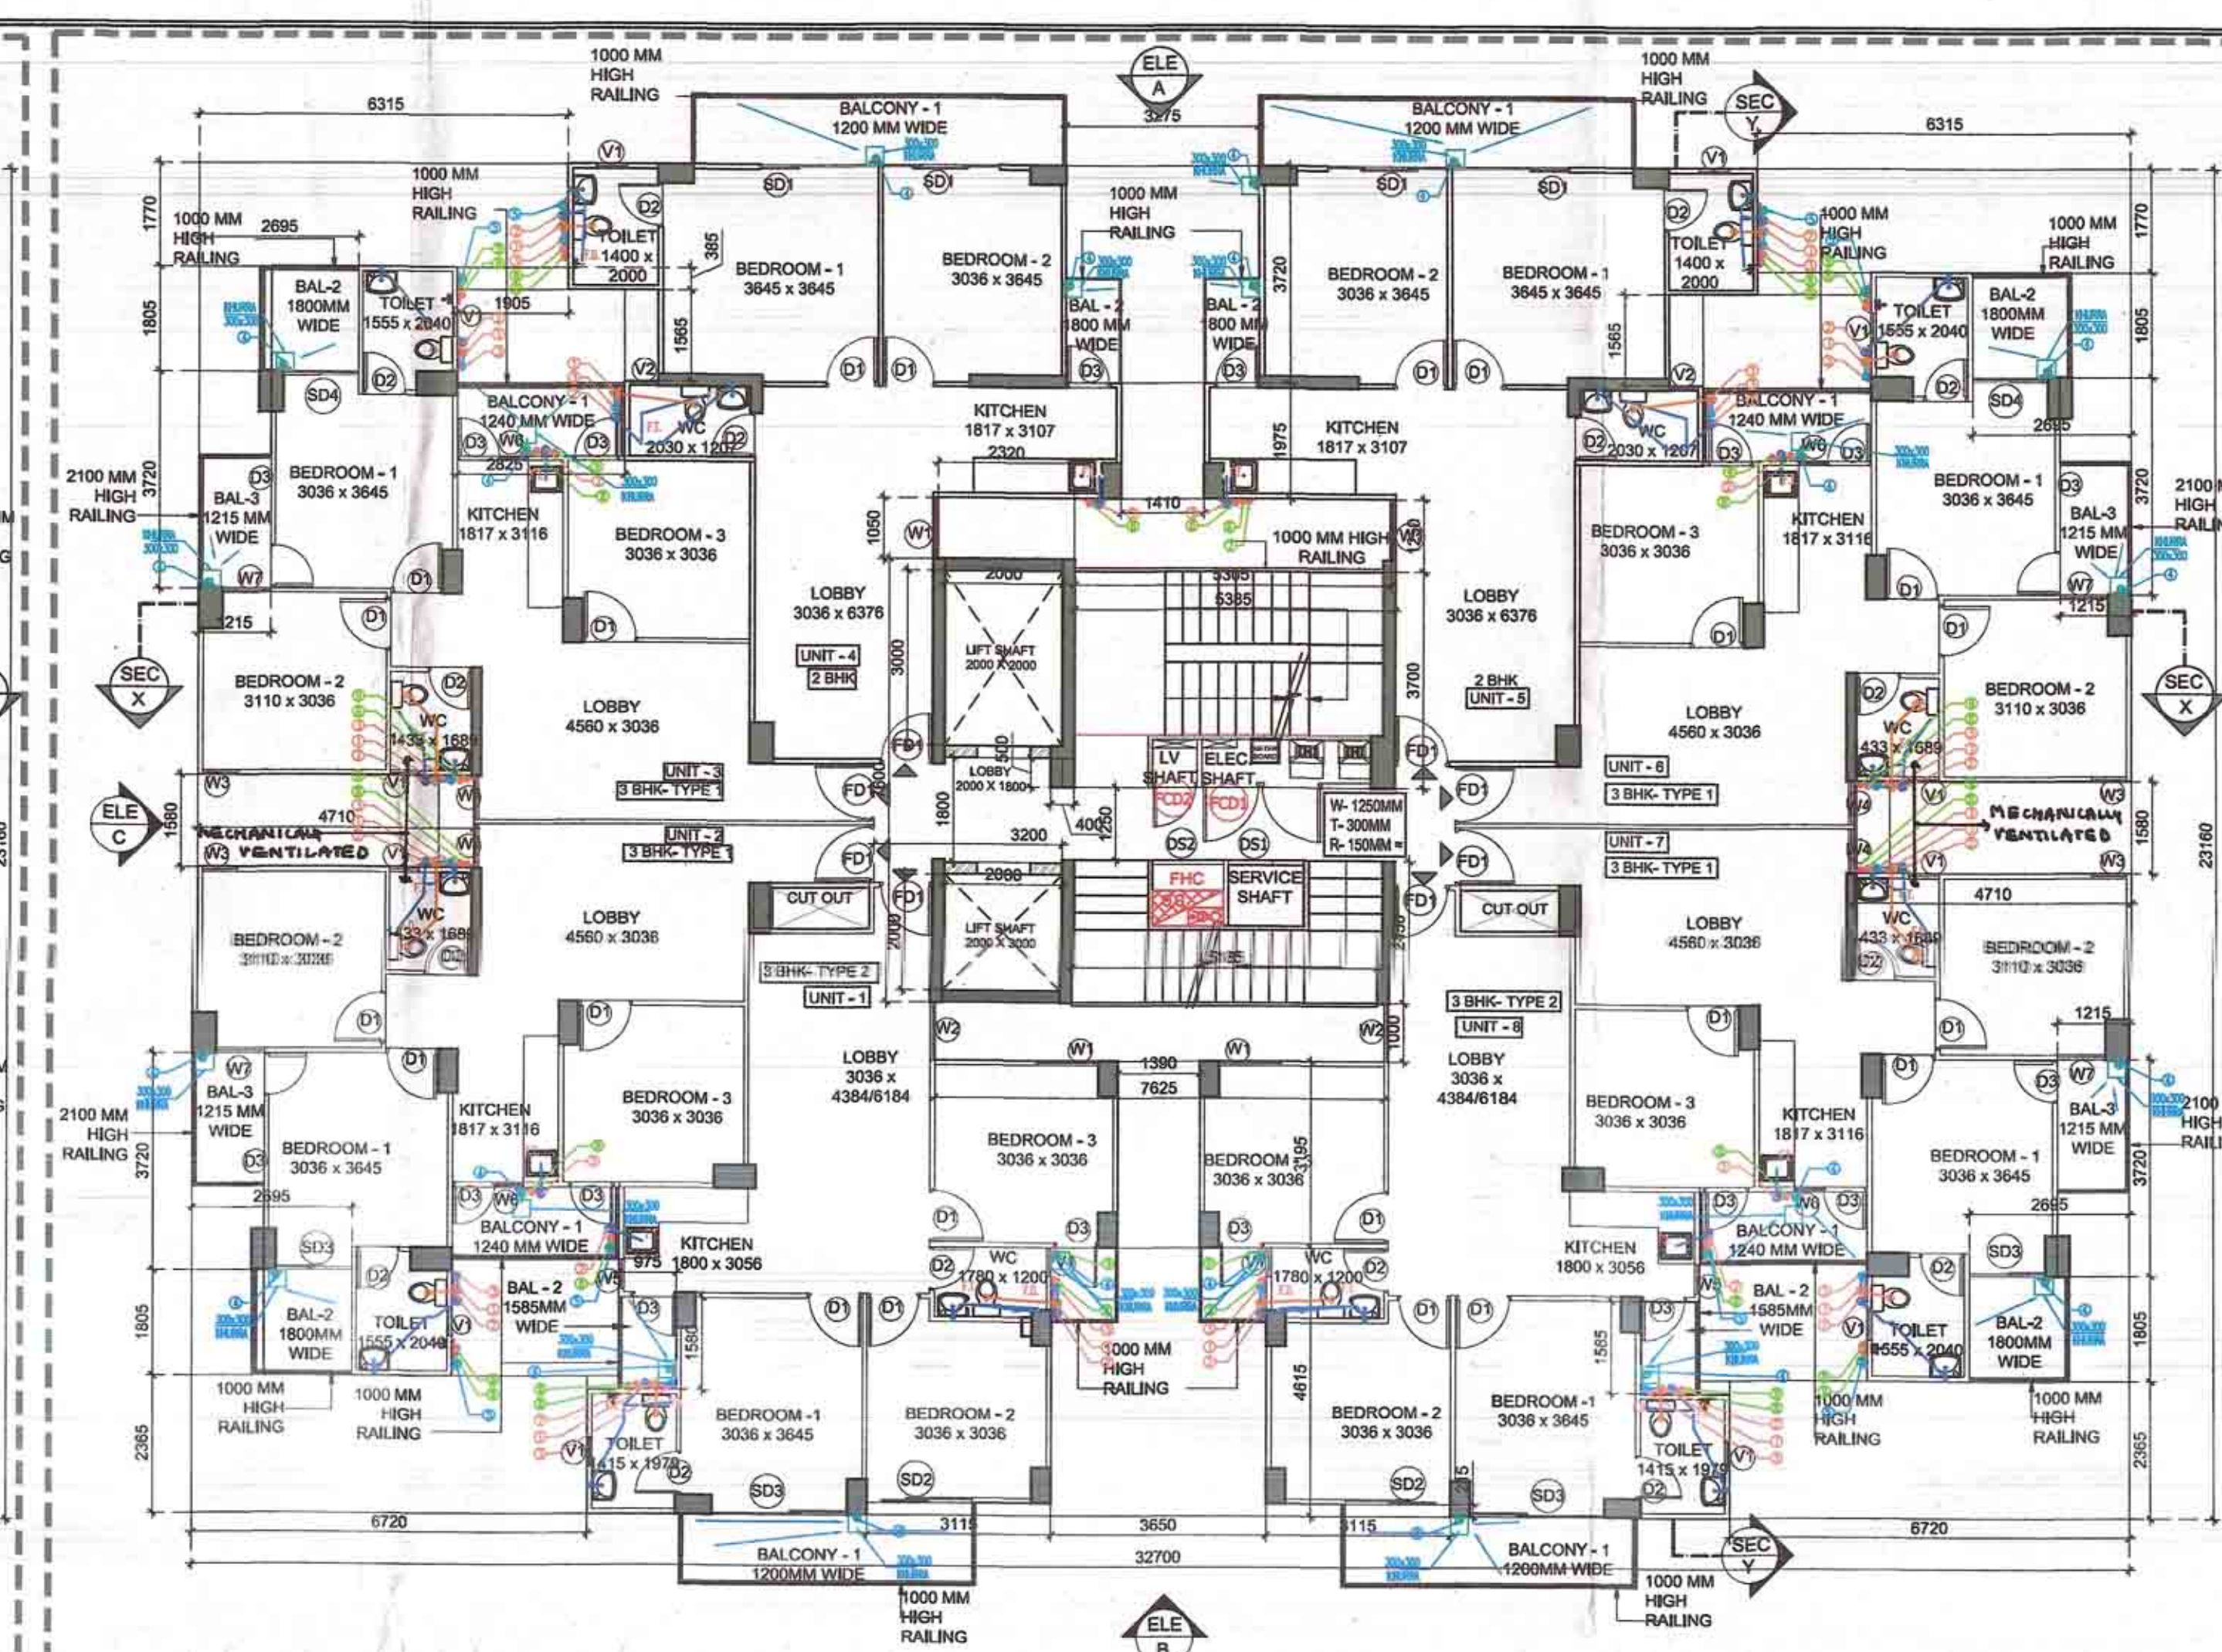




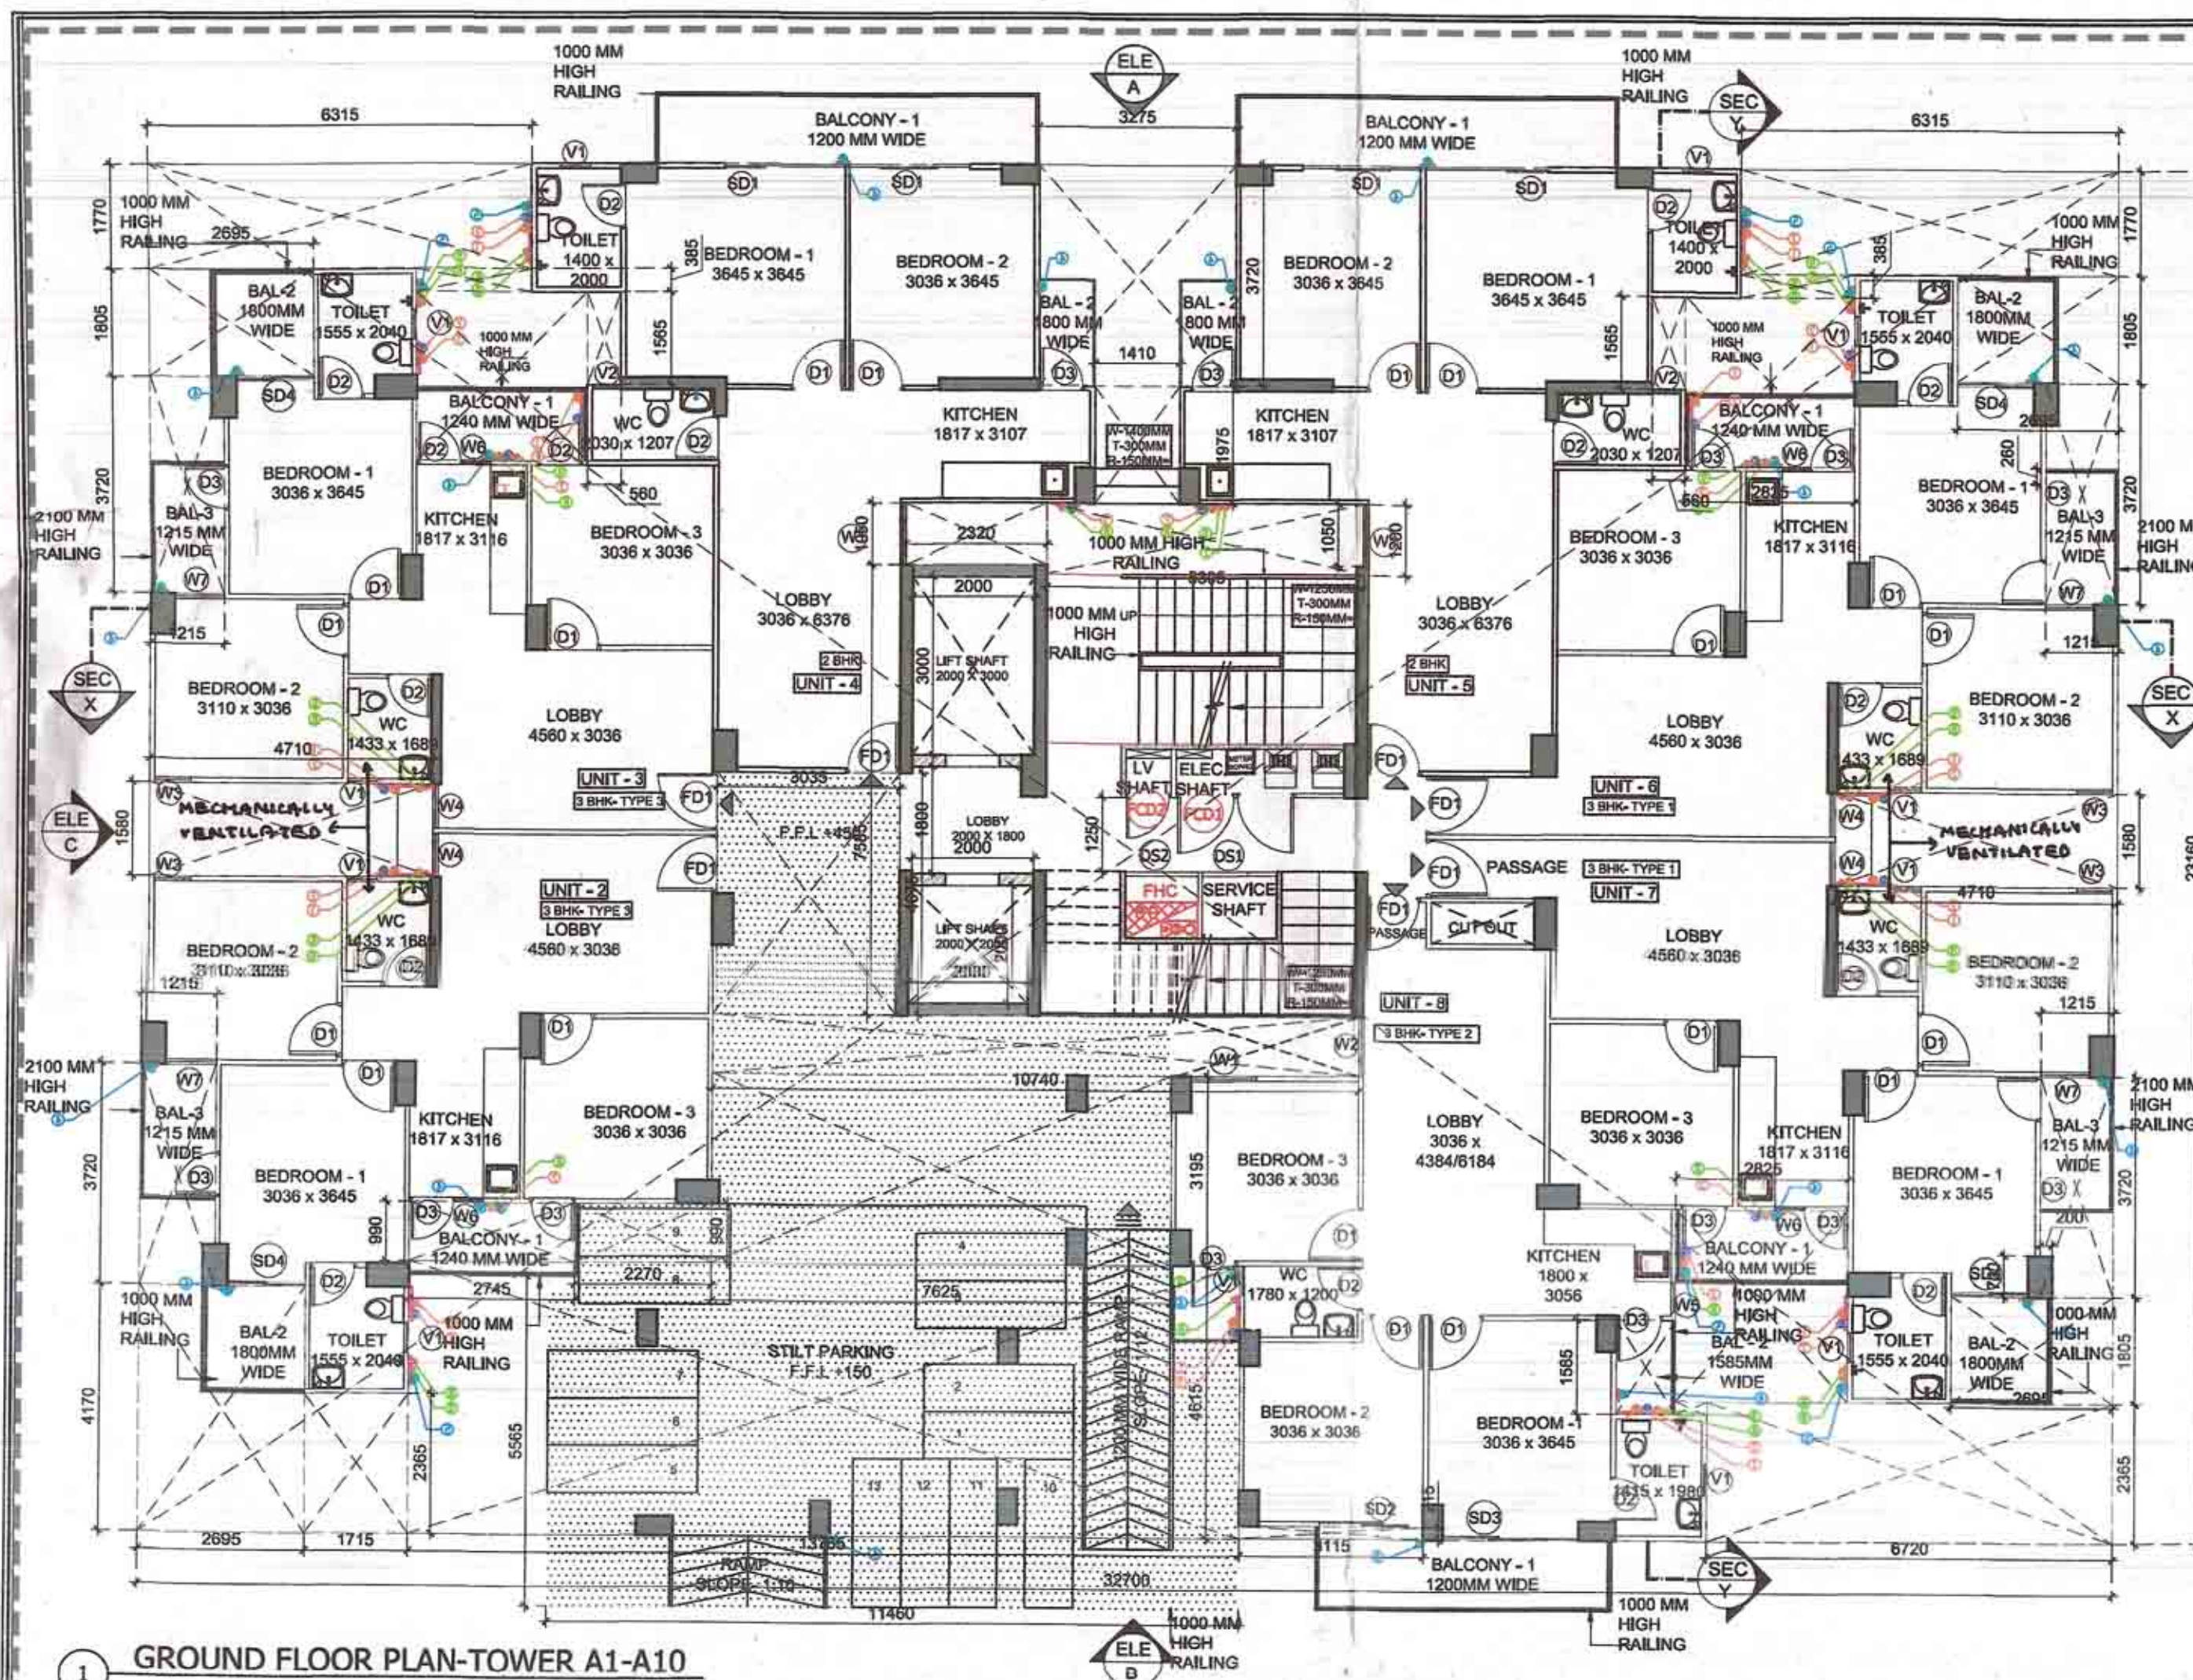


PLUMBING LEGEND:

1. HOT WATER SUPPLY (HWS) & HOT WATER RETURN (HWR) PIPES
2. COLD WATER SUPPLY (CWS) & COLD WATER RETURN (CWR) PIPES
3. HOT WATER SUPPLY (HWS) & HOT WATER RETURN (HWR) PIPES (FOR TERRACE)
4. SANITARY PIPES TO DATE PLUMBING
5. SANITARY PIPES TO DATE PLUMBING
6. SANITARY PIPES TO DATE PLUMBING
7. FLOORING WATER SUPPLY ON THE FLOOR

DOOR & WINDOW SCHEDULE

DESCRIPTION	WIDTH	HEIGHT	LOCATION
D1	800	2100	BEDROOM
D2	700	2100	TOILET
D3	700	2100	BALCONY
D4	1200	2200	LOBBY
D5	1200	2100	TERRACE
D6	1200	2100	LOBBY
D7	1200	2100	LOBBY
D8	1200	2100	BALCONY
D9	1200	2100	BALCONY
D10	1200	2100	BALCONY
D100	1200	2100	BALCONY

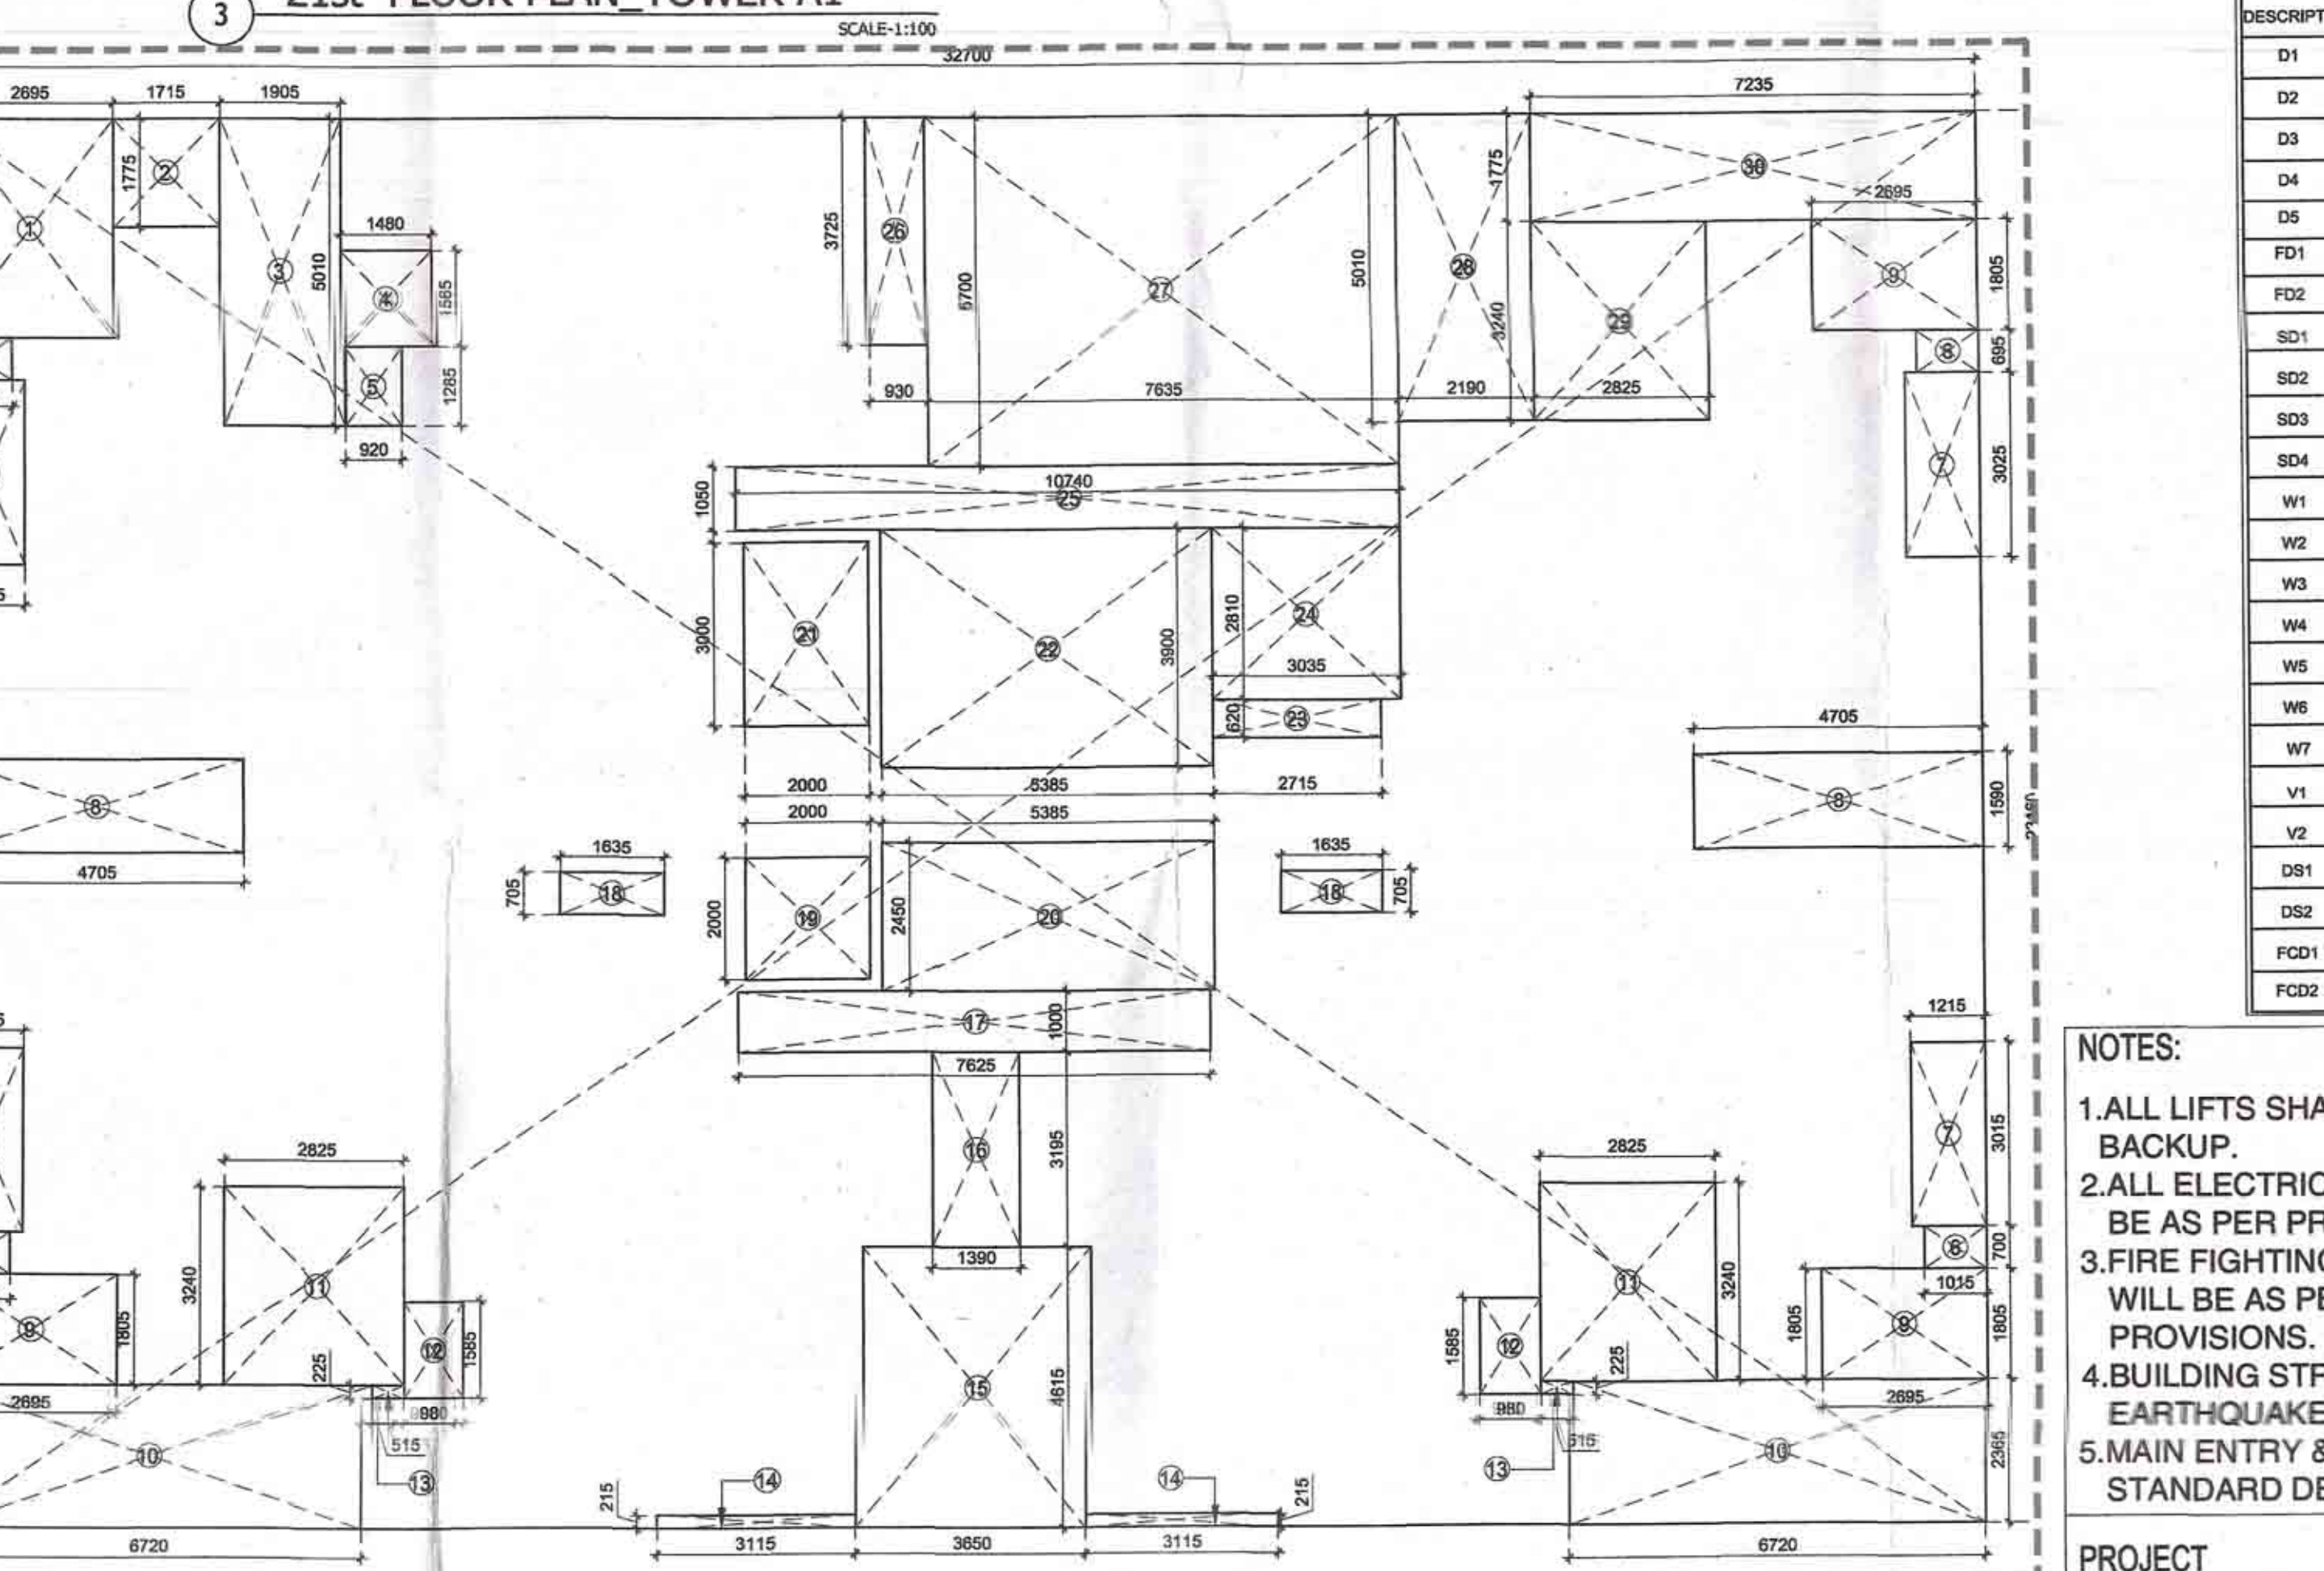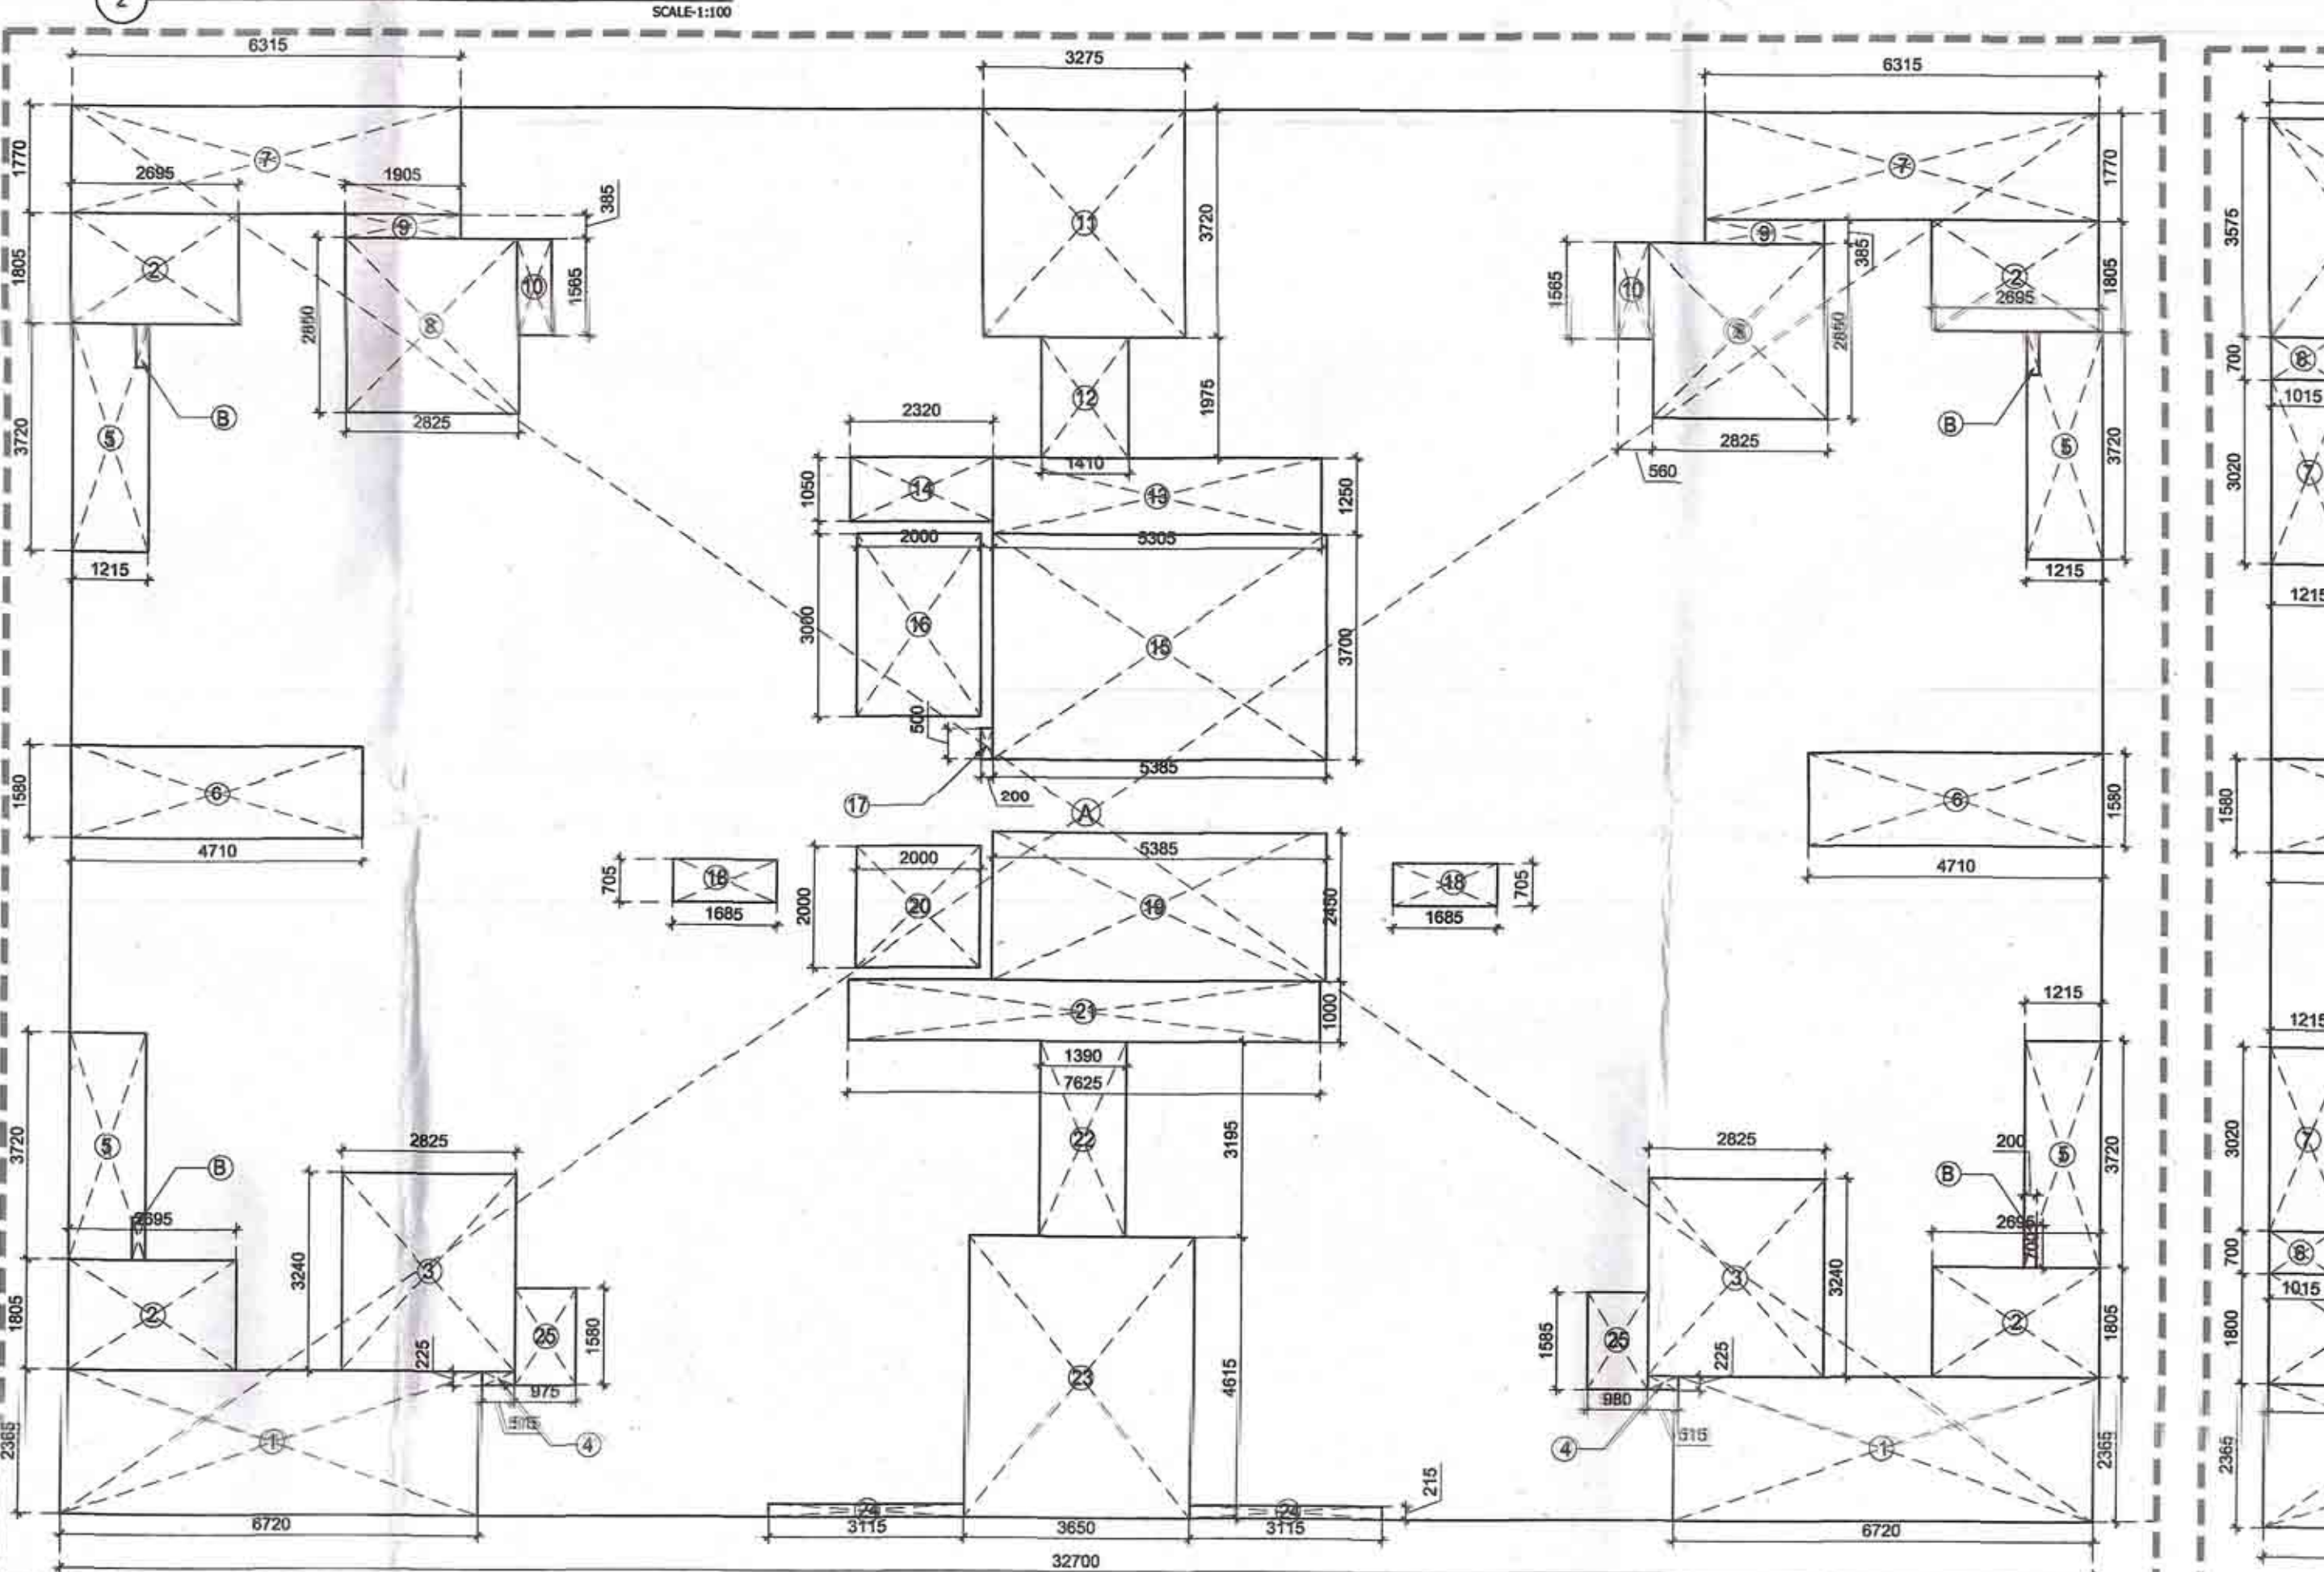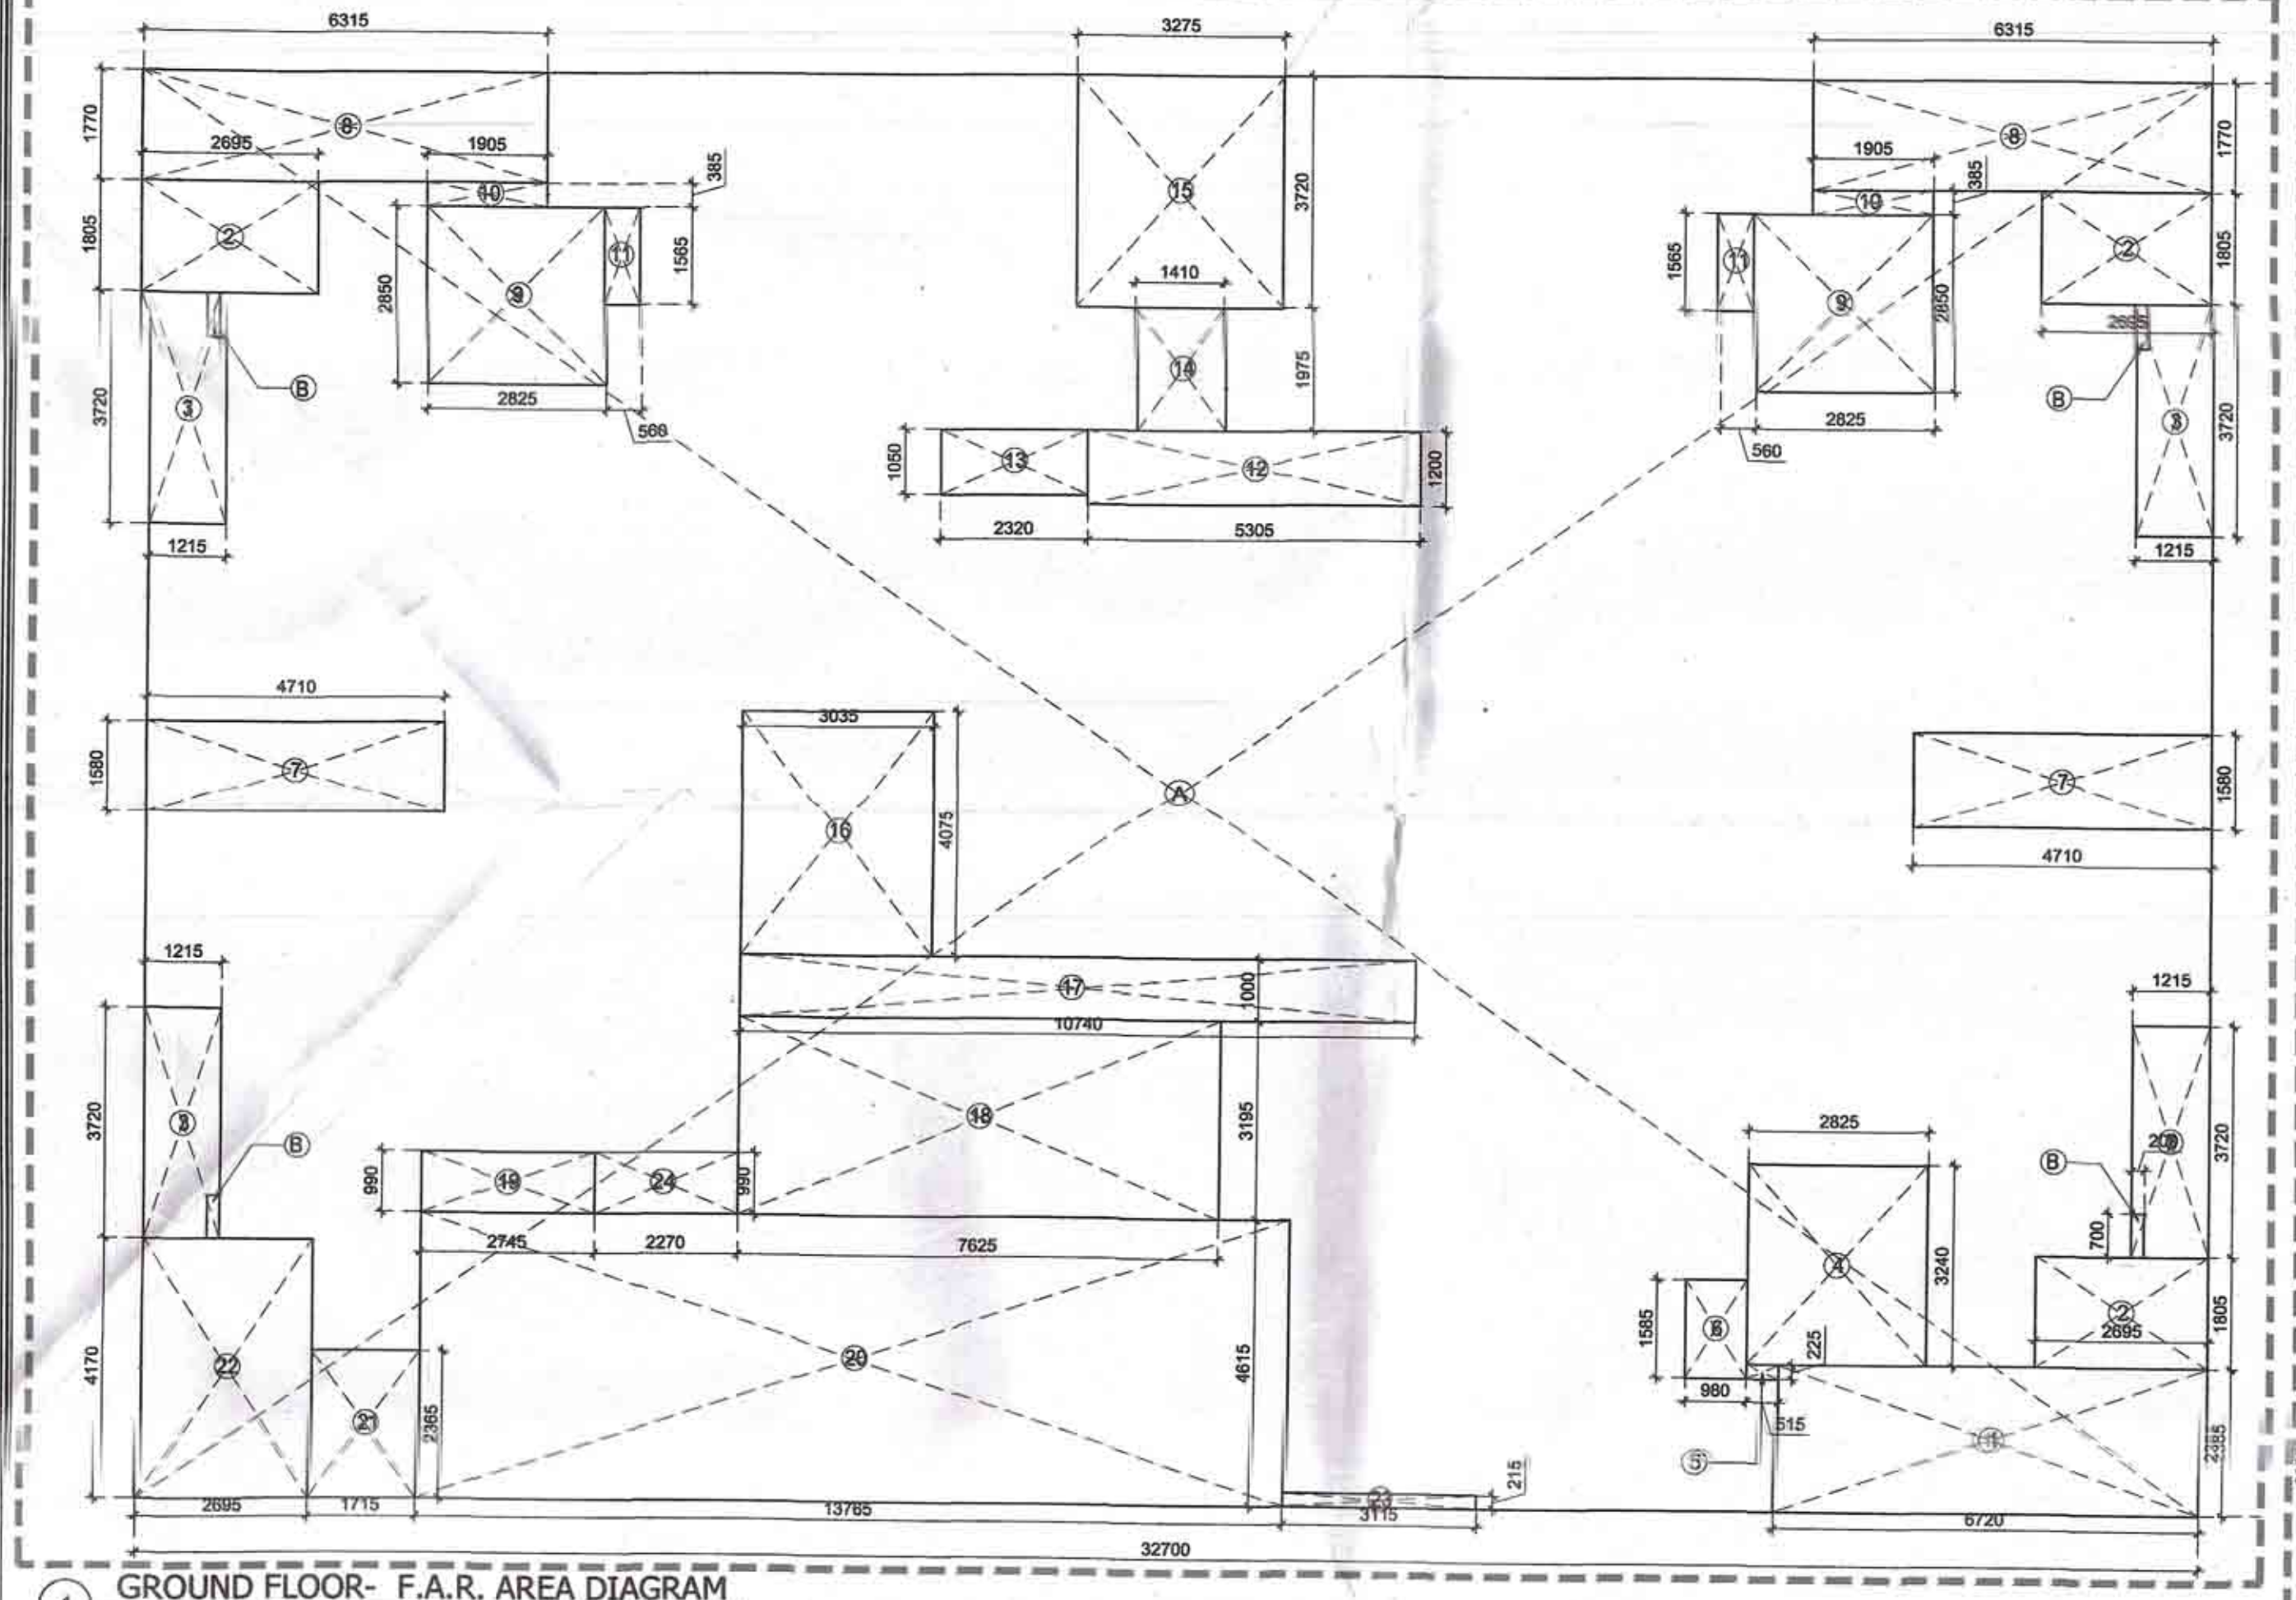

GROUND FLOOR AREA DETAIL (F.A.R.)


DETAIL	XX-YY	AREA
TOTAL AREA	XX-YY	757.892
XX (ADDITION)		271.842
YY (SUBTRACTION)		486.050
TOTAL AREA		757.892

DETAIL XX-YY

TYPE	ENVELOPE (ADDITION)	AREA
A	REC 32.700 23.160 1	757.332
B	REC 0.200 0.700 4	0.560
TOTAL XX-YY		757.892

DETAIL YY-YY

TYPE	ENVELOPE (SUBTRACTION)	AREA
1	REC 6.720 2.365 1	15.893
2	REC 2.695 1.805 3	14.593
3	REC 1.215 3.720 1	18.079
4	REC 2.825 3.240 1	9.153
5	REC 0.225 1.565 1	0.116
6	REC 0.980 1.565 1	1.533
7	REC 4.710 1.580 2	14.884
8	REC 2.825 2.850 2	16.103
9	REC 6.315 1.770 2	22.355
10	REC 1.905 0.385 2	1.467
11	REC 0.560 1.565 2	1.763
12	REC 5.265 1.200 1	6.318
13	REC 2.325 1.660 1	2.436
14	REC 1.410 1.975 1	2.785
15	REC 3.275 3.720 1	12.183
16	REC 3.035 4.075 1	12.368
17	REC 10.740 1.000 1	10.740
18	REC 3.720 3.185 1	24.362
19	REC 2.745 0.990 1	2.718
20	REC 13.765 4.615 1	63.529
21	REC 1.115 2.365 1	4.056
22	REC 2.695 4.170 1	11.236
23	REC 3.115 0.215 1	0.670
24	REC 0.980 2.270 1	2.247
TOTAL YY		271.842

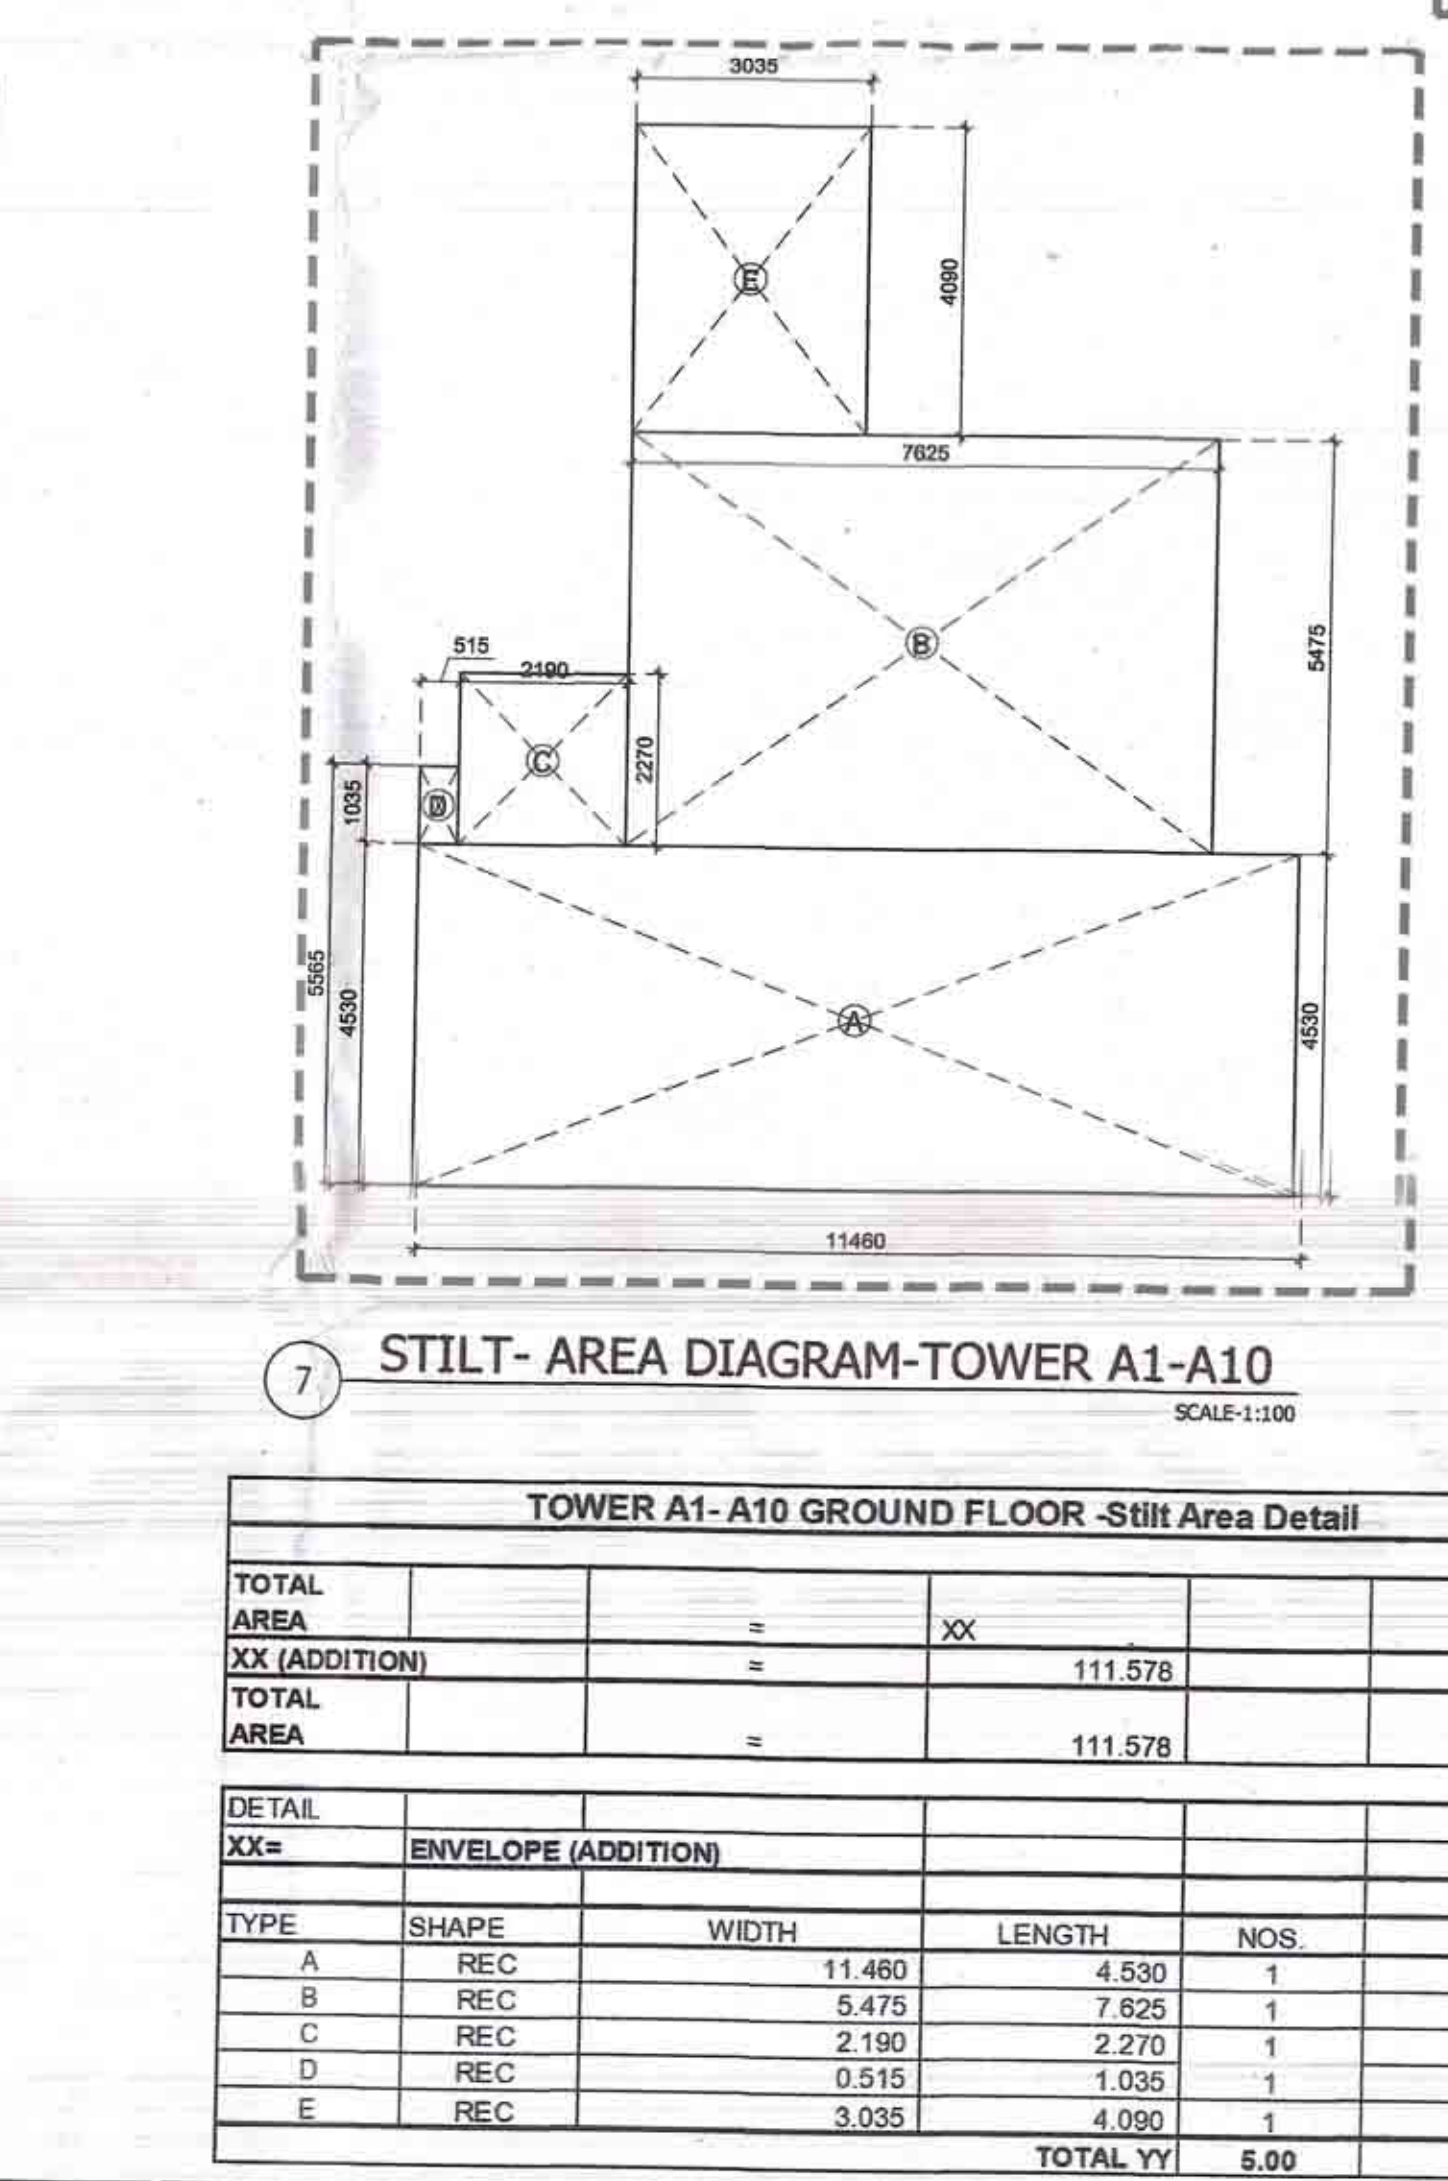

TYPICAL FLOOR AREA DETAIL

DETAIL	XX-YY	AREA
TOTAL AREA	XX-YY	757.892
XX (ADDITION)		247.407
YY (SUBTRACTION)		510.485
TOTAL AREA		757.892

DETAIL XX-YY

TYPE	ENVELOPE (ADDITION)	AREA
A	REC 32.700 23.160 1	757.332
B	REC 0.200 0.700 4	0.560
TOTAL XX-YY		757.892

DETAIL YY-YY

TYPE	ENVELOPE (SUBTRACTION)	AREA
1	REC 6.720 2.365 2	31.786
2	REC 2.695 1.805 4	19.458
3	REC 2.825 3.240 2	18.308
4	REC 0.225 1.565 2	0.232
5	REC 1.215 3.720 4	18.079
6	REC 4.710 1.580 2	14.884
7	REC 2.825 2.850 2	16.103
8	REC 6.315 1.770 2	22.355
9	REC 1.905 0.385 2	1.467
10	REC 0.560 1.565 2	1.763
11	REC 5.265 1.200 1	6.318
12	REC 2.325 1.660 1	2.436
13	REC 1.410 1.975 1	2.785
14	REC 3.275 3.720 1	12.183
15	REC 3.035 4.075 1	12.368
16	REC 10.740 1.000 1	10.740
17	REC 3.720 3.185 1	24.362
18	REC 2.745 0.990 1	2.718
19	REC 13.765 4.615 1	63.529
20	REC 1.115 2.365 1	4.056
21	REC 2.695 4.170 1	11.236
22	REC 3.115 0.215 1	0.670
23	REC 0.980 2.270 1	2.247
TOTAL YY		247.407

TOWER A1-21ST FLOOR- AREA DETAIL


DETAIL	XX-YY	AREA
TOTAL AREA	XX-YY	757.332
XX (ADDITION)		304.281
YY (SUBTRACTION)		453.051
TOTAL AREA		757.332

DETAIL XX-YY

TYPE	ENVELOPE (ADDITION)	AREA
A	REC 32.700 23.160 1	757.332
TOTAL XX-YY		757.332

DETAIL YY-YY

TYPE	ENVELOPE (SUBTRACTION)	AREA
1	REC 3.575 2.695 1	9.633
2	REC 1.775 1.715 1	3.044
3	REC 1.905 5.110 1	9.744
4	REC 1.480 1.585 1	2.319
5	REC 1.265 0.630 1	0.799
6	REC 0.700 1.015 4	2.840
7	REC 1.215 3.020 4	14.677
8	REC 4.705 1.680 2	15.680
9	REC 1.800 2.695 3	14.553
10	REC 6.720 2.365 2	31.786
11	REC 3.240 3.225 2	18.308
12	REC 1.585 0.680 2	3.107
13	REC 0.225 1.565 2	0.232
14	REC 0.215 1.515 2	0.650
15	REC 14.615 8.550 1	124.842
16	REC 3.185 5.380 1	17.158
17	REC 7.625 0.000 1	7.625
18	REC 0.705 1.635 2	2.305
19	REC 2.000 2.000 1	4.000
20	REC 2.450 1.385 1	3.385
21	REC 3.000 2.000 1	6.000
22	REC 3.900 1.585 1	21.002
23	REC 0.625 2.715 1	1.693
24	REC 3.035 2.810 1	8.528
25	REC 10.740 1.000 1	10.740
26	REC 3.720 3.185 1	24.362
27	REC 2.745 0.990 1	2.718
28	REC 5.010 2.180 1	10.972
29	REC 3.240 3.225 1	10.515
30	REC 7.235 1.775 1	12.842
TOTAL YY		304.281

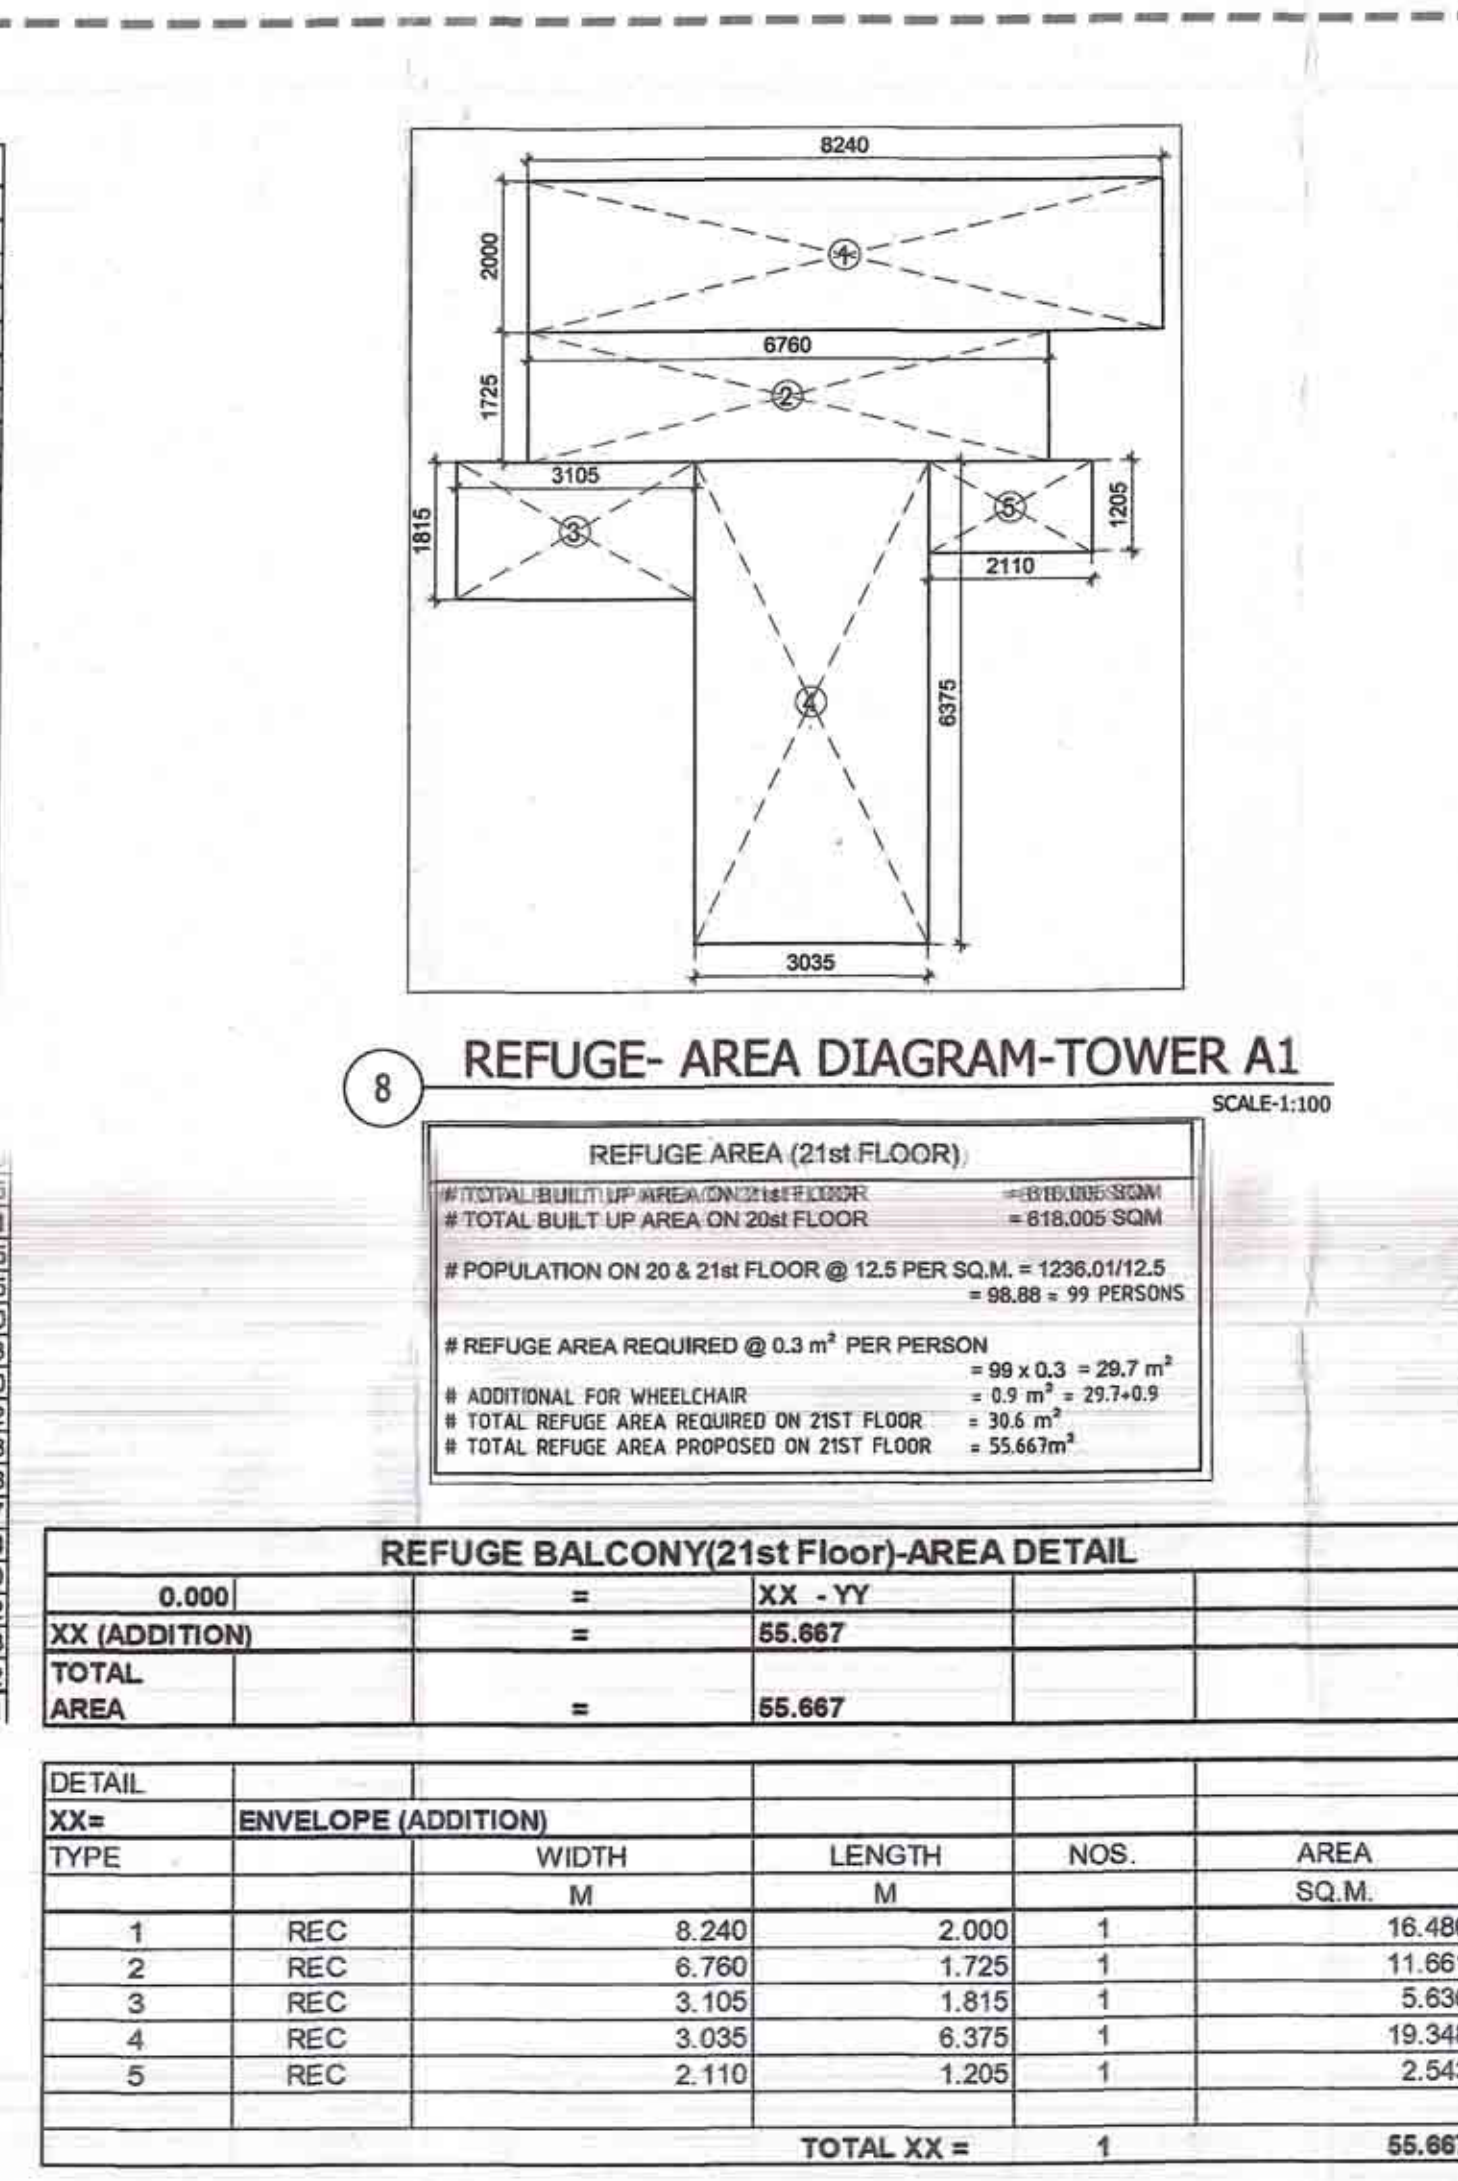

REFUGE AREA (21st FLOOR)

DETAIL	XX-YY	AREA
TOTAL AREA	XX-YY	1236.012
XX (ADDITION)		1236.012
YY (SUBTRACTION)		0.000
TOTAL AREA		1236.012

REFUGE AREA REQUIRED @ 0.3 m² PER PERSON

DETAIL	XX-YY	AREA
TOTAL AREA	XX-YY	1236.012
XX (ADDITION)		1236.012
YY (SUBTRACTION)		0.000
TOTAL AREA		1236.012

REFUGE BALCONY (21st Floor)-AREA DETAIL

DETAIL	XX-YY	AREA
TOTAL AREA	XX-YY	1236.012
XX (ADDITION)		1236.012
YY (SUBTRACTION)		0.000
TOTAL AREA		1236.012

NOTES:

1. ALL LIFTS SHALL HAVE 100% POWER BACKUP.
2. ALL ELECTRICAL INSTALLATIONS SHALL BE AS PER PROVISION OF NBC.
3. FIRE FIGHTING SAFETY PROVISIONS WILL BE AS PER RELEVANT NBC PROVISIONS.
4. BUILDING STRUCTURE DESIGNED EARTHQUAKE RESISTANT.
5. MAIN ENTRY & BOUNDARY WALL AS PER STANDARD DESIGN.

PROJECT
PROPOSED BUILDING PLAN OF AFFORDABLE GROUP HOUSING COLONY ON LAND MEASURING 9.3625 Acres (License no. 42 of 2021 dated 27.07.2021) IN SECTOR 102, GURUGRAM, HARYANA BEING DEVELOPED BY HABITAT TOWNSHIP PVT. LTD.

CLIENT
RUDRAKSHA REALTORS PVT. LTD. & OTHERS IN COLLABORATION WITH HABITAT TOWNSHIP PVT. LTD.

PRINCIPAL ARCHITECT
DESIGN FORUM INTERNATIONAL

K-47, KAILASH COLONY, NEW DELHI-110048
PHONE NO.: 011-46556800

DRG. TITLE
TOWER A1-A10-GROUND & TYPICAL FLOOR LVL- FLOOR PLANS & AREA DETAILS

OWNER'S SIGN
ARCHITECT'S SIGN

SCALE - AS MARKED
DATE - 24.08.2021

SHEET NO.
05